





SITE EVALUATORS LLC
 6136 FRISCO SQUARE BLVD.
 SUITE 400
 FRISCO, TX 75034
 214-705-8555

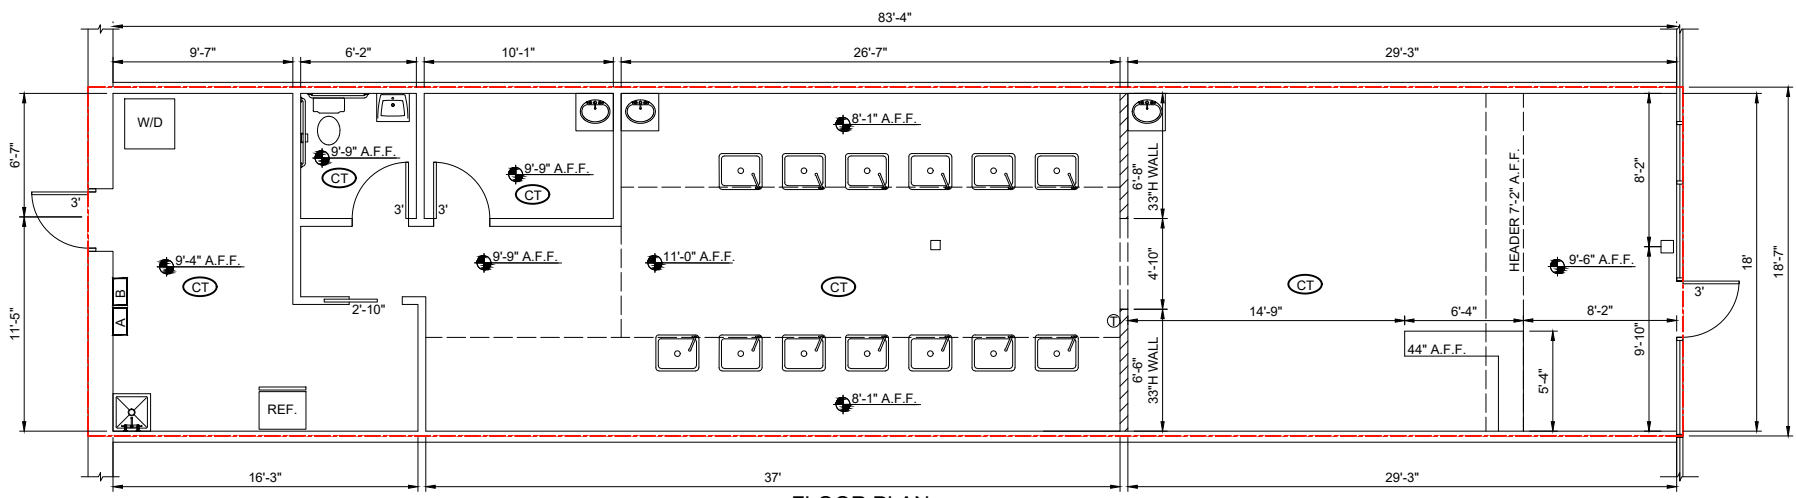

FLOOR PLAN
N.T.S.

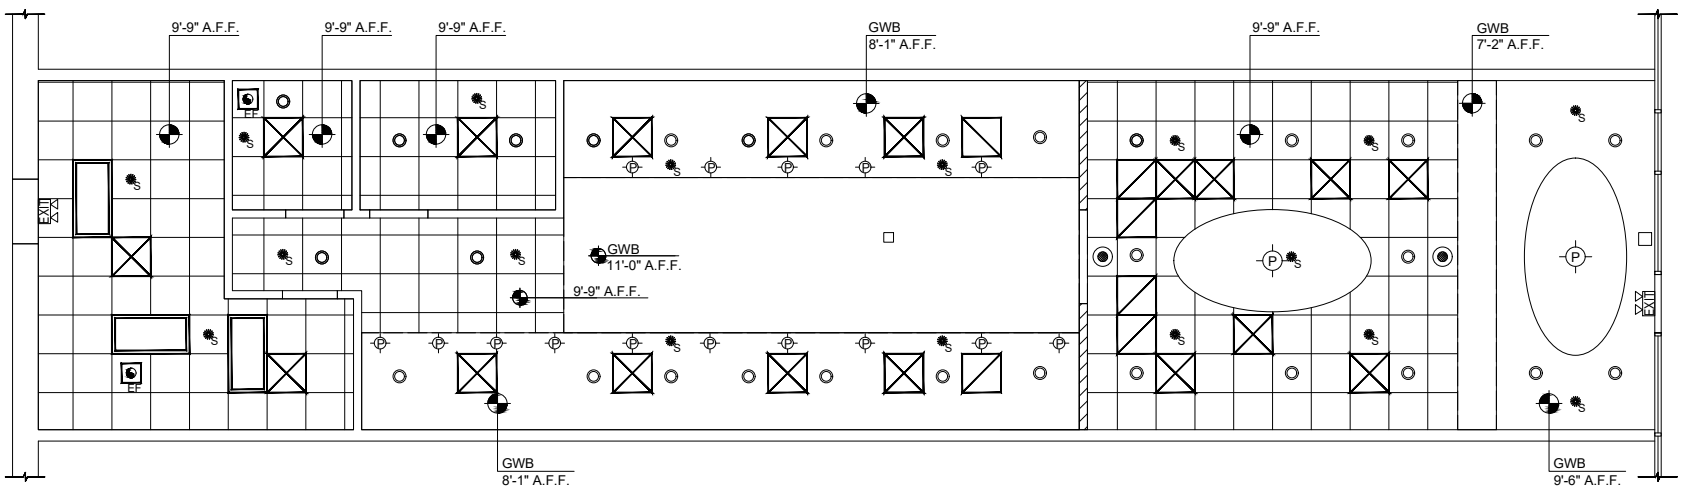

REFLECTED CEILING PLAN
N.T.S.

LEGEND		
A = 100 AMP, 480Y/277V	AIR SUPPLY DIFFUSOR	2'x4' LAY-IN LIGHT FIXTURE
B = 150 AMP, 208Y/120V	AIR RETURN DIFFUSOR	PENDANT LIGHT FIXTURE
T = THERMOSTAT	FIRE SPRINKLER	EXHAUST FAN
	RECESSED CAN LIGHT	SPEAKER

--- LEASEABLE S.F. = 1,580 SF

LEV COR

MARQ-E
 7670 KATY FWY., SUITE 90,
 HOUSTON, TX 77024

THIS IS NOT A WORKING DRAWING.
 DO NOT USE FOR CONSTRUCTION.
 ALL DIMENSIONS ARE SUGGESTED AND ARE TO BE VERIFIED BY THE CONTRACTOR.

DRAWN BY: I.S.
 NOT TO SCALE
 DATE: 06-10-25