



TO: PHASE II  
6" PVC SEWER

PLUMBING RISER DIAGRAM  
NOT TO SCALE

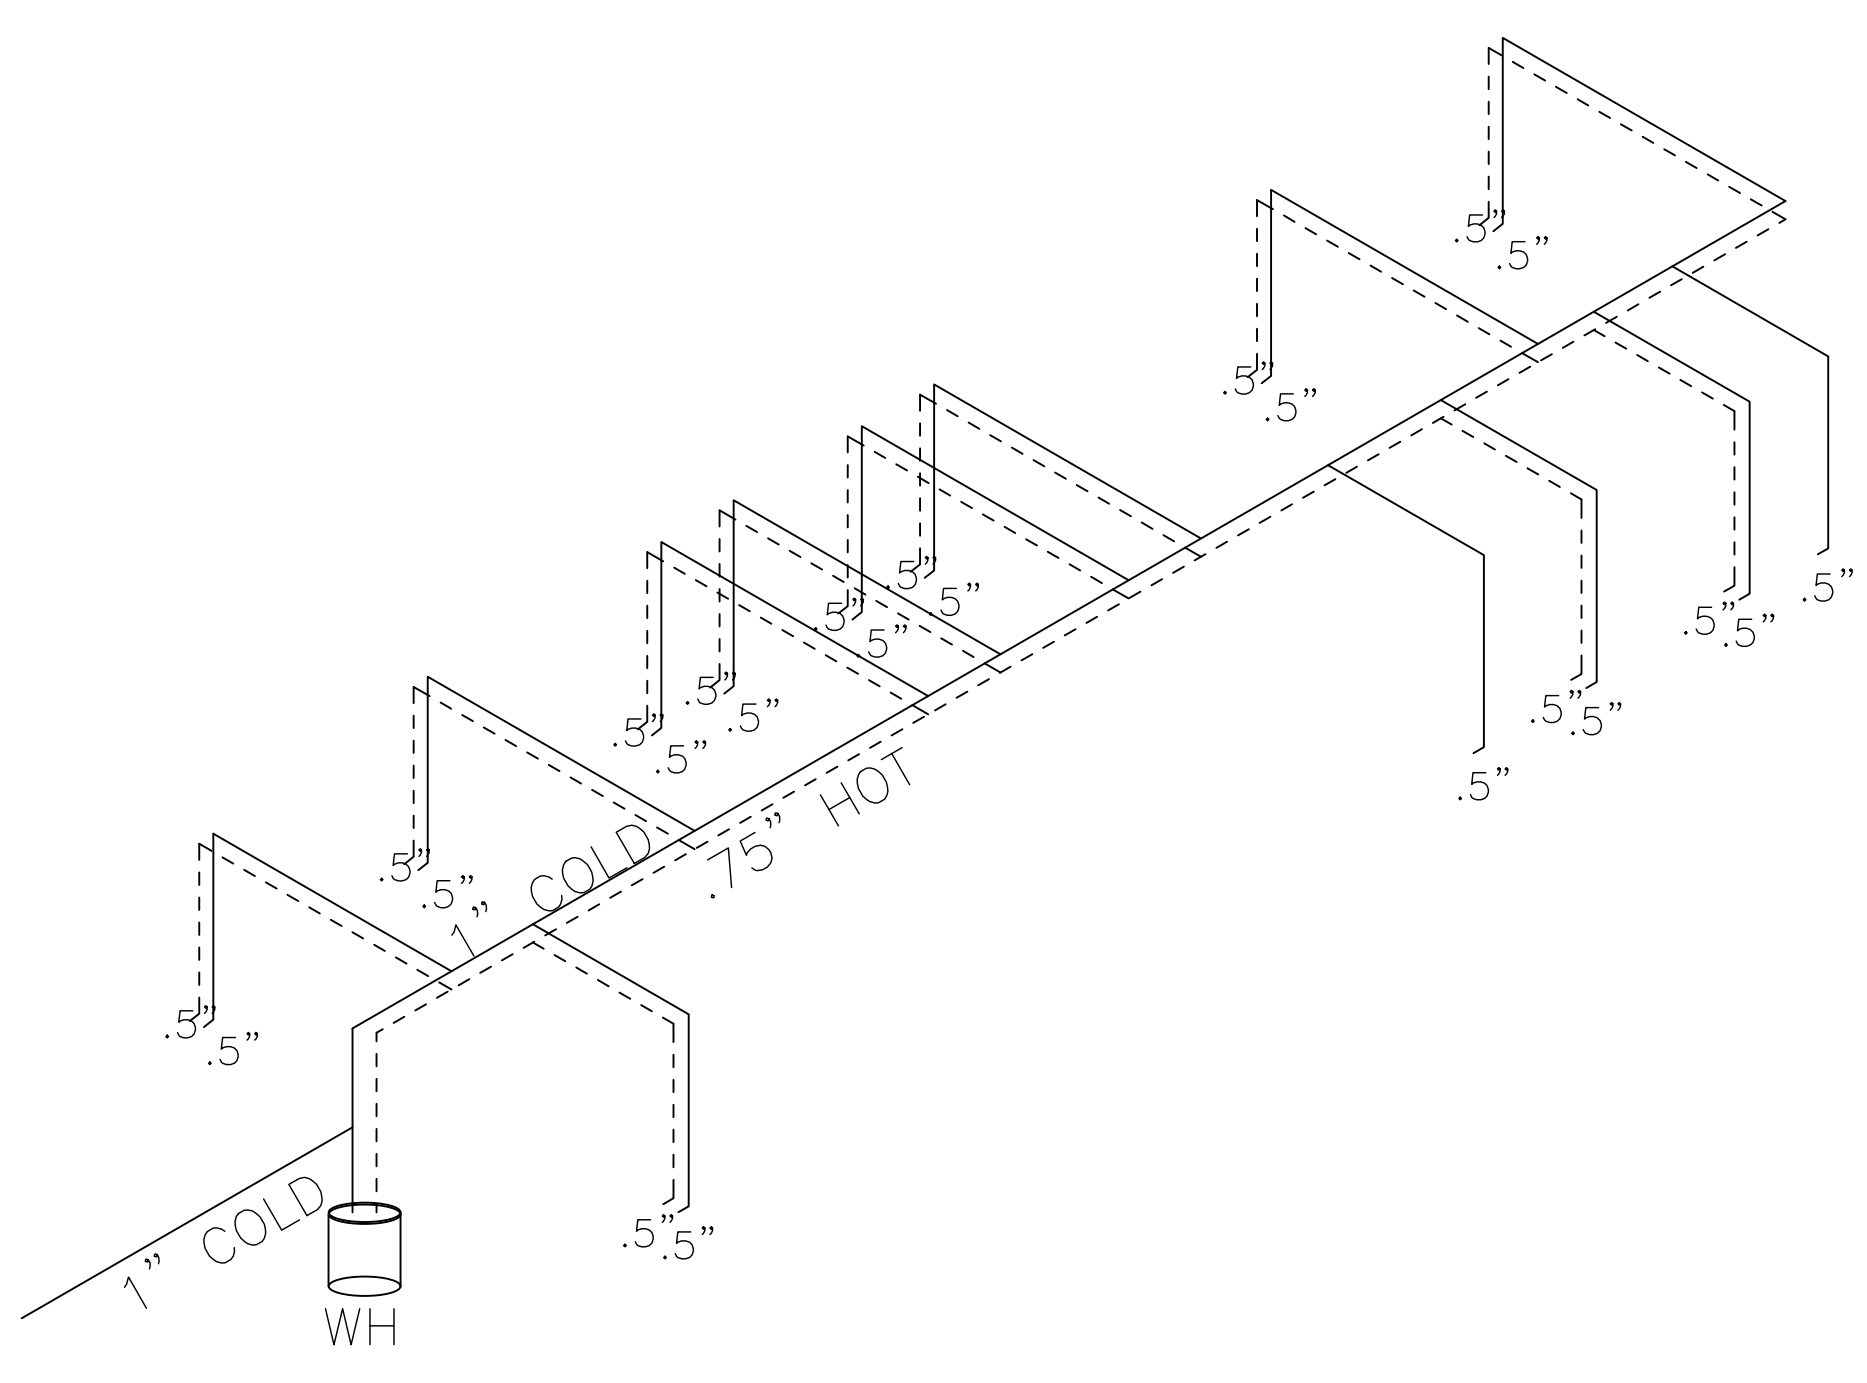

WATER RISER DIAGRAM  
NOT TO SCALE

DESIGNPOINT, Inc.  
architecture  
space planning  
interior design  
telephone (317.873.9286) 1837 corniche drive zionsville in 46077

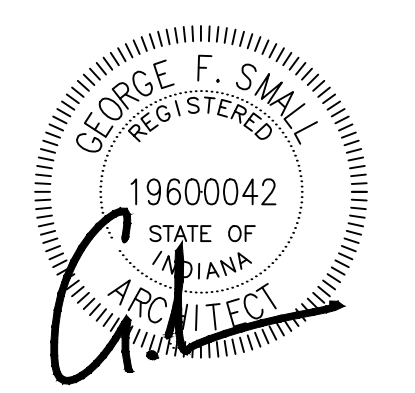

**GALLERY PASTRY SHOP**

Interior Remodel  
319 E. 16TH ST.  
Indianapolis, IN

DATE: 9.15.2020  
SCALE: AS NOTED  
DRAWN:

REVISIONS:

All ideas, designs, and plans indicated or represented by these drawings are owned by, and the property of Design Point, Inc. Contractors shall verify and be responsible for all dimensions on the job site. All rights reserved, except for uses expressly permitted in writing; information shown or included on these drawings are solely the property of Design Point, Inc.

DRAWING NAME:

PROJECT: SHEET:  
**P1.0**