


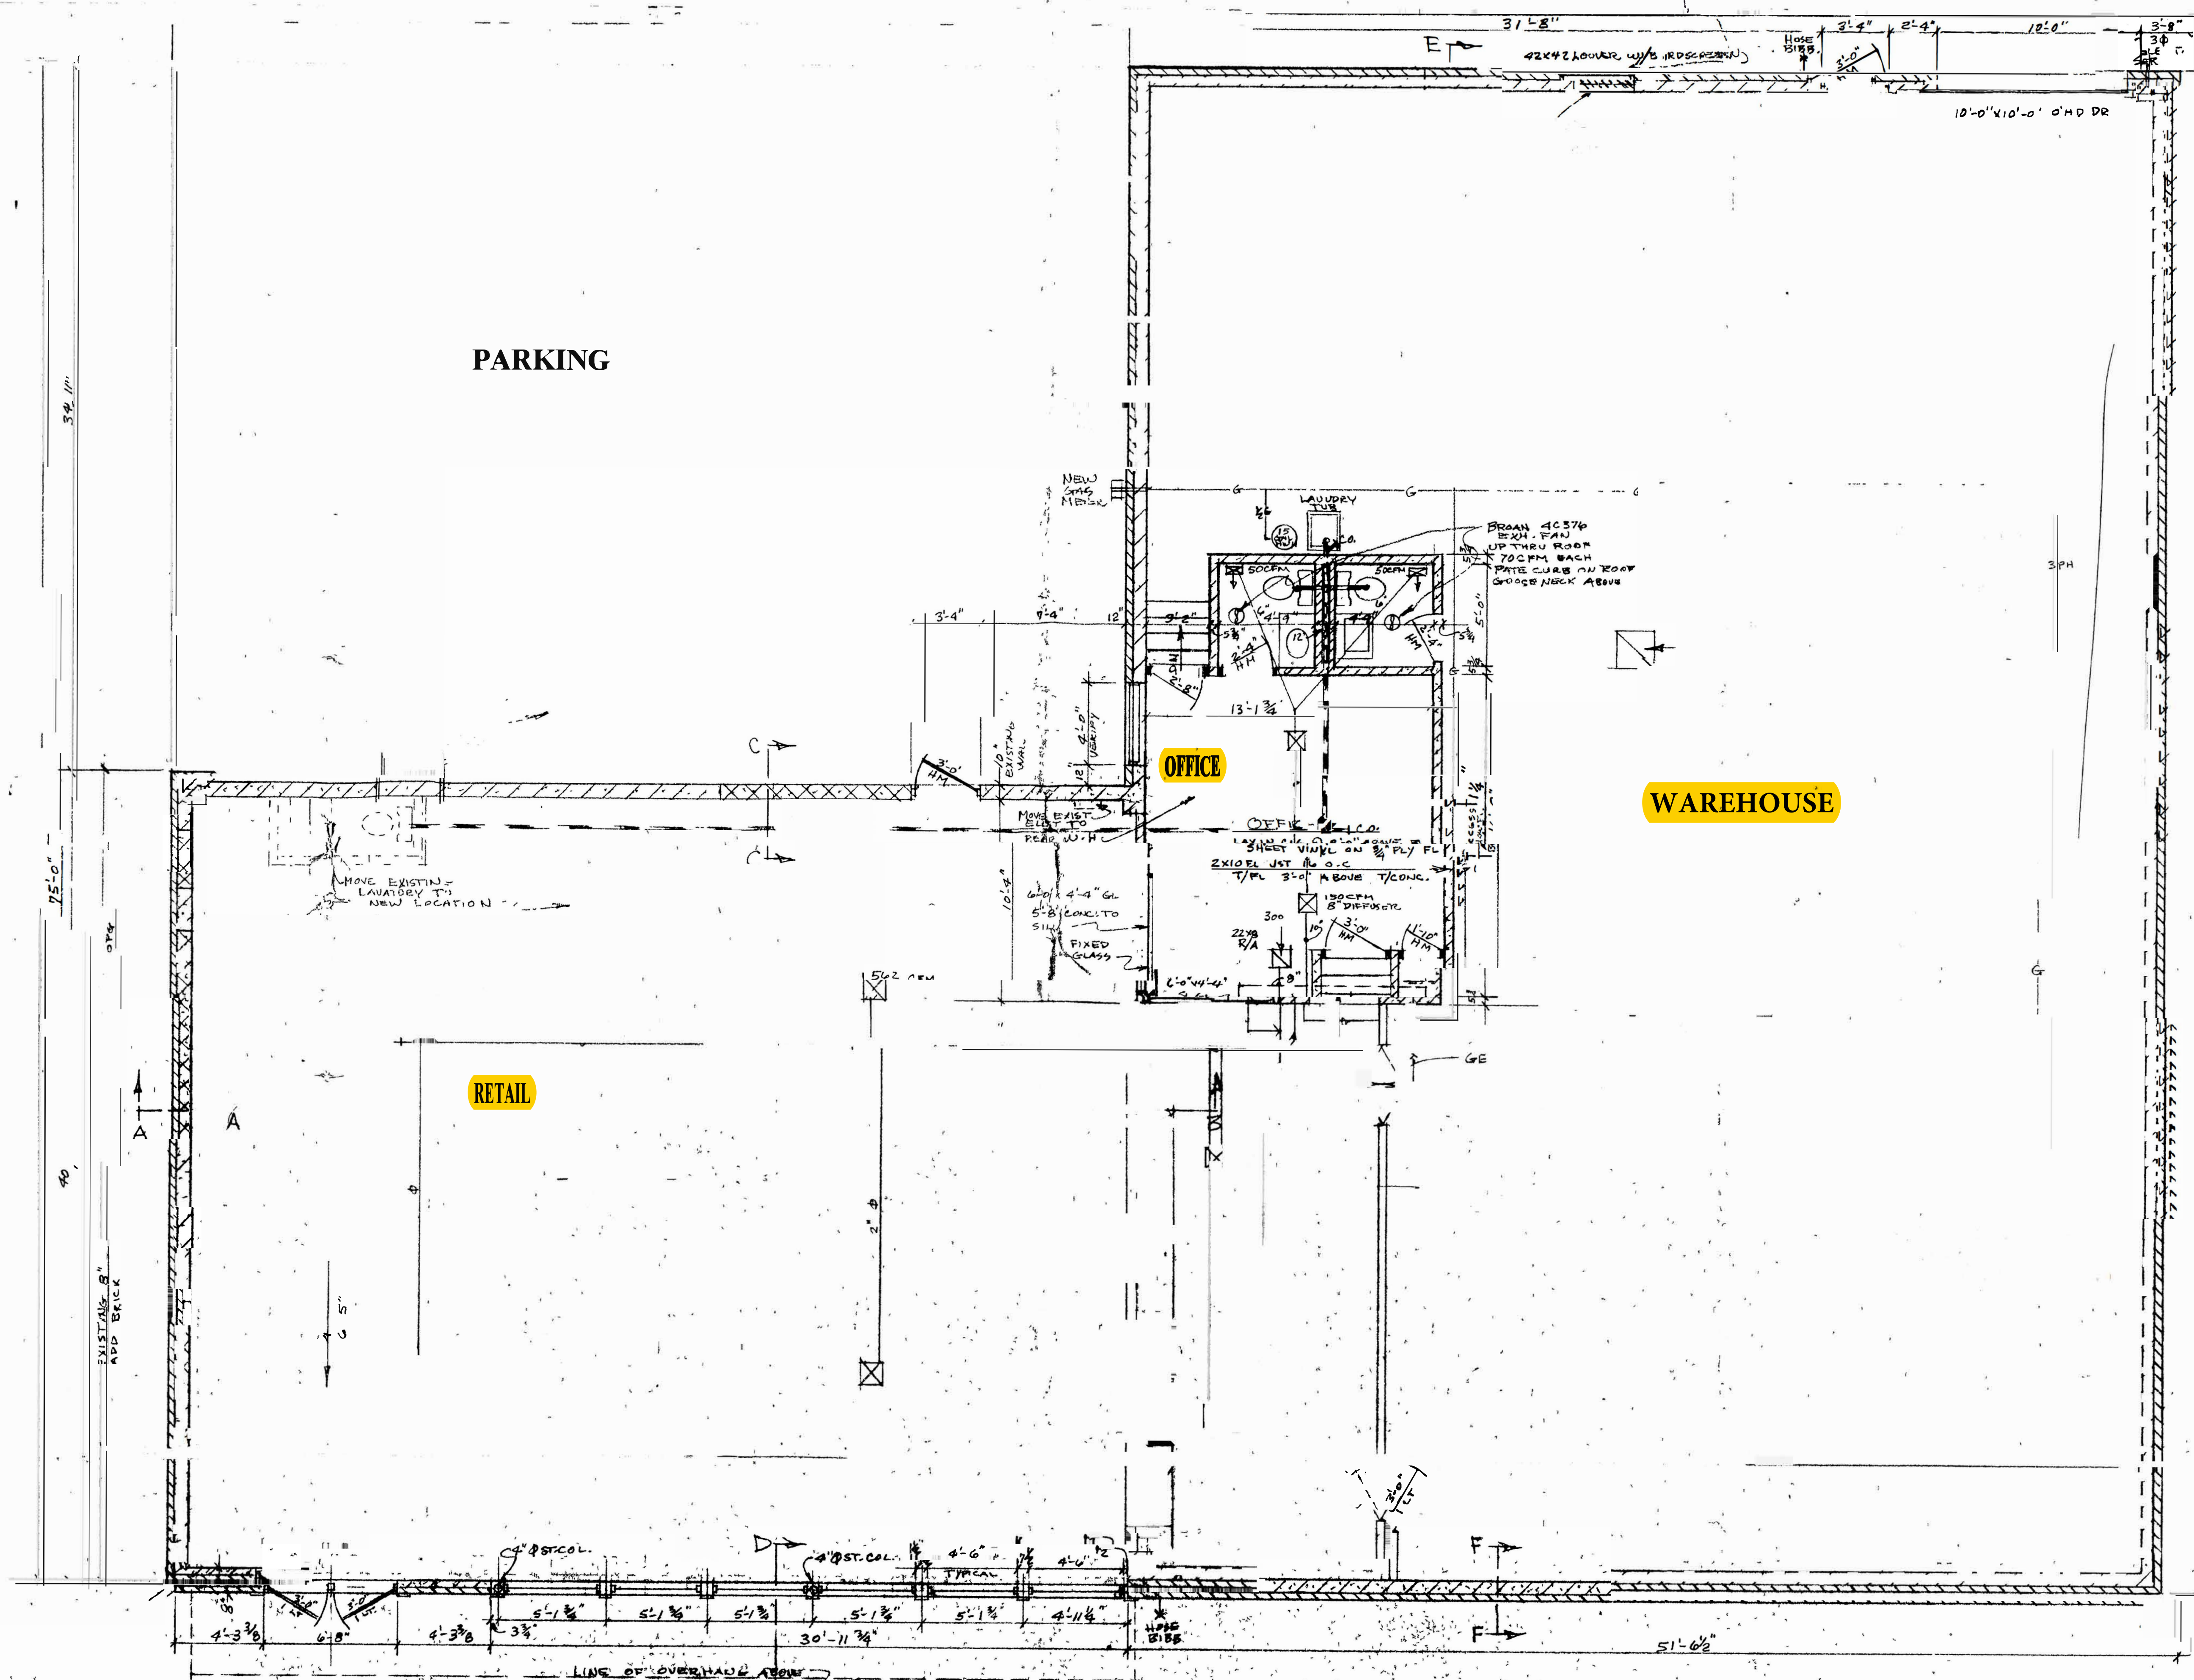

FLOOR PLAN & MECHANICAL LAYOUT SCALE 1/8" = 1'-0"