



ALICO COMMERCIAL PARK - LOT 13

LEE COUNTY - FLORIDA

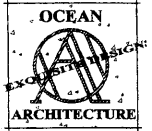

STRONG BUILDINGS

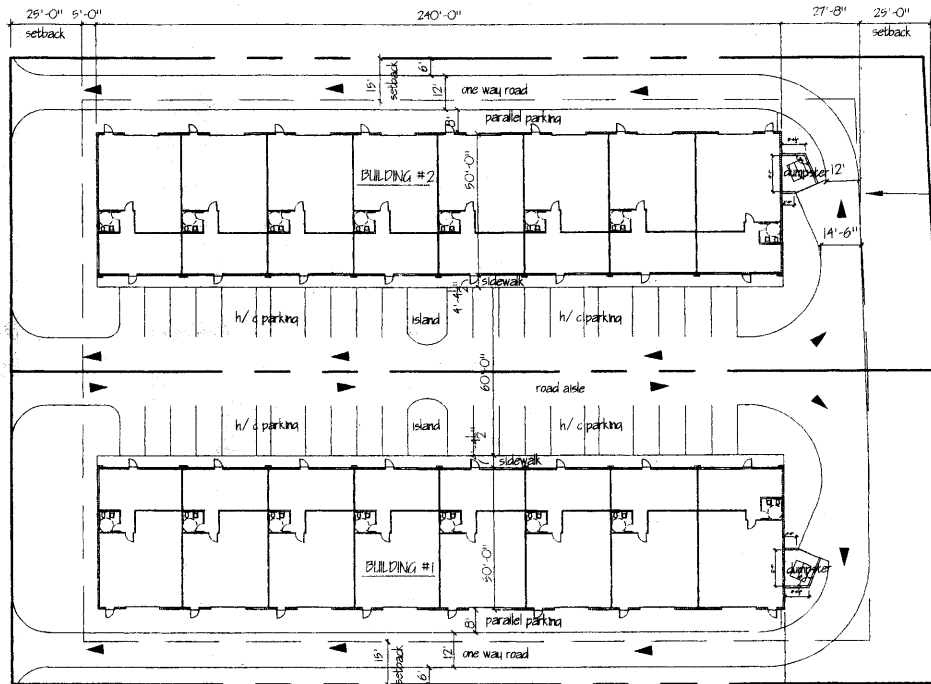

SITE PLAN
1 SD1
1" = 20'-0"

PROJECT DATA: PER FL. BLDG. CODE 2001

1- BLDG. CLASSIFICATION (PER CH. 5)

AREA	CLASSIFICATION	REMARKS
1	52 COMMERCIAL SERVICE	3395.1.1

2- CONSTRUCTION TYPE (PER CH. 6)

TYPE	REMARKS
1	FIRE SPRINKLER SYSTEM
2	NO. UNREINFORCED

3- FIRE FLOW CALCULATIONS

AREA	SF	CONSTR. TYPE	TRAFFIC FACTOR
1	12,000	TYPE 5	USE

EXP. FACTOR	PROTECT. FIRE FLOW REQ. (GPM)	FLOW PROVIDED
NO	1,454	

5- BUILDING LIMITATIONS (TABLE 500)

AREA	OCCUPANCY	BUILDING HEIGHT	PERMITTED	PROPOSED
1	52	52'	52'	

AREA	1 STORY AREA	MULTISTORY AREA	PERMITTED	PROPOSED
1	18,000	12,000	N/A	N/A

6- FIRE PROTECTION (TABLE 600)


CONFORMANCE	REQUIREMENTS	PROPOSED	REMARKS
1	FIRE WELLS	N/A	N/A
2	FLK. SUP. (PER FLOW)	1/2"	1/2"
3	EXTERIOR FIRE WALLS	0/1"	0/1"
4	NO. HIGH PRESS. WALLS	0/1"	0/1"
5	COLLAPSE	0/1"	0/1"
6	DRG. JOINTS, JOINTS & JOINTS	0/1"	0/1"
7	FLOOR/CEILING	0/1"	0/1"
8	WALL/CEILING	0/1"	0/1"

7- EGRESS REQUIREMENTS (TABLE 1004)

WALK	WALK	WALKWAY	WALKWAY	WALKWAY	WALKWAY
200'	50'	0/2"	4"	52'	

SHEET INDEX

SD1	SITE PLAN
	PROJECT DATA
	SHEET INDEX
	SITE LOCATION
	COMPLIANCE STATEMENT
S1	NOTES, BM/PTS. SCHD. & DETAILS
S2	FOUNDATION & ROOF FRMG. PLAN
S3	INTERIOR WALL SECTION
	EXTERIOR WALL SECTION
	BUILDING SECTION
A1	FRONT ELEVATION
A2	REAR & DOOR SCHEDULES
	1 HR. FIREWALL UL DET.
	BUILDING ELEVATIONS
MP	PLUMBING RISER DIAGRAM
	H.C. TOILET FIXTURES/DETAILS
	PLUMBING FLOOR PLAN
	MECHANICAL FLOOR PLANS
E1	ELECTRICAL & LIGHTING PLANS
E2	SPECIFICATIONS & NOTES
E3	POWER RISER DIAGRAM, PANEL SCHEDULES & LOAD CALC.

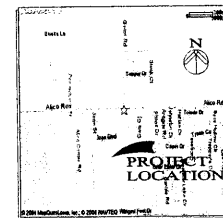

SITE LOCATION
N.T.S.

COMPLIANCE STATEMENT

THESE PLANS ARE IN COMPLIANCE WITH THE 1997 STANDARD BUILDING CODE INCLUDING SECTION 1606 FOR THE 110 MILE PER HOUR WIND LOAD.

RONALD J. OLSEN, AIA
REGISTERED ARCHITECT
FLORIDA CERTIFICATE NO. 001166

ALICO COMMERCIAL PARK - LOT 13

ALICO COMMERCIAL PARK - LEE COUNTY, FLORIDA

239 * 939 * 3337

OCEAN ARCHITECTURE
7181 COLLEGE PARKWAY # 6
FT. MYERS, FL 33907

oceanarchitecture@gmail.com

LIC: AR 0011166


DATE: 8/17/04 ISSUE: Preliminary

1/4/05 Final



SD1

PLAN NOTES

1. SEE DRAWING S1 FOR STRUCTURAL NOTES.
2. VERIFY DIMENSIONS AND ELEVATIONS WITH THE ARCHITECTURAL DRAWINGS. FOR ADDITIONAL INFORMATION SEE THE ARCHITECTURAL DRAWINGS.
3. WALL AND COLUMN CENTERLINES SHALL CENTER ON FOOTING CENTERLINES UNLESS NOTED OTHERWISE.
4. ELEVATION OF TOP OF FOOTINGS -1'-4" UNLESS NOTED OTHERWISE.
5. FLOOR IS 4" CONCRETE SLAB ON GRADE WITH 6x6-W1.4W1.4 WELDED WIRE FABRIC AT 1/3 DEPTH. SEE STRUCTURAL NOTES.
6. SLAB CONTRACTION JOINTS (CJ) ARE TO BE CUT WITHIN 4 HOURS OF CONCRETE PLACING. JOINTS SHOULD BE A MAXIMUM OF 20' APART AND HAVE A LENGTH NO MORE THAN THREE THE WIDTH. CUTS SHOULD BE 1/4 THE DEPTH WITH EVERY OTHER CROSS WIRE CUT AT THE JOINT. SEE PLAN.
7. MASONRY WALL VERTICAL REINFORCING IS #5 IN GROUT FILLED CELL AT 48" ON CENTER UNLESS NOTED OTHERWISE. SEE STRUCTURAL NOTES.
8. TE = THICKENED EDGE SLAB 12"x16" WITH (2) #5 CONTINUOUS.
9. TS = THICKENED SLAB 12"x8" WITH (1) #5 CONTINUOUS.

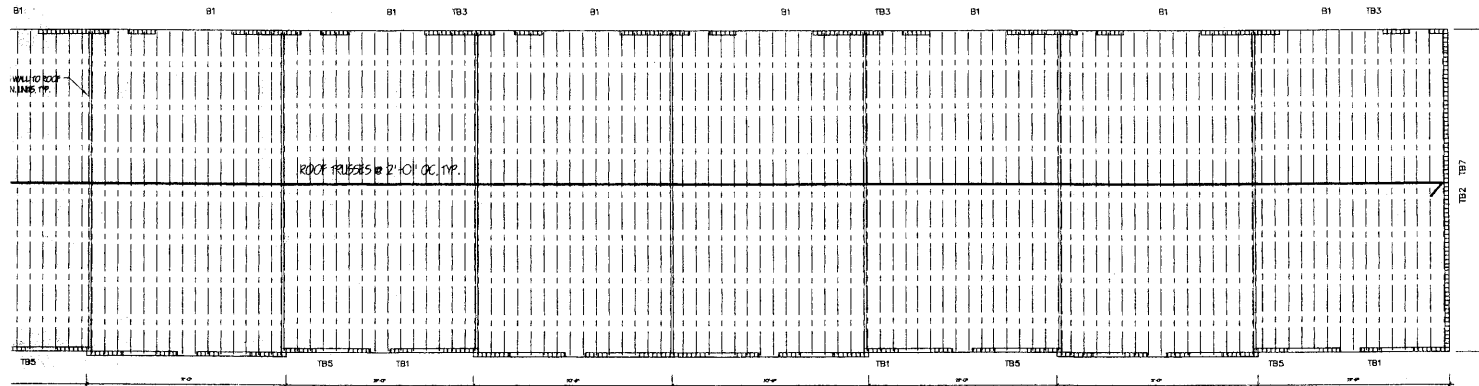

1
82
ROOF FRAMING PLAN
1/2" = 1'-0"

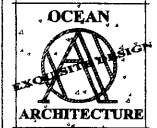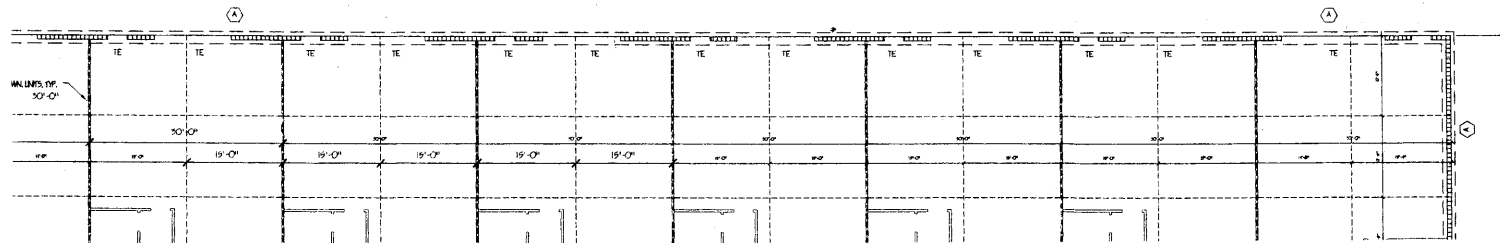


STRONG BUILDINGS

ALICO COMMERCIAL PARK - LOT 13


ALICO COMMERCIAL PARK - LEE COUNTY, FLORIDA

DESIGNED BY OCEAN ARCHITECTURE, INC. DRAWN BY THE ARCHITECT. ALL DIMENSIONS ARE IN FEET AND INCHES. UNLESS OTHERWISE NOTED, ALL DIMENSIONS ARE TO FACE.


239 • 939 • 3337
OCEAN ARCHITECTURE
7181 COLLINS PKWY, #6
FT. MYERS, FL 33907
oceanarchitecture@gmail.com

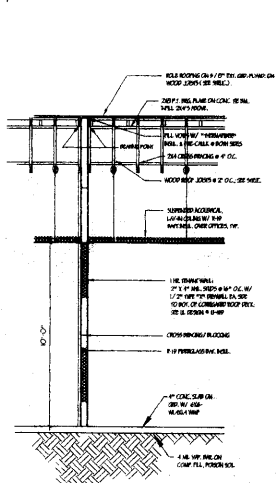


1 HR. WALL SEC.
1/2" = 1'-0"

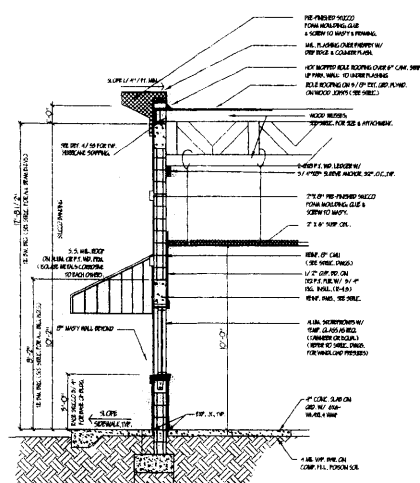

TYP. WALL SECTION
1/2" = 1'-0"

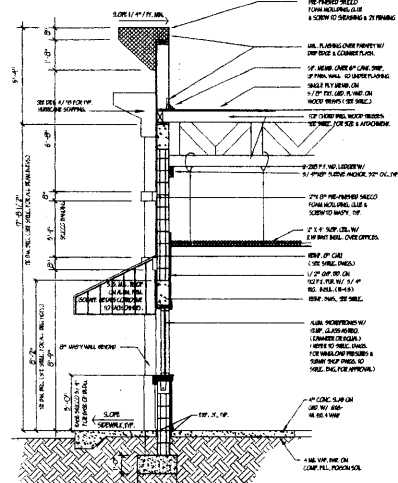


TYP. WALL SECTION
1/2" = 1'-0"

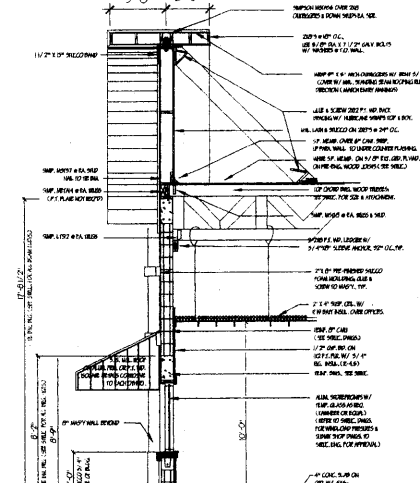


TYP. WALL SECTION
1/2" = 1'-0"

MIL. FLASHING OVER PARAPET W/
DRAIN EDGE & COUNTER FLASH.

PRE-FINISHED STUCCO
FOAM MOUNTING, GLUE
& SCREW TO MASS Y & FRAMING.

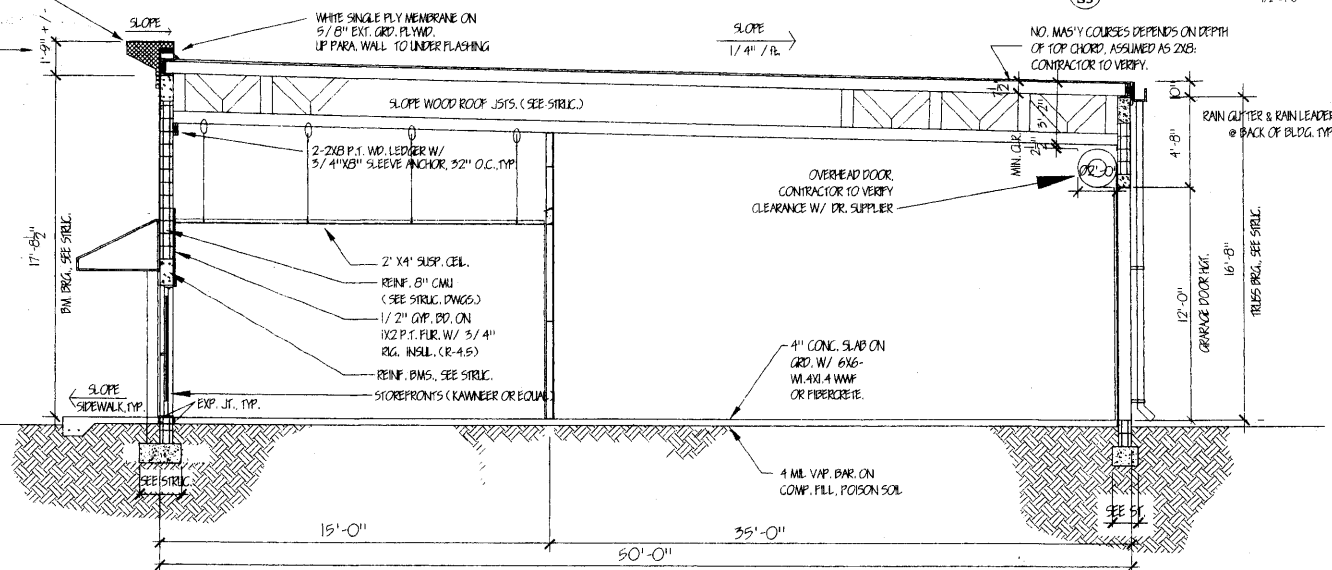

BUILDING SECTION
1/2" = 1'-0"

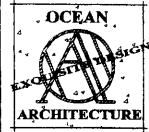

STRONG BUILDINGS

ALICO COMMERCIAL PARK - LOT 13

ALICO COMMERCIAL PARK - LEE COUNTY, FLORIDA

239 • 939 • 3337

OCEAN ARCHITECTURE
7181 COLLIER PARKWAY, #4
FT. MYERS, FL 33907
oceanarchitect.com

LIC: AR 0011166

DATE: 11/1/04
ISSUE: 1/4/05

DATE: 11/1/04
ISSUE: 1/4/05

DATE: 11/1/04
ISSUE: 1/4/05

DATE: 11/1/04
ISSUE: 1/4/05

DATE: 11/1/04
ISSUE: 1/4/05

DATE: 11/1/04
ISSUE: 1/4/05


DATE: 11/1/04
ISSUE: 1/4/05

DATE: 11/1/04
ISSUE: 1/4/05


DATE: 11/1/04
ISSUE: 1/4/05

DATE: 11/1/04
ISSUE: 1/4/05

S3

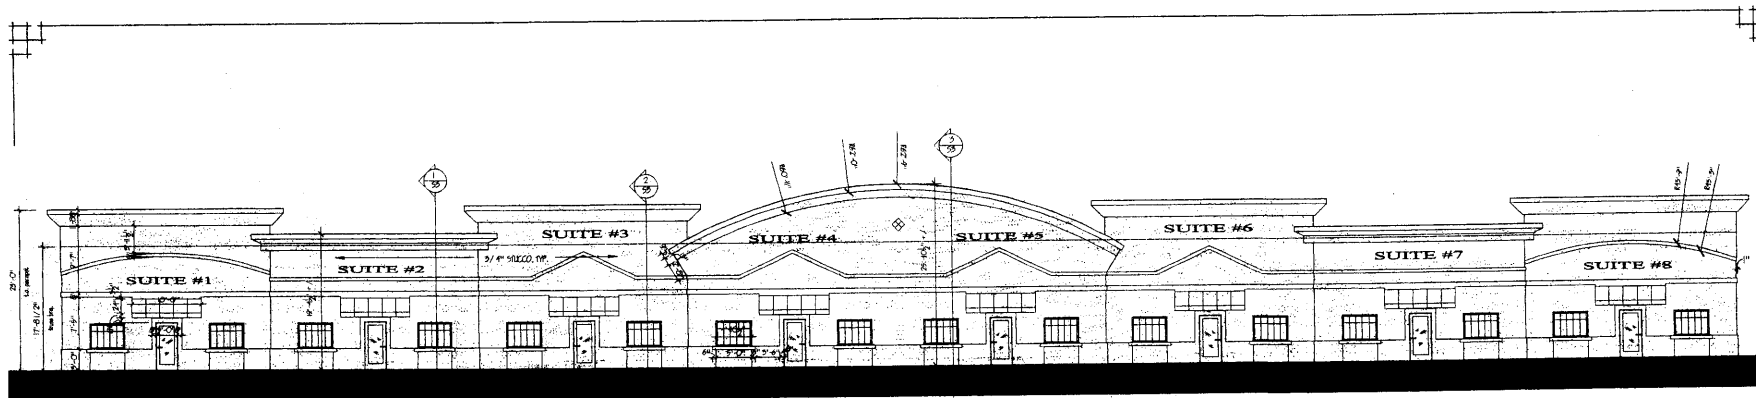

1 NORTH ELEVATION - BLDG. #1
1/8" = 1'-0"

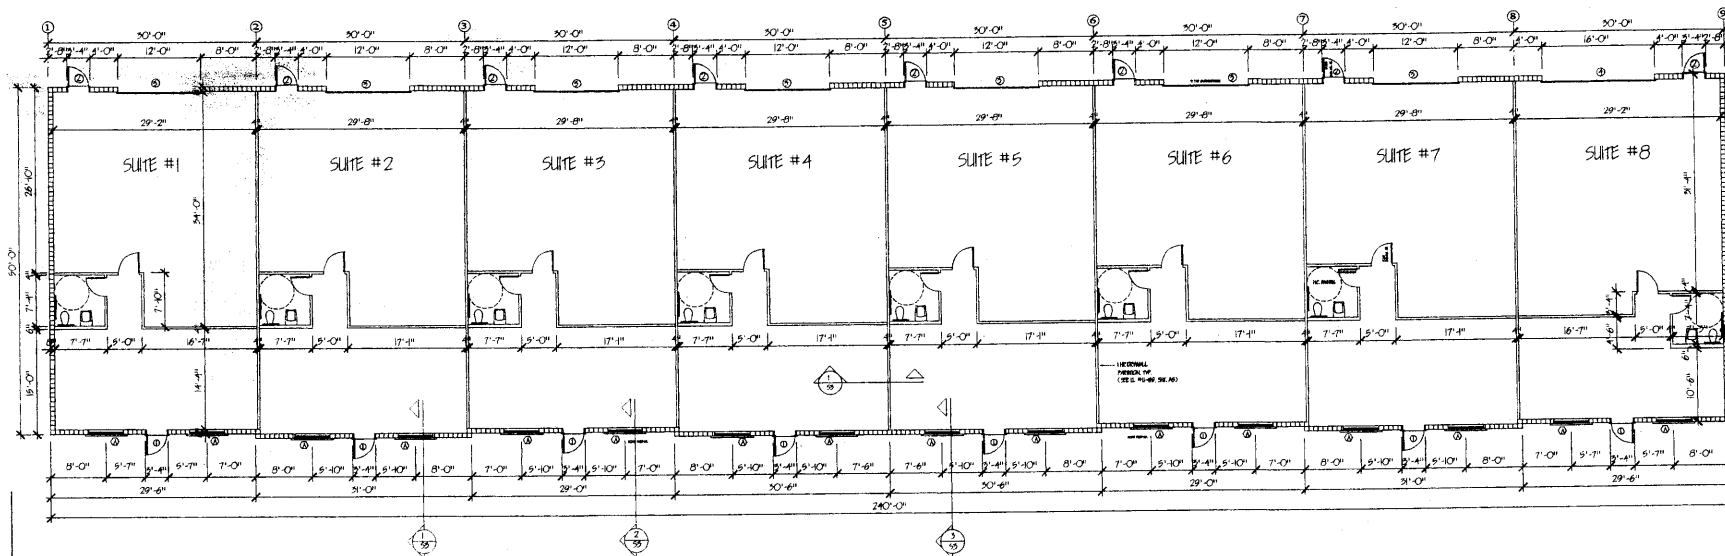

2 FLOOR PLAN - BLDG. #1
1/8" = 1'-0"



STRONG BUILDINGS

ALICO COMMERCIAL PARK - LOT 13

ALICO COMMERCIAL PARK - LEE COUNTY, FLORIDA

DESIGNED BY OCEAN ARCHITECTURE, INC. 2339 W. 9TH AVE. SUITE 100, FORT MYERS, FL 33907. PREPARED BY OCEAN ARCHITECTURE, INC. 2339 W. 9TH AVE. SUITE 100, FORT MYERS, FL 33907.

239 • 939 • 3337

OCEAN ARCHITECTURE
7181 COLLIER PARKWAY, #4
FT. MYERS, FL 33907
oceanarchitecture@gmail.com



LIC. AR. 0011166

DATE	ISSUE
11/17/04	Prepared
11/17/04	Prepared 2
11/17/04	Prepared 3
1/1/05	Final




A1

NOTE:
RISERS ARE SHOWN
FOR 1/2 THE BLDG.
ONLY.

PLUMB. RISER DIA.
N.T.S.

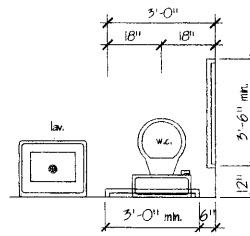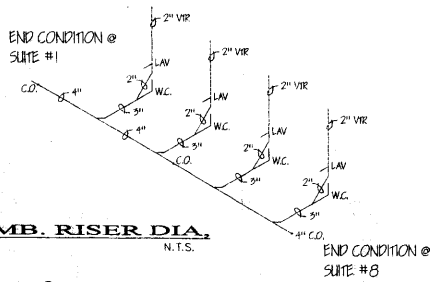

ACCESS. FIXTURES & DETAILS, TYP.
N.T.S.

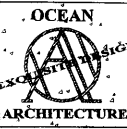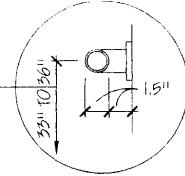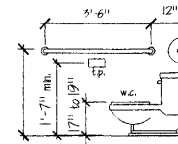

ALICO COMMERCIAL PARK - LOT 12

ALICO COMMERCIAL PARK - LEE COUNTY, FLORIDA


239 • 939 • 3337
OCEAN ARCHITECTURE
7181 COLLINS PKWY. #6
FT. MYERS, FL 33907
www.oceanarchitecture.com

LIC. AR 0011166


DATE 12/1/04 ISSUE 12/9/04

Prepared By: [Signature]
Checked By: [Signature]
Reviewed By: [Signature]

MP

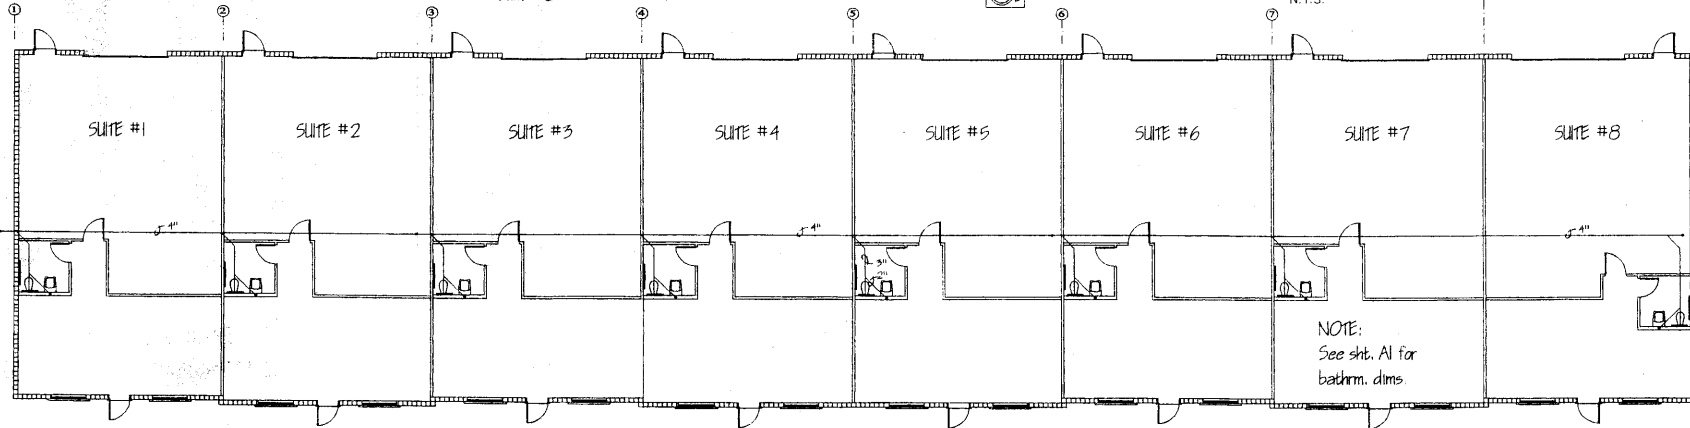


PLUMBING FLOOR PLAN - BLDG. #1

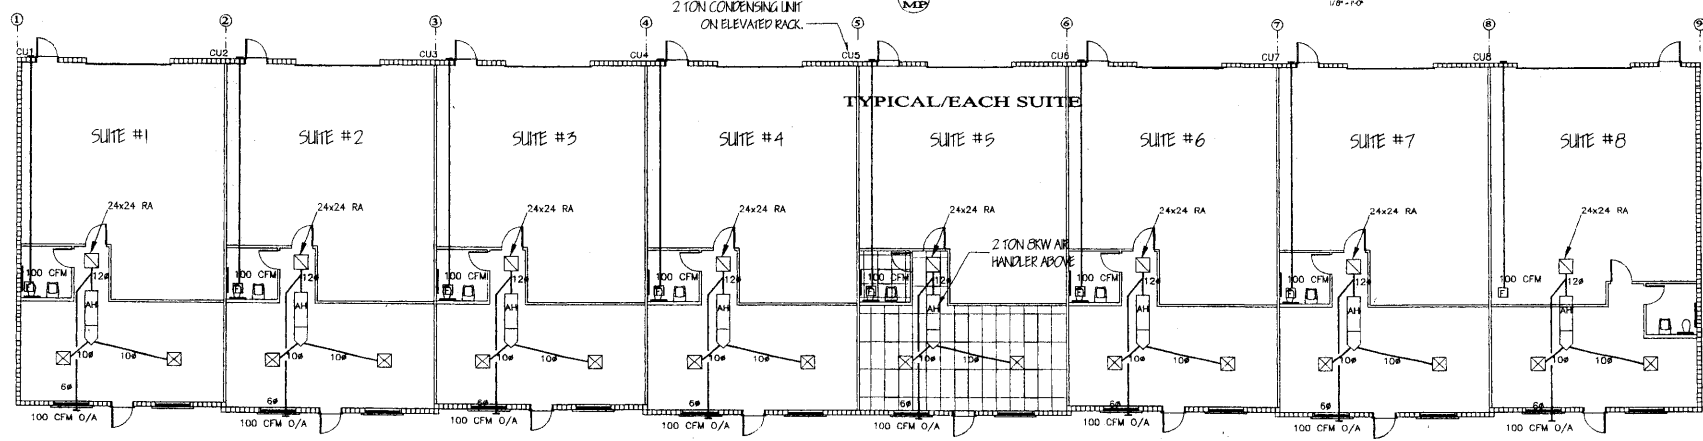


MECHANICAL FLOOR PLAN - BLDG. #1

HVAC LEGEND	
	100 CFM
	200 CFM


REF.	TYPE	SYMBOL	DESCRIPTION
1040	CE	○	FLUORESCENT FIXTURE AND OUTLET (SEE SCHEDULE)
1041	CE	○	6" INCAL RECESSED CAN
1042	WP	○	6" INCAL RECESSED CAN
1043	WP	○	6" INCAL RECESSED CAN
1044	WP	○	6" INCAL RECESSED CAN
1100	WP	○	6" INCAL RECESSED CAN

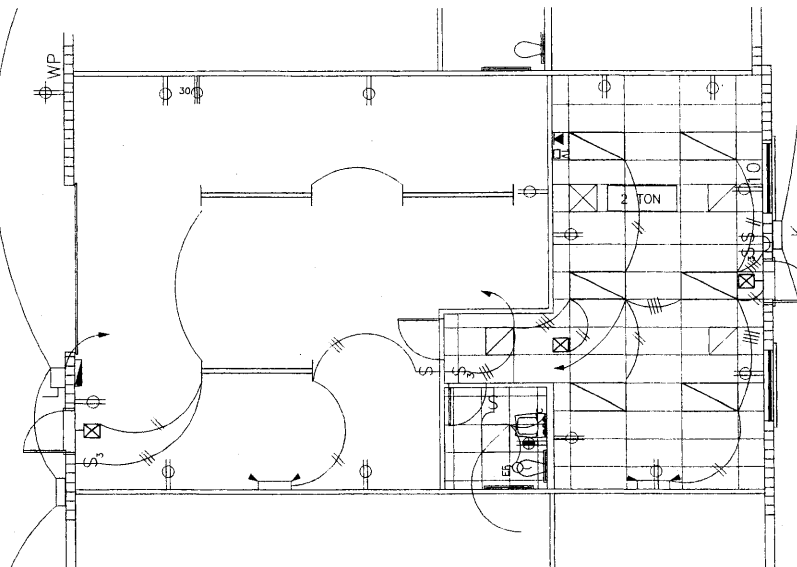

1 TYP. ELECTRIC/LIGHTING FLOOR PLAN
1/8" = 1'-0"

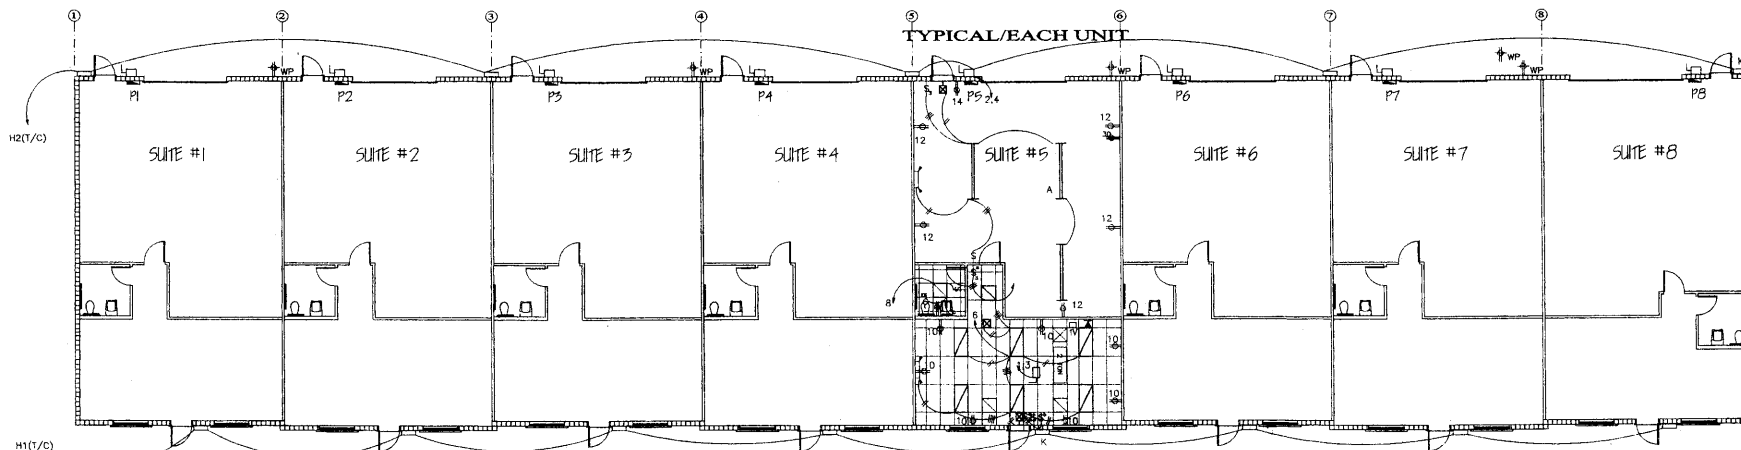

2 ELECTRICAL/LIGHTING FLOOR PLAN - BLDG. #1
1/8" = 1'-0"

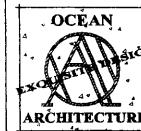

ALICO COMMERCIAL PARK - LOT 12

ALICO COMMERCIAL PARK - LEE COUNTY, FLORIDA

239 * 939 * 3337

OCEAN ARCHITECTURE
7181 COLLEGE PKWY., # 6
FT. MYERS, FL 33907
oceanarchitecture@earthlink.net

LIC. AR. 0011166

DATE 12/7/04 ISSUE
12/9/04 Preparer
12/9/04 Fmr

E1

E2

ALICO COMMERCIAL PARK - LEE COUNTY, FLORIDA

Copyright © 2004 American Institute of Architects. All rights reserved. No part of this publication may be reproduced without the written permission of the American Institute of Architects. The American Institute of Architects is an equal opportunity organization. The American Institute of Architects is not responsible for the content of any advertisements or other communications appearing in this publication. The American Institute of Architects is not responsible for the content of any advertisements or other communications appearing in this publication.

239 * 939 * 3337

OCEAN ARCHITECTURE
7181 COLLEGE PKWY., # 6
FT. MYERS, FL 33907
oceanarchitecture@earthlink.net

LIC: AR 0011166

DATE	ISSUE
------	-------

12/1/04	Preliminary
---------	-------------

12/31/04	Port

1	2	3	466
---	---	---	---	---	---	---	---	---	----	----	-----	-----	
[illegible]

Do

ES

15

1998, 1999, 2000, 2679, 26

**LOAD CALCULATIONS:
UNITS #1 THRU #8**

TYPICAL / UNIT	101.25 AMPS
TOTAL N/C LOAD	X 8 UNITS
	810 AMPS
HOUSE PANEL	12.5 AMPS
TOTAL CONNECTED LOAD	822.5 AMPS
$\frac{822.5 \text{ AMPS}}{1.73} = 475.43 \text{ ASD}$	
USE 600 AMP MAIN DISC.	

USE 600 AMP MAIN DISC

HOUSE PANEL

PANEL		ID#	SERVICE		FEEDER			
12 CIRCUITS			200 VAC W/ 3 PHASE		208 VAC W/ 3 PHASE			
			RATING		MIN. BKR. A.I.C.			
			100 AMP IN O.F.		100 AMP IN O.F.			
CIR.	TRIP	LOAD	A.M.P.	WIRE DESCRIPTION	WIRE LOAD	TRIP	LOAD	A.M.P.
1	20	1000	12	FXT LGF G	RESPINGLES	12	1000	20
5	20	1000	12	FXT LGF G	SPAZ			
7				SPAZ				
8								
9								
CONNECTED LOAD (K.V.A.)			A=2000 B=1000	TOTAL K.V.A. = 3000 WMTS		TOTAL AMPS =		
SERVICES		CONNECTED LOAD		DP	BST. DEMAND LOAD			
ID#								
PWR-5		5000 / 240 = 125 AMPS			(25 AMPS)			


TYP. TENANT PANEL X 8

PANEL "INVENT"		SERVICE		20-240V/10A FEEDER		2" CONDUIT 2" HIG	
				SINGLE PHASE		1" WT CUL+R&G	
20 CIRCUITS RATING		25 AMP MD		MIN. BKR. A.C.C.		0.0000	
OUT	PL	PL	LOAD A	LOAD B	WIRE	LOAD B	LOAD A
1	1	120	200	12	LIGHTING	A/H 15 T/EN 8	8500
2	1	120	200	12	RECEPTS	A/H 15 T/EN 8	9600
4	1	120	200	12	RECEPTS	C/H 2 T/EN 10	10000
6	1	120	200	12	RECEPTS	C/H 2 T/EN 10	10000
8	1	120	200	12	RECEPTS	25A C/EN 12	12000
10	1	120	200	12	RECEPTS	25A C/EN 12	12000
12					SPACE		
14					SPACE		
16					SPACE		
18					SPACE		
20					SPACE		

CONNECTED LOAD (K.V.A.)		TOTAL K.V.A. = 24200		TOTAL SERVICE AMPS = 102.5	
SERVICES	CONNECTED LOAD	DP	EST. DEMAND LOAD		
INVENT					
PANELS					
	24200 / 240 = 100.8		102.5		

NOTES - POWER RISE DIAGRAM

- [illegible]

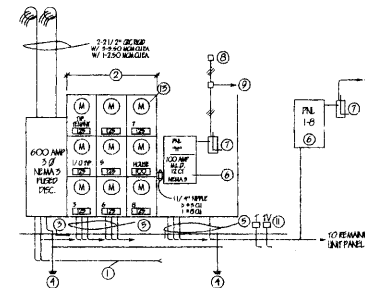

POWER RISER DIAGRAM
N.T.S.

POWER RISER DIAGRAM, PANEL SCHEDULES & LOAD CALCS.

E3

FROM : WOOD SOLUTIONS

FAX NO. : 9414333780

Aug. 29 2005 03:29PM P1

REVISED

REVISED
Floor
PLAN
TYPICAL

