



LOGO

CONFERENCE
→



INTERIORS



RESTROOM
←

RESTROOM
→



CONFERENCE
→

LOGO

T
INTERIORS


RESTROOM
→

CONFERENCE
→



T
INTERIORS



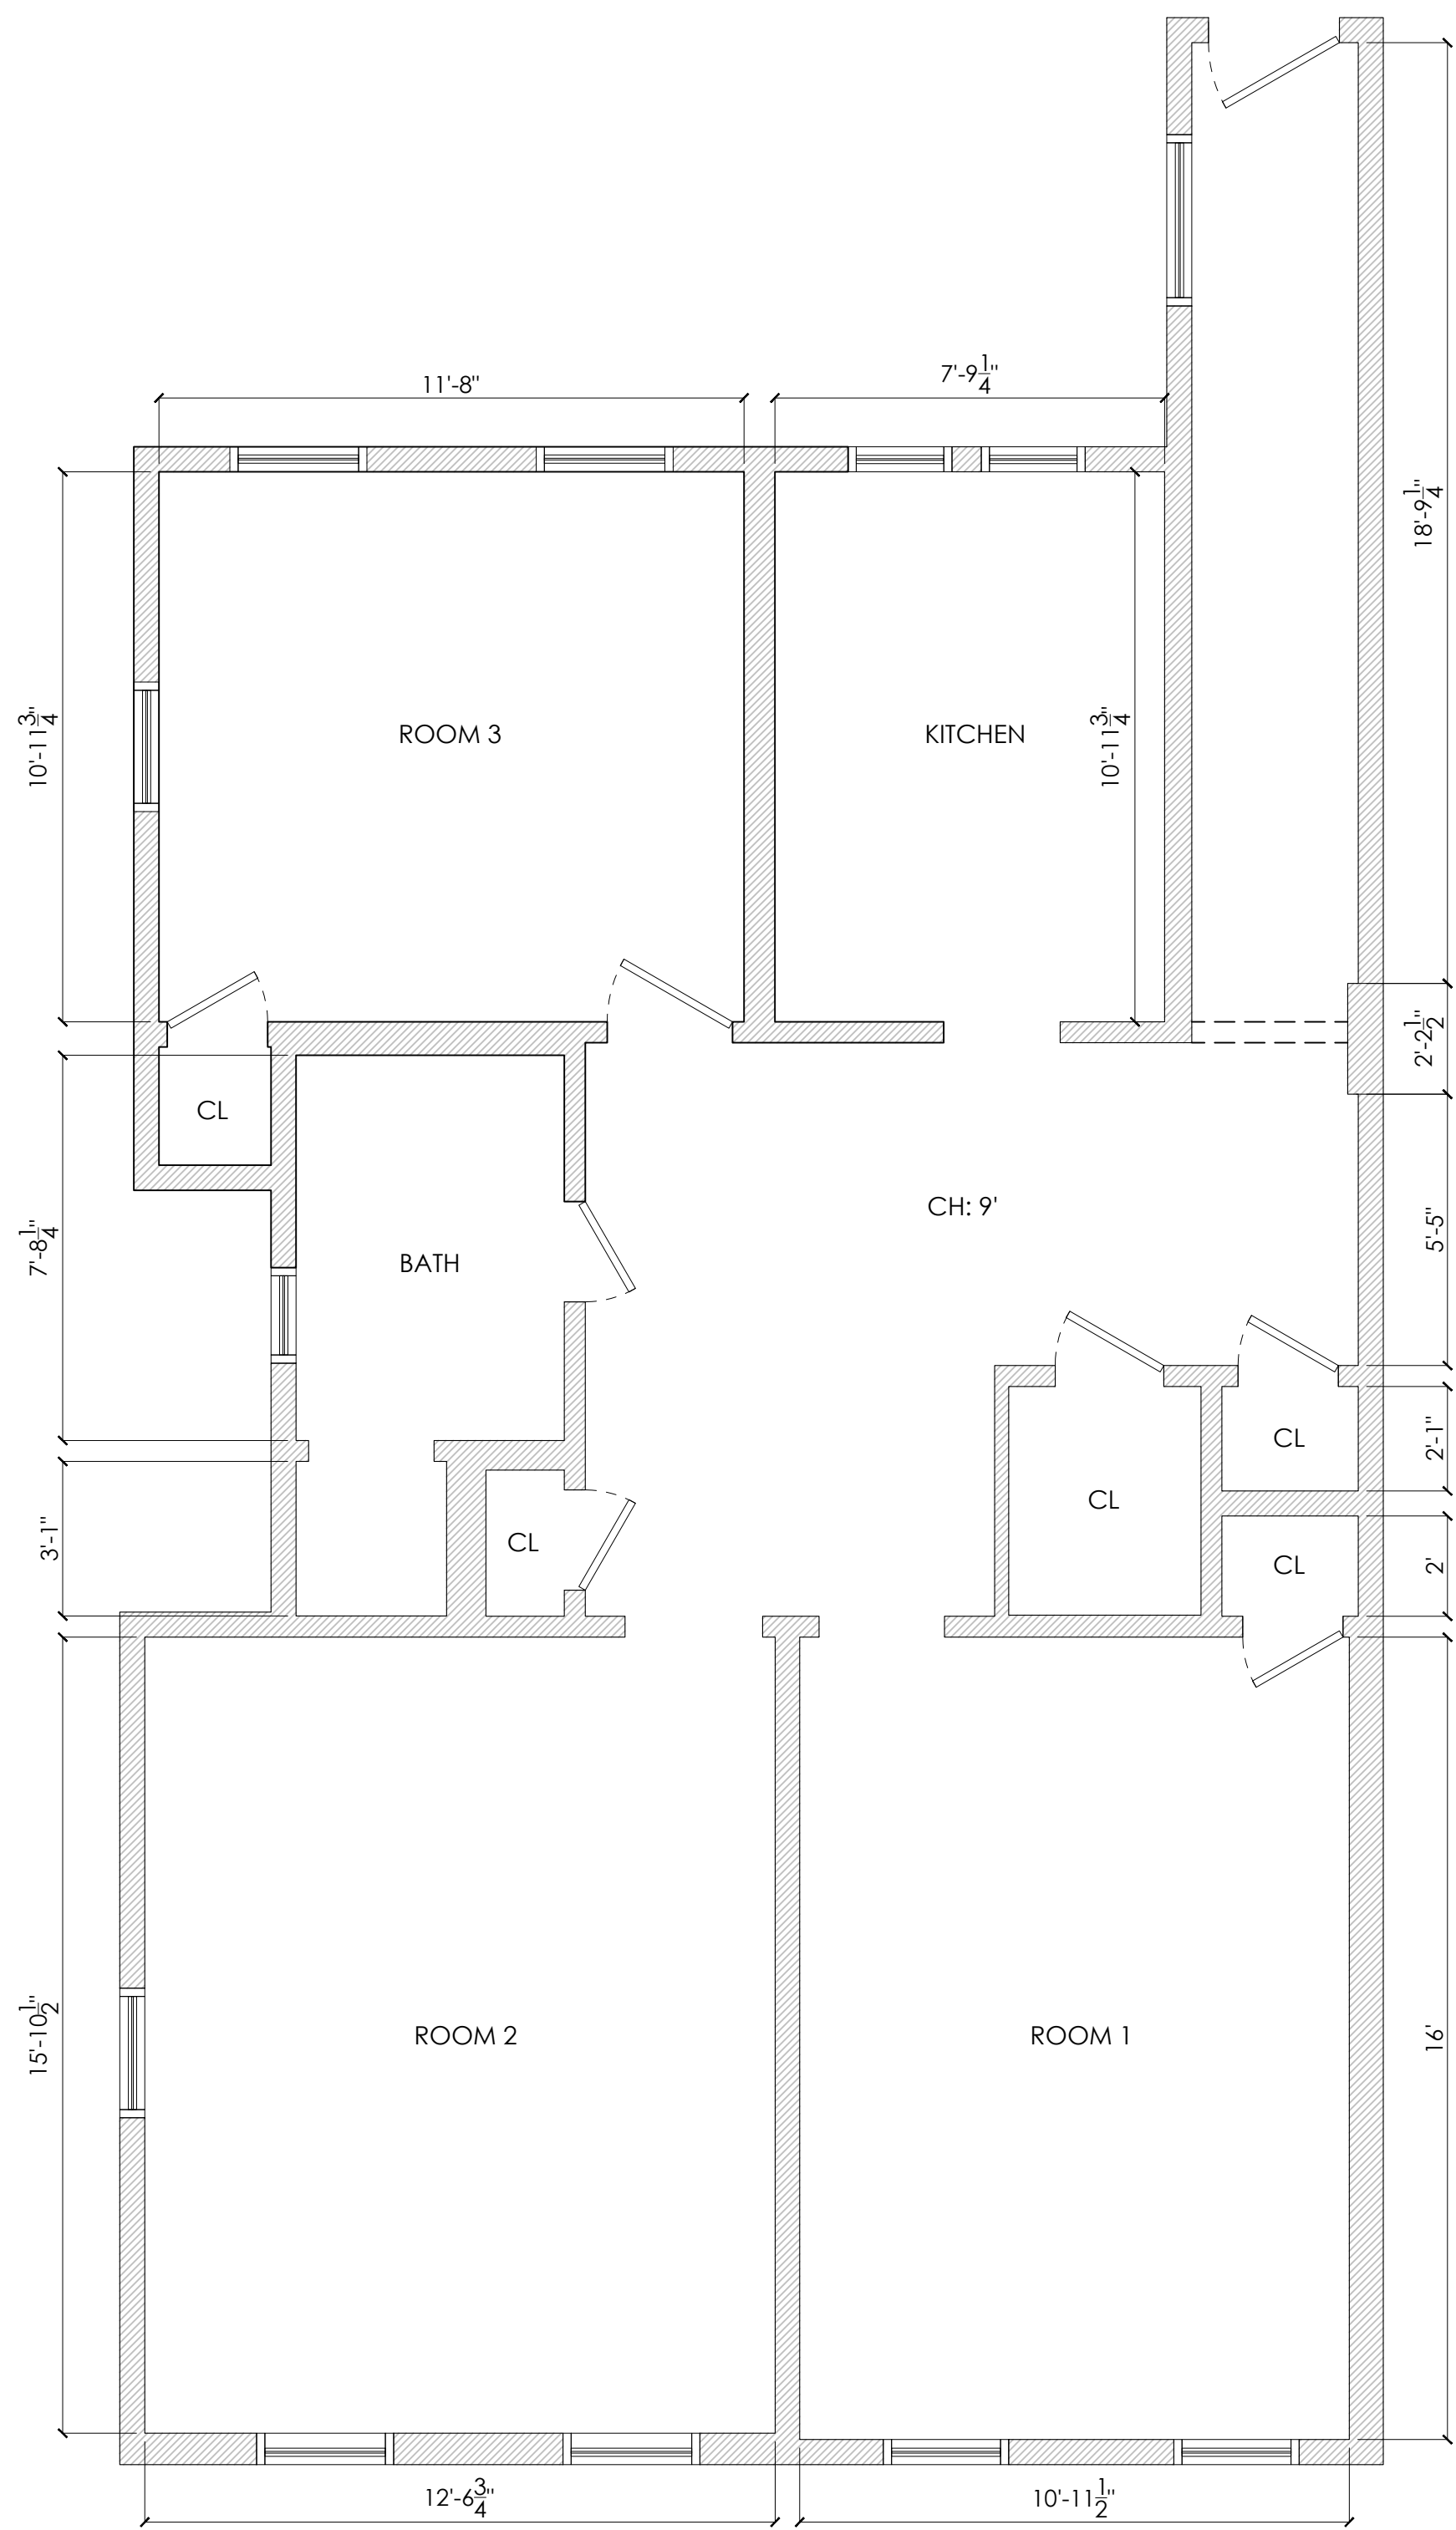

1

EXISTING FLOOR PLAN

Scale: 5/16" = 1'-0"



INTERIORS

TAMARA THALER
646-226-2374
TAMARA@TTINTERIORSLLC.COM

LEGEND:

NOTES:

PROJECT TITLE:
KAY OFFICE

DRAWING TILE:
EXISTING FLOOR PLAN

SCALE: 5/16" = 1'-0"

DRAWN: 5.7.2026

DRAWING #:

AX



INTERIORS

TAMARA THALER
646-226-2374
TAMARA@TTINTERIORSLLC.COM

LEGEND:

NOTES:

PROJECT TITLE:
KAY OFFICE


DRAWING TILE: DEMO
PLAN

SCALE: 5/16" = 1'-0"

DRAWN: 5.7.2026

DRAWING #:

DEMO

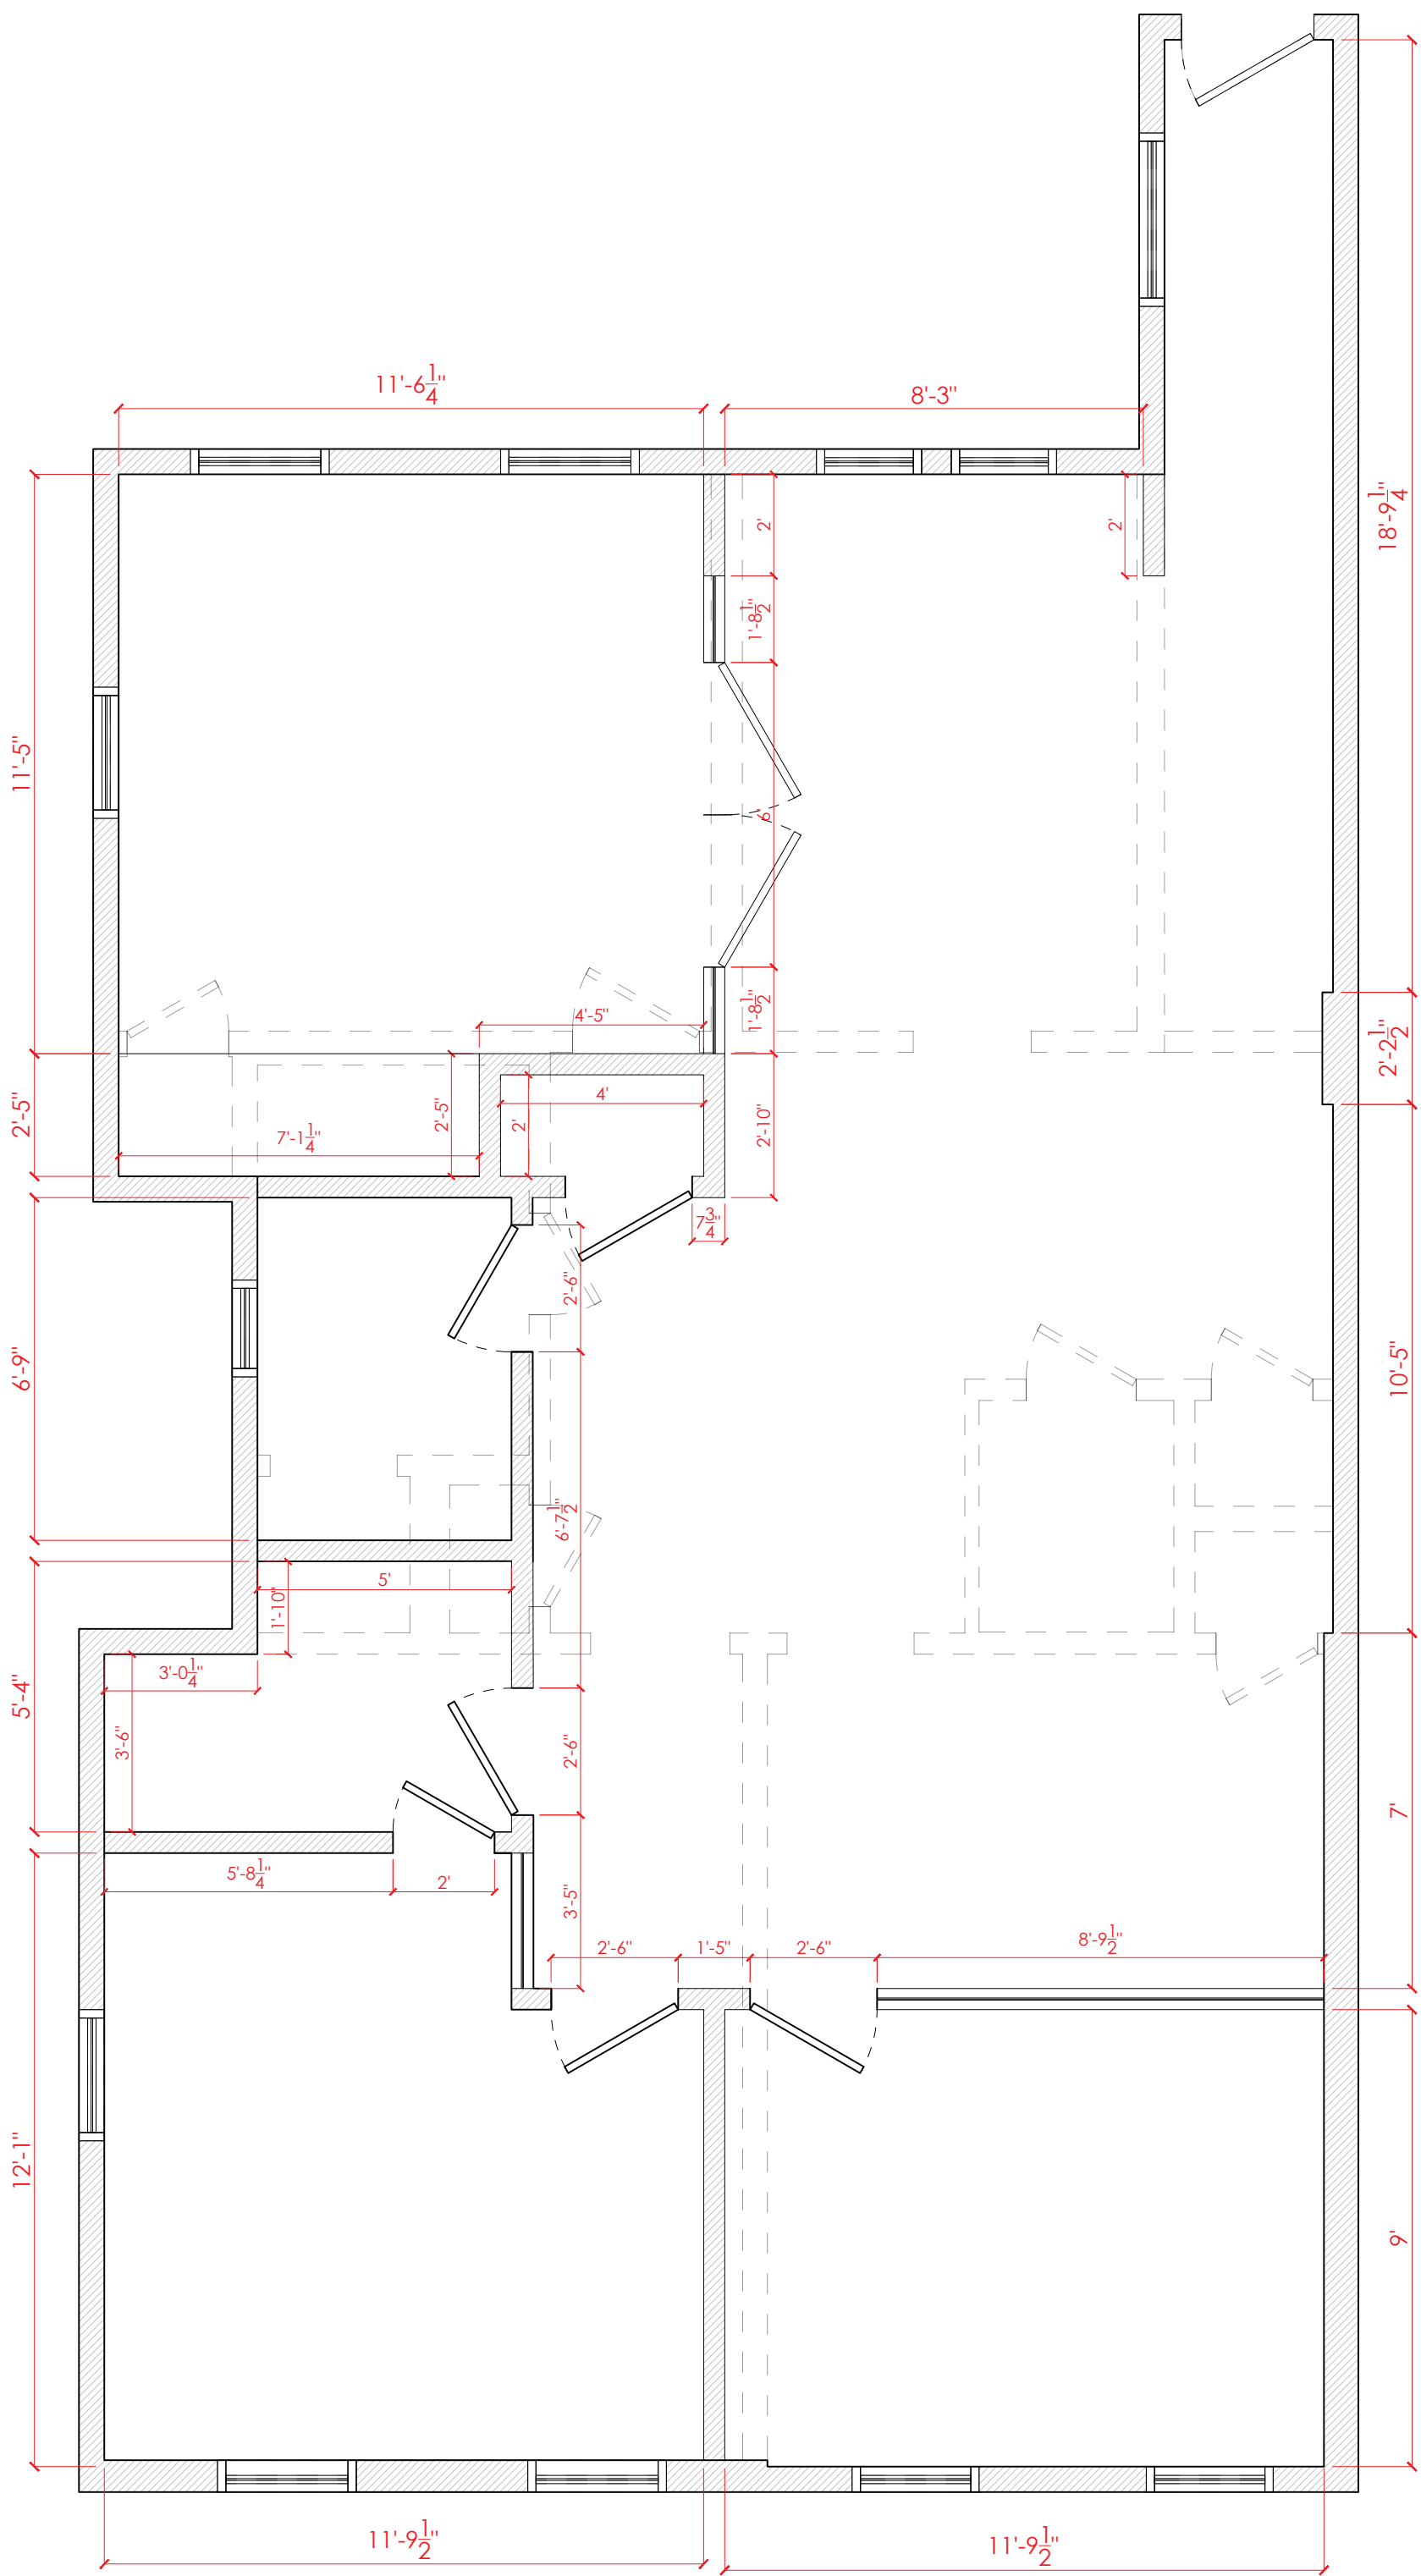

1

EXISTING FLOOR PLAN

Scale: 5/16" = 1'-0"



INTERIORS

TAMARA THALER
646-226-2374
TAMARA@TTINTERIORSLLC.COM

LEGEND:

NOTES:

PROJECT TITLE:
KAY OFFICE


DRAWING TILE:
PROPOSED PLAN

SCALE: 5/16" = 1'-0"

DRAWN: 5.7.2026

DRAWING #:

A-1

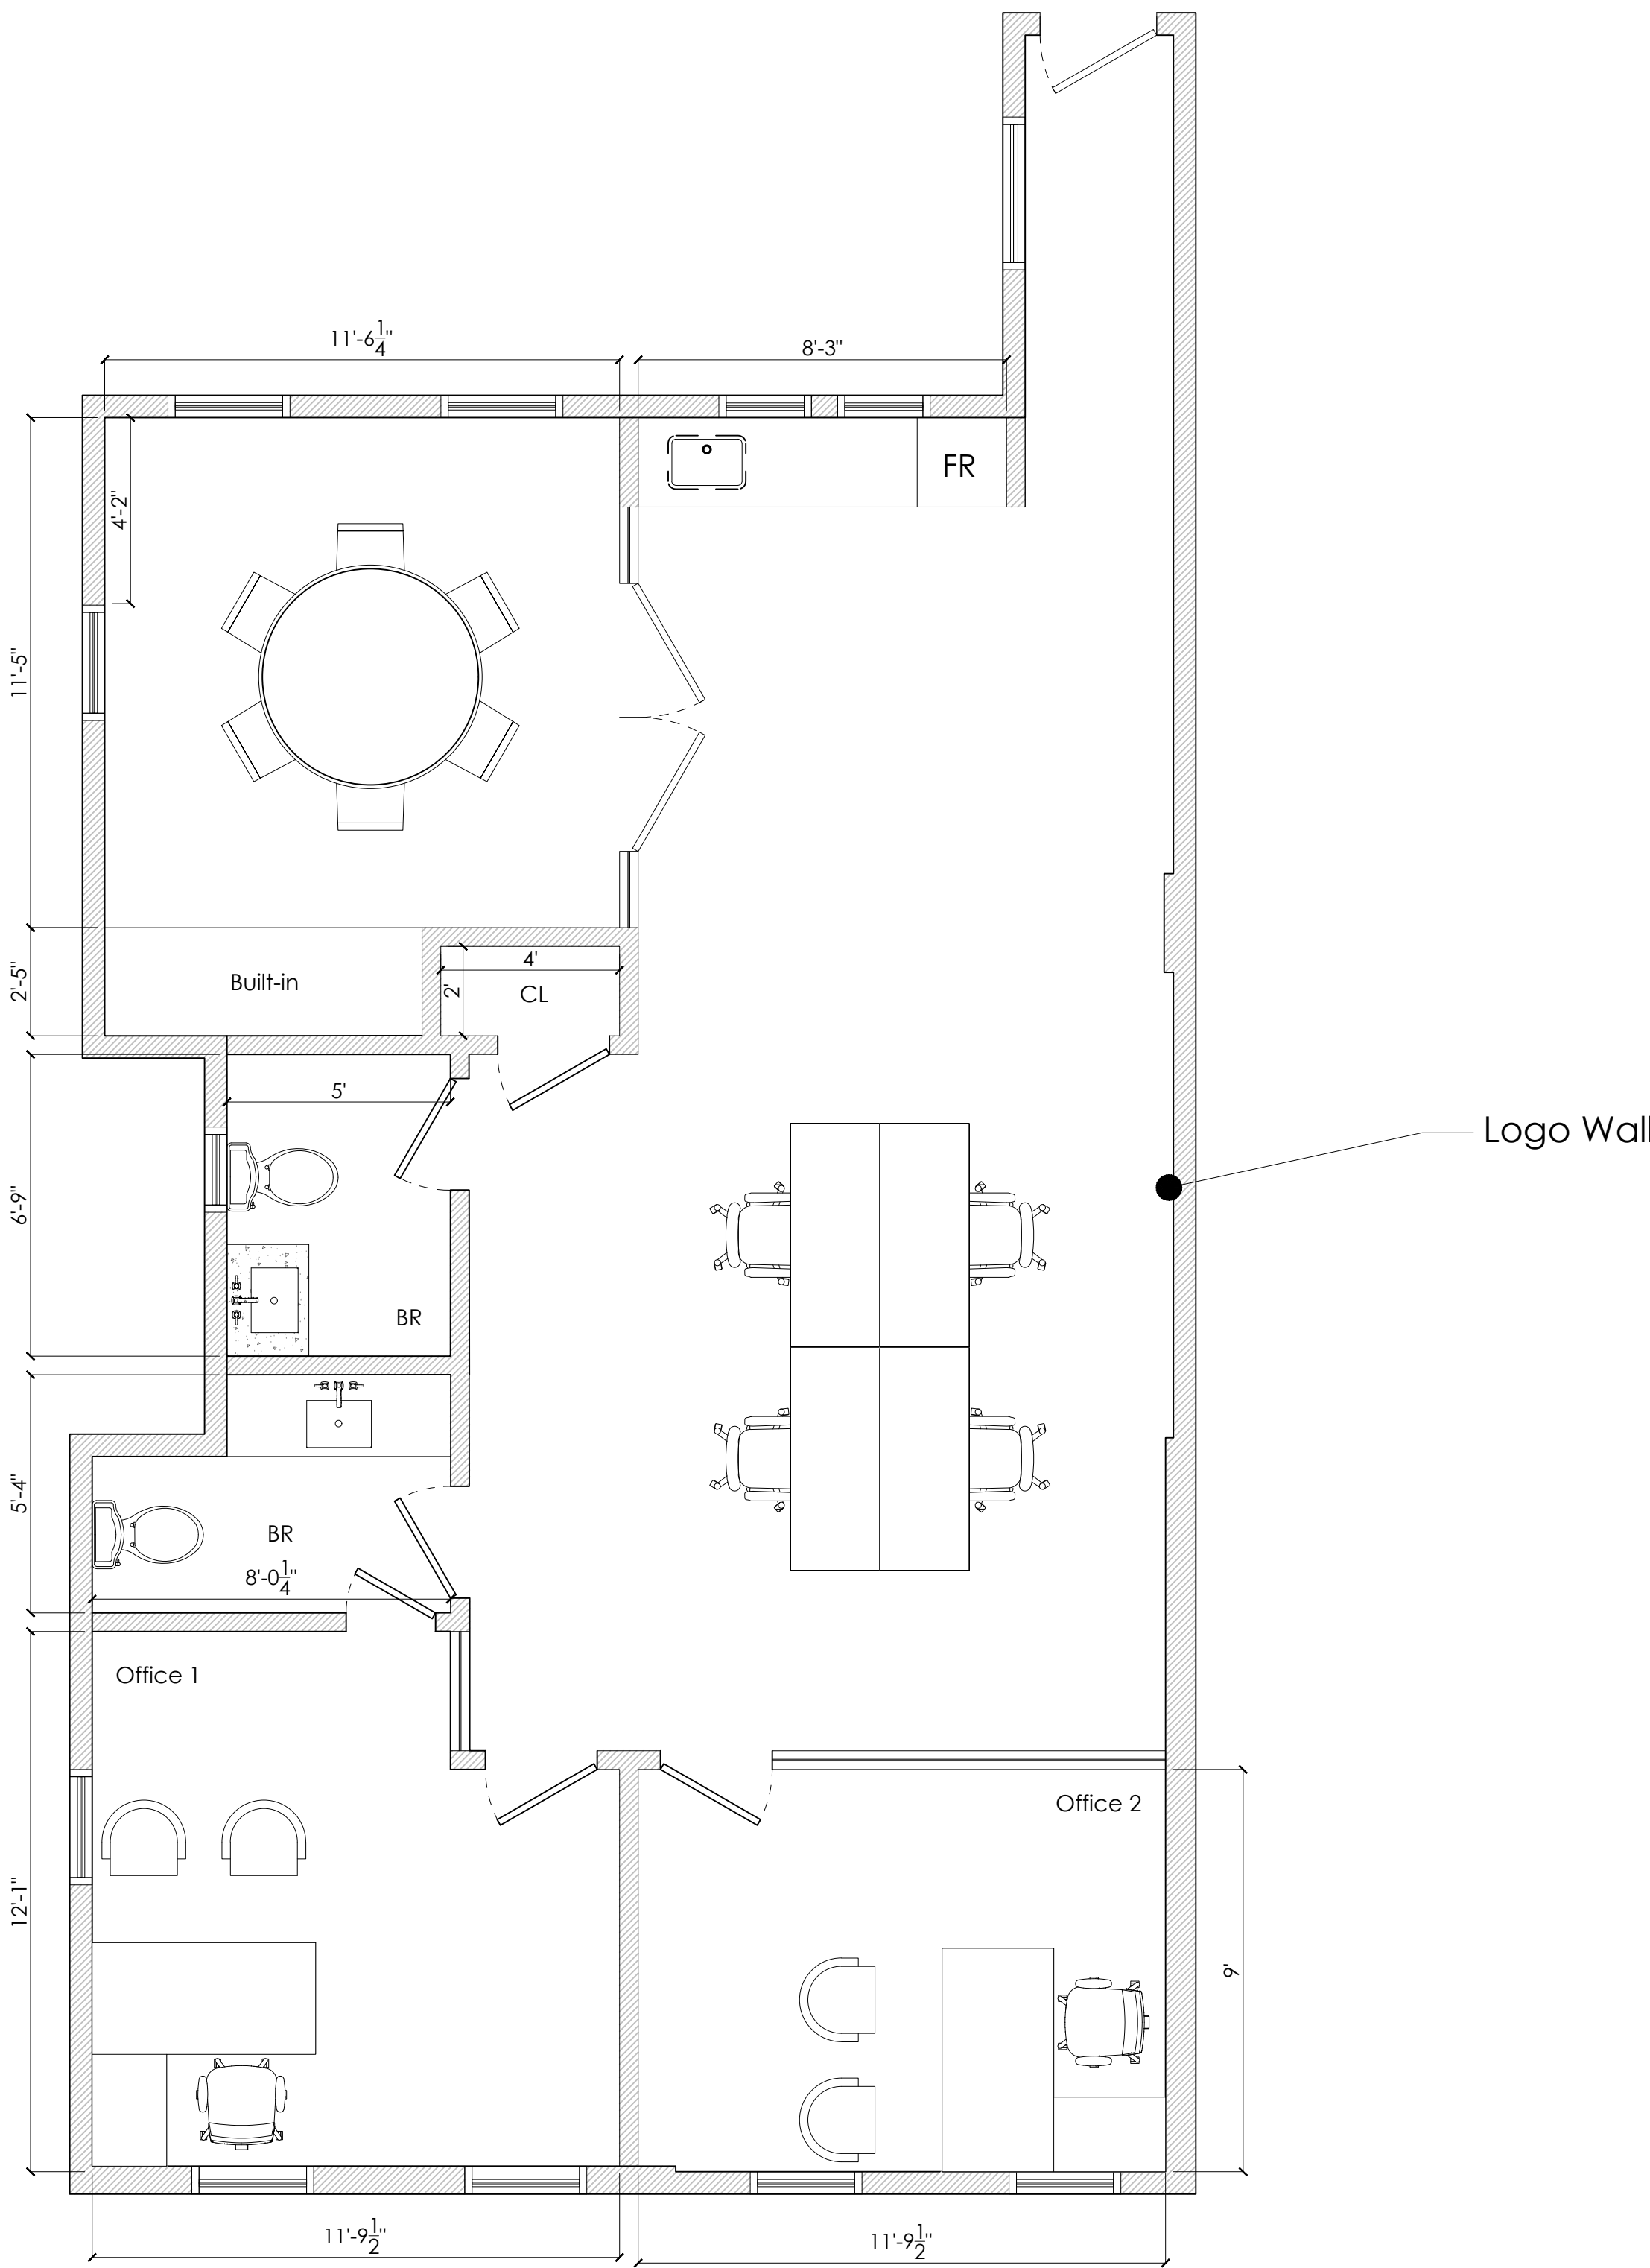

1

PROPOSED FLOOR PLAN

Scale: 5/16" = 1'-0"



INTERIORS

TAMARA THALER
646-226-2374
TAMARA@TTINTERIORSLLC.COM

LEGEND:

NOTES:

PROJECT TITLE:
KAY OFFICE


DRAWING TILE:
PROPOSED RCP

SCALE: 5/16" = 1'-0"


DRAWN: 5.7.2026

DRAWING #:


A-2

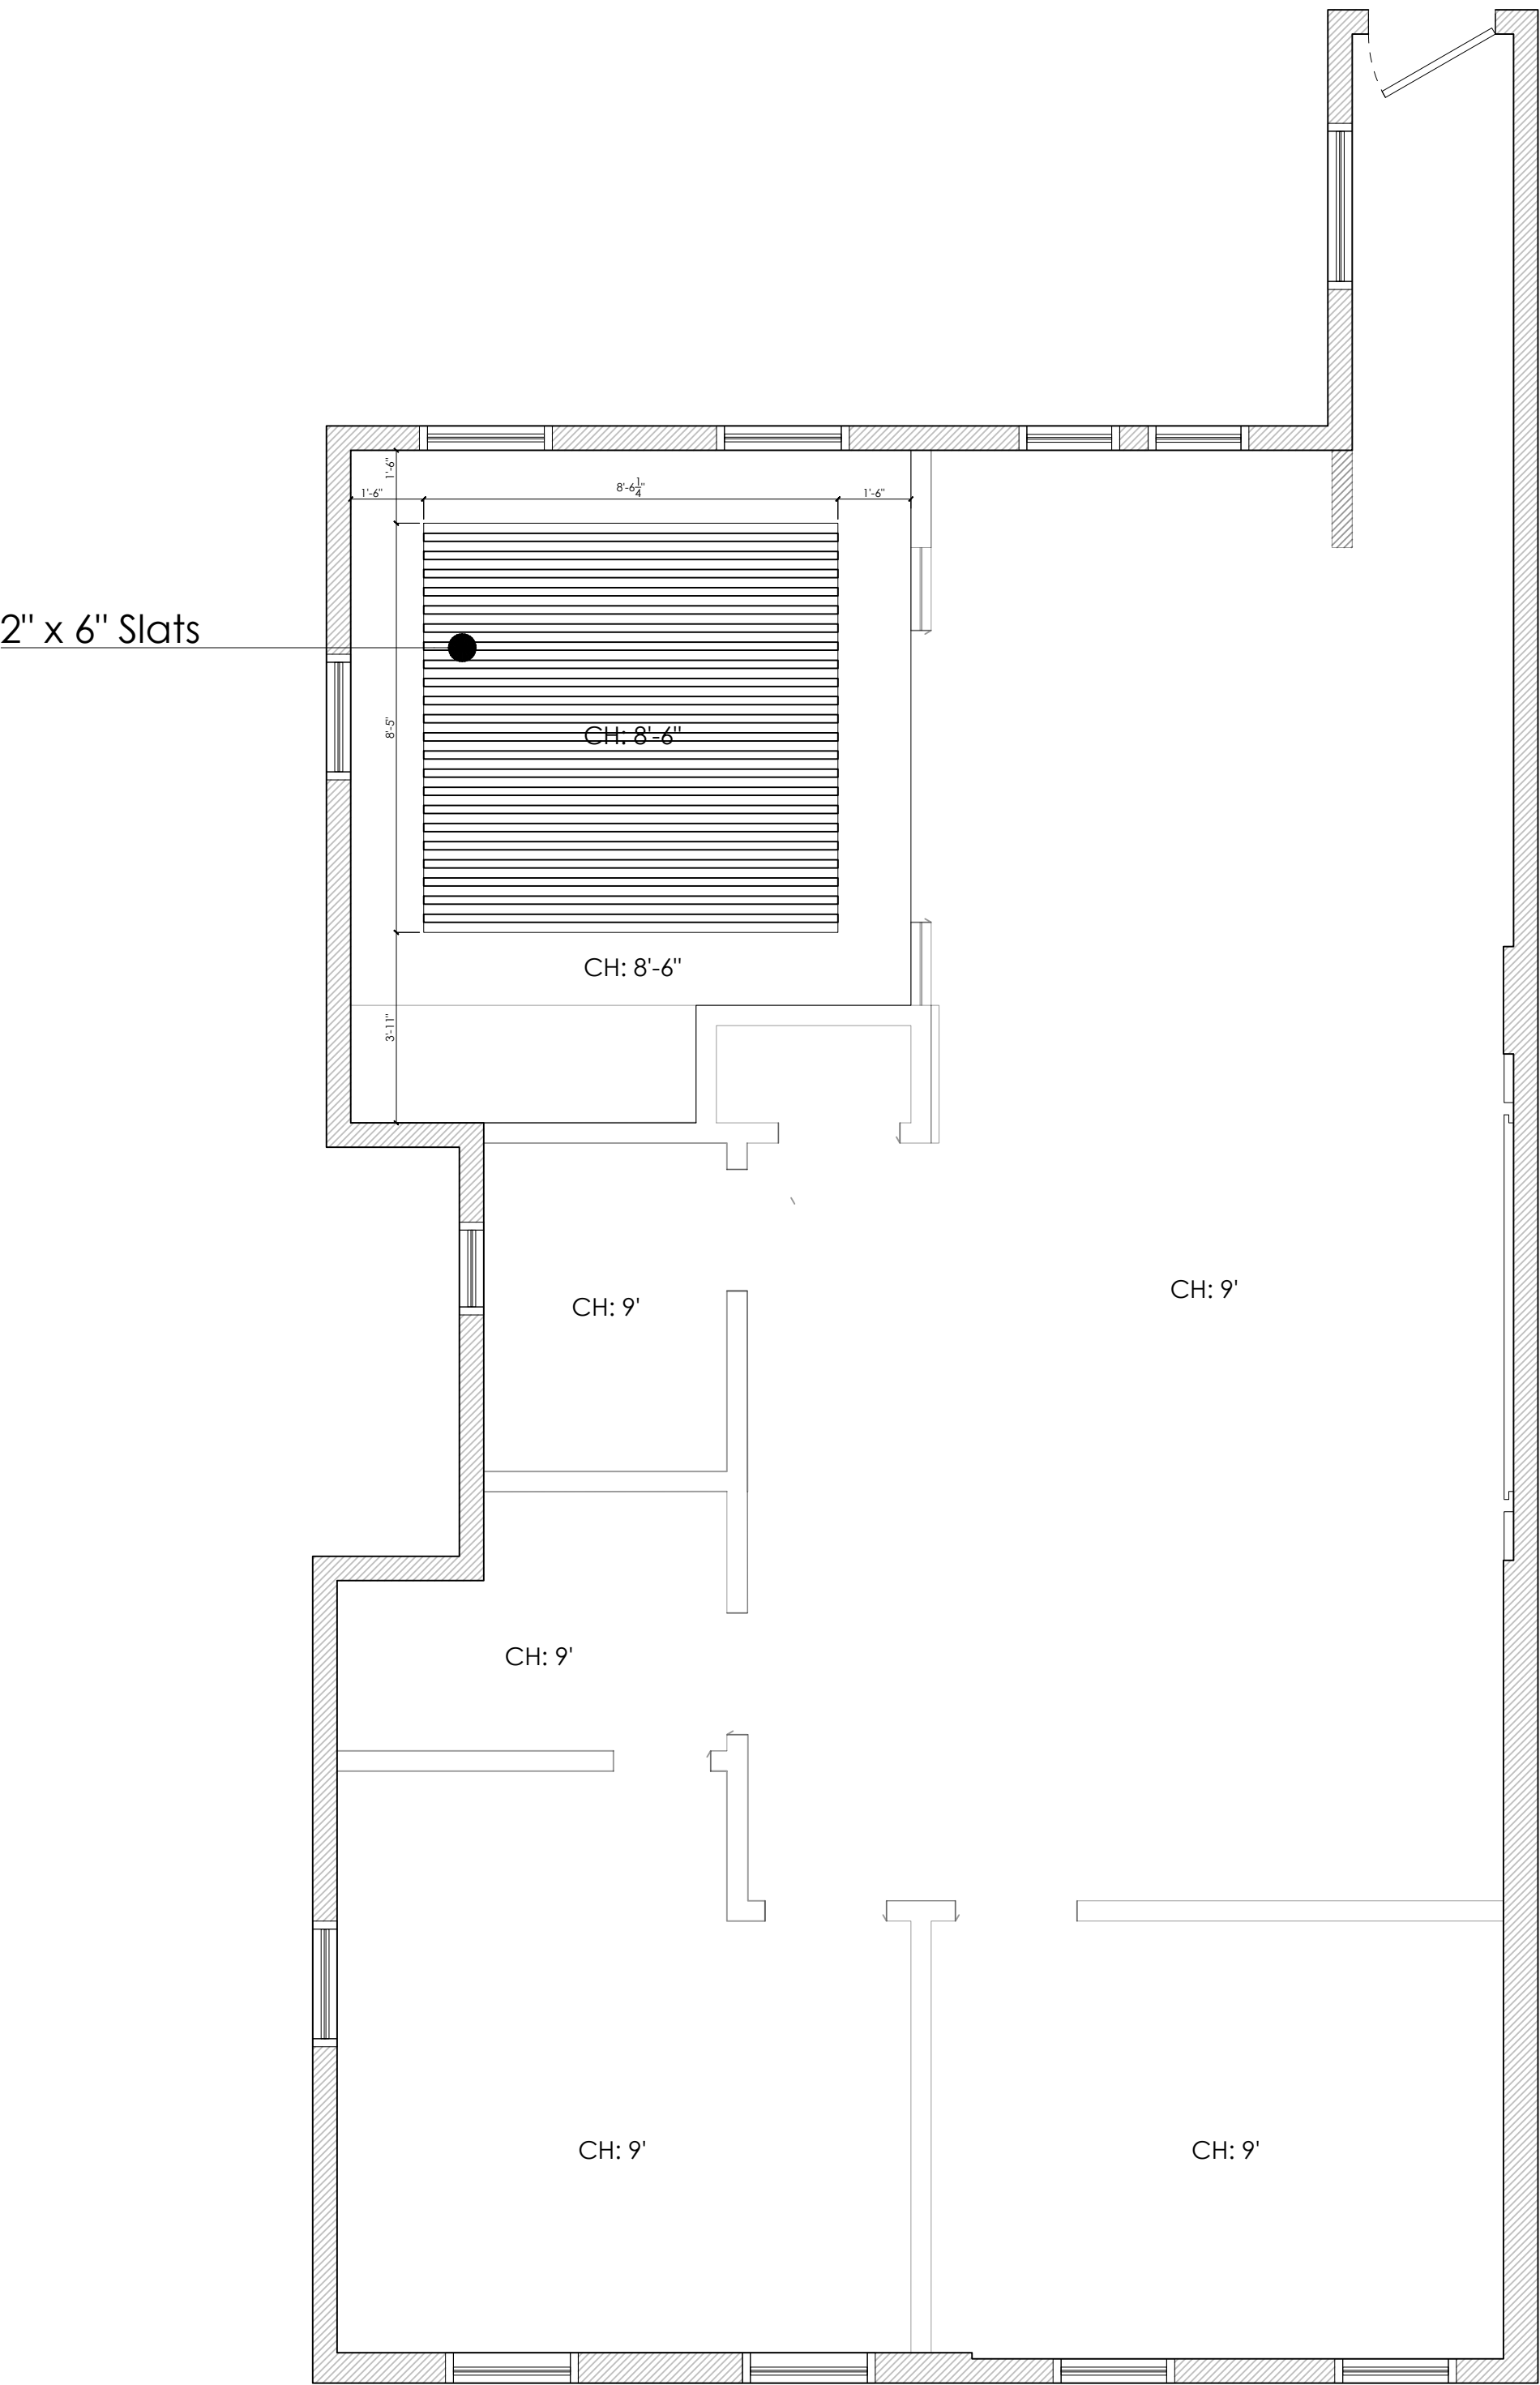


1 **PROPOSED RCP**
Scale: 5/16" = 1'-0"

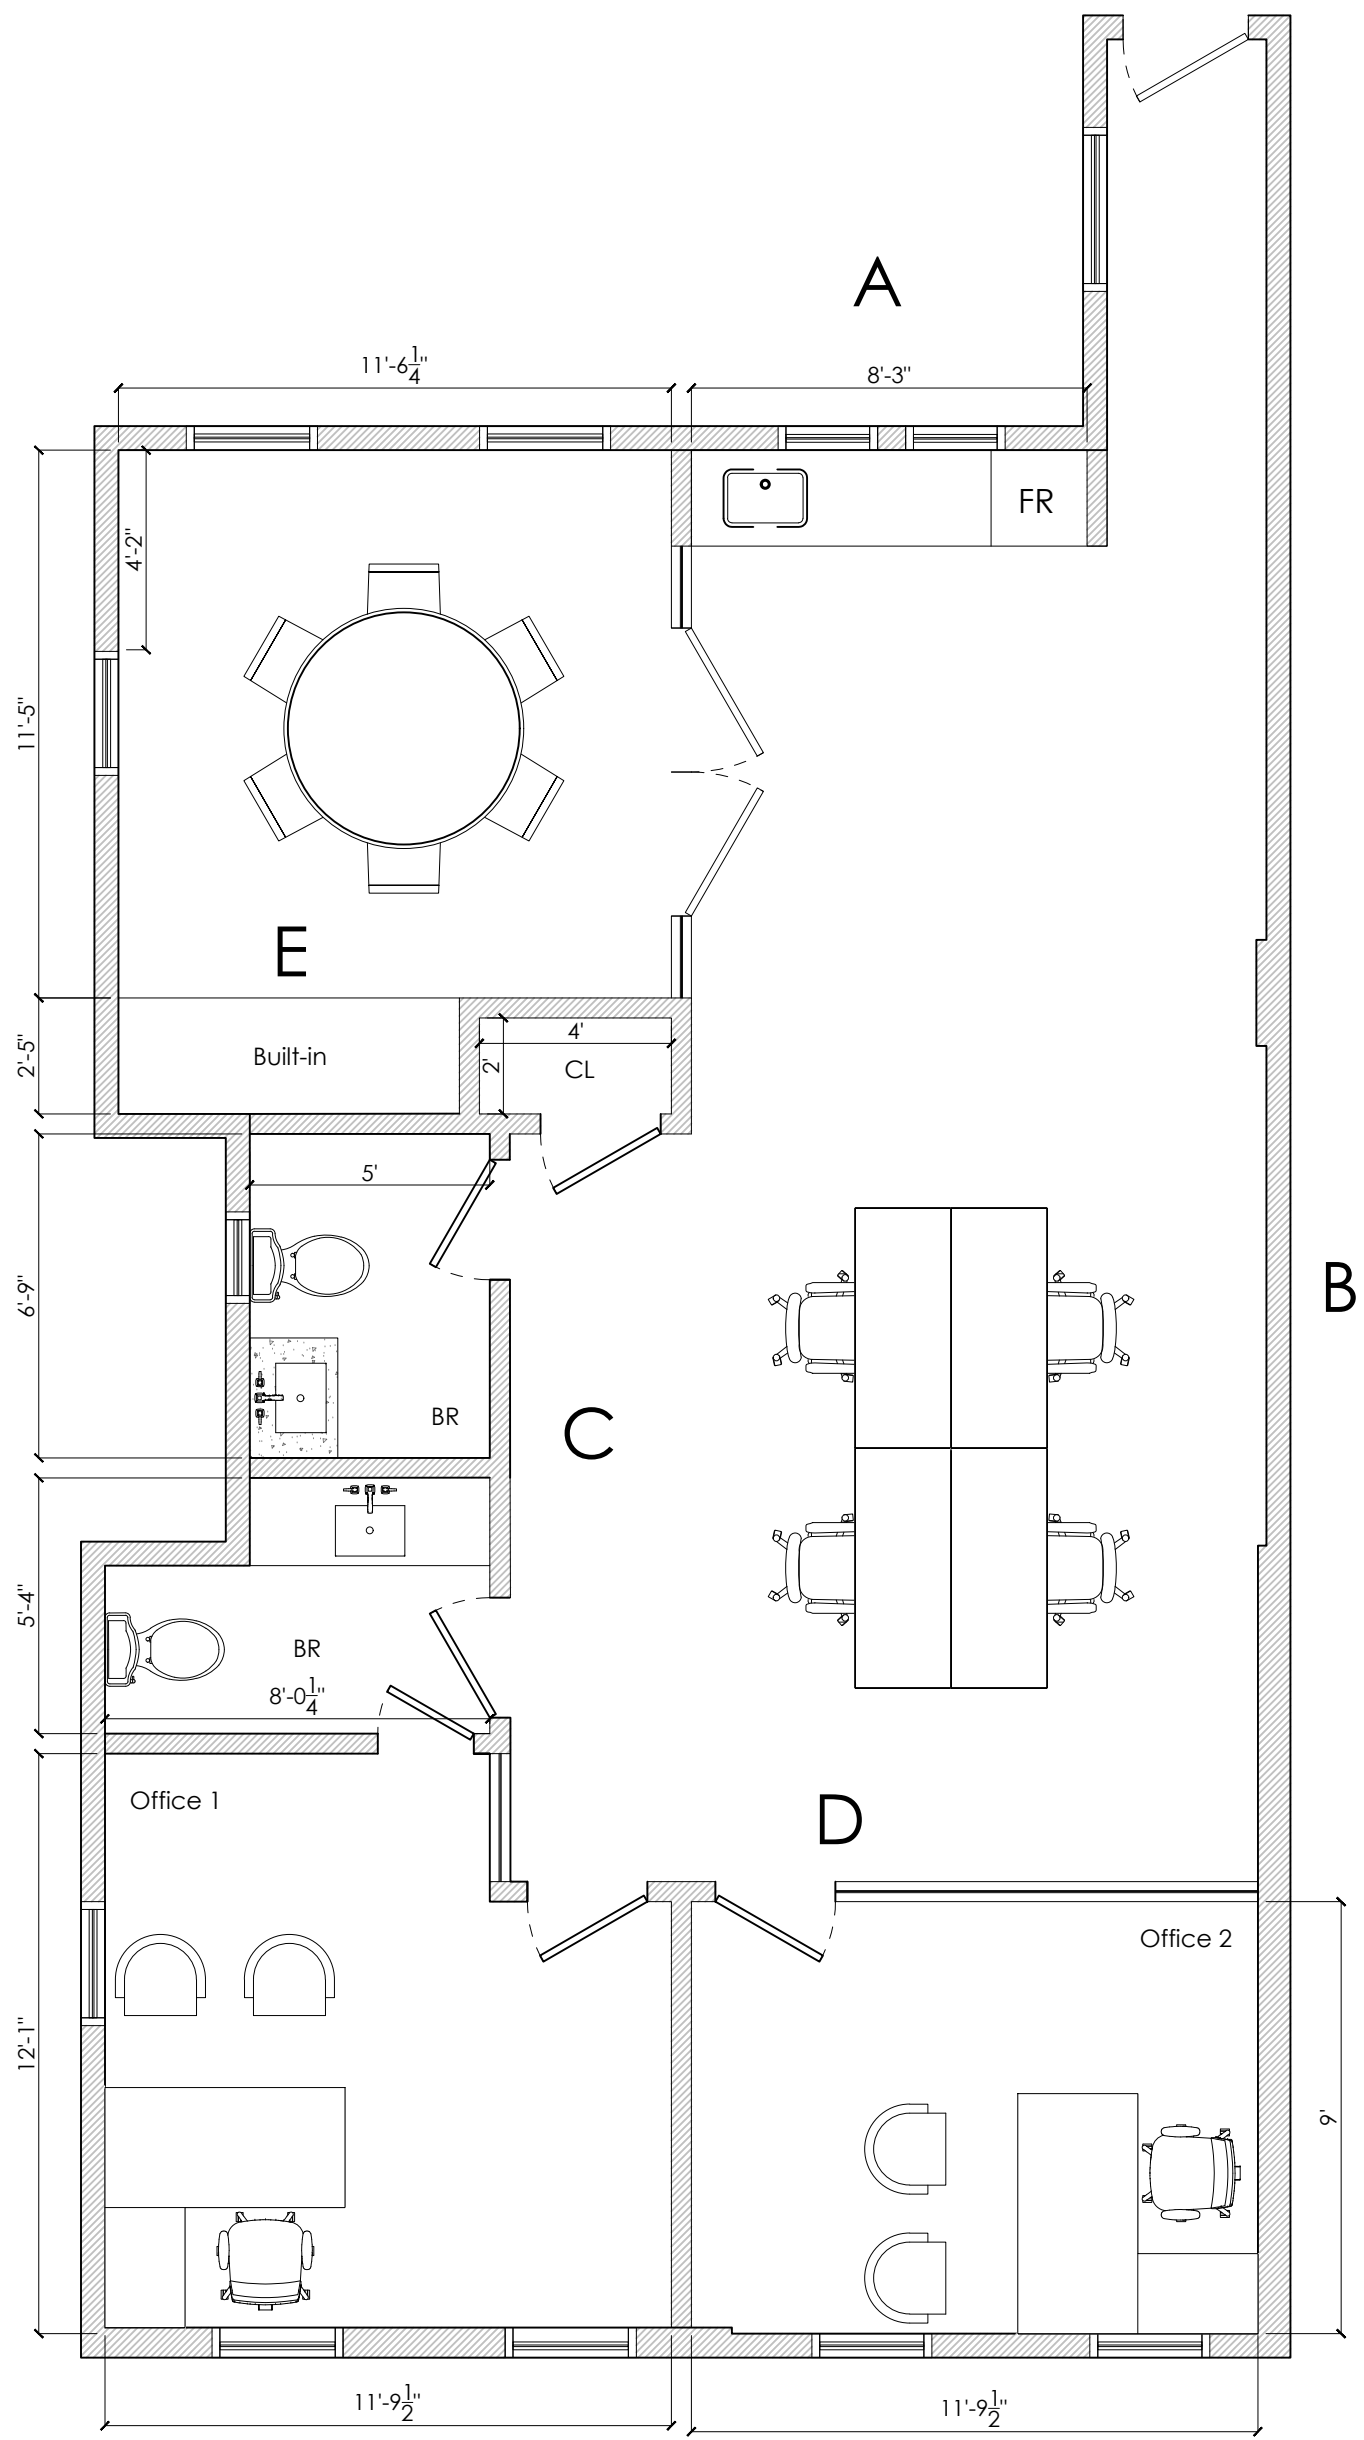


1 **PROPOSED FLOOR PLAN**
Scale: 1/4" = 1'-0"

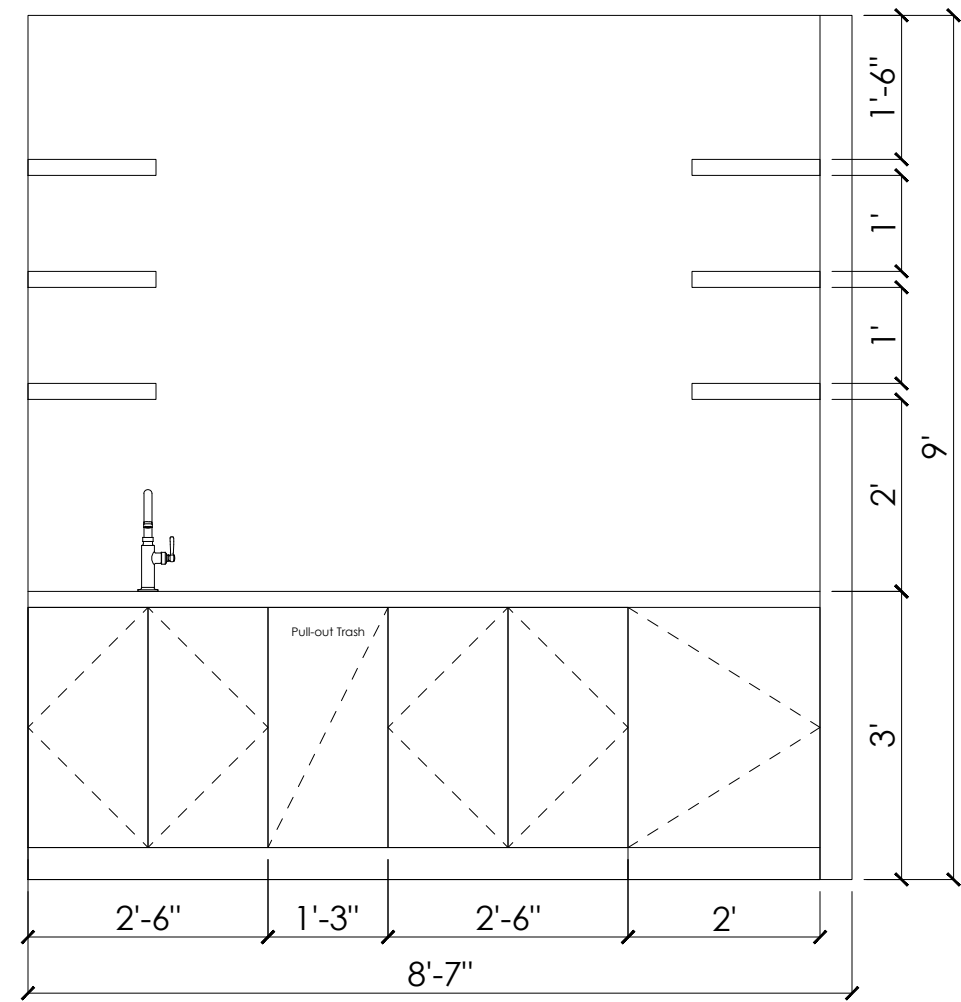


2 **ELEVATION A**
Scale: 1/4" = 1'-0"

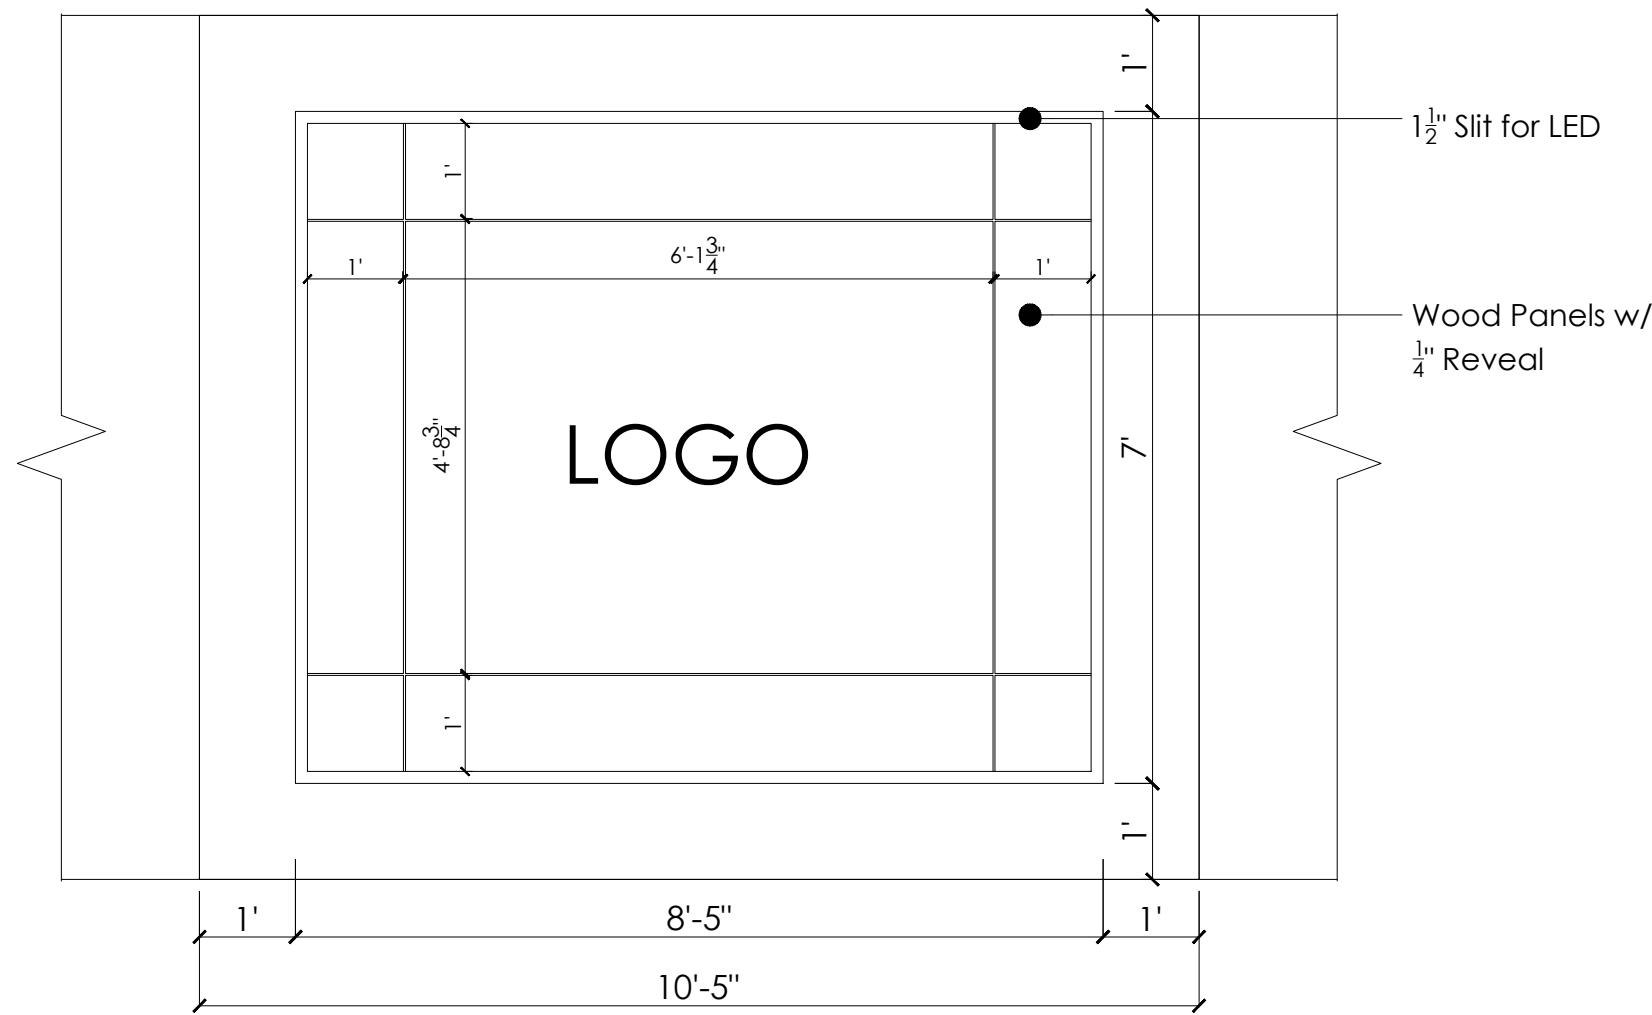


3 **ELEVATION B**
Scale: 1/4" = 1'-0"

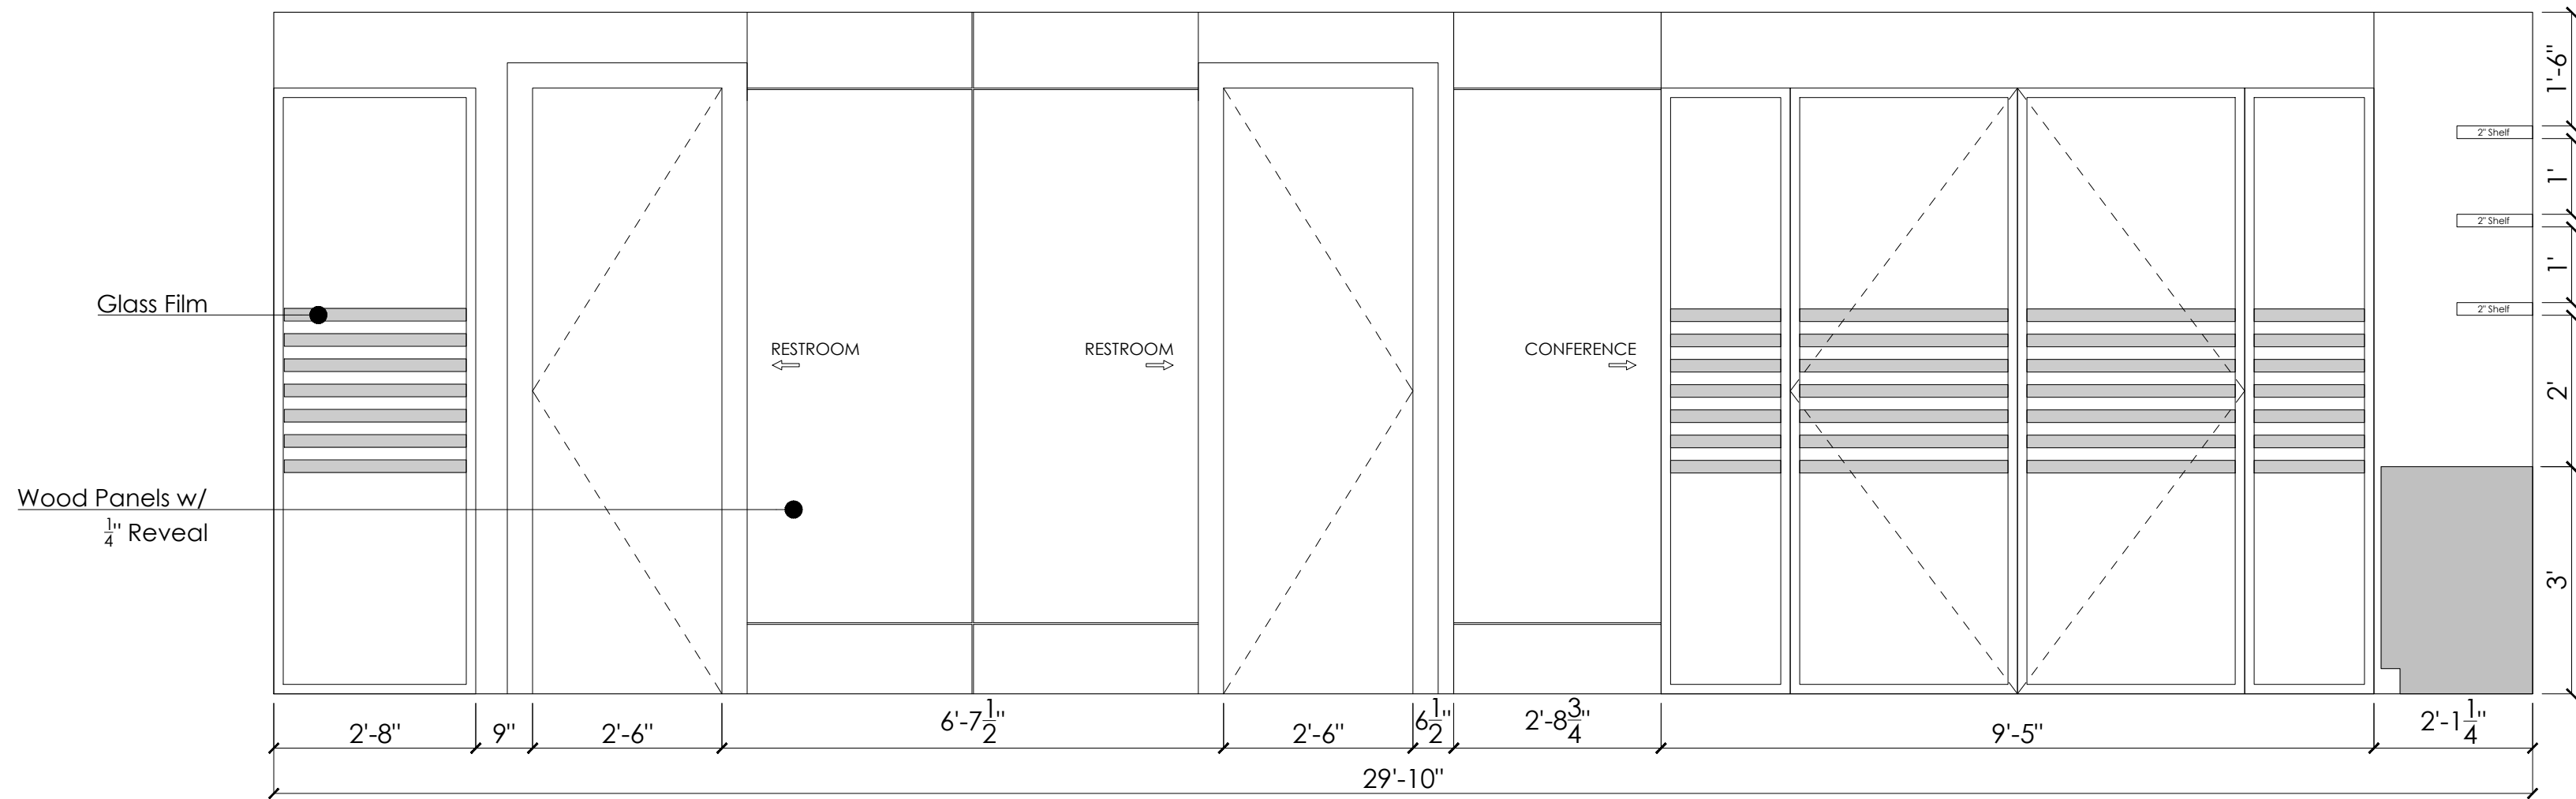

3 **ELEVATION C**
Scale: 1/4" = 1'-0"

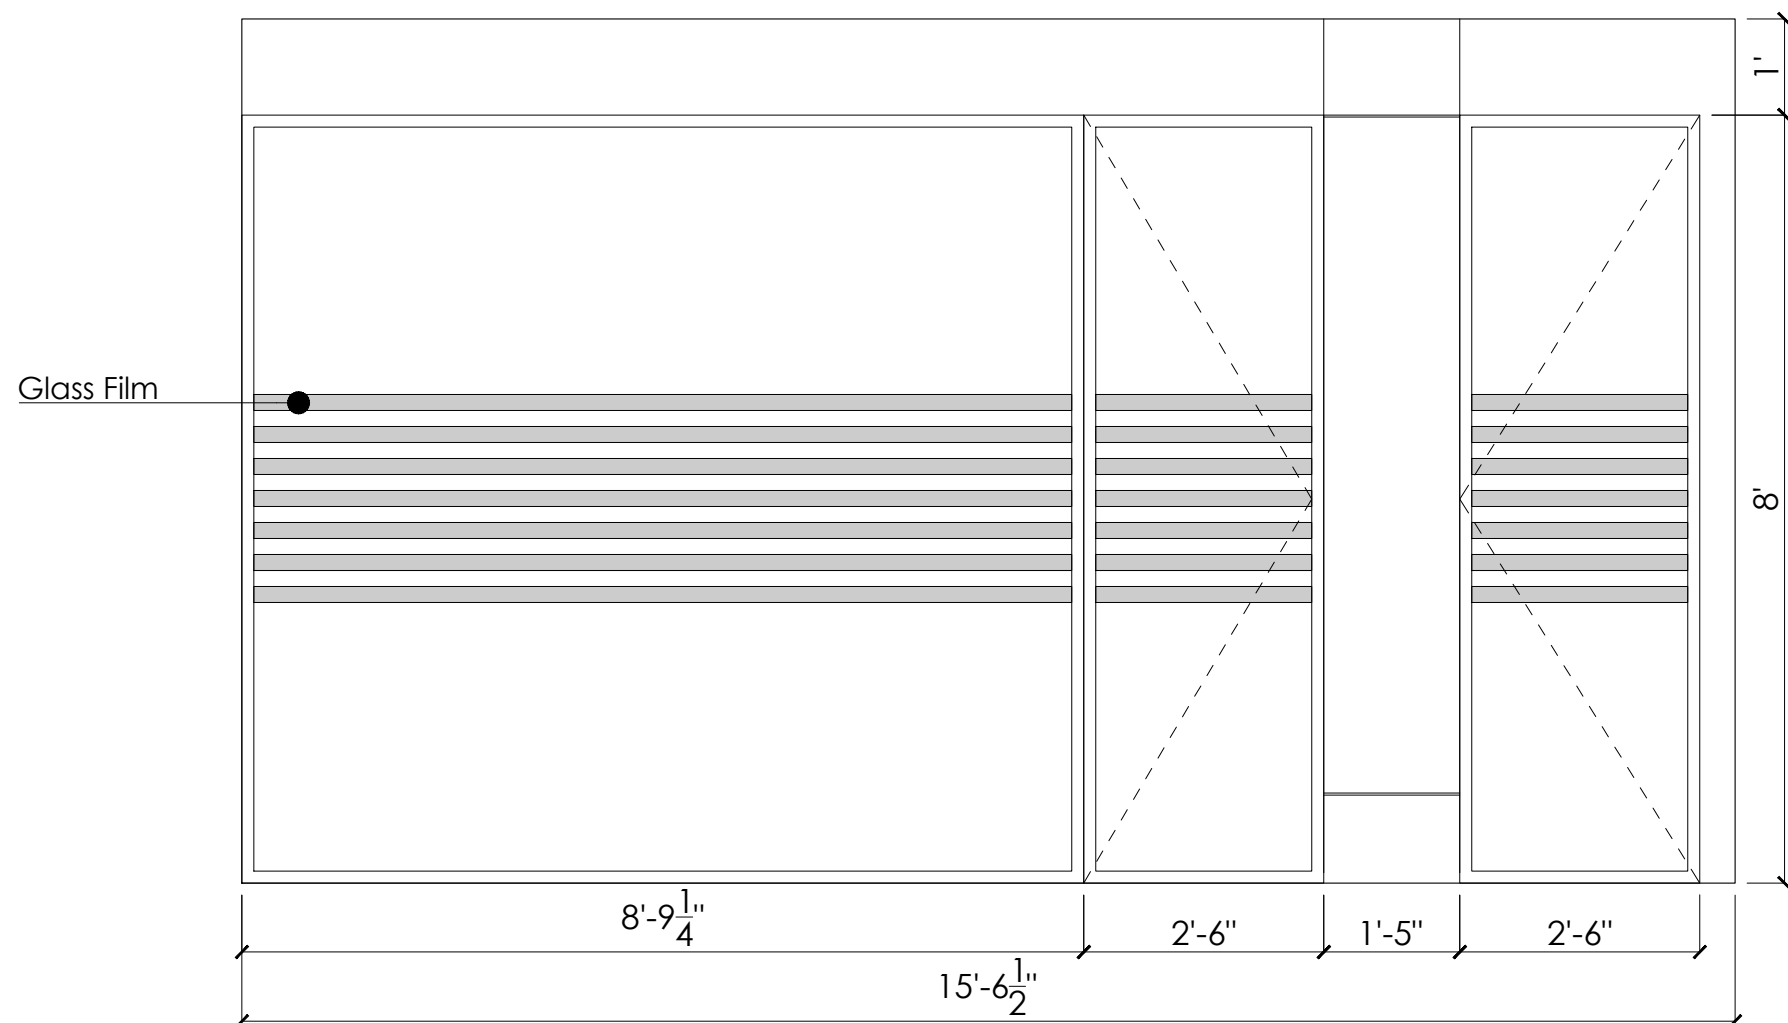

4 **ELEVATION D**
Scale: 1/4" = 1'-0"

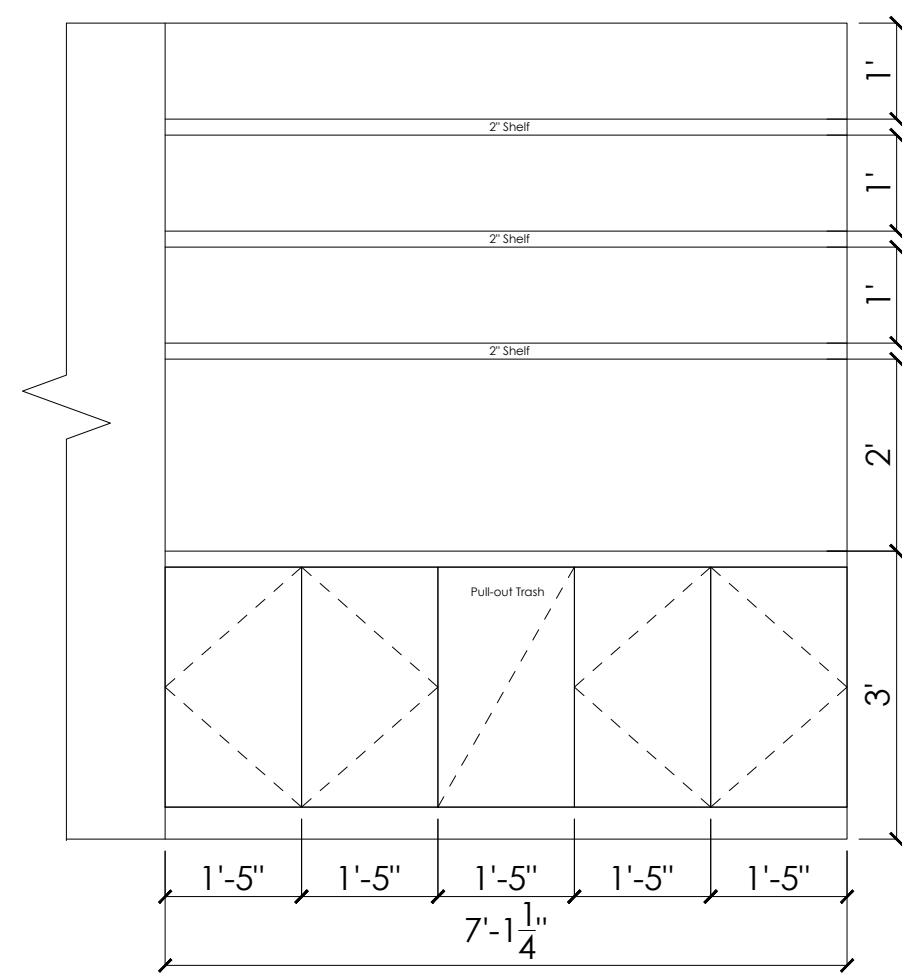

5 **ELEVATION E**
Scale: 1/4" = 1'-0"



INTERIORS

TAMARA THALER
646-226-2374
TAMARA@TTINTERIORSLLC.COM

LEGEND:

NOTES:

PROJECT TITLE:
KAY OFFICE

DRAWING TILE:
ELEVATIONS

SCALE: 1/4" = 1'-0"

DRAWN: 5.7.2026

DRAWING #:

A-3



INTERIORS

TAMARA THALER
646-226-2374
TAMARA@TTINTERIORSLLC.COM

LEGEND:

NOTES:

PROJECT TITLE:
KAY OFFICE


DRAWING TILE: LOGO
WALL

SCALE: 1" = 1'-0"


DRAWN: 5.7.2026

DRAWING #:

D-1

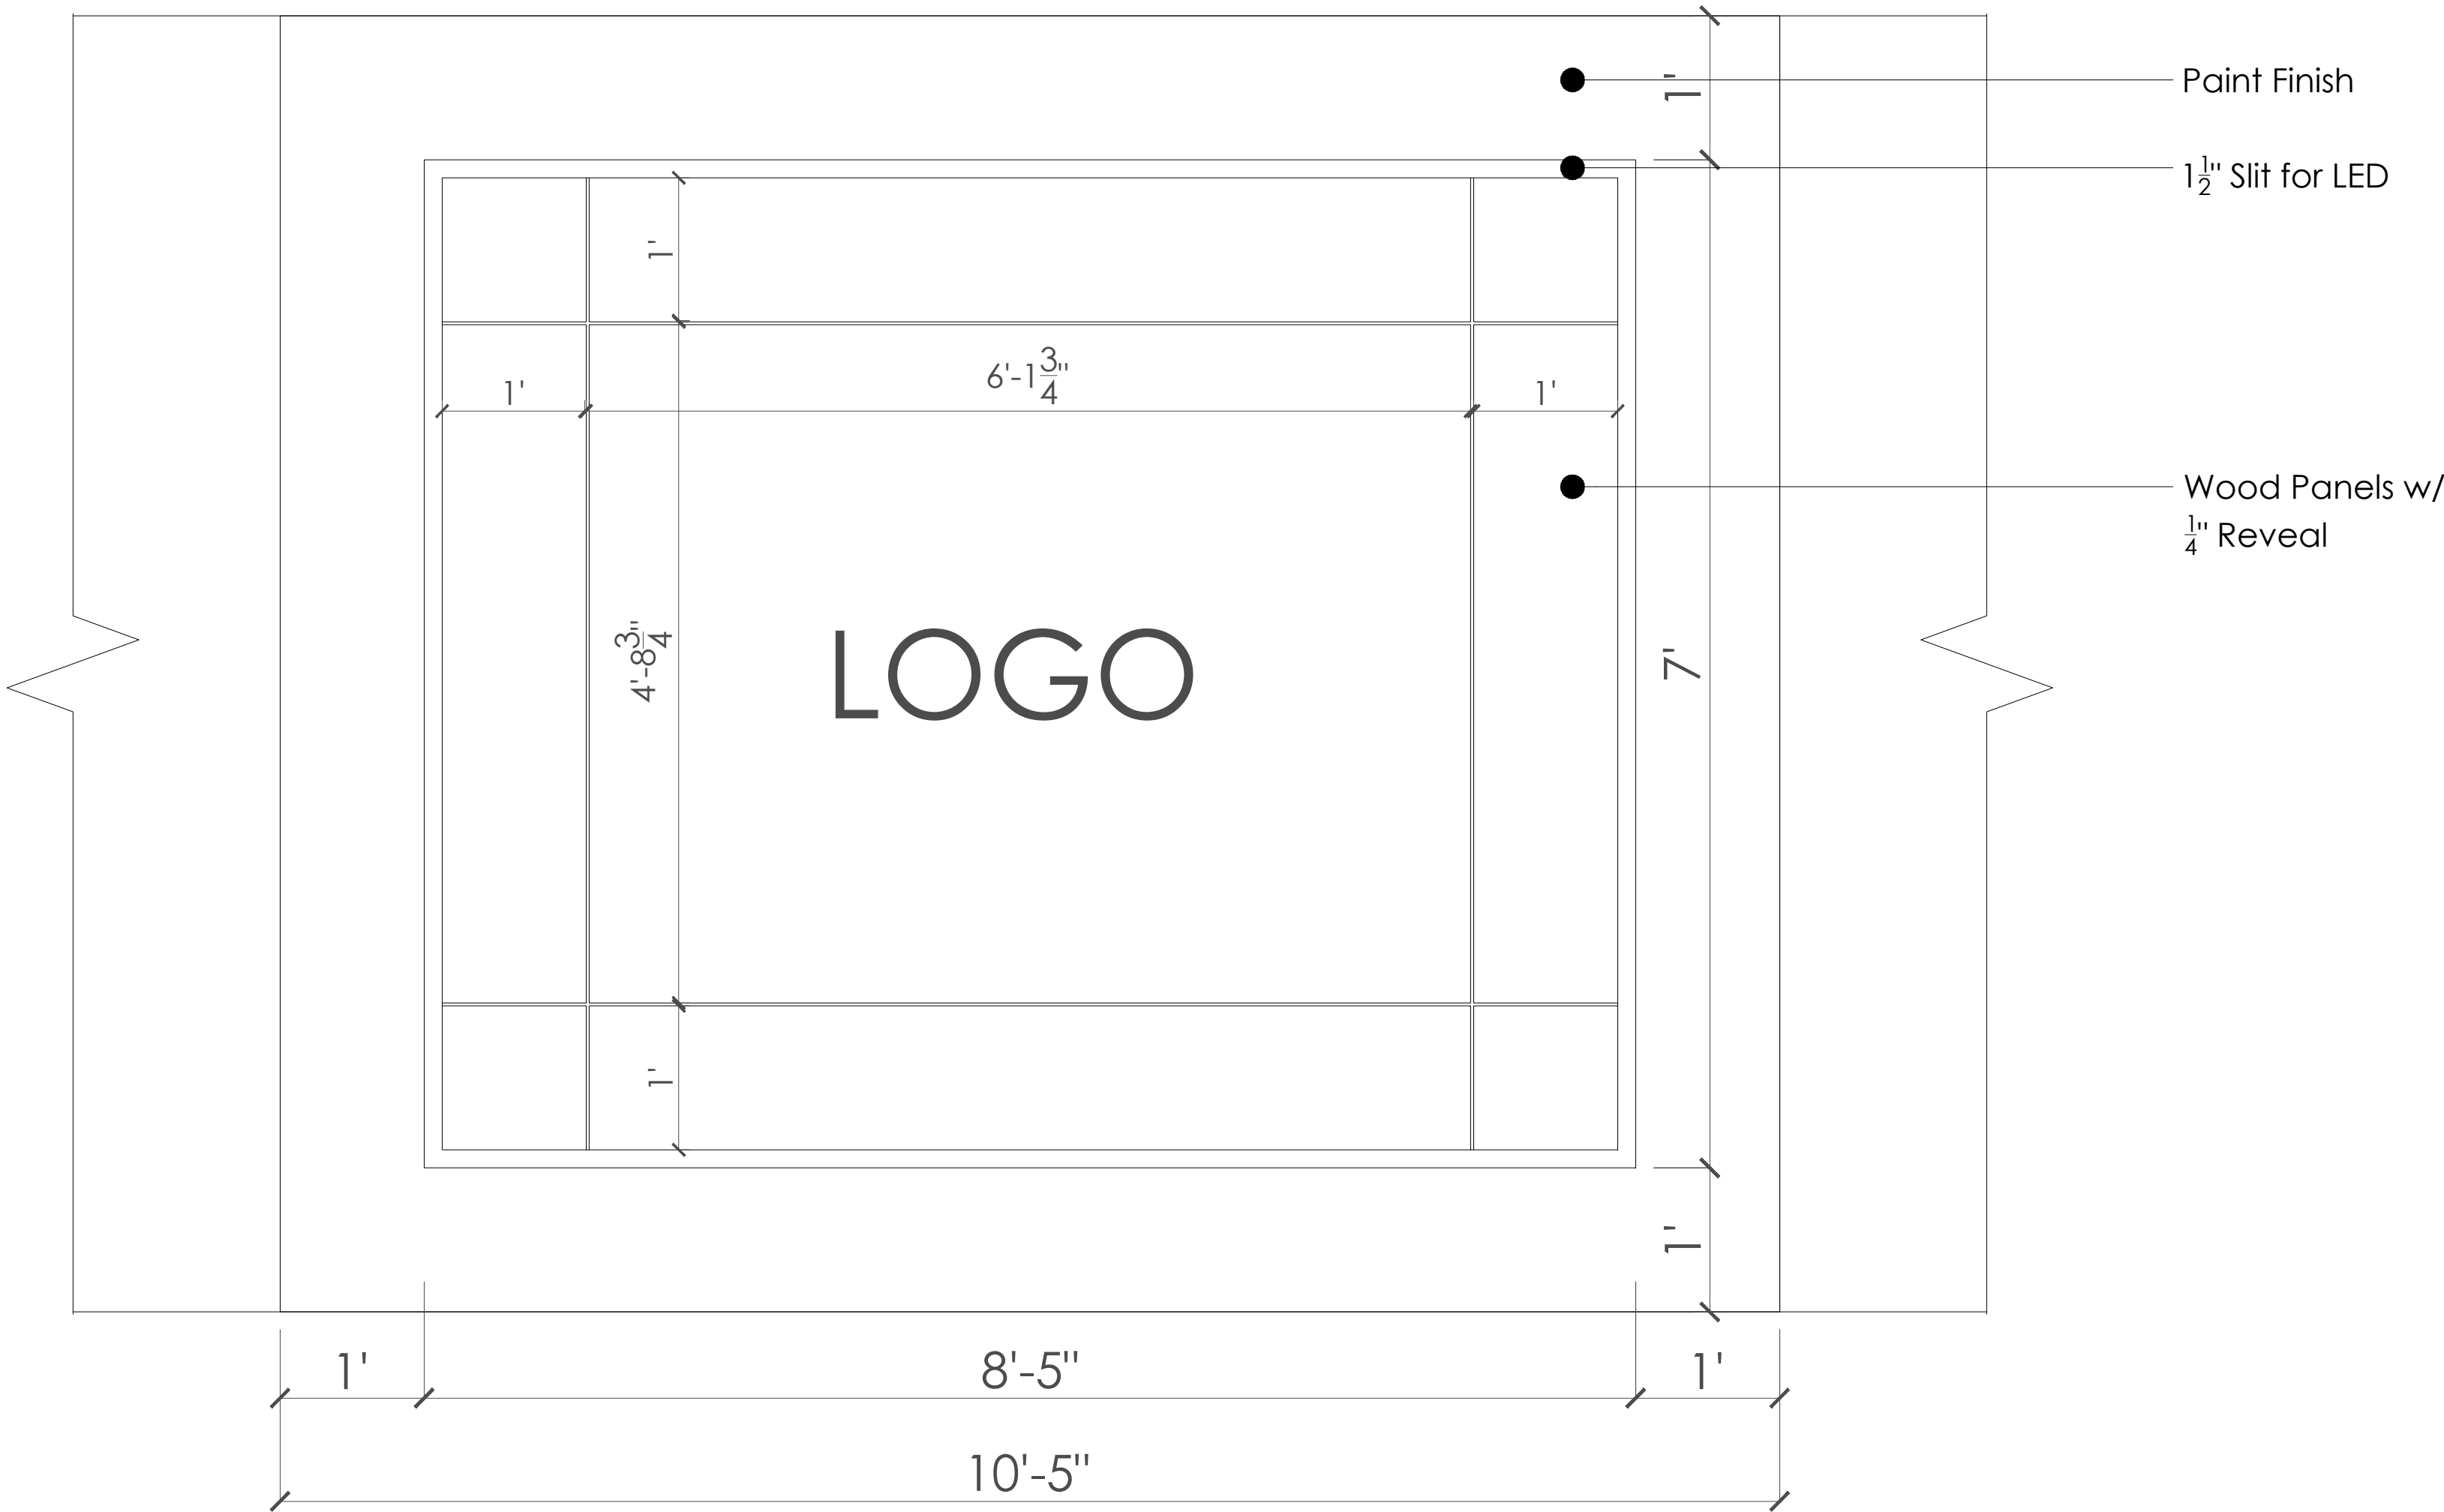

1 **LOGO WALL ELEVATION**
Scale: 1" = 1'-0"

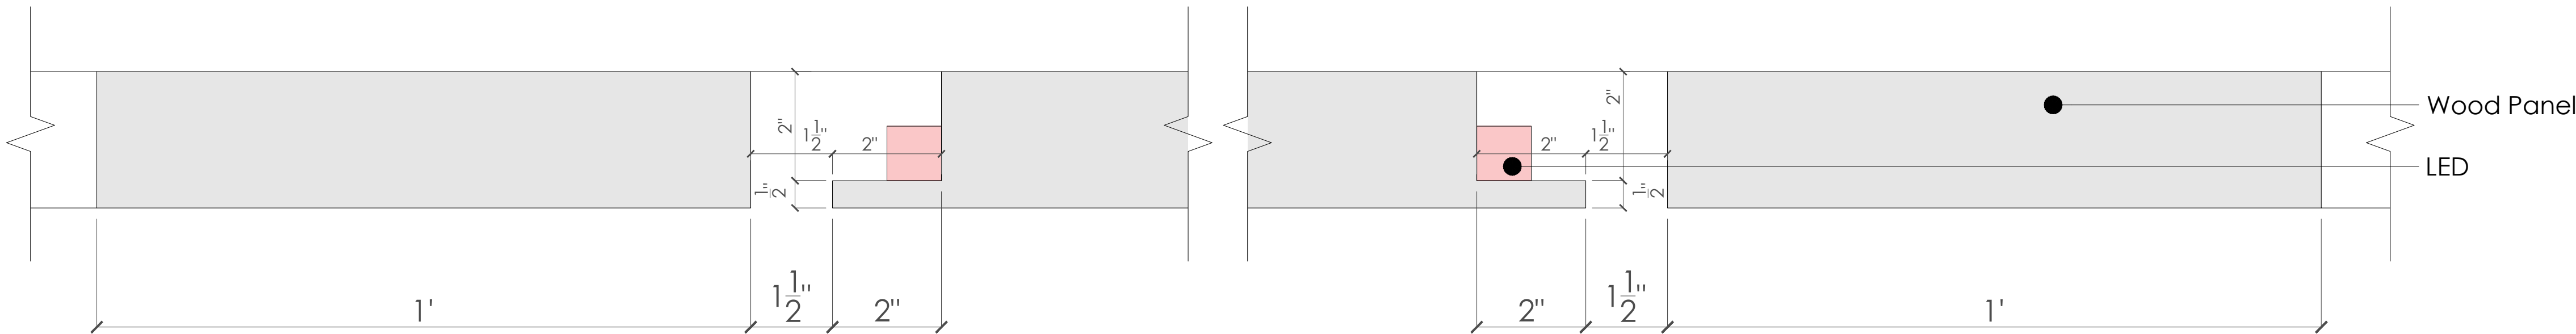

2 **PLAN DETAIL**
Scale: 1" = 1'-0"



INTERIORS

TAMARA THALER
646-226-2374
TAMARA@TTINTERIORSLLC.COM

LEGEND:

NOTES:

PROJECT TITLE:
KAY OFFICE


DRAWING TILE:
CONFERENCE ROOM
CEILING

SCALE: 1" = 1'-0"

DRAWN: 5.7.2026


DRAWING #:

D-2

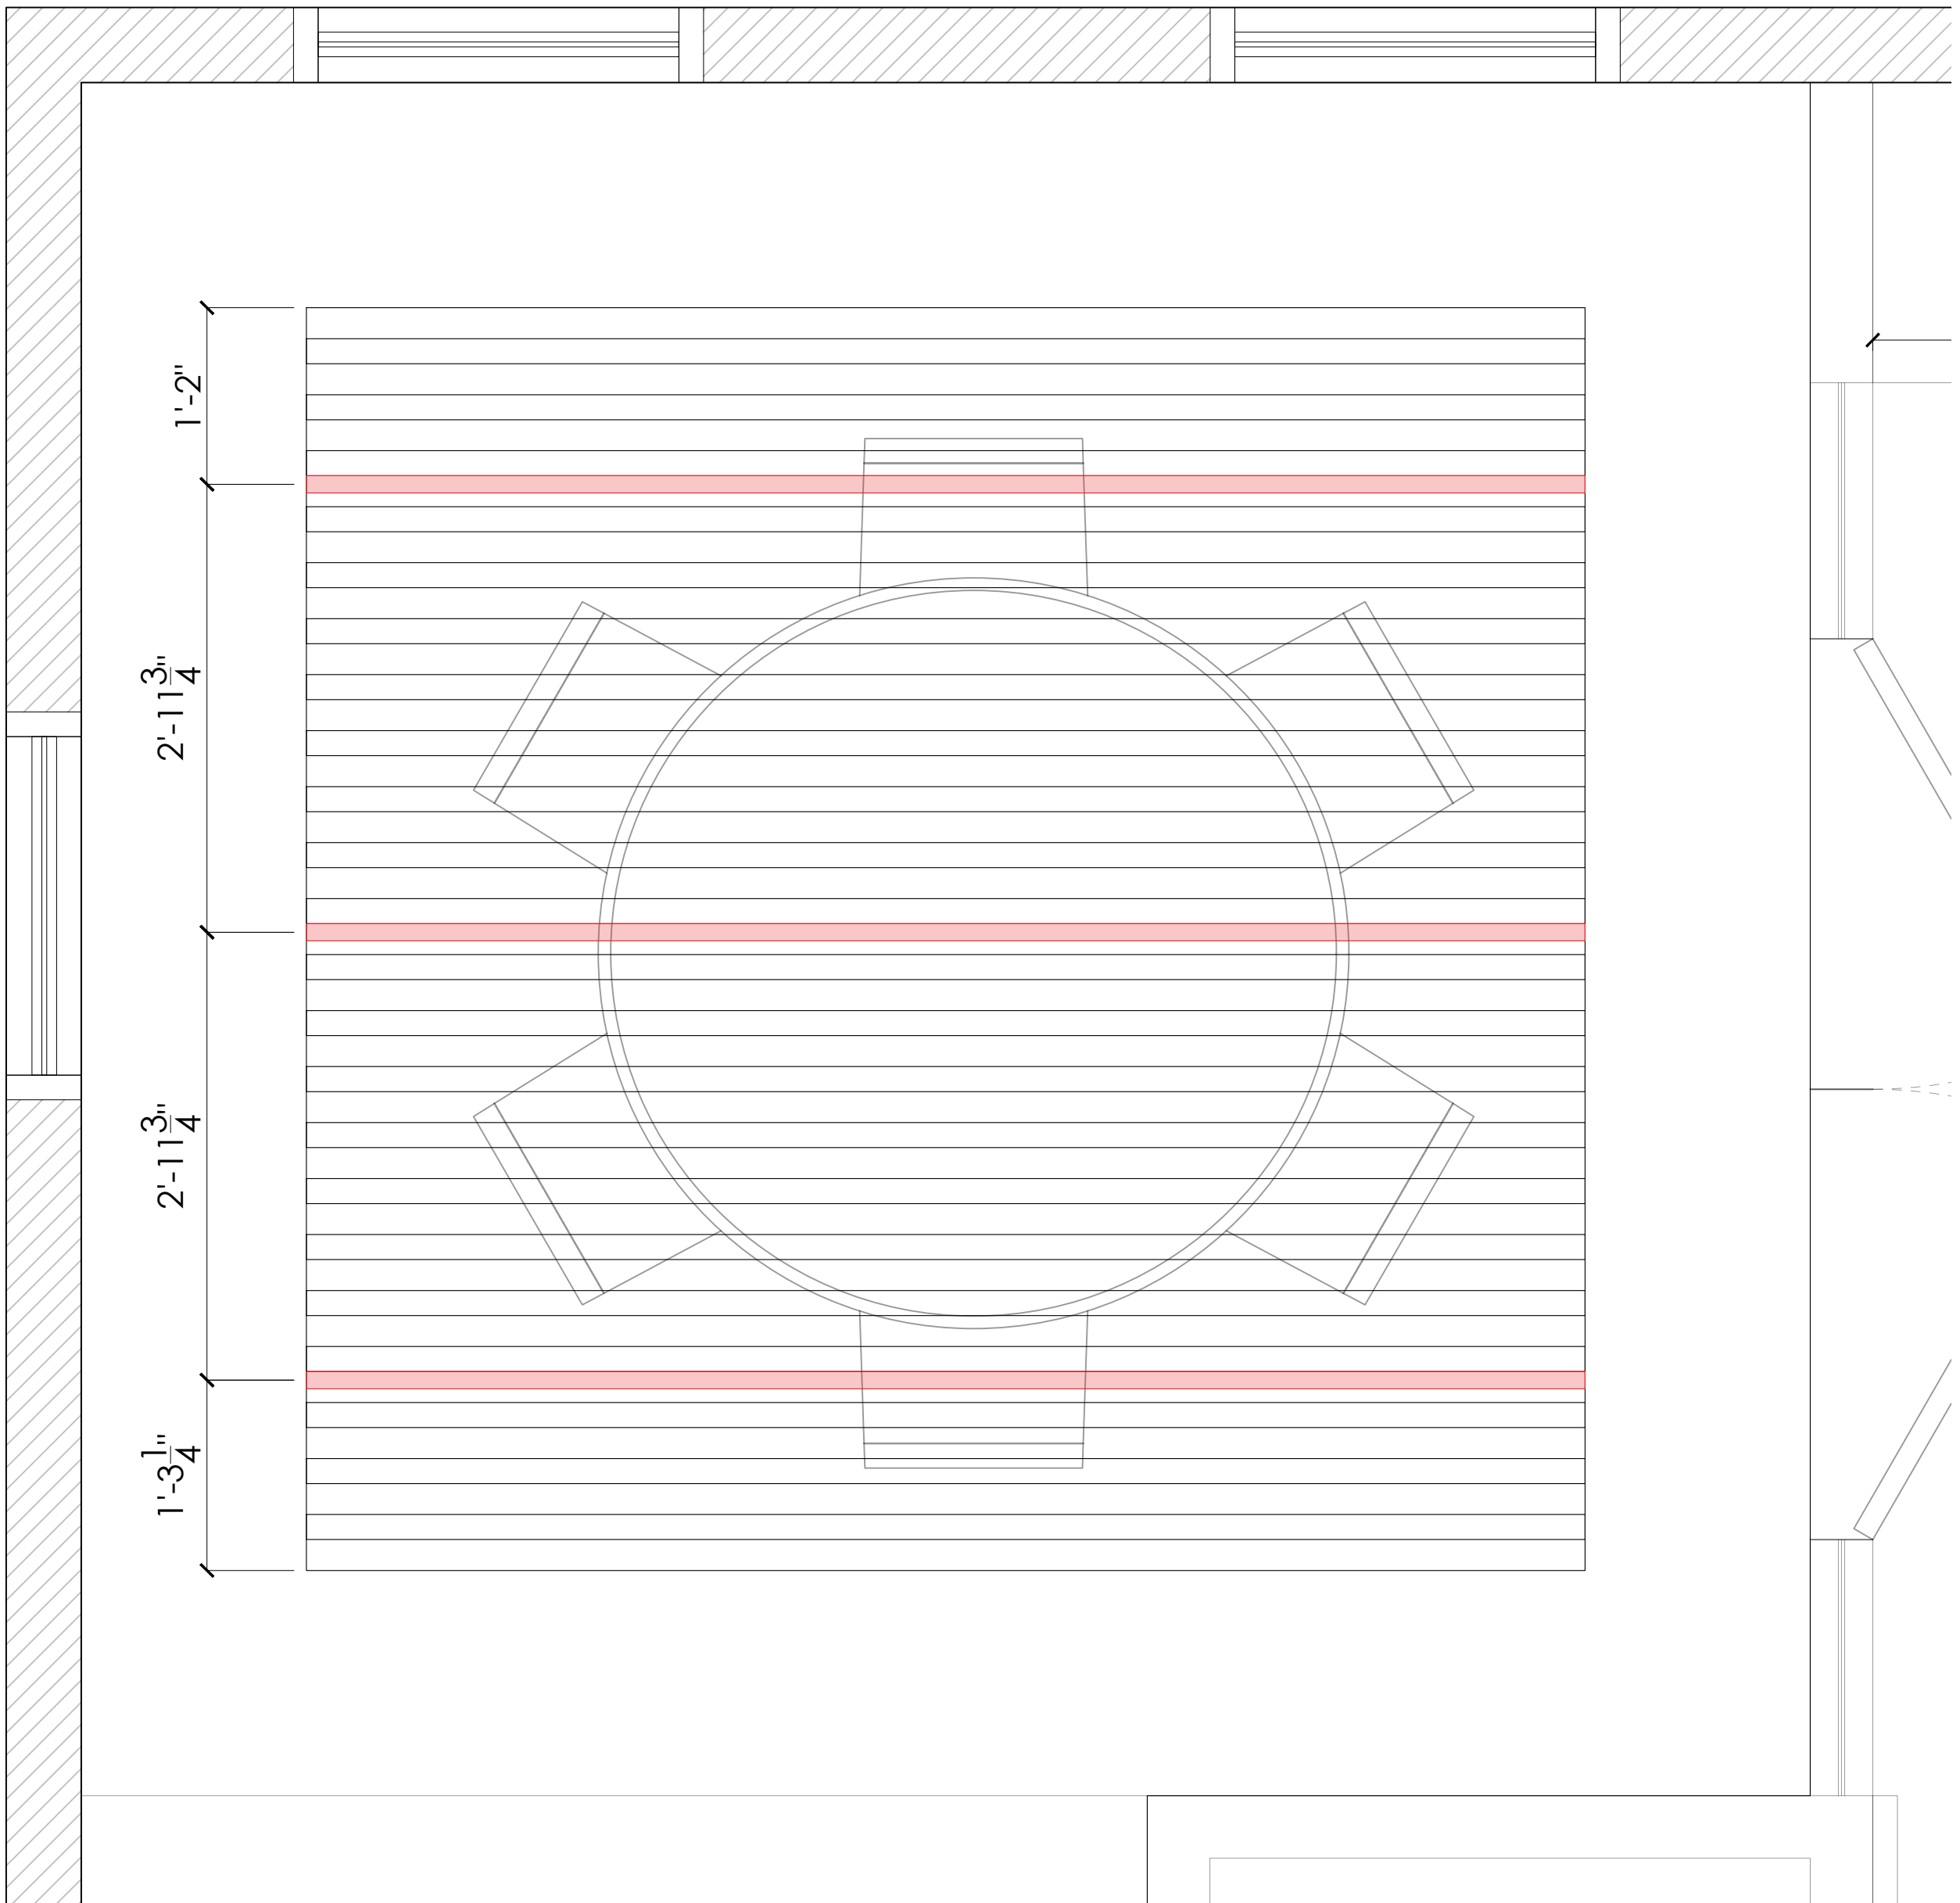

1 CONFERENCE ROOM CEILING PLAN

Scale: 1" = 1'-0"

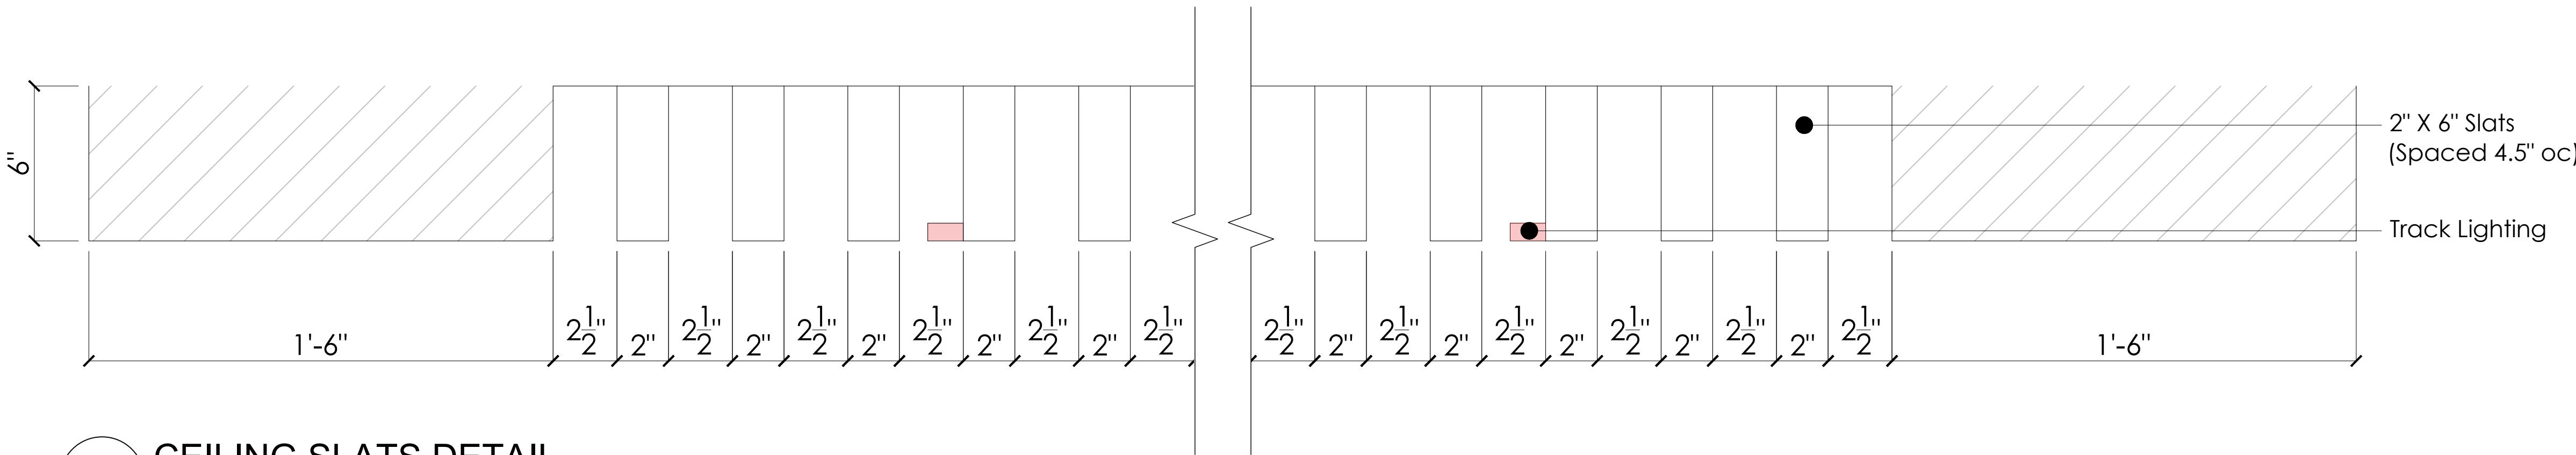

2 CEILING SLATS DETAIL

Scale: 1" = 1'-0"



INTERIORS

TAMARA THALER
646-226-2374
TAMARA@TTINTERIORSLLC.COM

LEGEND:

	3" RECESSED HIGH HAT
	FLUSH MOUNT FIXTURE
	HIDDEN LED
	WALL SCONCE

NOTES:

PROJECT TITLE:
KAY OFFICE


DRAWING TILE:
PROPOSED LIGHTING PLAN

SCALE: 5/16" = 1'-0"

DRAWN: 5.7.2026

DRAWING #:

E-1

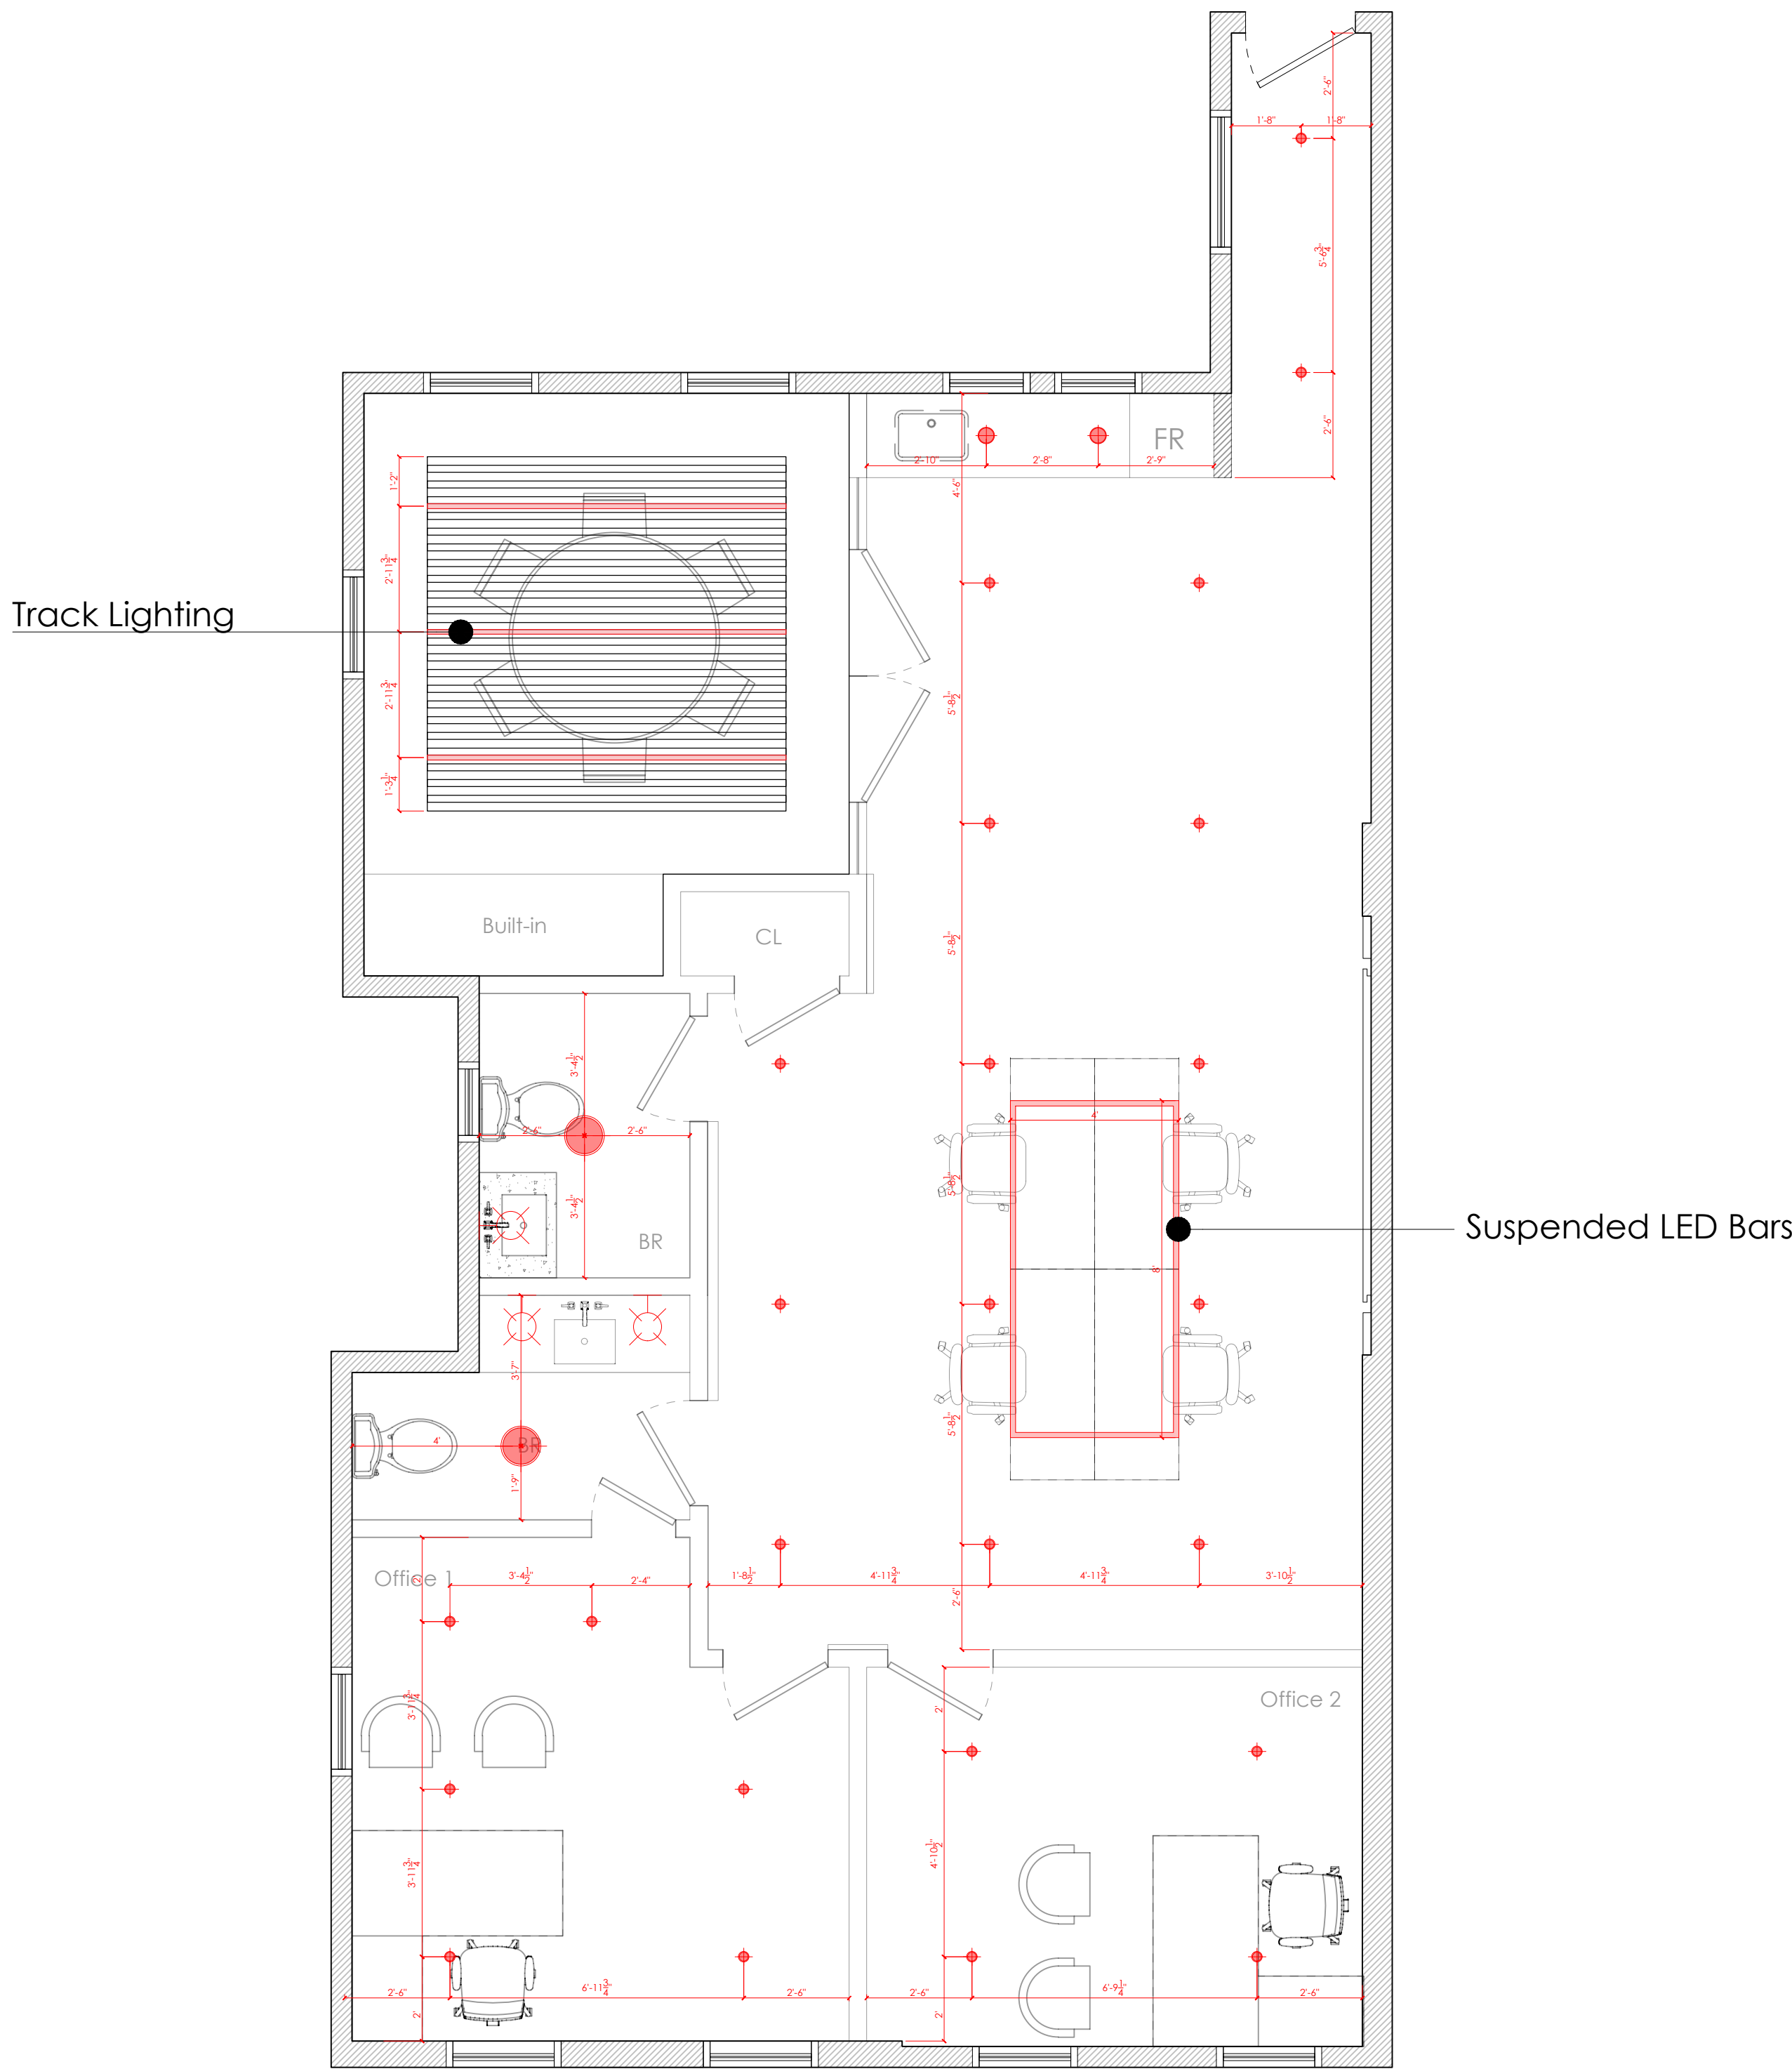

1 **PROPOSED LIGHTING PLAN**
Scale: 5/16" = 1'-0"



INTERIORS

TAMARA THALER
646-226-2374
TAMARA@TTINTERIORSLLC.COM

LEGEND:

	DUPLEX RECEPTACLE
	FLOOR OUTLET

NOTES:

PROJECT TITLE:
KAY OFFICE


DRAWING TILE:
PROPOSED ELECTRICAL PLAN

SCALE: 5/16" = 1'-0"

DRAWN: 5.7.2026

DRAWING #:

E-2

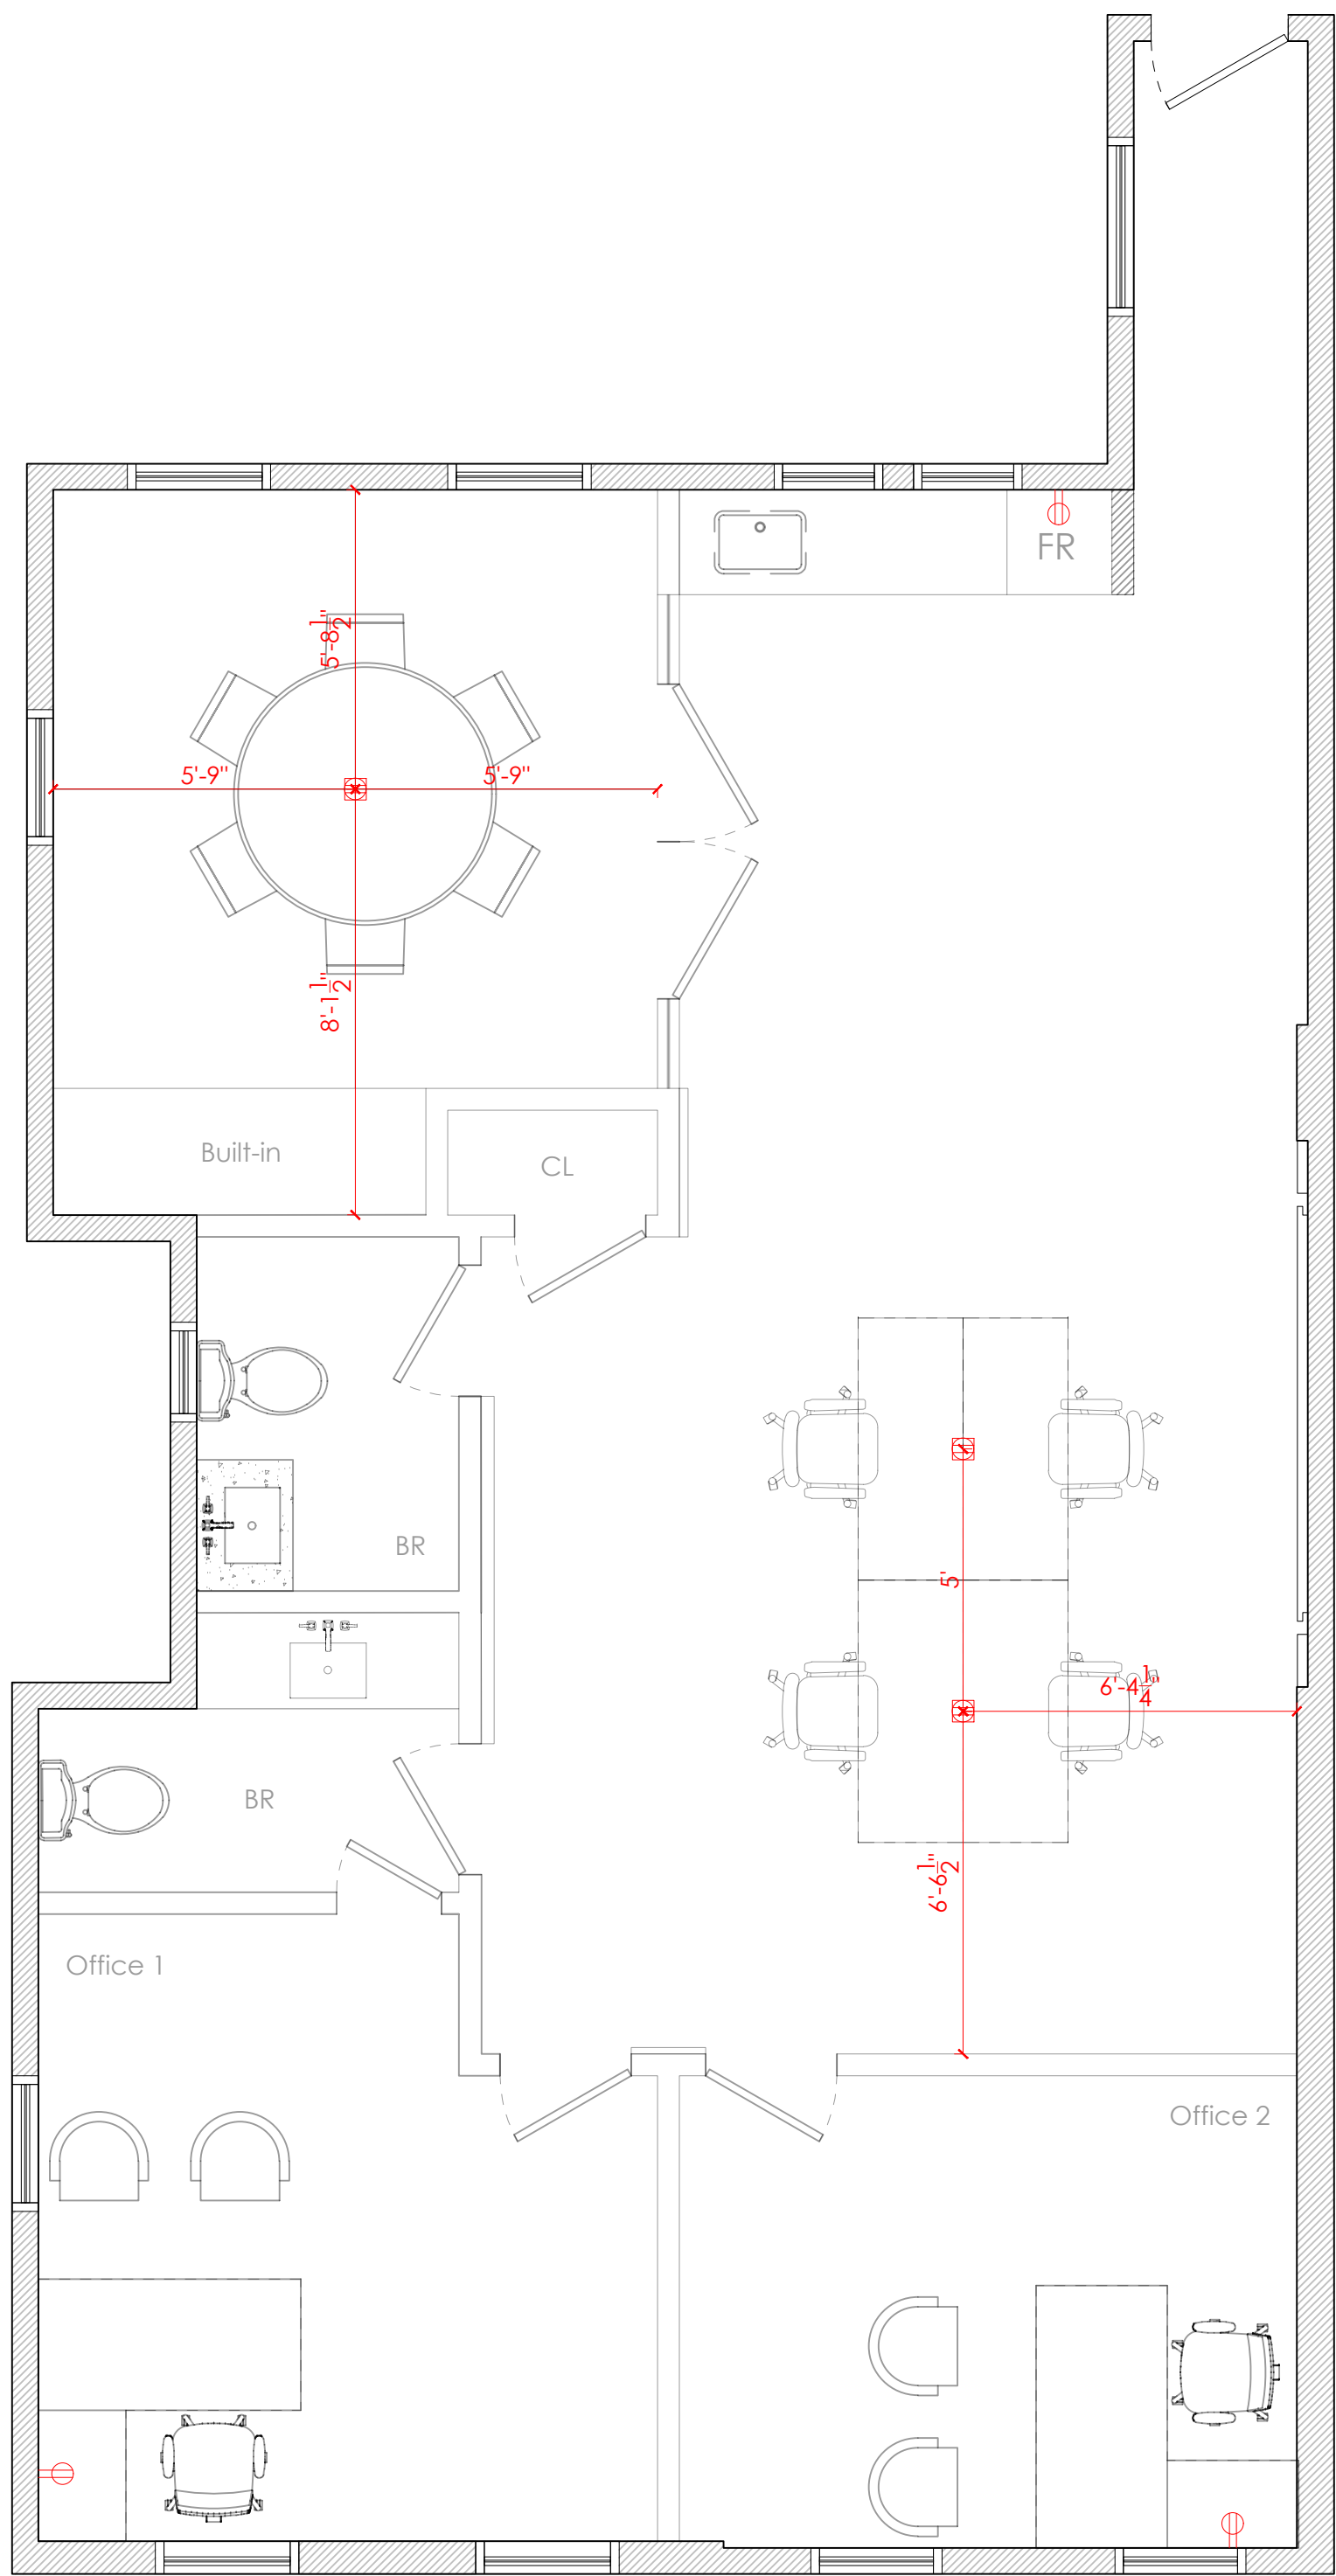

1 **PROPOSED ELECTRICAL PLAN**
Scale: 5/16" = 1'-0"