

Electrical Layout

No Scale


Electrical Symbols

- Wall Switch Typ.
- ⊙ Ceiling Mounted Light , Incandescent
- ⊙ Wall Mounted Light , Incandescent
- ⊙ Recessed Light , Incandescent
- ⊙ Recessed Mounted Fluorescent Light , 4T - 4 Tube
- ⊙ Duplex Receptacle Typ.
- ⊙ Duplex Receptacle W/ Ground Fault Interrupt , 42" High Typ.
- ⊙ Floor Receptacle , Verify Exact Location On Site W/ Owner
- ⊙ WP Weather-Proof , Duplex Receptacle
- ⊙ 220V Receptacle
- ⊙ Emergency Exit Light W/ Battery Back-Up Typ.
- ⊙ Emergency Light W/ Battery Back-Up Typ.
- ⊙ A/C , Furnace Disconnect Typ.
- ⊙ Electrical Panel Typ. Verify Location On Site
- ⊙ Exhaust Fan , Vent To Exterior Of Building Typ.
- ⊙ Smoke Detector Typ.
- ⊙ Thermostat Verify W/ HVAC Contractor
- ⊙ Telephone Jack , Verify Location On Site
- ⊙ Cable Jack , Verify Location On Site

Electrical Notes :

1. All Work Shall Meet All N.E.C. Req't. & All Local & State Codes.
2. Verify Location Of Telephone & Cable Jacks On Site W/ Owner.


Rental Space # 104

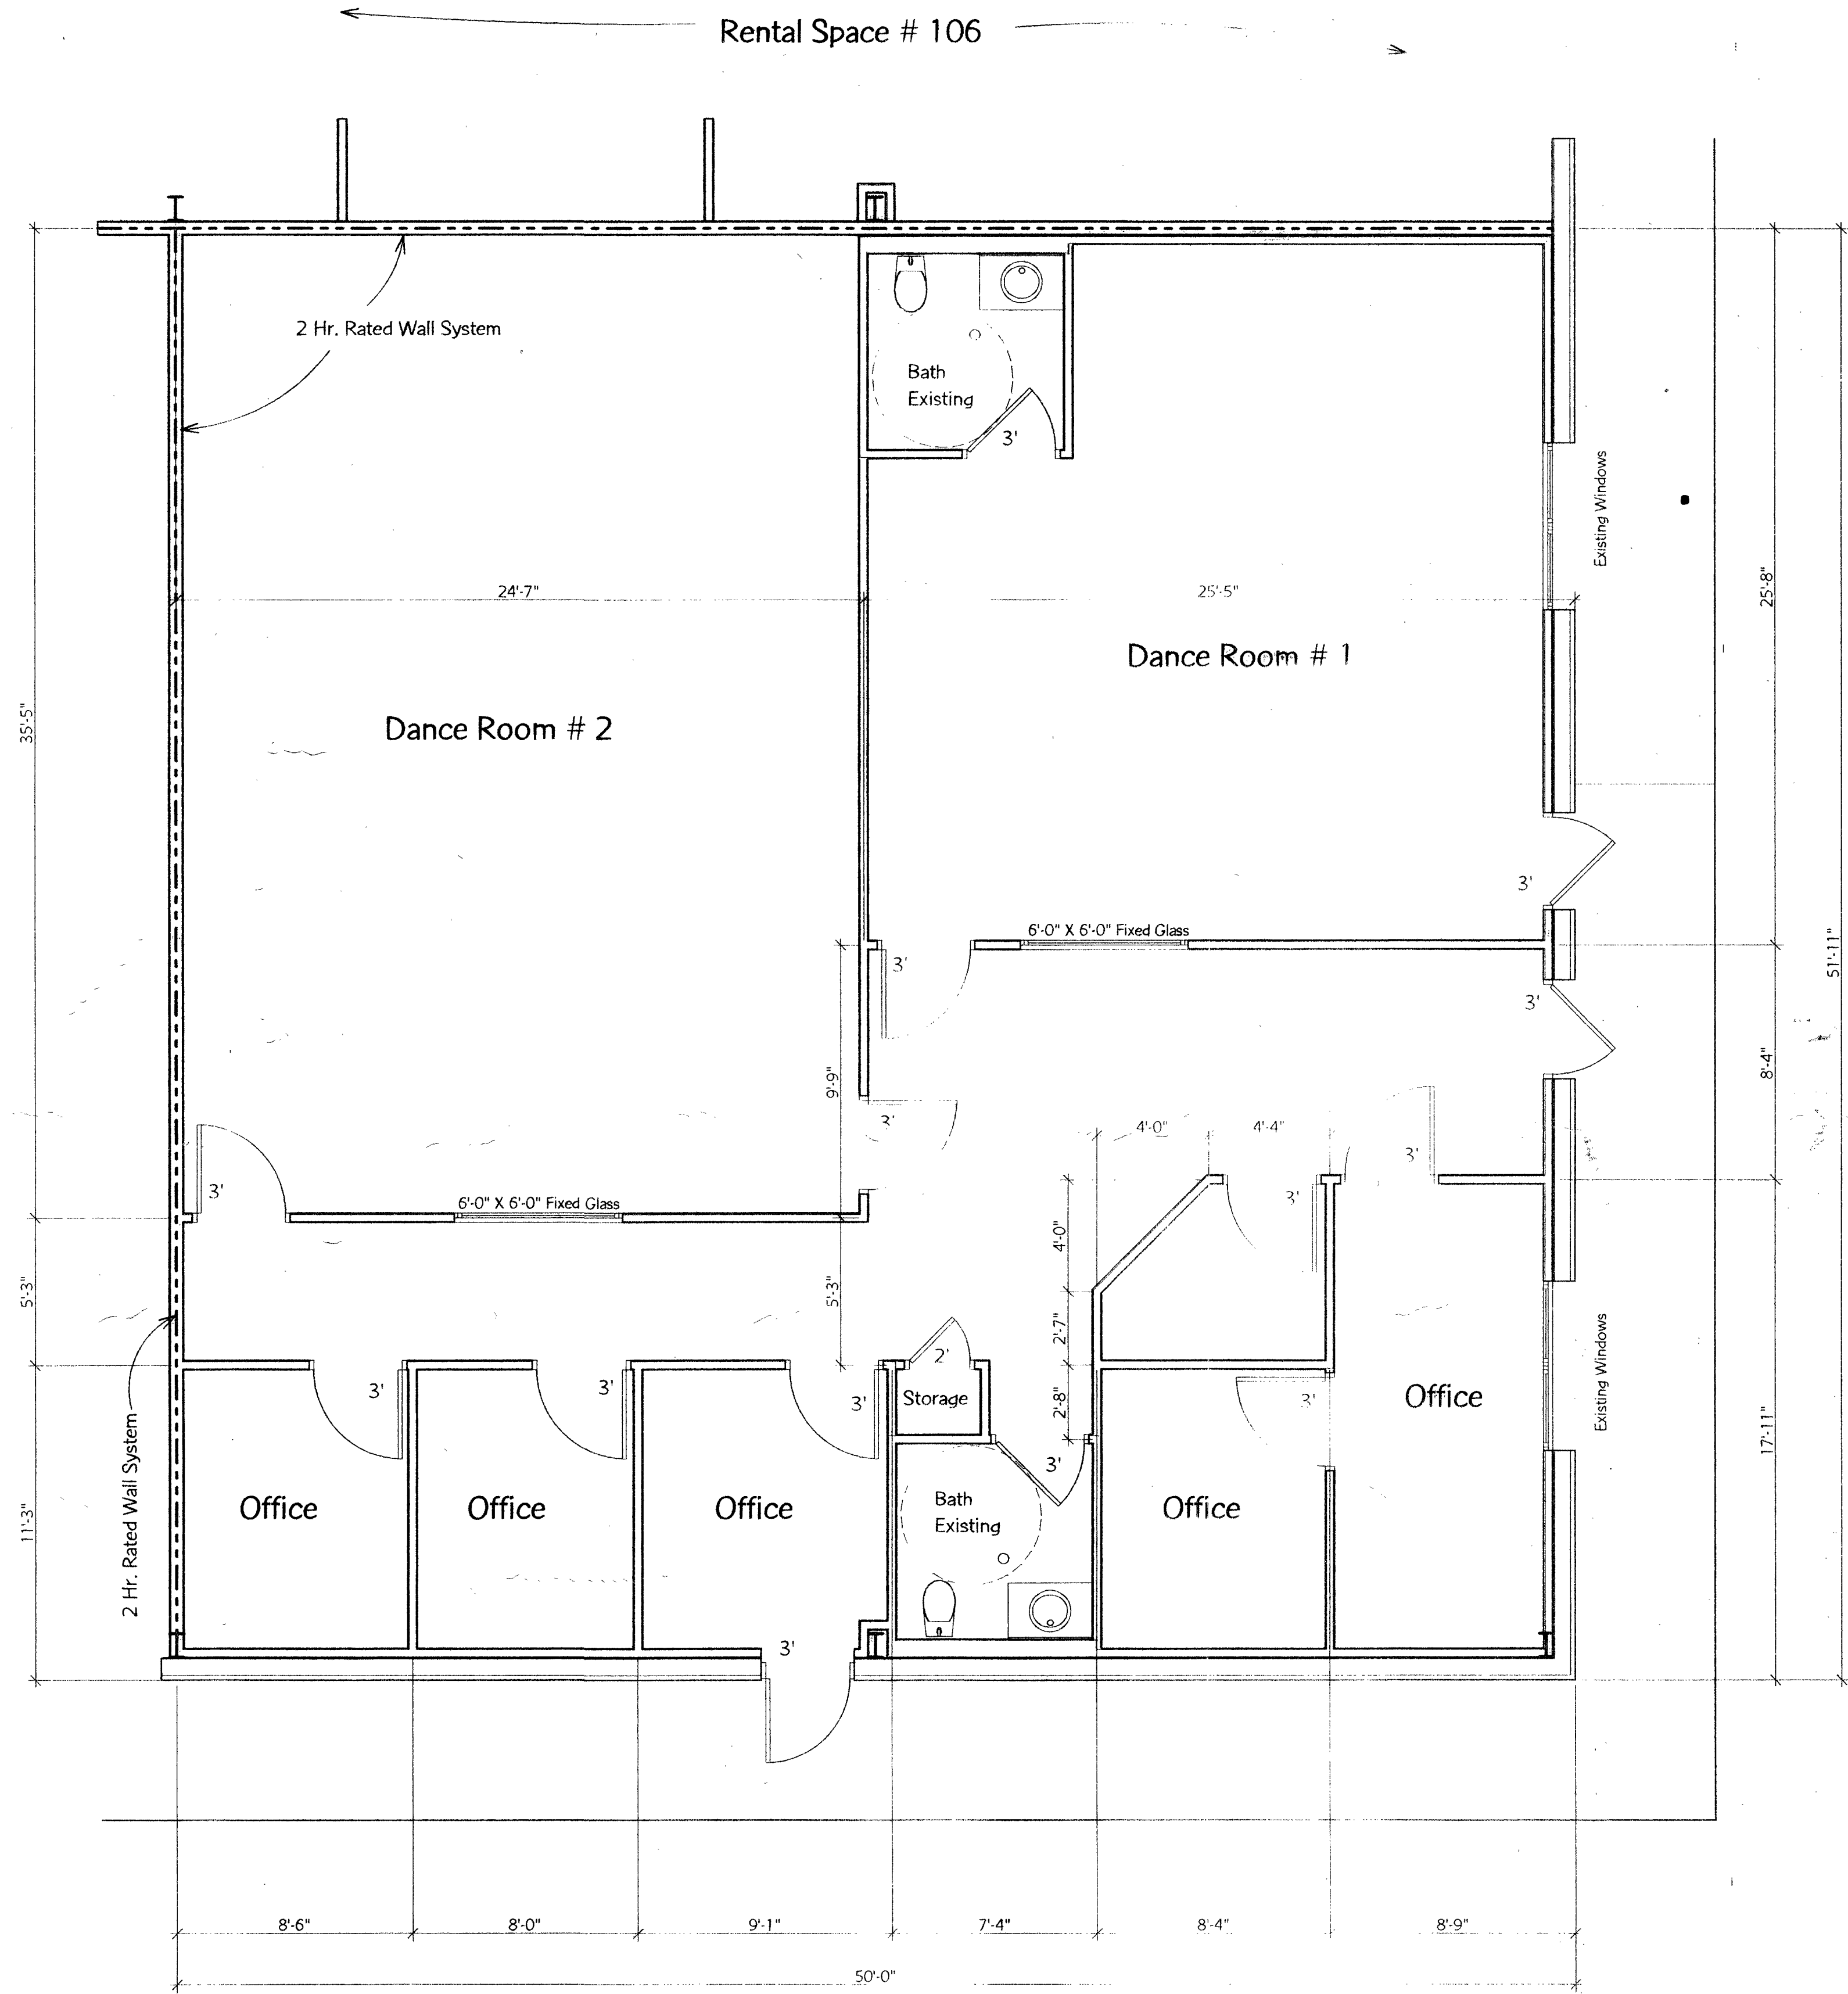

Rental Space 105 Layout

Bi-City Metal Building Plan (Existing)

1/4" = 1'-0" 2596 S.F. Total

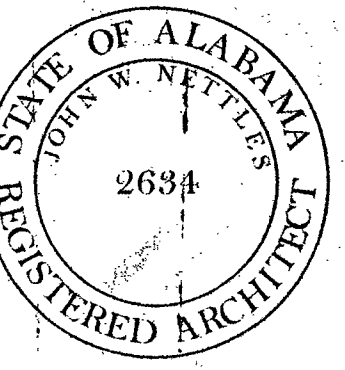

1695 East University Drive
Suite 201
Auburn Alabama 36830
(334) 887 - 3415
(334) 887 - 2057 Fax

**Nettles
Architecture
Company**

1975 Mall Boulevard
Auburn, AL
Suite 105

Proj. No.
Date: 5-22-2001
Scale: As Noted
Drawn By:
Chuck Locklin
OF