



EXISTING SPACES: 118
PROPOSED SPACES: 82
TOTAL: 200 SPACES PROVIDED
HANDICAP SPACES REQUIRED = 6
6 HANDICAP SPACES PROVIDED

AB 44033882.001

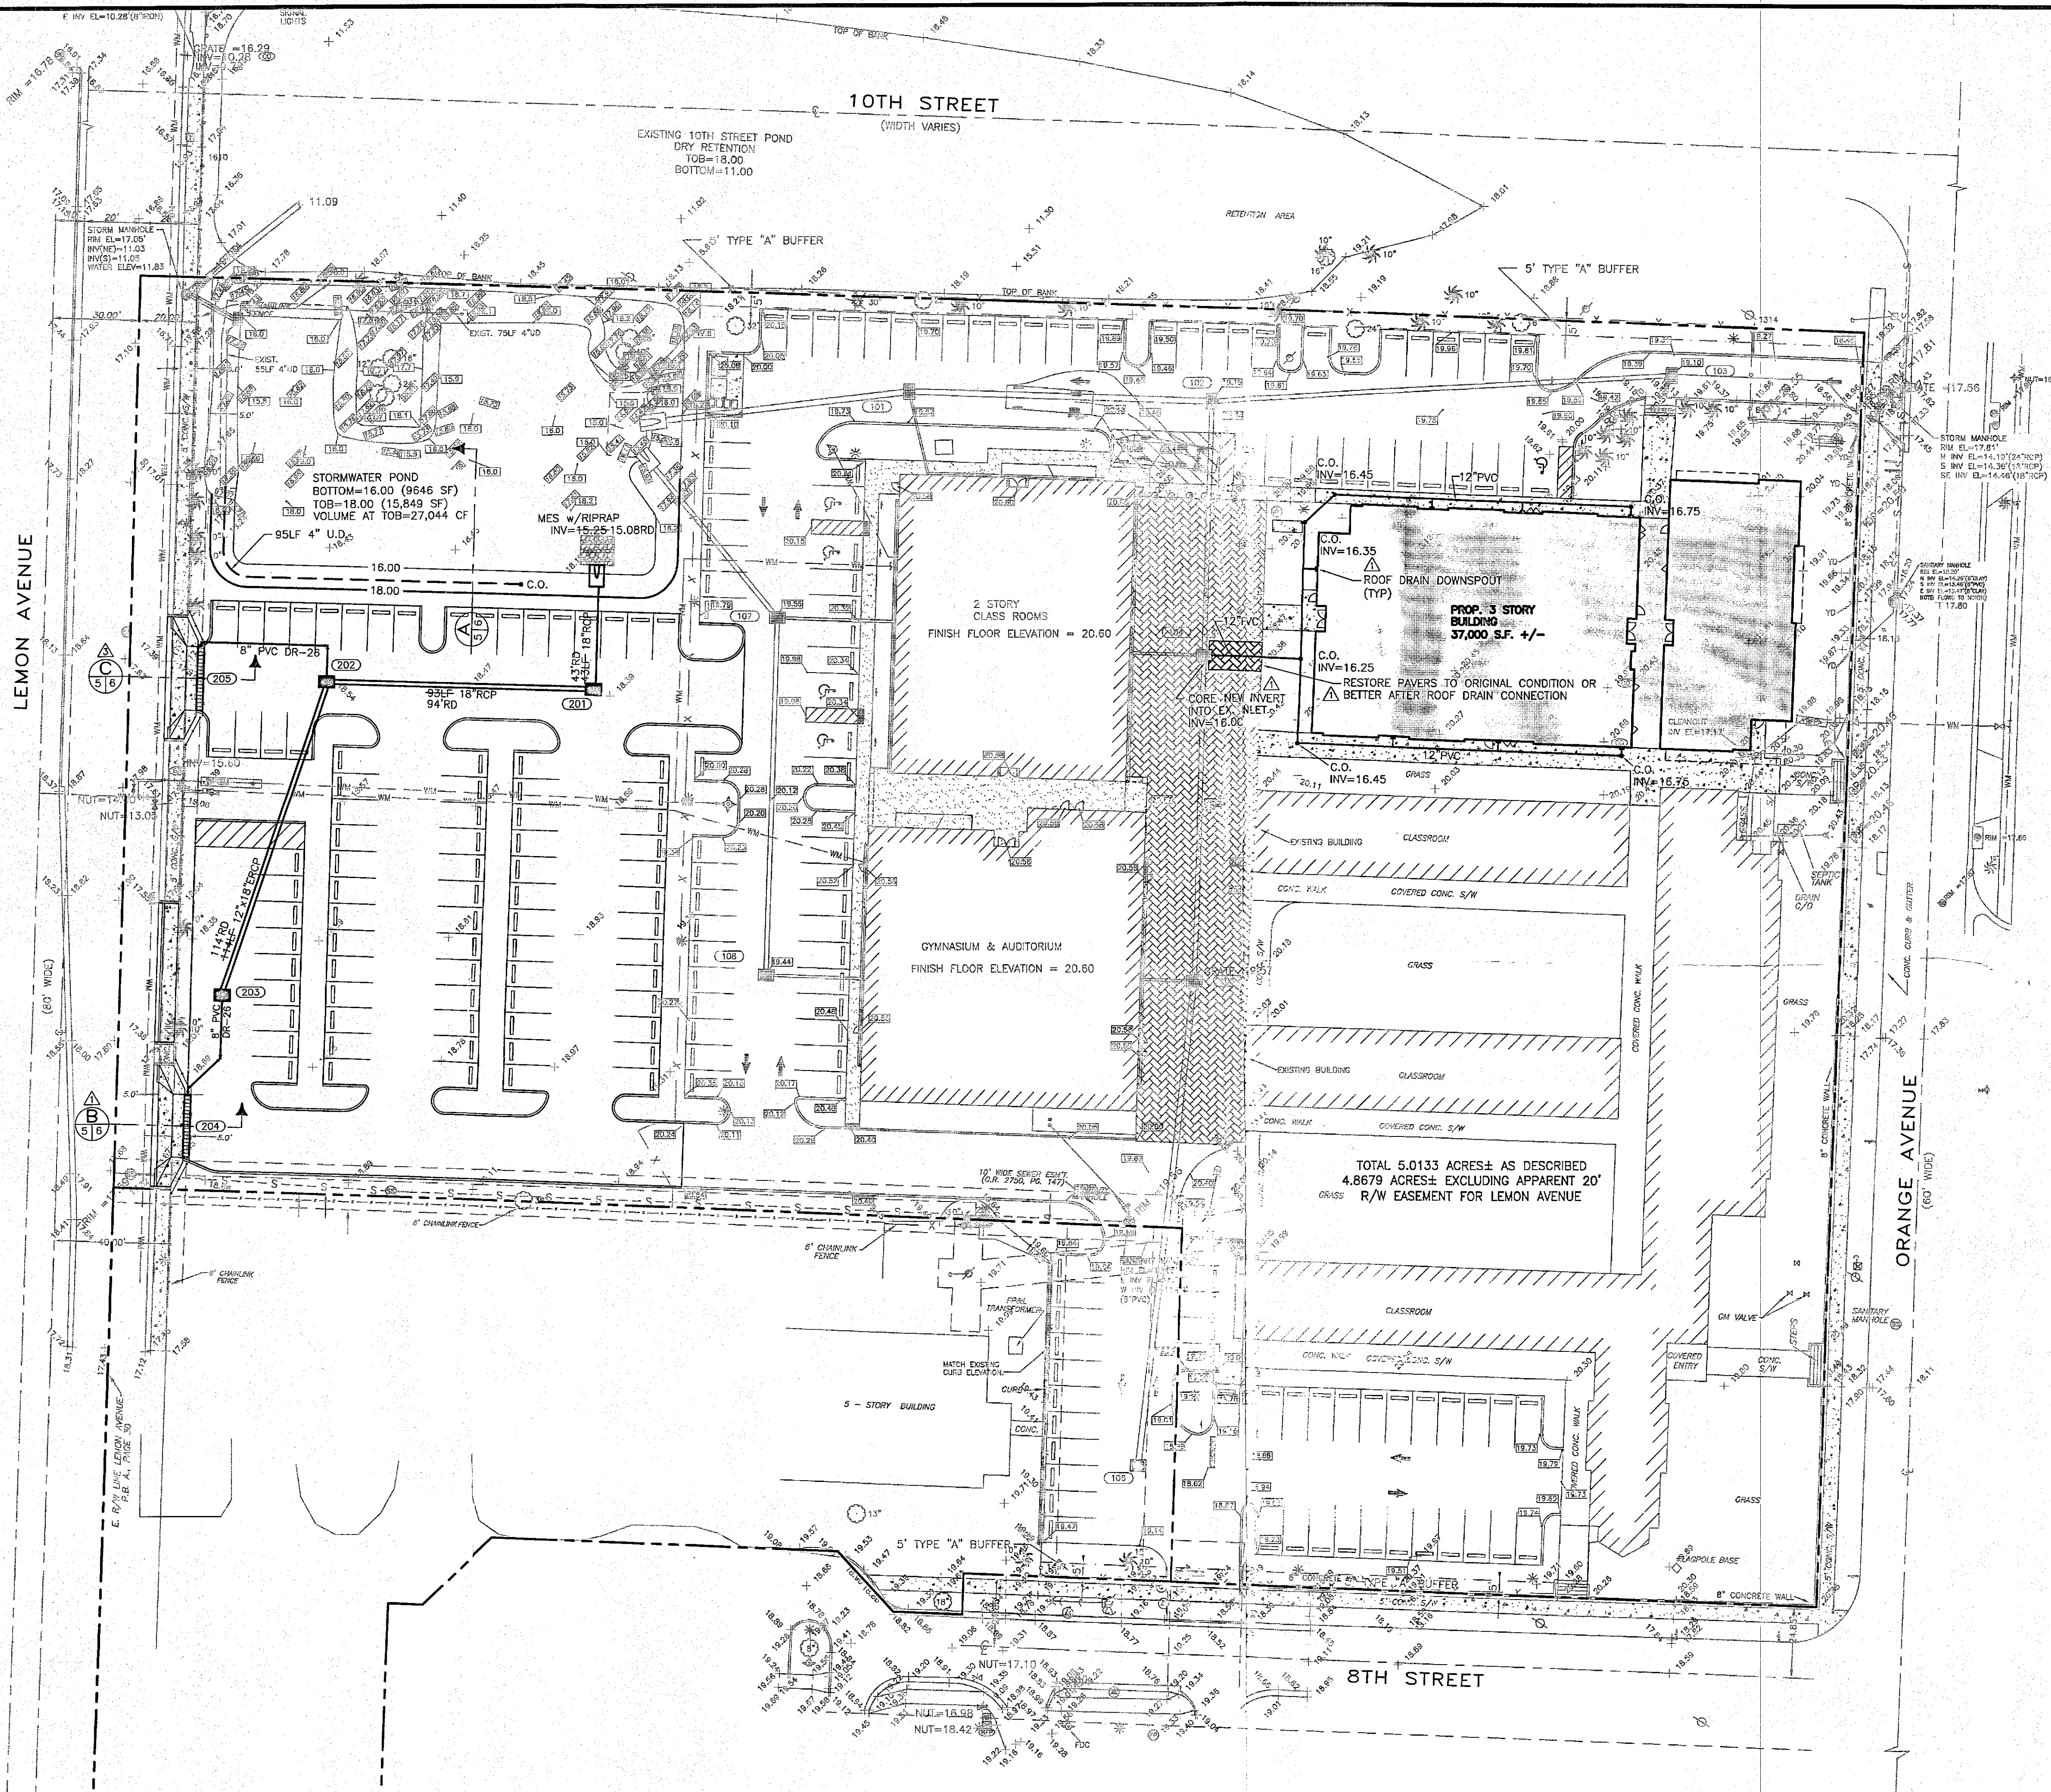

PROPOSED STORM SEWER INDEX (SHOP DRAWINGS REQUIRED FOR ALL STRUCTURES)									
STRUCTURE NUMBER	DESCRIPTION	TYPE	R/W/GRATE ELEVATION	NORTH INVERT	SOUTH INVERT	EAST INVERT	WEST INVERT		
201	INLET	TYPE "T"	+8.63-18.70RD	15.28RD	15.35RD	15.35RD	15.35RD		
202	INLET	TYPE "T"	+8.64-18.49RD	15.28RD	15.32RD	15.32RD	15.32RD		
203	INLET	TYPE "T"	+8.24-18.09RD	15.28RD	15.35RD	15.35RD	15.35RD		
204	ZURN TRENCH DRAIN	CHANNEL DRAIN	+7.74-17.76RD	16.64RD					
205	ZURN TRENCH DRAIN	CHANNEL DRAIN	+7.89-17.88RD	16.76RD					

* TYPE "T" GRATES IN ACCORDANCE WITH FDOT INDEX NO. 233. CONTRACTOR TO PROVIDE TYPE "T" GRATES WITH PRECAST LIDS AND BOXES SIZED BASED ON SIZE AND ANGLE OF PIPES AT ALL INLETS.
* ALL INLET TYPE "T" GRATES SHALL BE U.S.F. STEEL GRATES, HEAVY DUTY TRAFFIC BEARING (OR APPROVED EQUAL).

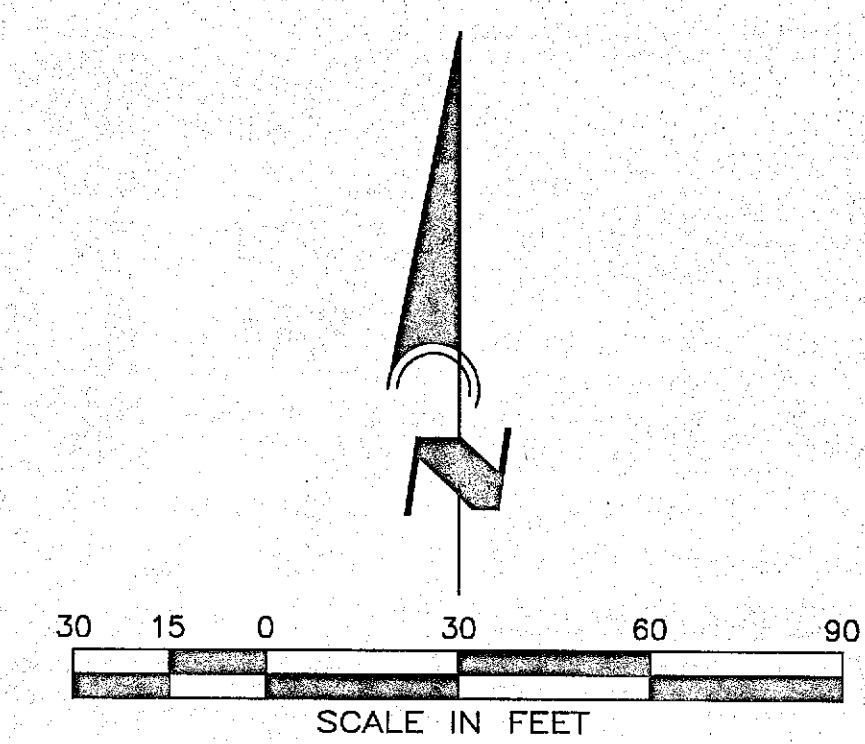

FOR CITY ENGINEER'S USE

O&M ENTITY COPY

STORMWATER RECORD DRAWING

CALL BEFORE YOU DIG!
"SUNSHINE STATE ONE-CALL CENTER"
1-800-432-4770














THE CONTRACTOR SHALL NOTIFY "SUNSHINE STATE ONE-CALL CENTER" AND ALL OTHER UTILITIES FOR LOCATION OF EXISTING FACILITIES PRIOR TO BEGINNING CONSTRUCTION.

REVISIONS		
BY	DATE	DESCRIPTION
SRC	1/10/08	PER CITY OF SARASOTA DRG MEETING 1/2/08
RWD	12/4/12	REVISIONS PER CITY ENGINEERING COMMENTS DATED 12/3/12
RWD	2/25/13	DRIVE AISLE REVISIONS PER ARCHITECT
RWD	9/16/13	STORMWATER RECORD DRAWING

ENGINEERING, INC.
8340 CONSUMER COURT
SARASOTA, FL 34240
ED #4334
PHONE: (941) 377-9178

PROJECT: **SARASOTA MILITARY ACADEMY**
SCALE: 1"=30'
DATE: 9/10/12
CLIENT: **CARLSON STUDIO ARCHITECTURE, INC.**
DESIGN: **PAVING, GRADING & DRAINAGE PLAN**
APPROVED BY: [Signature]
DRAWN BY: SRC
JOB NO: SMRA0003
DWG. NO: 05

Mon, 16 Sep 2013 - 2:40pm C:\AM Engineering Projects\Engineering\SRM0003\Storm Water\SRM0003PAVE.dwg

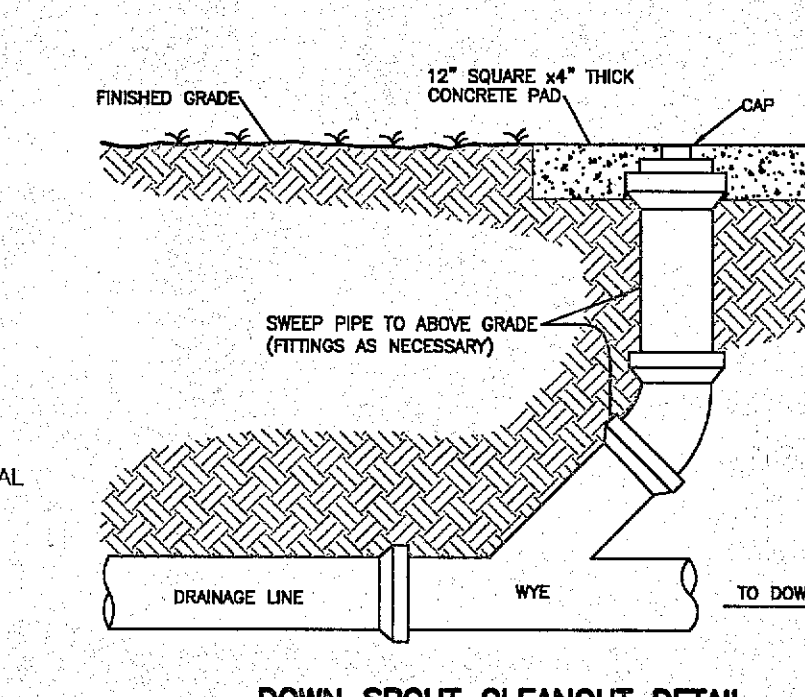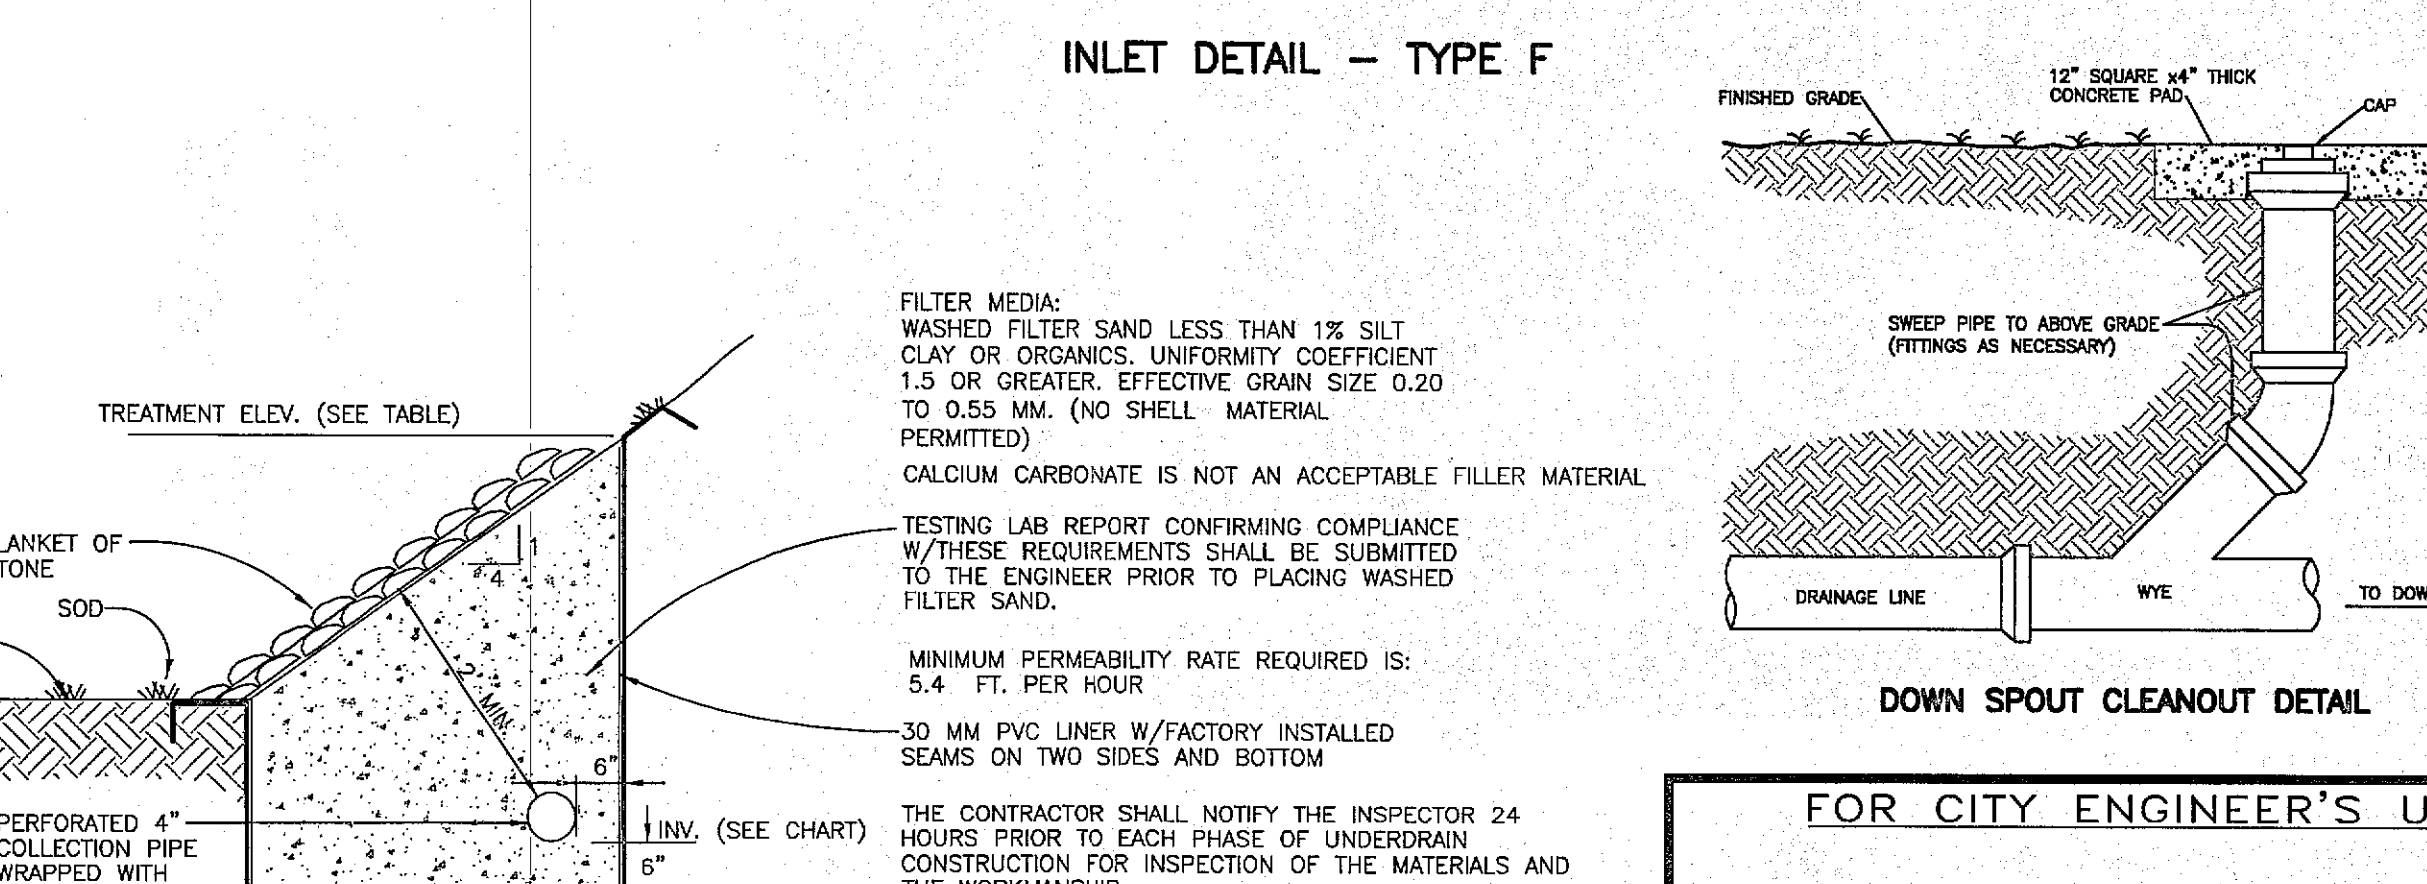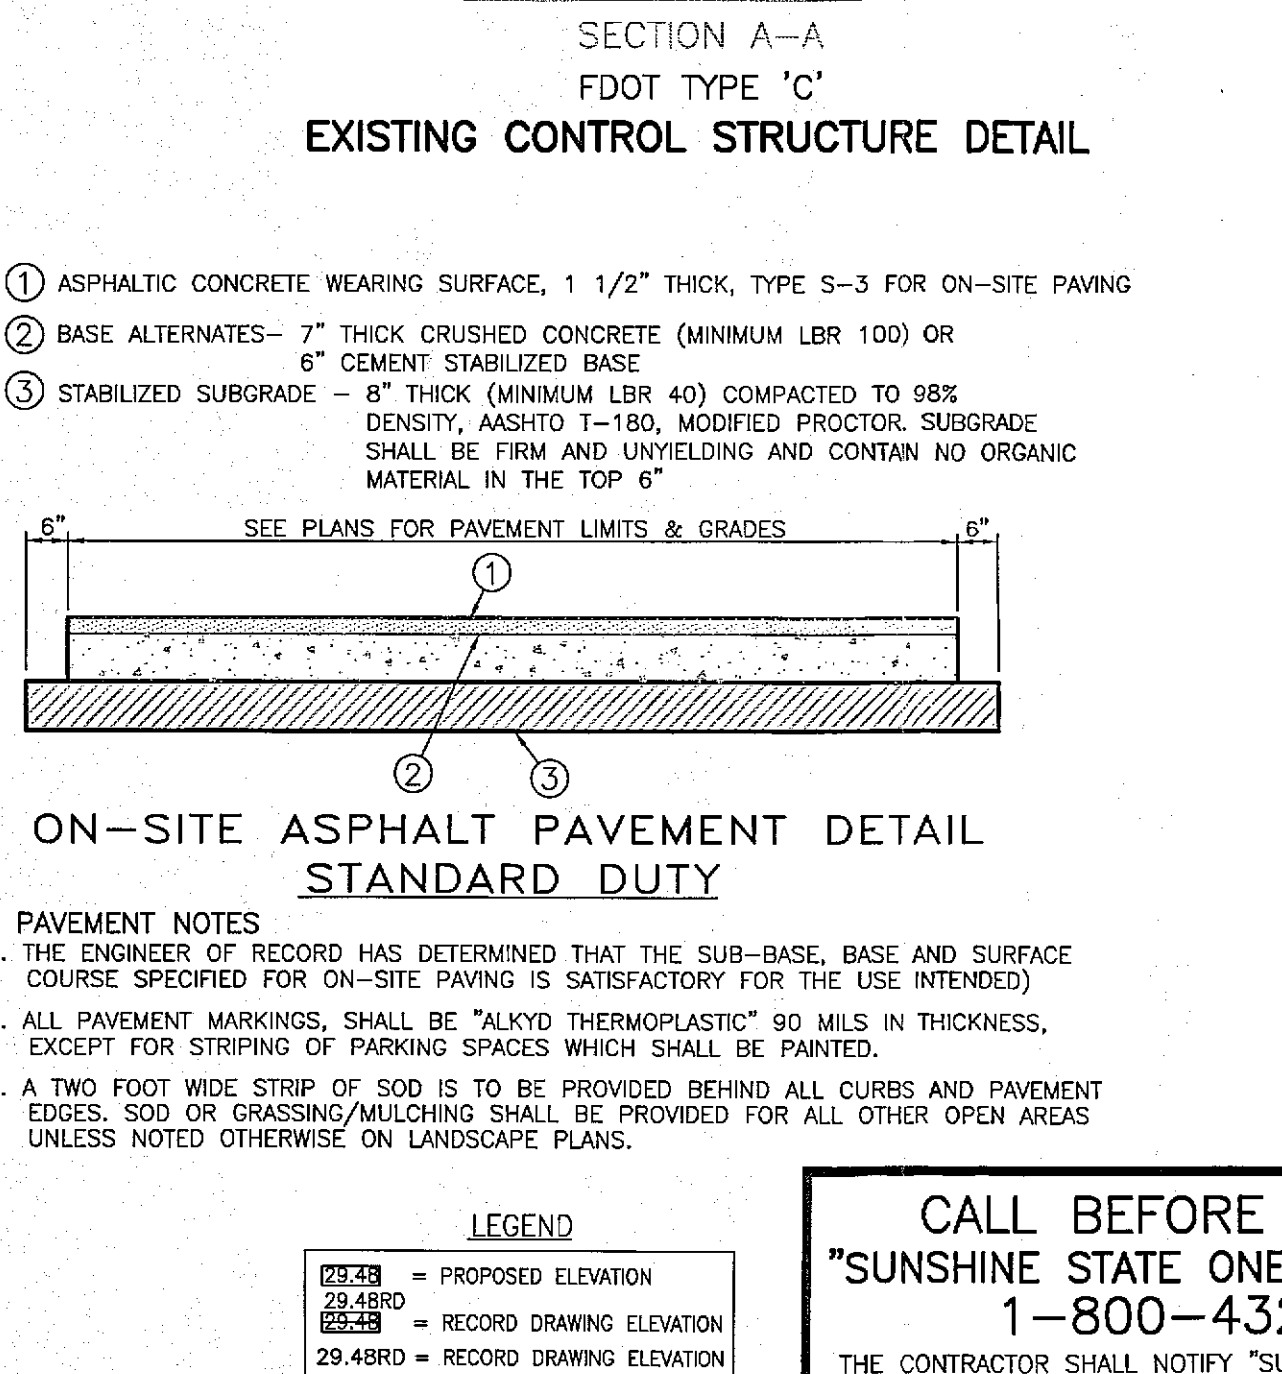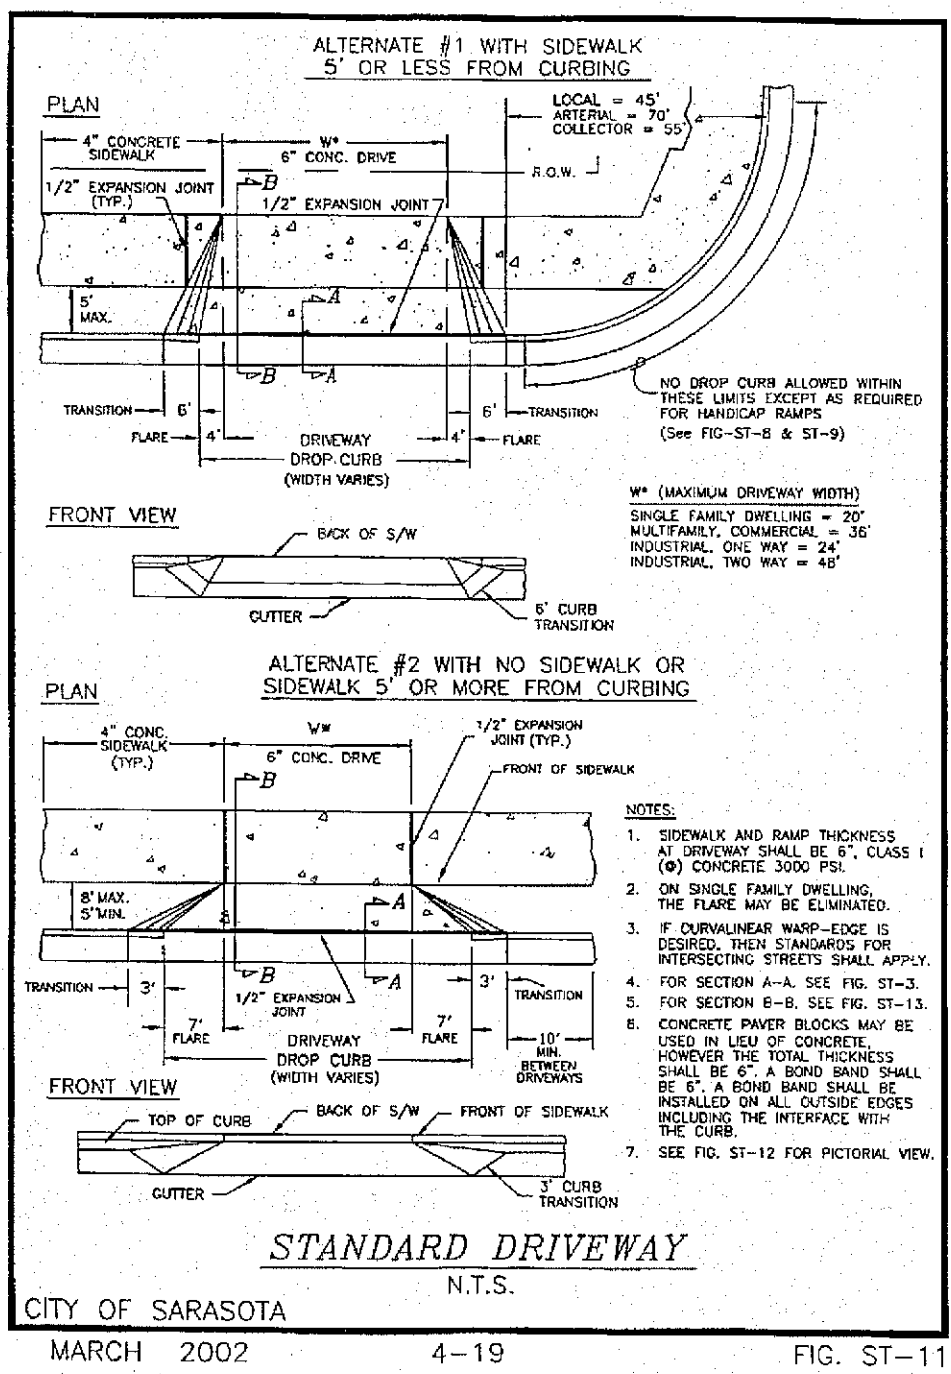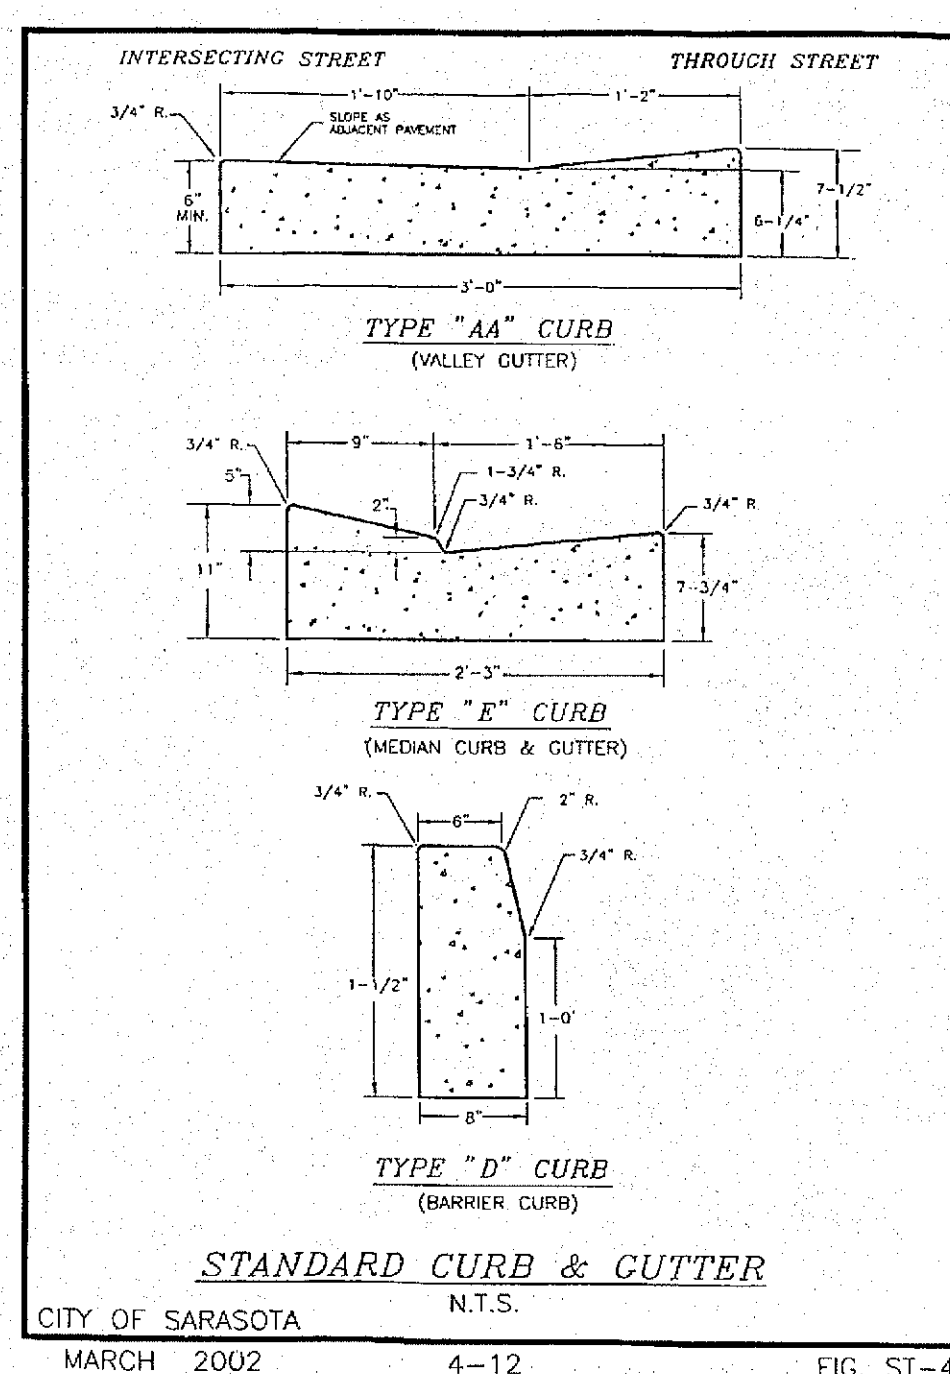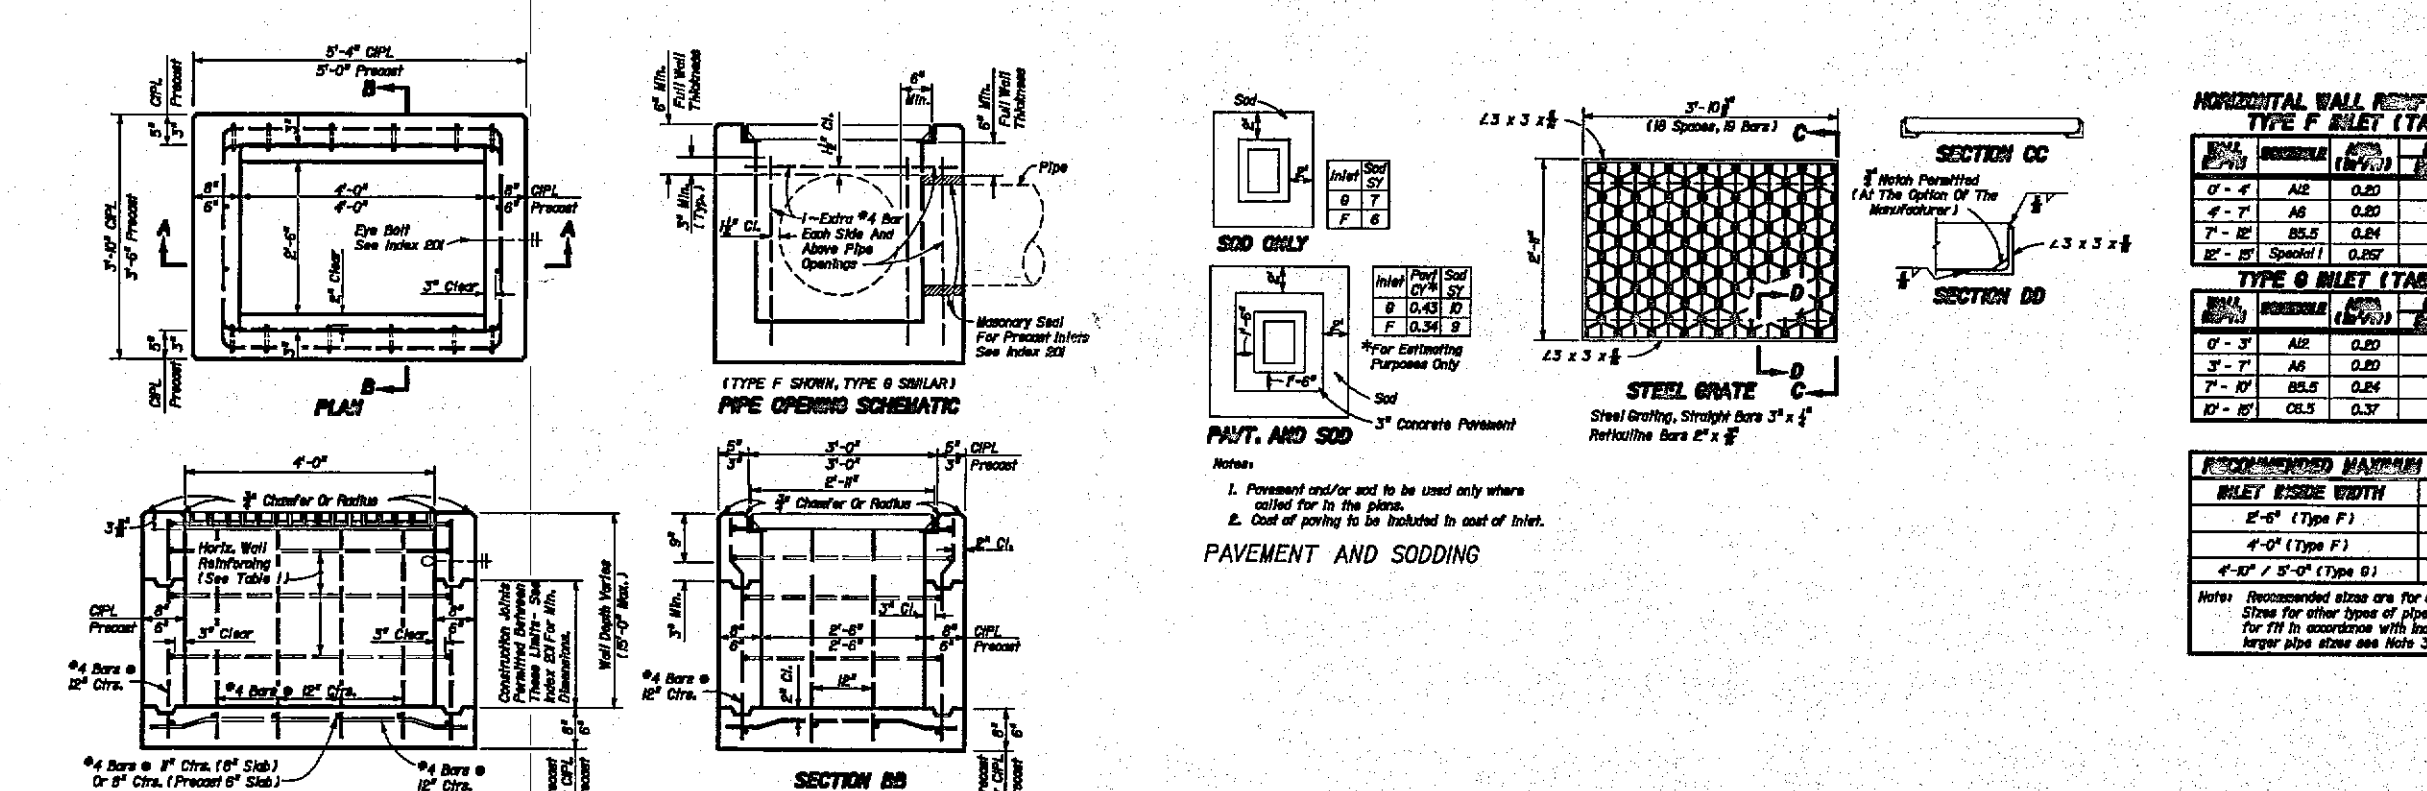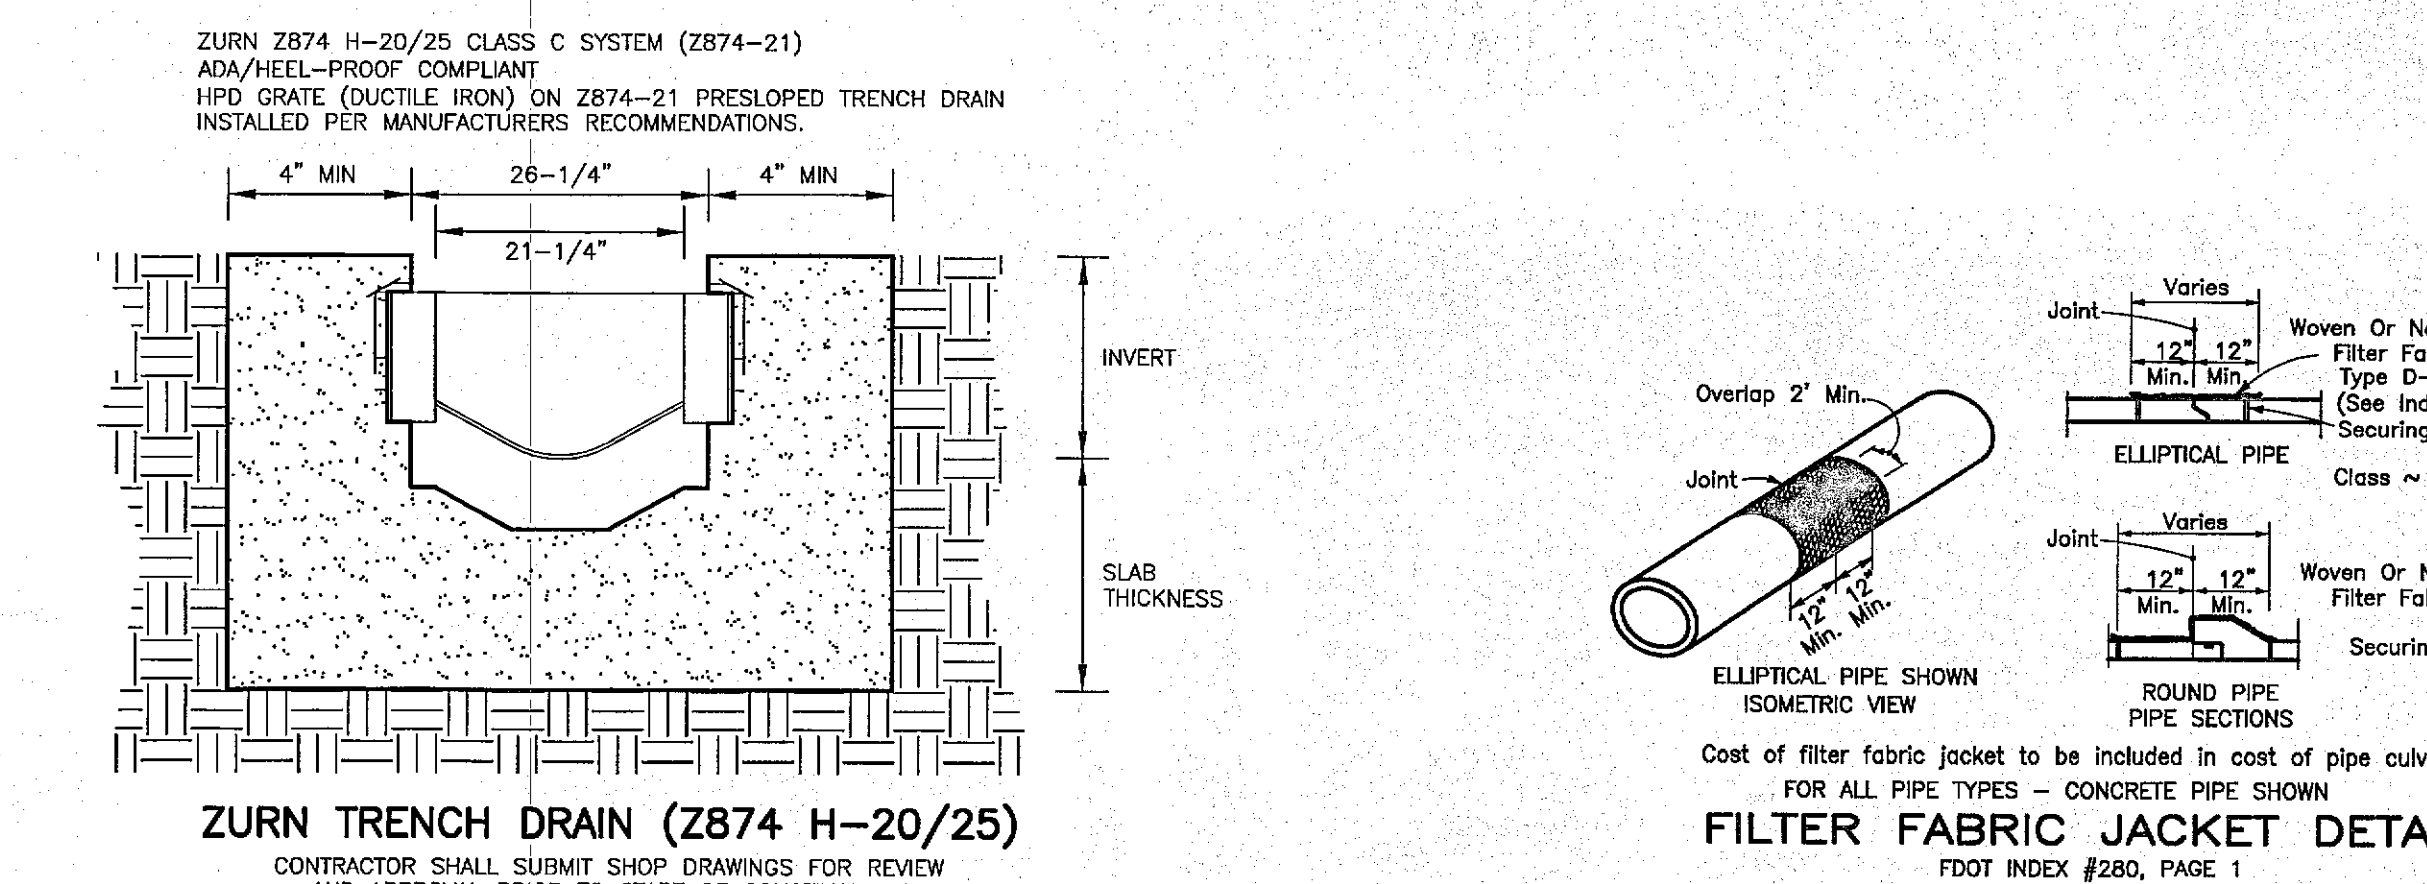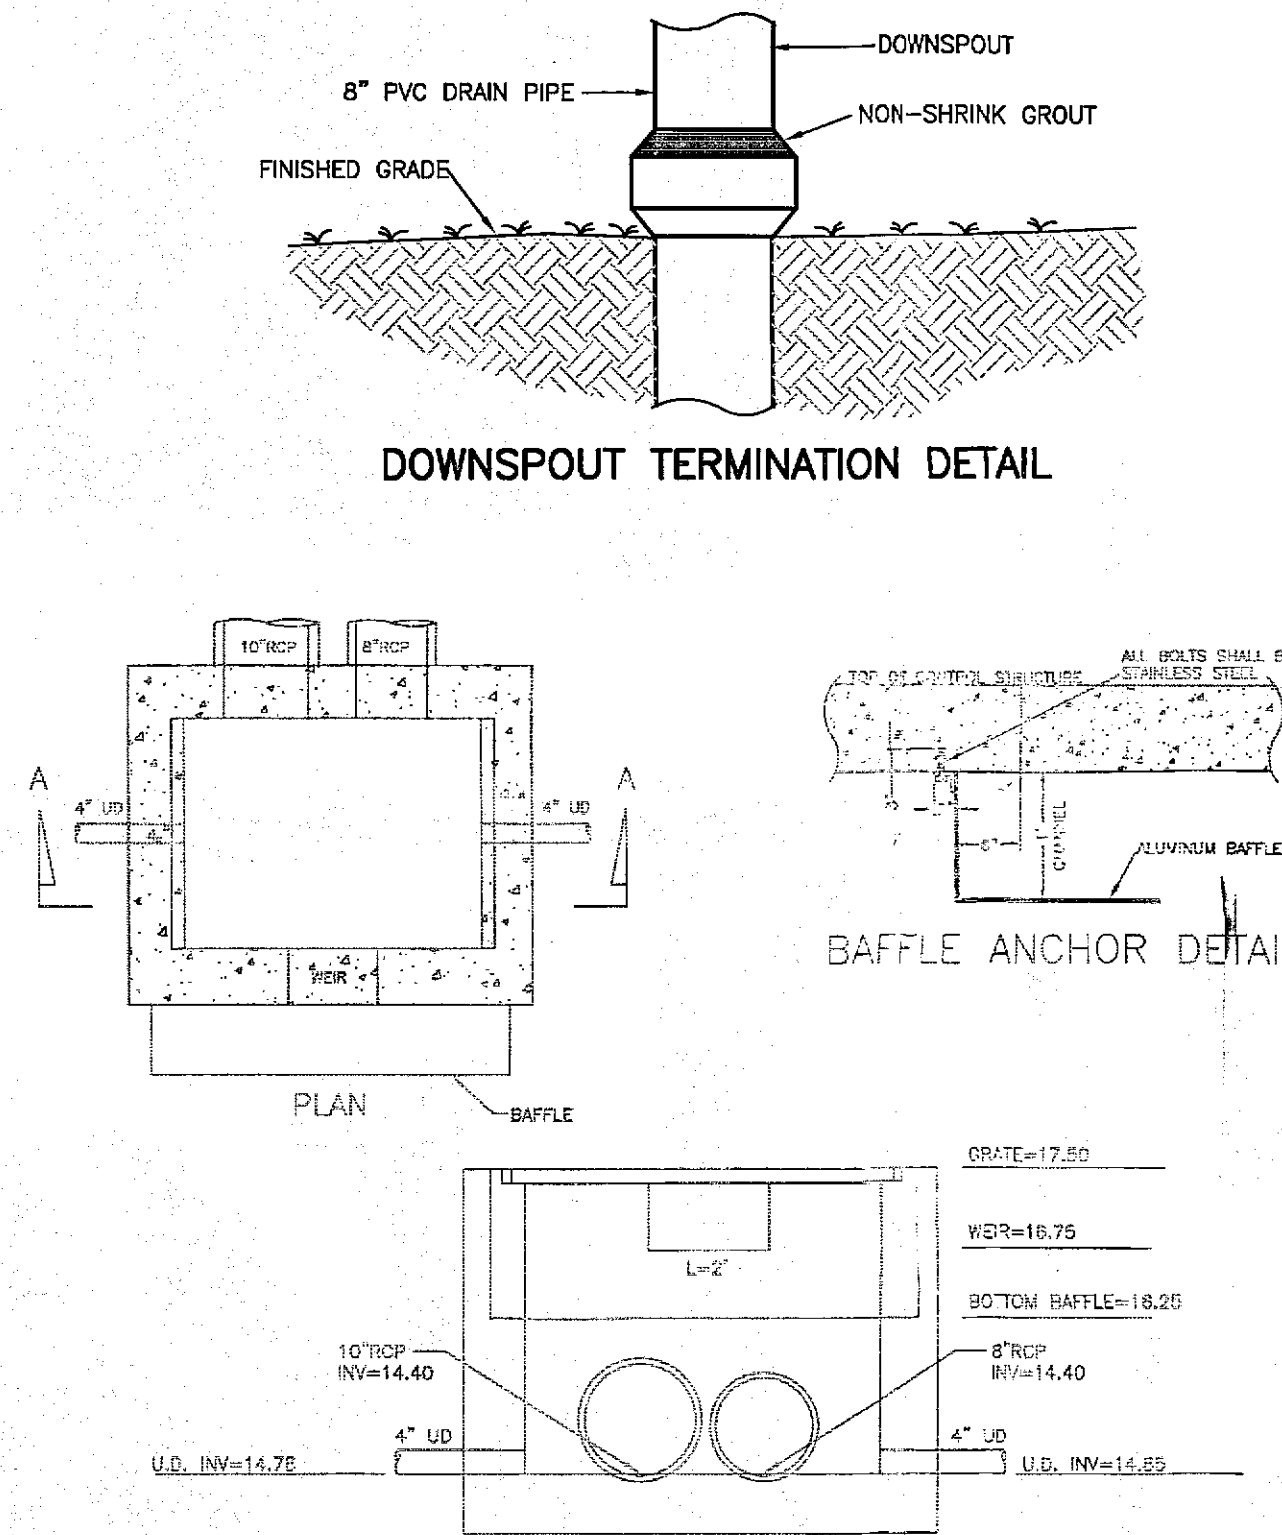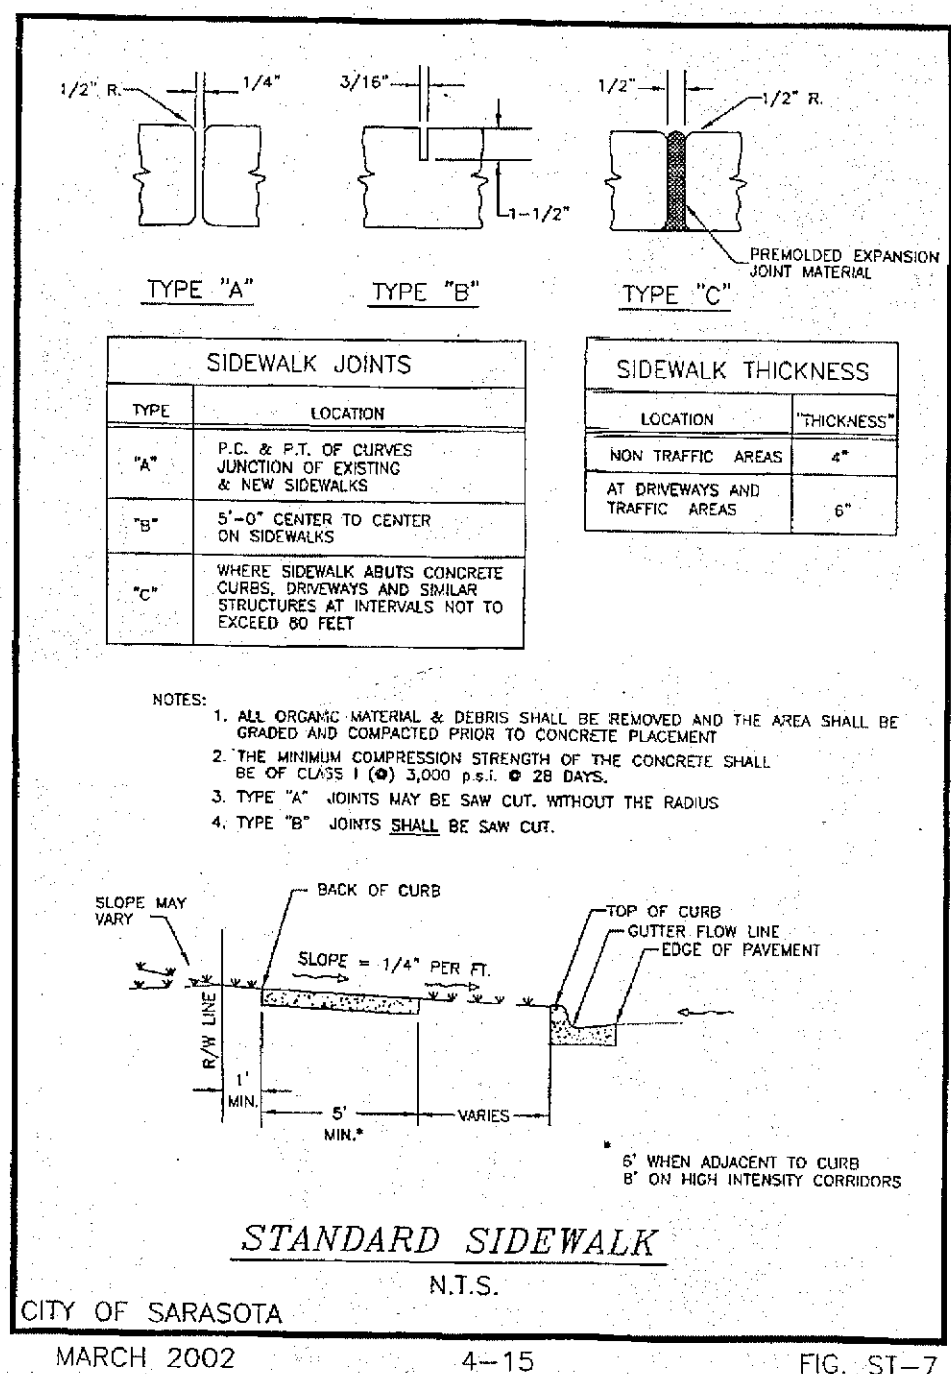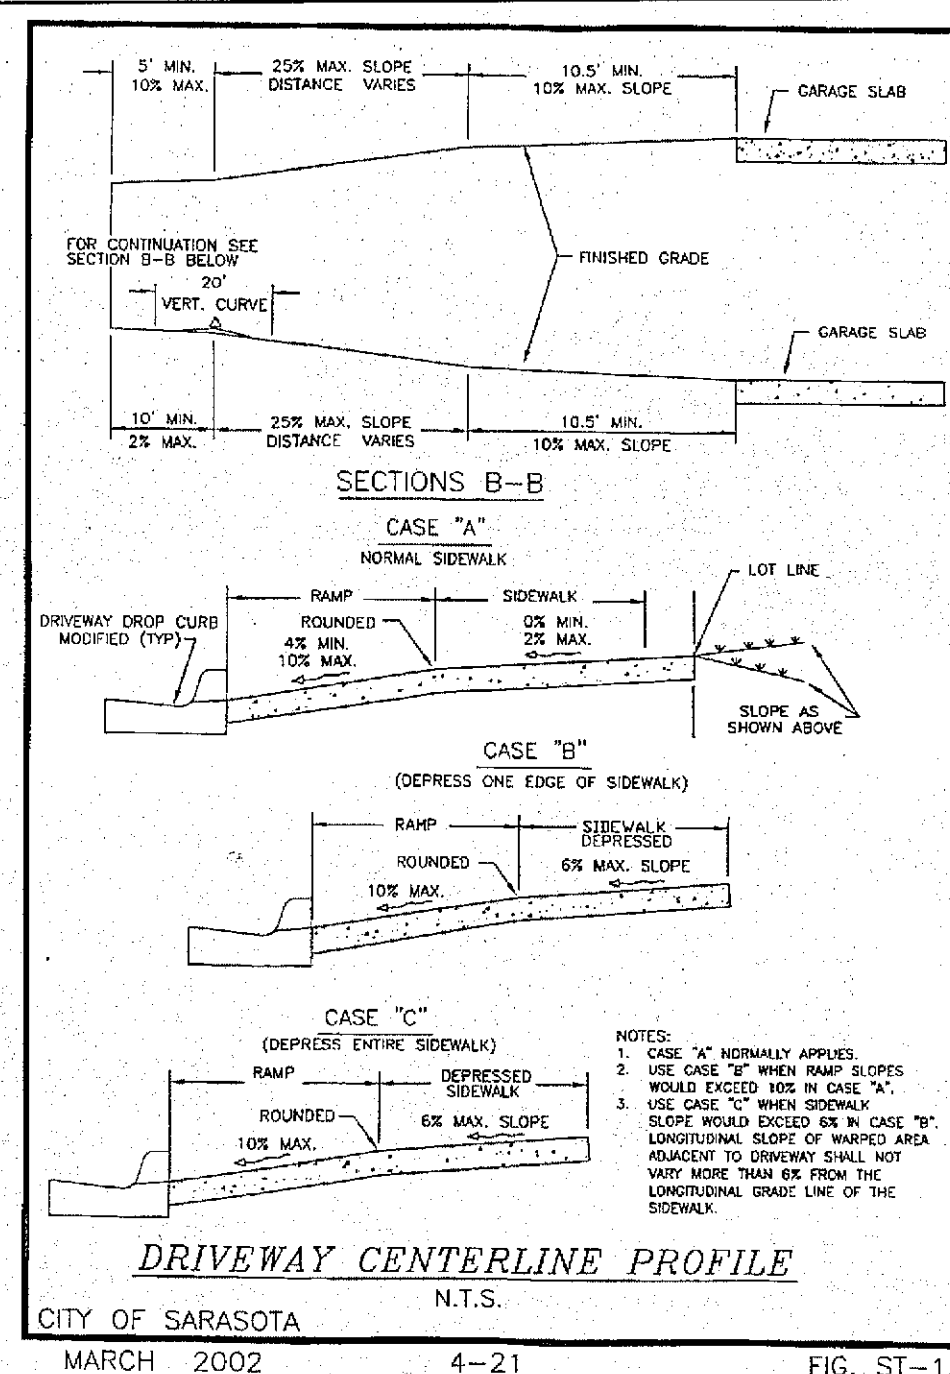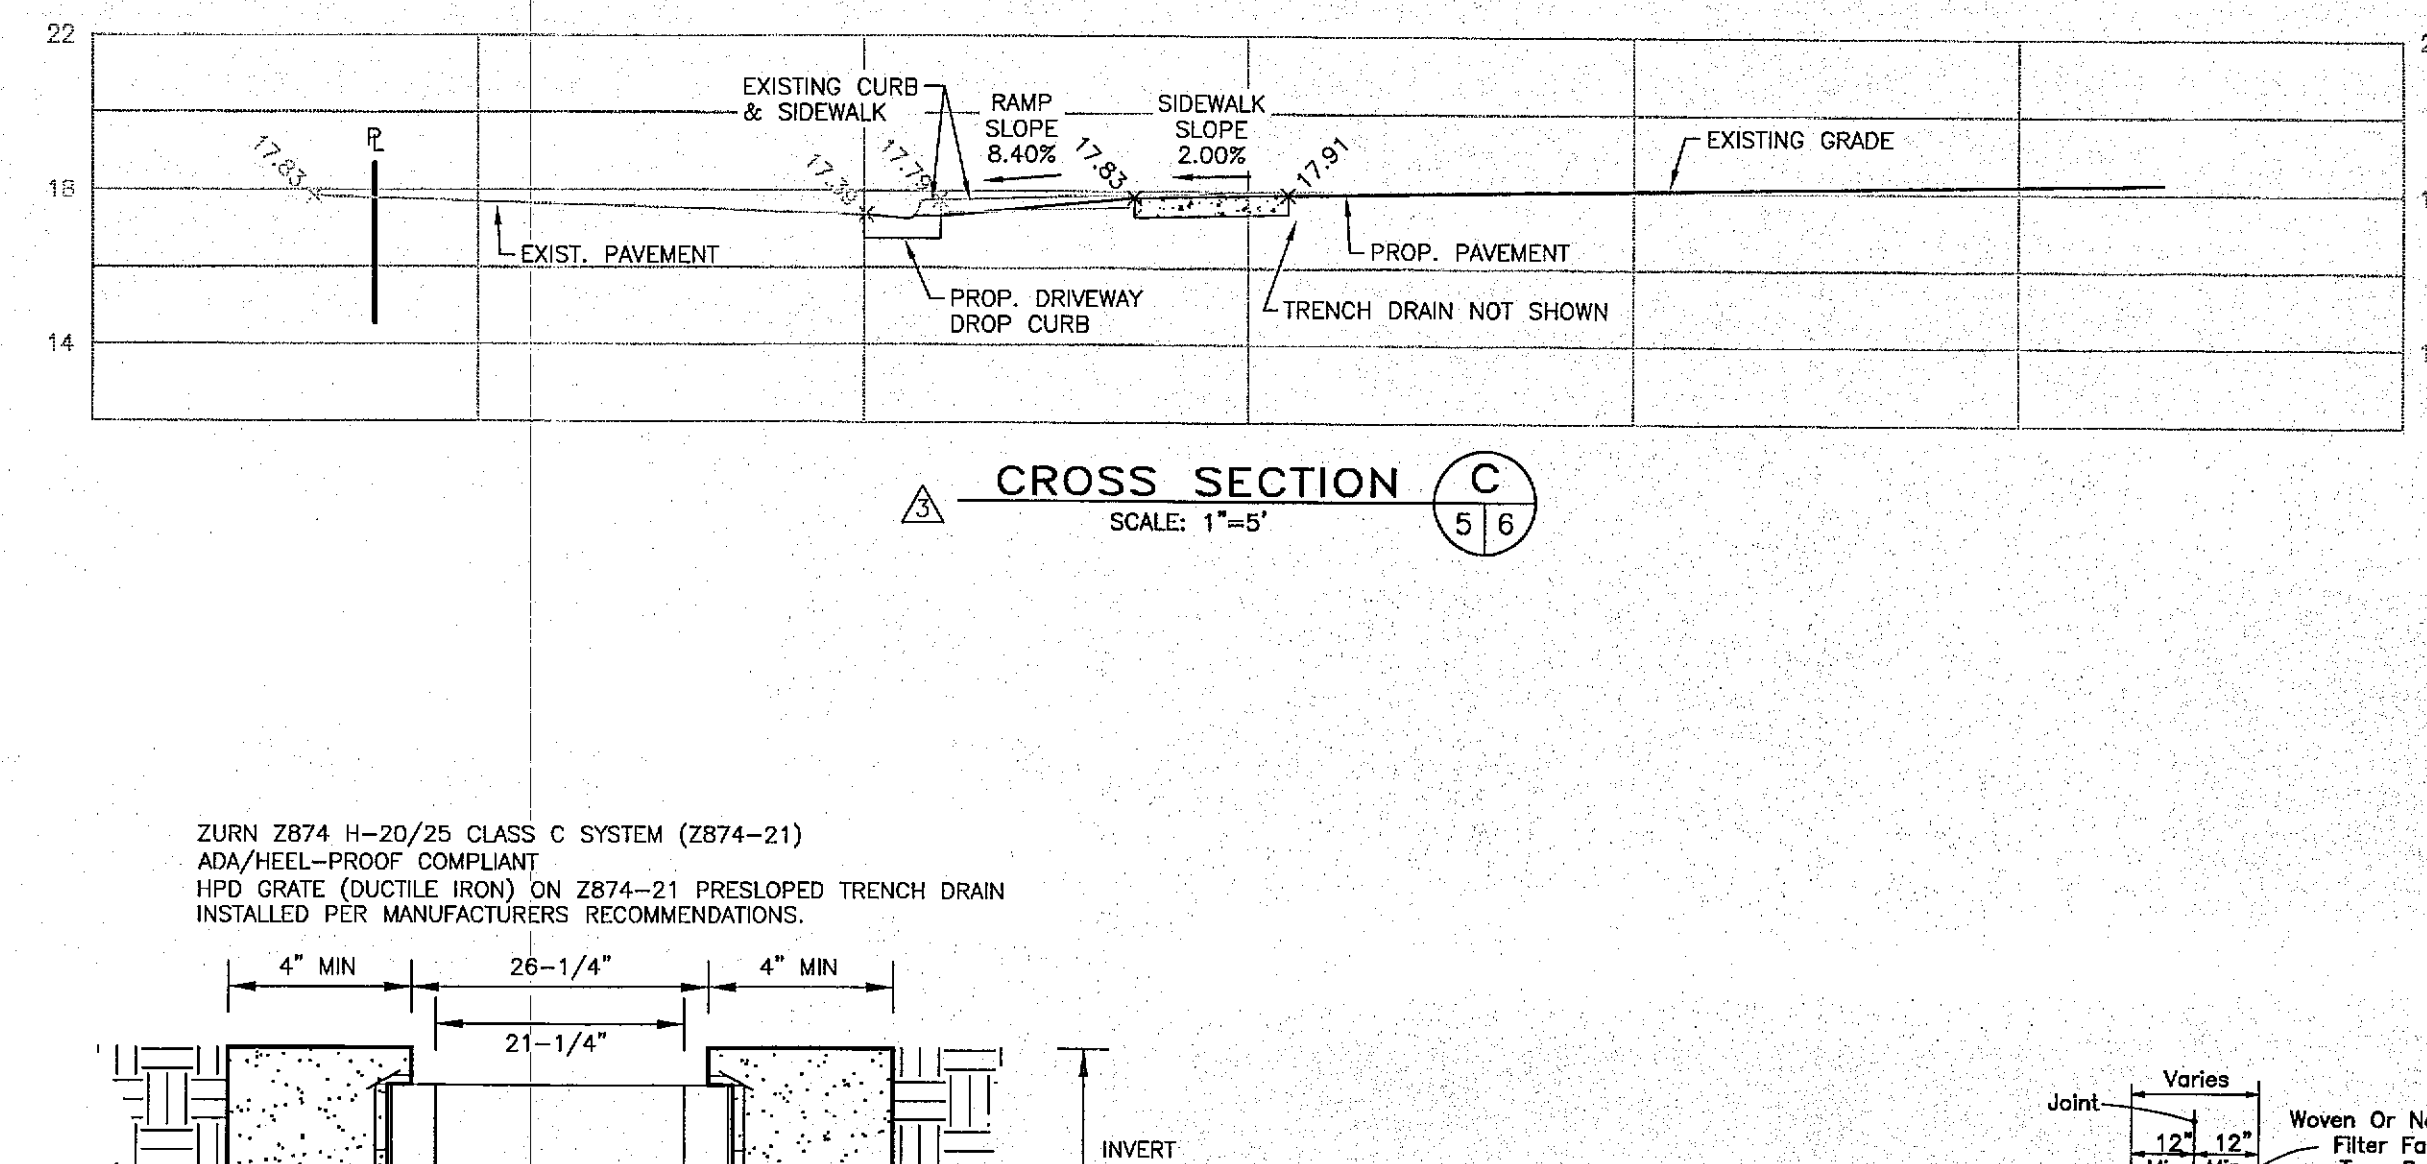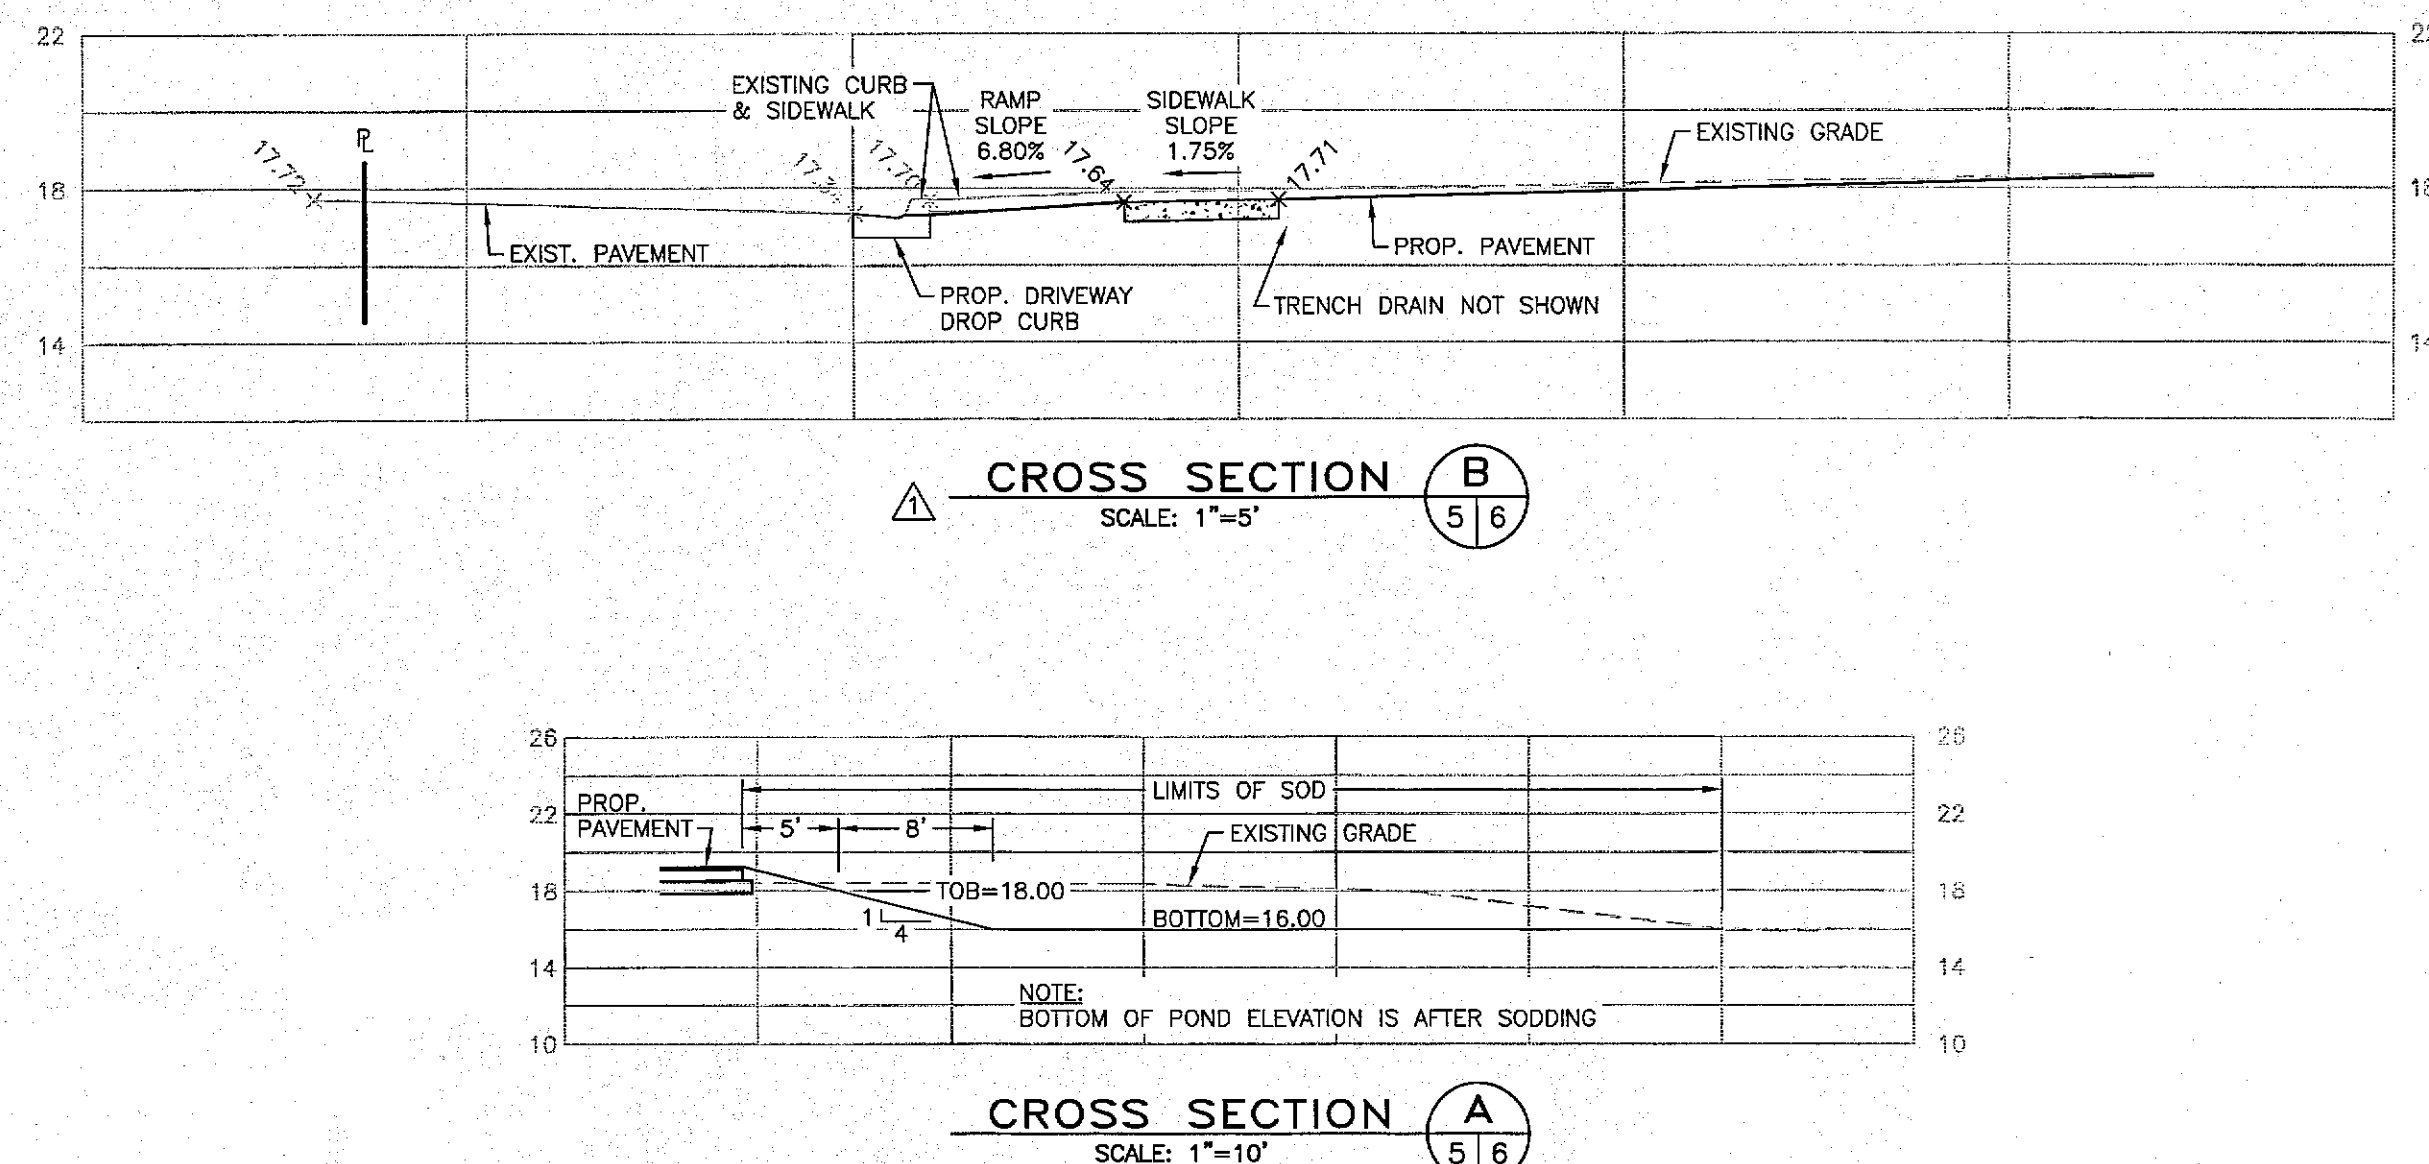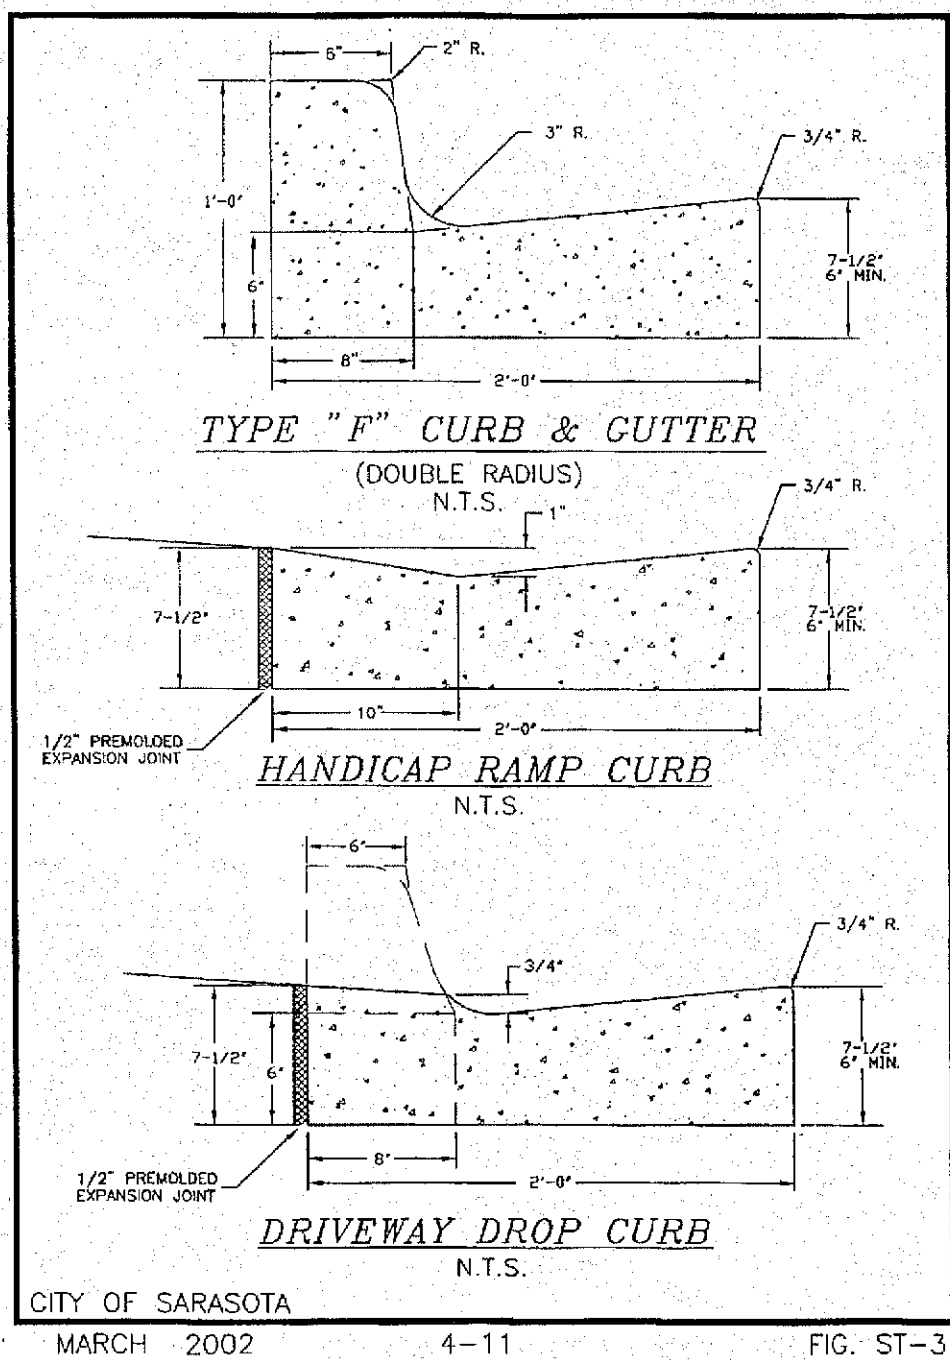

CALL BEFORE YOU DIG!
"SUNSHINE STATE ONE-CALL CENTER"
1-800-432-4770

THE CONTRACTOR SHALL NOTIFY "SUNSHINE STATE ONE-CALL CENTER" AND ALL OTHER UTILITIES FOR LOCATION OF EXISTING FACILITIES PRIOR TO BEGINNING CONSTRUCTION.

BY	DATE	DESCRIPTION
RWD	12/4/12	REVISIONS PER CITY ENGINEERING COMMENTS DATED 12/3/12
RWD	2/25/13	DRIVE AISLE REVISIONS PER ARCHITECT
RWD	9/16/13	STORMWATER RECORD DRAWING

REVISIONS

ENGINEERING, INC.
8540 CONSUMER COURT
SARASOTA, FL 34240
EB #4334

CARLSON STUDIO ARCHITECTURE, INC.
1000 10TH AVENUE
SARASOTA, FL 34234

STORMWATER RECORD DRAWING

SARASOTA MILITARY ACADEMY
APPROVED BY: [Signature]
DATE: 9/12/12
CLIENT: CARLSON STUDIO ARCHITECTURE, INC.
DESC: PAVING, GRADING & DRAINAGE DETAILS

O&M ENTITY COPY

PHONE: (941) 377-9178