

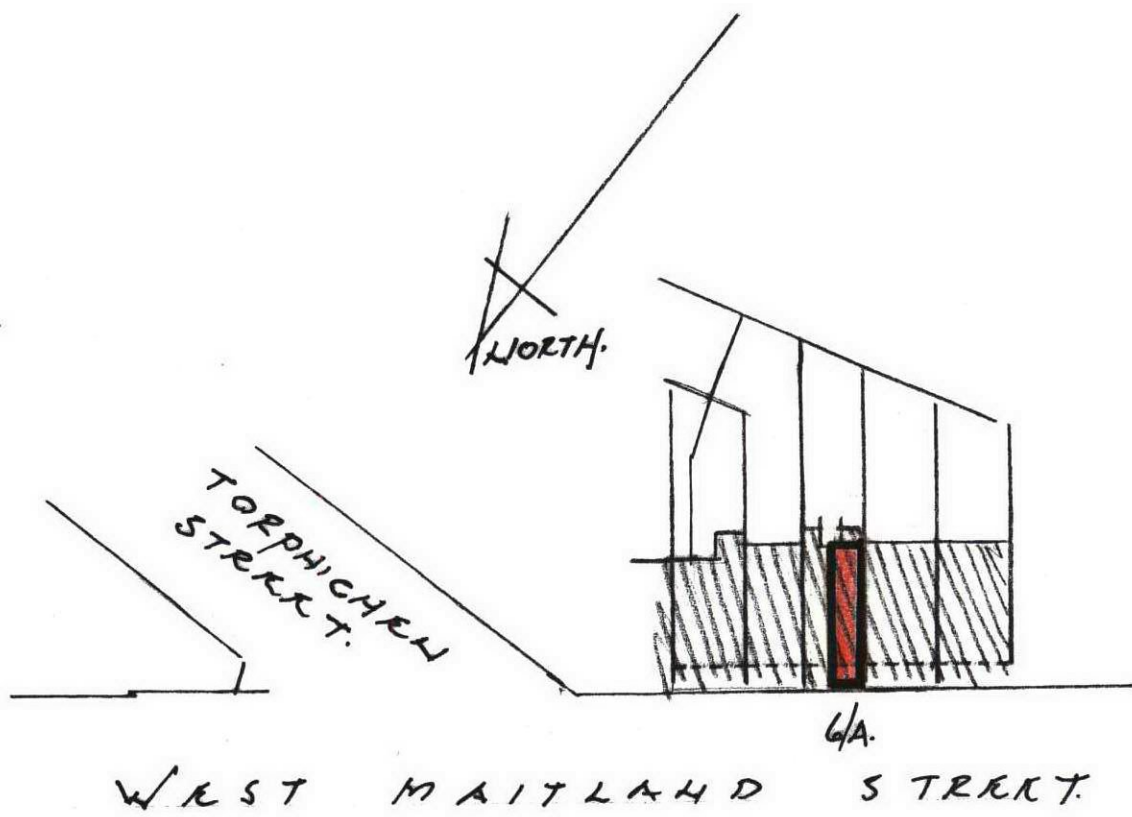


SECURE TO WALL TWIN
AIR CONDITION UNITS IN
COLUMN FORMATION.
EACH UNIT 582 WIDE X 340 DEEP
X 400 HIGH.

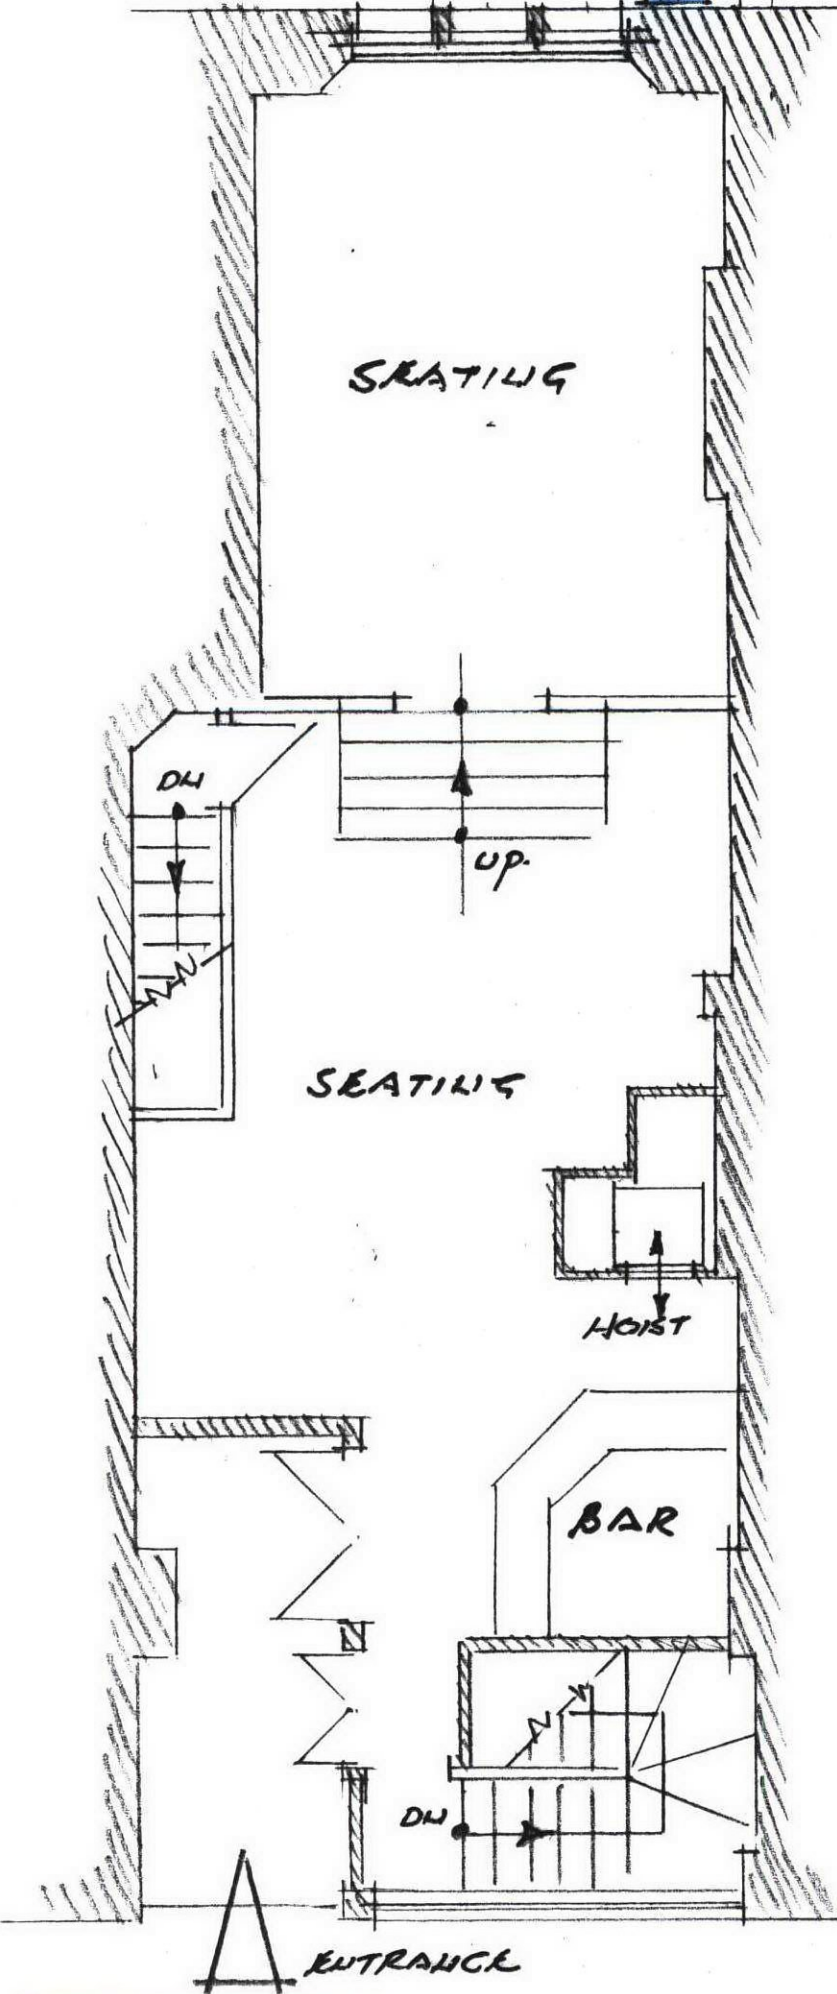

SCALE 1:500

LOCATION PLAN

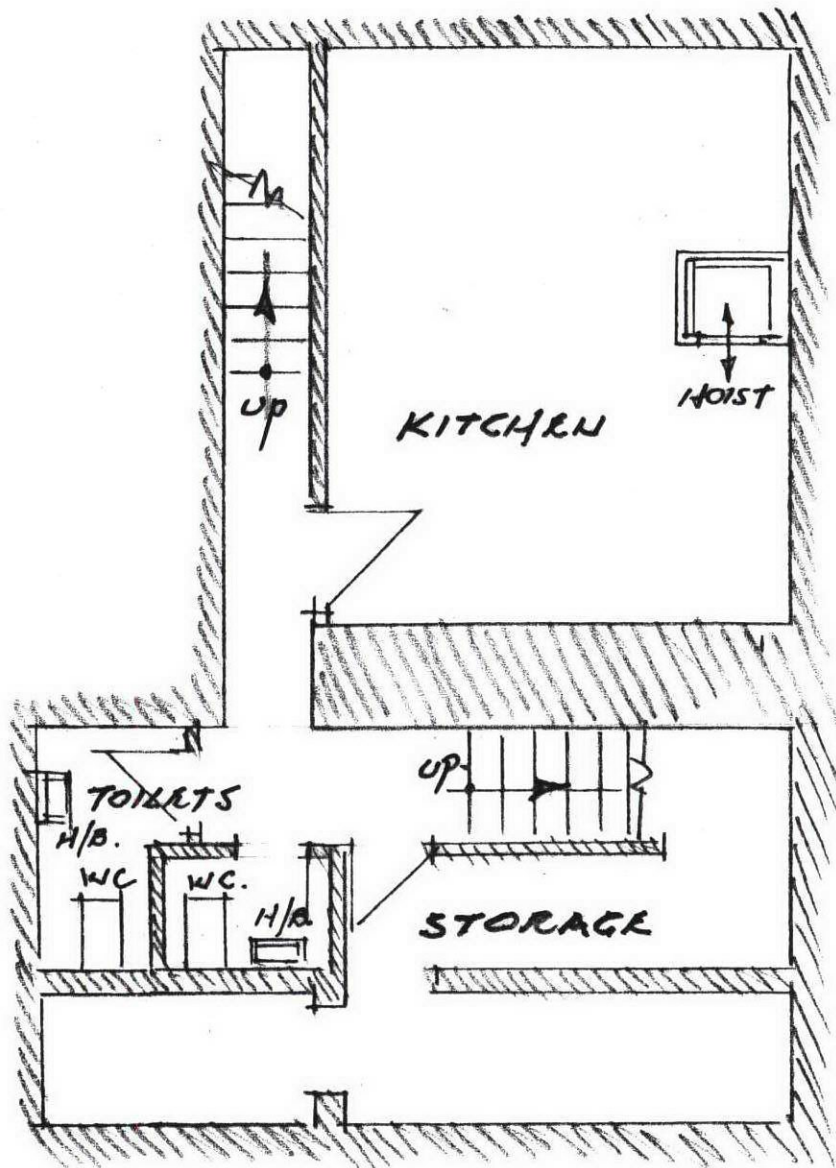

BASEMENT PLAN 1:500

PLANNING & STRATEGY	
DRAWING NO.	0410427118
DATE	25 NOV 2004
MEETING	
AGENDA ITEM	
DECISION	

STREET FLOOR PLAN 1:500

PROPOSED AIR CONDITION INSTALLATION AT
No 6/A WEST MAITLAND STREET * EDINBURGH

DWG : P-18/1

SCALE : AS NOTED

DATE : NOV 2004

AMENDMENTS

[Signature]
6 SILVERKNOWES ROAD EAST
EDINBURGH EH4 5PZ
TEL 0131 336 5983