


NOT FOR CONSTRUCTION
 [CONTRACTOR TO FIELD VERIFY EXISTING
 CONDITIONS PRIOR TO PRICING THIS PLAN]

PLAN LEGEND

- EXISTING TO REMAIN**
- WALL
 - PARTIAL HEIGHT WALL
 - WINDOW / SIDELIGHT
 - DOOR AND FRAME
- NEW / RELOCATED**
- WALL
 - PARTIAL HEIGHT WALL
 - WINDOW / SIDELIGHT
 - BUILT-IN CASEWORK/
PLUMBING FIXTURE
 - DOOR AND FRAME
N = NEW METAL DOOR AND
FRAME

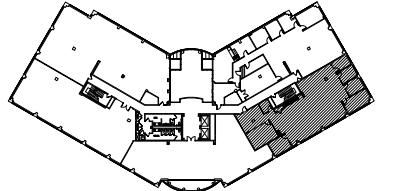

SPEC SUITE

LAKE POINTE IV | SUITE 210 | 8520 ALLISON POINTE BLVD. INDIANAPOLIS, IN 46240



2023.040
 DATE: 03.03.23
 PROJECT MGR: BNH
 SCALE: 1/8" = 1'-0"
 REVISION Δ

3,714 RSF

NOT FOR CONSTRUCTION
[CONTRACTOR TO FIELD VERIFY EXISTING
CONDITIONS PRIOR TO PRICING THIS PLAN]



PLAN LEGEND

EXISTING TO BE REMOVED

- WALL
- - - DOOR AND FRAME

EXISTING TO REMAIN

- WALL
- - - DOOR AND FRAME

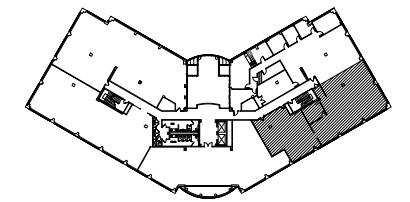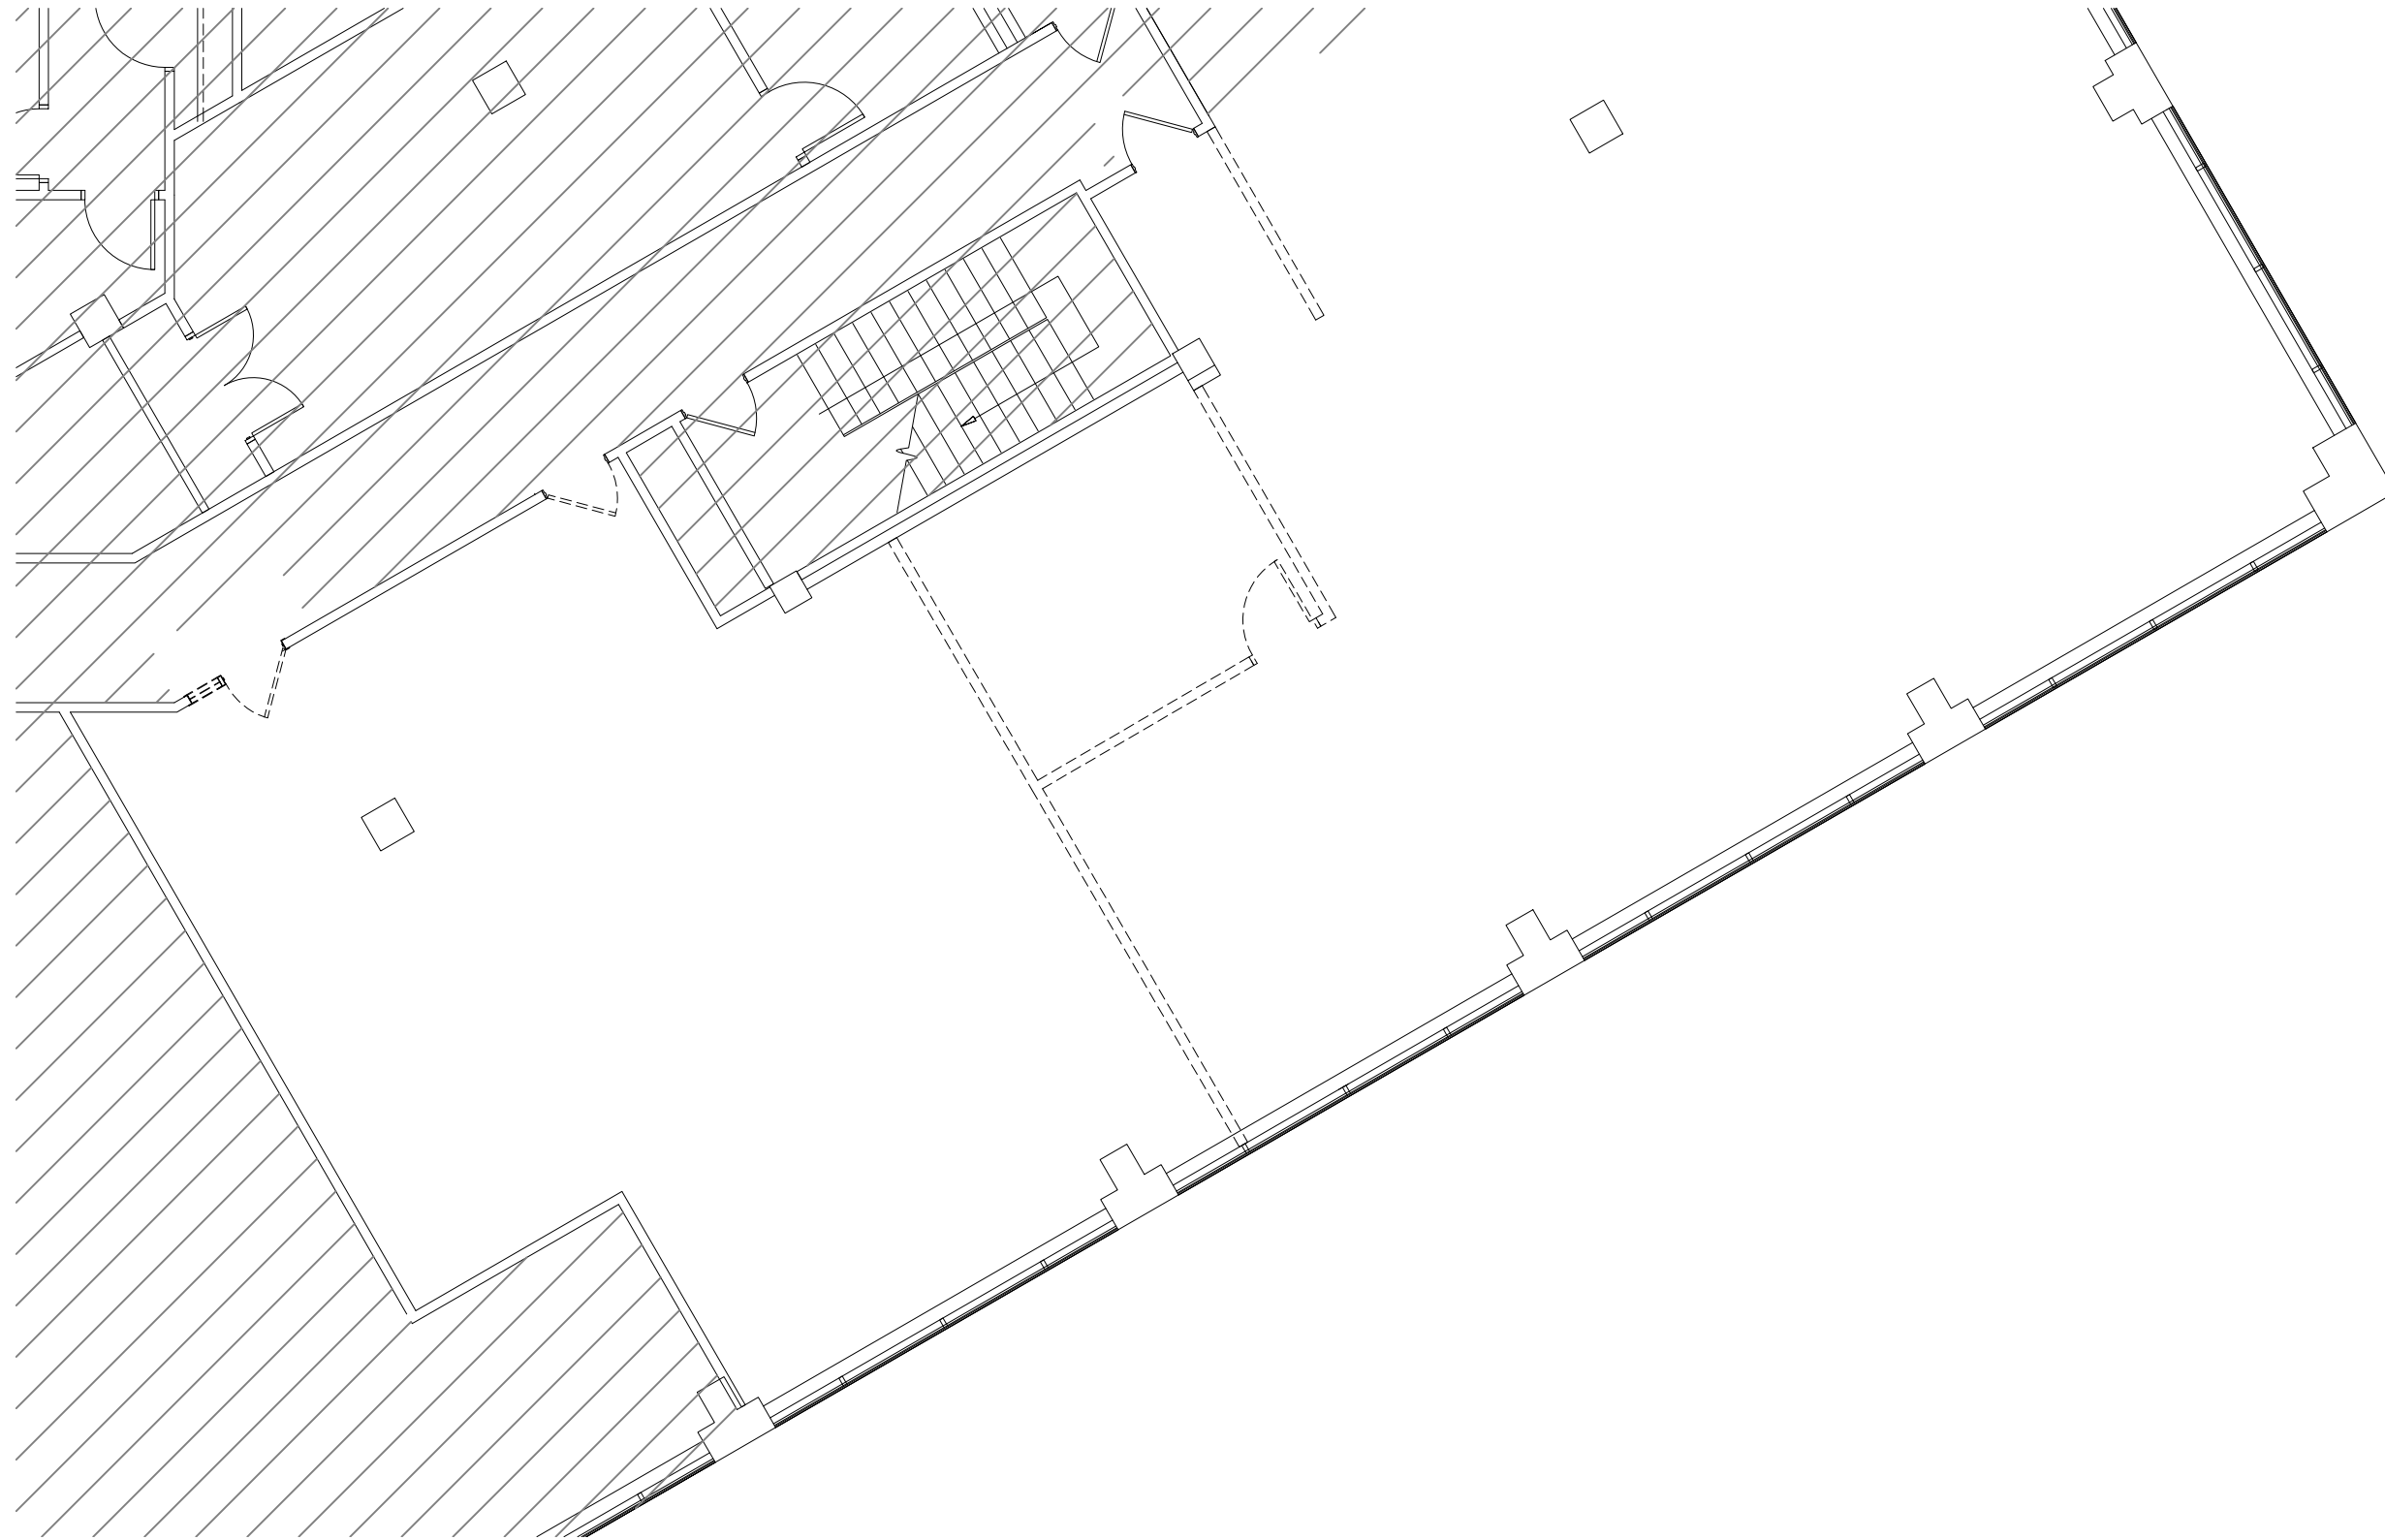

**DECONSTRUCTION
SPEC SUITE**

LAKE POINTE IV | SUITE 210 | 8520 ALLISON POINTE BLVD. INDIANAPOLIS, IN 46240



3,714 RSF

REVISION Δ

SCALE: 1/8" = 1'-0"

PROJECT MGR: BNH

DATE: 03.03.23

2023.040