





The contractor is responsible for checking dimensions, tolerances and references. Any discrepancy to be verified with the Architect before proceeding with the works. Where an item is covered by drawings to different scales the larger scale drawing is to be worked to. Do not scale drawing. Figured dimensions to be worked to in all cases.

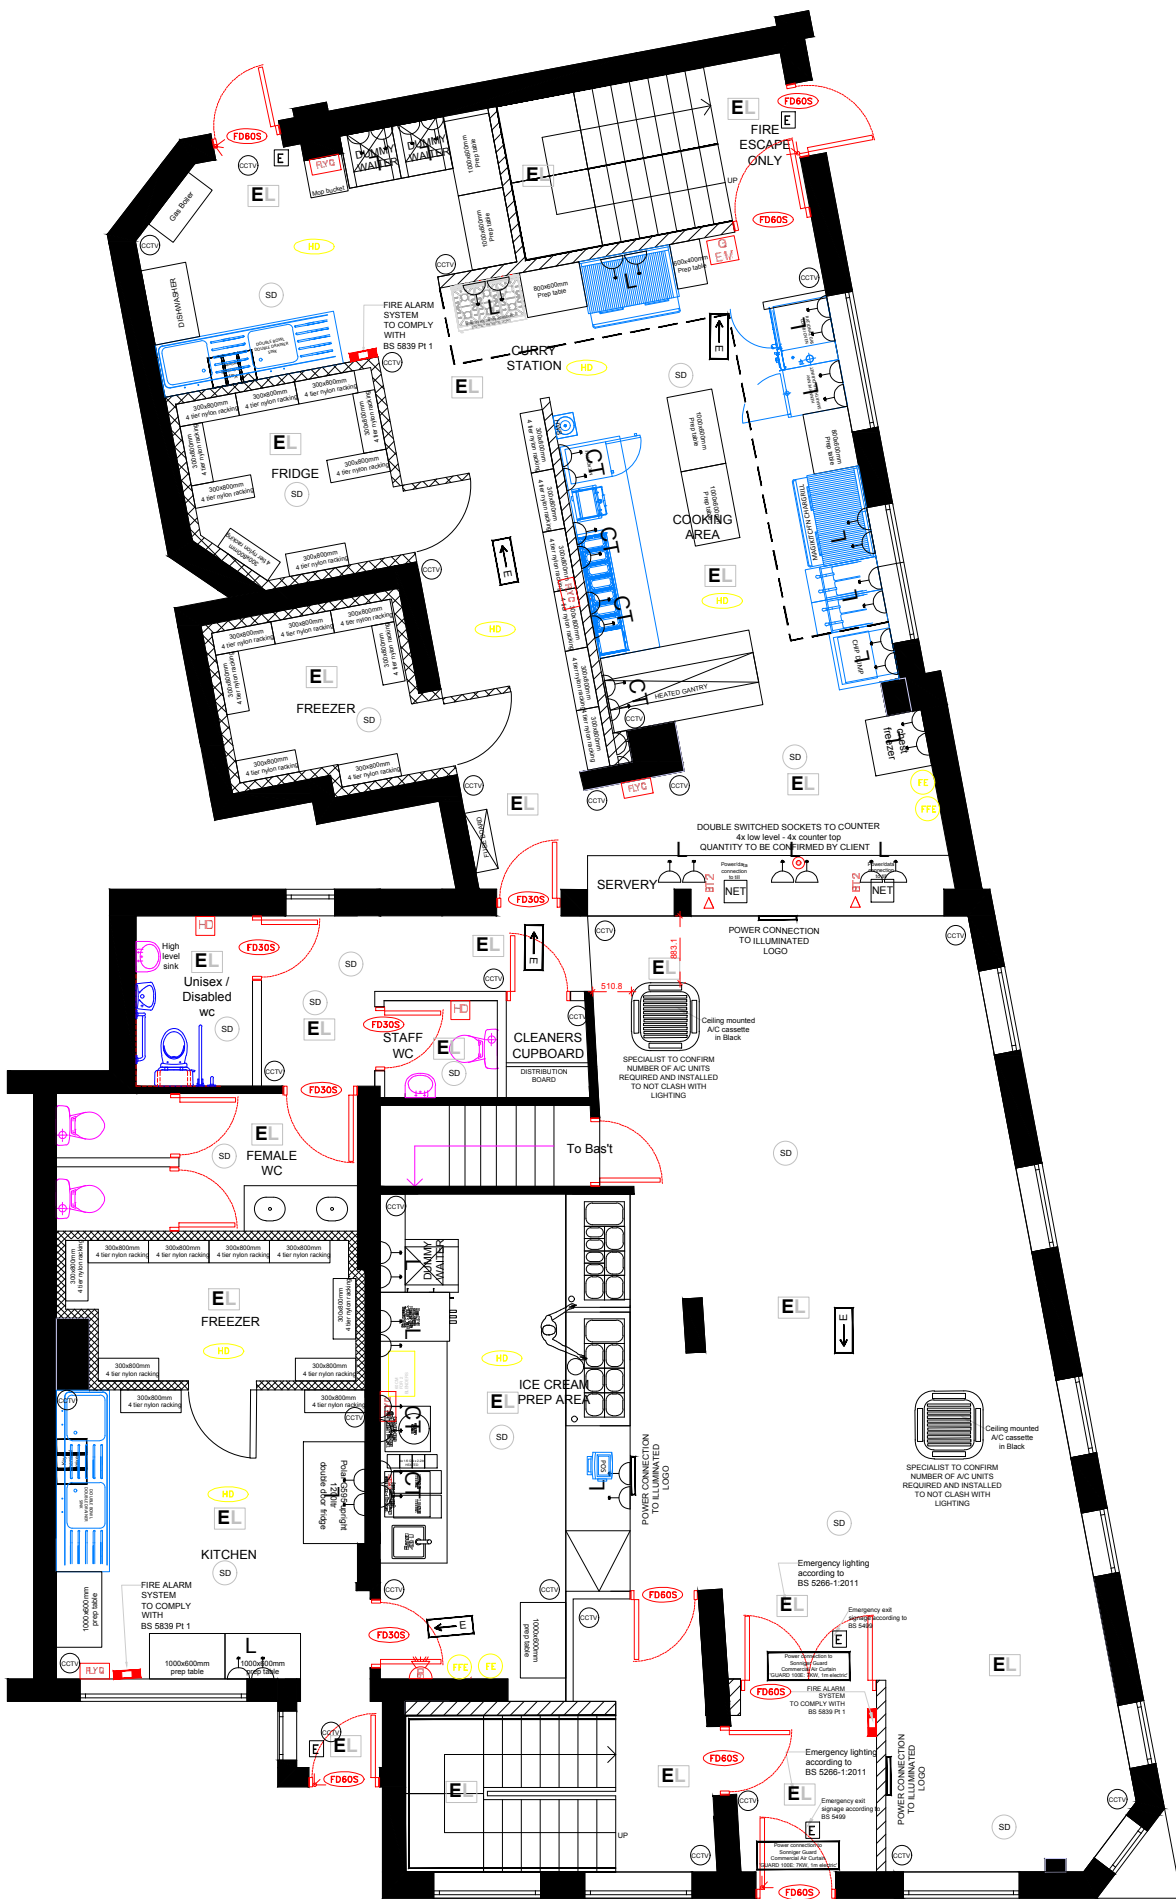

PROPOSED GROUND FLOOR ELECTRICAL LAYOUT

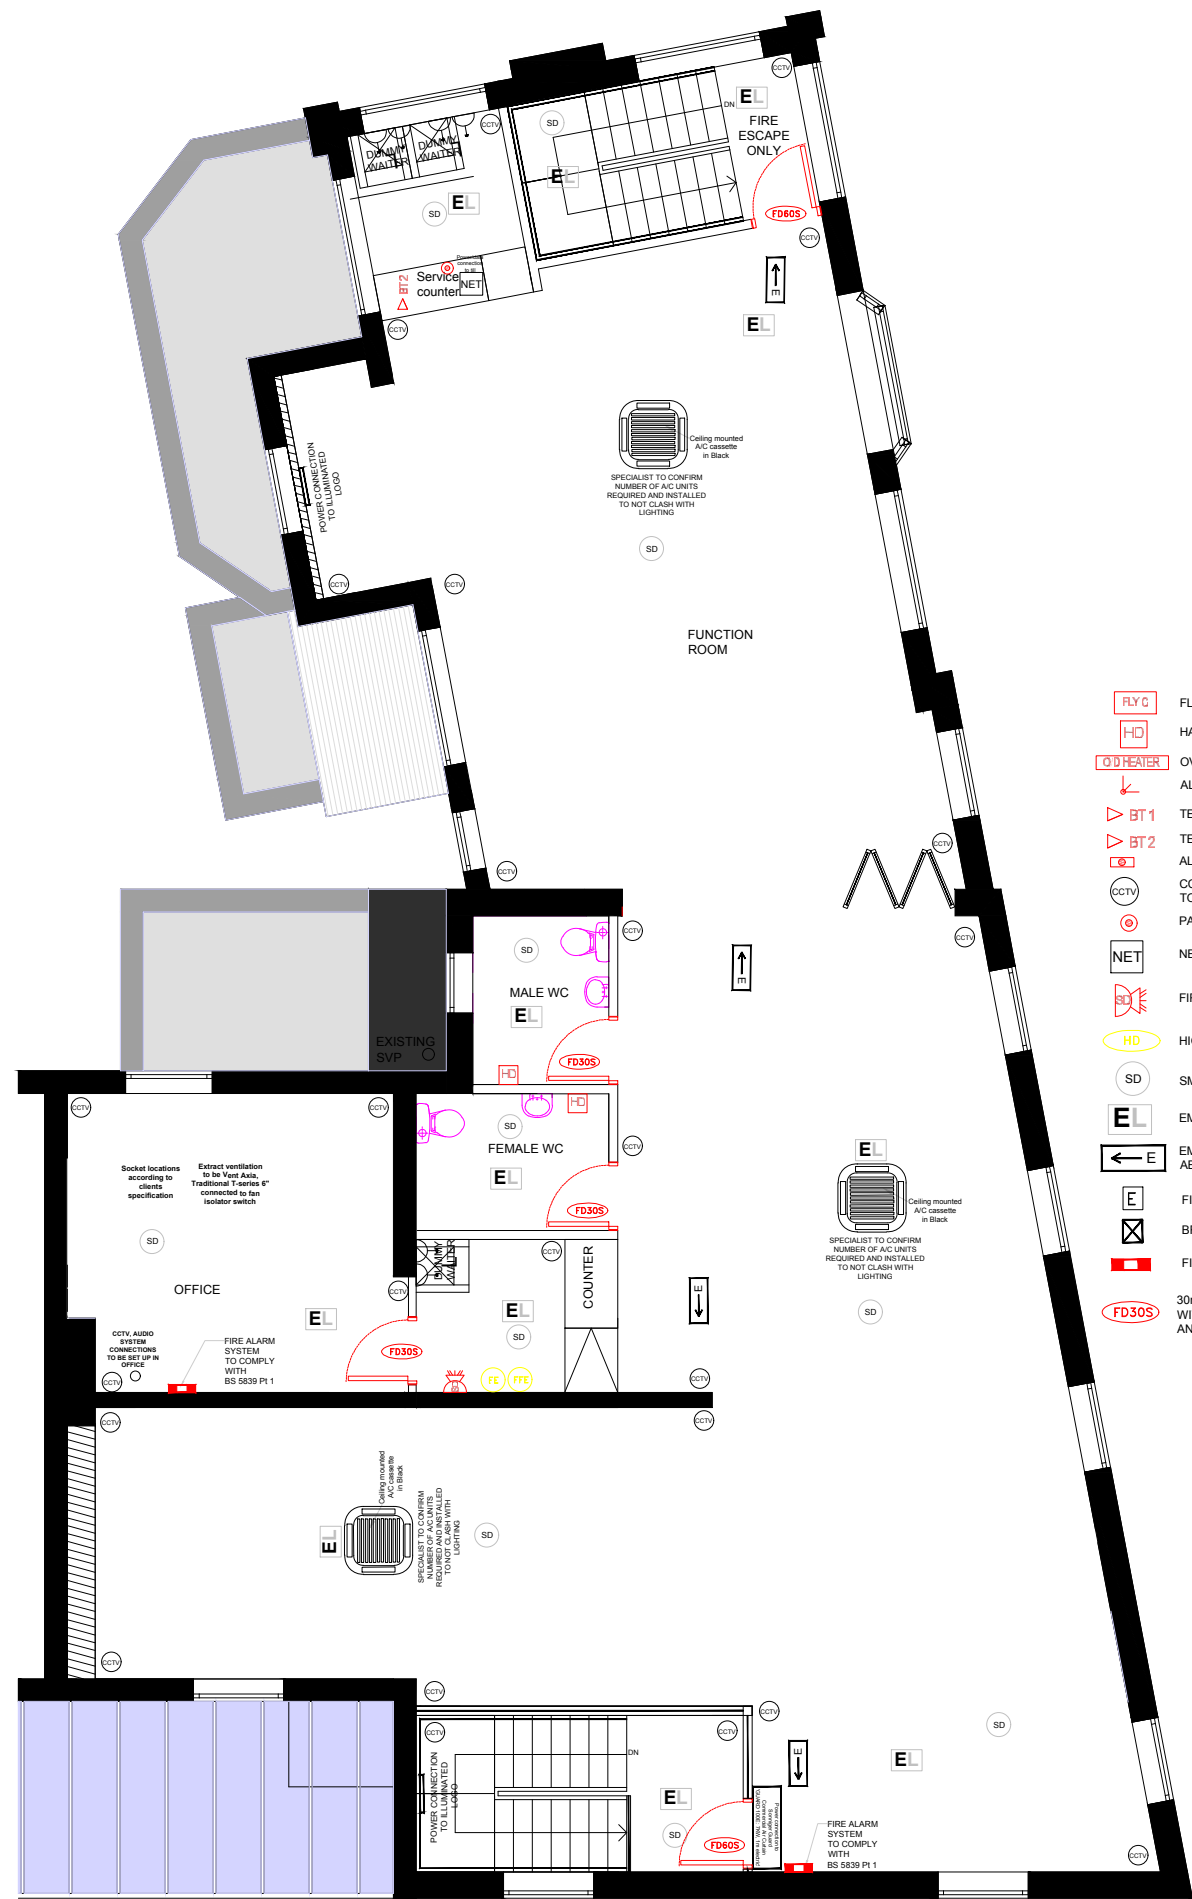

PROPOSED FIRST FLOOR ELECTRICAL LAYOUT

- FLYC FLYCATCHER
 - HD HAND DRYER FOR TOILETS
 - O/D HEATER OVER DOOR HEATER
 - BT 1 TELEPHONE LINE 1
 - BT 2 TELEPHONE LINE 2
 - A/C ALARM DOOR CONTACT/
 - CCTV CCTV, QUANTITY AND LOCATIONS TO BE CONFIRMED WITH CLIENT
 - PAB PANIC ALARM BUTTON IN COUNTER
 - NET NETWORK POINTS X2
 - S/B FIRE ALARM SOUNDER BEACON
 - HD HIGH TEMPERATURE HEAT DETECTOR
 - SD SMOKE DETECTOR
 - EL EMERGENCY LIGHTING
 - E EMERGENCY EXIT DIRECTION SIGN ABOVE DOOR
 - E FIRE EXIT SIGN
 - X BREAK GLASS
 - FACP FIRE/ALARM CONTROL PANEL
 - FD30S 30min SELF CLOSING FIRE DOOR WITH SMOKE SEALS AND INTUMESCENT STRIPS
 - FE FIRE EXTINGUISHER
 - FFE FOAM FIRE EXTINGUISHER
 - GEM EMERGENCY GAS SWITCH OFF
 - CT Counter top 13A Double socket
 - L Low level 13A Double socket
 - A/C Ceiling mounted A/C cassettes to specialist design and specification in White. To be mounted on the ceiling and not on the cable tray
 - E/F Extractor fan outlet to be routed via most appropriate route
- ALL LOCATIONS OF PROPOSED SOCKETS/CCTV CAMERAS ARE FOR INDICATIVE PURPOSES ONLY. CONTRACTOR TO CONFIRM LOCATIONS / NUMBERS ON SITE BEFORE INSTALLATION WITH CLIENT
- POWER CONNECTIONS TO ALL APPLIANCES TO COMPLY WITH MANUFACTURER SPECIFICATION
- CCTV, AUDIO SYSTEM CONNECTIONS TO BE SET UP IN OFFICE AT FIRST FLOOR

REV A - 01/12/2022
As requested by project manager

Drawing no. 9		
date	rev.	revision/author/checker
PURPOSE OF ISSUE		
CONSTRUCTION		
PROJECT		
936 - 938 Stockport Road, Levenshulme, Manchester, M19 3NN		
DRAWING		
PROPOSED PLANS: ELECTRICAL LAYOUT		
JOB NO.		REV
2022-165-009		A
DRAWN BY. AS	checked	
SCALE 1:100@A3	DATE: 08.12.2022	