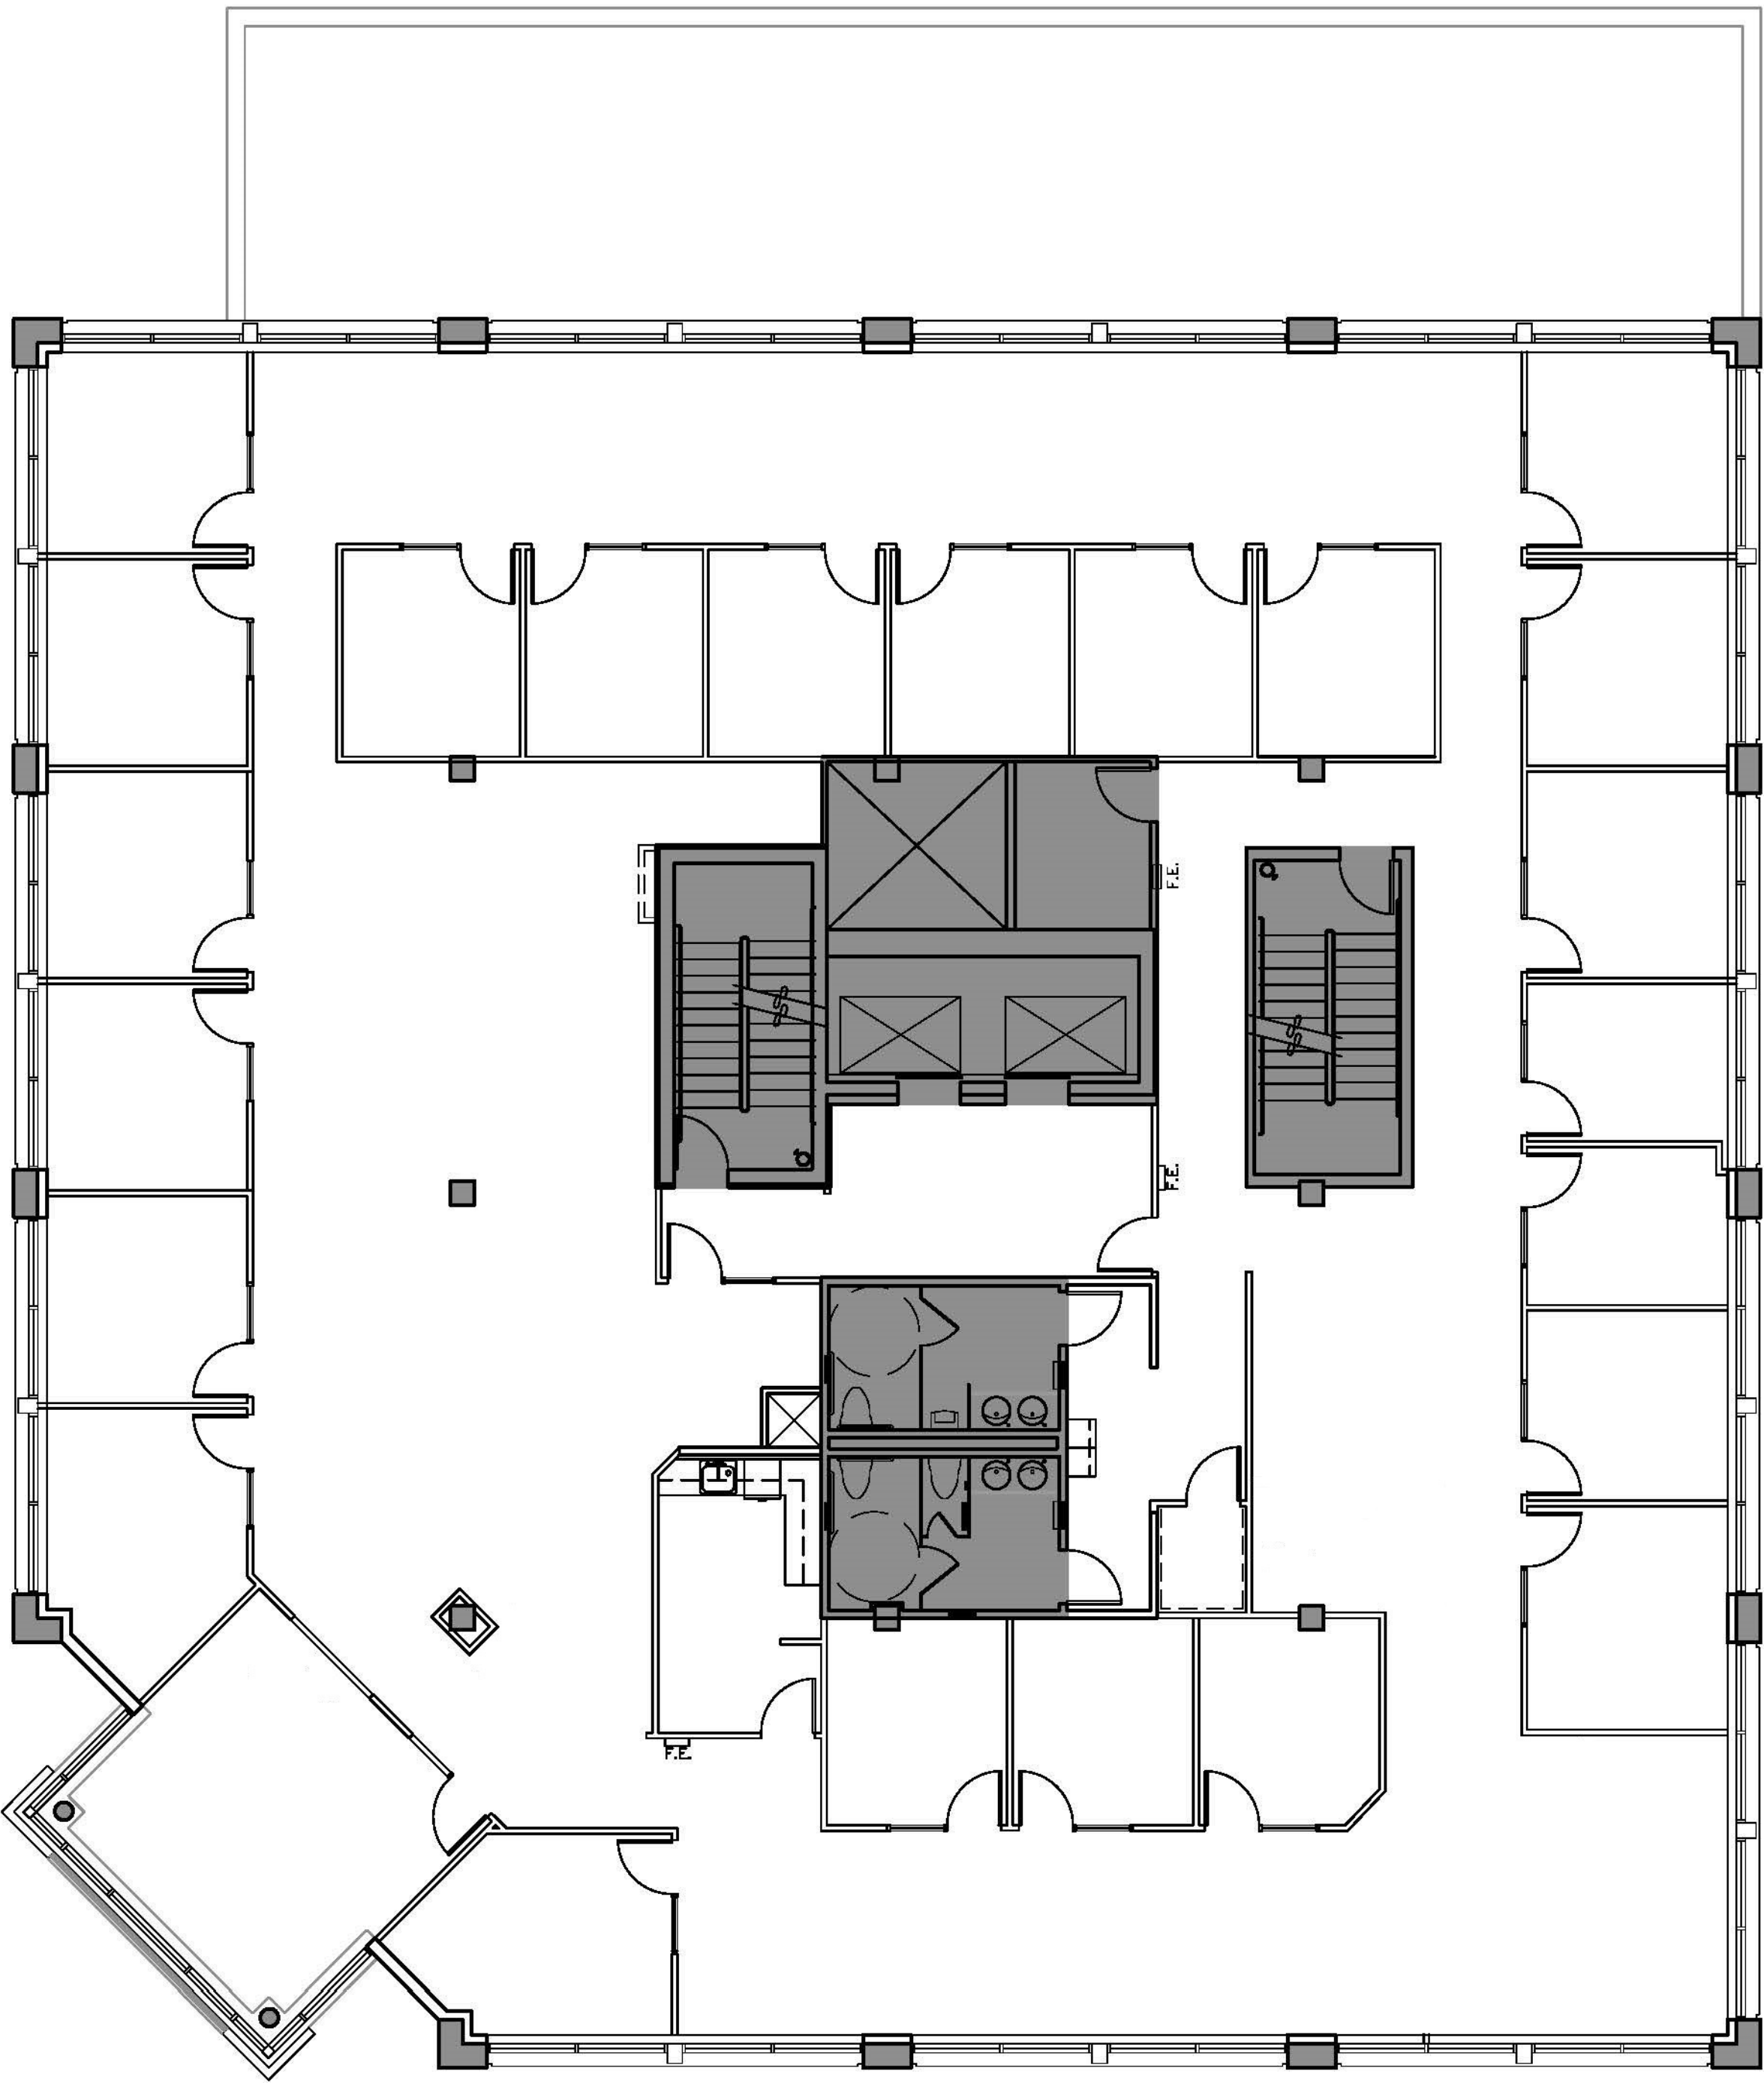


DEMOLITION SYMBOLS

- EXISTING CONSTRUCTION TO BE REMOVED
- EXISTING CONSTRUCTION TO REMAIN

GENERAL DEMOLITION NOTES

- REFER TO CONSTRUCTION PLAN AND CEILING PLAN FOR EXTENT OF DEMOLITION.
- SAVE AND STORE ALL LIGHT FIXTURES, EXIT SIGNS, DOORS & HARDWARE FOR RE-USE, UON.
- SAVE ALL EXISTING PLUMBING FIXTURES FOR RE-USE, UON.
- REMOVE ALL TELEPHONE, ELECTRICAL, AND DATA OUTLETS, FIXTURES, PANELS, ETC FROM ALL DEMOLISHED PARTITIONS. REMOVE ALL CORRESPONDING CABLES, CONDUIT, WIRING, ETC. ALL THE WAY BACK TO THE ORIGINATING SOURCE, UON.

KEYED SHEET NOTES

- REMOVE PORTION OF EXISTING PARTITION.

Tenant:

45TH STREET PLAZA
1100 NE 46TH STREET, SUITE 300
SEATTLE, WA

A Tenant Improvement for:
THE BLUME COMPANY
617 EASTLAKE AVE E, STE 340
SEATTLE, WA 98109



burgess design

| interiors • architecture

1326 Fifth Avenue, Suite 400, Seattle, Washington 98101 T: (206) 587.7120 F: (206) 587.7122

All reproduction & intellectual property rights reserved c 2013

Professional seal

No.	Issue Description	Date

Drawn by: TS Project Manager: TS
Project No: 13-0199-00

Original drawing is 24" x 36". Scale entities accordingly if reduced.