


2nd FLOOR POWER / DATA PLAN

Scale: 1/4" = 1'-0"

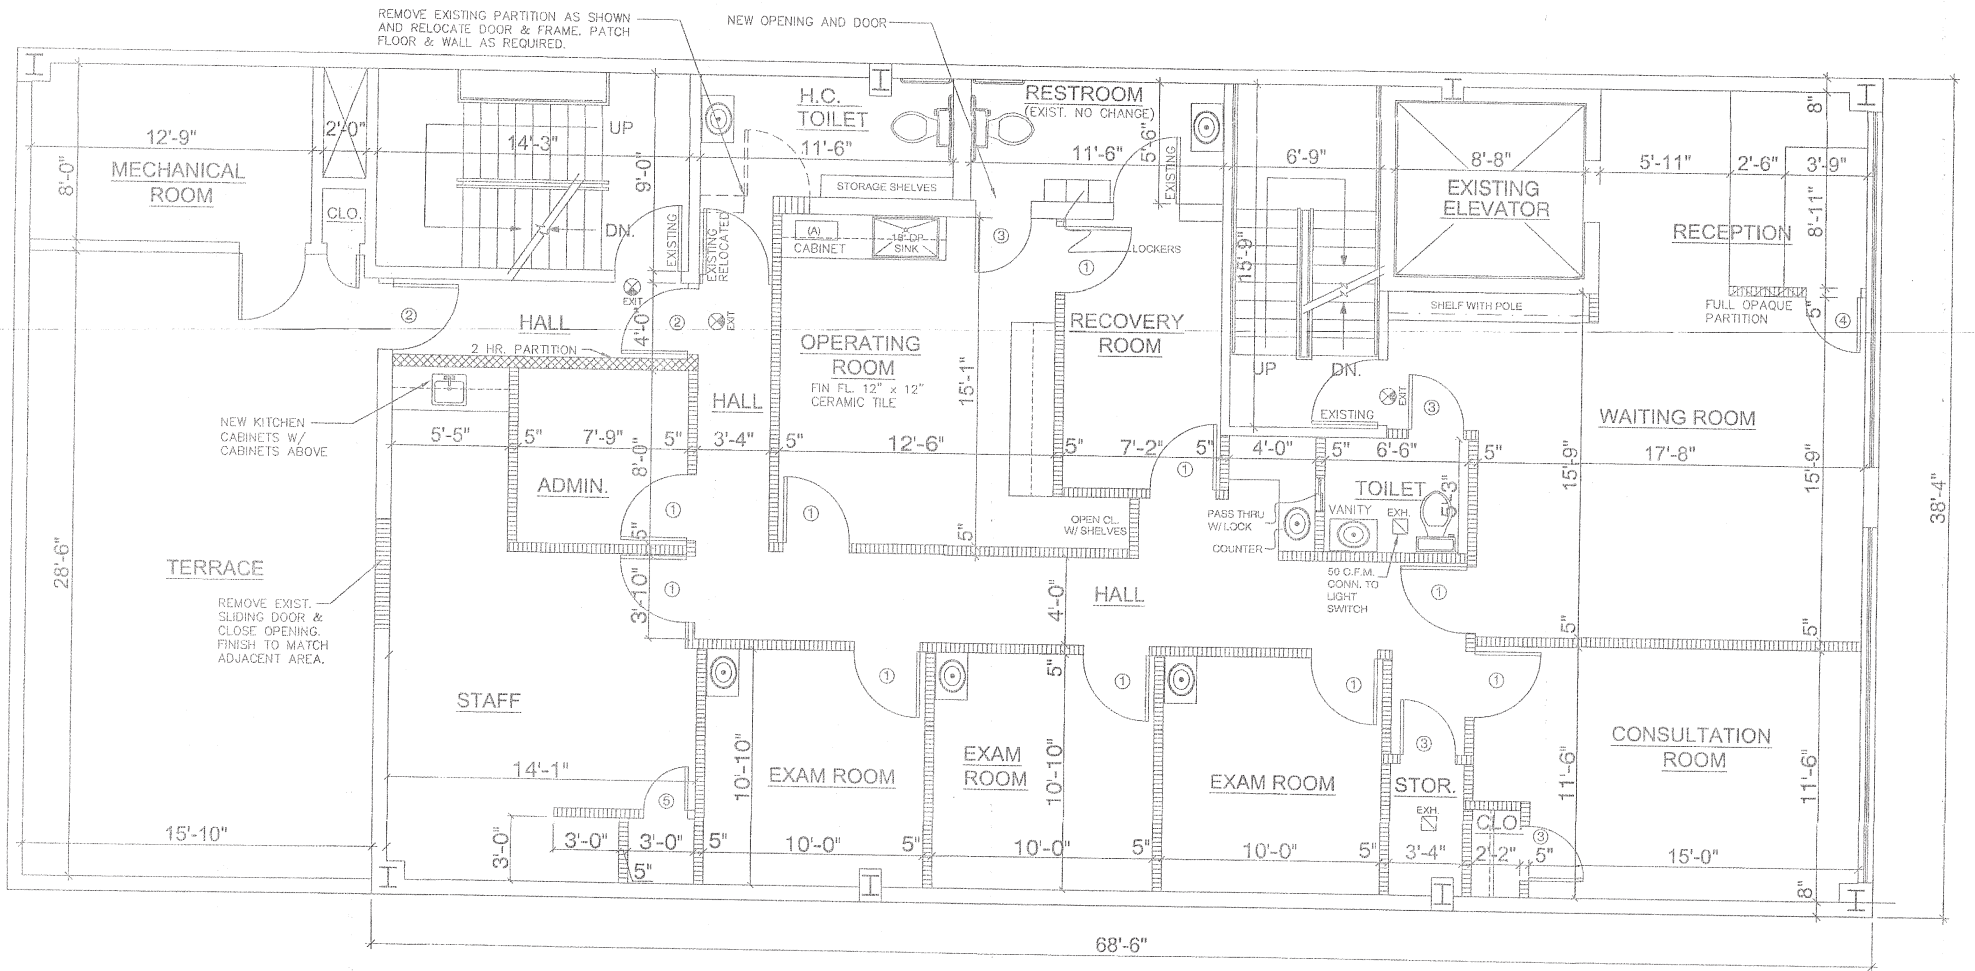

2nd FLOOR PLAN

Scale: 1/4" = 1'-0"