



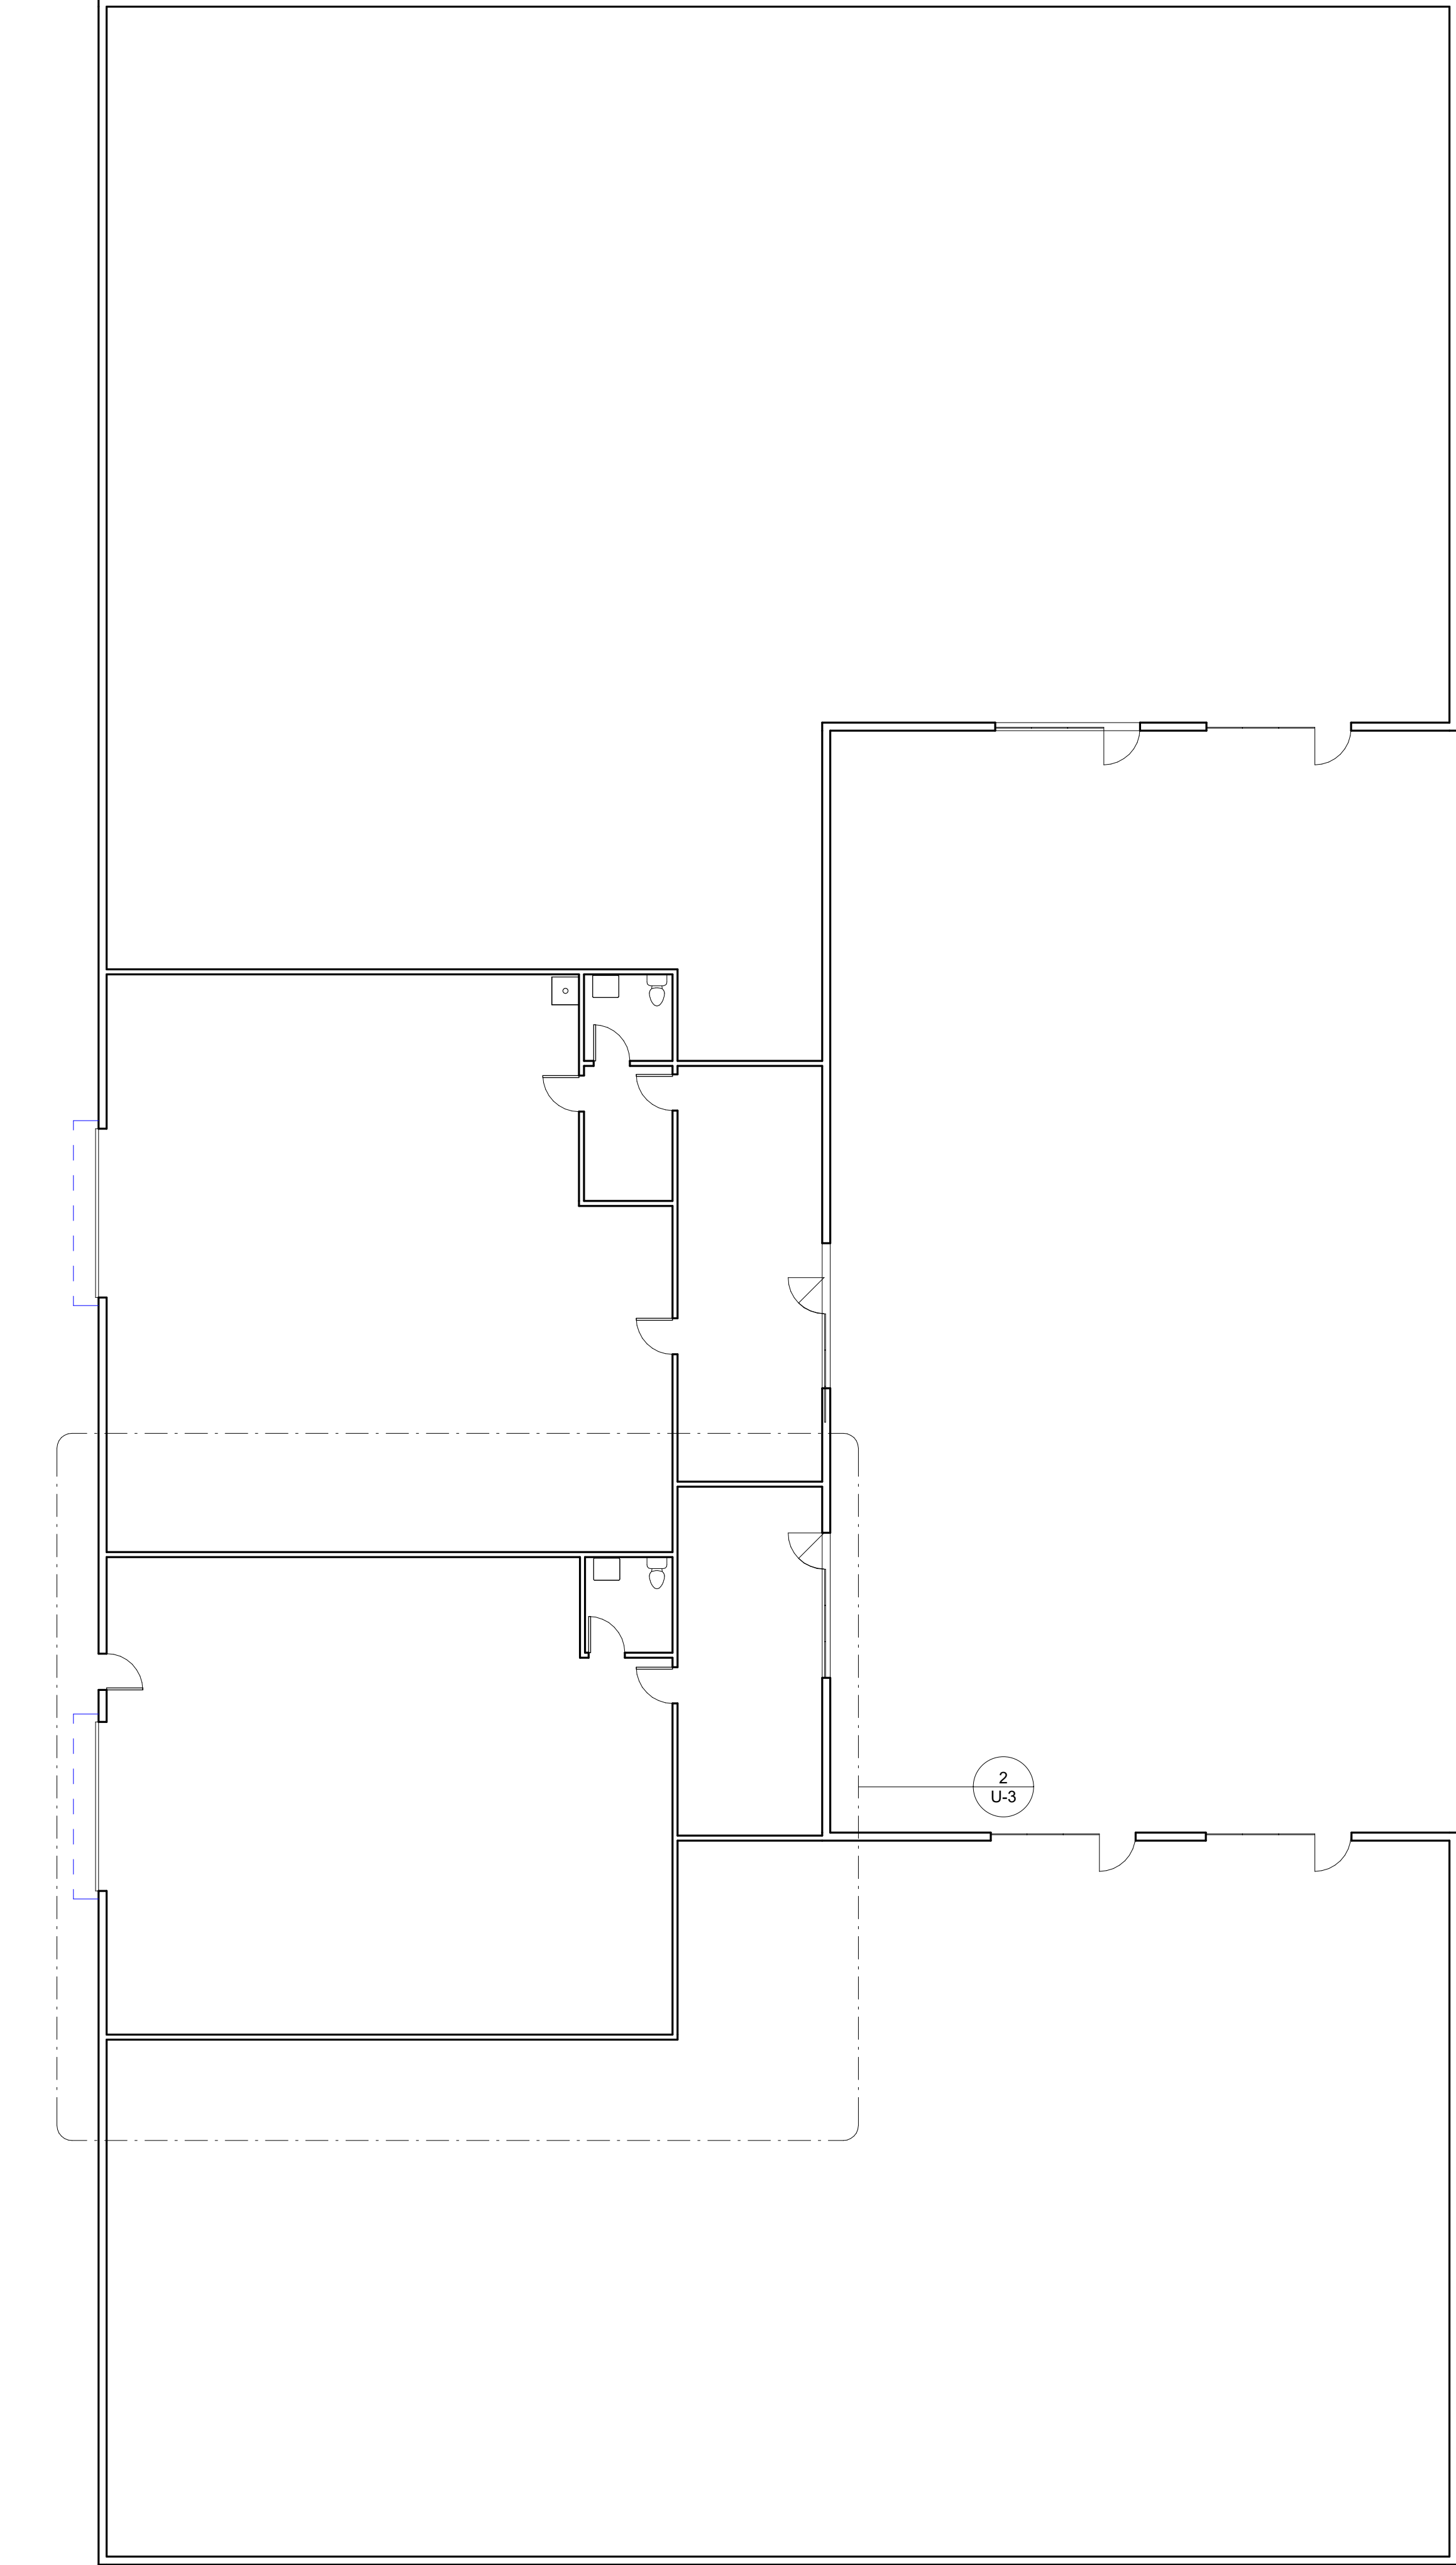

1 OVERALL PLAN
1" = 10'-0"

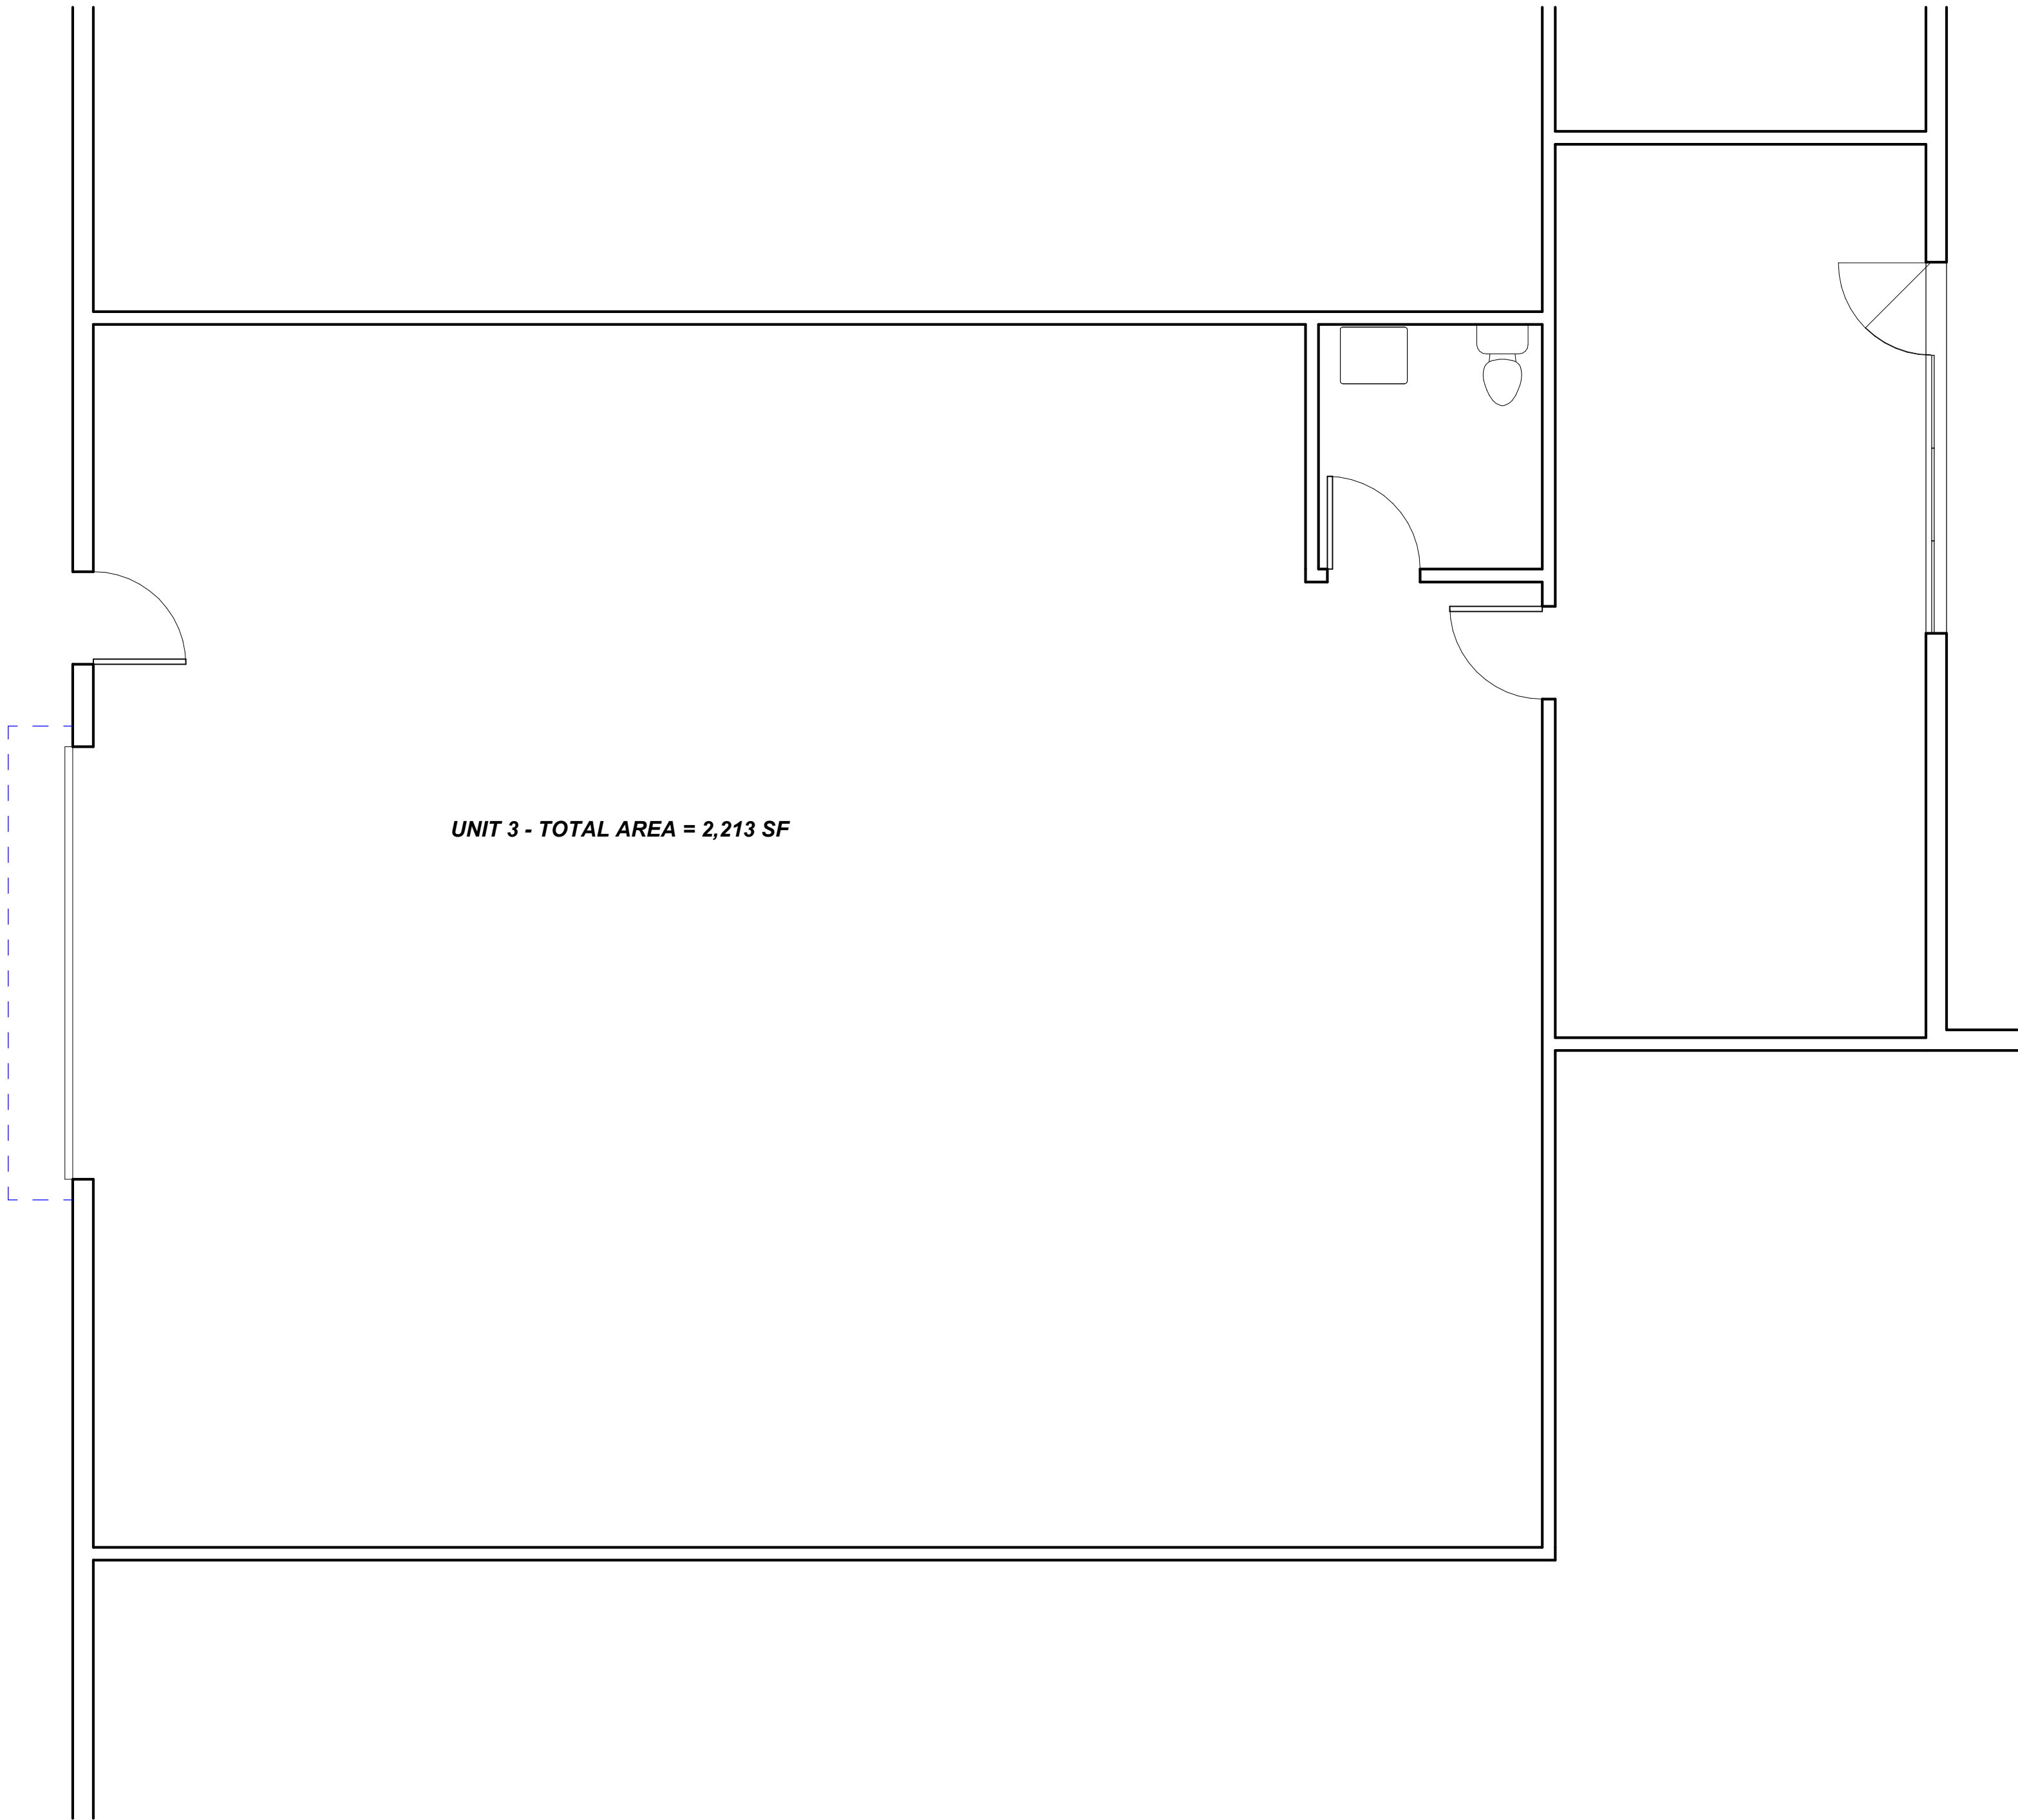

2 UNIT 3 ENLARGED
1/4" = 1'-0"

L&L PLUMBING PLANS: CLIENT-SPECIFIC & CONFIDENTIAL. NO SHARING OR USE BY OTHERS. ALL RIGHTS RESERVED.

LNL PROPERTIES

1155 WATSON WAY
1155 WATSON WAY, SPARKS, NV 89431

UNIT 3 FLOOR PLAN

DRAWING NO.
U-3
Project Number