
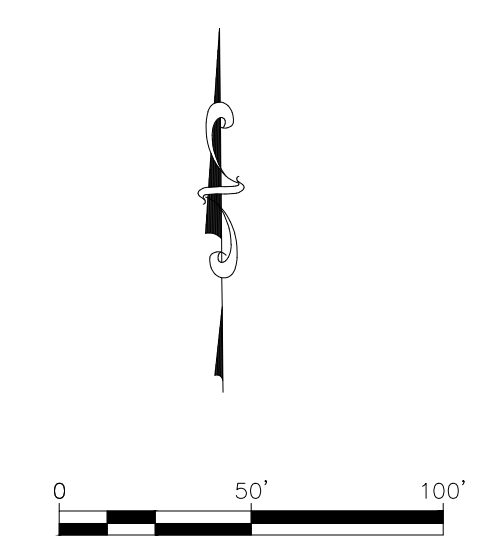


S:\ENGINEERING PROJECTS\10775 - CALIBER COLLISION VICTORIA\03 CAD\DESIGN SET\OVERALL SITE PLAN.DWG Jun. 17, 2022-5:03 PM

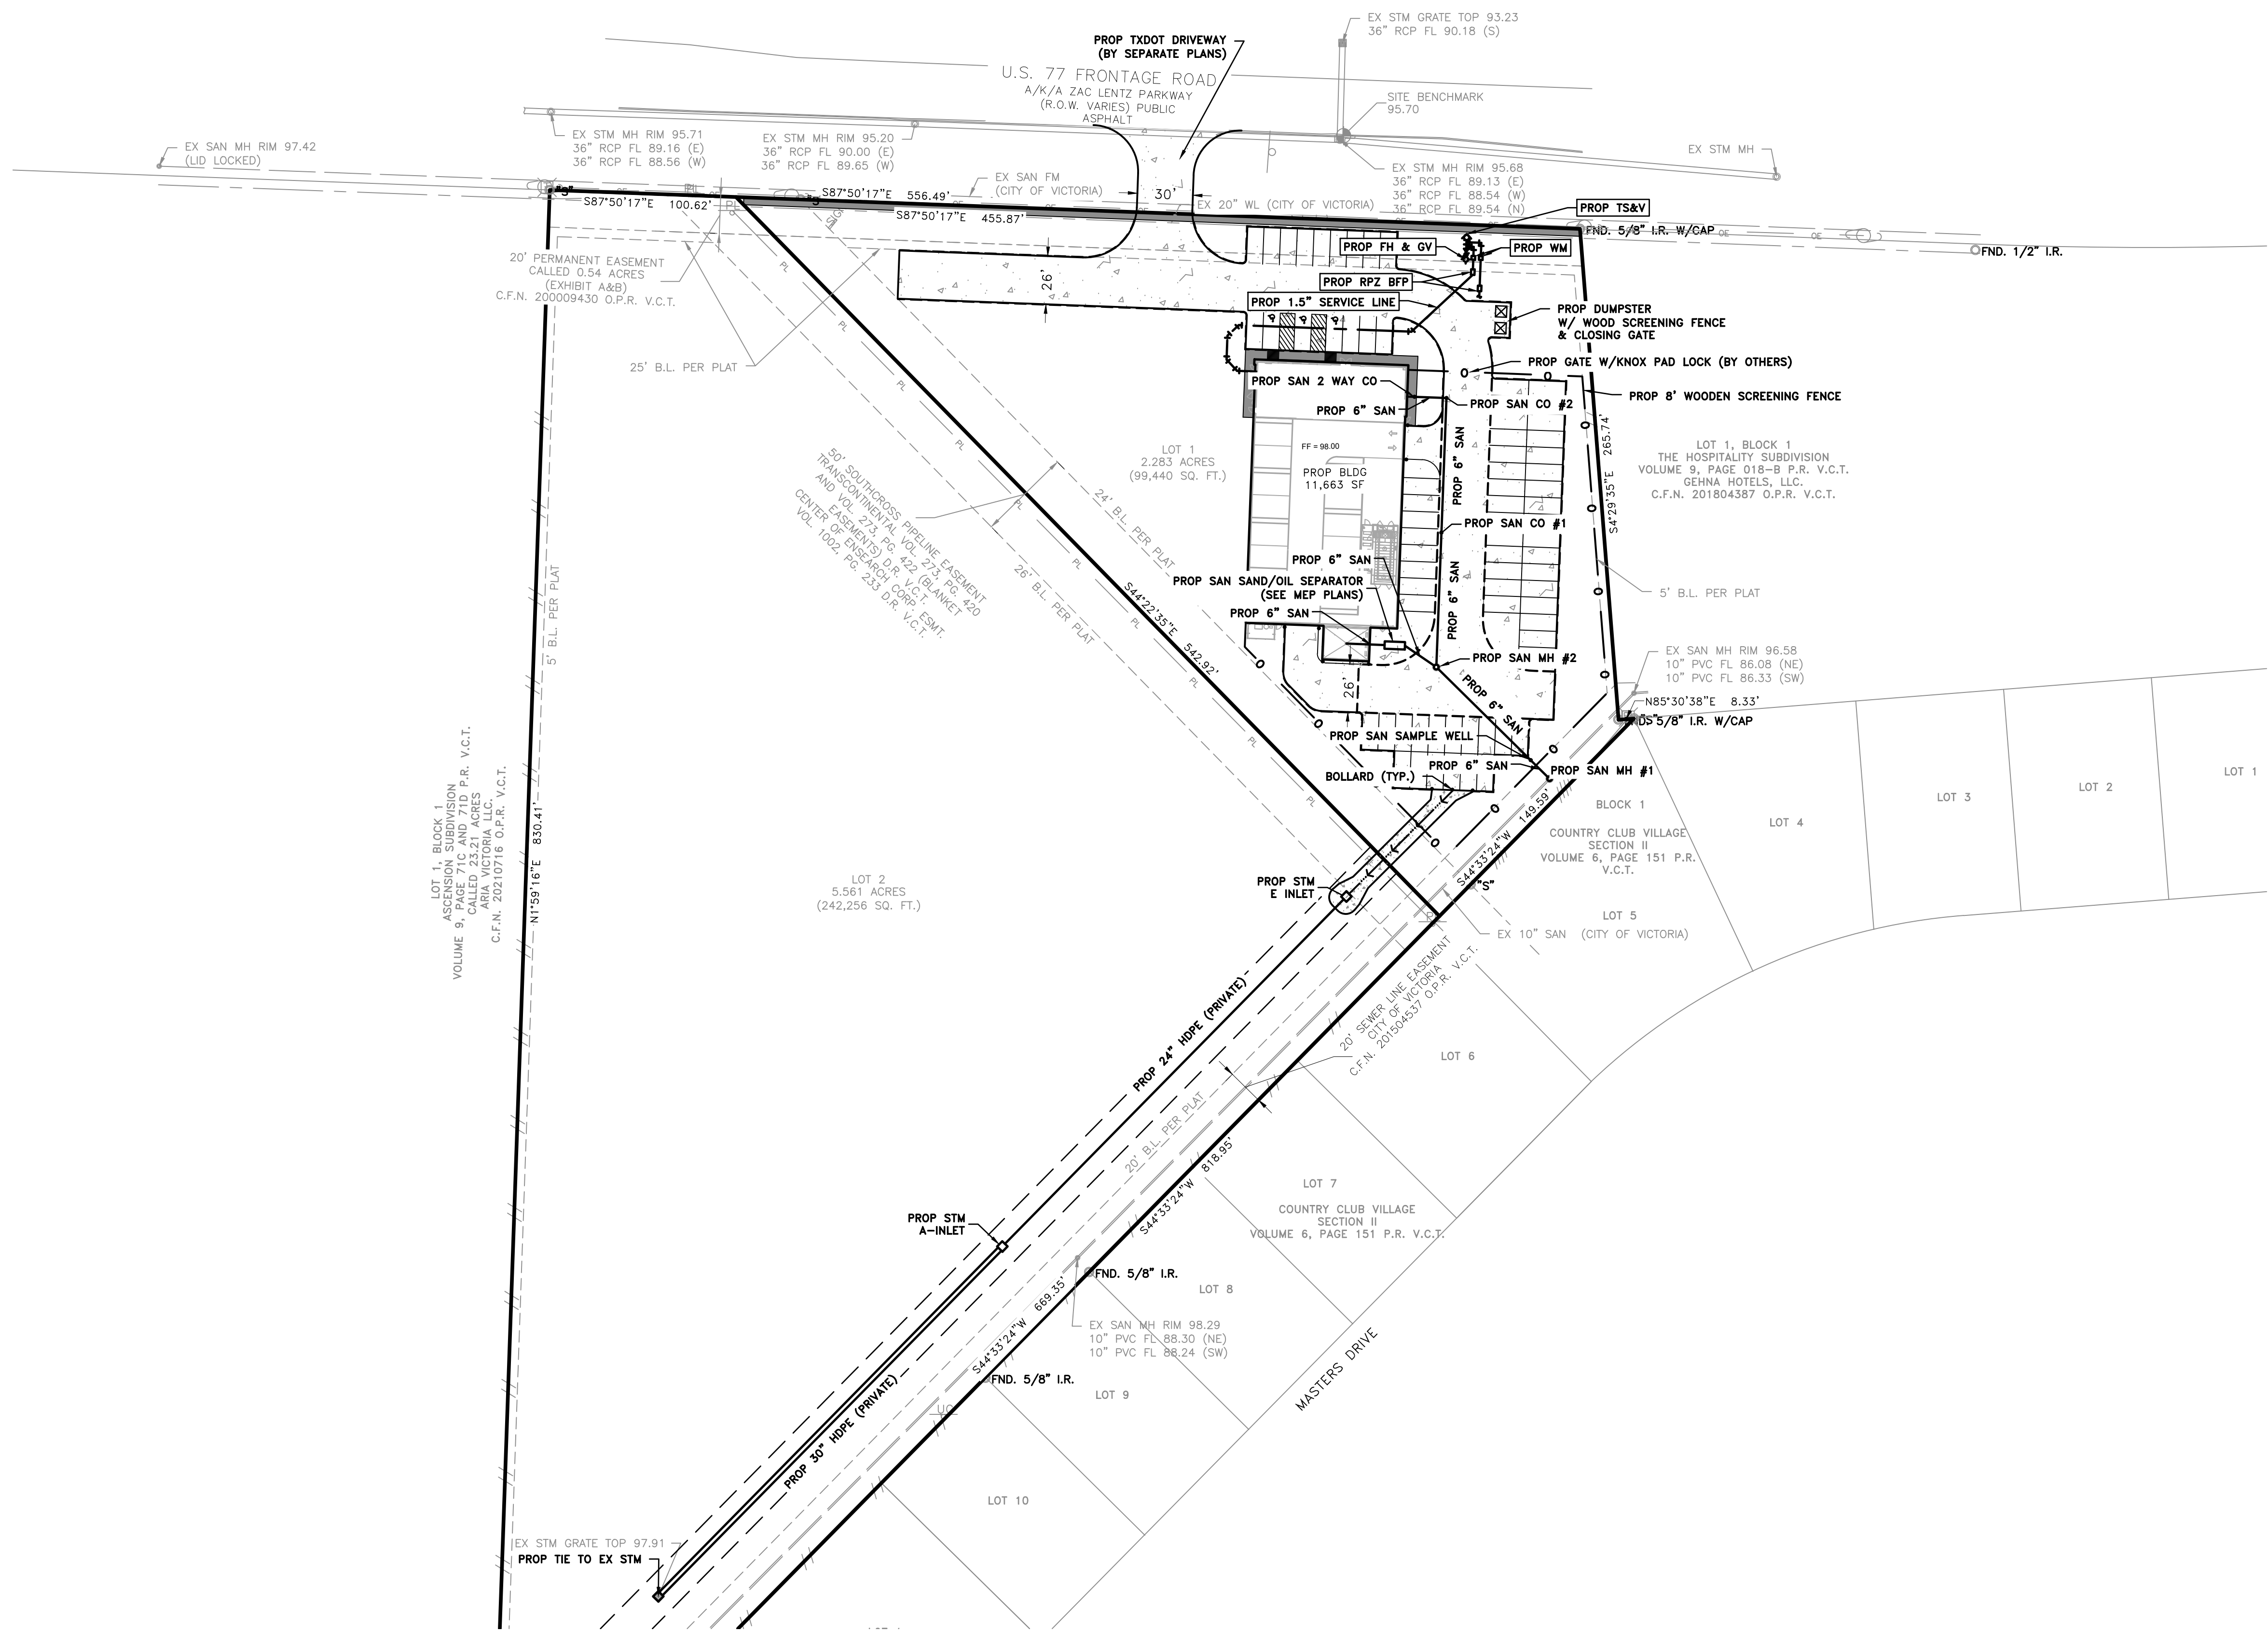

L SQUARED ENGINEERING
MUNICIPAL COMMERCIAL RESIDENTIAL
WWW.L2ENGINEERING.COM
3307 W. DAVIS STREET #1000
CONROE, TEXAS 77384
OFFICE: 936-647-0430
21123 EVA STREET #200
MONTGOMERY, TEXAS 77356

CLIENT INFORMATION
JOE DELL
4336 MARSH RIDGE ROAD
CARROLLTON, TEXAS 75010
PROJECT ADDRESS
8205 NE ZAC LENTZ PKWY
VICTORIA, TX 77904

CALIBER COLLISION VICTORIA

OVERALL SITE PLAN

DRAWING ISSUE			
#	DATE	BY	* COMMENT
1	6/17/22	RHM	FOR PERMIT

LEGEND:
— PL — GAS PIPELINE
• BOLLARD

DRAWING INFORMATION			
PROJECT	10775	TDLR	**
DRAWN	RHM	EIT	ET
SCALE	SHEET		04
1" = 50' (24x36) 1" = 100' (11x17)			

Lesley Reel
6/17/2022

*PLANS NOT RELEASED FOR CONSTRUCTION UNLESS INDICATED ABOVE