


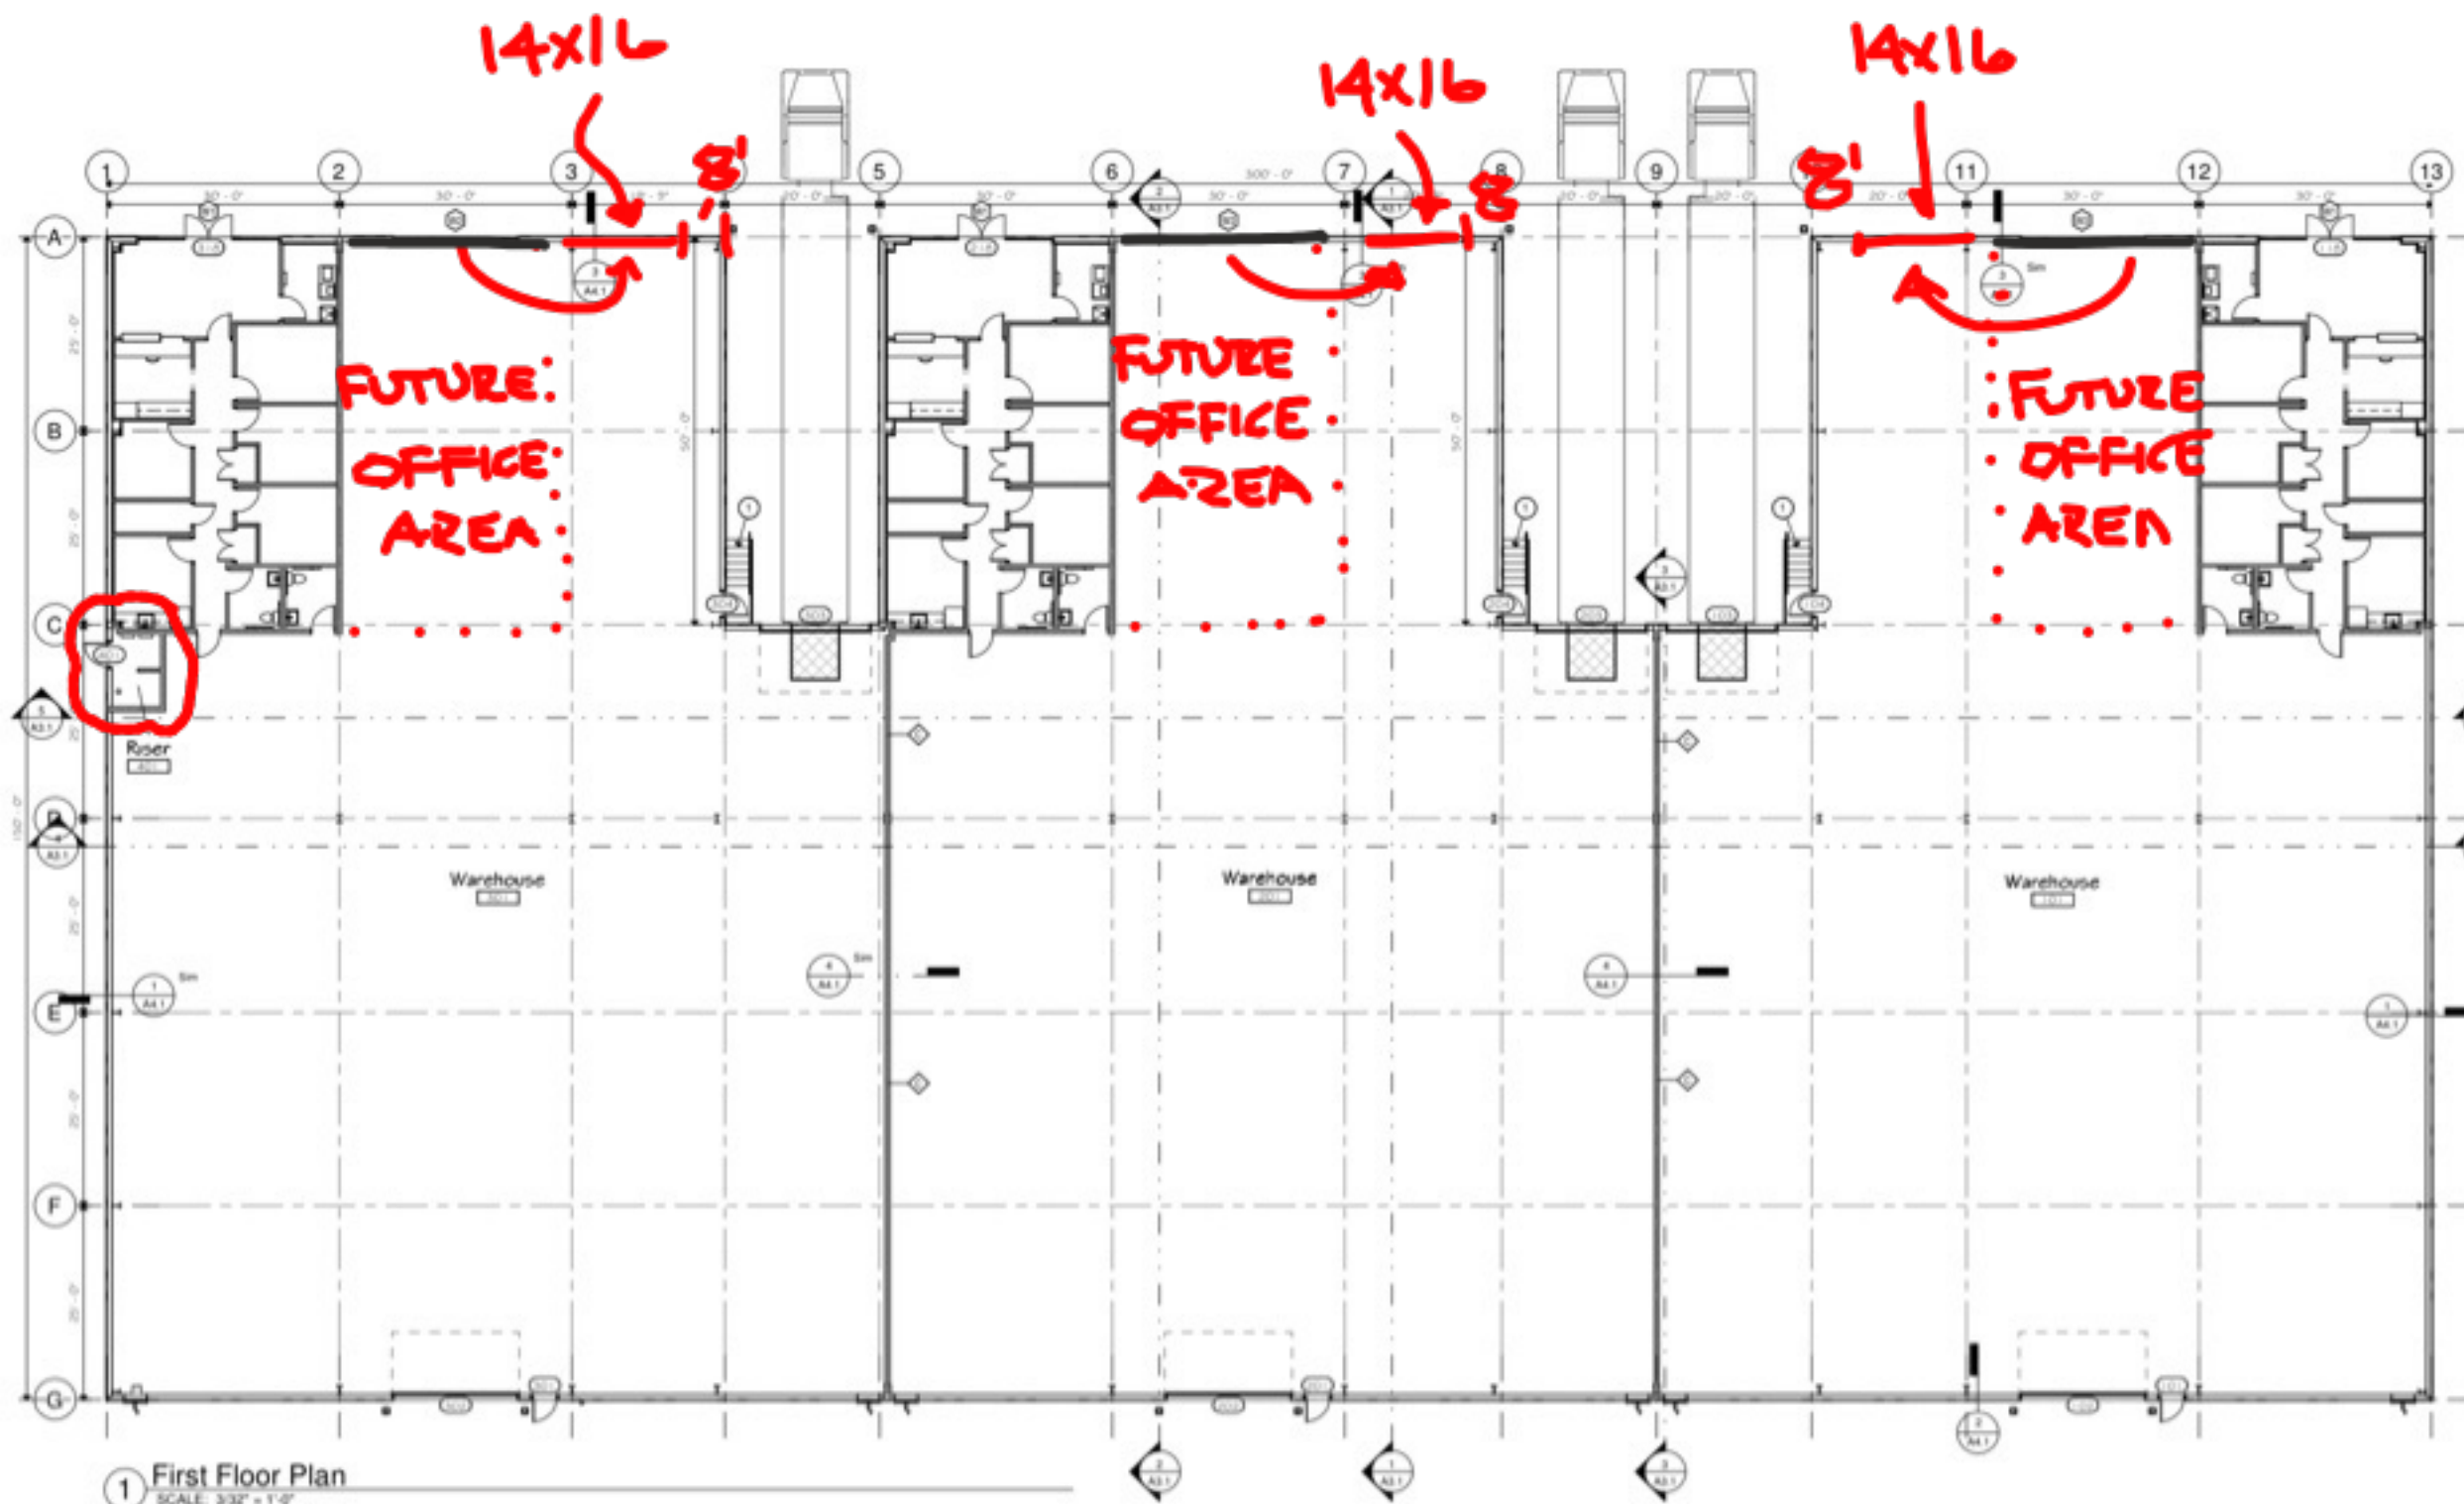

1 First Floor Plan
SCALE: 3/32" = 1'-0"

FLOOR PLAN NOTES

1 Exterior Metal Stair by Specialty Engineer.
Architect shall review shop drawings
provided by Specialty Engineer.

LEGEND

Non-insulated
Insulated w/3" sound
batt insulation
NEW PARTITIONS

PLAN NOTES:

- Dimensions are given from face of stud, exclusive of interior finish, unless noted otherwise.
- Provide blocking at TVs, wall cabinets, and countertops, grab bars, plumbing fixtures & accessories per manf. specifications.
- Provide blocking at Dental Equipment per Manufacturer Specifications.