


Exhibit A – Space Plan

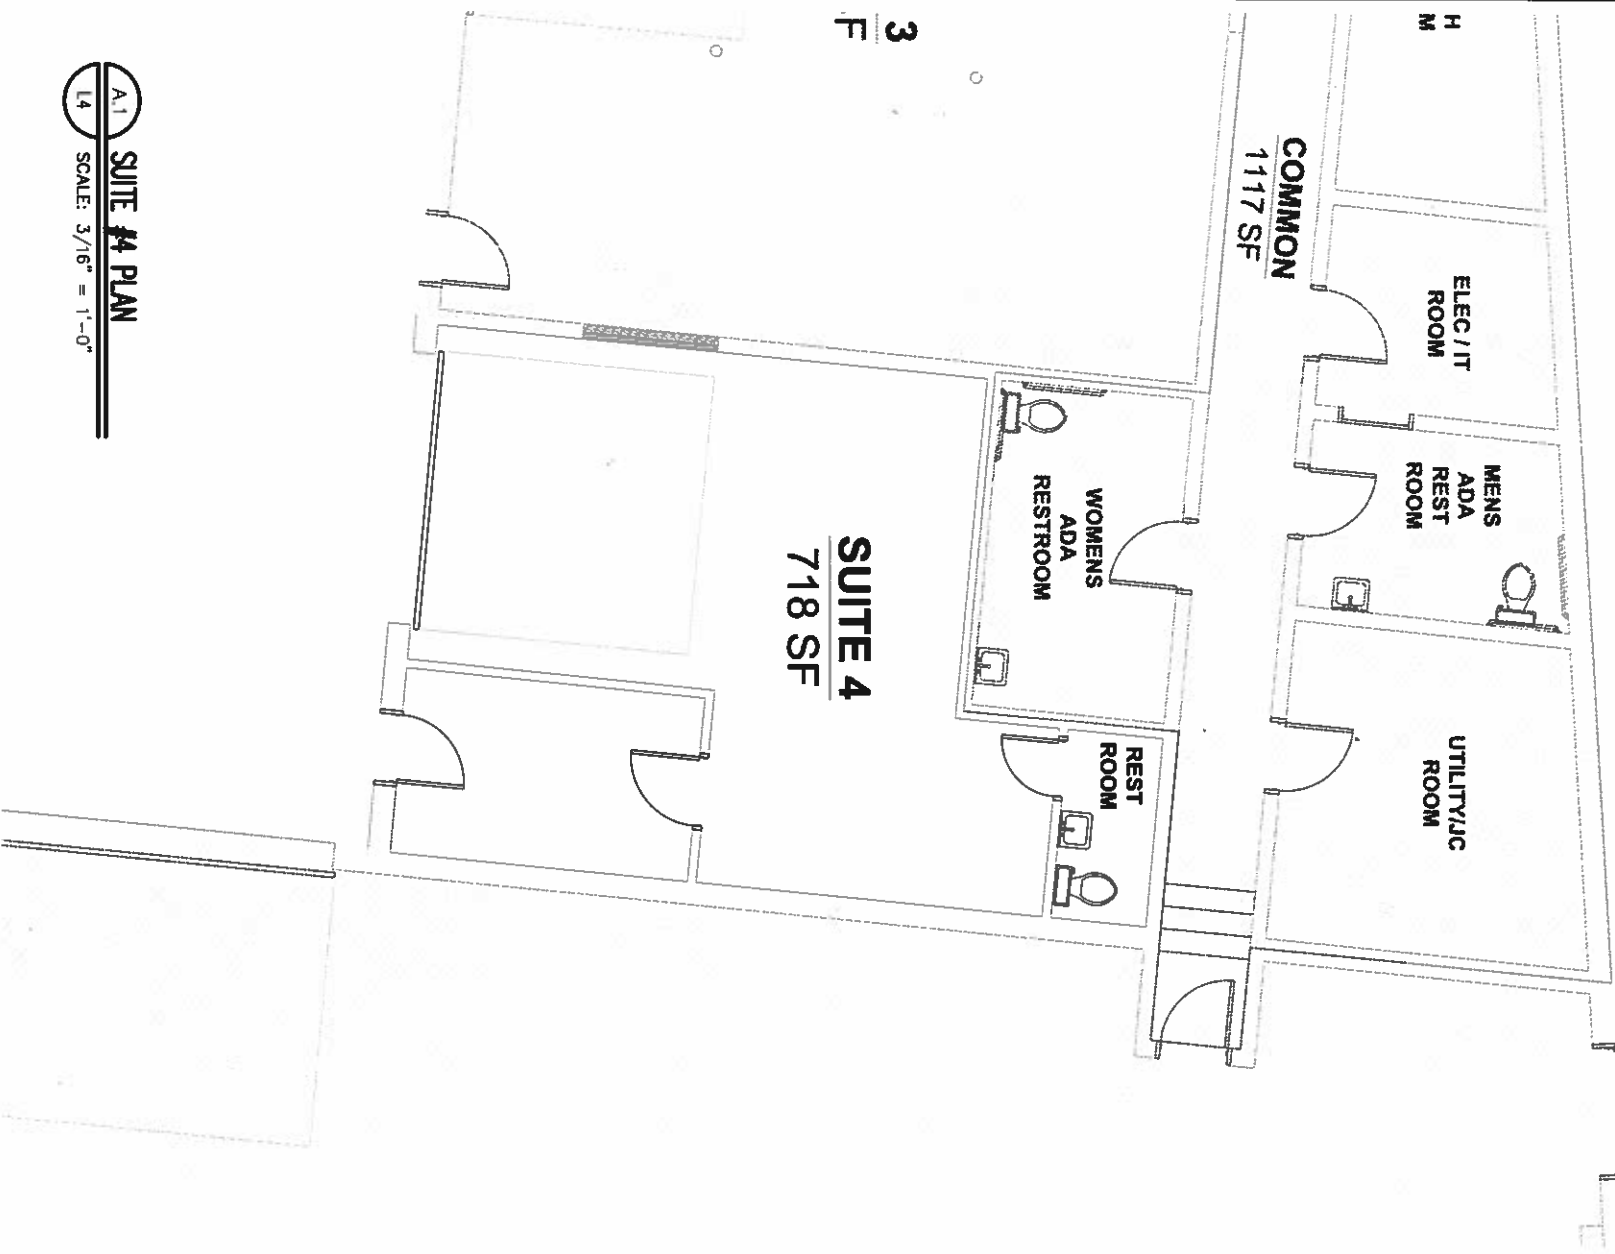

A.1 **SUITE #4 PLAN**
L4 SCALE: 3/16" = 1'-0"

DAY STOKOSA
 ENGINEERING P.C.

3 Van Wyck Lane Suite 2
 Wappingers Falls, New York 12580
 (845)-223-3202

PROJECT
Page Park Associates
 9 W Oakley Street
 City of Poughkeepsie
 Dutchess County, New York

Revised			Suite #4 Floor Plan	
DATE	AS NOTED	DESIGNED BY	GPL	DRAWING NO.
12-20-21		BJS		L4