

Plan Review and Professional Certification Disclaimer

IMPORTANT NOTICE TO PURCHASER

These plans are provided as conceptual construction documents intended for informational and preliminary construction purposes only. Building codes, zoning regulations, energy requirements, wind-load criteria, snow-load criteria, seismic requirements, floodplain regulations, and permitting requirements vary by jurisdiction.

Prior to construction, the purchaser is solely responsible for retaining a licensed architect and/or professional engineer, as required by the local authority having jurisdiction, to:

1. Review all plans, drawings, specifications, and details.
2. Verify compliance with all applicable local, state, provincial, and federal building codes and regulations.
3. Modify the plans as necessary to meet site-specific conditions and local code requirements.
4. Provide any required professional seals, stamps, calculations, certifications, or engineering documents required for permitting and construction.
5. Verify structural adequacy for the specific building site, including but not limited to soil conditions, wind loads, snow loads, seismic requirements, flood hazards, and foundation design.

The seller, designer, and copyright holder make no representation or warranty that these plans comply with the building codes, zoning ordinances, permitting requirements, or engineering standards of any particular jurisdiction.

Purchaser acknowledges that construction shall not commence until all required reviews, modifications, approvals, permits, and professional certifications have been obtained.

The purchaser assumes all responsibility for the use of these plans and for compliance with all applicable laws, regulations, codes, and permitting requirements.

By purchasing, downloading, or using these plans, the purchaser agrees to release and hold harmless the seller, designer, and copyright holder from any claims, damages, losses, liabilities, costs, or expenses arising from the use of these plans.

COPYRIGHT INFORMATION

© 2026 SAND EQUITIES, LLC. ALL RIGHTS RESERVED.

THE TINY DUPLEX™ – These plans and drawings are the exclusive property of Sand Equities, LLC and are protected by U.S. Copyright Law. The purchase of these plans grants the purchaser a **limited, non-transferable license to construct one (1) dwelling** from these plans. No reproduction, modification, distribution, resale, transfer, sharing, or construction of additional dwellings is permitted without the prior written consent of Sand Equities, LLC. Ownership of the plans and all intellectual property rights remain exclusively with Sand Equities, LLC. Unauthorized use is subject to legal action. **Each additional dwelling constructed from these plans requires the purchase of an additional license from Sand Equities, LLC.**


© 2026 SAND EQUITIES, L.L.C. ALL RIGHTS RESERVED.

THE TINY DUPLEX™ – These plans and drawings are the exclusive property of Sand Equities, L.L.C. and are protected by Copyright Law. The purchase of these plans grants the purchaser a limited, non-transferable license to construct one (1) dwelling from these plans. No reproduction, modification, distribution, resale, rental, sharing, or construction of additional dwellings is permitted without the prior written consent of Sand Equities, L.L.C. Ownership of the plans and all intellectual property rights remain exclusively with Sand Equities, L.L.C. Uninstructed use is strictly prohibited. Each additional dwelling constructed from these plans requires the purchase of an additional license from Sand Equities, L.L.C.

5/27/2026 9:26:12 AM

FOR REFERENCE ONLY, VERIFY WITH
SCHEDULES IF AVAILABLE

FOR REFERENCE ONLY, VERIFY WITH
SCHEDULES IF AVAILABLE


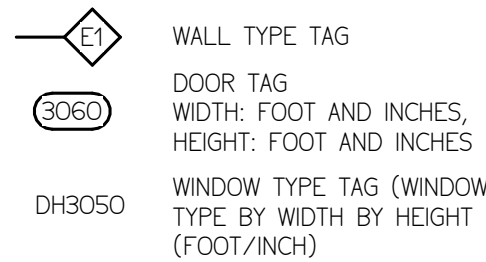


ROOM NAME
SQUARE FOOTAGE


ROOM NAME
SQUARE FOOTAGE

TAKEN FROM FACE OF


TAKEN FROM FACE OF

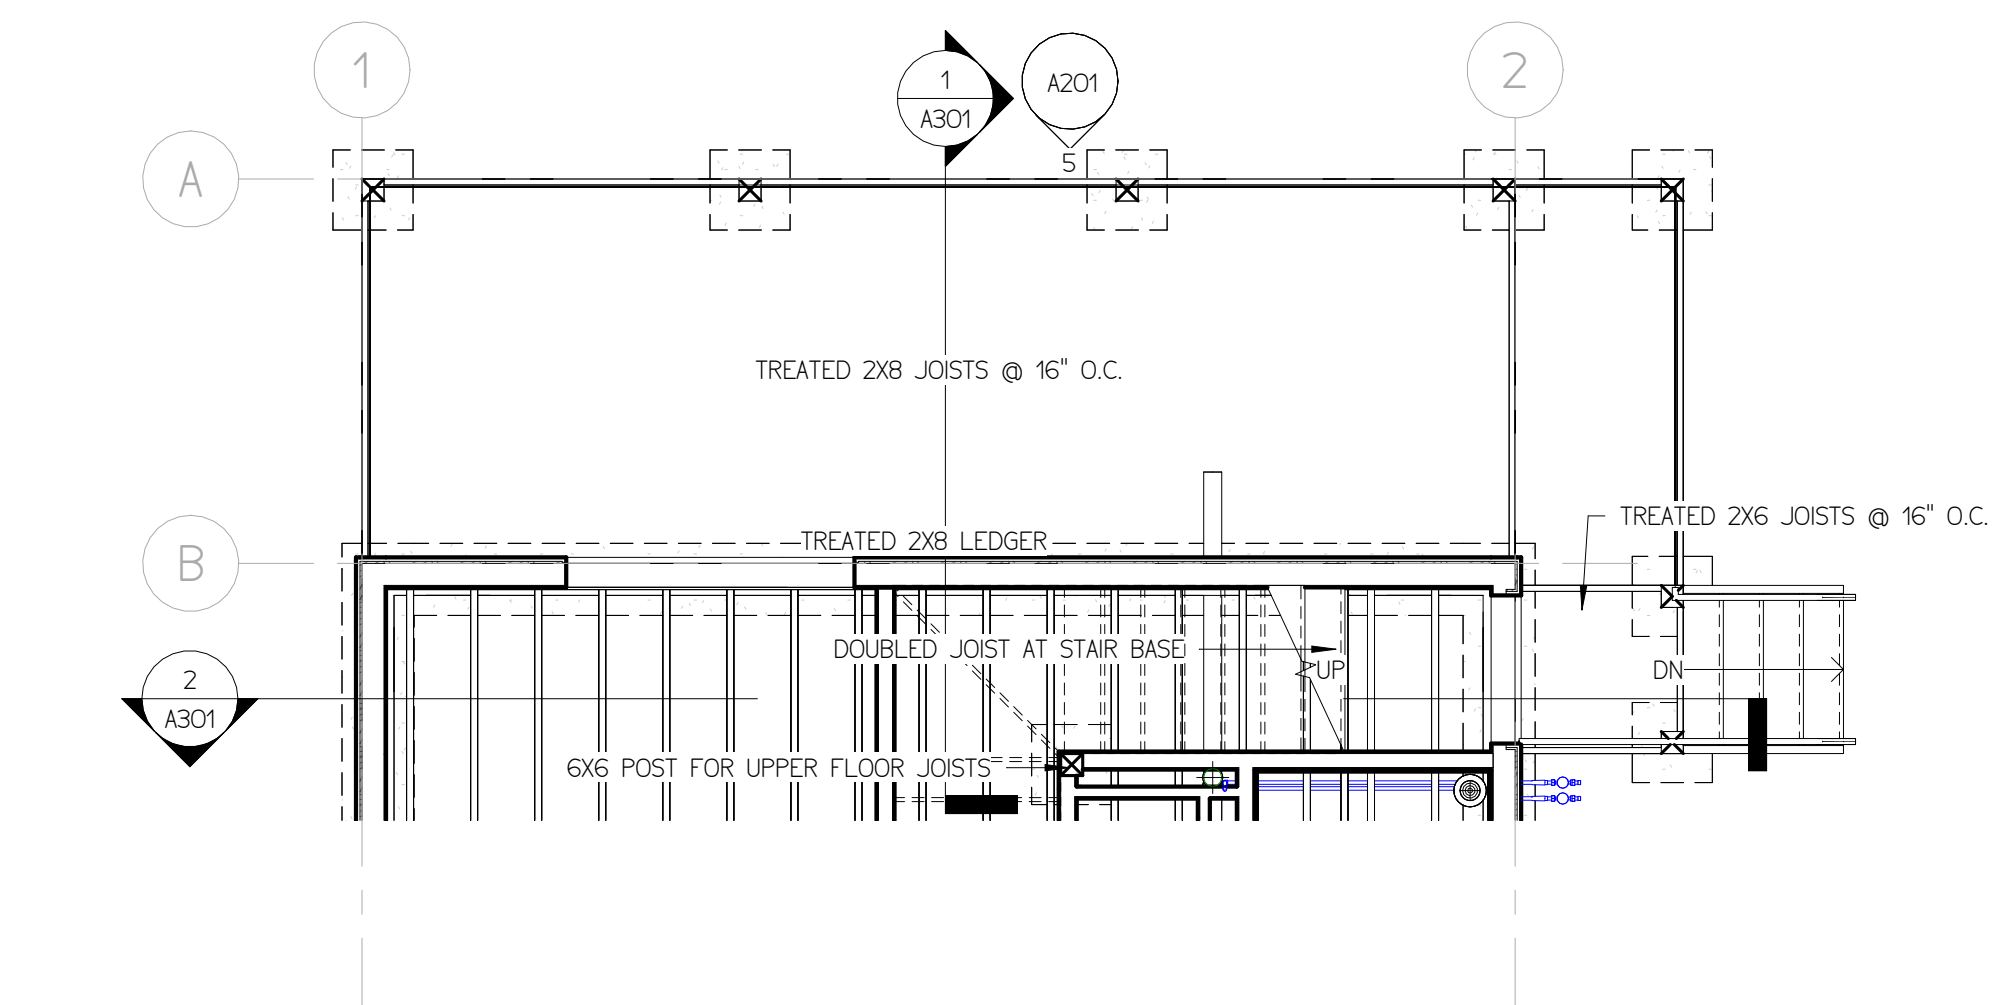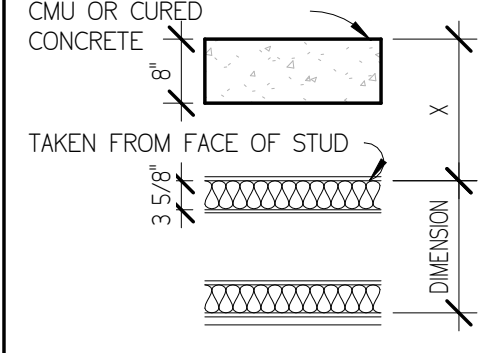


⑤ LOWER FLOOR FRAMING OPTION 2
1/4" = 1'-0"

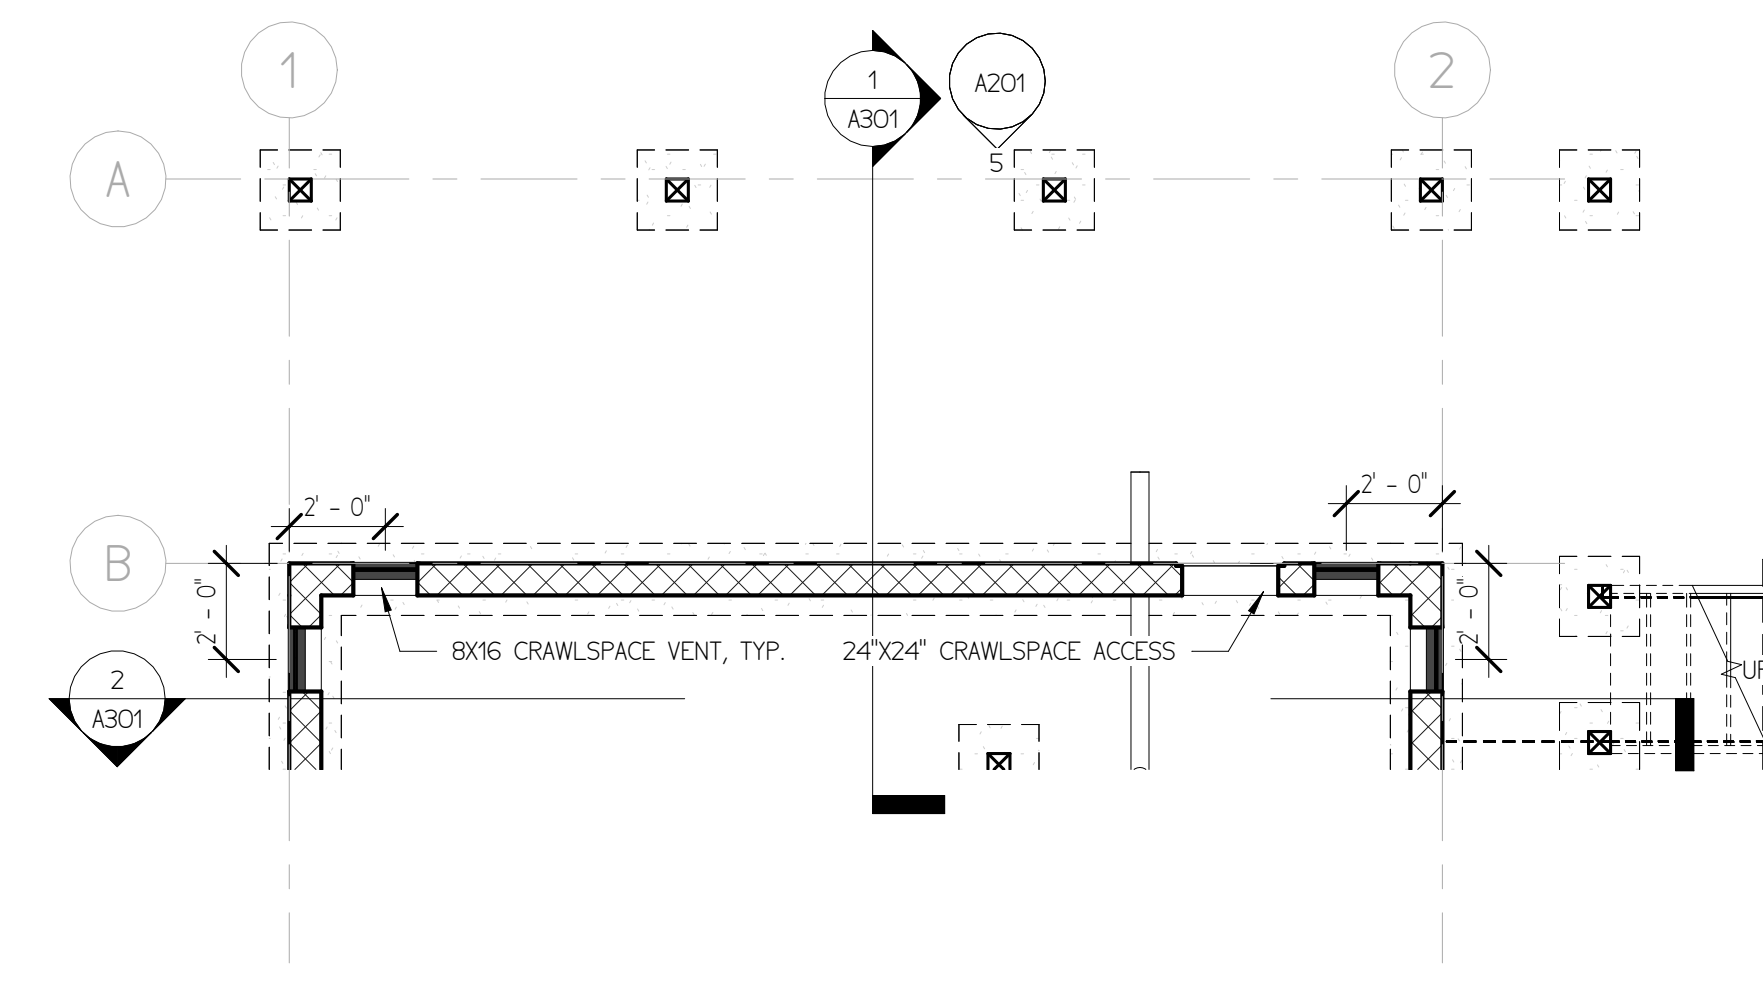


① FOUNDATION OPTION 2
1/4" = 1'-0"

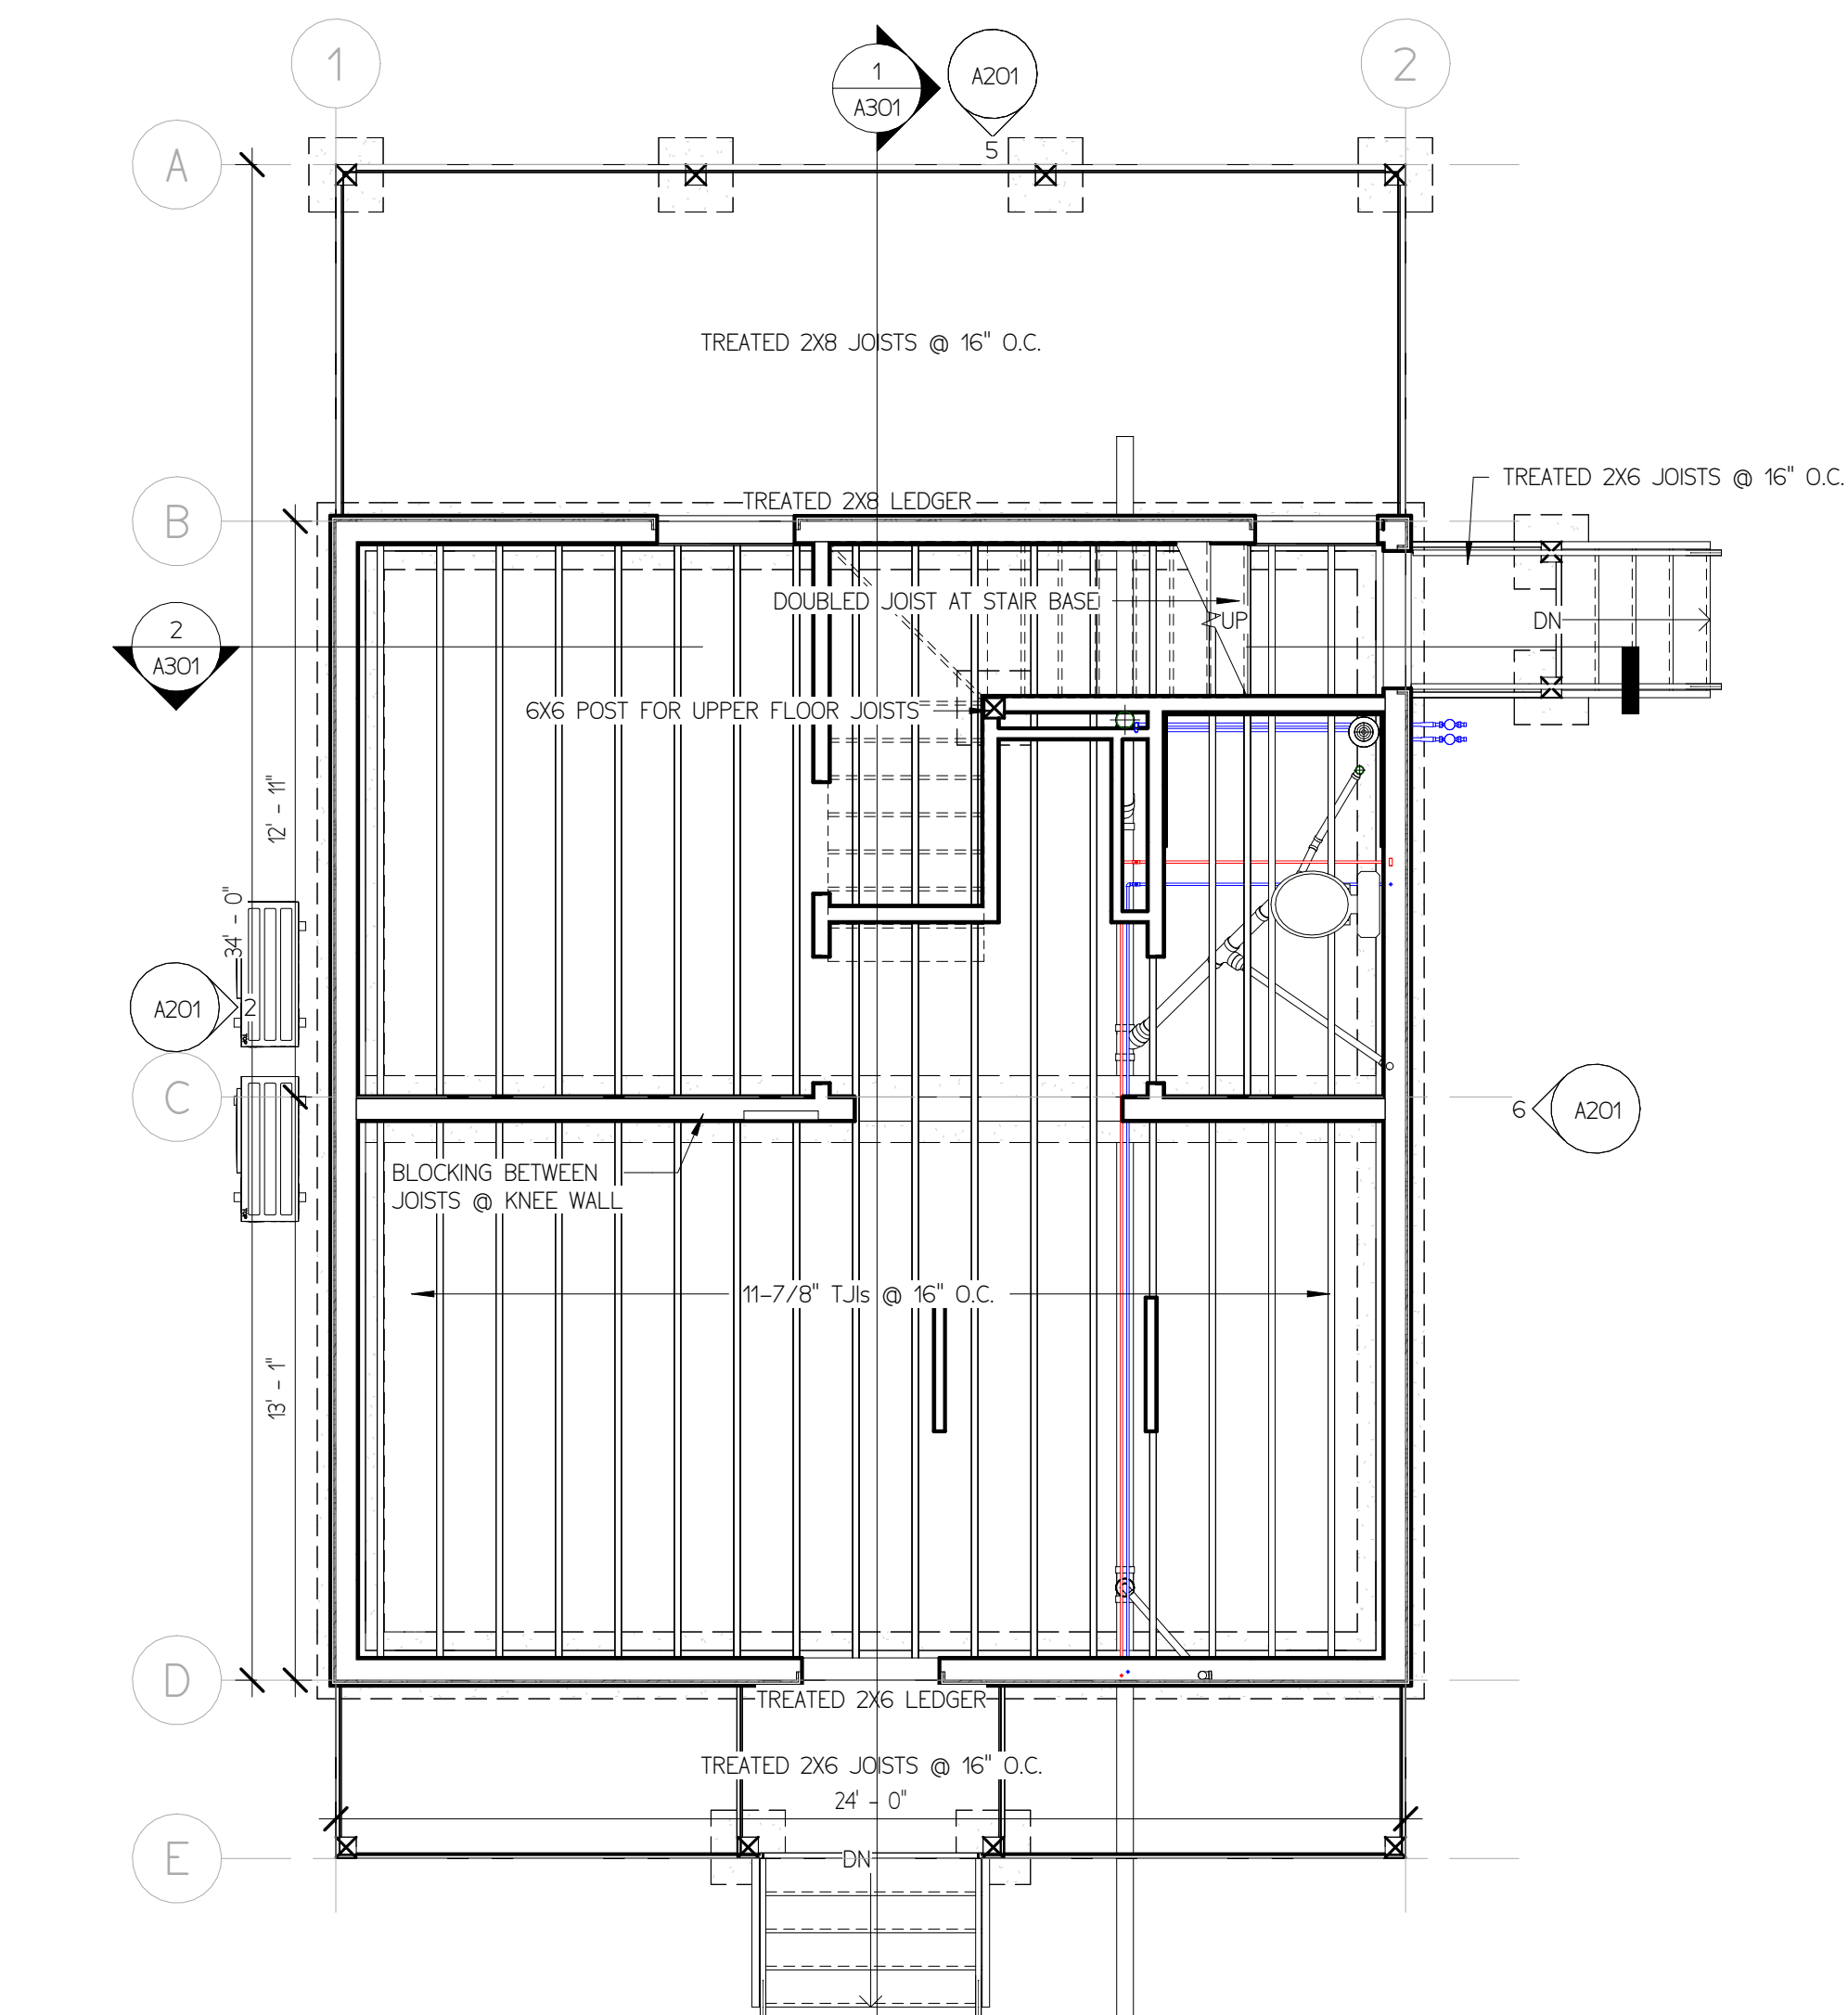

③ LOWER FLOOR FRAMING
1/4" = 1'-0"

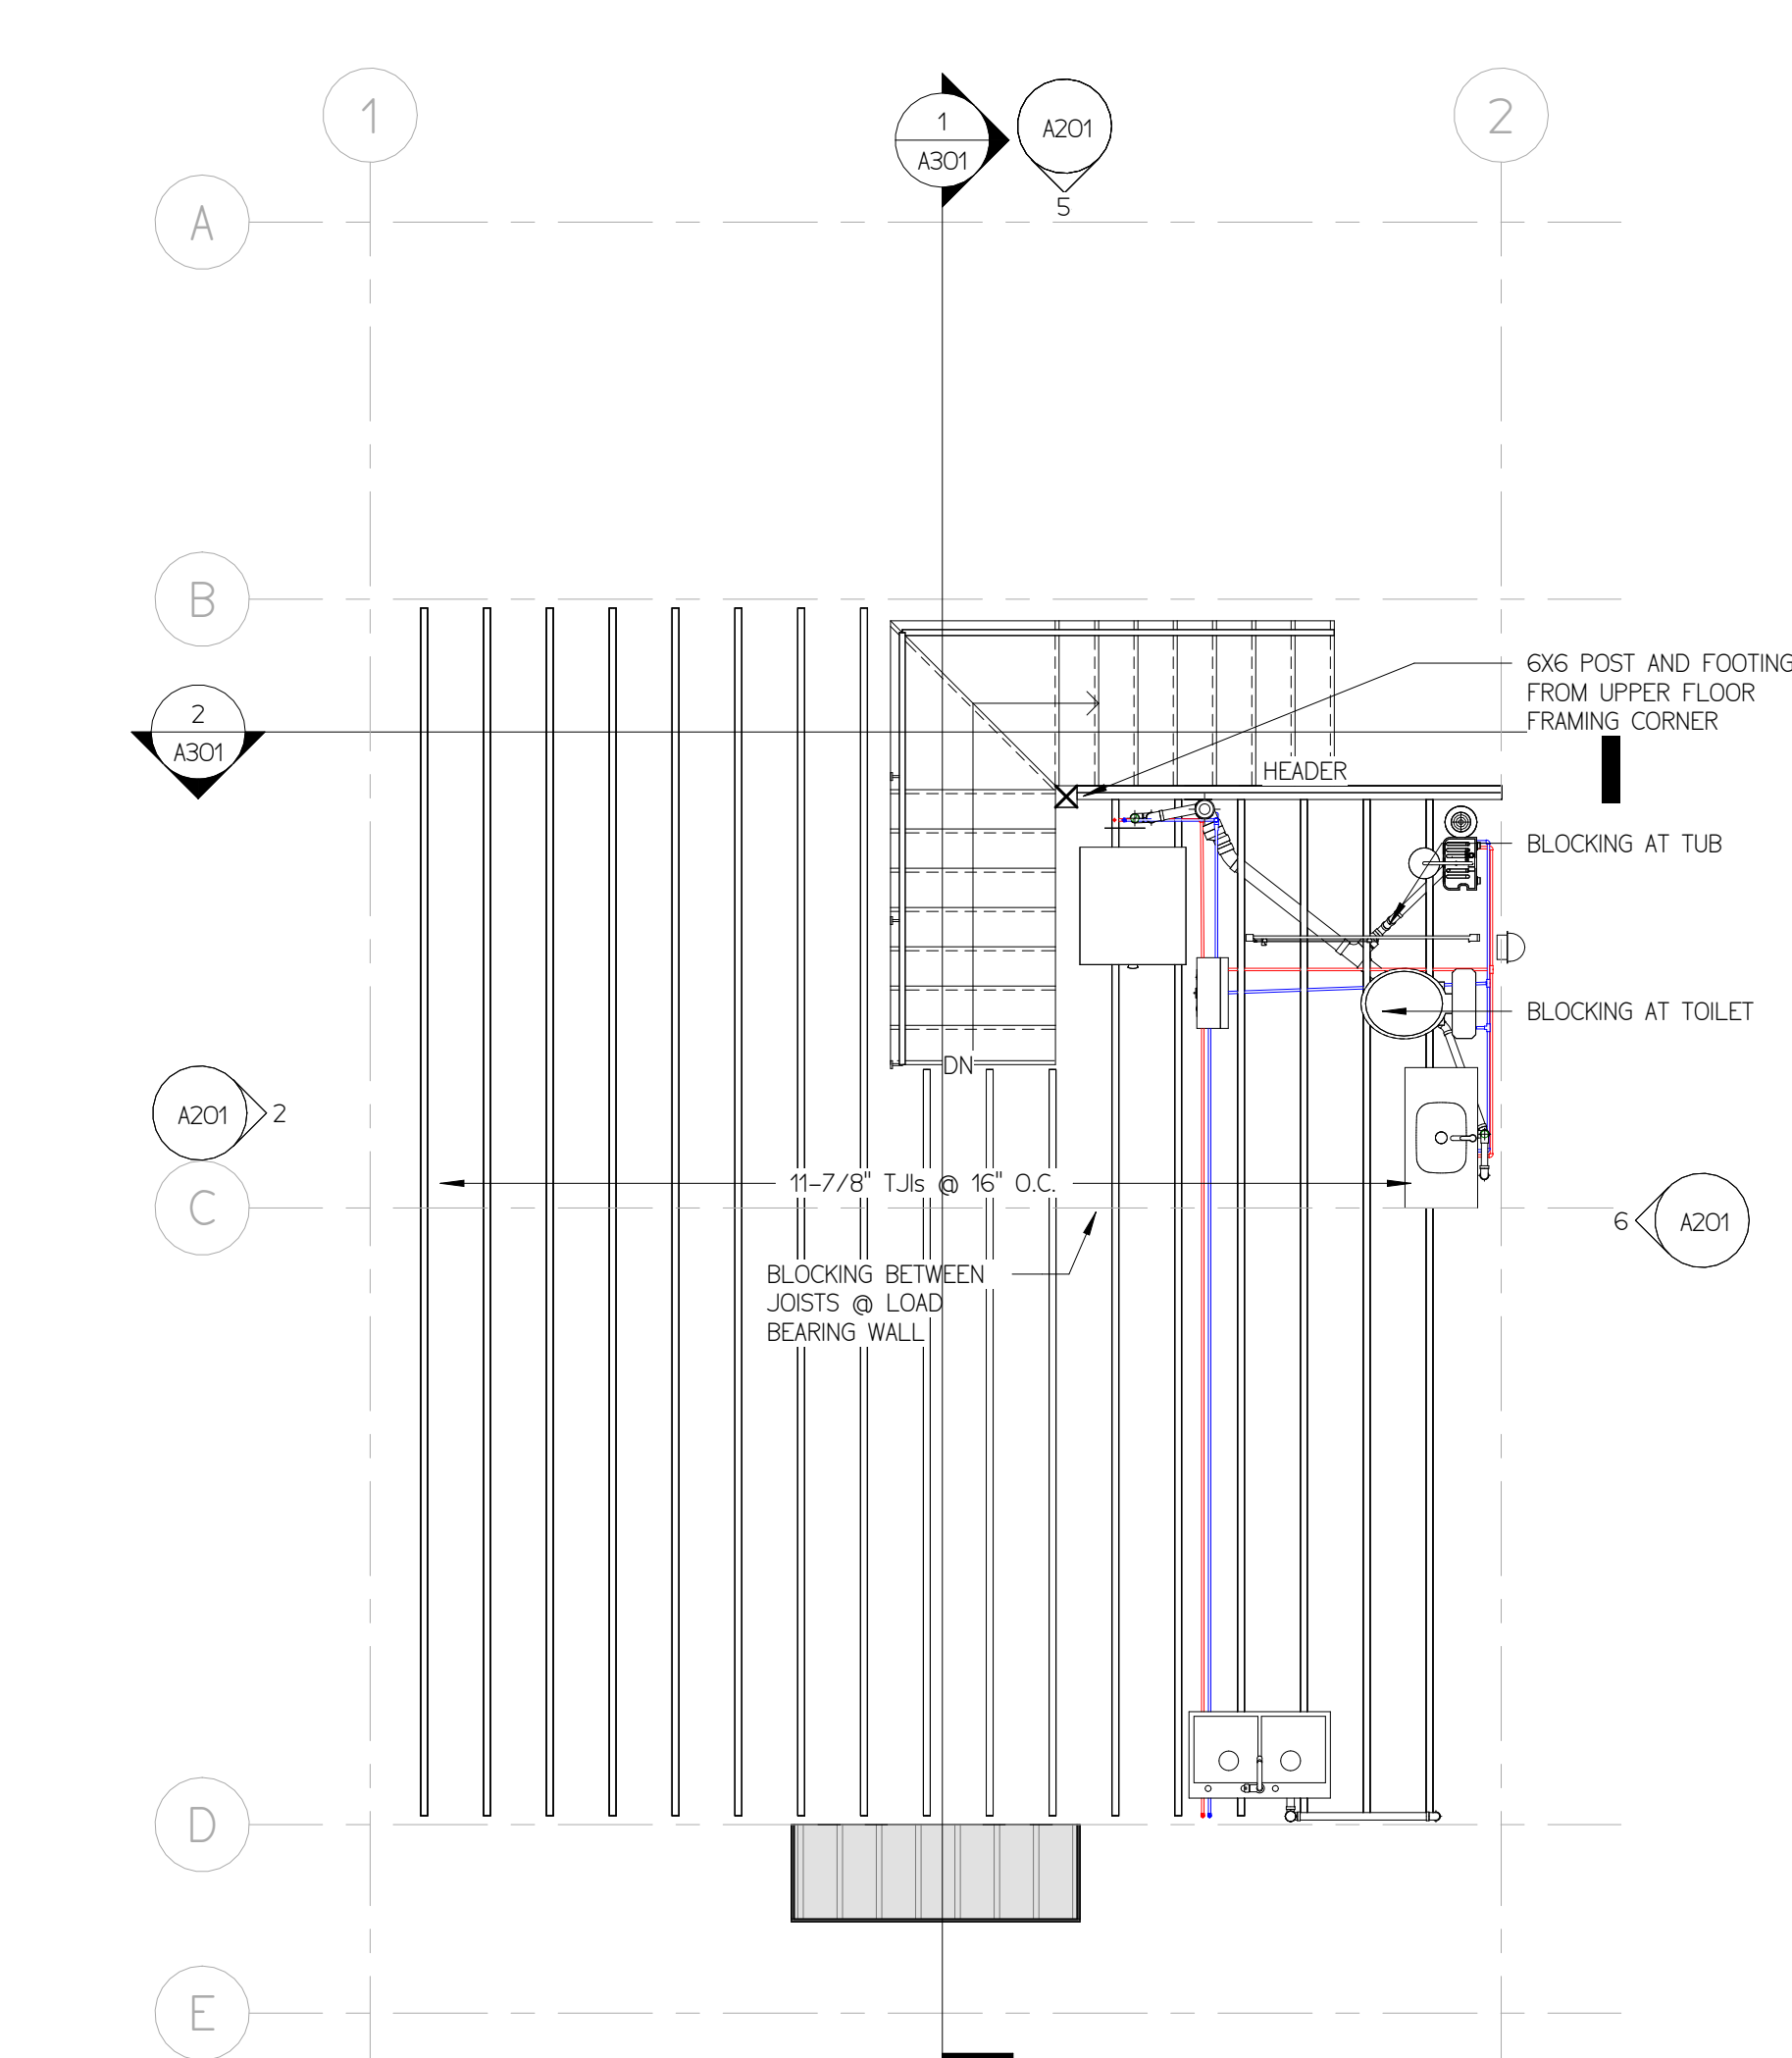

④ UPPER FLOOR FRAMING
1/4" = 1'-0"

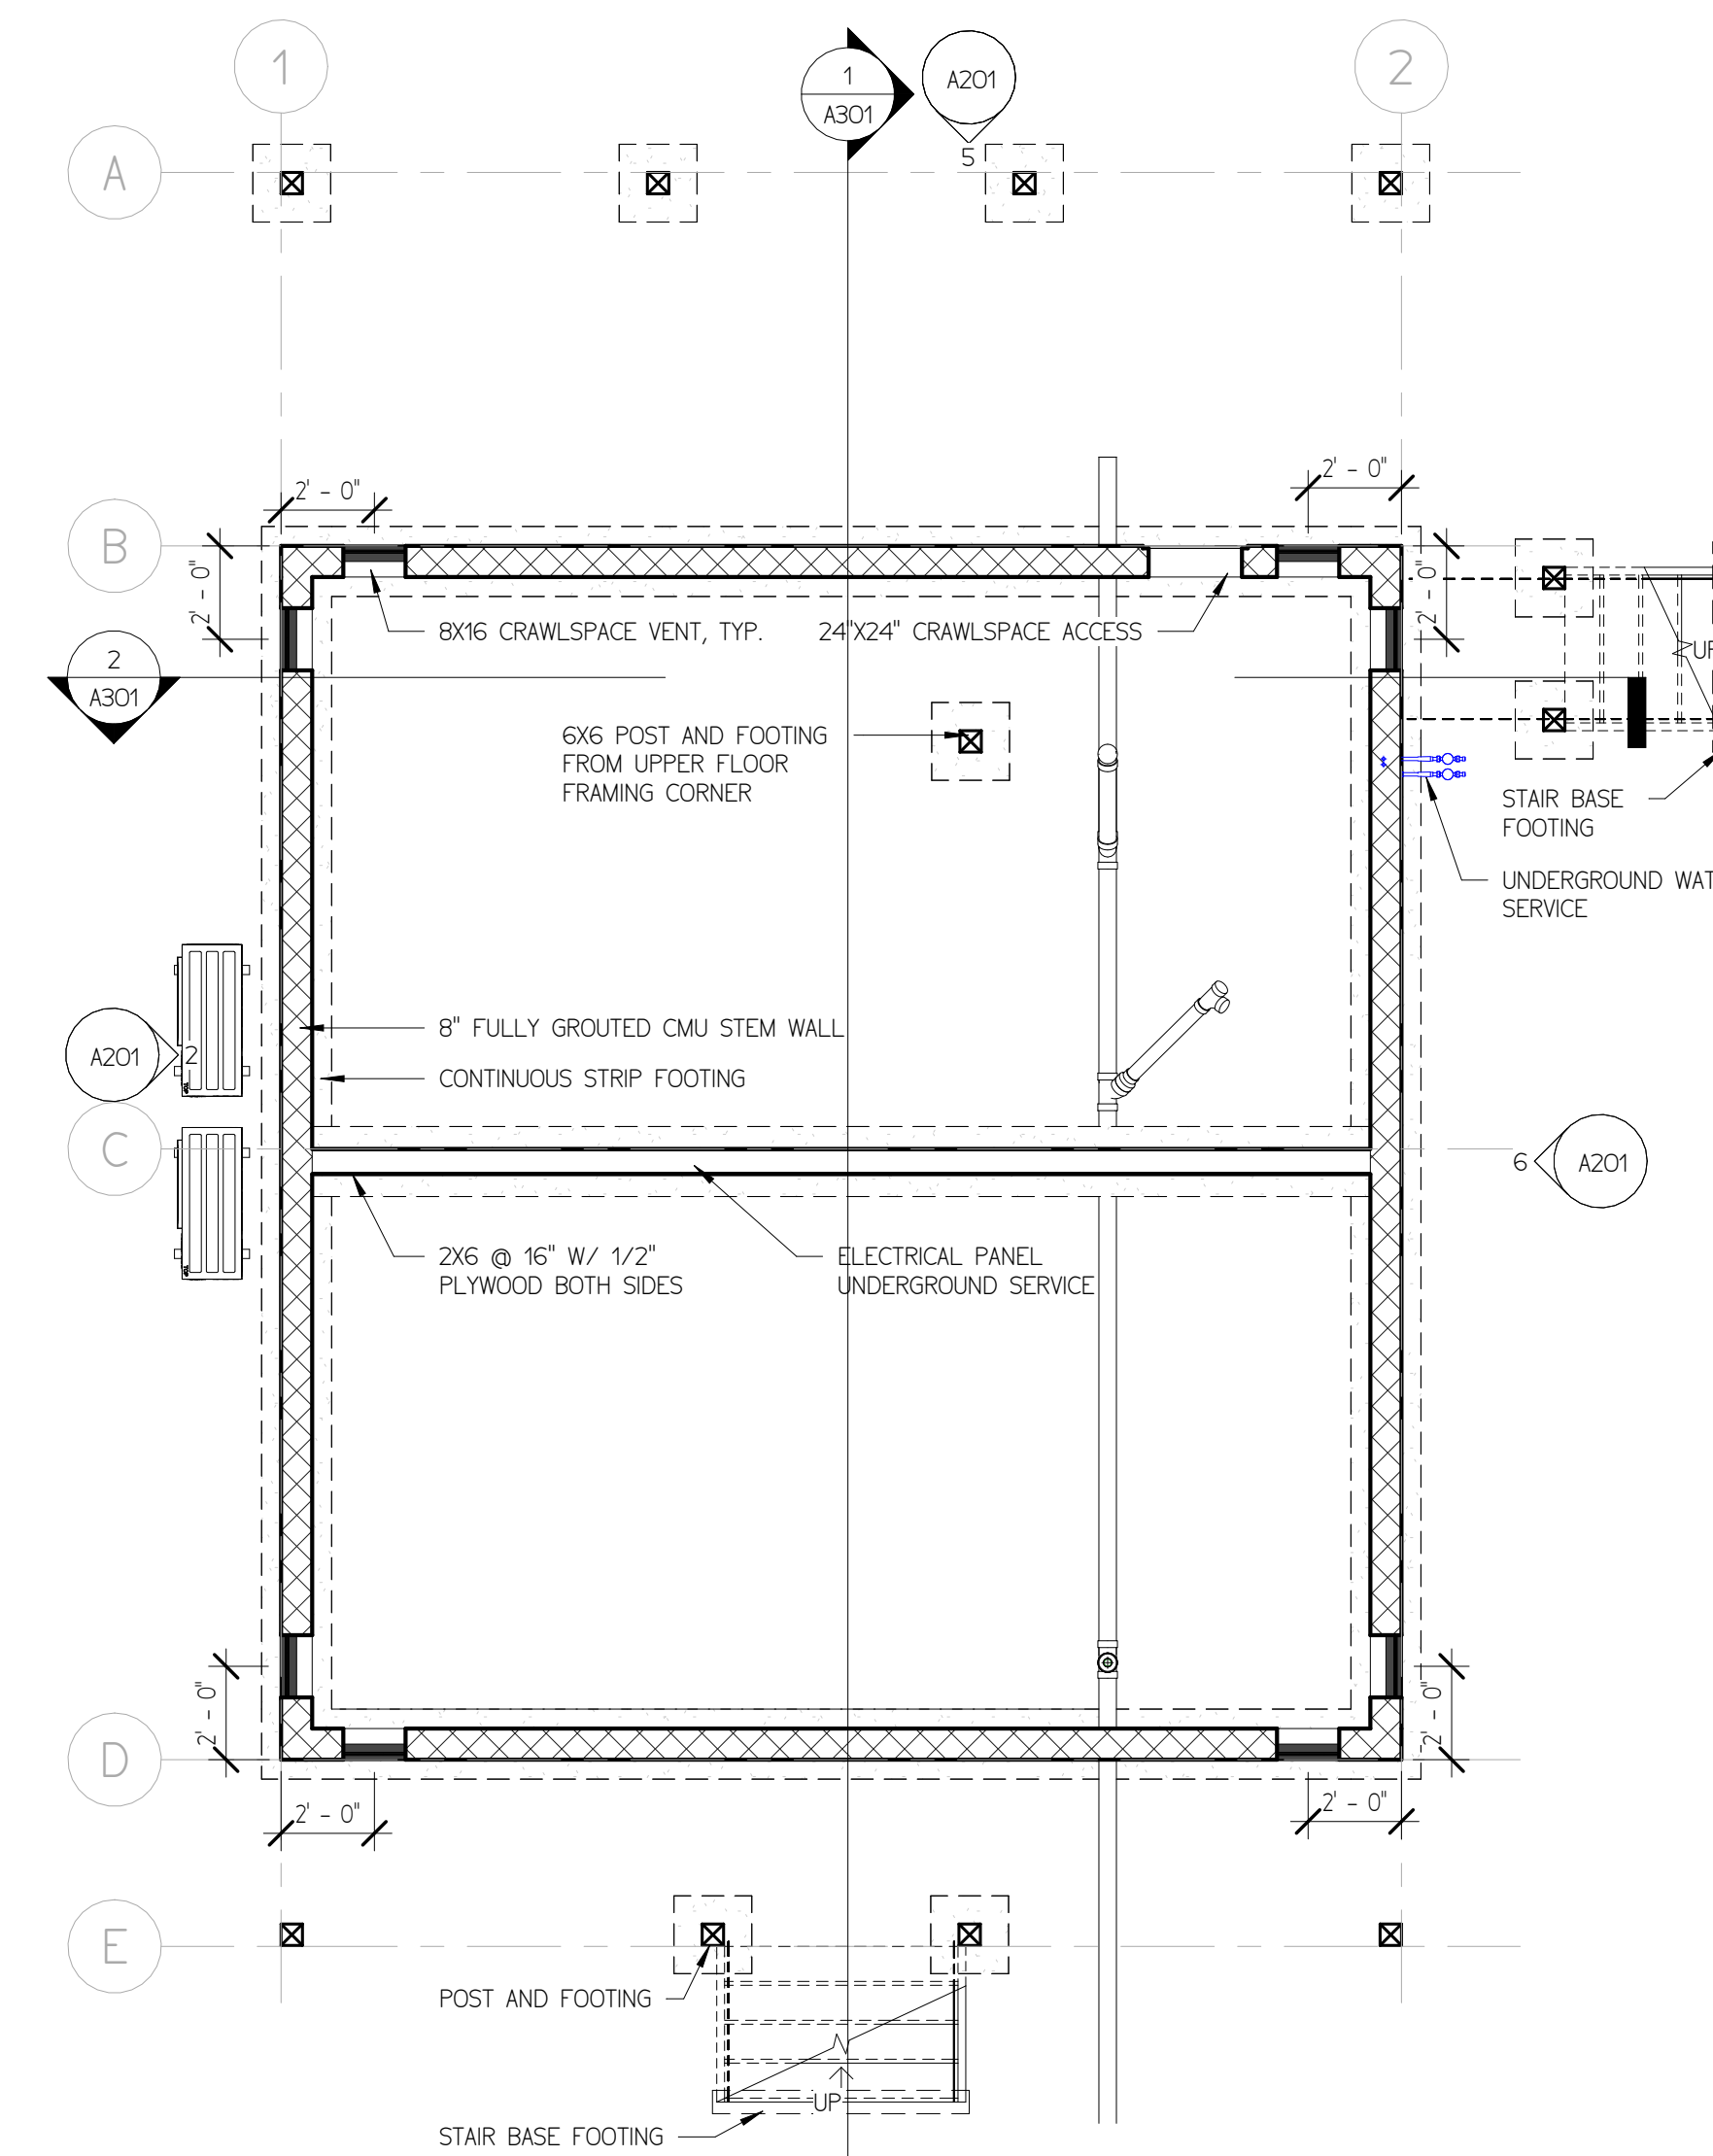

② FOUNDATION
1/4" = 1'-0"

© 2026 SAND AND EQUITIES, LLC. ALL RIGHTS RESERVED.
THE TINY DUPLEX™ – These plans and drawings are the exclusive property of Sand Equities, LLC and are protected by U.S. Copyright Law. Sand Equities, LLC hereby grants the purchaser a limited, non-transferable license to construct one (1) dwelling from these plans. No reproduction, modification, distribution, sale, rental, sharing, or construction of additional dwellings is permitted without the prior written consent of Sand Equities, LLC. Ownership of the plans and all intellectual property rights remain exclusively with Sand Equities, LLC. Unauthorized use is subject to legal action. Each additional dwelling constructed from these plans requires the purchaser an additional license from Sand Equities, LLC.

PDF SHEETS WHEN SIGNED ARE LOCKED FOR EDITING AND ALTERATION. ALL DESIGNS ARE COPYRIGHT PROTECTED AND ARE LEASED FOR CONSTRUCTION TO THE BUILDER OR OWNER AT ONE LOCATION AS STATED ON TITLEBLOCK AND COVER SHEET UNLESS OTHERWISE AUTHORIZED.

GENERAL NOTES:

—FIBERGLASS DRAFTING & DESIGN, LLC SHALL NOT BE RESPONSIBLE FOR ANY LOSSES AS A RESULT OF BUILDING CONSTRUCTION. THE OWNER AND CONTRACTOR SHALL HOLD RESPONSIBILITY FOR THE CONSTRUCTION OF THE PROJECT AND ALL ASSOCIATED DOCUMENTS.

—ALL DIMENSIONS AND LOCATIONS MUST BE VERIFIED BY THE OWNER AND ARCHITECTS BEFORE BEING BROUGHT TO THE ATTENTION OF THE ARCHITECT FOR CLARIFICATION.

—THE CONTRACTOR SHALL BE RESPONSIBLE FOR VERIFYING ALL DIMENSIONS AND LOCATIONS OF ALL PLANS AND SPECIFICATIONS. THE CONTRACTOR SHALL VERIFY ALL MECHANICAL EQUIPMENT HEIGHTS, LOCATION AND ASSOCIATED OPENINGS WITH MECHANICAL CONTRACTORS.

—THE CONTRACTOR SHALL PROVIDE ALL MANTAIN TEMPORARY BRACKETS, SHORING, GUYING, ETC. AND OTHER METHODS REQUIRED EXCESSIVE STRESSES DURING CONSTRUCTION. THE CONTRACTOR SHALL BE RESPONSIBLE FOR PROVIDING ALL SUFFICIENT PERMANENT MEMBERS ARE CONSTRUCTED TO SUPPORT THE WEIGHT OF THE STRUCTURE.


—UNLESS OTHERWISE NOTED, DETAILS SHOWN ON ALL DRAWINGS ARE TO BE CONSIDERED TYPICAL FOR ALL SIMILAR SITUATIONS.

STRUCTURAL PLANS AND DETAILS SHALL ONLY BE VALID AND FOR CONSTRUCTION WITH STATE LICENSED ENGINEER STAMP AND SIGNATURE BELOW

REVISIONS

[illegible]

OWNER

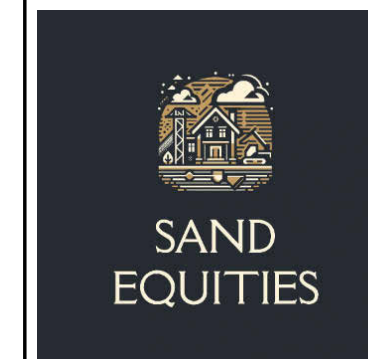

SAND EQUITIES,
LLC

THE TINY DUPLEX

Project number	26-1
Date	05/27/20
Drawn by	SJ
Scale	As indicated

FOUNDATION
AND FRAMING
PLAN

A102

ARCH D | 24"x36" | 610X914MM

PDF SHEETS WHEN SIGNED ARE LOCKED FOR EDITING AND ALTERATION. ALL DESIGNS ARE COPYRIGHT PROTECTED AND ARE LEASED FOR CONSTRUCTION TO THE BUILDER OR OWNER AT ONE LOCATION AS STATED ON TITLEBLOCK AND COVER SHEET, UNLESS OTHERWISE AUTHORIZED.

- ALL DIMENSIONS AND CONDITIONS MUST BE VERIFIED IN THE FIELD AND ANY DISCREPANCIES SHALL BE BROUGHT TO THE ATTENTION OF THE ARCHITECT FOR CLARIFICATION BEFORE PROCEEDING WITH THE AFFECTED PART OF WORK.
- THE CONTRACTOR SHALL VERIFY ALL DIMENSIONS AND ELEVATIONS WITH PLANS BEFORE STARTING WORK.
- VERIFY ALL MECHANICAL EQUIPMENT WEIGHTS, LOCATIONS AND ASSOCIATED OPENINGS WITH MECHANICAL CONTRACT NOTIFY ENGINEER IF ACTUAL WEIGHT EXCEEDS THE DESIGN WEIGHT.
- CONTRACTOR SHALL PROVIDE AND MAINTAIN TEMPORARY BRACINGS, SHORINGS, GUYS, ETC. AND OTHER METHODS PREVENT EXCESSIVE STRESSES DURING CONSTRUCTION. THESE PROVISIONS ARE TO REMAIN IN PLACE UNTIL SUFFICIENT PERMANENT MEMBERS ARE CONSTRUCTED TO INSURE THE SAFETY OF THE STRUCTURE.
- OTHER METHODS SHALL BE SHOWN ON ANY DRAWING ARE TO BE CONSIDERED TYPICAL FOR ALL SIMILAR CONDITIONS.




11


































[illegible]

THE TINY DUPLEX

SECTIONS

ARCH D | 24"x36" | 610X914

   

     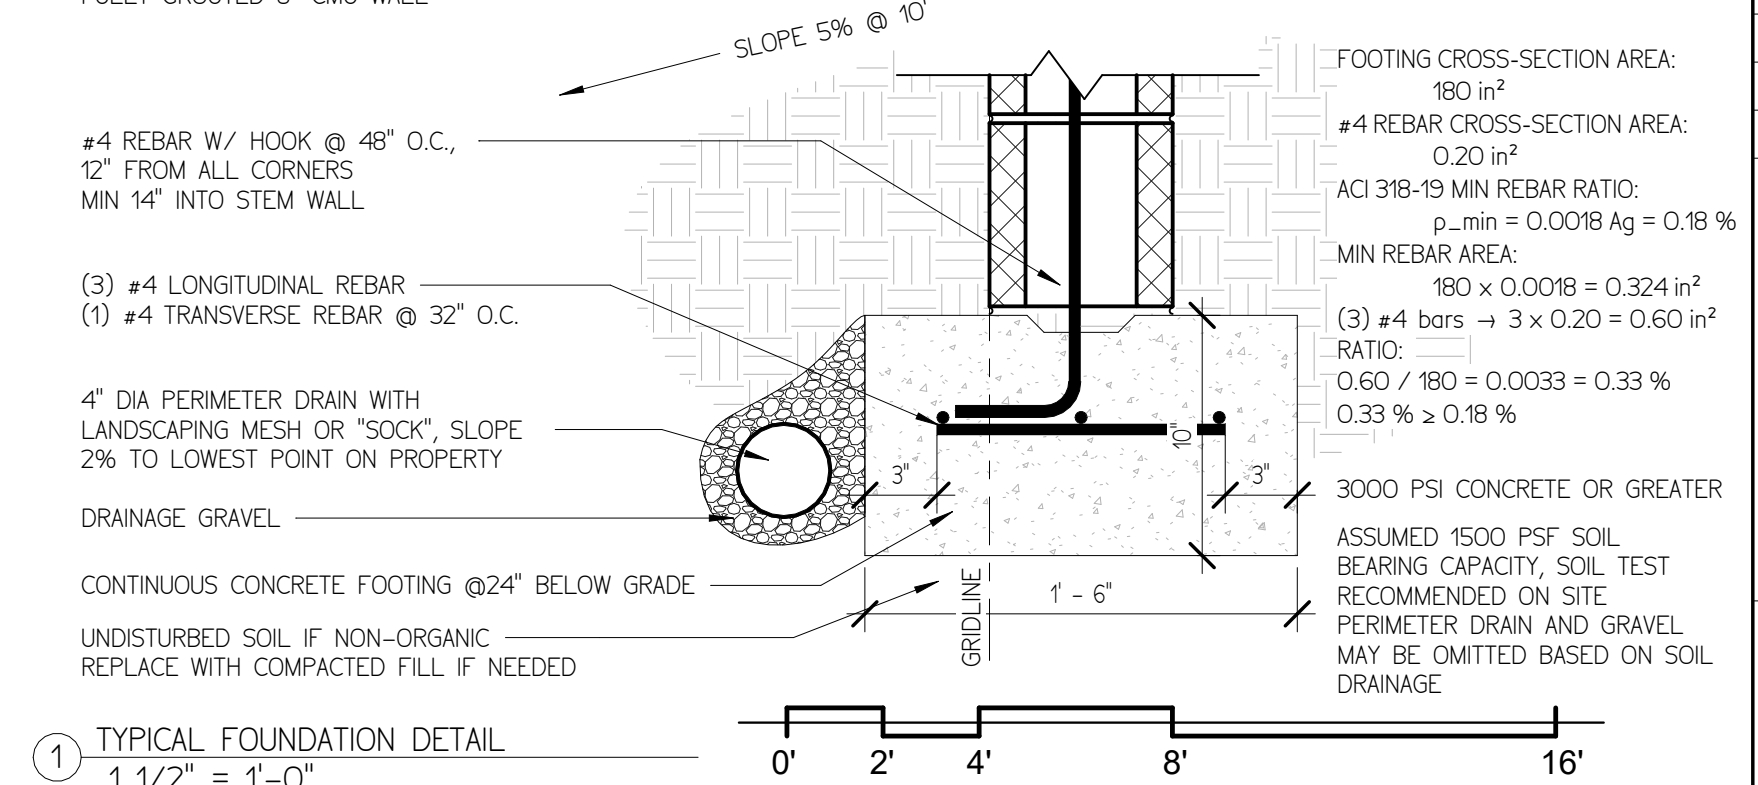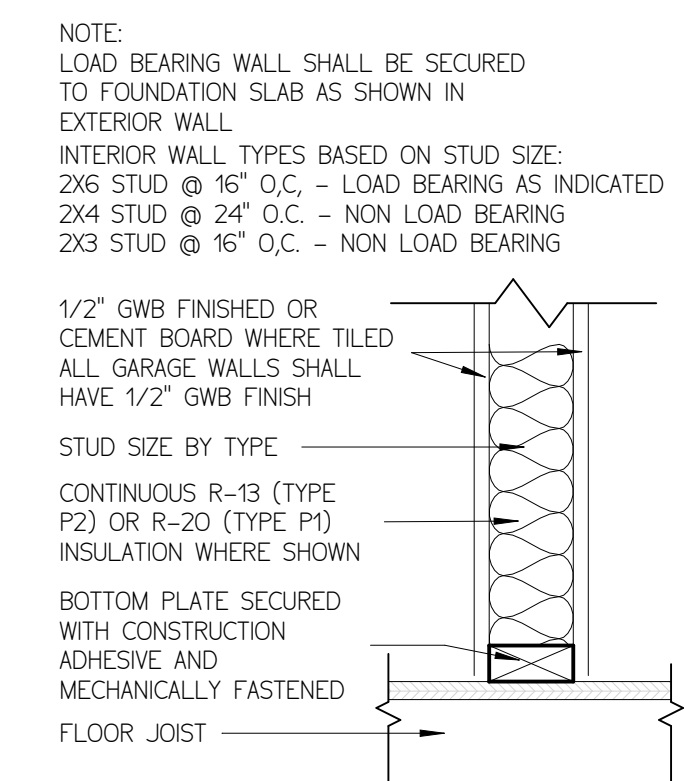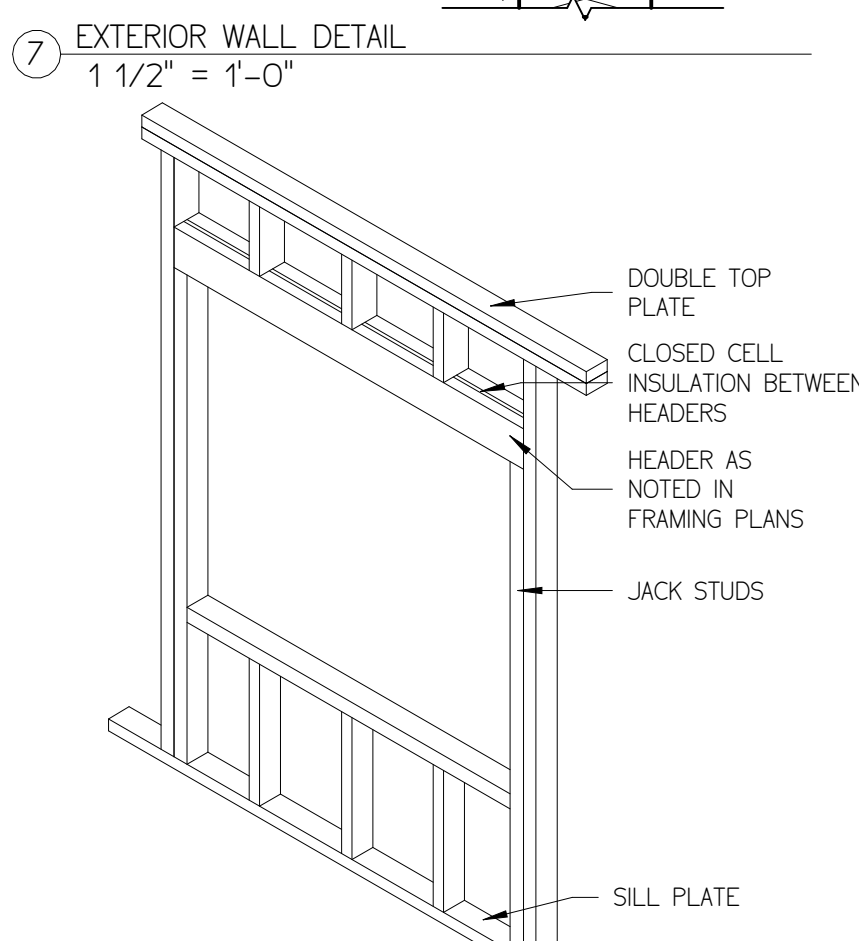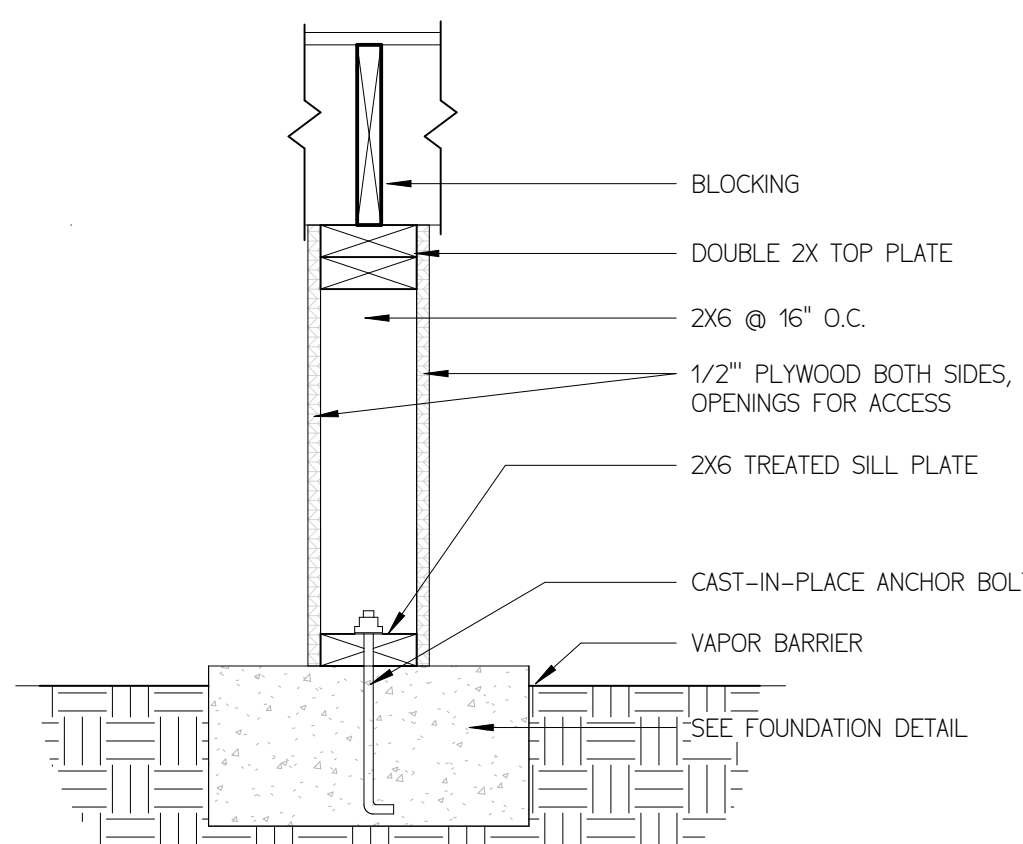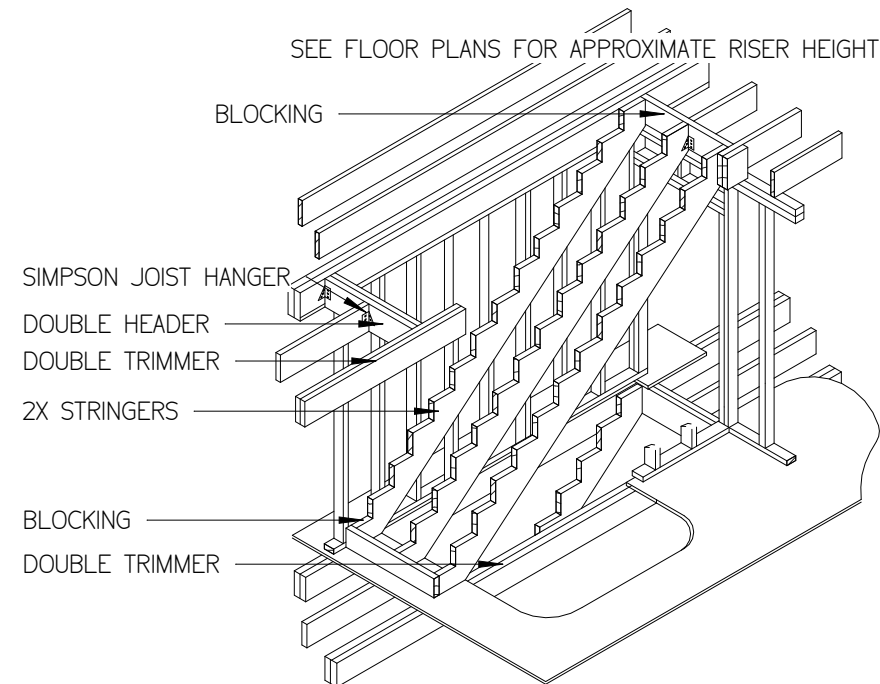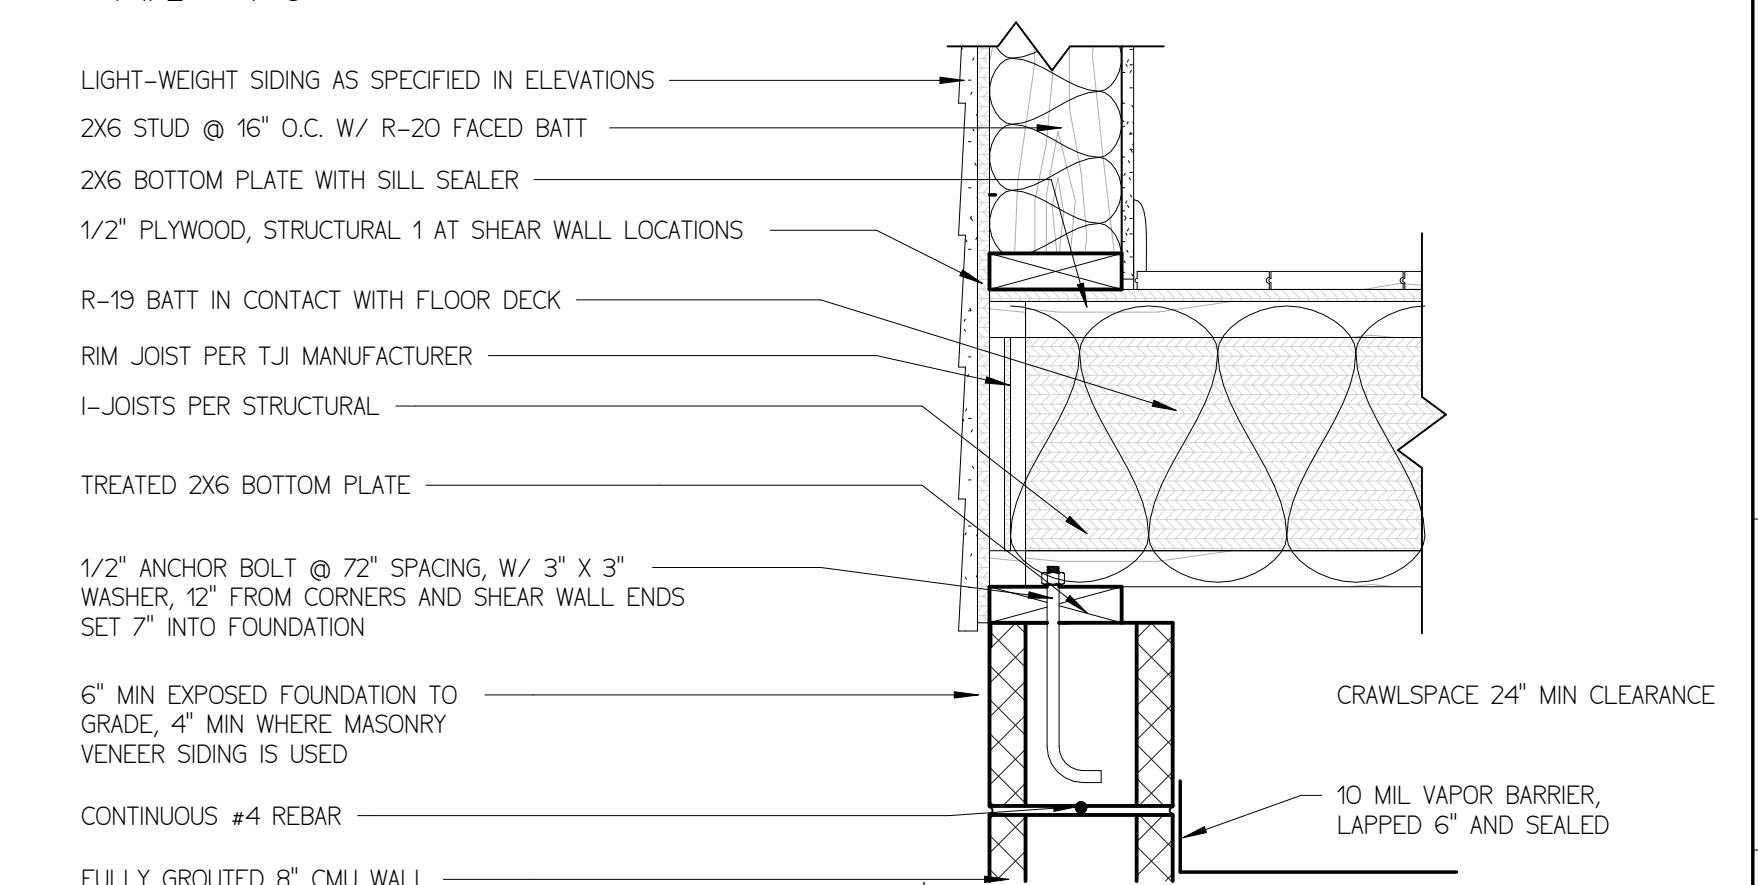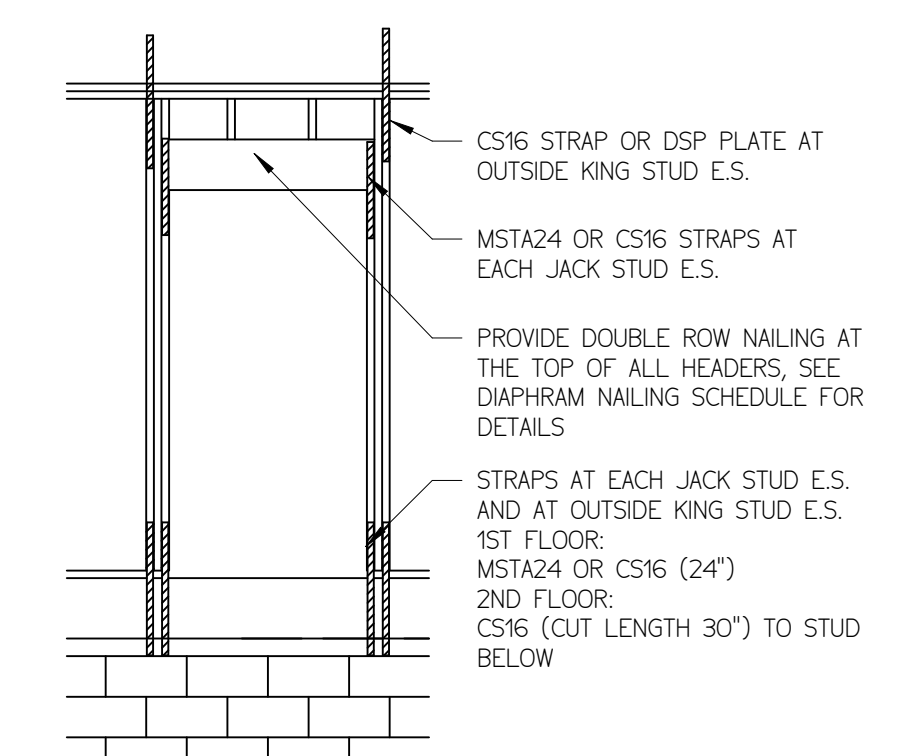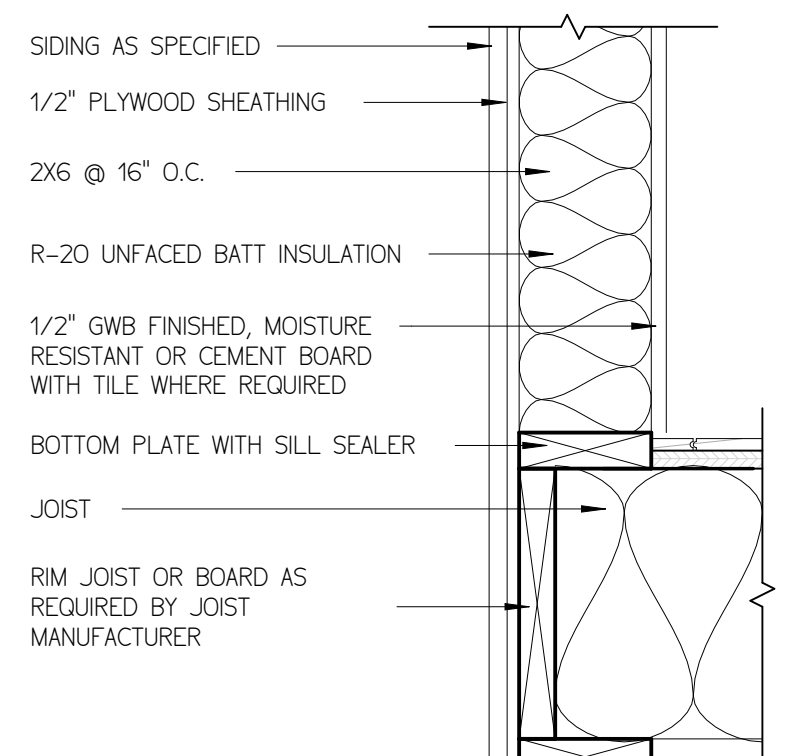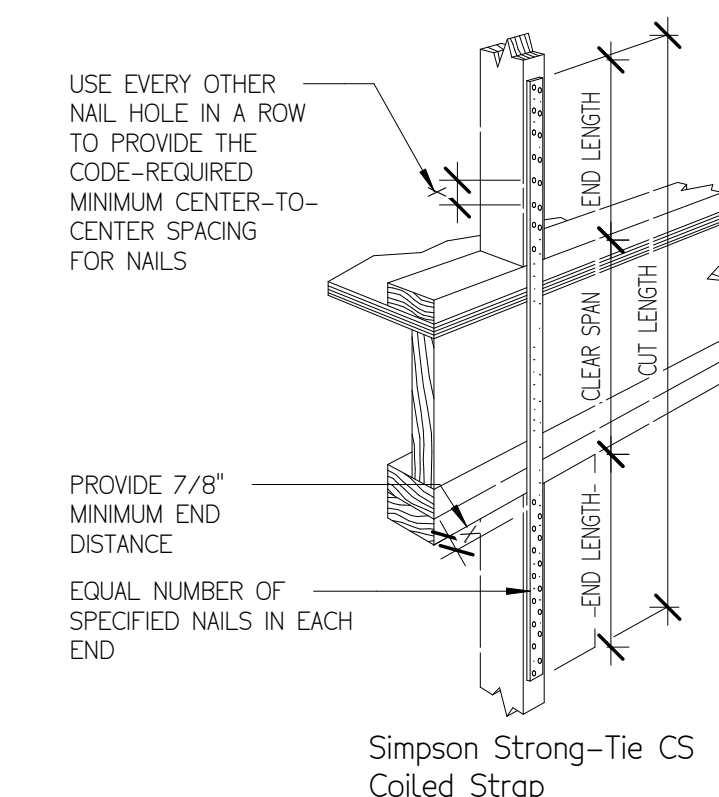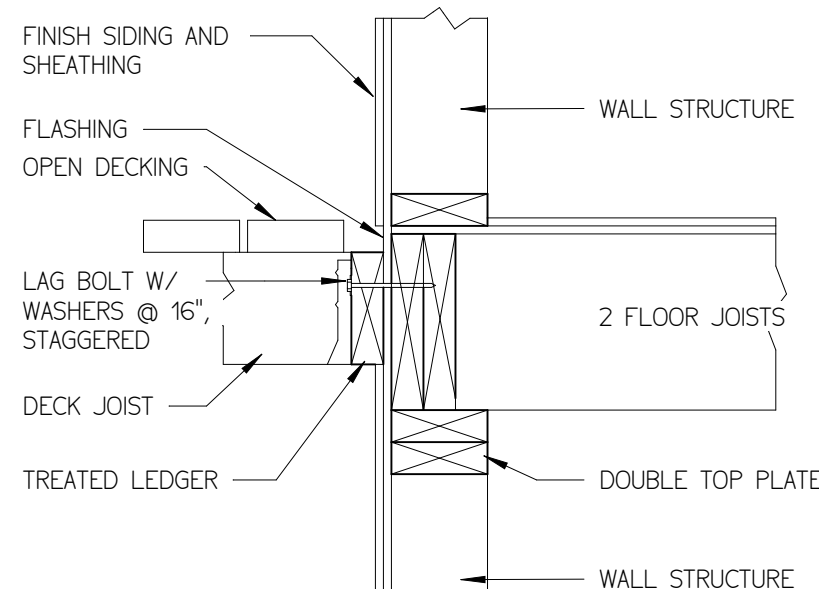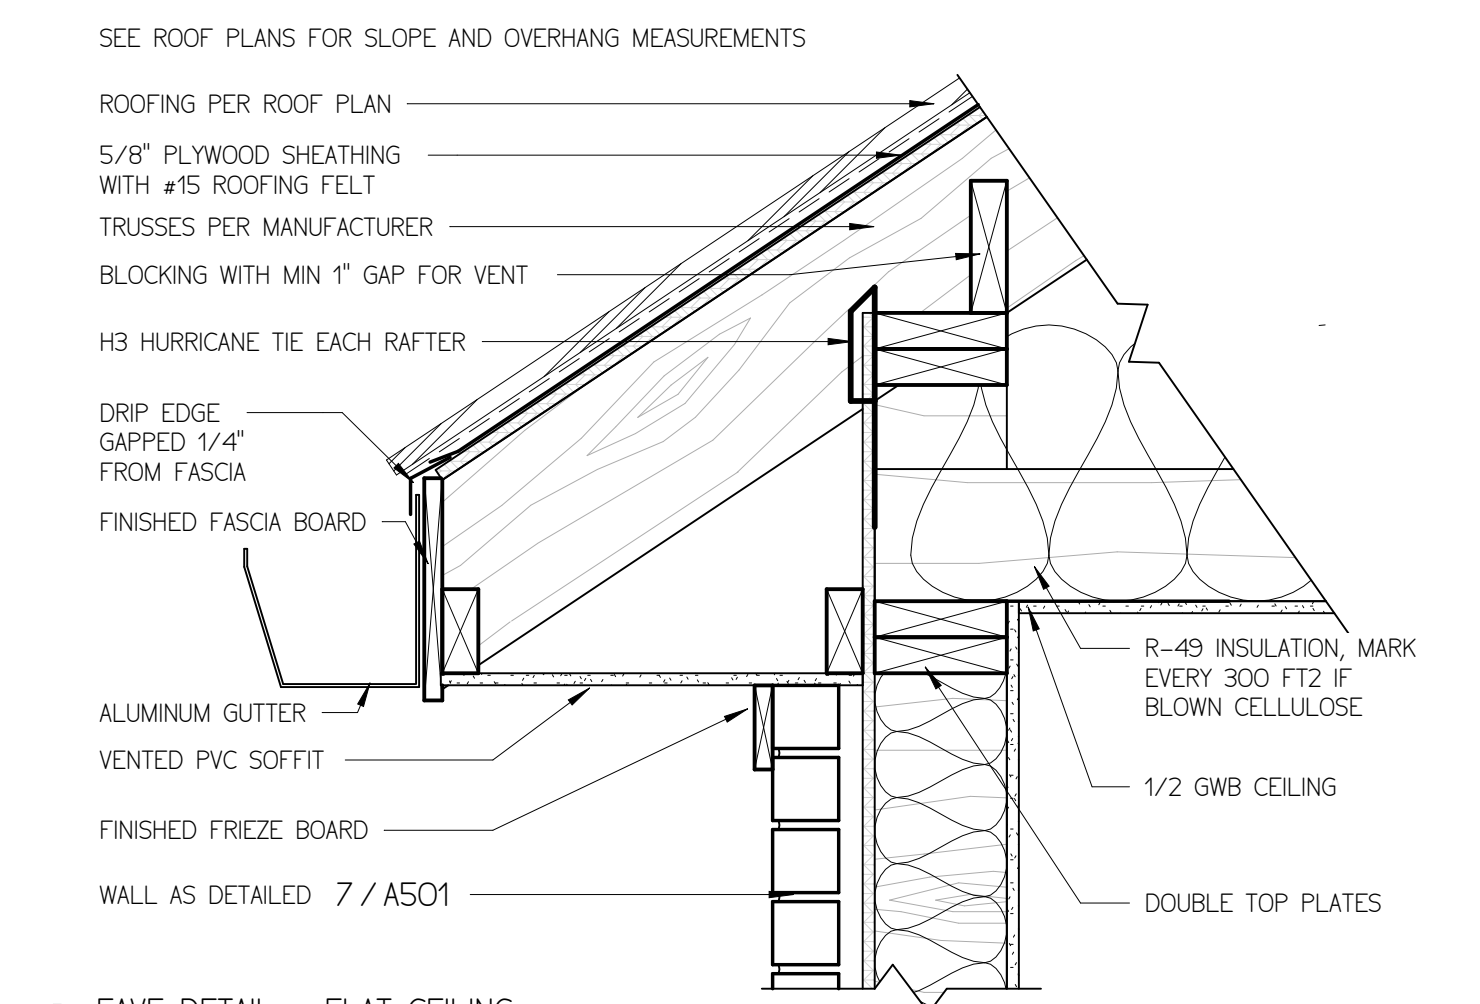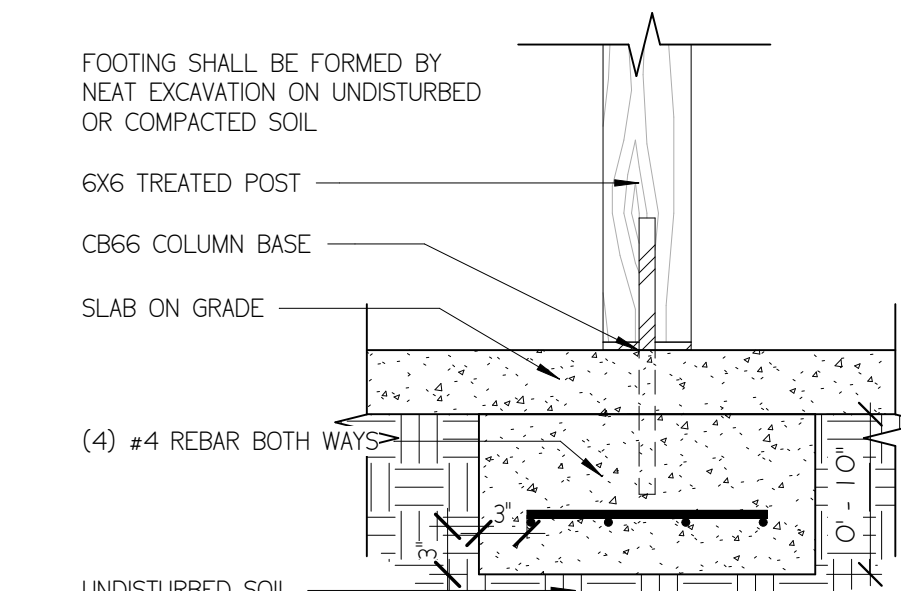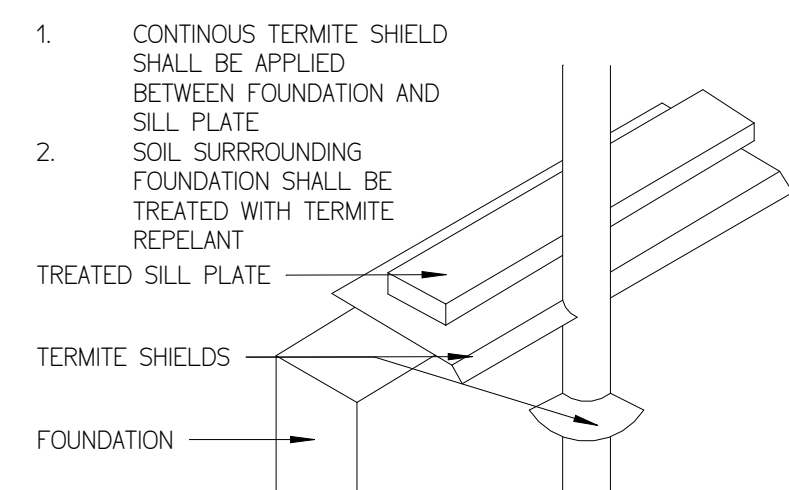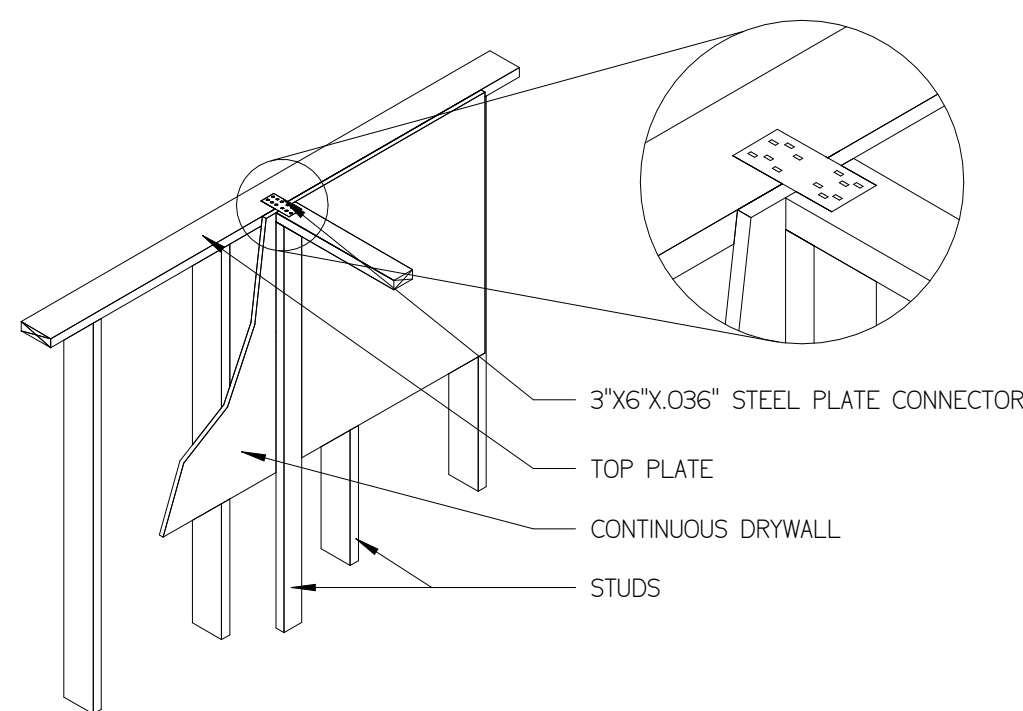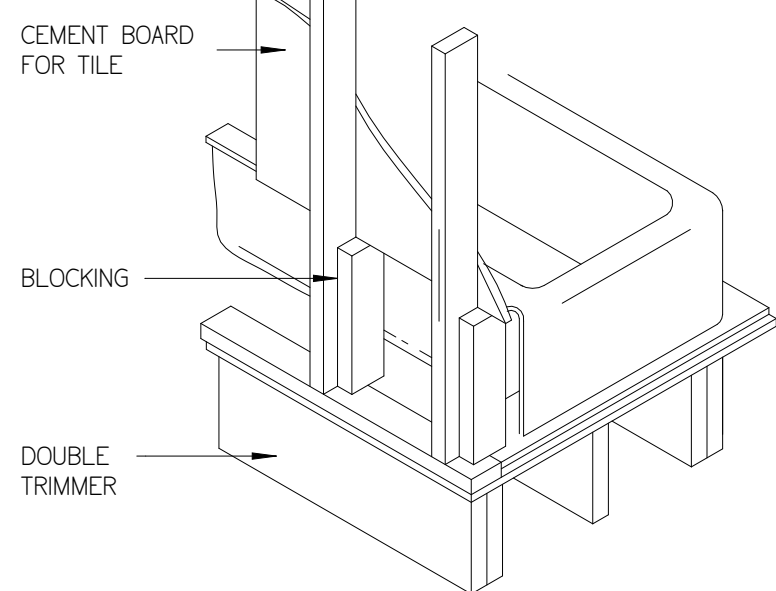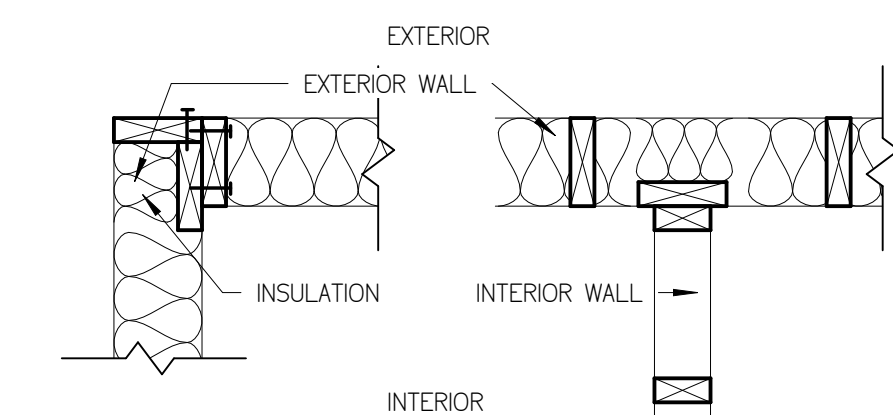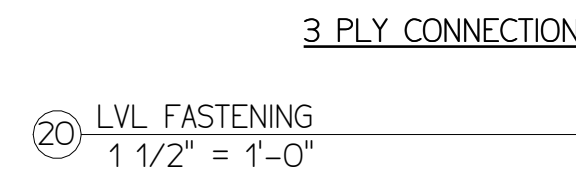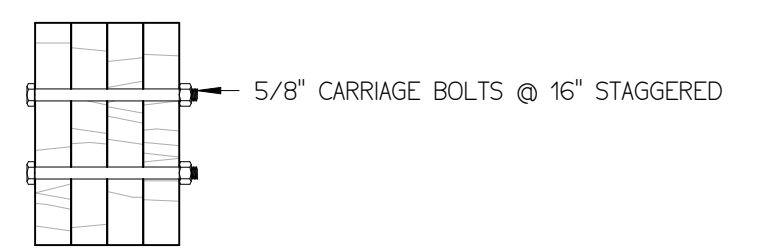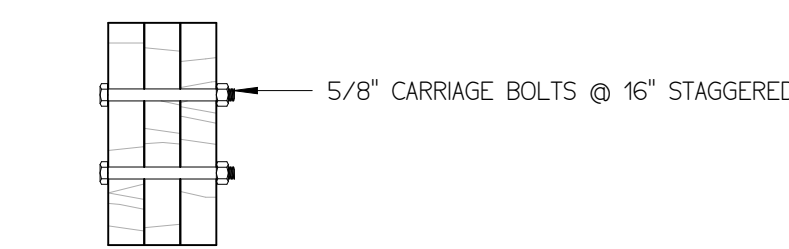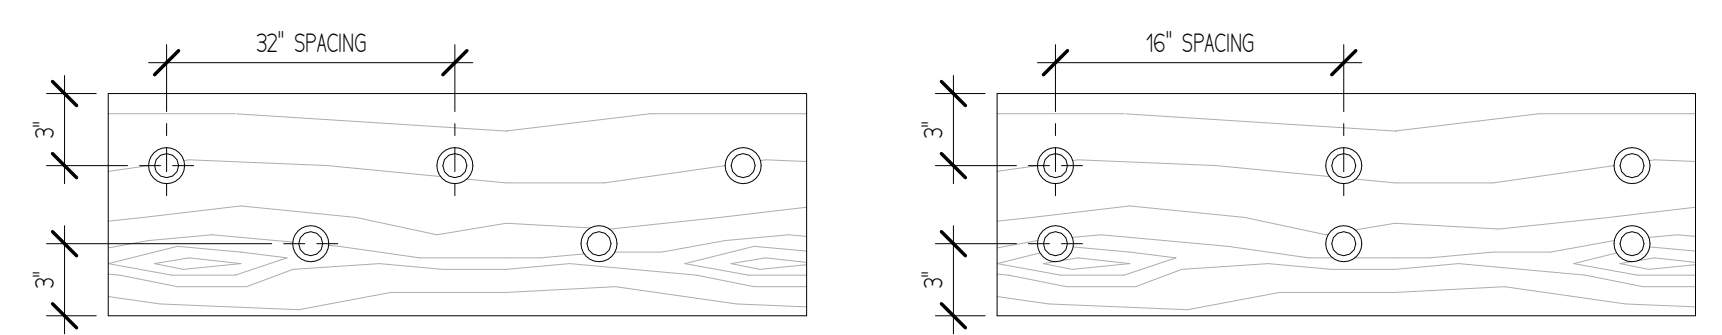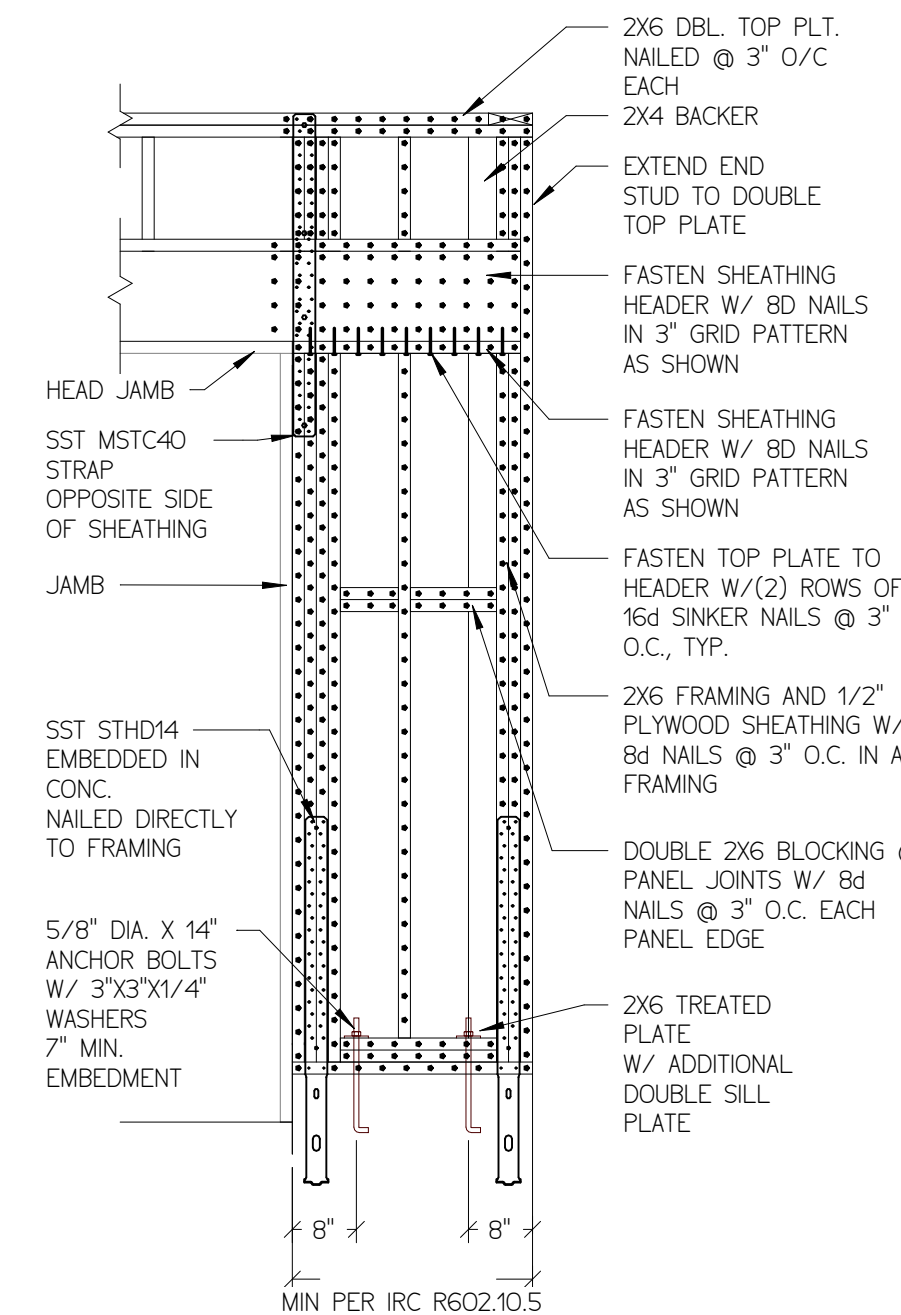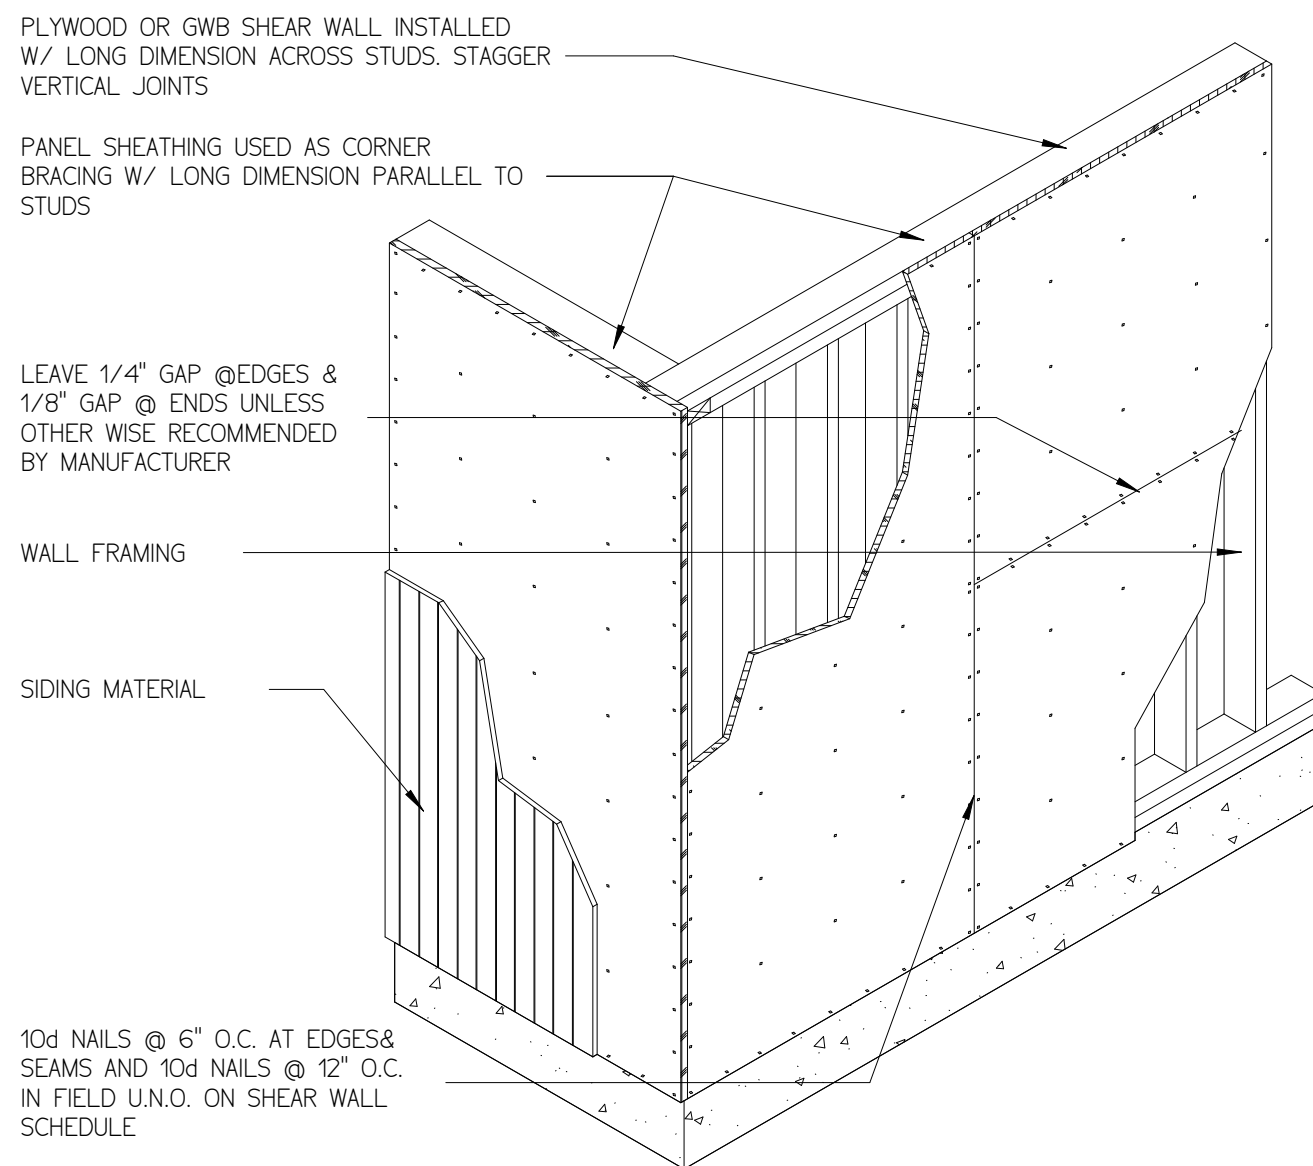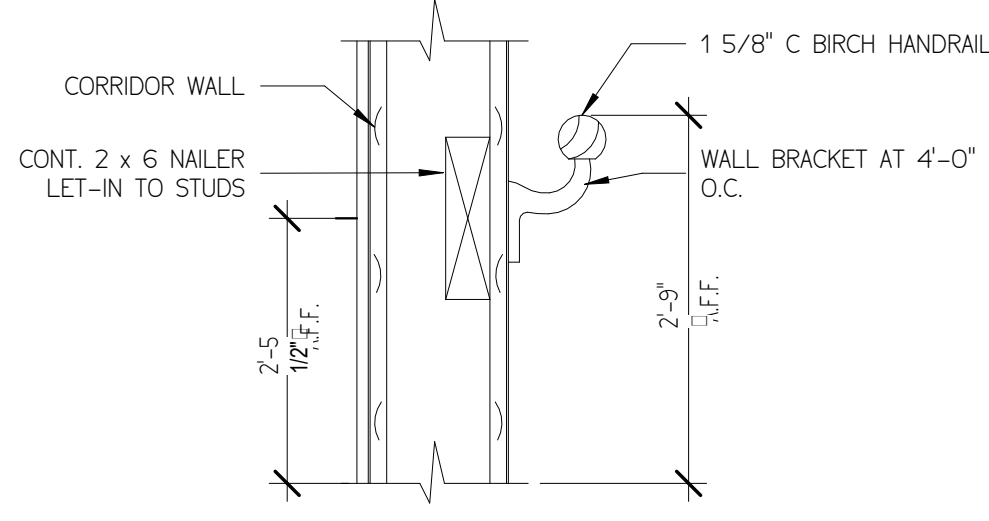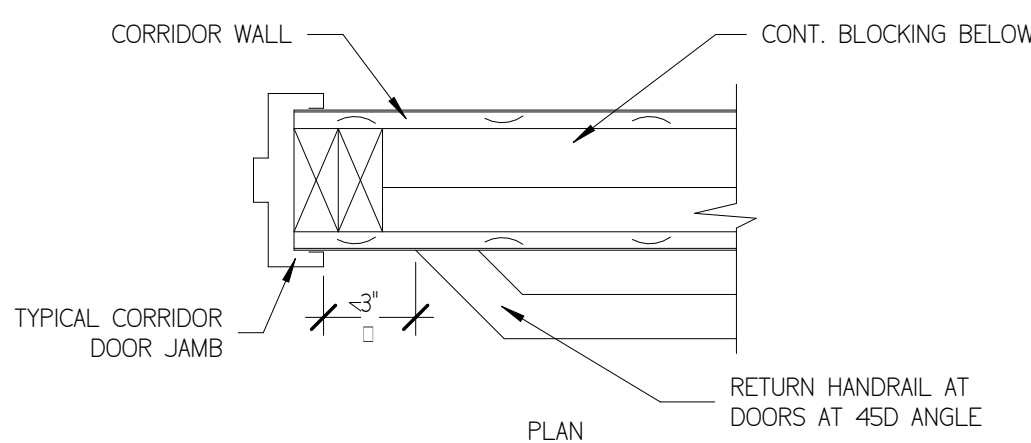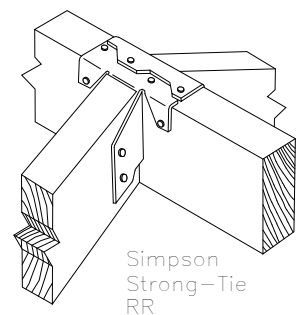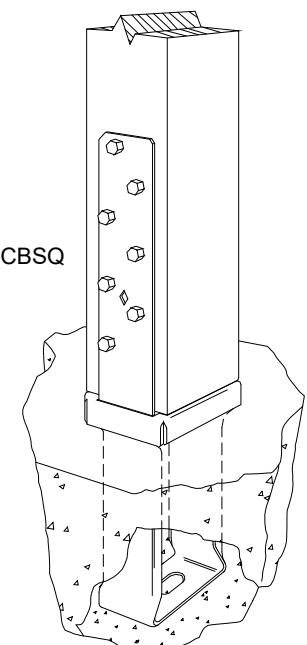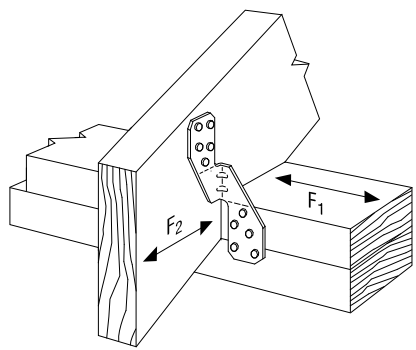 

SAND EQUITIES, LLC, ALL RIGHTS RESERVED.

TWIN'S DUPLEX™ – These plans and drawings are the exclusive property of Sand Equities, LLC and are protected by U.S. Copyright Law. The purchase of these plans limits the purchaser a limited, non-transferable license to construct one (1) dwelling being pulled from the production, distribution, resale, rental, leasing, or construction of additional dwellings is permitted without the prior written consent of Sand Equities, LLC. Membership of Sand Equities, LLC in all other rights remain exclusively with Sand Equities, LLC. Unauthorized use is subject to legal action. Each additional dwelling constructed from these plans requires the purchase of an additional license from Sand Equities, LLC.

IF SHEETS WHEN SIGNED ARE LOOKED FOR EDITING AND ALTERATION, ALL DESIGNS ARE COPYRIGHT PROTECTED AND ARE LEASED FOR CONSTRUCTION TO THE BUILDER. OWNER AT ONE LOCATION AS STATED ON TITLEBLOCK AND COVER SHEET UNLESS OTHERWISE AUTHORIZED.

GENERAL NOTES:

1. ROBINSON DRAFTING & DESIGN, LLC SHALL NOT BE LIABLE FOR ANY LOSSES AS A RESULT OF BUILDING CONSTRUCTION. THE OWNER AND CONTRACTOR SHALL HOLD RESPONSIBILITY FOR THE CONSTRUCTION OF THE BUILDINGS IN THIS DOCUMENT.

2. ALL DIMENSIONS AND CONDITIONS SHALL BE VERIFIED IN THE FIELD AND ANY DISCREPANCIES SHALL BE BROUGHT TO THE ATTENTION OF THE ARCHITECT FOR CLARIFICATION BEFORE PROCEEDING WITH THE AFFECTED PART OF WORK. THE CONTRACTOR SHALL VERIFY ALL DIMENSIONS AND CONDITIONS WITH PLANS BEFORE STARTING WORK.

3. THE CONTRACTOR SHALL VERIFY ALL DIMENSIONS, LOCATIONS AND ASSOCIATED OPENINGS WITH MECHANICAL CONTRACTOR'S ENGINEER IF ACTUAL WEIGHT EXCEEDS THE DESIGN WEIGHT.

4. THE CONTRACTOR SHALL PROVIDE AND MAINTAIN TEMPORARY BRACING, SHORNS, GUYNES, ETC. AND OTHER METHODS TO AVOID EXCESSIVE STRESSES DURING CONSTRUCTION.

5. THE PROVIDER SHALL PROVIDE THE FOLLOWING:

- a. SUFFICIENT PERMANENT MEMBERS ARE CONSTRUCTED TO GUARANTEE THE SAFETY OF THE STRUCTURE.
- b. SUFFICIENT OVERLAP NOTED, DETAILS SHOWN FOR ALL JOINTS.
- c. MEMBERS ARE TO BE CONSIDERED THIN ON ALL ANALYSES.

STRUCTURAL PLANS AND DETAILS SHALL ONLY BE VALID AND FOR CONSTRUCTION WITH STATE LICENSED ENGINEER STAMP AND SIGNATURE BELOW

OR PERMIT

REVISIONS:

[illegible]

OWNER



SAND EQUITIES

THE TINY DUPLIX

Project number	26-13
Date	05/27/26
Drawn by	SJR
Scale	As indicated


DRAFTING DETAILS

A501


RCH D | 24"x36" | 610X914MM

2. ALL ELECTRICAL WORK SHALL COMPLY WITH THE 2023 NFPA 70 CODE WITH AMENDMENTS BY THE STATE OF NC
3. NOT LESS THAN 100 PERCENT OF THE LAMPS IN PERMANENTLY INSTALLED LIGHTING FIXTURES SHALL BE HIGH-EFFICACY LAMPS OR NOT LESS THAN 75 PERCENT OF THE
4. PERMANENTLY INSTALLED LIGHTING FIXTURES SHALL CONTAIN ONLY HIGH-EFFICACY LAMPS.
5. EXTERIOR LIGHTING $\geq$ 30 WATTS SHALL HAVE THE FOLLOWING CONTROLS: MANUAL ON/OFF SWITCH WITH AUTOMATIC SHUT-OFF, AUTOMATIC SHUT-OFF IN DAYLIGHT HOURS, AND
6. CONTROLS THAT OVERIDE AUTOMATIC SHUT-OFF AND RETURNS TO AUTOMATIC CONTROL WITHIN 1 HOUR.
7. PERMANENT INTERIOR LIGHTING SHALL BE CONTROLLED WITH EITHER A DIMMER, OCCUPANCY SENSOR OR OTHER CONTROL BUILT INTO THE FIXTURE.
8. EXISTING GROUNDING SYSTEM AND CONNECTIONS FROM METER TO PANEL SHALL BE INSPECTED (IF APPLICABLE).
9. ALL RECESSED LIGHT FIXTURES SHALL BE PROPERLY SEALED WHEN PENETRATING BUILDING ENVELOPE. ANY INSTALLED IN THE BUILDING ENVELOPE SHALL BE IC COMPLIANT.
10. PROVIDE WIRE SLACK TO ANY EQUIPMENT THAT PRODUCES NOISE OR VIBRATION
11. INSTALL WATER GUARD ON ALL ELECTRICAL EQUIPMENT ENCLOSURES
12. ALL COUNTER TOP RECEPTACLES LOCATED IN KITCHENS, BATHROOMS, GARAGE, OR NEAR WATER FIXTURES SHALL BE GFCI
13. WEATHER PROOF GFCI RECEPTACLES SHALL BE INSTALLED IN ANY EXTERIOR AREA.
14. ALL RECEPTACLES SHALL BE INSTALLED AT 18" A.F.F. @ CENTERLINE UNLESS COUNTER TOP OR OTHERWISE INDICATED.
15. ALL SWITCHES, THERMOSTATS, AND ELECTRICAL CONTROLS SHALL BE INSTALLED AT 48" A.F.F. @ CENTERLINE
16. AFC BREAKERS REQUIRED WHERE SPECIFIED BY 2023 NFPA 70 CODE.
17. BRANDED WIRE SHALL ONLY BE ATTACHED TO THE WIRE TERMINALS. SOLID WIRE MAY USE PUSH-TYPE CONNECTION AFTER CONNECTION HAS BEEN MADE, SWITCHES AND/OR
18. RECEPTACLES SHALL BE WRAPPED WITH FRICION OR PVC TAPE IN A MANNER THAT COVERS THE SCREW TERMINALS.
19. ELECTRICAL CONTRACTOR SHALL PROVIDE CIRCUITS AND FINAL POWER CONNECTIONS FOR FIRE PROTECTION.
20. ELECTRICAL CONTRACTOR SHALL FIREPROOF ALL CONDUIT OPENINGS BETWEEN FLOORS AND ANY INTERSPACE FIRE SEPARATION BLOCK WALLS WITH AN ARCHITECT APPROVED U.L.
21. LISTED FIRE RETARDANT MATERIAL. ELECTRICAL CONTRACTOR SHALL WEATHERPROOF ALL PENETRATIONS THRU FOUNDATION AND EXTERIOR WALLS.
22. NO CONDUITS SHALL BE ROUTED THROUGH H.V.A.C. AIR DUCTS.
23. NO WIREWAY OR TROUGHTS ARE PERMITTED UNLESS INDICATED ON THE ELECTRICAL DRAWINGS FOR A SPECIFIC USE. ELECTRICAL CONTRACTOR SHALL FURNISH AND INSTALL PROPERLY
24. SIZED JUNCTION OR PULL BOXES WHERE REQUIRED. PULL AND JUNCTION BOXES SHALL BE HELD TO A MINIMUM.
25. PROVIDE A SEPARATE GREEN GROUND CONDUCTOR IN ALL FLEXIBLE CONDUIT CONNECTIONS TO EQUIPMENT.
26. FURNISH AND INSTALL SLEEVES FOR PENETRATIONS THRU BLOCK OR CONCRETE WALLS AND FLOORS.
27. ALL WIRE SHALL BE INSTALLED IN THINWALL, ELECTRICAL METALLIC TUBING (E.M.T.) CONDUIT UNLESS OTHERWISE NOTED. MINIMUM SIZE SHALL BE 3/4" FOR BRANCH CIRCUIT
28. ALLOWING TIGHT TO SWITCHES AND BRANCH DEVICES MAY BE 1/2" UNLESS OTHERWISE NOTED ON DRAWINGS. ALL THINWALL FITTINGS SHALL BE OF THE STEEL COMPRESSION GLAND
29. TYPE. PVC NOT ALLOWED. SEE NOTE FOR REPAIRS.
30. BRANCH CIRCUIT CONDUCTORS SHALL BE COPPER TYPE NM-B (ROMEX) INSTALLED PER 2023 NEC ART. 334. NM-B SHALL BE CONCEALED WITHIN FRAMING CAVITIES, WHEN RUN ON
31. EXPOSED SURFACES OR IN LOCATIONS SUBJECT TO PHYSICAL DAMAGE (GARAGES, UNFINISHED BASEMENTS, WITHIN 6-8 FT OF FLOOR, ETC.), PROVIDE PROTECTION IN ACCORDANCE
32. WITH NEC 334.15(B) USING EMT, SCHEDULE 80 PVC, GROUND STRIPS, OR OTHER APPROVED MEANS.
33. ALL 15 OR 20 AMPERE BRANCH CIRCUIT HOMERUNS 100' OR LONGER SHALL BE #10 AWG (MINIMUM) OR LARGER, SIZED TO LIMIT VOLTAGE DROP TO CODE REQUIREMENTS.
34. THE FOLLOWING WIRE TYPES SHALL BE USED FOR THEIR RESPECTIVE AMPERAGE AND APPLICATION


14-2 ROMEX	5 A	LIGHTING CIRCUITS
12-2 ROMEX	20 A	LIGHTING AND OUTLET CIRCUITS, REFRIGERATOR
10-2 ROMEX	30 A	ELECTRIC WATER HEATER, BASEBOARD HEATERS
10-3 ROMEX	30 A	ELECTRIC CLOTHES DRYER
6/3 CU RANGE CABLE	50 A	RANGE, HEATPUMP, ON-DEMAND ELECTRIC WATER HEATER
2 GAUGE COPPER	100 A	CENTRAL ELECTRIC HEAT
AL 4/0 SER	200 A	SERVICE FEEDER WIRE FOR 200A BREAKER PANEL

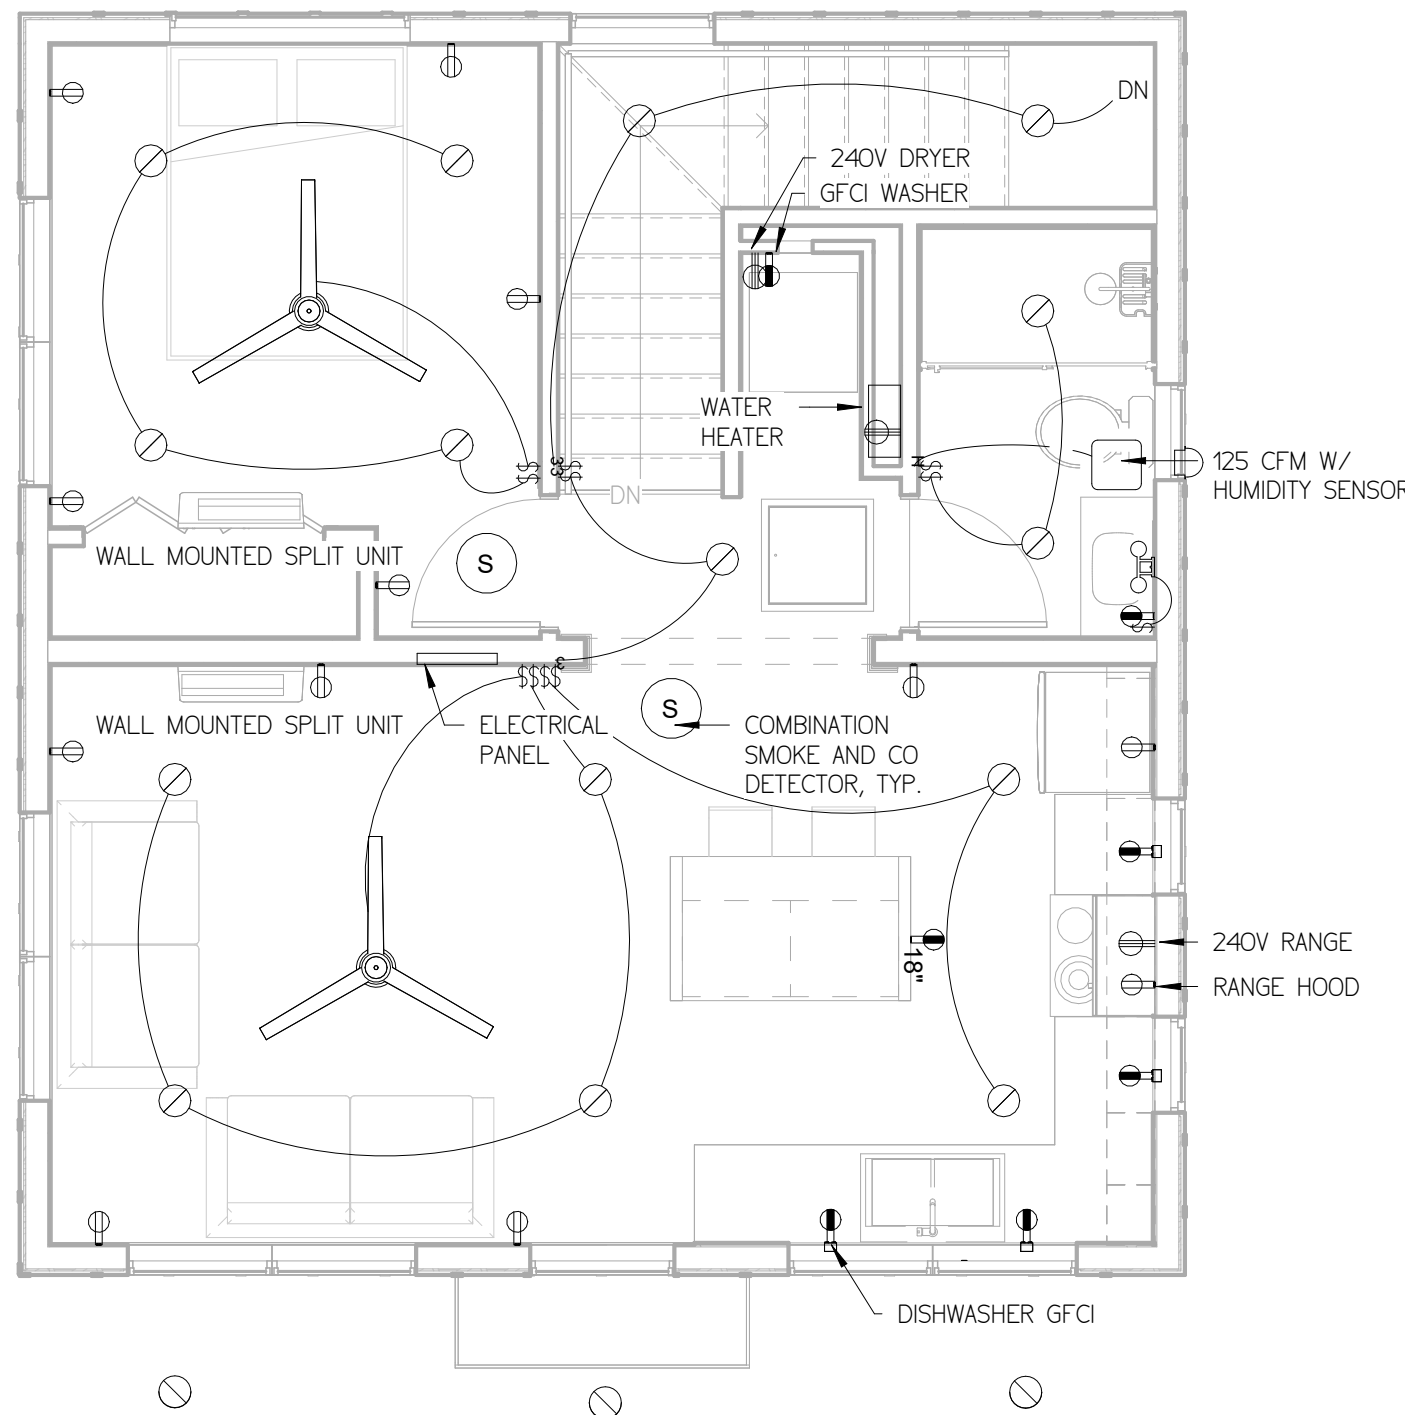

② UPPER FLOOR ELECTRICAL
1/4" = 1'-0"

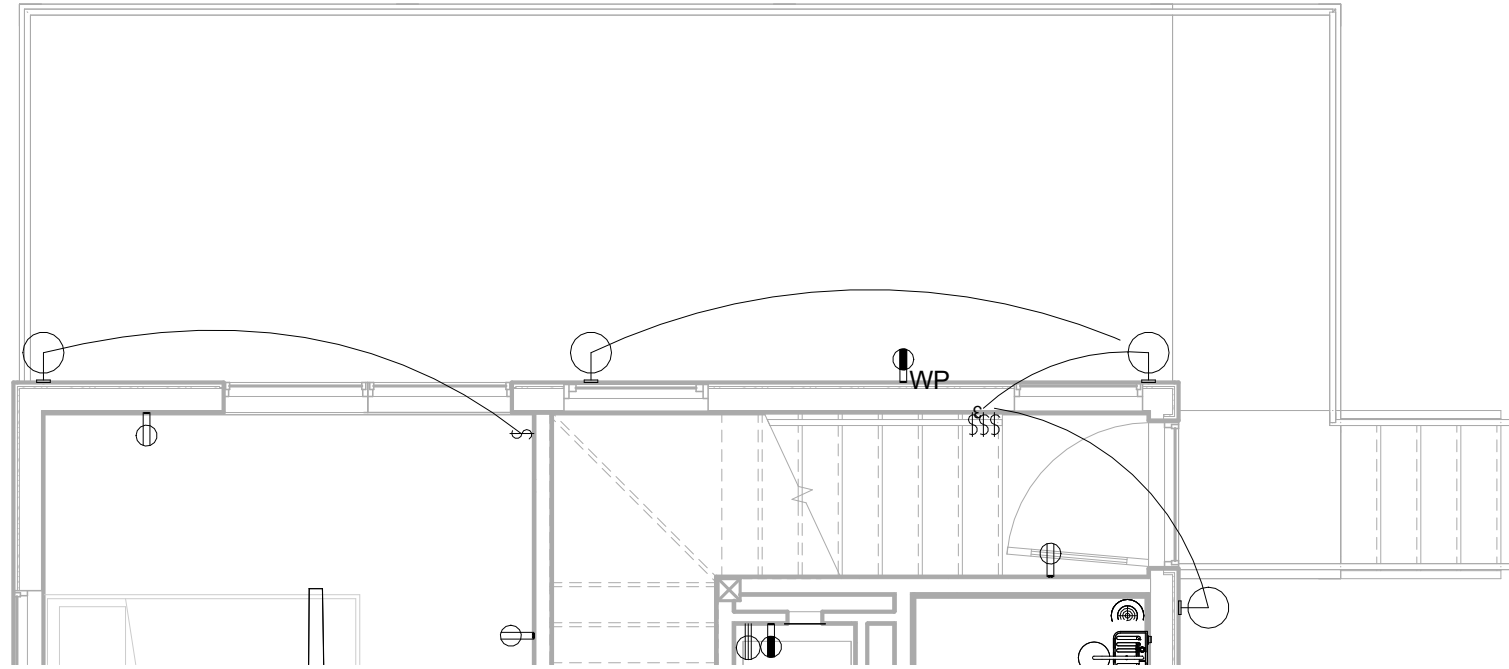

3 LOWER FLOOR ELECTRICAL OPTION 2
1/4" = 1'-0"

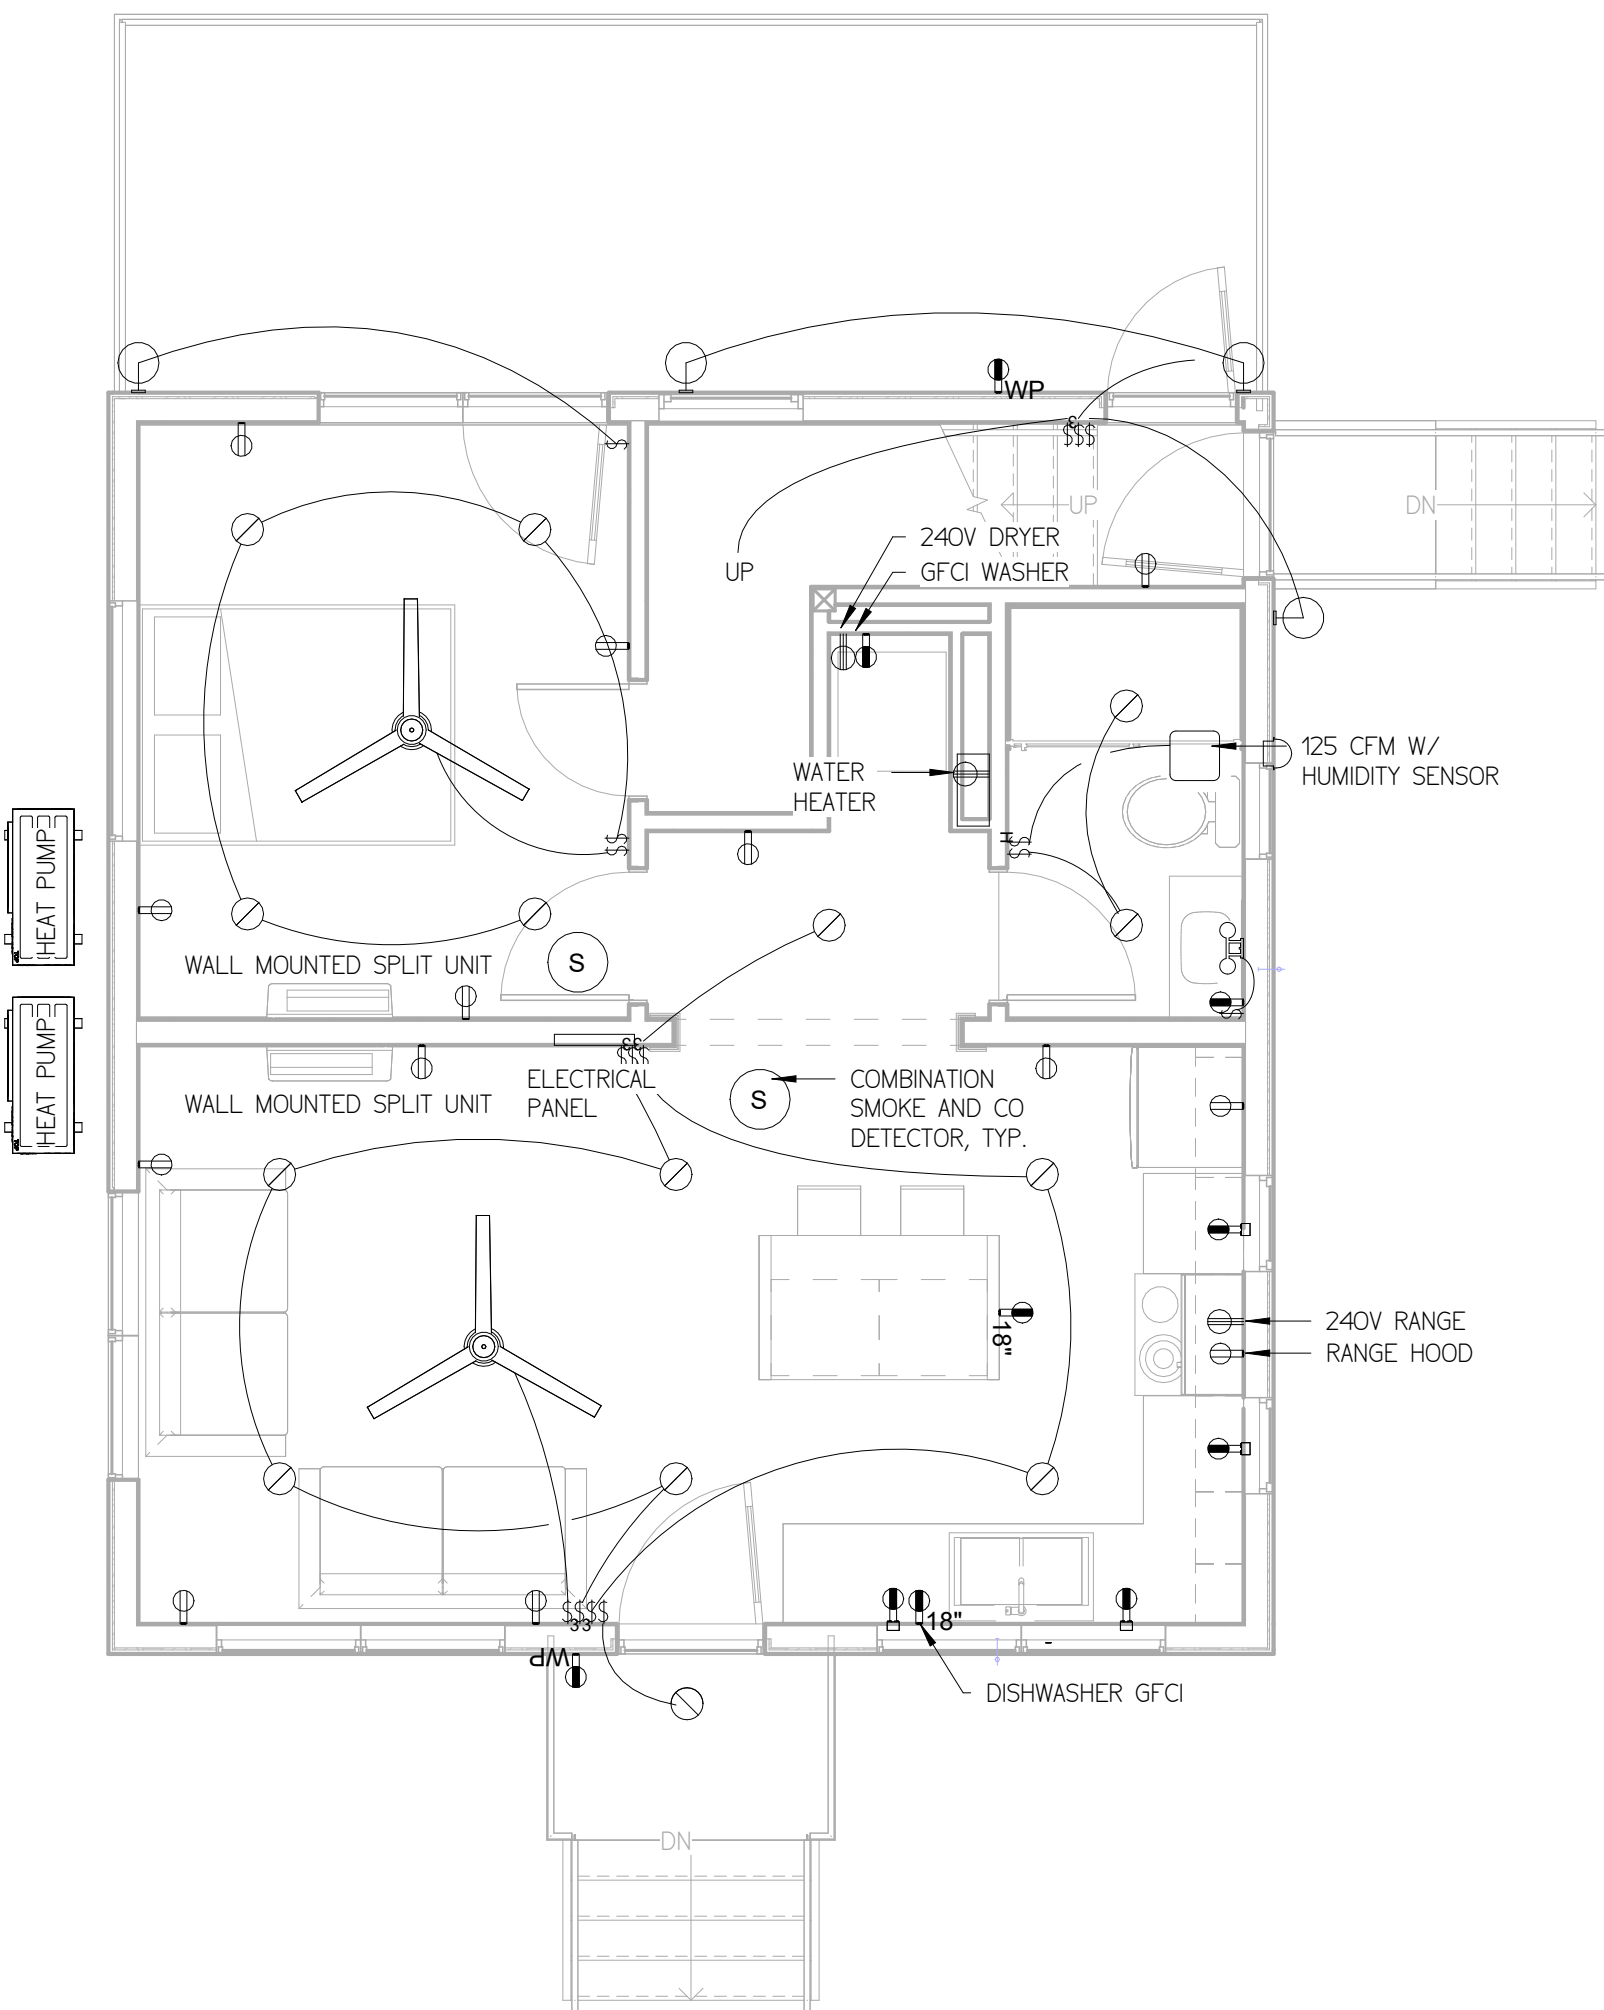

① LOWER FLOOR ELECTRICAL
1/4" = 1'-0"

 EXTERIOR WALL MOUNTED LIGHT
 RECESSED CAN LIGHT
 SMOKE DETECTOR/CO DETECTOR
 CEILING MOUNTED EXHAUST FAN
 CEILING FAN WITH LIGHT AS DISPLAYED

- STANDARD DUPLEX RECEPTACLE
- WEATHERPROOF DUPLEX GFCI RECEPTACLE
- STANDARD GFCI DUPLEX RECEPTACLE
- 240V SINGLE RECEPTACLE
- CEILING MOUNTED SMOKE DETECTOR
- SINGLE POLE LIGHT SWITCH
- 3 WAY LIGHT SWITCH
- JUNCTION BOX
- TELEPHONE RECEPTACLE
- DATA/CABLE RECEPTACLE

© 2026 SAND EQUITIES, LLC. ALL RIGHTS RESERVED.
THE TINY DUPLEX™ – These plans and drawings are the exclusive property of Sand Equities, LLC and are protected by U.S. Copyright Law. The purchase of these plans grants the purchaser a limited, non-transferable license to construct one (1) dwelling from these plans. No reproduction, modification, distribution, resale, transfer, sharing, or construction of additional dwellings is permitted without the prior written consent of Sand Equities, LLC. Ownership of the plans and all intellectual property rights remain exclusively with Sand Equities, LLC. Unauthorized use is subject to legal action. Each additional dwelling constructed from these plans requires the purchase of an additional license from Sand Equities, LLC.

PDF SHEETS WHEN SIGNED ARE LOCKED FOR EDITING AND ALTERATION. ALL DESIGNS ARE COPYRIGHT PROTECTED AND ARE LEASED FOR CONSTRUCTION TO THE BUILDER OR OWNER AT ONE LOCATION AS STATED ON TITLEBLOCK AND COVER SHEET UNLESS OTHERWISE AUTHORIZED.

GENERAL NOTES

ROBINSON ENGINEERING & DESIGN, LLC SHALL NOT BE LIABLE FOR ANY LOSSES AS A RESULT OF BUILDING CONSTRUCTION. THE CONTRACTOR SHALL HOLD ROBINSON ENGINEERING & DESIGN, LLC HARMLESS FOR THE CONSTRUCTION OF THE BUILDINGS IN THESE DOCUMENTS.

THE CONDITIONS AND CONDITIONS MUST BE VERIFIED BY THE FIELD AND ANY DISCREPANCIES SHALL BE BROUGHT TO THE ATTENTION OF THE ARCHITECT FOR CLARIFICATION. THE CONTRACTOR SHALL VERIFY ALL DIMENSIONS AND LOCATIONS OF ALL MECHANICAL PLANT EQUIPMENT, INCLUDING ALL MECHANICAL EQUIPMENT WEIGHTS, LOCATION AND ASSOCIATED DIMENSIONS WITH MECHANICAL CONTRACTORS. IF THE MECHANICAL EXCEEDS THE CONTRACT WEIGHT SHOWN ON THE DRAWINGS.

THE CONTRACTOR SHALL PROVIDE, MAINTAIN TEMPORARY BRACING AND SHORING TO PREVENT EXCESSIVE STRESSES DURING CONSTRUCTION. THESE PROVISIONS ARE TO REMAIN IN PLACE UNTIL THE STRUCTURE IS COMPLETE. THE CONTRACTOR SHALL INSURE THE SAFETY OF THE STRUCTURE.

ALL DRAWINGS SHALL BE CONSIDERED TYPICAL FOR ALL DRAWINGS UNLESS BE CONSIDERED TYPICAL FOR ALL DRAWINGS UNDER SPECIAL CONDITIONS.

STRUCTURAL PLANS AND DETAILS SHALL
ONLY BE VALID AND FOR CONSTRUCTION
WITH STATE LICENSED ENGINEER STAMP
AND SIGNATURE BELOW

FOR PERMIT

REVISIONS

[illegible]

OWNER



SAND EQUITIES

SAND EQUITIES,
LLC


THE TINY DUPLIX


Project number	26-13
Date	05/27/26
Drawn by	SJR
Scale	As indicated

ELECTRICAL

E101




ARCH D | 24"x36" | 610X914MM

 

 

DHW - (WSFU)	
LAVATORY	1 @ 1.0 = 1.0
KITCHEN SINK	1 @ 1.5 = 1.5
DISHWASHER	1 @ 1.5 = 1.5
CLOTHES WASHER	1 @ 1.5 = 1.5
BATHTUB W/ SHOWER	1 @ 1.0 = 1.0
DHW TOTAL =	6.5 WSFU

  1. ALL PLUMBING WORK SHALL COMPLY WITH THE 2024 NC PLUMBING CODE (BASED ON 2021 IPC) AND 2024 NC FUEL GAS CODE (BASED ON 2021 IFGC)
2. ALL MATERIALS, FIXTURES, AND APPLIANCES SHALL BE NEW, LISTED, AND INSTALLED IN ACCORDANCE WITH THE MANUFACTURER'S INSTRUCTIONS AND THE 2021 IPC
3. PLUMBERS/ CONTRACTORS SHALL VERIFY ALL FIXTURE LOCATIONS, ROUGH-IN HEIGHTS, AND CONNECTIONS PRIOR TO INSTALLATION.
4. ALL DOMESTIC WATER PIPING SHALL BE TYPE L COPPER, PEX-A, OR PEX-B, INSTALLED PER MANUFACTURER REQUIREMENTS AND LISTED ASTM STANDARDS.
5. ALL HOT WATER PIPES SHALL BE INSULATED TO A MINIMUM OF R-3 IN ACCORDANCE WITH NC 150.2 (BASED ON 2021 IECC R-3.5).
6. NO WATER PIPING SHALL BE RUN IN EXTERIOR WALLS OR ATTICS UNLESS PROTECTED BY REQUIRED INSULATION OR HEAT TRACE.
7. PROVIDE WATER HAMMER ARRESTORS AT ALL QUICK-CLOSING FIXTURES AND APPLIANCES.
8. PRESSURE-REDUCING VALVE REQUIRED WHEN STATIC PRESSURE EXCEEDS 80 PSI.
9. THERMAL EXPANSION CONTROL DEVICE REQUIRED WHEN A PRESSURE-REDUCING VALVE OR BACKFLOW PREVENTER IS INSTALLED ON THE DOMESTIC WATER SYSTEM.
10. WATER HEATERS SHALL BE INSTALLED WITH FULL-PORT BALL VALVES ON BOTH SUPPLY AND DISCHARGE LINES AND SHALL INCLUDE A TEMPERATURE AND PRESSURE RELIEF VALVE (T&P) PIPED FULL-SIZE TO WITHIN 6" OF THE FLOOR OR TO AN APPROVED DRAIN LOCATION.
11. ALL WATER HEATERS LOCATED ABOVE OCCUPIED SPACES SHALL HAVE A DRAIN PAN WITH A DEDICATED DRAIN LINE TO AN APPROVED TERMINATION.
12. ALL WATER HEATERS SHALL BE PROVIDED WITH EXHAUSTION AIR AND VENTING IN ACCORDANCE WITH THE 2024 IFGC (BASED ON 2021 IFGC) AND MANUFACTURER'S INSTRUCTIONS.
13. ALL FIXTURES SHALL BE EQUIPPED WITH SHUTOFF VALVES ACCESSIBLE FROM THE SAME ROOM AS THE FIXTURE.
14. ALL PLUMBING PIPING PENETRATIONS THROUGH FIRE-RATED CONSTRUCTION SHALL BE SEALED WITH UL-LISTED FIRESTOP SYSTEMS.
15. UNDERGROUND DW PIPING SHALL BE TESTED AT 10' HEAD OF WATER FOR 15 MINUTES OR 5 PSI AIR PRESSURE FOR 15 MINUTES. ABOVEGROUND DW SYSTEMS SHALL BE TESTED AT 10' HEAD OF WATER OR 5 PSI AIR PRESSURE FOR 15 MINUTES.
16. ALL CLEANOUTS SHALL BE ACCESSIBLE AND INSTALLED PER 2024 IPC (BASED ON 2021 IPC) SECTION 708.
17. HOSE BIBBS SHALL BE FROST-PROOF, SELF-DRAINING TYPE WITH INTEGRAL VACUUM BREAKERS.
18. BACKFLOW PREVENTERS SHALL BE PROVIDED ON ALL IRRIGATION AND MAKE-UP WATER CONNECTIONS.
19. SUMP AND EJECTORS SHALL BE EQUIPPED WITH CHECK VALVES AND FULL-PORT ISOLATION VALVES.
20. ALL EXPOSED INTERIOR PLUMBING IN UNCONDITIONED SPACES SHALL BE INSULATED AND PROTECTED FROM FREEZING.

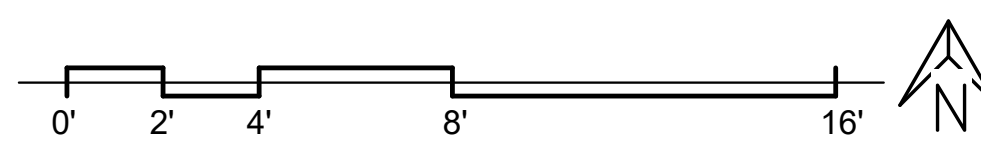

ARCH D | 24"X36" | 610X914M