



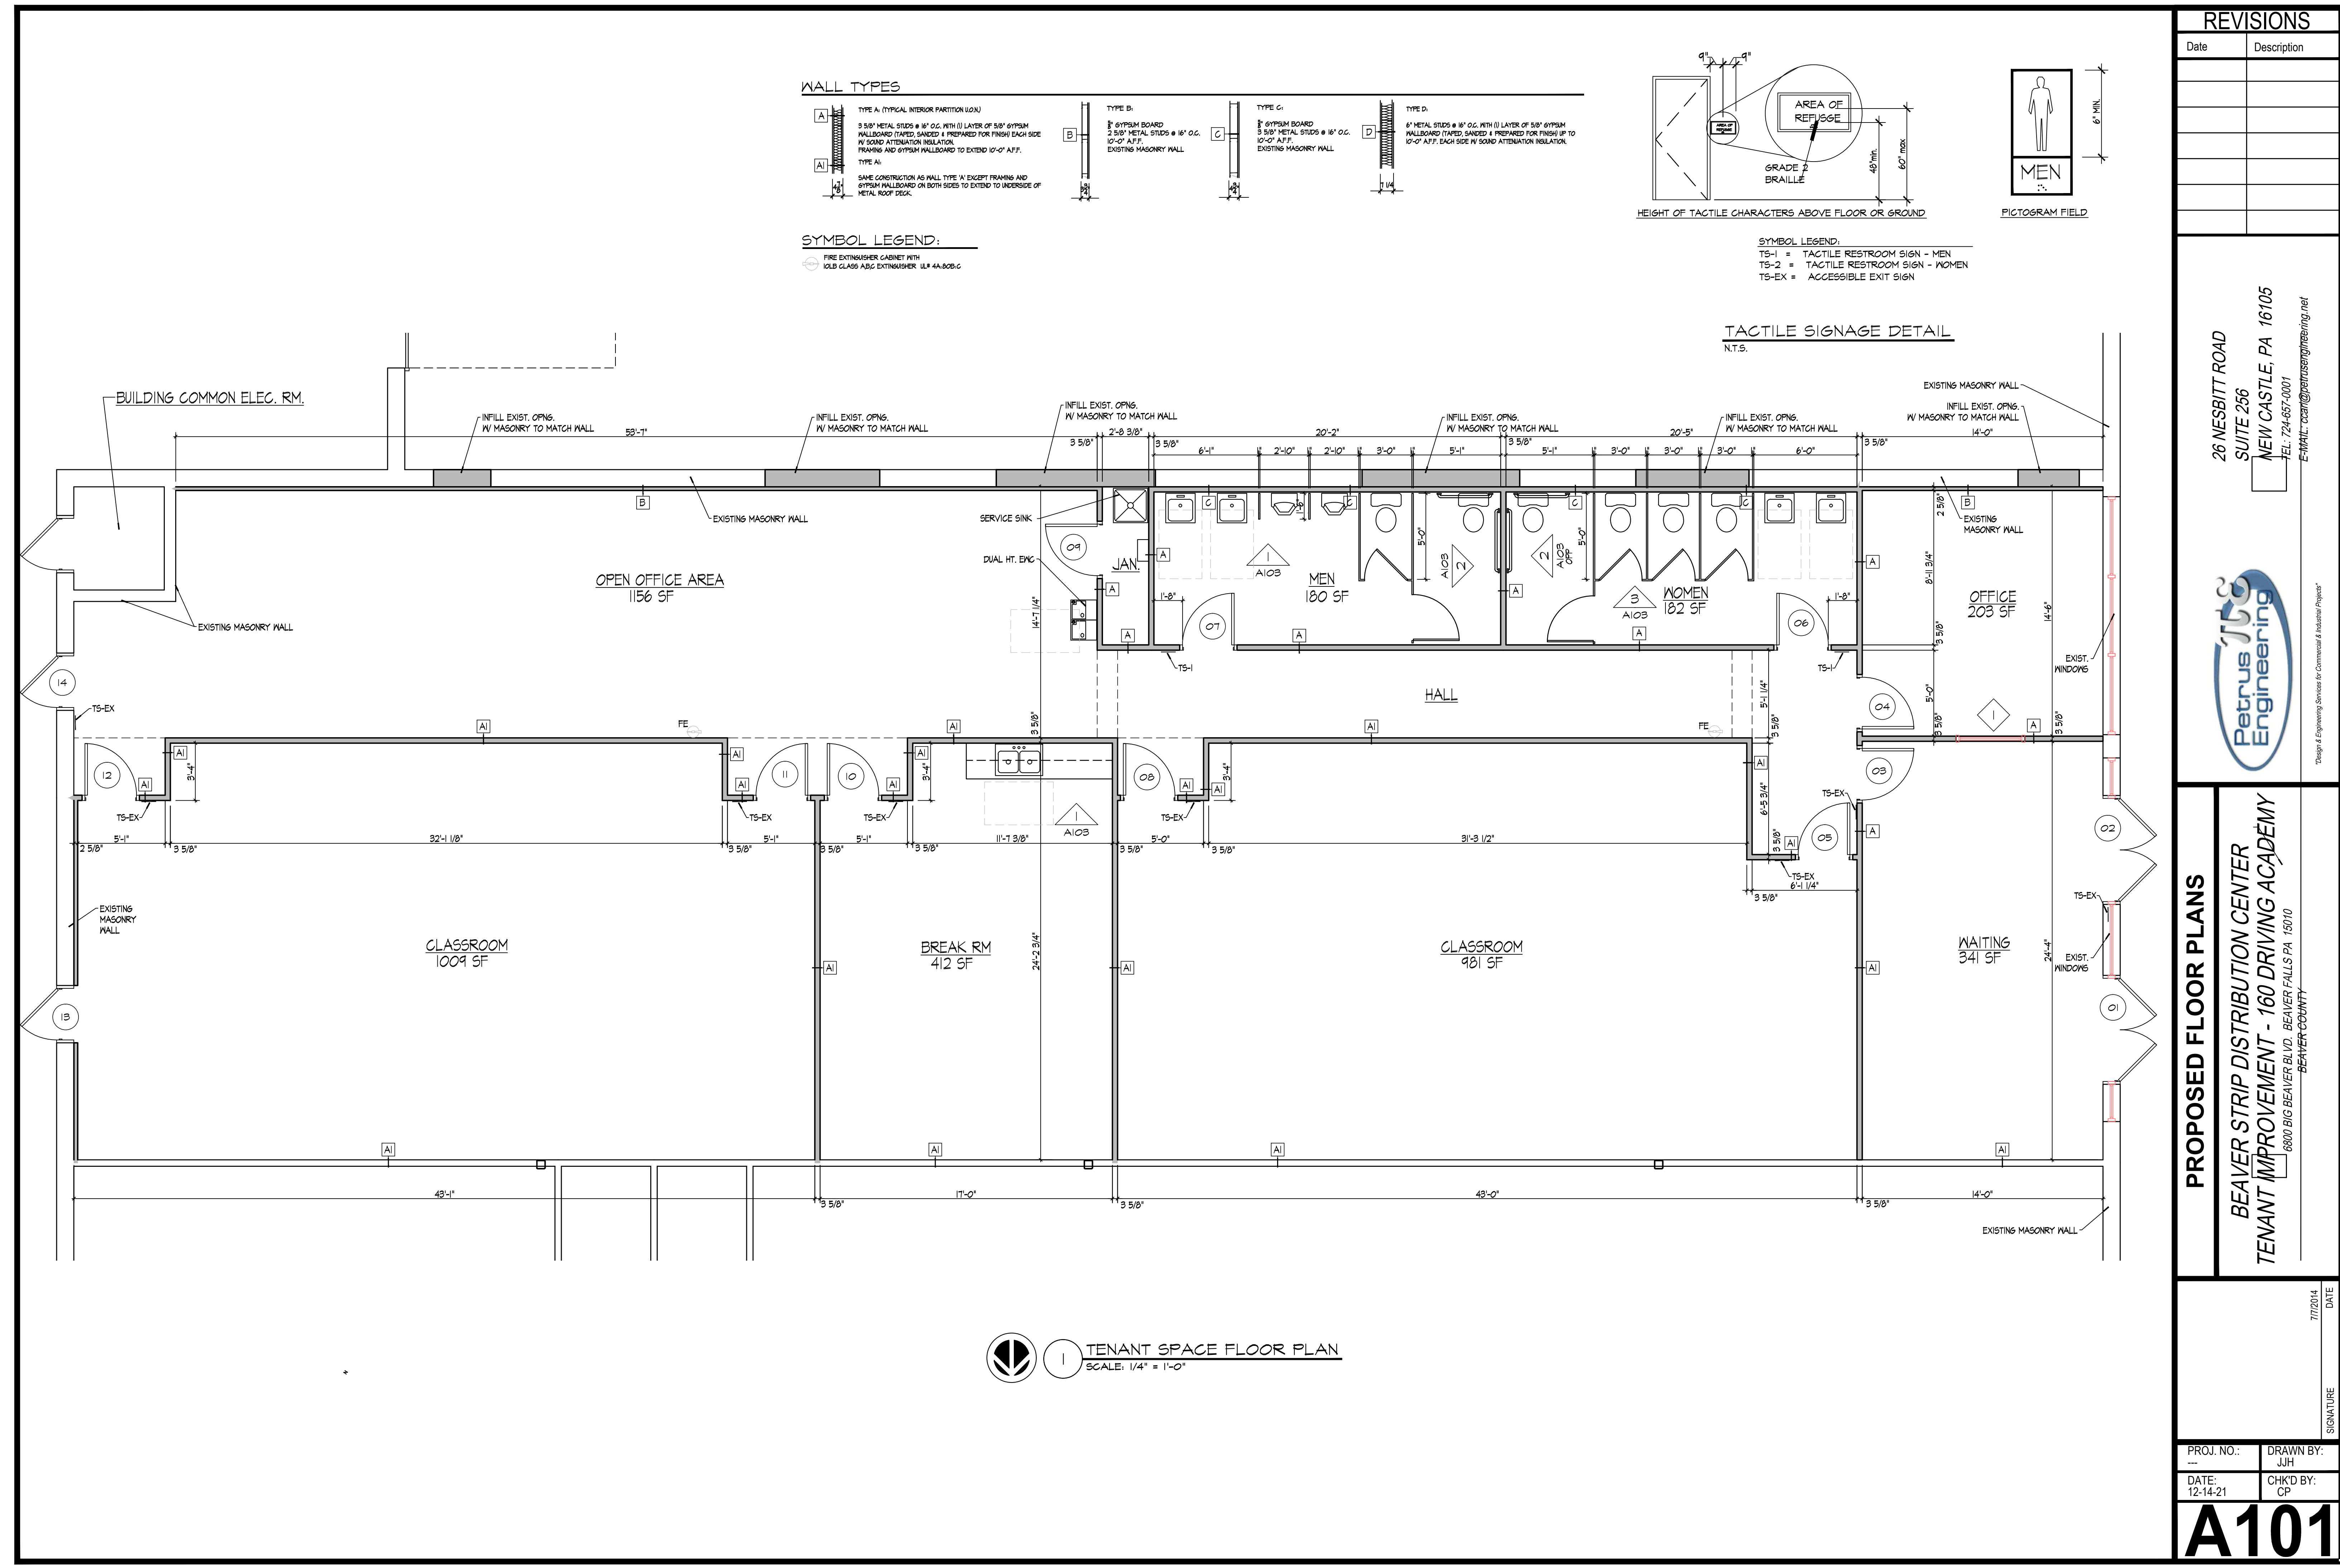


WALL TYPES

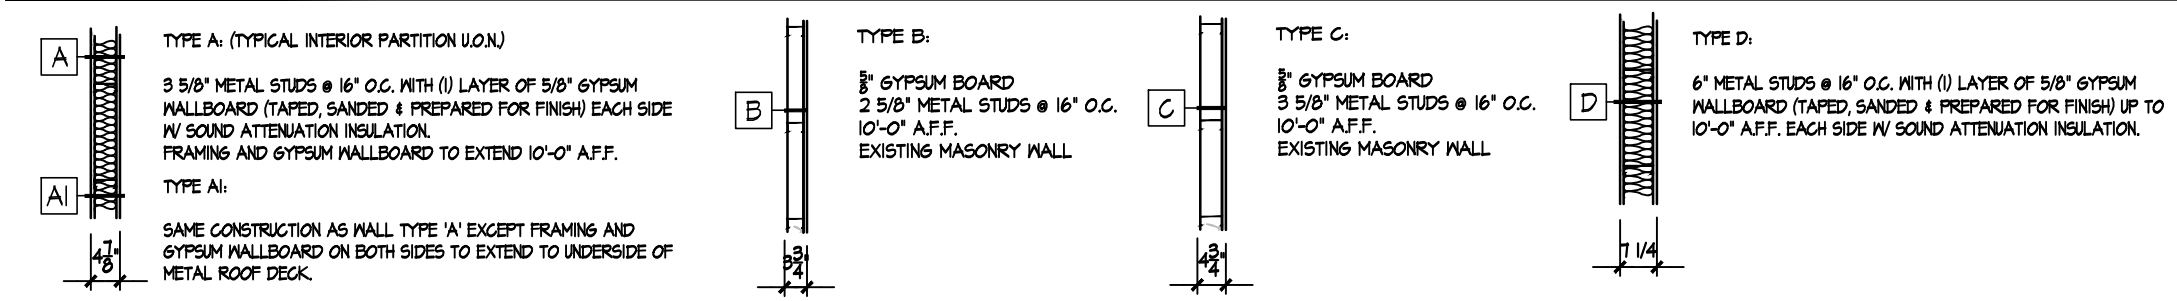

SYMBOL LEGEND:

Fire extinguisher cabinet with 10LB class ABC extinguisher ULF 4A-BBC-C

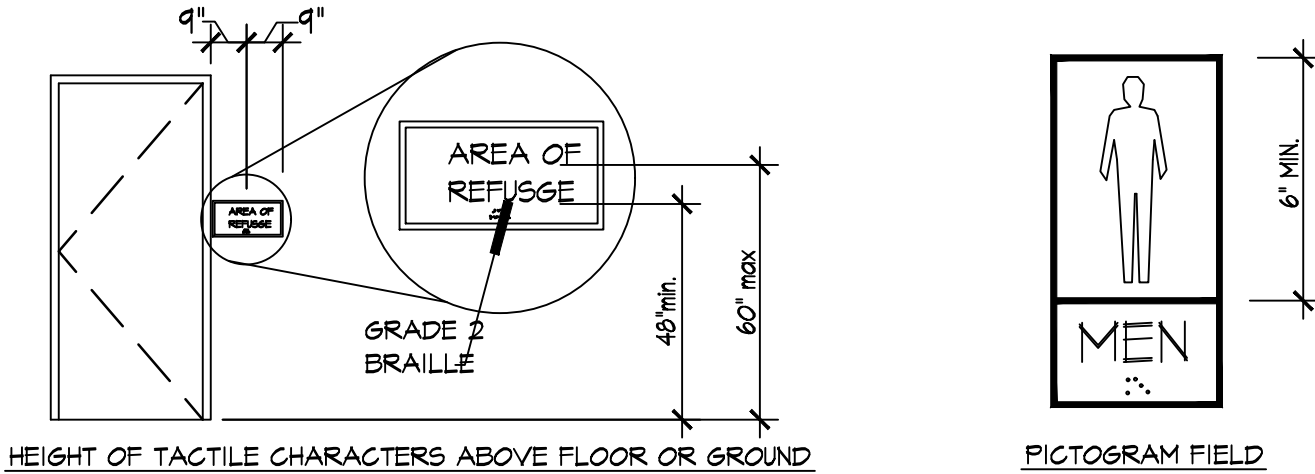

SYMBOL LEGEND:

TS-1 = Tactile Restroom Sign - Men
TS-2 = Tactile Restroom Sign - Women
TS-EX = Accessible Exit Sign

TACTILE SIGNAGE DETAIL

N.T.S.

REVISIONS

Date	Description

26 NESBITT ROAD
SUITE 256
NEW CASTLE, PA 16105
TEL: 724-657-0001
E-MAIL: ccc@petrusengineering.net



Petrus Engineering
Design & Engineering Services for Commercial & Industrial Projects

PROPOSED FLOOR PLANS

BEAVER STRIP DISTRIBUTION CENTER
TENANT IMPROVEMENT - 160 DRIVING ACADEMY

6800 BIG BEAVER BLVD. BEAVER FALLS PA 15010
BEAVER COUNTY

7/7/2014
DATE

SIGNATURE

PROJ. NO.:

DATE:
12-14-21

DRAWN BY:
JJH

CHK'D BY:
CP

A101