


# AS-BUILT DOCUMENTATION

## 3711 E Silver Springs Blvd. Ocala, FL 34470

### DRAWING INDEX

- C-1 COVER SHEET | DRAWING INDEX
- SL SYMBOLS LEGEND
- AB-1 OVERALL FLOOR PLAN
- AB-2 AREA "A" FLOOR PLAN  $\frac{3}{32}$ "
- AB-3 AREA "B" FLOOR PLAN  $\frac{3}{32}$ "
- AB-4 AREA "C" FLOOR PLAN  $\frac{3}{32}$ "
- AB-5 AREA "D" FLOOR PLAN  $\frac{3}{32}$ "

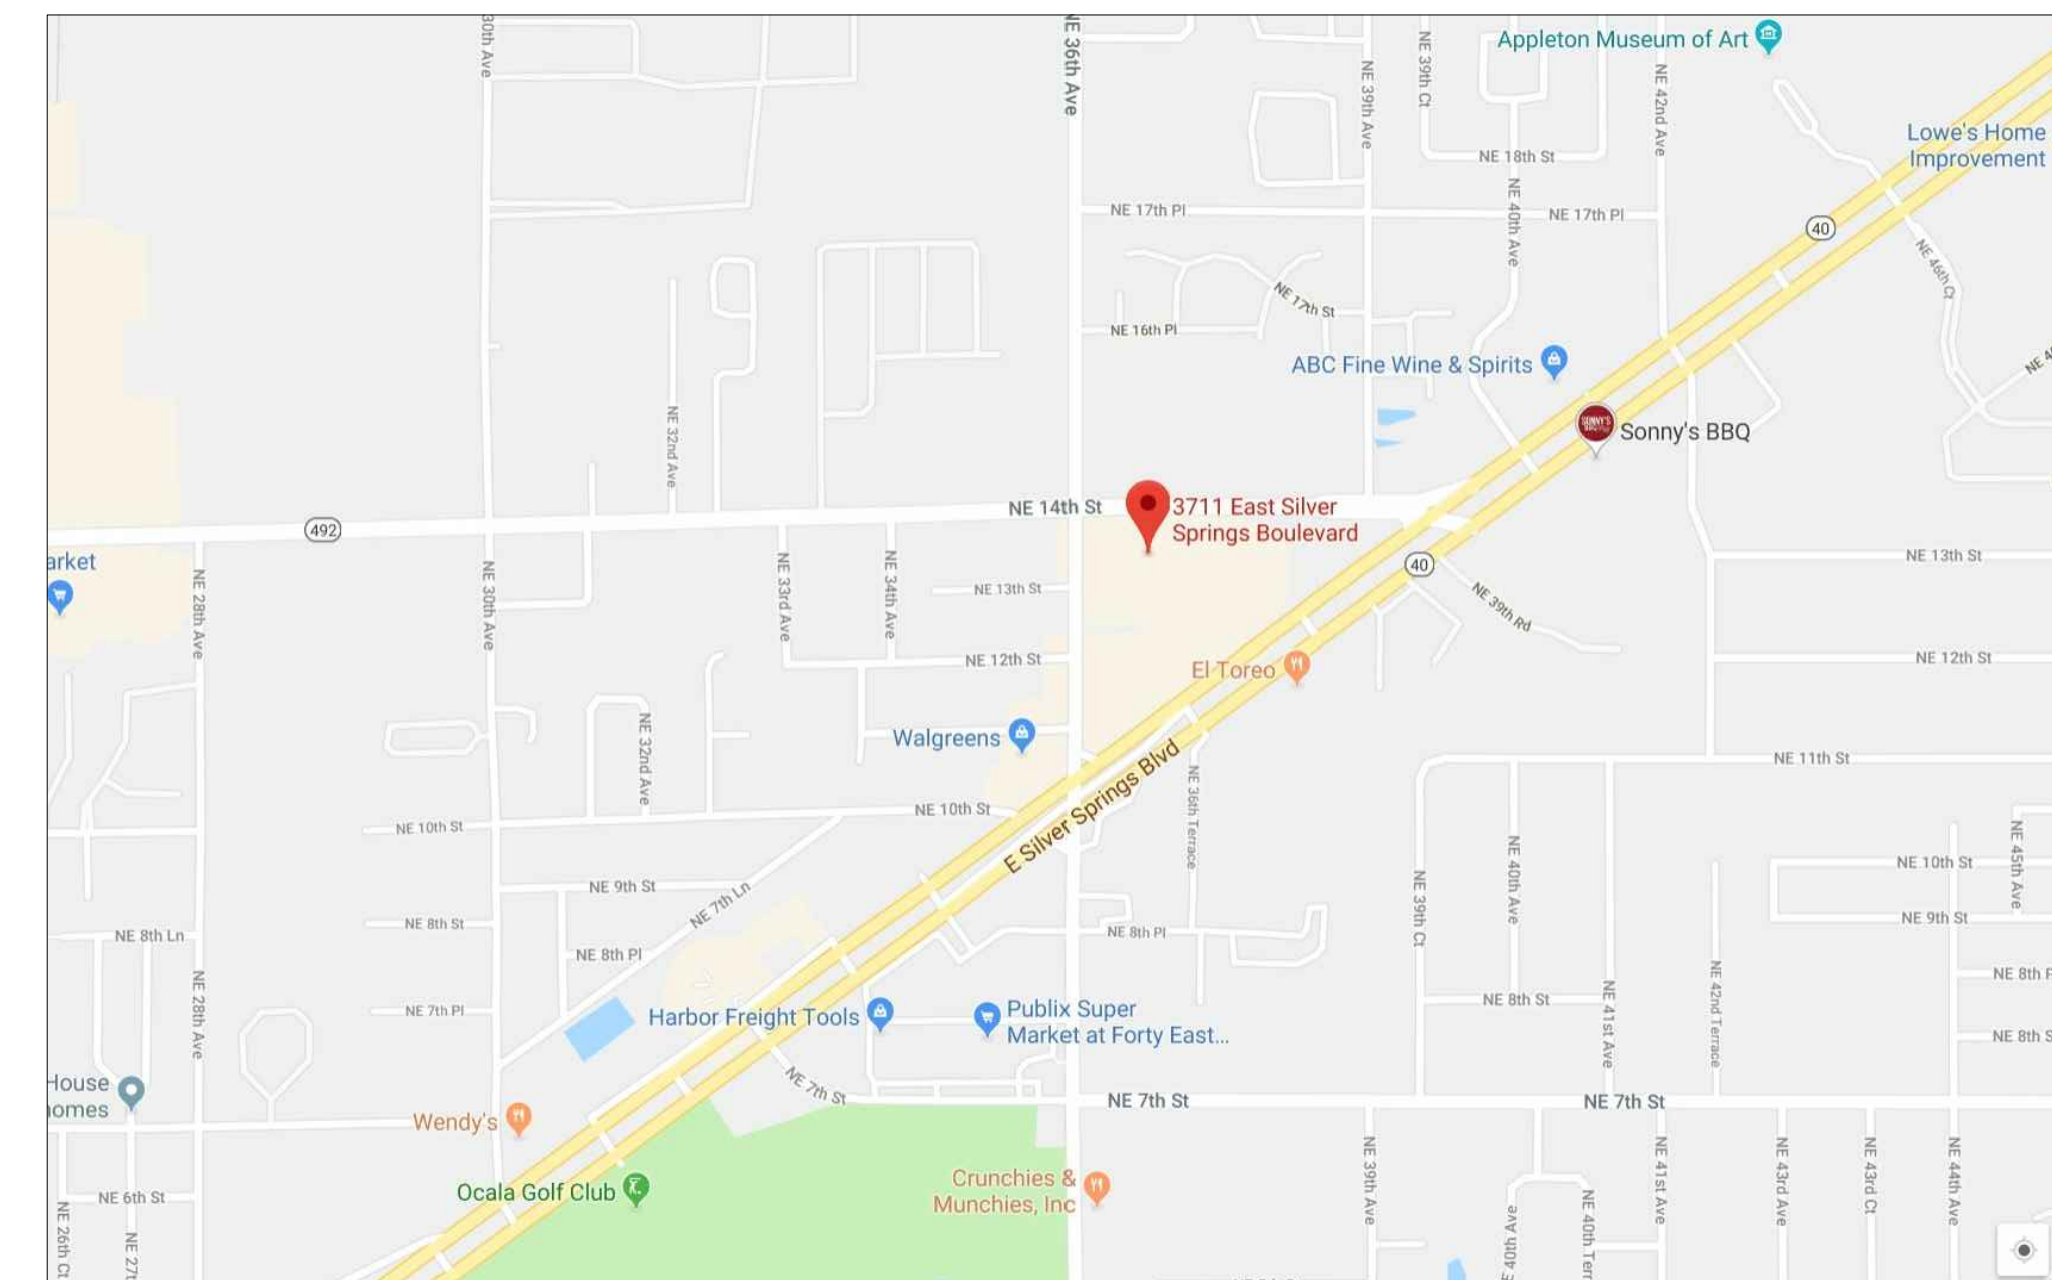

VICINITY MAP  
NTS

AREA DATA	
FIRST FLOOR	112,809 S.F. ±
SECOND FLOOR	NOT INCLUDED
GATED FENCED GARDEN AREA	NOT INCLUDED
COVERED ENTRIES	NOT INCLUDED
COVERED LOADING AREAS	NOT INCLUDED
GRAND TOTAL	NOT INCLUDED

**ARCHITECTURAL AS BUILT**  
**3711 E Silver Springs Blvd.**  
**Ocala, FL 34470**

**100% SUBMITTAL**

**MARCH 6, 2019**

O1	100% SUBMISSION	SEE COVER SHEET
NO.	ISSUES   REVISIONS	DATE

**COVER SHEET**

HL	PROJECT MANAGER
HL	PROJECT DIRECTOR
012318-1	PROJECT NUMBER
	SCALE
CL	DRAWN BY
	SHEET NUMBER

**C-1**

# SYMBOLS LEGEND

## RCP

	EXHAUST VENT		TRACK LIGHT OR VANITY LIGHT
	CEILING MOUNTED LIGHT FIXTURE		WALL-MOUNTED LIGHT FIXTURE
	CEILING MOUNTED DIRECTIONAL LIGHT		EMERGENCY EXIT SIGN
	RECESSED CAN LIGHT		EMERGENCY EXIT LIGHT
	EYEBALL OR SMALL CAN LIGHT		EMERGENCY EXIT LIGHT W/ SIGN
	PENDANT LIGHT		LIGHTED STAIR SIGN
	INDIVIDUAL FLUOR. LAY-IN FIXTURE 4 BULB		FLOOD LIGHT
	INDIVIDUAL FLUOR. HANGING FIXTURE 2 BULB		PHOTO CELL
	INDIVIDUAL FLUOR. FLUSH MOUNT FIXTURE 4 BULB		CEILING FAN
	CAMERA		CEILING FAN W/ LIGHT KIT
	MOTION DET.	<b>7-2-6</b>	CEILING HEIGHT AND TRIM 7'-2" ABOVE FLOOR BELOW WITH 6" CROWN MOULDING. NOTE: ALL CEILINGS NOT LABELED ARE PLASTER. CEILINGS SHOWN WITH A GRID ARE LAY IN ACOUSTICAL TILE..
	SUPPLY VENT		JUNCTION BOX
	SUPPLY VENT		
	RETURN VENT		
	RETURN VENT		
	SPEAKER		

## ELECTRIC

	DATA OUTLET
	TELEPHONE JACK
	ELECTRIC SWITCH
	CABLE TELEVISION OUTLET
	DUPLEX RECEPTACLE OUTLET
	SPECIAL PURPOSE CONNECTION OR OUTLET
	QUADRUPLEX RECEPTACLE OUTLET
	FLOOR DUPLEX RECEPTACLE OUTLET
	ELECTRIC PANEL
	ELECTRIC METER
	BUTTON SWITCH
	DISCONNECT SWITCH
	GROUND/FLOOR LIGHT
	KEY PAD

## FIRE PROTECTION



	FIRE EXTINGUISHER
	FIRE PULL
	FIRE ALARM (HORN/SRTO)
	SMOKE DETECTOR
	SMOKE ALARM SPEAKER
	SPRINKLER HEAD CEILING MOUNT
	SPRINKLER HEAD WALL MOUNT

## MEP


	THERMOSTAT
	FLOOR DRAIN
	VALVE
	HOSE BIB
	WATER SUPPLY
	SUSPENDED GAS HEATER

## MISC

	BOLLARD
	11-4-11/16 SPOT ELEVATION

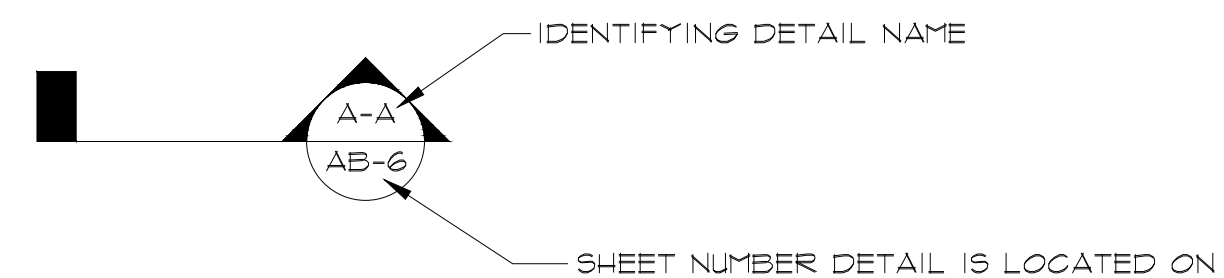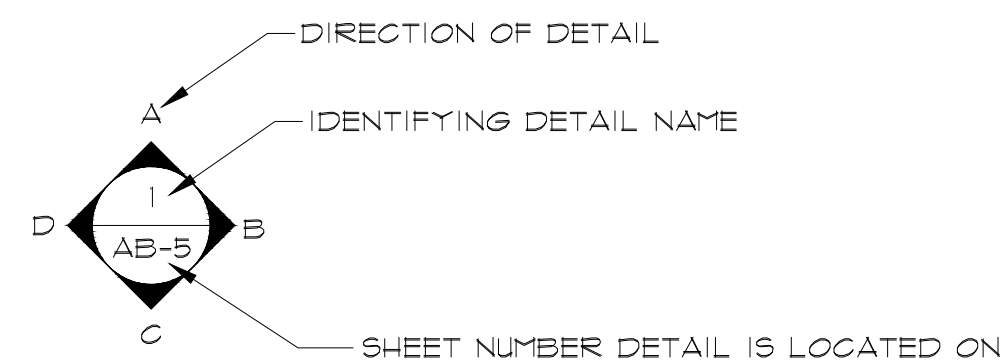

## PHOTO DOCUMENTATION LEGEND

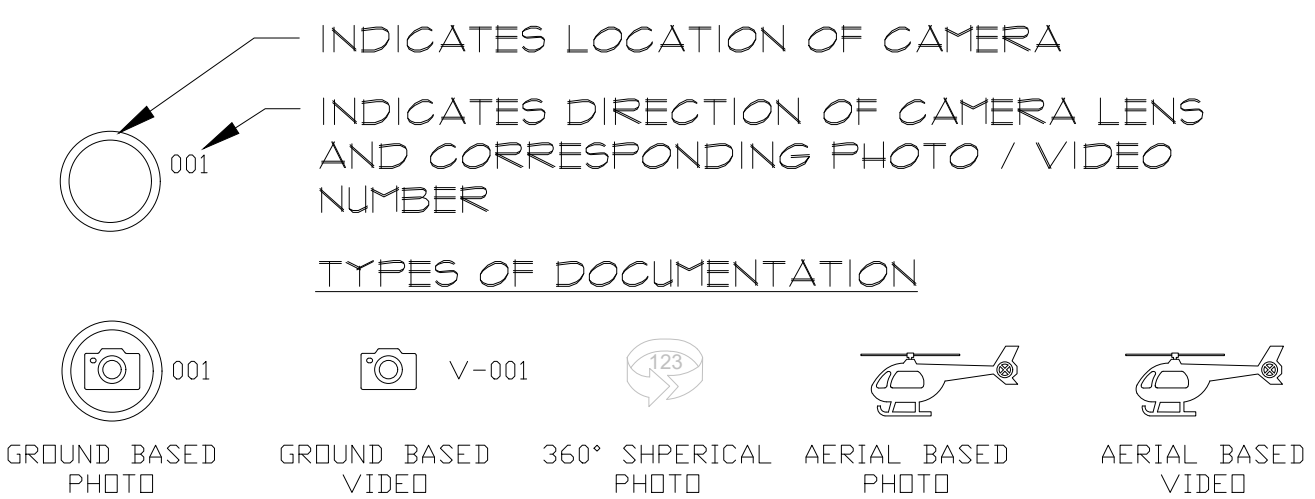


**ARCHITECTURAL AS BUILT**  
**3711 E Silver Springs Blvd.**  
**Ocala, FL 34470**

01	100% SUBMISSION	SEE COVER SHEET
NO.	ISSUES   REVISIONS	DATE

SHEET TITLE

HL	PROJECT MANAGER
HL	PROJECT DIRECTOR
012318-1	PROJECT NUMBER
<b>NO SCALE</b>	SCALE
CL	DRAWN BY
	SHEET NUMBER

**SL**

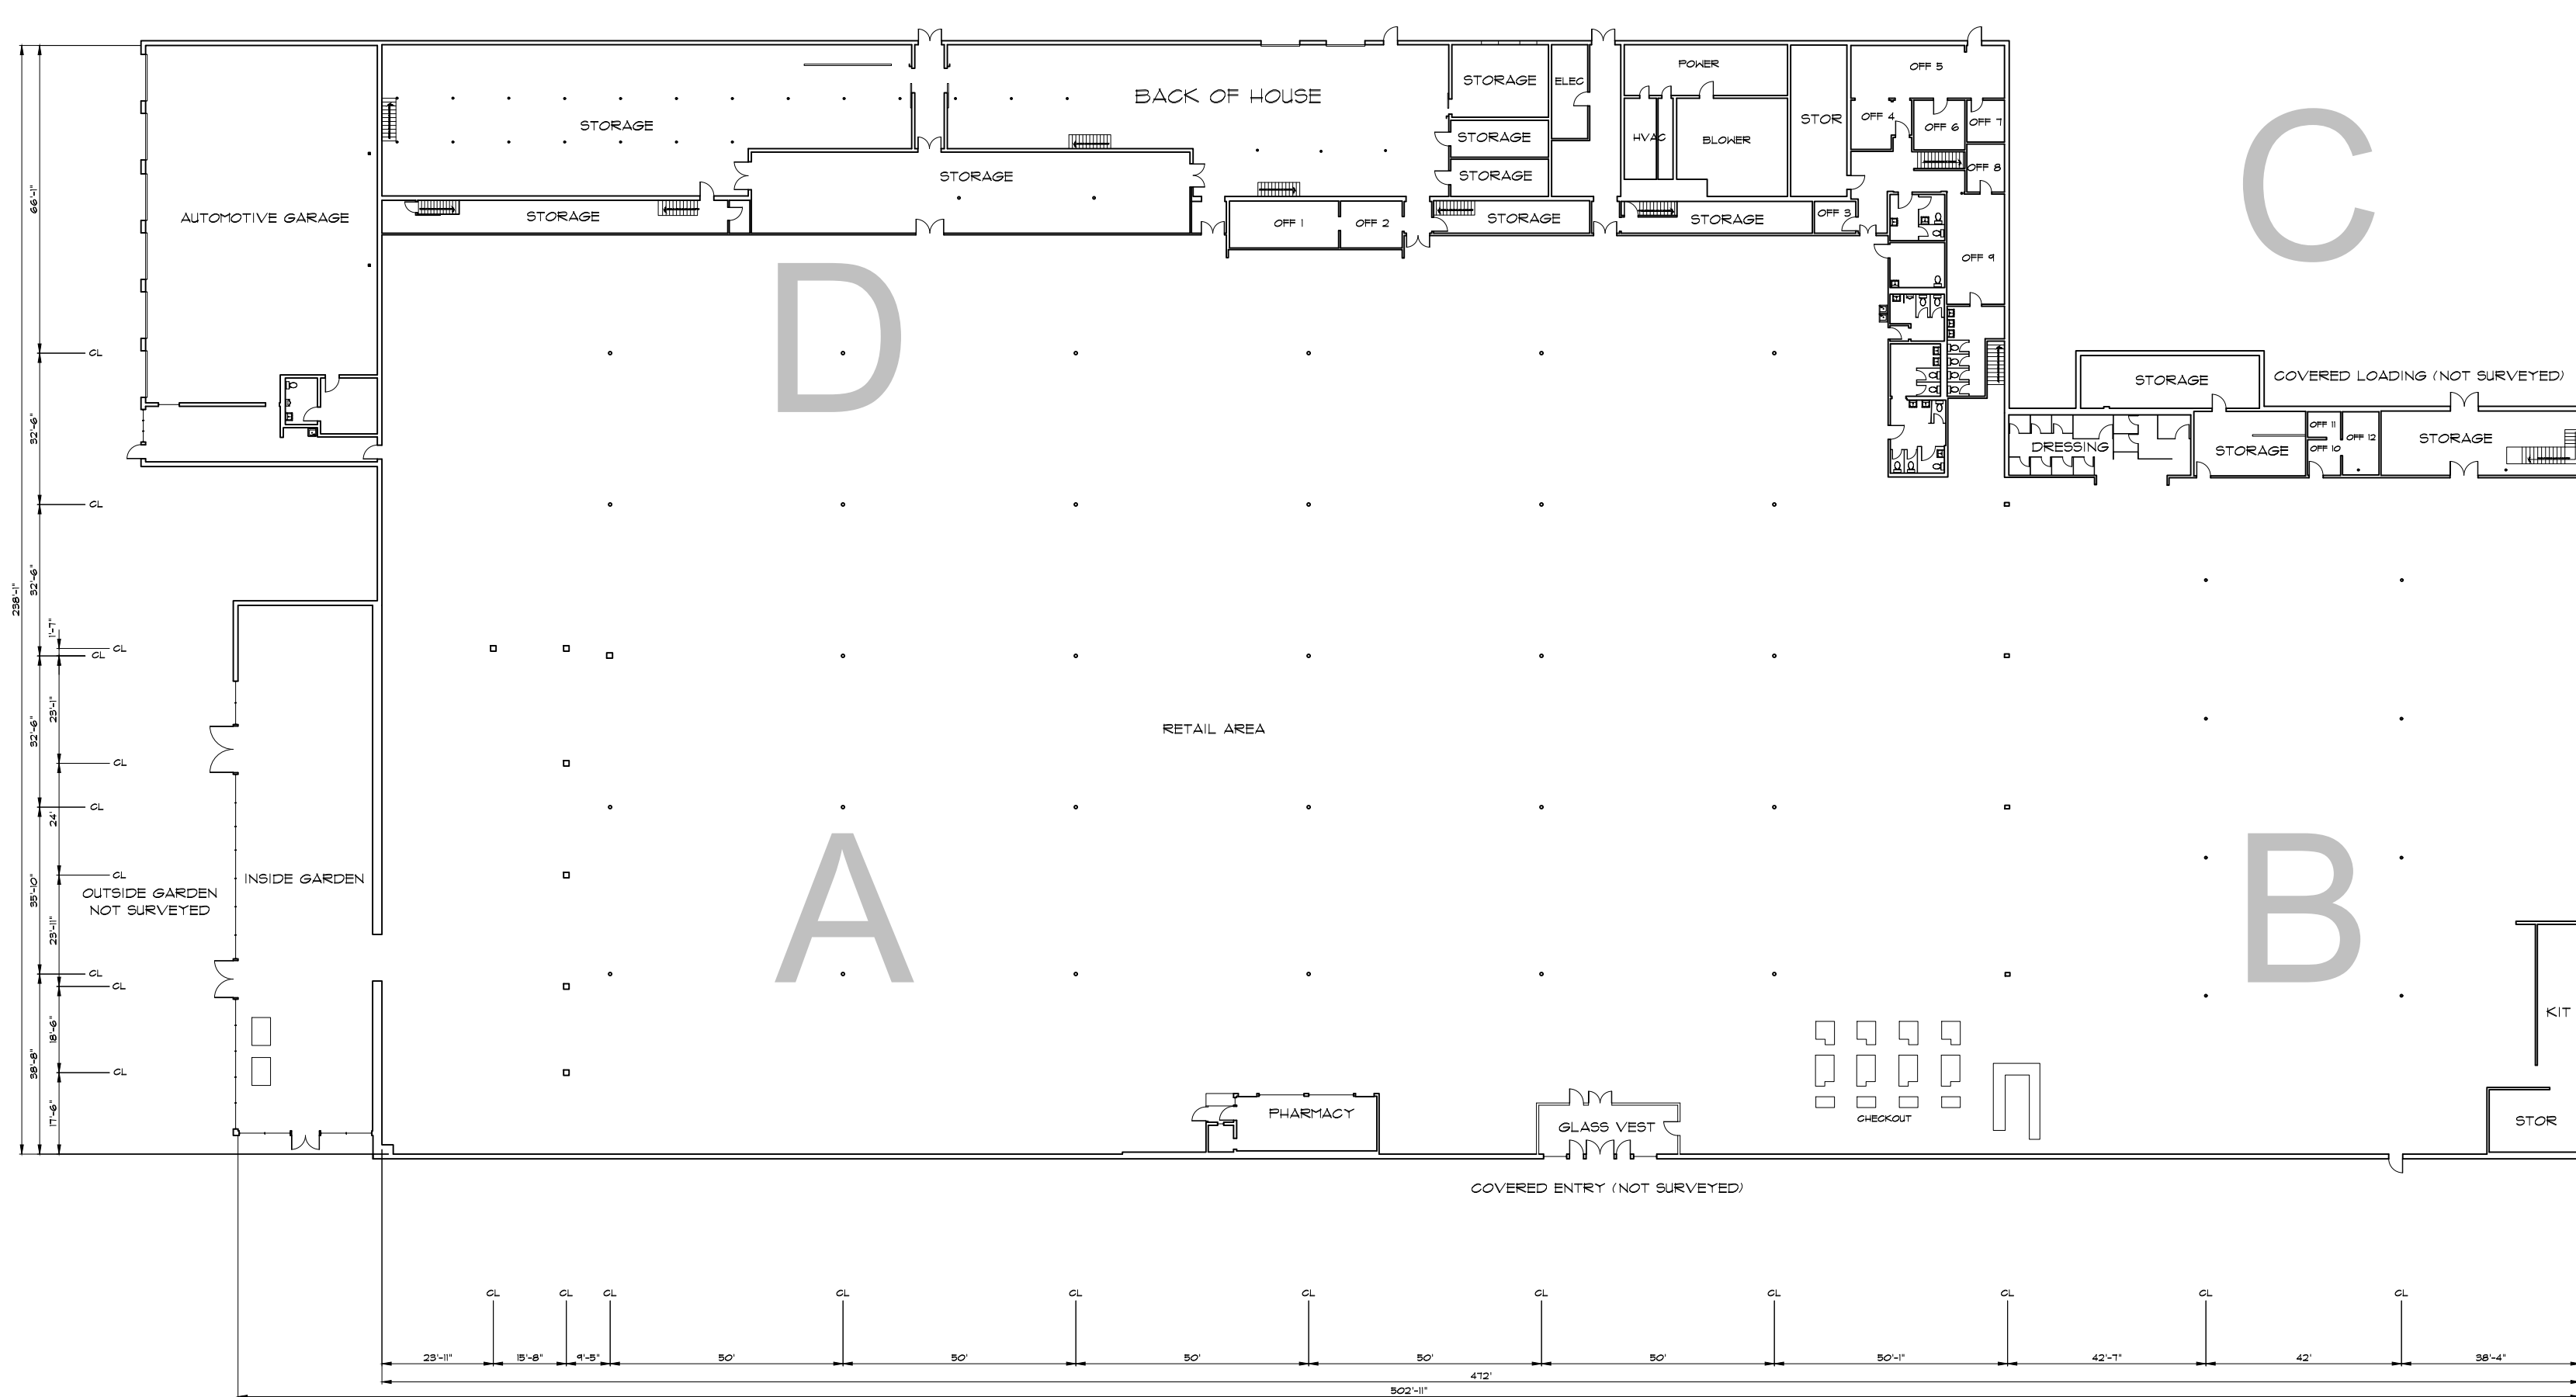

FIRST FLOOR PLAN


**ARCHITECTURAL AS BUILT**  
**3711 E Silver Springs Blvd.**  
**Ocala, FL 34470**

01	100% SUBMISSION	SEE COVER SHEET
NO.	ISSUES   REVISIONS	DATE

HL	PROJECT MANAGER
HL	PROJECT DIRECTOR
012318-1	PROJECT NUMBER
1/32"=1'-0"	SCALE
CL	DRAWN BY
	SHEET NUMBER

**AB-1**

**ARCHITECTURAL AS BUILT**  
**3711 E Silver Springs Blvd.**  
**Ocala, FL 34470**

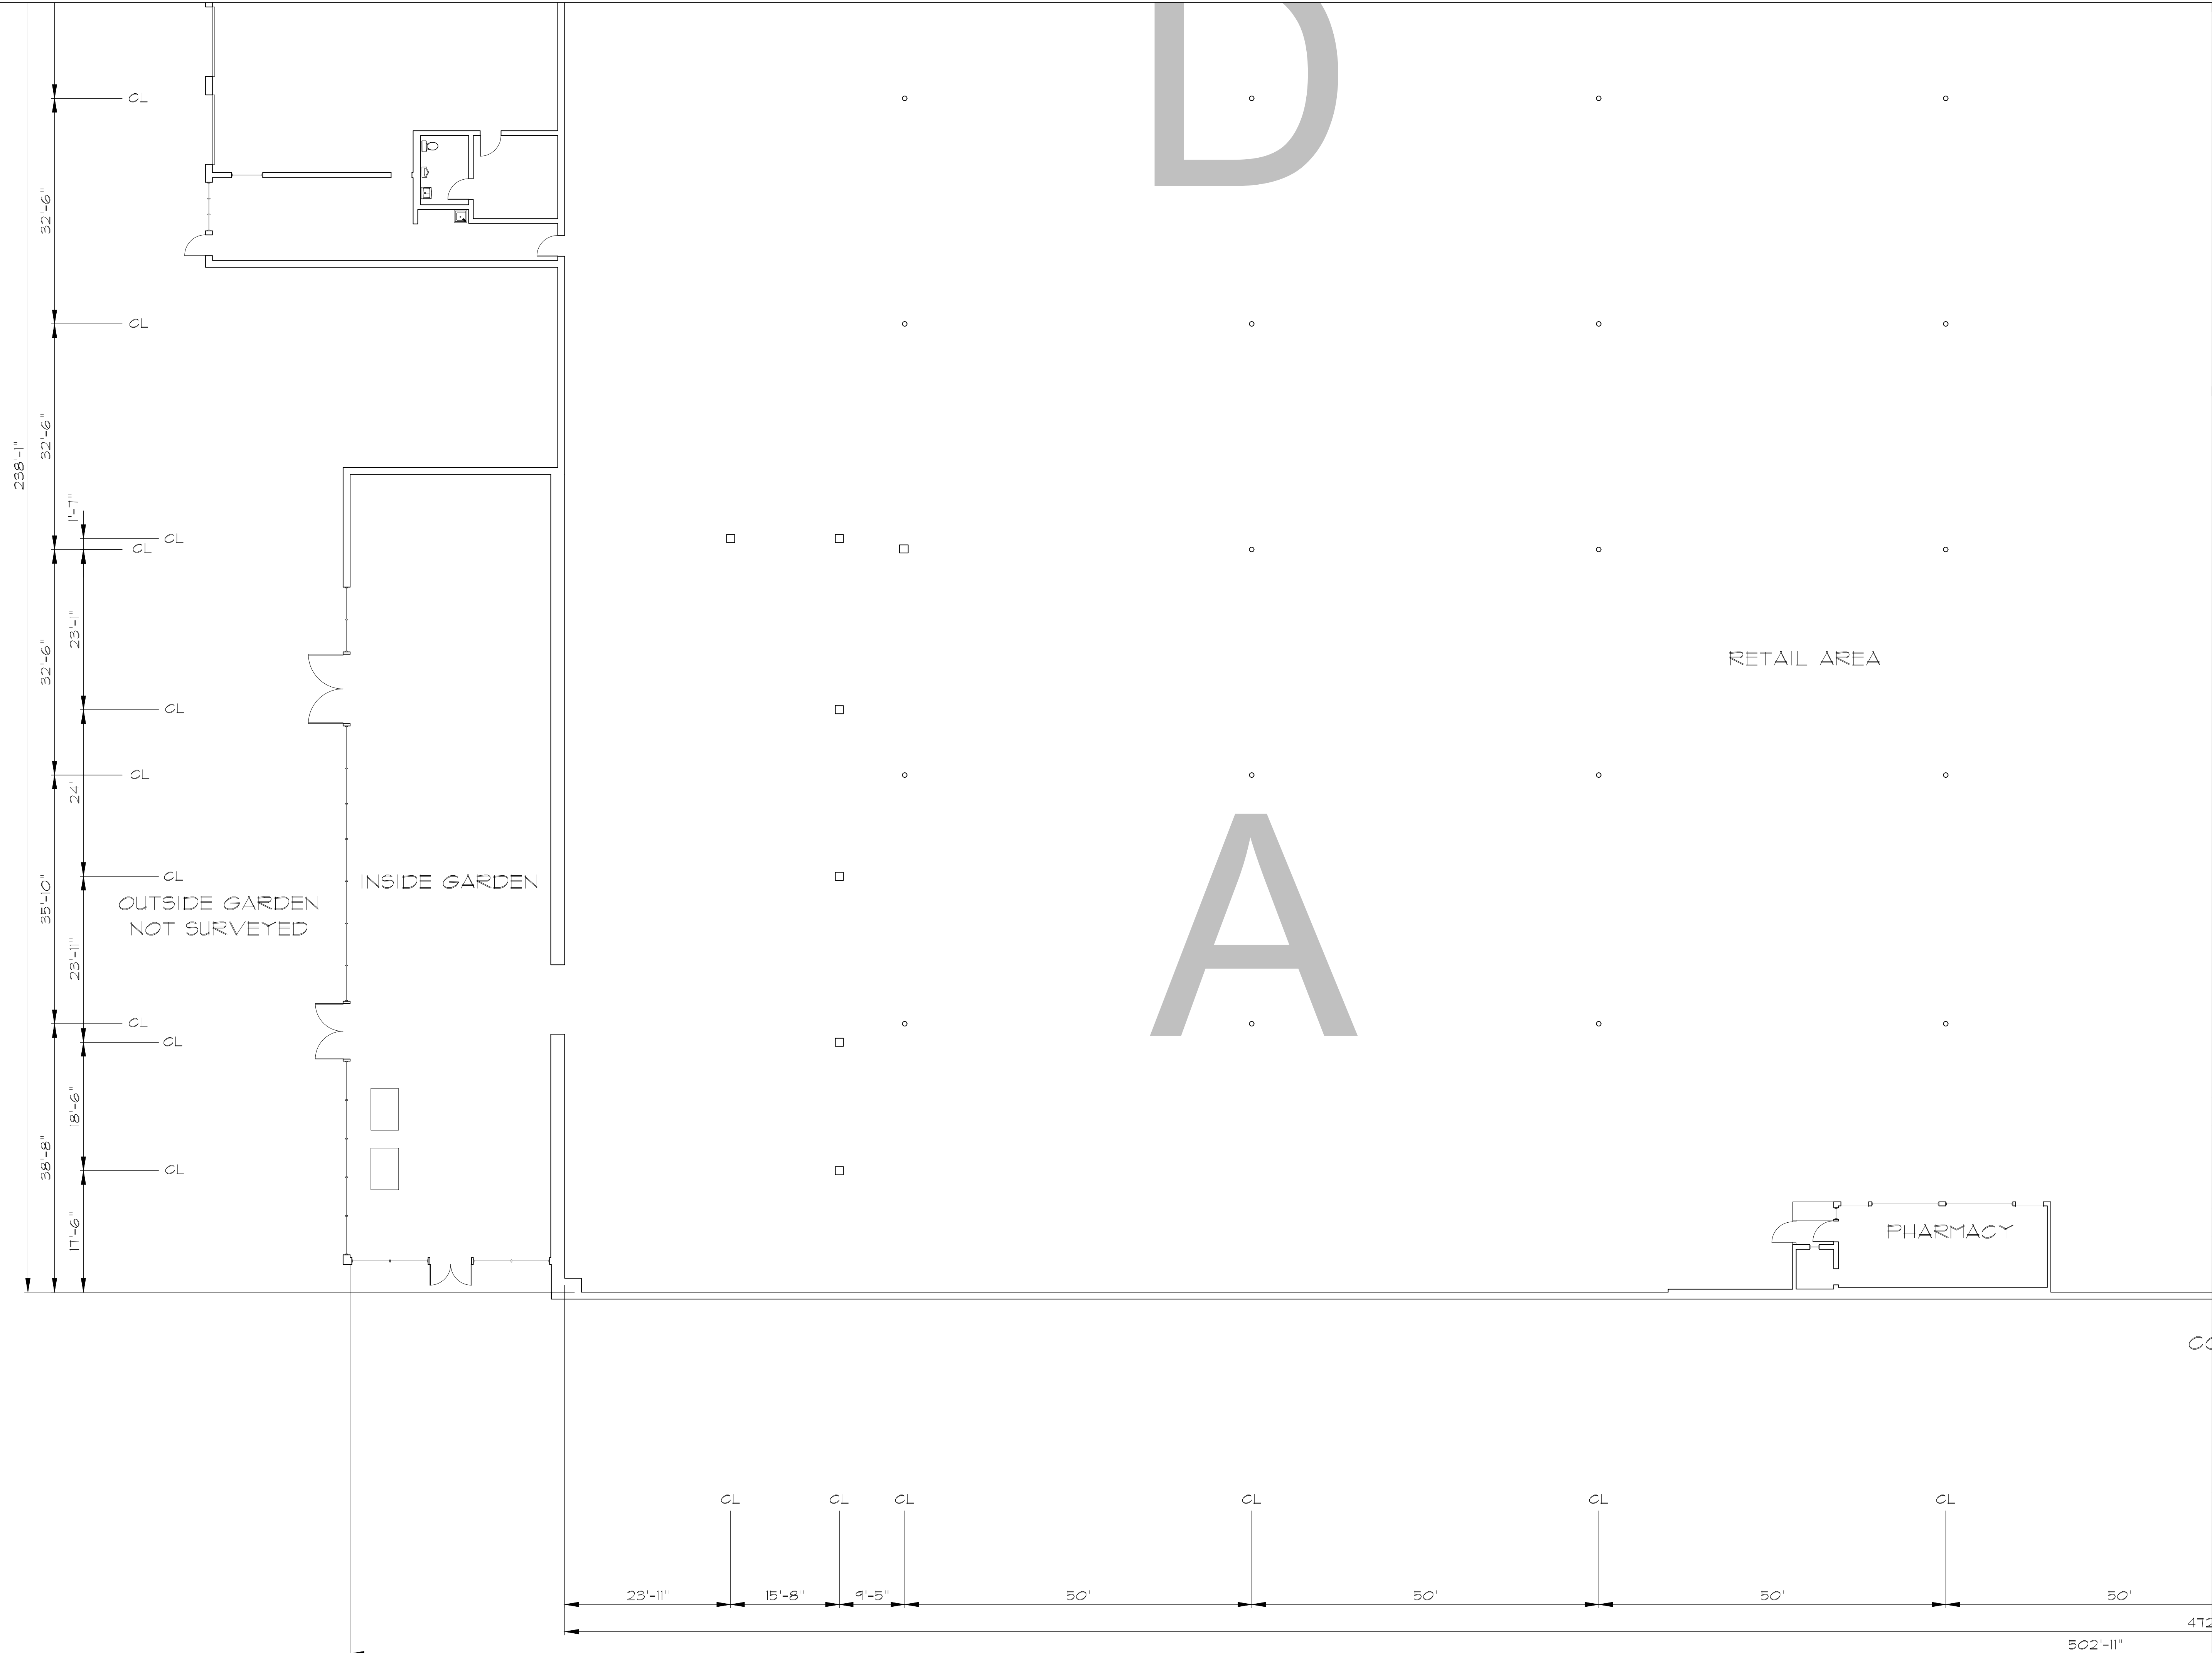


NO.	ISSUES   REVISIONS	DATE	SHEET TITLE
01	100% SUBMISSION		SEE COVER SHEET

HL	PROJECT MANAGER
HL	PROJECT DIRECTOR
012318-1	PROJECT NUMBER
3/32"=1'-0"	SCALE
CL	DRAWN BY
	SHEET NUMBER

**AB-2**



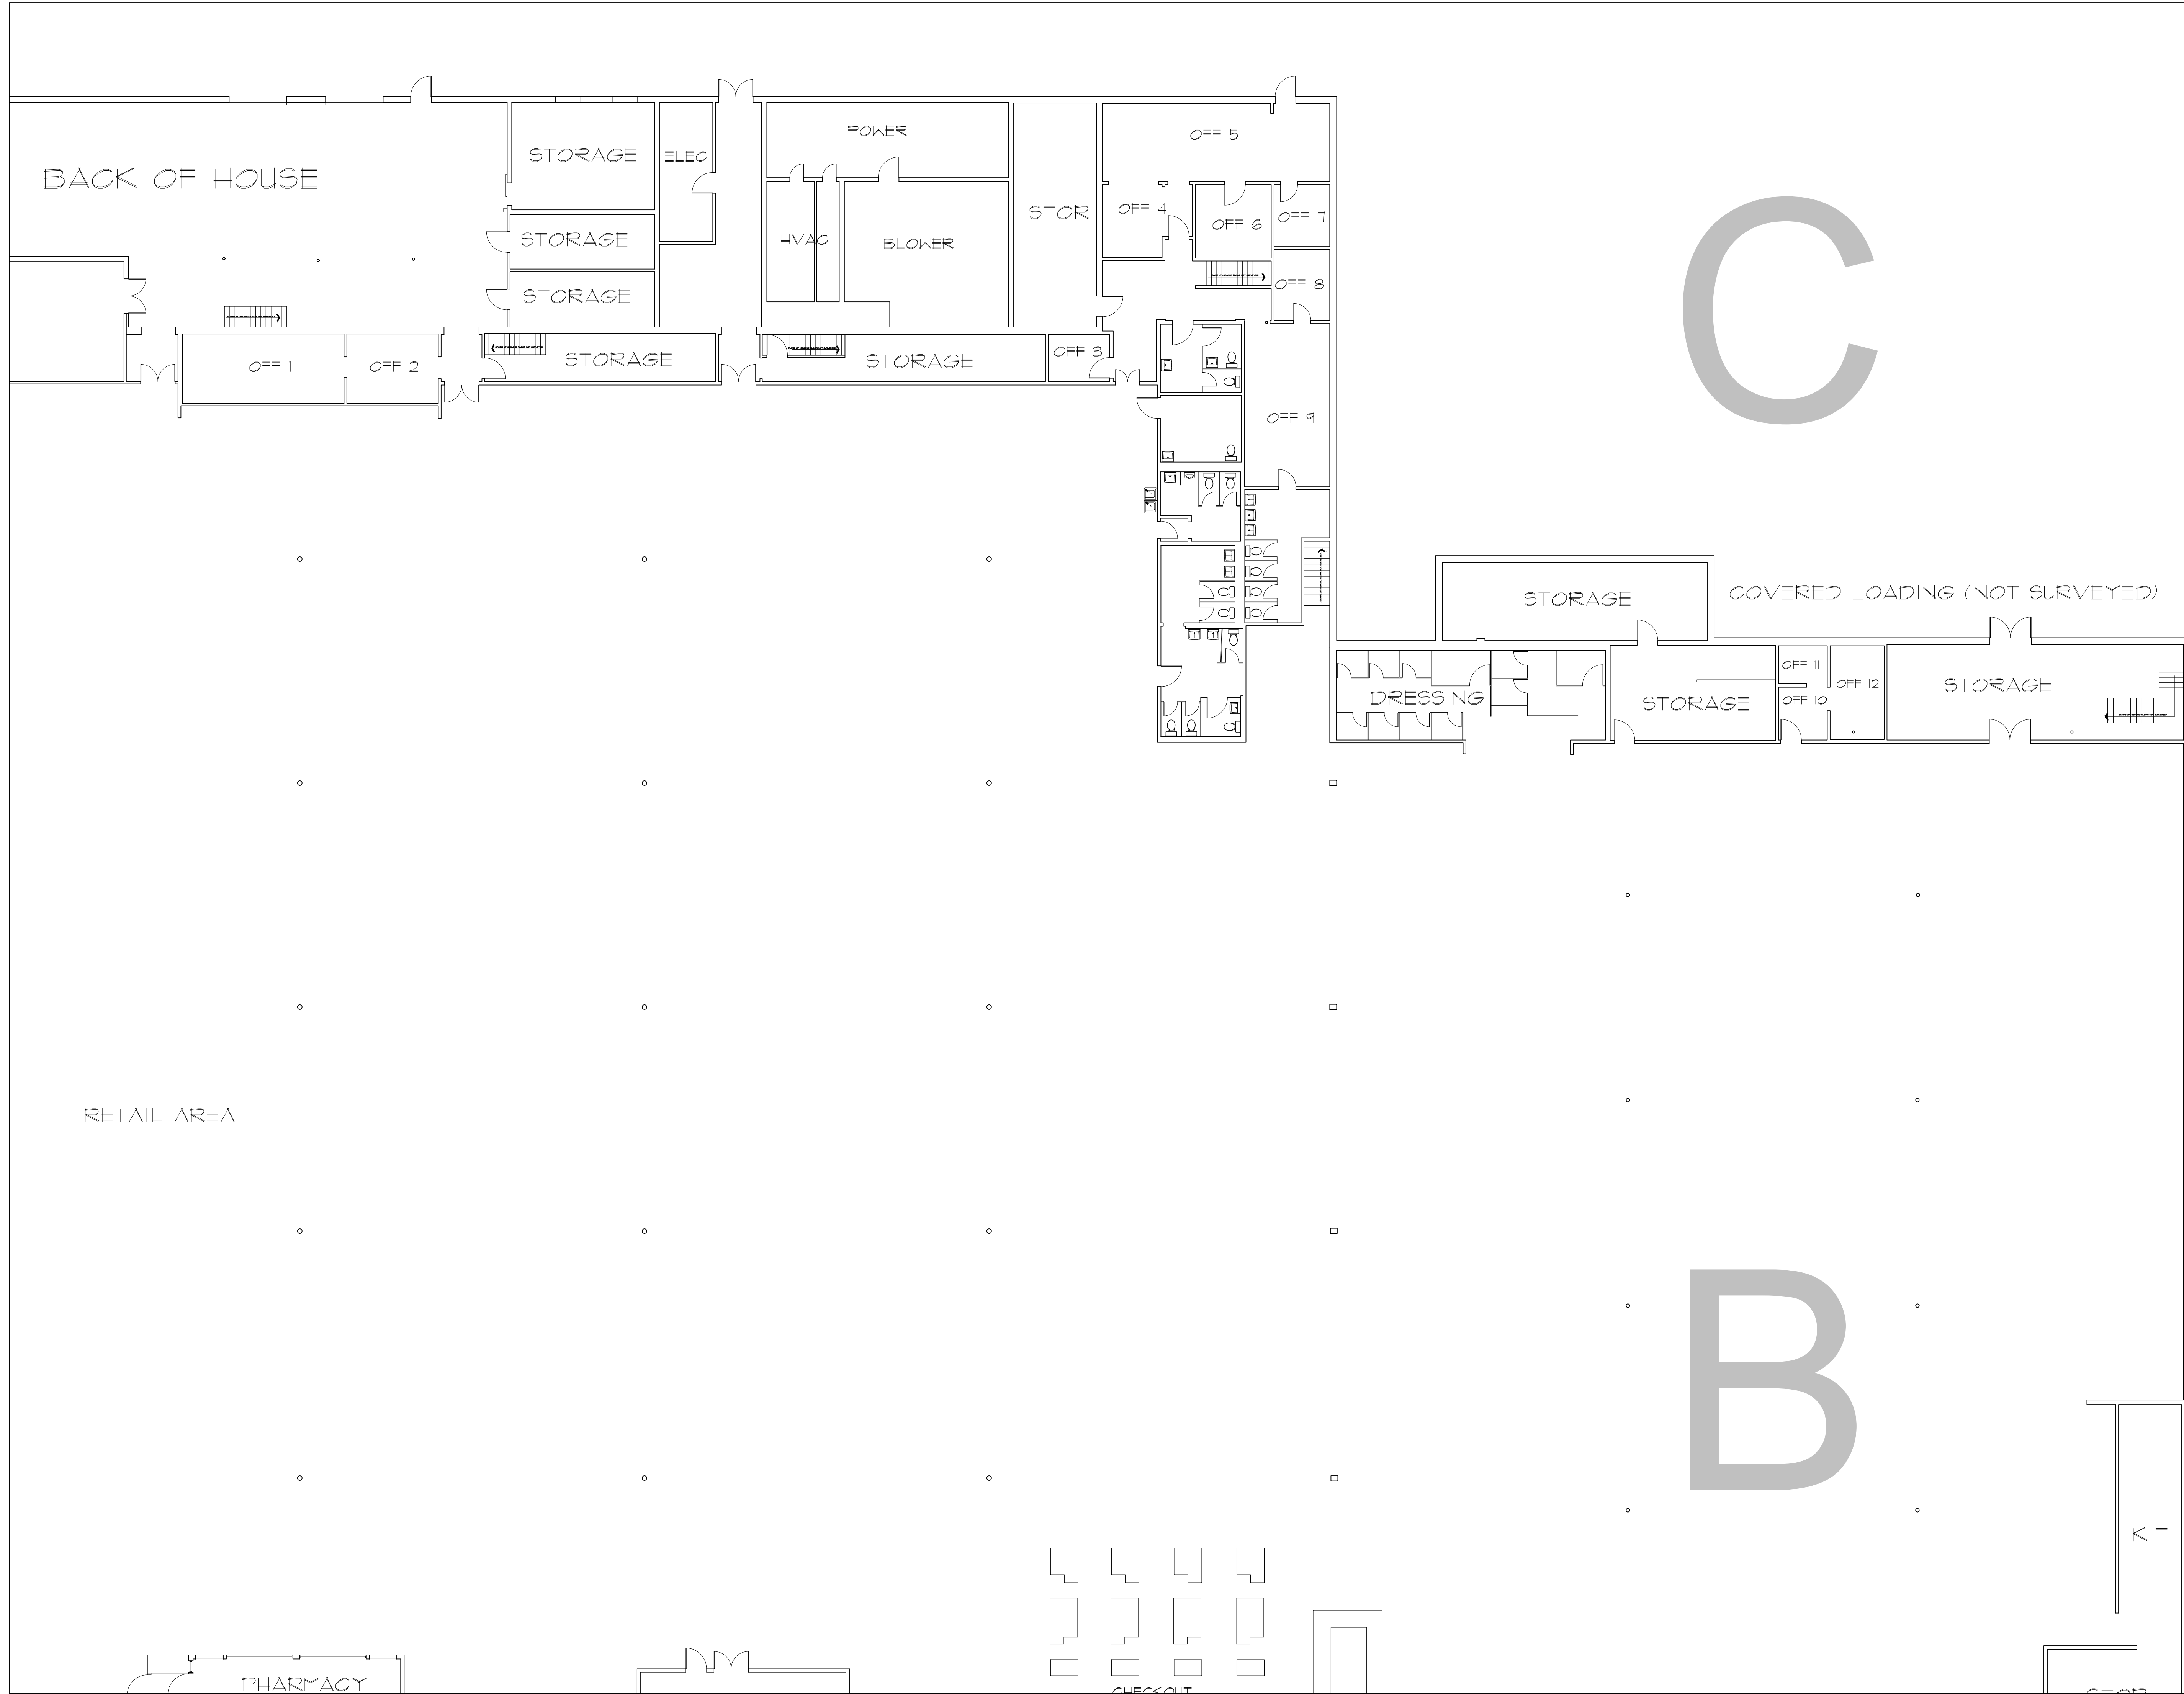

**AS BUILT**  
**PROFESSIONALS**  
 www.asbuiltprofessionals.com  
 A DIVISION OF:


**AEC**  
 CONSULTANTS  
 INC  
 844.272.8458  
 844 ASBUILT

© 2014 AEC CONSULTANTS INC

**ARCHITECTURAL AS BUILT**  
**3711 E Silver Springs Blvd.**  
**Ocala, FL 34470**

01	100% SUBMISSION	SEE COVER SHEET
NO.	ISSUES   REVISIONS	DATE
SHEET TITLE		
HL	PROJECT MANAGER	
HL	PROJECT DIRECTOR	
012318-1	PROJECT NUMBER	
3/32"=1'-0"	SCALE	
CL	DRAWN BY	
SHEET NUMBER		
<b>AB-4</b>		

**ARCHITECTURAL AS BUILT**  
**3711 E Silver Springs Blvd.**  
**Ocala, FL 34470**

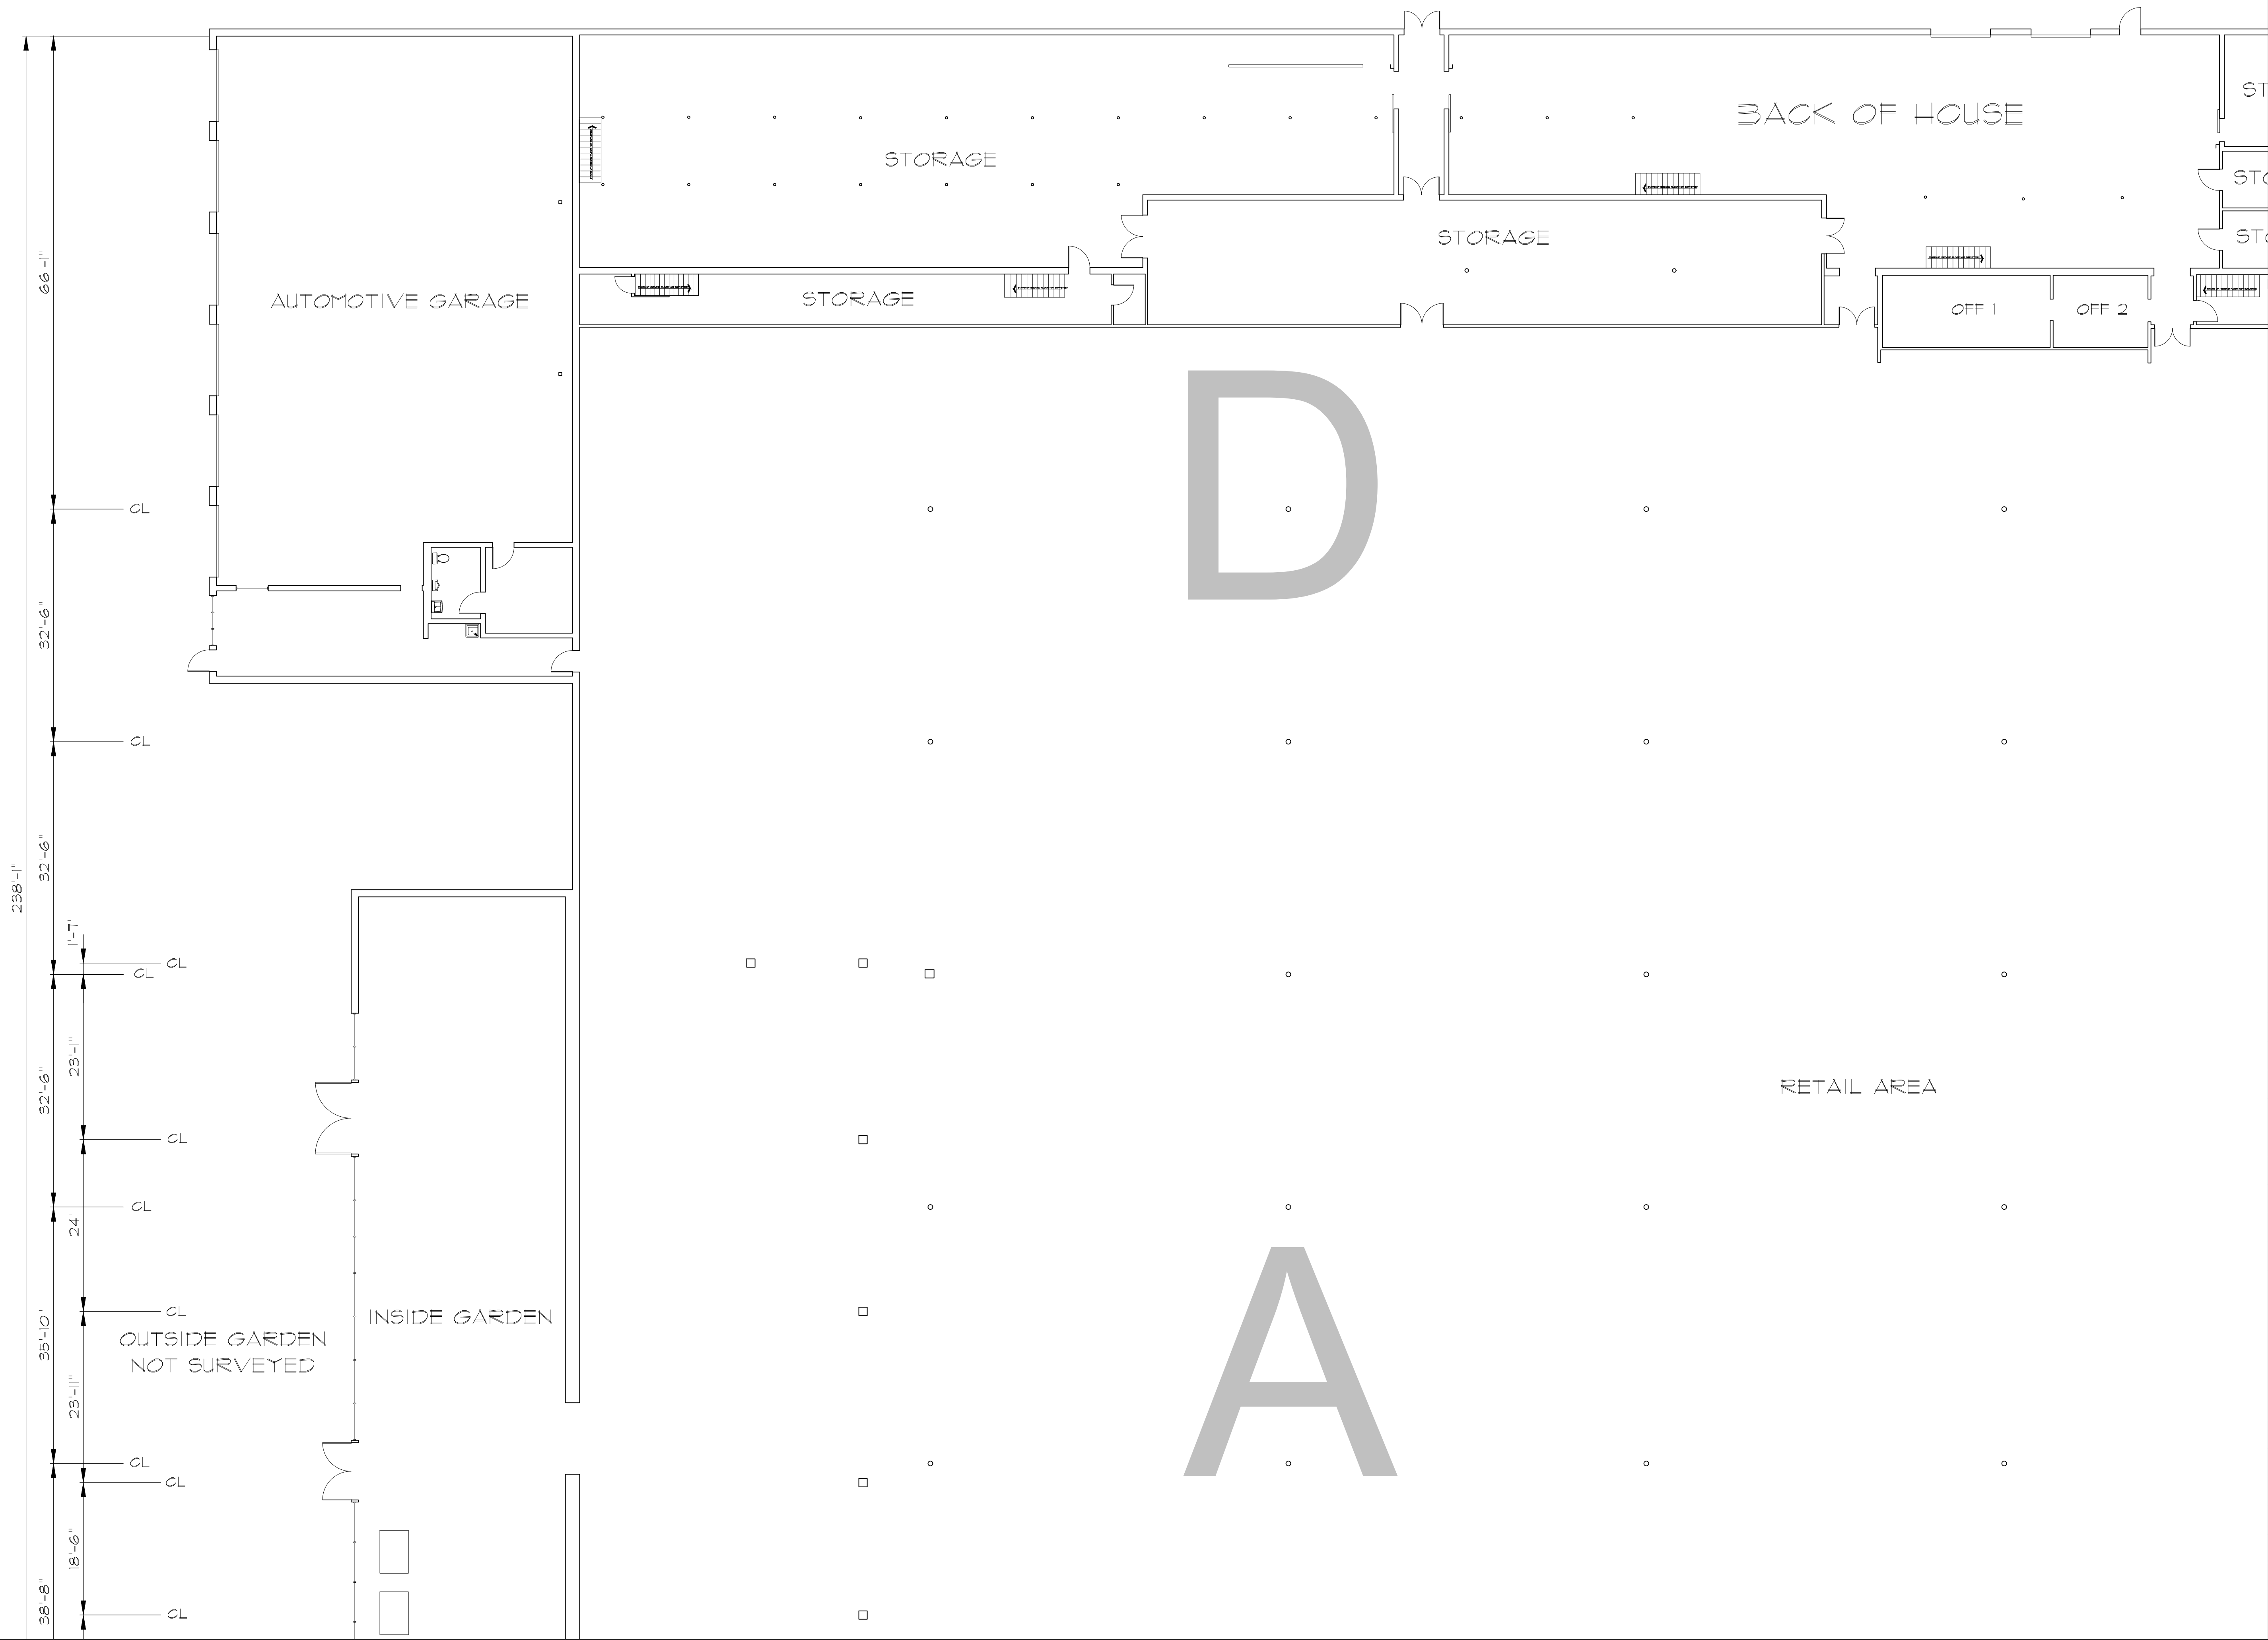

NO.	ISSUES   REVISIONS	DATE	SHEET TITLE
01	100% SUBMISSION		SEE COVER SHEET

HL	PROJECT MANAGER
HL	PROJECT DIRECTOR
012318-1	PROJECT NUMBER
3/16"=1'-0"	SCALE
CL	DRAWN BY
	SHEET NUMBER

**AB-5**