

- FLOOR PLAN KEYED NOTES - ORANGE LEAF INDICATED BY #
- CERAMIC TILE ON WALLS AROUND YOGURT SERVING AREA. - MAIN WALL TILE: SARK TILE - MODEL # ORANGE LEAF ORAN (x). WALL BASE TILE 6" HIGH: SARK TILE - MODEL # ORANGE LEAF ORAN 2x2.
 - SOLID SURFACE SURROUND AROUND YOGURT MACHINE OPENINGS THRU WALL SHALL BE CORIAN. COLOR GAMEO WHITE. REFER TO INTERIOR ELEVATIONS FOR OPENING SIZE. REFER TO ORANGE LEAF CONSTRUCTION MANUAL FOR DETAILS.
 - ALL MILLWORK AND COUNTERTOPS SHALL BE RELOCATED FROM ORANGE LEAF'S EXISTING LOCATION AND REASSEMBLED AT THIS SITE PER FLOOR PLAN LOCATIONS.
 - EXISTING YOGURT EQUIPMENT TO BE RELOCATED FROM EXISTING STORE TO NEW LOCATIONS SHOWN ON FLOOR PLAN.
 - EXISTING PLUMBING FIXTURES SHALL BE RELOCATED FROM EXISTING STORE TO NEW LOCATIONS SHOWN ON THE FLOOR PLAN.
 - EXISTING KITCHEN EQUIPMENT SHALL BE RELOCATED FROM EXISTING STORE TO NEW LOCATIONS SHOWN OF THE FLOOR PLAN.
 - REFER TO MEP PLANS FOR LOCATIONS OF EXISTING LIGHTING AND MECHANICAL AND PLUMBING FIXTURES.
 - NEW RADIUS SECTION OF MILLWORK. BUILD TO MATCH EXISTING MILLWORK LOCATED IN THIS AREA. BUILD PER ORANGE LEAF'S CONSTRUCTION MANUAL.
 - GYP. BOARD FURFDOWN OVER YOGURT MACHINES. REFER TO DETAIL 1/A3.1





6 REFLECTED CEILING PLAN RESTROOMS 104 & 105 SCALE - 1/4" = 1'-0"

5 REFLECTED CEILING PLAN RESTROOMS 107 & 108 SCALE - 1/4" = 1'-0"

4 ENLARGED FLOOR PLAN RESTROOMS 104 & 105 SCALE - 1/4" = 1'-0"

3 ENLARGED FLOOR PLAN RESTROOMS 107 & 108 SCALE - 1/4" = 1'-0"

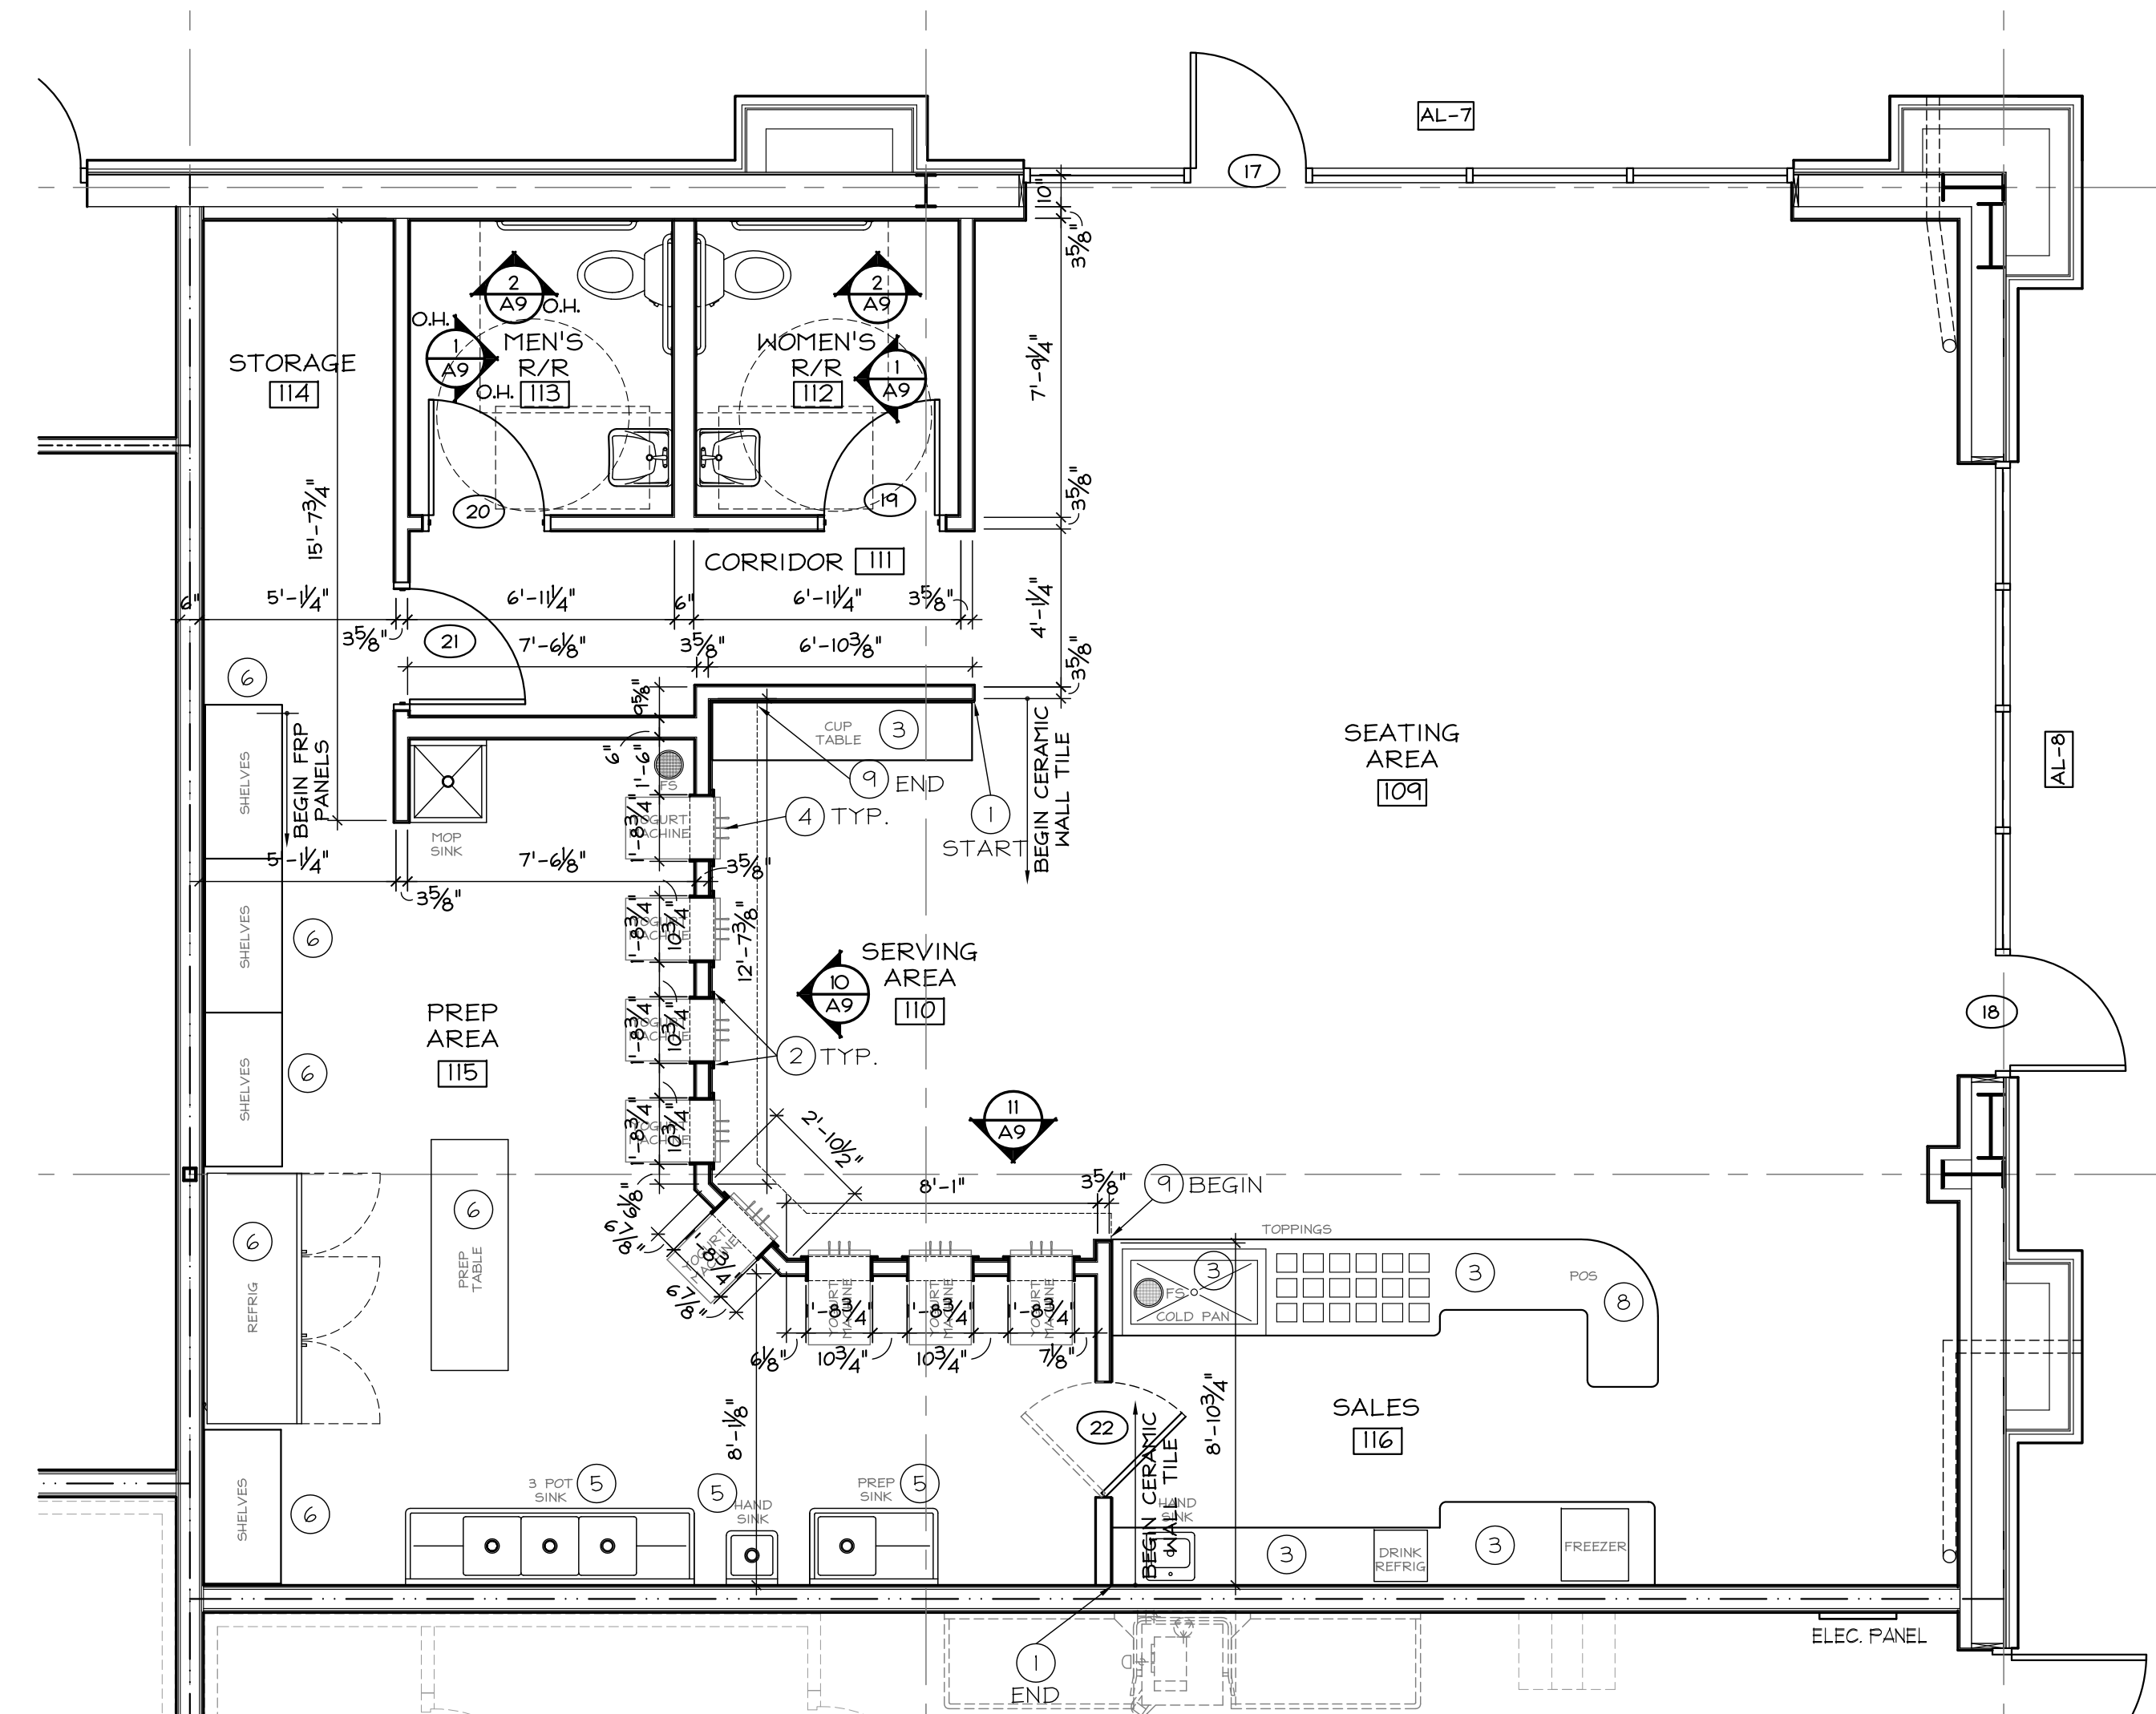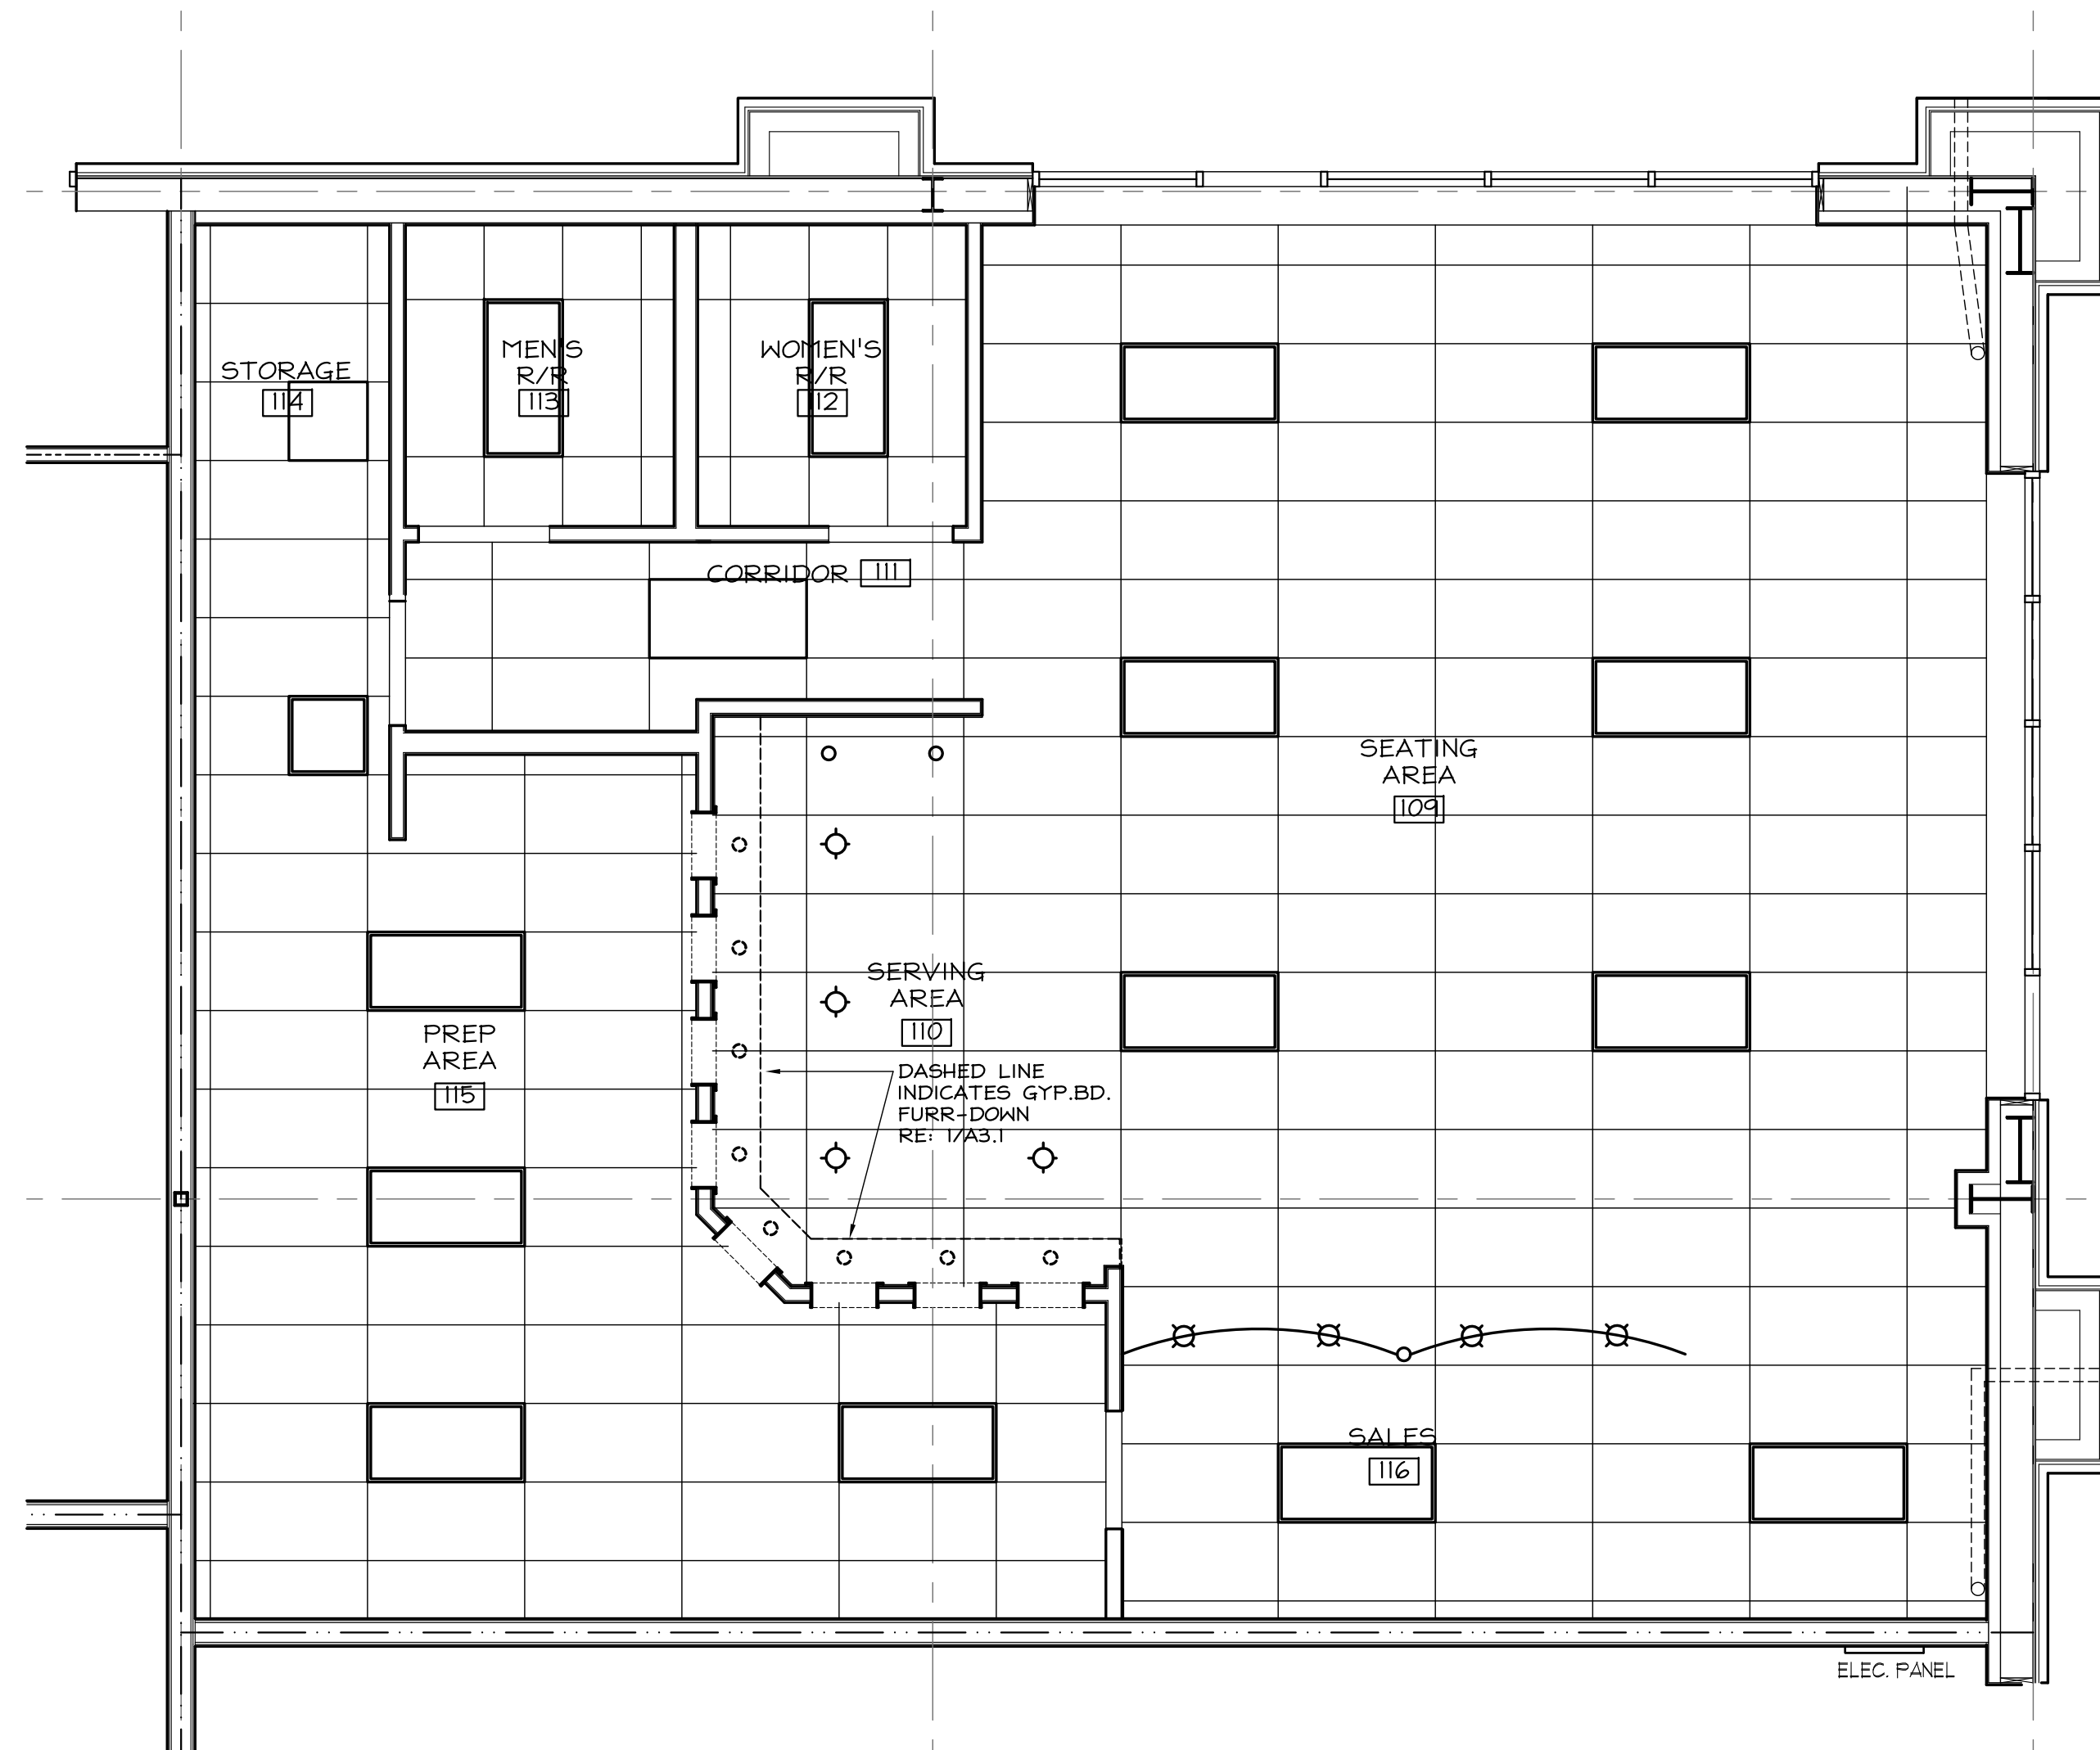

2 REFLECTED CEILING PLAN - ORANGE LEAF SCALE - 1/4" = 1'-0"



1 FLOOR PLAN - ORANGE LEAF SCALE - 1/4" = 1'-0"



MUSTANG TRADE CENTER
 NEW PAD BUILDING
 S.W. 74TH STREET & MUSTANG ROAD
 MUSTANG, OKLAHOMA

DW ARCHITECTS
 ARCHITECTURAL DESIGN
 DARREN P. WATSON, AIA
 (806) 548-0860
 dpw.architect@sbeglobal.net
 5102 91st Street
 Lubbock, Texas 79424

JOB:
 DATE: JUNE 30, 2015
 SHEET

A2

OF 11