
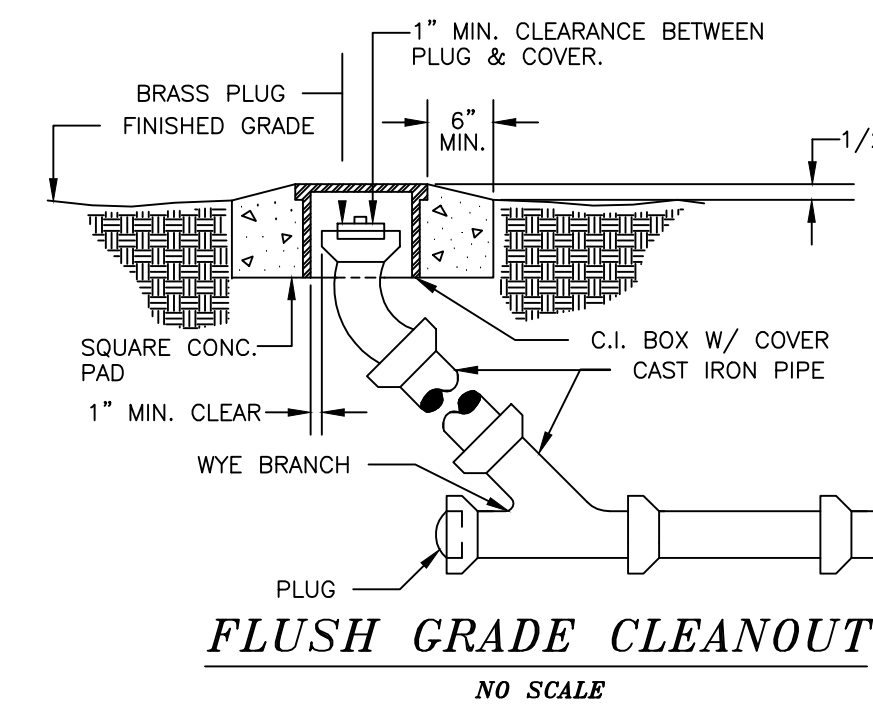



1 PLUMBING PLAN

SCALE: 1/8"=1'-0"

1. ALL EXPOSED WATER PIPING SHALL BE INSULATED AS REQUIRED.
2. WATER PIPING SHALL BE SCHD. 40 PVC.
3. HOT WATER NOT INCLUDED IN DESIGN. (SEE TENANT LAY-OUT FOR ANY HOT WATER)

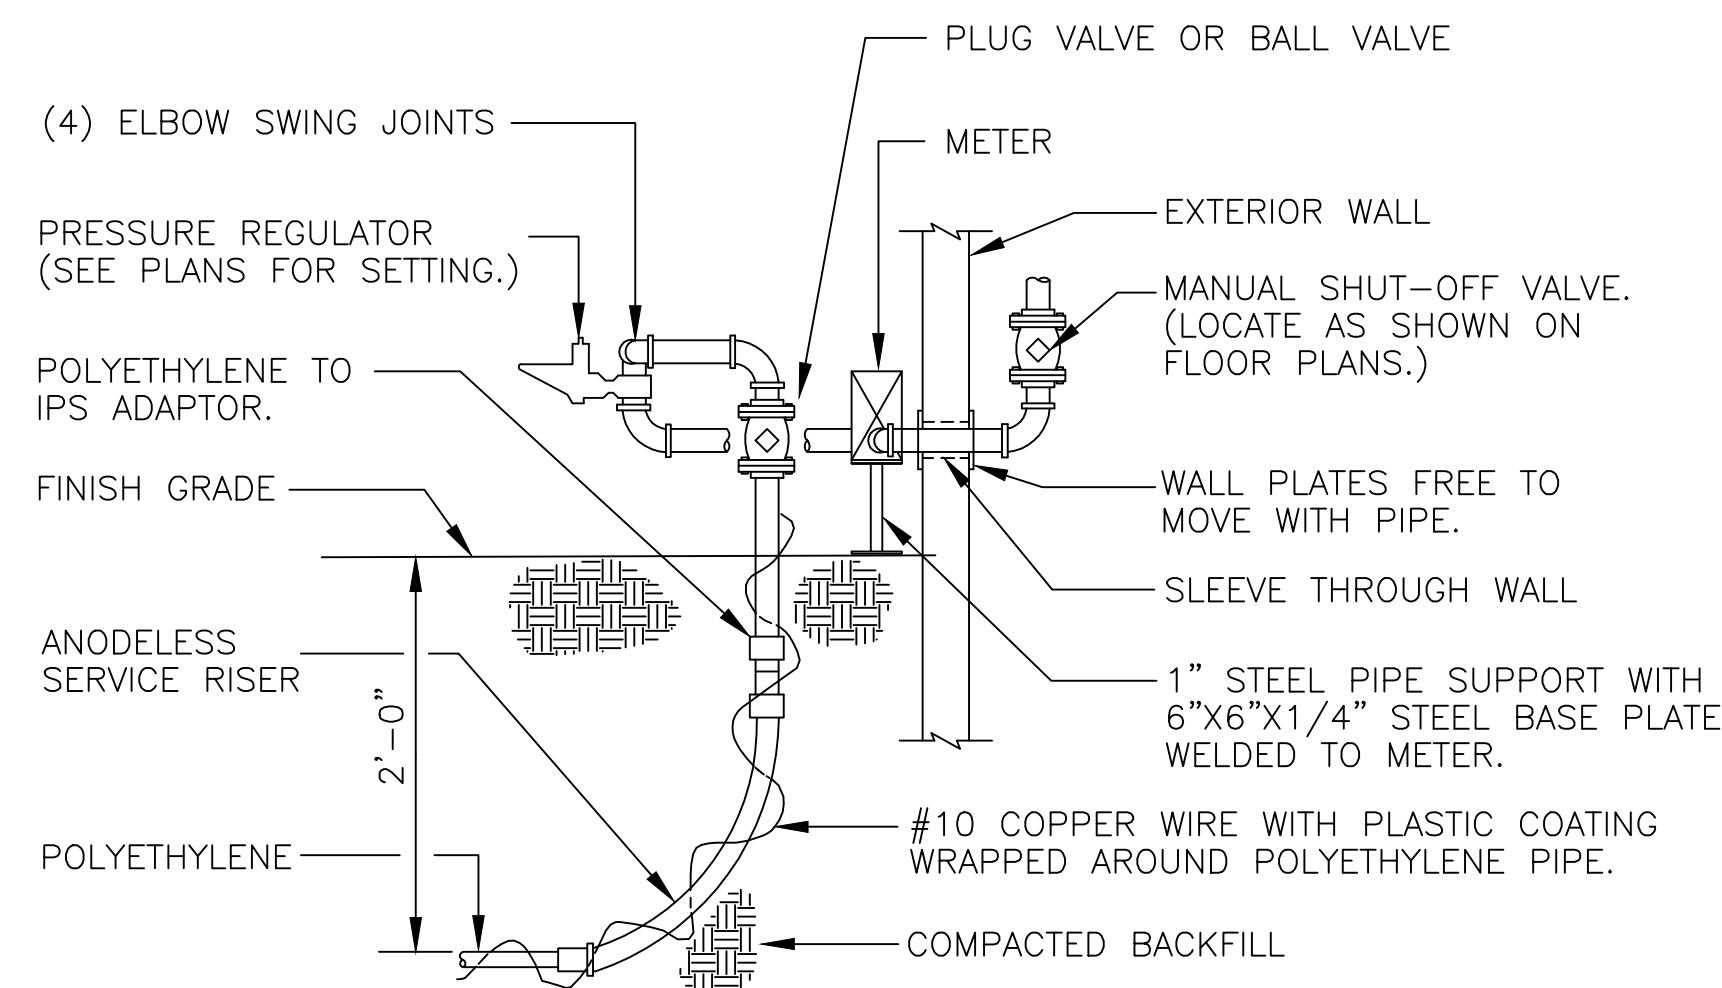

REVISIONS	BY

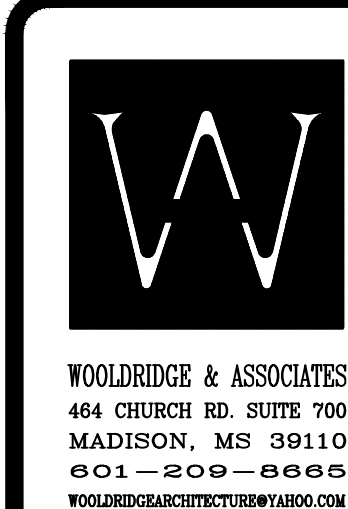

WOOLRIDGE & ASSOCIATES
484 CHURCH RD. SUITE 700
MADISON, MS 39110
601-209-8865
WOOLRIDGE@ARCHITECTURE.WA.AO

Corner @ Calhoun
Calhoun Station Parkway
Gluckstadt, Mississippi

THIS DESIGN IS THE COPYRIGHTED PROPERTY OF WOOLRIDGE & ASSOCIATES. IT MAY NOT BE REPRODUCED OR TRANSMITTED IN ANY FORM OR BY ANY MEANS, ELECTRONIC OR MECHANICAL, WITHOUT THE EXPRESS WRITTEN PERMISSION OF WOOLRIDGE & ASSOCIATES.

DRAWN
CHECKED
DATE 3/16/21
SCALE
JOB NO.
SHEET
P1.0
OF SHEETS