

FOR:
PROPOSED

LOCATION OF SITE:

MAP # 339, BLOCK # 190, LOT # 23



SCALE: 1"=2000'
PLAN REFERENCE: NEW HAVEN CT USGS QUADRANGLE



SCALE: 1"=100'

SHEET INDEX

PREPARED BY




REV	DATE	COMMENT	B'
1			
2			
3			
4			
5			
6			
7			
8			
9			
10			
11			
12			
13			
14			
15			

PRELIMINARY

PROJECT No.:	W161042
DRAWN BY:	WS/JF
CHECKED BY:	JF/AD
DATE:	09/07/18
SCALE:	AS NOTED
CAD I.D.:	W161042SS0

PROJECT: **SITE
DEVELOPMENT
PLANS
—FOR—
CONNECTICUT
HEALTH CARE
HOLDINGS LLC**

**NEW HAVEN, CT
MAP #339, BLOCK #190, LOT #17
240 WINTHROP AVENUE
CITY OF NEW HAVEN
NEW HAVEN COUNTY,
CONNECTICUT**

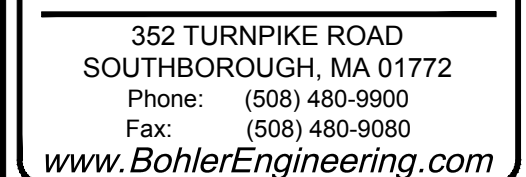

J.G. SWERLING

PROFESSIONAL ENGINEER
MASSACHUSETTS LICENSE No. 41697
NEW HAMPSHIRE LICENSE No. 14695
MAINE LICENSE No. 13816
CONNECTICUT LICENSE No. 30786
RHODE ISLAND LICENSE No. 14225

SHEET TITLE:

COVER SHEET

SHEET NUMBER: 1 OF 14

REV 0 - 09/07/2018

GENERAL NOTES

CONTRACTOR IS RESPONSIBLE FOR COMPLIANCE WITH THE NOTES AND SPECIFICATIONS CONTAINED HEREIN. CONTRACTOR IS RESPONSIBLE TO ENSURE THAT ALL SUBCONTRACTORS FULLY AND COMPLETELY CONFORM TO AND COMPLY WITH THESE REQUIREMENTS.

1. THE FOLLOWING DOCUMENTS ARE INCORPORATED BY REFERENCE AS PART OF THIS SITE PLAN:

- "BOUNDARY AND TOPOGRAPHIC SURVEY", PREPARED BY CONTROL POINT ASSOCIATES, INC., DATED 3/9/16, LAST REVISED 2/28/18.

PRIOR TO THE START OF CONSTRUCTION, THE CONTRACTOR MUST VERIFY THAT HE/SHE HAS THE LATEST EDITION OF THE DOCUMENTS REFERENCED ABOVE. THIS IS CONTRACTOR'S RESPONSIBILITY.

2. ALL ACCESSIBLE (AKIA ADA) PARKING SPACES MUST BE CONSTRUCTED TO MEET, AT A MINIMUM, THE MORE STRINGENT OF THE REQUIREMENTS OF THE "AMERICANS WITH DISABILITIES ACT" (ADA CODE (42 U.S.C. § 12101 et seq. AND 42 U.S.C. § 4151 et seq.) OR THE REQUIREMENTS OF THE JURISDICTION WHERE THE PROJECT IS TO BE CONSTRUCTED, AND ANY AND ALL AMENDMENTS TO BOTH WHICH ARE IN EFFECT WHEN THESE PLANS ARE COMPLETED.

3. PRIOR TO STARTING CONSTRUCTION, THE CONTRACTOR IS RESPONSIBLE TO ENSURE THAT ALL REQUIRED PERMITS AND APPROVALS HAVE BEEN OBTAINED. NO CONSTRUCTION OR FABRICATION SHALL BEGIN UNTIL THE CONTRACTOR HAS RECEIVED AND THOROUGHLY REVIEWED THE COMMENTS TO ALL PLANS AND OTHER DOCUMENTS REVIEWED AND APPROVED BY THE PERMITTING AUTHORITIES AND CONFIRMED THAT ALL NECESSARY OR REQUIRED PERMITS HAVE BEEN OBTAINED. CONTRACTOR MUST HAVE COPIES OF ALL PERMITS AND APPROVALS ON SITE AT ALL TIMES.

4. THE OWNER/CONTRACTOR MUST BE FAMILIAR WITH AND RESPONSIBLE FOR THE PROCUREMENT OF ANY AND ALL CERTIFICATIONS REQUIRED FOR THE ISSUANCE OF A CERTIFICATE OF OCCUPANCY.

5. ALL WORK MUST BE PERFORMED IN ACCORDANCE WITH THESE PLANS, SPECIFICATIONS AND CONDITIONS OF APPROVAL, AND ALL APPLICABLE REQUIREMENTS, RULES, REGULATIONS, STATUTORY REQUIREMENTS, CODES, LAWS AND STANDARDS OF ALL GOVERNMENTAL ENTITIES WITH JURISDICTION OVER THIS PROJECT.

6. THE GEOTECHNICAL REPORT AND RECOMMENDATIONS SET FORTH HEREIN ARE A PART OF THE REQUIRED CONSTRUCTION DOCUMENTS AND, IN CASE OF CONFLICT, DISCREPANCY OR AMBIGUITY, THE MORE STRINGENT REQUIREMENTS AND/OR RECOMMENDATIONS CONTAINED IN THE PLANS AND THE GEOTECHNICAL REPORT AND RECOMMENDATIONS SHALL TAKE PRECEDENCE UNLESS SPECIFIED NOT OTHERWISE ON THE PLANS. THE CONTRACTOR MUST NOTIFY THE ENGINEER, IN WRITING, OF ANY SUCH CONFLICT, DISCREPANCY OR AMBIGUITY BETWEEN THE GEOTECHNICAL REPORTS AND PLANS AND SPECIFICATIONS PRIOR TO PROCEEDING WITH ANY FURTHER WORK.

7. THESE PLANS ARE BASED ON INFORMATION PROVIDED TO BOHLER ENGINEERING BY THE OWNER AND OTHERS PRIOR TO THE TIME OF PLAN PREPARATION. CONTRACTOR MUST FIELD VERIFY EXISTING CONDITIONS AND NOTIFY BOHLER ENGINEERING, IN WRITING, IMMEDIATELY IF ACTUAL SITE CONDITIONS DIFFER FROM THOSE SHOWN ON THE PLAN, OR IF THE PROPOSED WORK CONFLICTS WITH ANY OTHER SITE FEATURES.

8. ALL DIMENSIONS SHOWN ON THE PLANS MUST BE FIELD VERIFIED BY THE CONTRACTOR PRIOR TO THE START OF CONSTRUCTION. CONTRACTOR MUST NOTIFY ENGINEER, IN WRITING, IF ANY CONFLICTS, DISCREPANCIES, OR AMBIGUITIES EXIST PRIOR TO PROCEEDING WITH CONSTRUCTION. NO EXTRA COMPENSATION WILL BE PAID TO THE CONTRACTOR FOR WORK WHICH HAS TO BE REDONE OR REPAIRED DUE TO DIMENSIONS OR GRADES SHOWN INCORRECTLY ON THESE PLANS PRIOR TO CONTRACTOR GIVING ENGINEER WRITTEN NOTIFICATION OF SAME AND ENGINEER, THEREAFTER, PROVIDING CONTRACTOR WITH WRITTEN AUTHORIZATION TO PROCEED WITH SUCH ADDITIONAL WORK.

9. CONTRACTOR MUST REFER TO THE ARCHITECTURAL/BUILDING PLANS "OF RECORD" FOR EXACT LOCATIONS AND DIMENSIONS OF ENTRY/EXIT POINTS, ELEVATIONS, PRECISE BUILDING DIMENSIONS, AND EXACT BUILDING UTILITY LOCATIONS.

10. PRIOR TO THE START OF CONSTRUCTION, THE CONTRACTOR MUST COORDINATE THE BUILDING LAYOUT BY CAREFUL REVIEW OF THE ENTIRE SITE PLAN AND THE LATEST ARCHITECTURAL PLANS (INCLUDING, BUT NOT LIMITED TO, STRUCTURAL, MECHANICAL, ELECTRICAL, PLUMBING AND FIRE SUPPRESSION PLAN, WHERE APPLICABLE). CONTRACTOR MUST IMMEDIATELY NOTIFY OWNER, ARCHITECT AND SITE ENGINEER, IN WRITING, OF ANY CONFLICTS, DISCREPANCIES OR AMBIGUITIES WHICH EXIST.

11. DEBRIS MUST NOT BE BURIED ON THE SUBJECT SITE AND ALL UNSUITABLE EXCAVATED MATERIAL AND DEBRIS (SOLID WASTE) MUST BE DISPOSED OF IN ACCORDANCE WITH THE REQUIREMENTS OF ANY AND ALL GOVERNMENTAL AUTHORITIES WHICH HAVE JURISDICTION OVER THIS PROJECT OR OVER CONTRACTOR.

12. THE CONTRACTOR IS RESPONSIBLE FOR IDENTIFYING WHEN SHORING IS REQUIRED AND FOR INSTALLING ALL SHORING REQUIRED DURING EXCAVATION (TO BE PERFORMED IN ACCORDANCE WITH CURRENT OSHA STANDARDS) AND ANY ADDITIONAL PRECAUTIONS TO BE TAKEN TO ASSURE THE STABILITY OF ADJACENT, NEARBY AND CONTIGUOUS STRUCTURES AND PROPERTIES.

13. THE CONTRACTOR IS TO EXERCISE EXTREME CARE WHEN PERFORMING ANY WORK ACTIVITIES ADJACENT TO PAVEMENT, STRUCTURES, ETC. WHICH ARE TO REMAIN EITHER FOR AN INITIAL PHASE OF THE PROJECT OR AS PART OF THE FINAL CONDITION. CONTRACTOR IS RESPONSIBLE FOR TAKING ALL APPROPRIATE MEASURES REQUIRED TO ENSURE THE STRUCTURAL STABILITY OF SIDEWALKS AND PAVEMENT, UTILITIES, BUILDINGS, AND INFRASTRUCTURE WHICH ARE TO REMAIN, AND TO PROVIDE A SAFE WORK AREA FOR THIRD PARTIES, PEDESTRIANS AND ANYONE INVOLVED WITH THE PROJECT.

14. THE CONTRACTOR IS RESPONSIBLE FOR REPAIRING ANY DAMAGE DONE TO ANY NEW OR EXISTING CONSTRUCTION OR PROPERTY DURING THE COURSE OF CONSTRUCTION, INCLUDING BUT NOT LIMITED TO DRAINAGE, UTILITIES, PAVEMENT, CURB, ETC. AND SHALL BEAR ALL COSTS ASSOCIATED WITH SAME TO INCLUDE, BUT NOT BE LIMITED TO, REDESIGN, RE-SURVEY, RE-PERMITTING AND CONSTRUCTION. THE CONTRACTOR IS RESPONSIBLE FOR AND MUST REPLACE ALL SIGNAL, INTERCONNECTION CABLE, WIRING CONDUITS, AND ANY UNDERGROUND ACCESSORY EQUIPMENT DURING CONSTRUCTION AND MUST BEAR ALL COSTS ASSOCIATED WITH SAME. THE REPAIR OF ANY SUCH NEW OR EXISTING CONSTRUCTION OR PROPERTY MUST RESTORE SUCH CONSTRUCTION OR PROPERTY TO A CONDITION EQUIVALENT TO OR BETTER THAN THE CONDITIONS PRIOR TO COMMENCEMENT OF THE CONSTRUCTION AND IN CONFORMANCE WITH APPLICABLE CODES, LAWS, RULES, REGULATIONS, STATUTORY REQUIREMENTS AND STATUTES. CONTRACTOR MUST BEAR ALL COSTS ASSOCIATED WITH SAME. CONTRACTOR IS RESPONSIBLE TO DOCUMENT ALL EXISTING DAMAGE AND TO NOTIFY THE OWNER AND THE CONSTRUCTION MANAGER PRIOR TO THE START OF CONSTRUCTION.

15. ALL CONCRETE MUST BE AIR ENTRAINED AND HAVE THE MINIMUM COMPRESSIVE STRENGTH OF 4,000 PSI AT 28 DAYS UNLESS OTHERWISE NOTED ON THE PLANS, DETAILS AND/OR GEOTECHNICAL REPORT.

16. THE ENGINEER IS NOT RESPONSIBLE FOR CONSTRUCTION METHODS, MEANS, TECHNIQUES OR PROCEDURES, GENERALLY OR FOR THE CONSTRUCTION MEANS, METHODS, TECHNIQUES OR PROCEDURES FOR COMPLETION OF THE WORK DEPICTED BOTH ON THESE PLANS, AND FOR ANY CONFLICTS/SOPE REVISIONS WHICH RESULT FROM SAME. CONTRACTOR IS RESPONSIBLE FOR DETERMINING THE METHODS/MEANS FOR COMPLETION OF THE WORK PRIOR TO THE COMMENCEMENT OF CONSTRUCTION.

17. THE ENGINEER OF RECORD IS NOT RESPONSIBLE FOR JOB SITE SAFETY. THE ENGINEER OF RECORD HAS NOT BEEN RETAINED TO PERFORM OR BE RESPONSIBLE FOR JOB SITE SAFETY, SAME BEING WHOLLY OUTSIDE OF ENGINEER'S SERVICES AS RELATED TO THE PROJECT. THE ENGINEER OF RECORD IS NOT RESPONSIBLE TO IDENTIFY OR REPORT ANY JOB SITE SAFETY ISSUES, AT ANY TIME.

18. ALL CONTRACTORS MUST CARRY THE SPECIFIED STATUTORY WORKER'S COMPENSATION INSURANCE, EMPLOYER'S LIABILITY INSURANCE AND LIMITS OF COMMERCIAL GENERAL LIABILITY INSURANCE (CGL). ALL CONTRACTORS MUST HAVE THEIR CGL POLICIES ENDORSED TO NAME BOHLER ENGINEERING AND ITS PAST, PRESENT AND FUTURE OWNERS, OFFICERS, DIRECTORS, PARTNERS, SHAREHOLDERS, MEMBERS, PRINCIPALS, COMMISSIONERS, AGENTS, SERVANTS, EMPLOYEES, AFFILIATES, SUBSIDIARIES, AND RELATED ENTITIES, AND ITS SUBCONTRACTORS AND SUBCONSULTANTS AS ADDITIONAL NAMED INSURED AND TO PROVIDE CONTRACTUAL LIABILITY COVERAGE SUFFICIENT TO INSURE THIS HOLD HARMLESS AND INDEMNITY OBLIGATIONS ASSUMED BY THE CONTRACTORS. ALL CONTRACTORS MUST FURNISH BOHLER ENGINEERING WITH CERTIFICATIONS OF INSURANCE AS EVIDENCE OF THE REQUIRED INSURANCE PRIOR TO COMMENCING WORK AND UPON RENEWAL OF EACH POLICY DURING THE ENTIRE PERIOD OF CONSTRUCTION AND FOR ONE YEAR AFTER THE COMPLETION OF CONSTRUCTION. IN ADDITION, ALL CONTRACTORS WILL, TO THE FULLEST EXTENT PERMITTED UNDER THE LAW, INDEMNIFY, DEFEND AND HOLD HARMLESS BOHLER ENGINEERING AND ITS PAST, PRESENT AND FUTURE OWNERS, OFFICERS, DIRECTORS, PARTNERS, SHAREHOLDERS, MEMBERS, PRINCIPALS, COMMISSIONERS, AGENTS, SERVANTS, EMPLOYEES, AFFILIATES, SUBSIDIARIES, AND RELATED ENTITIES, AND ITS SUBCONTRACTORS AND SUBCONSULTANTS FROM AND AGAINST ANY DAMAGES, INJURIES, CLAIMS, ACTIONS, PENALTIES, EXPENSES, PUNITIVE DAMAGES, TORT DAMAGES, STATUTORY CLAIMS, STATUTORY CAUSES OF ACTION, LOSSES, CAUSES OF ACTION, LIABILITIES OR COSTS, INCLUDING, BUT NOT LIMITED TO, REASONABLE ATTORNEY'S FEES AND DEFENSE COSTS, ARISING OUT OF OR IN ANY WAY CONNECTED WITH OR TO THE PROJECT, INCLUDING ALL CLAIMS BY EMPLOYEES OF THE CONTRACTORS. ALL CLAIMS BY THIRD PARTIES AND ALL CLAIMS RELATED TO THE PROJECT. CONTRACTOR MUST NOTIFY ENGINEER, IN WRITING, AT LEAST THIRTY (30) DAYS PRIOR TO ANY TERMINATION, SUSPENSION OR CHANGE OF ITS INSURANCE HEREUNDER.

19. BOHLER ENGINEERING WILL REVIEW OR TAKE OTHER APPROPRIATE ACTION ON THE CONTRACTOR SUBMITTALS, SUCH AS SHOP DRAWINGS, PRODUCT DATA, SAMPLES, AND OTHER DATA, WHICH THE CONTRACTOR IS REQUIRED TO SUBMIT, BUT ONLY FOR THE LIMITED PURPOSE OF CHECKING FOR CONFORMANCE WITH THE DESIGN INTENT AND THE INFORMATION SHOWN IN THE CONSTRUCTION DOCUMENTS. THE CONTRACTOR'S MEANS AND/OR METHODS AND/OR TECHNIQUES OR PROCEDURES OR COORDINATION OF THE WORK WITH OTHER TRADES, AND CONSTRUCTION SAFETY PRECAUTIONS ARE THE SOLE RESPONSIBILITY OF THE CONTRACTOR AND BOHLER HAS NO RESPONSIBILITY OR LIABILITY FOR SAME. HOWEVER, BOHLER ENGINEERING'S SHOP DRAWING REVIEW WILL BE CONDUCTED WITH REASONABLE PROMPTNESS WHILE ALLOWING SUFFICIENT TIME TO PERMIT ADEQUATE REVIEW. REVIEW OF ANY SPECIFIC ITEM DOES NOT INDICATE THAT BOHLER ENGINEERING HAS REVIEWED THE ENTIRE ASSEMBLY OF WHICH THE ITEM IS A COMPONENT. BOHLER ENGINEERING WILL NOT BE RESPONSIBLE FOR THE DEVIATIONS FROM THE CONSTRUCTION DOCUMENTS NOT PROMPTLY AND IMMEDIATELY REPORTED TO ITS ATTENTION, IN WRITING, BY THE CONTRACTOR. BOHLER ENGINEERING WILL NOT BE REQUIRED TO REVIEW PARTIAL SUBMISSIONS OR THOSE FOR WHICH SUBMISSIONS OF CORRELATED ITEMS HAVE NOT BEEN RECEIVED.

20. NEITHER THE PROFESSIONAL ACTIVITIES OF BOHLER ENGINEERING, NOR THE PRESENCE OF BOHLER ENGINEERING AND/OR ITS PAST, PRESENT AND FUTURE OWNERS, OFFICERS, DIRECTORS, PARTNERS, SHAREHOLDERS, MEMBERS, PRINCIPALS, COMMISSIONERS, AGENTS, SERVANTS, EMPLOYEES, AFFILIATES, SUBSIDIARIES, AND RELATED ENTITIES, AND ITS SUBCONTRACTORS AND SUBCONSULTANTS AT A CONSTRUCTION PROJECT SITE, SHALL RELIEVE THE GENERAL CONTRACTOR OF ITS OBLIGATIONS, DUTIES AND RESPONSIBILITIES INCLUDING, BUT NOT LIMITED TO, CONSTRUCTION MEANS, METHODS, TECHNIQUES OR PROCEDURES, NECESSARY FOR PERFORMING, OVERSEEING, SUPERINTENDING AND COORDINATING THE WORK IN ACCORDANCE WITH THE CONTRACT DOCUMENTS AND COMPLIANCE WITH ANY HEALTH OR SAFETY PRECAUTIONS REQUIRED BY ANY REGULATORY AGENCIES WITH JURISDICTION OVER THE PROJECT AND/OR PROPERTY. BOHLER ENGINEERING AND ITS PERSONNEL HAVE NO AUTHORITY TO EXERCISE ANY CONTROL OVER ANY CONTRACTOR OR ITS EMPLOYEES IN CONNECTION WITH THEIR WORK OR ANY HEALTH OR SAFETY PROGRAMS OR PROCEDURES. THE GENERAL CONTRACTOR IS SOLELY RESPONSIBLE FOR JOB SITE SAFETY. BOHLER ENGINEERING SHALL BE INDEMNIFIED BY THE GENERAL CONTRACTOR AND MUST BE NAMED AN ADDITIONAL INSURED UNDER THE GENERAL CONTRACTOR'S POLICIES OF GENERAL LIABILITY INSURANCE AS DESCRIBED ABOVE IN NOTE 19 FOR JOB SITE SAFETY.

21. IF THE CONTRACTOR DEVIATES FROM THE PLANS AND SPECIFICATIONS, INCLUDING THE NOTES CONTAINED HEREIN, WITHOUT FIRST OBTAINING THE PRIOR WRITTEN AUTHORIZATION OF THE ENGINEER FOR SUCH DEVIATIONS, THE CONTRACTOR IS SOLELY RESPONSIBLE FOR THE PAYMENT OF ALL COSTS INCURRED IN CORRECTING ANY WORK DONE WHICH DEVIATES FROM THE PLANS, ALL FINES AND/OR PENALTIES ASSESSED WITH RESPECT THERETO AND ALL COMPENSATORY OR PUNITIVE DAMAGES RESULTING THEREFROM AND, FURTHER, SHALL DEFEND, INDEMNIFY AND HOLD HARMLESS THE ENGINEER, TO THE FULLEST EXTENT PERMITTED UNDER THE LAW, IN ACCORDANCE WITH PARAGRAPH 19 HEREIN, FOR AND FROM ALL FEES, ATTORNEY'S FEES, DAMAGES, COSTS, JUDGMENTS, PENALTIES AND THE LIKE RELATED TO SAME.

22. CONTRACTOR IS RESPONSIBLE FOR MAINTENANCE AND PROTECTION OF TRAFFIC PLAN FOR ALL WORK THAT AFFECTS PUBLIC TRAVEL EITHER IN THE R.O.W. OR ON SITE. THE COST FOR THIS ITEM MUST BE INCLUDED IN THE CONTRACTOR'S PRICE.

23. ALL SIGNING AND PAVEMENT STRIPING MUST CONFORM TO MANUAL ON UNIFORM TRAFFIC CONTROL DEVICES OR LOCALLY APPROVED SUPPLEMENT.

24. ENGINEER IS NOT RESPONSIBLE FOR ANY INJURY OR DAMAGES RESULTING FROM CONTRACTOR'S FAILURE TO BUILD OR CONSTRUCT IN STRICT ACCORDANCE WITH THE APPROVED PLANS. IF CONTRACTOR AND/OR OWNER FAIL TO BUILD OR CONSTRUCT IN STRICT ACCORDANCE WITH APPROVED PLANS, THEY AGREE TO JOINTLY AND SEVERALLY INDEMNIFY AND HOLD ENGINEER HARMLESS FOR ALL INJURIES AND DAMAGES THAT ENGINEER SUFFERS AND COSTS THAT ENGINEER INCURS.

25. OWNER MUST MAINTAIN AND PRESERVE ALL PHYSICAL SITE FEATURES AND DESIGN FEATURES DEPICTED ON THE PLANS AND RELATED DOCUMENTS, IN STRICT ACCORDANCE WITH THE APPROVED PLANS AND SPECIFICATIONS. IF ANY INJURY OR DAMAGE TO ANY PHYSICAL SITE FEATURES AND/OR DESIGN FEATURES DEPICTED ON THE PLANS AND RELATED DOCUMENTS, OWNER AGREES TO INDEMNIFY AND HOLD ENGINEER HARMLESS FOR ALL INJURIES AND DAMAGES THAT ENGINEER SUFFERS AND COSTS THAT ENGINEER INCURS AS A RESULT OF SAID FAILURE.

26. ALL DIMENSIONS MUST BE TO FACE OF CURB, EDGE OF PAVEMENT, OR EDGE OF BUILDING, UNLESS NOTED OTHERWISE.

27. ALL CONSTRUCTION AND MATERIALS MUST COMPLY WITH AND CONFORM TO APPLICABLE FEDERAL, STATE AND LOCAL REGULATIONS, LAWS, ORDINANCES, RULES AND CODES, AND ALL APPLICABLE OSHA REQUIREMENTS.

28. CONTRACTOR AND OWNER MUST INSTALL ALL ELEMENTS AND COMPONENTS IN STRICT COMPLIANCE WITH AND ACCORDANCE WITH MANUFACTURER'S STANDARDS AND RECOMMENDED INSTALLATION CRITERIA AND SPECIFICATIONS. IF CONTRACTOR AND/OR OWNER FAIL TO DO SO, THEY AGREE TO JOINTLY AND SEVERALLY INDEMNIFY AND HOLD ENGINEER HARMLESS FOR ALL INJURIES AND DAMAGES THAT ENGINEER SUFFERS AND COSTS THAT ENGINEER INCURS AS A RESULT OF SAID FAILURE.

29. CONTRACTOR IS RESPONSIBLE TO MAINTAIN ON-SITE STORMWATER POLLUTION PREVENTION PLAN (SWPPP) IN COMPLIANCE WITH EPA REQUIREMENTS FOR SITES WHERE ONE (1) ACRE OR MORE (UNLESS THE LOCAL JURISDICTION REQUIRES FEWER) IS DISTURBED BY CONSTRUCTION ACTIVITIES. CONTRACTOR IS RESPONSIBLE TO ENSURE THAT ALL ACTIVITIES, INCLUDING THOSE OF SUBCONTRACTORS, ARE IN COMPLIANCE WITH THE SWPPP, INCLUDING BUT NOT LIMITED TO LOGGING ACTIVITIES (MINIMUM ONCE PER WEEK AND AFTER RAINFALL EVENTS) AND CORRECTIVE MEASURES, AS APPROPRIATE.

30. AS CONTAINED IN THESE DRAWINGS AND ASSOCIATED APPLICATION DOCUMENTS PREPARED BY THE SIGNATORY PROFESSIONAL ENGINEER, THE USE OF THE WORDS CERTIFY OR CERTIFICATION CONSTITUTES AN EXPRESSION OF "PROFESSIONAL OPINION" REGARDING THE INFORMATION WHICH IS THE SUBJECT OF THE UNDERSIGNED PROFESSIONAL'S KNOWLEDGE OR BELIEF AND IN ACCORDANCE WITH COMMON ACCEPTED PROCEDURE CONSISTENT WITH THE APPLICABLE STANDARDS OF PRACTICE, AND DOES NOT CONSTITUTE A WARRANTY OR GUARANTEE, EITHER EXPRESSED OR IMPLIED.

GENERAL GRADING & UTILITY PLAN NOTES

1. LOCATIONS OF ALL EXISTING AND PROPOSED SERVICES ARE APPROXIMATE AND MUST BE INDEPENDENTLY CONFIRMED WITH LOCAL UTILITY COMPANIES PRIOR TO COMMENCEMENT OF ANY CONSTRUCTION OR EXCAVATION. SANITARY SEWER AND ALL OTHER UTILITY SERVICE CONNECTION POINTS MUST BE INDEPENDENTLY CONFIRMED BY THE CONTRACTOR IN THE FIELD PRIOR TO THE COMMENCEMENT OF CONSTRUCTION. ALL DISCREPANCIES MUST IMMEDIATELY BE REPORTED, IN WRITING, TO THE ENGINEER. CONSTRUCTION MUST COMMENCE BEGINNING AT THE LOWEST INVERT (POINT OF CONNECTION) AND PROGRESS UP GRADIENT. PROPOSED INTERFACE POINTS (CROSSINGS) WITH EXISTING UNDERGROUND UTILITIES SHALL BE FIELD VERIFIED BY TEST PIT PRIOR TO COMMENCEMENT OF CONSTRUCTION.

2. CONTRACTOR MUST VERTICALLY AND HORIZONTALLY LOCATE ALL UTILITIES AND SERVICES INCLUDING, BUT NOT LIMITED TO, GAS, WATER, ELECTRIC, SANITARY AND STORM SEWER, TELEPHONE, CABLE, FIBER OPTIC CABLE, ETC. WITHIN THE LIMITS OF DISTURBANCE OR WORK SPACE, WHICHEVER IS GREATER. THE CONTRACTOR MUST USE, REFER TO, AND COMPLY WITH THE REQUIREMENTS OF THE APPLICABLE UTILITY NOTIFICATION SYSTEM TO LOCATE ALL THE UNDERGROUND UTILITIES. THE CONTRACTOR IS RESPONSIBLE FOR REPAIRING ALL DAMAGE TO ANY EXISTING UTILITIES DURING CONSTRUCTION, AT NO COST TO THE OWNER. CONTRACTOR SHALL BEAR ALL COSTS ASSOCIATED WITH DAMAGE TO ANY EXISTING UTILITIES DURING CONSTRUCTION.

3. IT IS THE CONTRACTOR'S RESPONSIBILITY TO REVIEW ALL CONSTRUCTION CONTRACT DOCUMENTS INCLUDING, BUT NOT LIMITED TO, ALL OF THE DRAWINGS AND SPECIFICATIONS ASSOCIATED WITH THE PROJECT WORK SCOPE AND THE INTENTION AND COMMENCEMENT OF CONSTRUCTION. SHOULD THE CONTRACTOR FIND A CONFLICT AND/OR DISCREPANCY BETWEEN THE DOCUMENTS RELATIVE TO THE SPECIFICATIONS OR THE RELATIVE OR APPLICABLE CODES, REGULATIONS, LAWS, RULES, STATUTES AND/OR ORDINANCES, IT IS THE CONTRACTOR'S SOLE RESPONSIBILITY TO NOTIFY THE PROJECT ENGINEER OF RECORD, IN WRITING, OF SAID CONFLICT AND/OR DISCREPANCY PRIOR TO THE START OF CONSTRUCTION. CONTRACTOR'S FAILURE TO NOTIFY THE PROJECT ENGINEER SHALL CONSTITUTE CONTRACTOR'S FULL AND COMPLETE ACCEPTANCE OF ALL RESPONSIBILITY TO COMPLETE THE SCOPE OF WORK AS DEFINED BY THE DRAWINGS AND IN FULL COMPLIANCE WITH ALL FEDERAL, STATE AND LOCAL REGULATIONS, LAWS, STATUTES, ORDINANCES AND CODES AND, FURTHER, CONTRACTOR SHALL BE RESPONSIBLE FOR ALL COSTS ASSOCIATED WITH SAME.

4. THE CONTRACTOR MUST LOCATE AND CLEARLY AND UNAMBIGUOUSLY DEFINE VERTICALLY AND HORIZONTALLY ALL ACTIVE AND INACTIVE UTILITY AND/OR SERVICE SYSTEMS THAT ARE TO BE REMOVED. THE CONTRACTOR IS RESPONSIBLE TO PROTECT AND MAINTAIN ALL ACTIVE AND INACTIVE SYSTEMS THAT ARE NOT BEING REMOVED/RELOCATED DURING SITE ACTIVITY.

5. THE CONTRACTOR MUST FAMILIARIZE ITSELF WITH THE APPLICABLE UTILITY SERVICE PROVIDER REQUIREMENTS AND IS RESPONSIBLE FOR ALL COORDINATION REGARDING UTILITY DEMOLITION AS IDENTIFIED OR REQUIRED FOR THE PROJECT. THE CONTRACTOR MUST PROVIDE THE OWNER WITH WRITTEN NOTIFICATION THAT THE EXISTING UTILITIES AND SERVICES HAVE BEEN TERMINATED AND ABANDONED IN ACCORDANCE WITH THE JURISDICTION AND UTILITY COMPANY REQUIREMENTS AND ALL OTHER APPLICABLE REQUIREMENTS, RULES, STATUTES, LAWS, ORDINANCES AND CODES.

6. THE CONTRACTOR MUST INSTALL ALL STORM SEWER AND SANITARY SEWER COMPONENTS WHICH FUNCTION BY GRAVITY PRIOR TO THE INSTALLATION OF ALL OTHER UTILITIES.

7. CONTRACTOR IS RESPONSIBLE FOR COORDINATION OF SITE PLAN DOCUMENTS AND ARCHITECTURAL DESIGN FOR EXACT BUILDING UTILITY CONNECTION LOCATIONS, GREASE TRAP REQUIREMENTS, SINKS, DOOR ACCESS, AND EXTERIOR GRADING. THE ARCHITECT WILL DETERMINE THE UTILITY SERVICE SIZES. THE CONTRACTOR MUST COORDINATE INSTALLATION OF UTILITIES/SERVICES WITH THE INDIVIDUAL COMPANIES, TO AVOID CONFLICTS AND TO ENSURE THAT PROPER DEPTHS ARE ACHIEVED. THE CONTRACTOR IS RESPONSIBLE FOR ENSURING THAT INSTALLATION OF ALL IMPROVEMENTS COMPLIES WITH ALL UTILITY REQUIREMENTS WITH JURISDICTION AND/OR CONTROL OF THE SITE, AND ALL OTHER APPLICABLE REQUIREMENTS, RULES, STATUTES, LAWS, ORDINANCES AND CODES AND, FURTHER, IS RESPONSIBLE FOR COORDINATING THE UTILITY MISCONNECTIONS PRIOR TO CONNECTING TO THE EXISTING UTILITY/SERVICE. WHERE A CONFLICT(S) EXISTS BETWEEN THESE SITE PLANS AND THE ARCHITECTURAL PLANS, OR WHERE ARCHITECTURAL PLAN UTILITY CONNECTION POINTS DIFFER, THE CONTRACTOR MUST IMMEDIATELY NOTIFY THE ENGINEER, IN WRITING, AND PRIOR TO CONSTRUCTION, RESOLVE SAME.

8. WATER SERVICE MATERIALS, BURIAL DEPTH, AND COVER REQUIREMENTS MUST BE SPECIFIED BY THE LOCAL UTILITY COMPANY. CONTRACTOR'S PRICE FOR WATER SERVICE MUST INCLUDE ALL FEES, COSTS AND APPURTENANCES REQUIRED BY THE UTILITY TO PROVIDE FULL AND COMPLETE WORKING. CONTRACTOR MUST CONTACT THE APPLICABLE MUNICIPALITY TO CONFIRM THE PROPER WATER METER AND VAULT, PRIOR TO COMMENCING CONSTRUCTION.

9. ALL NEW UTILITIES/SERVICES, INCLUDING ELECTRIC, TELEPHONE, CABLE TV, ETC. ARE TO BE INSTALLED UNDERGROUND. ALL NEW UTILITIES/SERVICES MUST BE INSTALLED IN ACCORDANCE WITH THE UTILITY/SERVICE PROVIDER INSTALLATION SPECIFICATIONS AND STANDARDS.

10. SITE GRADING MUST BE PERFORMED IN ACCORDANCE WITH THESE PLANS AND SPECIFICATIONS AND THE RECOMMENDATIONS SET FORTH IN THE GEOTECHNICAL REPORT REFERENCED IN THIS PLAN SET. THE CONTRACTOR IS RESPONSIBLE FOR REMOVING AND REPLACING UNSUITABLE MATERIALS WITH SUITABLE MATERIALS AS SPECIFIED IN THE GEOTECHNICAL REPORT. ALL EXCAVATED OR FILLED AREAS MUST BE COMPACTED AS OUTLINED IN THE GEOTECHNICAL REPORT. MOISTURE CONTENT AT TIME OF PLACEMENT MUST BE SUBMITTED IN A COMPACTION REPORT PREPARED BY A QUALIFIED GEOTECHNICAL ENGINEER, REGISTERED WITH THE STATE WHERE THE WORK IS PERFORMED, VERIFYING THAT ALL FILLED AREAS AND SUBGRADE AREAS WITHIN THE BUILDING PAD AREA AND AREAS TO BE PAVED HAVE BEEN COMPACTED IN ACCORDANCE WITH THESE PLANS, SPECIFICATIONS AND THE RECOMMENDATIONS SET FORTH IN THE GEOTECHNICAL REPORT AND ALL APPLICABLE REQUIREMENTS, RULES, STATUTES, LAWS, ORDINANCES AND CODES. SUBBASE MATERIAL FOR SIDEWALKS, CURB, OR ASPHALT MUST BE FREE OF ORGANICS AND OTHER UNSUITABLE MATERIALS. SHOULD SUBBASE BE DEEMED UNSUITABLE BY OWNER/DEVELOPER, OR OWNER/DEVELOPER'S REPRESENTATIVE, SUBBASE IS TO BE REMOVED AND FILLED WITH APPROVED FILL MATERIAL, COMPACTED AS DIRECTED BY THE GEOTECHNICAL REPORT. EARTHWORK ACTIVITIES INCLUDING, BUT NOT LIMITED TO, EXCAVATION, BACKFILL, AND COMPACTING MUST COMPLY WITH THE RECOMMENDATIONS IN THE GEOTECHNICAL REPORT AND ALL APPLICABLE REQUIREMENTS, RULES, STATUTES, LAWS, ORDINANCES AND CODES. EARTHWORK ACTIVITIES MUST COMPLY WITH THE STANDARD STATE DOT SPECIFICATIONS FOR ROADWAY CONSTRUCTION (LATEST EDITION) AND ANY AMENDMENTS OR REVISIONS THERETO.

11. ALL FILL, COMPACTED AND BACKFILL MATERIALS REQUIRED FOR UTILITY INSTALLATION MUST BE AS PER THE RECOMMENDATIONS PROVIDED IN THE GEOTECHNICAL REPORT AND MUST BE COORDINATED WITH THE APPLICABLE UTILITY COMPANY SPECIFICATIONS. WHEN THE PROJECT DOES NOT HAVE GEOTECHNICAL RECOMMENDATIONS, FILL AND COMPACTATION MUST, AT A MINIMUM, COMPLY WITH THE STATE DOT REQUIREMENTS AND SPECIFICATIONS AND CONSULTANT SHALL HAVE NO LIABILITY OR RESPONSIBILITY FOR OR AS RELATED TO FILL, COMPACTION AND BACKFILL. FURTHER, CONTRACTOR IS FULLY RESPONSIBLE FOR EARTHWORK BACKFILL.

12. THE CONTRACTOR MUST COMPLY, TO THE FULLEST EXTENT, WITH THE LATEST OSHA STANDARDS AND REGULATIONS, AND/OR ANY OTHER AGENCY WITH JURISDICTION FOR EXCAVATION AND TRENCHING PROCEDURES. THE CONTRACTOR IS RESPONSIBLE FOR DETERMINING THE "MEANS AND METHODS" REQUIRED TO MEET THE INTENT AND PERFORMANCE CRITERIA OF OSHA, AS WELL AS ANY OTHER ENTITY THAT HAS JURISDICTION FOR EXCAVATION AND/OR TRENCHING PROCEDURES AND CONSULTANT SHALL HAVE NO RESPONSIBILITY FOR OR AS RELATED TO FILL OR AS RELATED TO EXCAVATION AND TRENCHING PROCEDURES.

13. PAVEMENT MUST BE SAW CUT IN STRAIGHT LINES, AND EXCEPT FOR EDGE OF BUTT JOINTS, MUST EXTEND TO THE FULL DEPTH OF THE EXISTING PAVEMENT. ALL DEBRIS FROM REMOVAL OPERATIONS MUST BE REMOVED FROM THE SITE AT THE TIME OF EXCAVATION. STOCKPIILING OF DEBRIS WILL NOT BE PERMITTED.

14. THE TOPS OF EXISTING MANHOLES, INLET STRUCTURES, AND SANITARY CLEANOUT TOPS MUST BE ADJUSTED, AS NECESSARY, TO MATCH PROPOSED GRADES IN ACCORDANCE WITH ALL APPLICABLE STANDARDS, REQUIREMENTS, RULES, STATUTES, LAWS, ORDINANCES AND CODES.

15. DURING THE INSTALLATION OF SANITARY SEWER, STORM SEWER, AND ALL UTILITIES, THE CONTRACTOR MUST MAINTAIN A CONTEMPORANEOUS AND THOROUGH RECORD OF CONSTRUCTION TO THE DEPTH THE AS-INSTALLED LOCATIONS OF ALL UTILITIES THAT DEVIATE FROM THE INFORMATION CONTAINED IN THE UTILITY PLAN. THIS RECORD MUST BE KEPT ON A CLEAN COPY OF THE DRAINAGE OR UTILITY PLAN, WHICH CONTRACTOR MUST PROMPTLY PROVIDE TO THE OWNER AT THE COMPLETION OF WORK.

16. WHEN THE SITE IMPROVEMENT PLANS INVOLVE MULTIPLE BUILDINGS, SOME OF WHICH MAY BE BUILT AT A LATER DATE, THE CONTRACTOR MUST EXTEND ALL LINES, INCLUDING BUT NOT LIMITED TO STORM SEWER, SANITARY SEWER, UTILITIES, AND IRRIGATION LINE, TO A POINT AT LEAST FIVE (5) FEET BEYOND THE PAVED AREAS FOR WHICH THE CONTRACTOR IS RESPONSIBLE. CONTRACTOR MUST CAP ENDS AS APPROPRIATE, MARK LOCATIONS WITH A 2x4, AND MUST NOTE THE LOCATION OF ALL OF THE ABOVE ON A CLEAN COPY OF THE DRAINAGE OR UTILITY PLAN, WHICH CONTRACTOR MUST PROMPTLY PROVIDE TO THE OWNER UPON COMPLETION OF THE WORK.

17. THE CONTRACTOR IS FULLY RESPONSIBLE FOR VERIFICATION OF EXISTING TOPOGRAPHIC INFORMATION AND UTILITY INVERT ELEVATIONS PRIOR TO COMMENCING ANY CONSTRUCTION. CONTRACTOR MUST CONFIRM AND ENSURE 0.75% MINIMUM SLOPE AGAINST ISLANDS, TUFFERS, AND CURBS; 1.0% ON ALL CONCRETE SURFACES; AND 1.5% MINIMUM ON ASPHALT (EXCEPT WHERE ADA REQUIREMENTS OR EXISTING TOPOGRAPHY LIMIT GRADES). TO PREVENT POONDING, CONTRACTOR MUST IMMEDIATELY IDENTIFY, IN WRITING TO THE ENGINEER, ANY DISCREPANCIES THAT MAY OR COULD AFFECT THE PUBLIC SAFETY, HEALTH OR GENERAL WELFARE, OR PROJECT COST. IF CONTRACTOR PROCEEDS WITH CONSTRUCTION WITHOUT PROVIDING PROPER NOTIFICATION, MUST BE AT THE CONTRACTOR'S OWN RISK AND, FURTHER, CONTRACTOR SHALL INDEMNIFY, DEFEND AND HOLD HARMLESS THE DESIGN ENGINEER FOR ANY DAMAGES, COSTS, INJURIES, ATTORNEY'S FEES AND THE LIKE WHICH RESULT FROM SAME.

18. PROPOSED TOP OF CURB ELEVATIONS ARE GENERALLY 6" ABOVE EXISTING LOCAL ASPHALT GRADE UNLESS OTHERWISE NOTED. FIELD ADJUST TO CREATE A MINIMUM OF .07% GUTTER GRADE ALONG CURB FACE. IT IS CONTRACTOR'S OBLIGATION TO ENSURE THAT DESIGN ENGINEER APPROVES FINAL CURBING OUT SHEETS PRIOR TO INSTALLATION OF SAME.

19. REFER TO THIS SHEET FOR ADDITIONAL NOTES.

20. IN THE EVENT OF DISCREPANCIES AND/OR CONFLICTS BETWEEN PLANS OR RELATIVE TO OTHER PLANS, THE SITE PLAN WILL TAKE PRECEDENCE AND CONTROL. CONTRACTOR MUST IMMEDIATELY NOTIFY THE DESIGN ENGINEER, IN WRITING, OF ANY DISCREPANCIES AND/OR CONFLICTS.

21. CONTRACTOR IS REQUIRED TO SECURE ALL NECESSARY AND/OR REQUIRED PERMITS AND APPROVALS FOR ALL OFF SITE MATERIAL SOURCES AND DISPOSAL FACILITIES. CONTRACTOR MUST SUPPLY A COPY OF APPROVALS TO ENGINEER AND OWNER PRIOR TO INITIATING ANY WORK.

22. WHERE RETAINING WALLS (WHETHER OR NOT THEY MEET THE JURISDICTIONAL DEFINITION) ARE IDENTIFIED ON PLANS, ELEVATIONS IDENTIFIED ARE FOR THE EXPOSED PORTION OF THE WALL. WALL FOOTING/FOUNDATION ELEVATIONS ARE NOT IDENTIFIED HEREIN AND ARE TO BE SET DETERMINED BY THE CONTRACTOR BASED ON FINAL STRUCTURAL DESIGN SHOP DRAWINGS PREPARED BY THE APPROPRIATE PROFESSIONAL LICENSED IN THE STATE WHERE THE CONSTRUCTION OCCURS.

23. STORM DRAINAGE PIPE UNLESS INDICATED OTHERWISE, ALL STORM SEWER PIPE MUST BE REINFORCED CONCRETE PIPE (RCP) CLASS III WITH SLT TIGHT JOINTS. WHEN HIGH-DENSITY POLYETHYLENE PIPE (HDPE) IS CALLED FOR ON THE PLANS, IT MUST CONFORM TO ASTM M241 AND TYPE S (SMOOTH INTERIOR WITH ANGULAR CORRUGATIONS) WITH GASKET FOR SLT TIGHT JOINT. PVC PIPE FOR ROOF DRAIN CONNECTION MUST BE SDR 26 OR SCHEDULE 40 UNLESS INDICATED OTHERWISE.

24. UNLESS INDICATED OTHERWISE ON THE DRAWINGS, SANITARY SEWER PIPE SHALL BE AS FOLLOWS:

- FOR PIPES LESS THAN 12 FT. DEEP: POLYVINYL CHLORIDE (PVC) SDR 35 PER ASTM D3034
- FOR PIPES MORE THAN 12 FT. DEEP: POLYVINYL CHLORIDE (PVC) SDR 35 PER ASTM D3034
- FOR PIPE WITHIN 10 FT. OF BUILDING, PIPE MATERIAL SHALL COMPLY WITH APPLICABLE BUILDING AND PLUMBING CODES. CONTRACTOR TO VERIFY WITH LOCAL OFFICIALS.

25. STORM AND SANITARY SEWER PIPE LENGTHS INDICATED ARE NOMINAL AND MEASURED CENTER OF INLET AND/OR MANHOLES STRUCTURE TO CENTER OF STRUCTURE.

26. STORMWATER ROOF DRAIN LOCATIONS ARE BASED ON PRELIMINARY ARCHITECTURAL PLANS. CONTRACTOR IS RESPONSIBLE TO AND FOR VERIFYING LOCATIONS OF SAME BASED ON FINAL ARCHITECTURAL PLANS.

27. SEWERS CROSSING STREAMS AND/OR LOCATION WITHIN 10 FEET OF THE STREAM EMBANKMENT, OR WHERE SITE CONDITIONS SO INDICATE, MUST BE CONSTRUCTED OF STEEL, REINFORCED CONCRETE, DUCTILE IRON OR CAST IRON. SEWERS CONVEYING SANITARY FLOW COMBINED SANITARY AND STORMWATER FLOW OR INDUSTRIAL FLOW MUST BE SEPARATED FROM WATER MAINS BY A DISTANCE OF AT LEAST 10 FEET HORIZONTALLY. IF SUCH LATERAL SEPARATION IS NOT POSSIBLE, THE PIPES MUST BE IN SEPARATE TRENCHES WITH THE SEWER AT LEAST 18 INCHES BELOW THE BOTTOM OF THE WATER MAIN, OR SUCH OTHER SEPARATION AS APPROVED BY THE GOVERNMENT AGENCY WITH JURISDICTION OVER SAME.

28. WHERE APPROPRIATE SEPARATION FROM A WATER MAIN IS NOT POSSIBLE, THE SEWER MUST BE ENCASED IN CONCRETE, OR CONSTRUCTED OF DUCTILE IRON PIPE USING MECHANICAL OR SLIP-ON JOINTS FOR A DISTANCE OF AT LEAST 10 FEET ON EITHER SIDE OF THE CROSSING. IN ADDITION, ONE FULL LENGTH OF SEWER PIPE SHOULD BE LOCATED SO BOTH JOINTS WILL BE AS FAR FROM THE WATER LINE AS POSSIBLE. WHERE A WATER MAIN CROSSES UNDER A SEWER, ADEQUATE STRUCTURAL SUPPORT FOR THE SEWER MUST BE PROVIDED.

29. WATER MAIN PIPING MUST BE INSTALLED IN ACCORDANCE WITH THE REQUIREMENTS AND SPECIFICATIONS OF THE LOCAL WATER PURVEYOR. IN THE ABSENCE OF SUCH REQUIREMENTS, WATER MAIN PIPING MUST BE CEMENT-LINED DUCTILE IRON (DIP) MINIMUM CLASS 52 THICKNESS. ALL PIPE AND APPURTENANCES MUST COMPLY WITH THE APPLICABLE AWWA STANDARDS IN EFFECT AT THE TIME OF APPLICATION.

30. CONTRACTOR MUST ENSURE THAT ALL UTILITY TRENCHES LOCATED IN EXISTING PAVED ROADWAYS INCLUDING SEWER, WATER AND STORM SYSTEMS, MUST BE REPAIRED IN ACCORDANCE WITH REFERENCED MUNICIPAL, COUNTY AND/OR DOT DETAILS AS APPLICABLE. CONTRACTOR MUST COORDINATE INSPECTION AND APPROVAL OF COMPLETED WORK WITH THE AGENCY WITH JURISDICTION OVER SAME.

31. LOCATION OF PROPOSED UTILITY POLE RELOCATION IS AT THE SOLE DISCRETION OF UTILITY COMPANY.

32. CONSULTANT IS NEITHER LIABLE NOR RESPONSIBLE FOR ANY SUBSURFACE CONDITIONS AND FURTHER, SHALL HAVE NO LIABILITY FOR ANY HAZARDOUS MATERIALS, HAZARDOUS SUBSTANCES, OR POLLUTANTS ON, ABOUT OR UNDER THE PROPERTY.

GENERAL DEMOLITION NOTES

1. THIS PLAN REFERENCES DOCUMENTS AND INFORMATION BY:

- "BOUNDARY AND TOPOGRAPHIC SURVEY", PREPARED BY CONTROL POINT ASSOCIATES, INC., DATED 3/9/16, LAST REVISED 2/28/18.

2. CONTRACTOR SHALL PERFORM ALL WORK IN ACCORDANCE WITH THE REQUIREMENTS OF THE OCCUPATIONAL SAFETY AND HEALTH ACT OF 1970, (29 U.S.C. 651 et seq.), AS AMENDED AND ANY MODIFICATIONS, AMENDMENTS OR REVISIONS TO SAME.

3. BOHLER ENGINEERING HAS NO CONTRACTUAL, LEGAL, OR OTHER RESPONSIBILITY FOR JOB SITE SAFETY OR JOB SITE SUPERVISION, OR ANYTHING RELATED TO SAME.

4. THE DEMOLITION PLAN IS INTENDED TO PROVIDE GENERAL INFORMATION, ONLY, REGARDING ITEMS TO BE DEMOLISHED AND/OR REMOVED. THE CONTRACTOR MUST ALSO REVIEW THE OTHER SITE PLAN DRAWINGS AND INCLUDE IN DEMOLITION ACTIVITIES ALL INCIDENTAL WORK NECESSARY FOR THE CONSTRUCTION OF THE NEW SITE IMPROVEMENTS.

5. CONTRACTOR MUST RAISE ANY QUESTIONS CONCERNING THE ACCURACY OR INTENT OF THESE PLANS OR SPECIFICATIONS, CONCERNS REGARDING THE APPLICABLE SAFETY STANDARDS, OR THE SAFETY OF THE CONTRACTOR OR THIRD PARTIES IN PERFORMING THE WORK ON THIS PROJECT, WITH BOHLER ENGINEERING, IN WRITING, AND RESPONDED TO BY BOHLER, IN WRITING, PRIOR TO THE INITIATION OF ANY SITE ACTIVITY AND ANY DEMOLITION ACTIVITY. ALL DEMOLITION ACTIVITIES MUST BE PERFORMED IN ACCORDANCE WITH THE REQUIREMENTS OF THESE PLANS AND SPECIFICATIONS AND ALL APPLICABLE FEDERAL, STATE AND LOCAL REGULATIONS, RULES, REQUIREMENTS, STATUTES, ORDINANCES AND CODES.

6. PRIOR TO STARTING ANY DEMOLITION, CONTRACTOR IS RESPONSIBLE FOR/TO:

- A. OBTAINING ALL REQUIRED PERMITS AND MAINTAINING THE SAME ON SITE FOR REVIEW BY THE ENGINEER AND OTHER PUBLIC AGENCIES WITH JURISDICTION THROUGHOUT THE DURATION OF THE PROJECT, SITE WORK, AND DEMOLITION WORK.

- B. NOTIFYING, AT A MINIMUM, THE MUNICIPAL ENGINEER, DESIGN ENGINEER, AND LOCAL SOIL CONSERVATION DISTRICT, 72 HOURS PRIOR TO THE START OF WORK.

- C. INSTALLING THE REQUIRED SOIL EROSION AND SEDIMENT CONTROL MEASURES PRIOR TO SITE DISTURBANCE.

- D. IN ACCORDANCE WITH STATE LAW, THE CONTRACTOR MUST CALL THE STATE ONE-CALL DAMAGE PROTECTION SYSTEM FOR UTILITY MARKOUT, IN ADVANCE OF ANY EXCAVATION.

- E. LOCATING AND PROTECTING ALL UTILITIES AND SERVICES, INCLUDING BUT NOT LIMITED TO GAS, WATER, ELECTRIC, SANITARY AND STORM SEWER, TELEPHONE, CABLE, FIBER OPTIC CABLE, ETC. WITHIN AND ADJACENT TO THE LIMITS OF PROJECT ACTIVITIES. THE CONTRACTOR MUST USE AND COMPLY WITH THE REQUIREMENTS OF THE APPLICABLE UTILITY NOTIFICATION SYSTEM TO LOCATE ALL THE UNDERGROUND UTILITIES.



- F. PROTECTING AND MAINTAINING IN OPERATION, ALL ACTIVE UTILITIES AND SYSTEMS THAT ARE NOT BEING REMOVED DURING ALL DEMOLITION ACTIVITIES.

- G. ARRANGING FOR AND COORDINATING WITH THE APPLICABLE UTILITY SERVICE PROVIDER(S) FOR THE TEMPORARY OR PERMANENT TERMINATION OF SERVICE REQUIRED BY THE PROJECT PLANS AND SPECIFICATIONS. THE CONTRACTOR MUST PROVIDE THE UTILITY ENGINEER AND OWNER WRITTEN NOTIFICATION THAT THE EXISTING UTILITIES AND SERVICES HAVE BEEN TERMINATED AND ABANDONED IN ACCORDANCE WITH JURISDICTIONAL AND UTILITY COMPANY REQUIREMENTS.

- H. COORDINATION WITH UTILITY COMPANIES REGARDING WORKING "OFF-PEAK" HOURS OR ON WEEKENDS AS MAY BE REQUIRED TO MINIMIZE THE IMPACT ON THE AFFECTED PARTIES. WORK REQUIRED TO BE DONE "OFF-PEAK" IS TO BE DONE AT NO ADDITIONAL COST TO THE OWNER.


- I. IN THE EVENT THE CONTRACTOR DISCOVERS ANY HAZARDOUS MATERIAL, THE REMOVAL OF WHICH IS NOT ADDRESSED IN THE PROJECT PLANS AND SPECIFICATIONS, THE CONTRACTOR MUST IMMEDIATELY CEASE ALL WORK AND IMMEDIATELY NOTIFY THE OWNER AND ENGINEER OF THE DISCOVERY OF SUCH MATERIALS.

7. THE FIRM OR ENGINEER OF RECORD IS NOT RESPONSIBLE FOR JOB SITE SAFETY OR SUPERVISION. CONTRACTOR MUST PROCEED WITH THE DEMOLITION IN A SYSTEMATIC AND SAFE MANNER, FOLLOWING ALL THE OSHA REQUIREMENTS, TO ENSURE PUBLIC AND CONTRACTOR SAFETY.

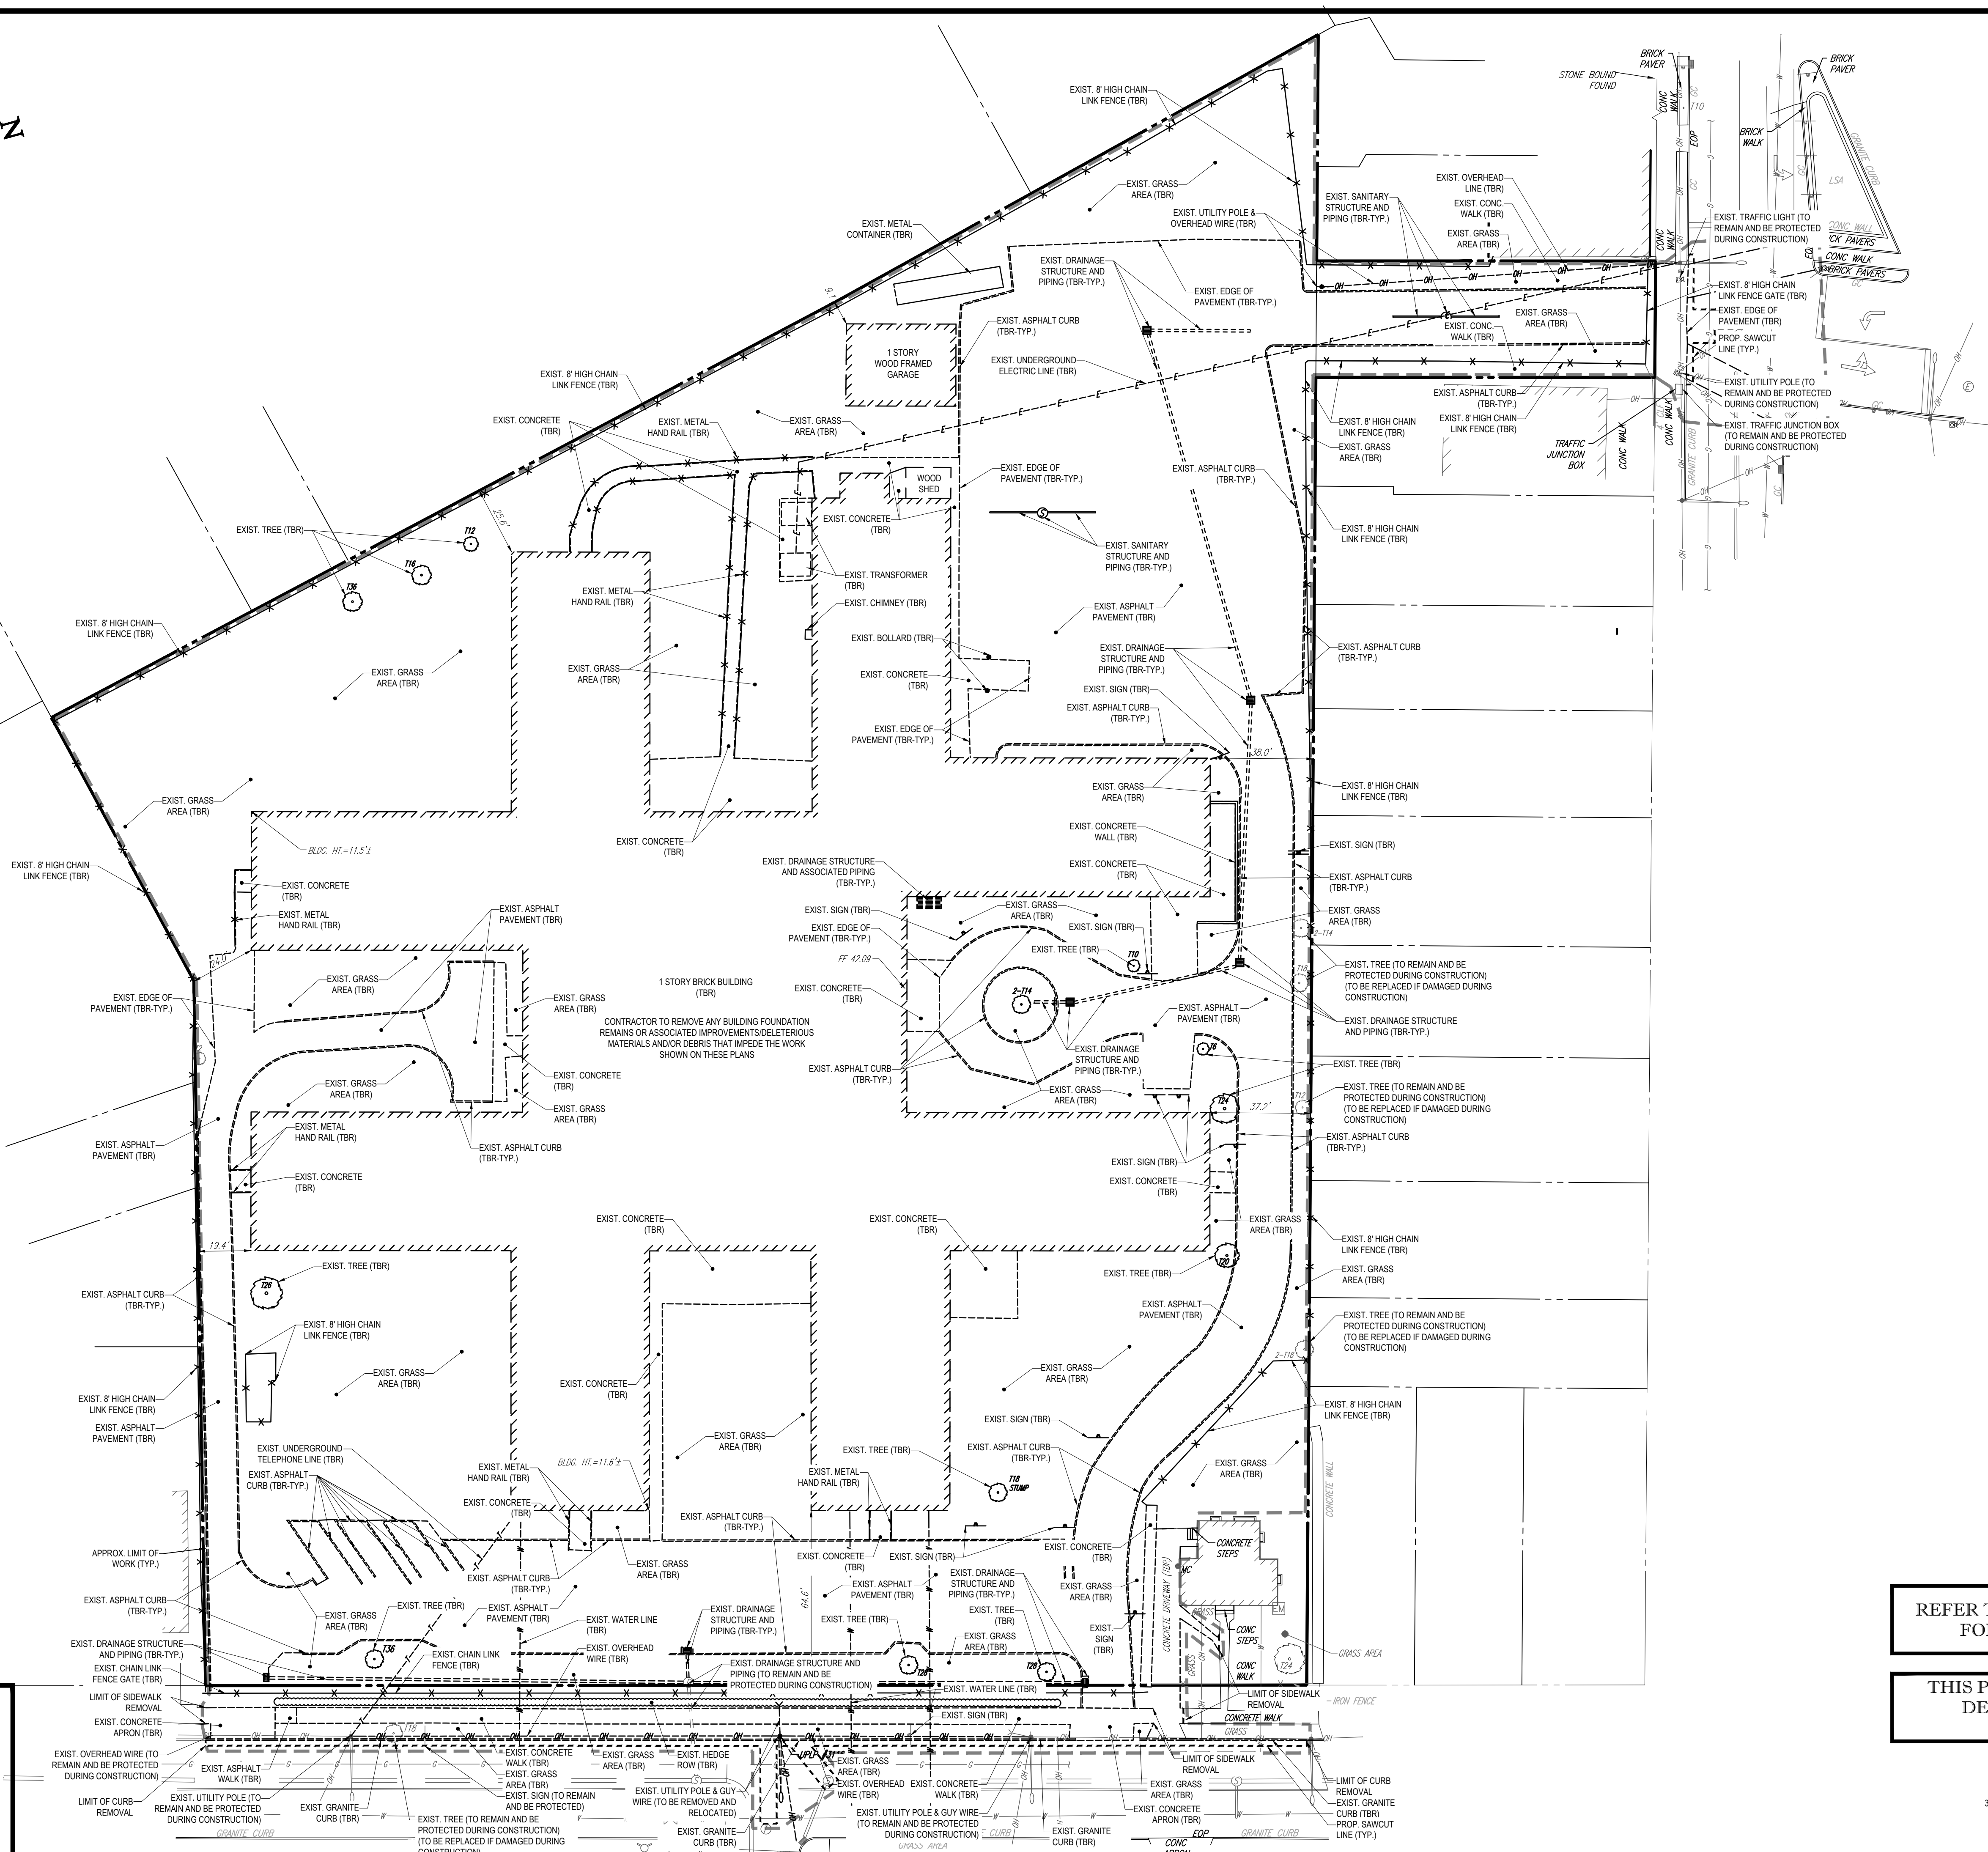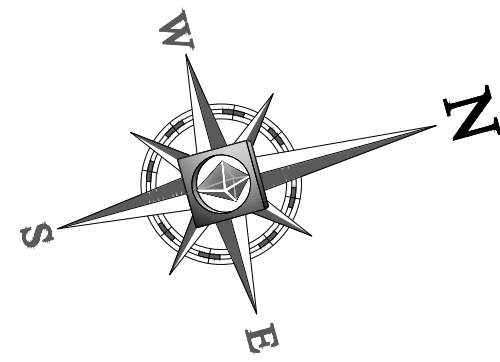

REFER TO GENERAL NOTES SHEET
FOR DEMOLITION NOTES

THIS PLAN TO BE UTILIZED FOR
DEMOLITION/ REMOVAL
PURPOSES ONLY

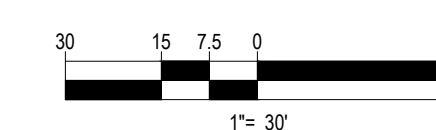

BOHLER ENGINEERING

SITE CIVIL AND CONSULTING ENGINEERING
LAND SURVEYING DESIGN
SUSTAINABLE DESIGN
PERMITTING SERVICES
TRANSPORTATION SERVICES

CHARLOTTE, NC
ATLANTA, GA
BALTIMORE, MD
BIRMINGHAM, AL
CHICAGO, IL
CINCINNATI, OH
COLUMBIA, SC
DENVER, CO
FORT LAUDERDALE, FL
HOUSTON, TX
INDIANAPOLIS, IN
JACKSONVILLE, FL
KANSAS CITY, MO
LONG BEACH, CA
LOS ANGELES, CA
MEMPHIS, TN
MIAMI, FL
MINNEAPOLIS, MN
NEW YORK, NY
PHILADELPHIA, PA
PORTLAND, OR
SAN ANTONIO, TX
SAN JOSE, CA
SEATTLE, WA
SPRINGFIELD, IL
TAMPA, FL
WASHINGTON, DC
WICHITA, KS

REVISIONS			
REV	DATE	COMMENT	BY
1			
2			
3			
4			
5			
6			
7			
8			
9			
10			
11			
12			
13			
14			
15			

PRELIMINARY

PROJECT No.: W161042
DRAWN BY: WSJF
CHECKED BY: JF/AD
DATE: 09/07/18
SCALE: AS NOTED
CAD I.D.: W161042SS0

PROJECT: **SITE DEVELOPMENT PLANS FOR CONNECTICUT HEALTH CARE HOLDINGS LLC**

NEW HAVEN, CT
MAP #339, BLOCK #190, LOT #17
240 WINTHROP AVENUE
CITY OF NEW HAVEN
NEW HAVEN COUNTY, CONNECTICUT

BOHLER ENGINEERING

352 TURNPIKE ROAD
SOUTHBOROUGH, MA 01772
Phone: (508) 480-9900
Fax: (508) 480-9080
www.BohlerEngineering.com

J.G. SWERLING


PROFESSIONAL ENGINEER
MASSACHUSETTS LICENSE No. 41691
NEW HAMPSHIRE LICENSE No. 14695
MAINE LICENSE No. 13816
CONNECTICUT LICENSE No. 30786
RHODE ISLAND LICENSE No. 14255

SHEET TITLE:
DEMOLITION PLAN

SHEET NUMBER:
3


OF 14

REV 0 - 09/07/2018

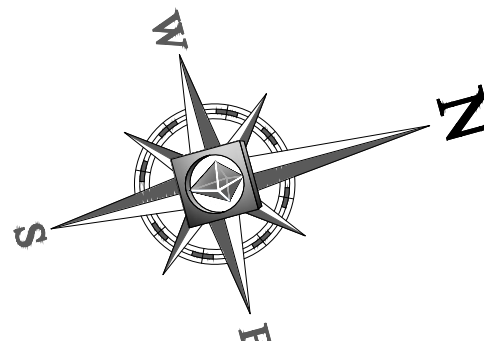

LAND USE / ZONING INFORMATION & NOTES


1. APPLICANT:
CONNECTICUT HEALTHCARE HOLDINGS, LLC
8825 163RD STREET
JAMAICA, NY 11432
2. OWNER:
CONNECTICUT HEALTHCARE HOLDINGS, LLC
8825 163RD STREET
JAMAICA, NY 11432
3. PARCEL:
MAP #339, BLOCK #190, LOT #17
240 WINTHROP AVENUE
TOWN OF NEW HAVEN
NEW HAVEN COUNTY, CONNECTICUT

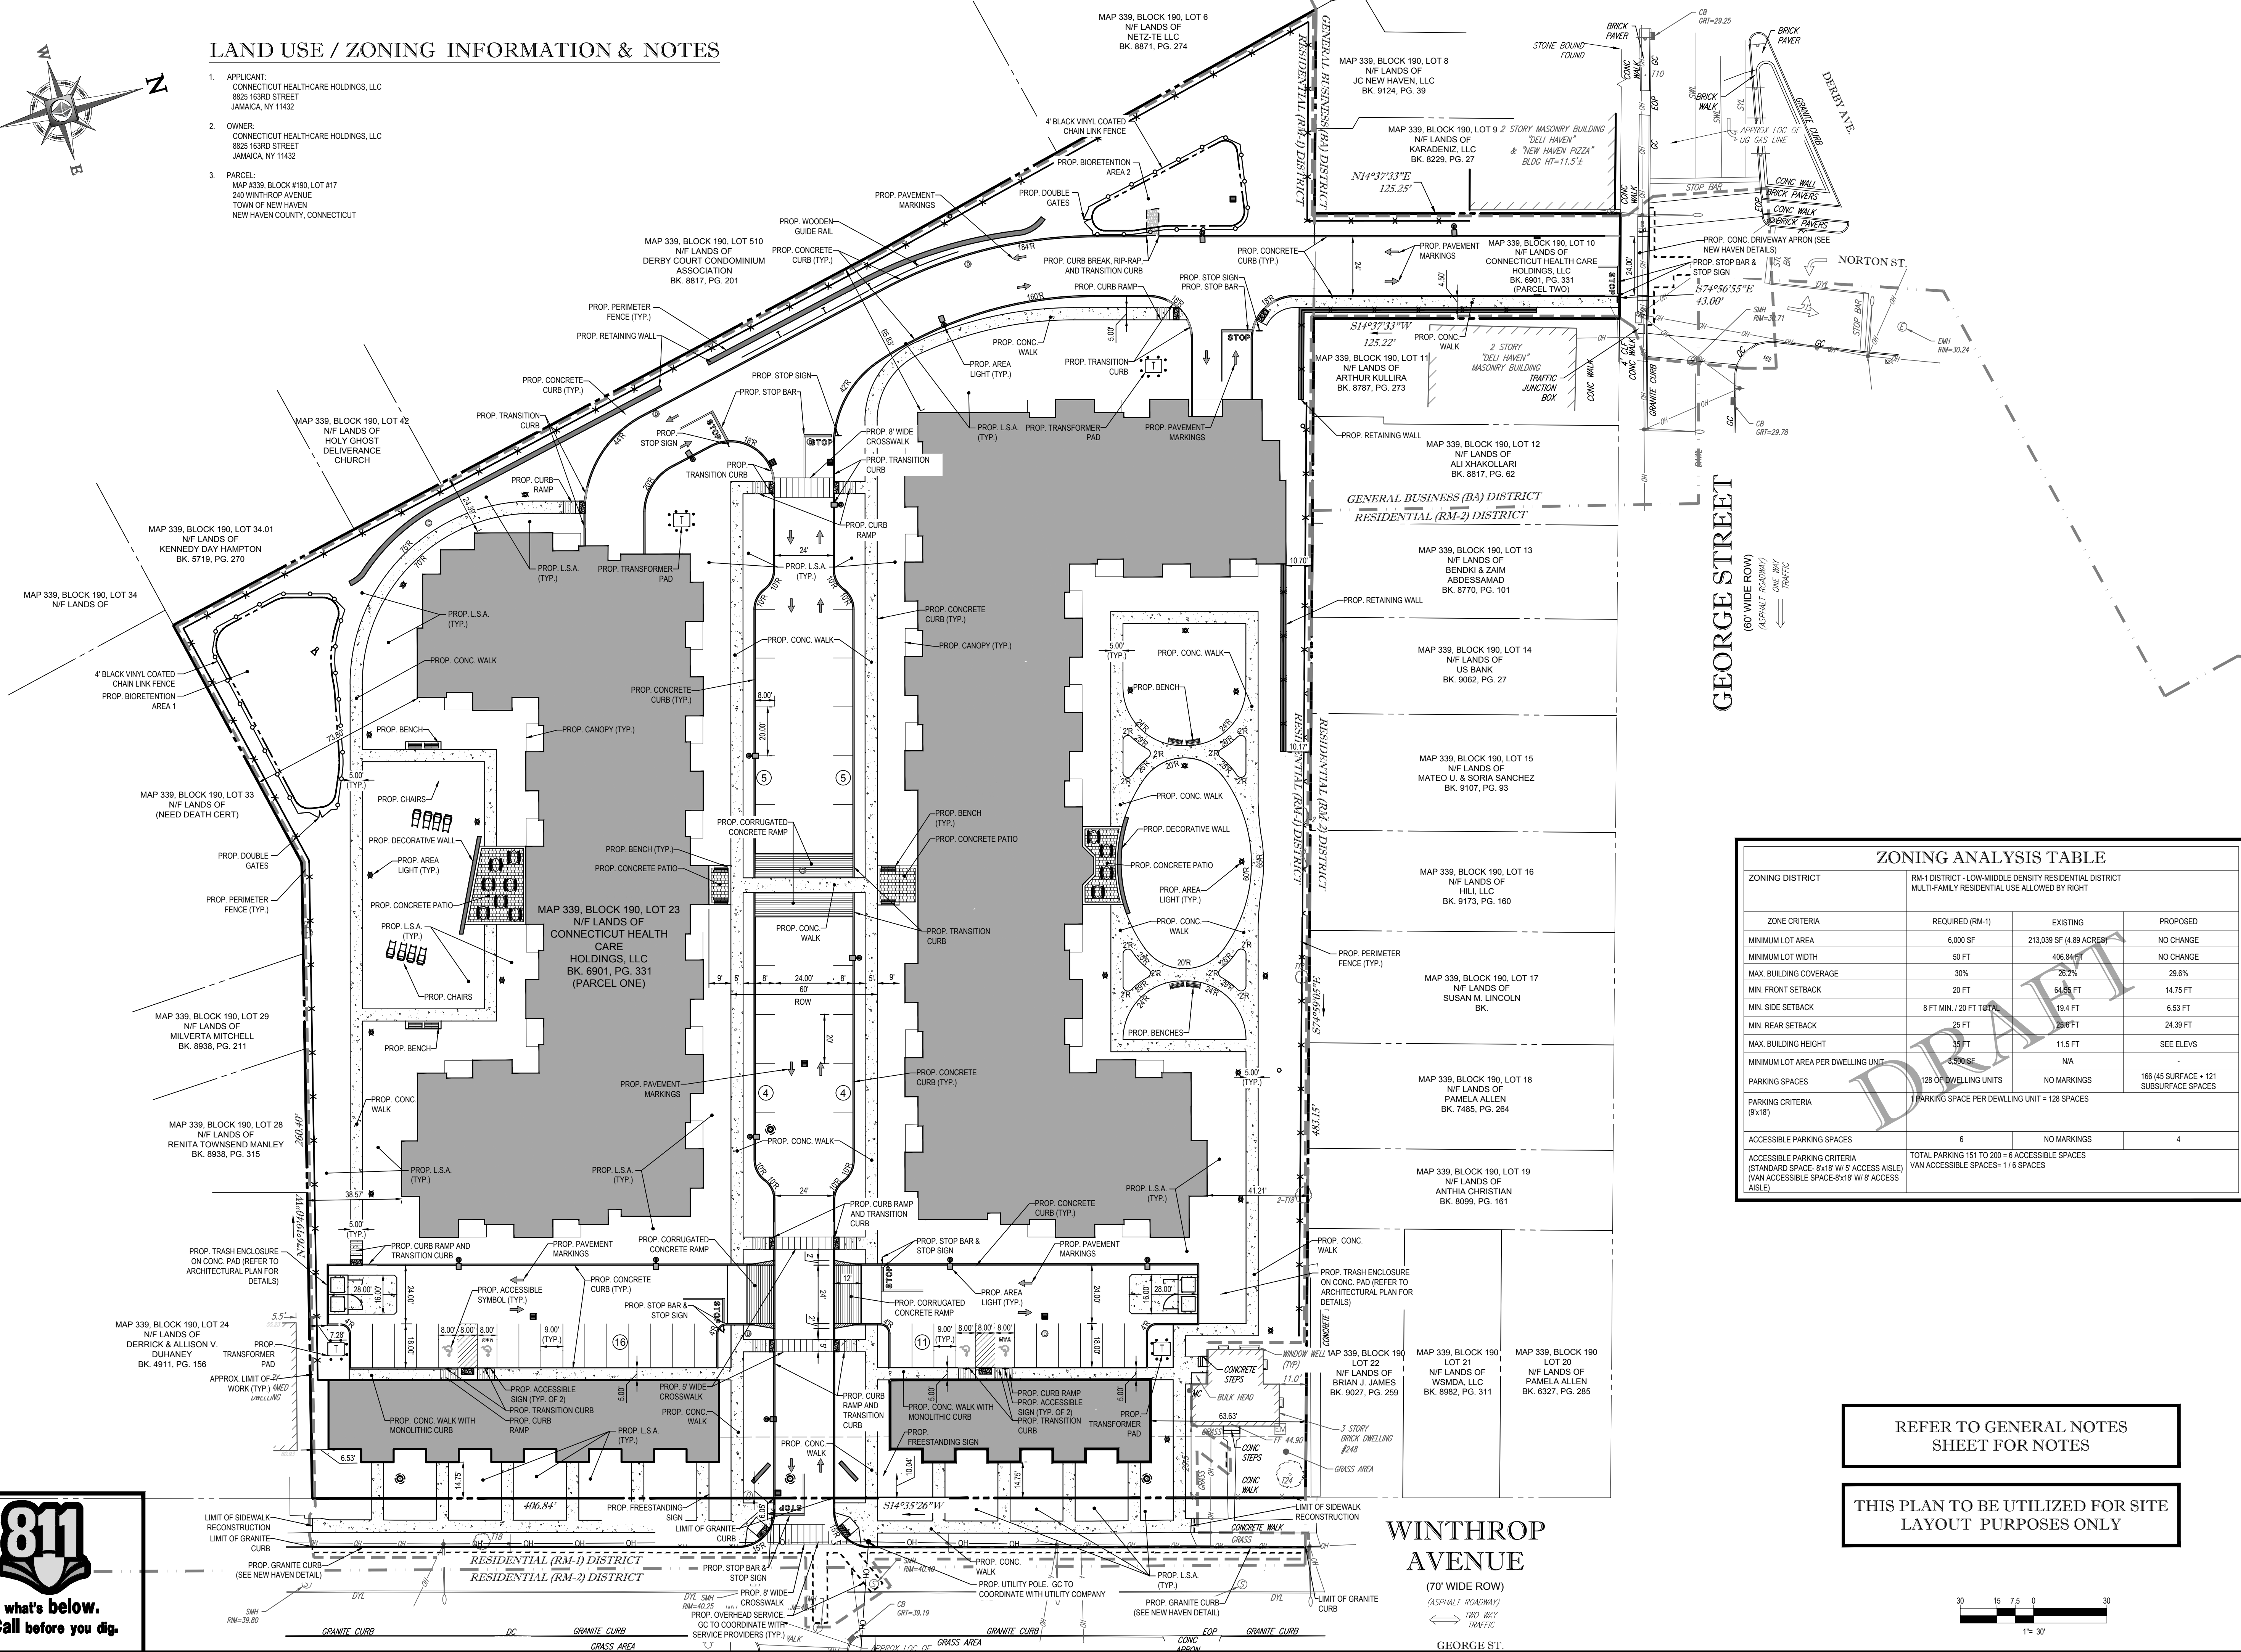

ZONING ANALYSIS TABLE			
ZONING DISTRICT	RM-1 DISTRICT - LOW/MIDDLE DENSITY RESIDENTIAL DISTRICT MULTI-FAMILY RESIDENTIAL USE ALLOWED BY RIGHT		
ZONE CRITERIA	REQUIRED (RM-1)	EXISTING	PROPOSED
MINIMUM LOT AREA	6,000 SF	213,039 SF (4.89 ACRES)	NO CHANGE
MINIMUM LOT WIDTH	50 FT	406.84 FT	NO CHANGE
MAX. BUILDING COVERAGE	30%	26.2%	29.6%
MIN. FRONT SETBACK	20 FT	64.55 FT	14.75 FT
MIN. SIDE SETBACK	8 FT MIN. / 20 FT TOTAL	19.4 FT	6.53 FT
MIN. REAR SETBACK	25 FT	28.6 FT	24.39 FT
MAX. BUILDING HEIGHT	35 FT	11.5 FT	SEE ELEV.
MINIMUM LOT AREA PER DWELLING UNIT	4,500 SF	N/A	
PARKING SPACES	128 OF DWELLING UNITS	NO MARKINGS	166 (45 SURFACE + 121 SUBSURFACE SPACES)
PARKING CRITERIA (9x18)	1 PARKING SPACE PER DWELLING UNIT = 128 SPACES		
ACCESSIBLE PARKING SPACES	6	NO MARKINGS	4
ACCESSIBLE PARKING CRITERIA (STANDARD SPACE- 8x18' W/ 5' ACCESS AISLE) (VAN ACCESSIBLE SPACE-8x18' W/ 8' ACCESS AISLE)	TOTAL PARKING 151 TO 200 = 6 ACCESSIBLE SPACES VAN ACCESSIBLE SPACES= 1 / 6 SPACES		

REFER TO GENERAL NOTES
SHEET FOR NOTES

THIS PLAN TO BE UTILIZED FOR SITE
LAYOUT PURPOSES ONLY

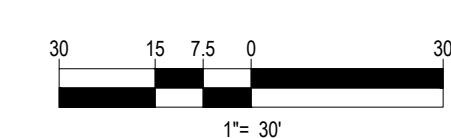

BOHLER ENGINEERING

SITE CIVIL AND CONSULTING ENGINEERING
LAND SURVEYING, ARCHITECTURE
SUSTAINABLE DESIGN, PERMITTING SERVICES, TRANSPORTATION SERVICES

NEW YORK, NY
NEW JERSEY
NEW HAMPSHIRE
MASSACHUSETTS
CONNECTICUT
RHODE ISLAND
VIRGINIA
NORTH CAROLINA
SOUTH CAROLINA
FLORIDA
ALABAMA
LOUISIANA
MISSISSIPPI
ARKANSAS
OKLAHOMA
KANSAS
NEBRASKA
MINNESOTA
IOWA
MICHIGAN
OHIO
PENNSYLVANIA
DELAWARE
MARYLAND
DISTRICT OF COLUMBIA
WASHINGTON
MONTANA
WYOMING
UTAH
ARIZONA
NEW MEXICO
IDAHO
OREGON
CALIFORNIA
HAWAII

REVISIONS			
REV	DATE	COMMENT	BY
1			
2			
3			
4			
5			
6			
7			
8			
9			
10			
11			
12			
13			
14			
15			

PRELIMINARY

PROJECT No.: W161042
DRAWN BY: JWS/JAD
CHECKED BY: JWS/JAD
DATE: 09/07/18
SCALE: AS NOTED
CAD I.D.: W161042S50

PROJECT: **SITE DEVELOPMENT PLANS FOR CONNECTICUT HEALTH CARE HOLDINGS LLC**

NEW HAVEN, CT
MAP #339, BLOCK #190, LOT #17
240 WINTHROP AVENUE
CITY OF NEW HAVEN
NEW HAVEN COUNTY, CONNECTICUT

BOHLER ENGINEERING

352 TURNPIKE ROAD
SOUTHBOROUGH, MA 01772
Phone: (508) 480-9900
Fax: (508) 480-9080
www.BohlerEngineering.com

J.G. SWERLING



PROFESSIONAL ENGINEER
MASSACHUSETTS LICENSE No. 41693
NEW HAMPSHIRE LICENSE No. 14695
MAINE LICENSE No. 13816
CONNECTICUT LICENSE No. 30786
RHODE ISLAND LICENSE No. 1425

SHEET TITLE: **SITE PLAN**

SHEET NUMBER: **4**

OF 14


REV 0 - 09/07/2018

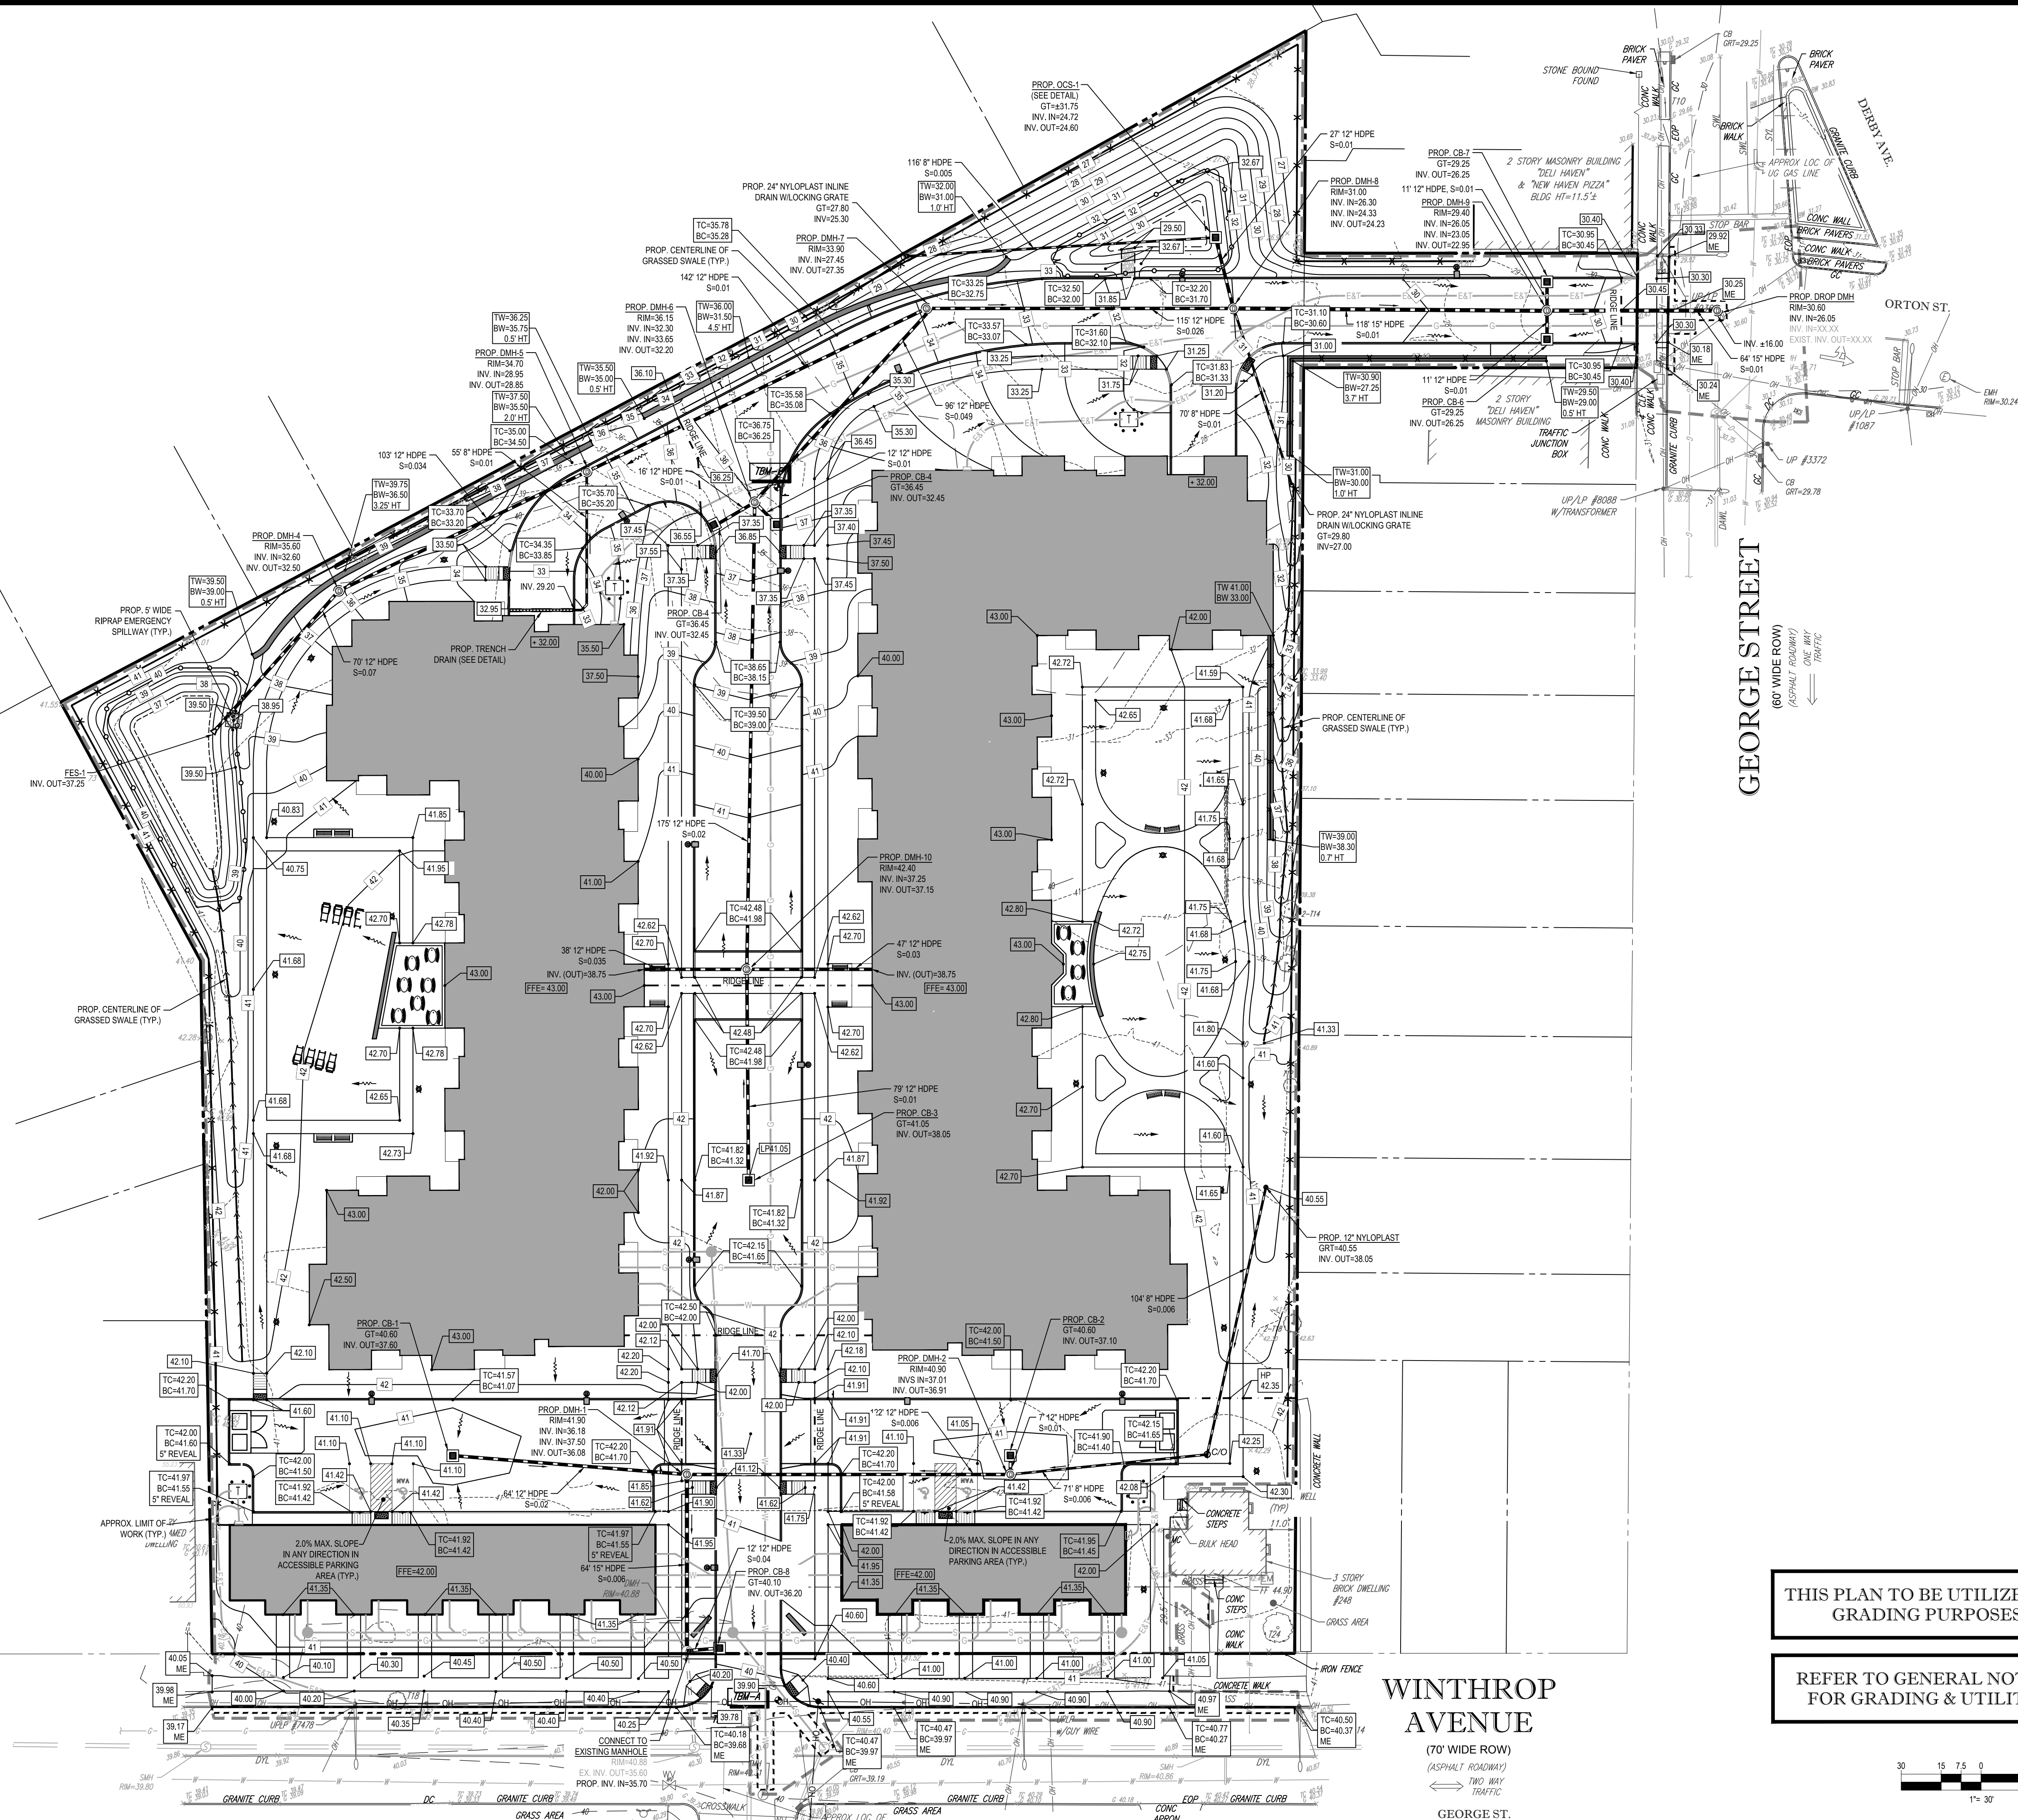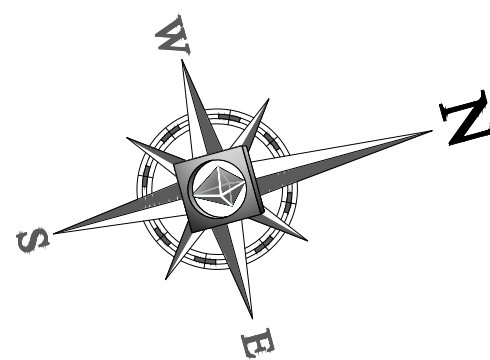

WINTHROP AVENUE
(70' WIDE ROW)
(ASPHALT ROADWAY)
TWO WAY TRAFFIC

THIS PLAN TO BE UTILIZED FOR SITE GRADING PURPOSES ONLY

REFER TO GENERAL NOTES SHEET FOR GRADING & UTILITY NOTES

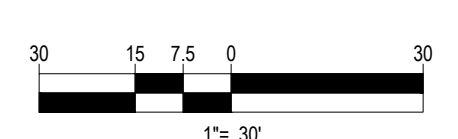

BOHLER ENGINEERING

SITE CIVIL AND CONSULTING ENGINEERING
LAND SURVEYING DESIGN
SUSTAINABLE DESIGN

PERMITTING SERVICES
TRANSPORTATION SERVICES

CHARLOTTE, NC
ATLANTA, GA
BALTIMORE, MD
BIRMINGHAM, AL
CHICAGO, IL
CINCINNATI, OH
COLUMBIA, SC
DENVER, CO
FORT LAUDERDALE, FL
HOUSTON, TX
INDIANAPOLIS, IN
JACKSONVILLE, FL
KANSAS CITY, MO
LOS ANGELES, CA
MEMPHIS, TN
MIAMI, FL
MINNEAPOLIS, MN
NEW YORK, NY
PHILADELPHIA, PA
PORTLAND, ME
SAN ANTONIO, TX
SAN FRANCISCO, CA
SEATTLE, WA
SPRINGFIELD, IL
TAMPA, FL
WASHINGTON, DC
WICHITA, KS

REVISIONS			
REV	DATE	COMMENT	BY
1			
2			
3			
4			
5			
6			
7			
8			
9			
10			
11			
12			
13			
14			
15			

PRELIMINARY

PROJECT No.: W161042

DRAWN BY: WS/JF

CHECKED BY: JF/AD

DATE: 09/07/18

SCALE: AS NOTED

CAD I.D.: W161042SS0

SITE DEVELOPMENT PLANS

FOR

CONNECTICUT HEALTH CARE HOLDINGS LLC

NEW HAVEN, CT
MAP #339, BLOCK #190, LOT #17
240 WINTHROP AVENUE
CITY OF NEW HAVEN
NEW HAVEN COUNTY,
CONNECTICUT

BOHLER ENGINEERING

352 TURNPIKE ROAD
SOUTHBOROUGH, MA 01772
Phone: (508) 480-9900
Fax: (508) 480-9080
www.BohlerEngineering.com

J.G. SWERLING


PROFESSIONAL ENGINEER
MASSACHUSETTS LICENSE No. 41697
NEW HAMPSHIRE LICENSE No. 14699
MAINE LICENSE No. 13816
CONNECTICUT LICENSE No. 30786
RHODE ISLAND LICENSE No. 1425

GRADING & DRAINAGE PLAN

SHEET NUMBER: 5

OF 14


REV 0 - 09/07/2018

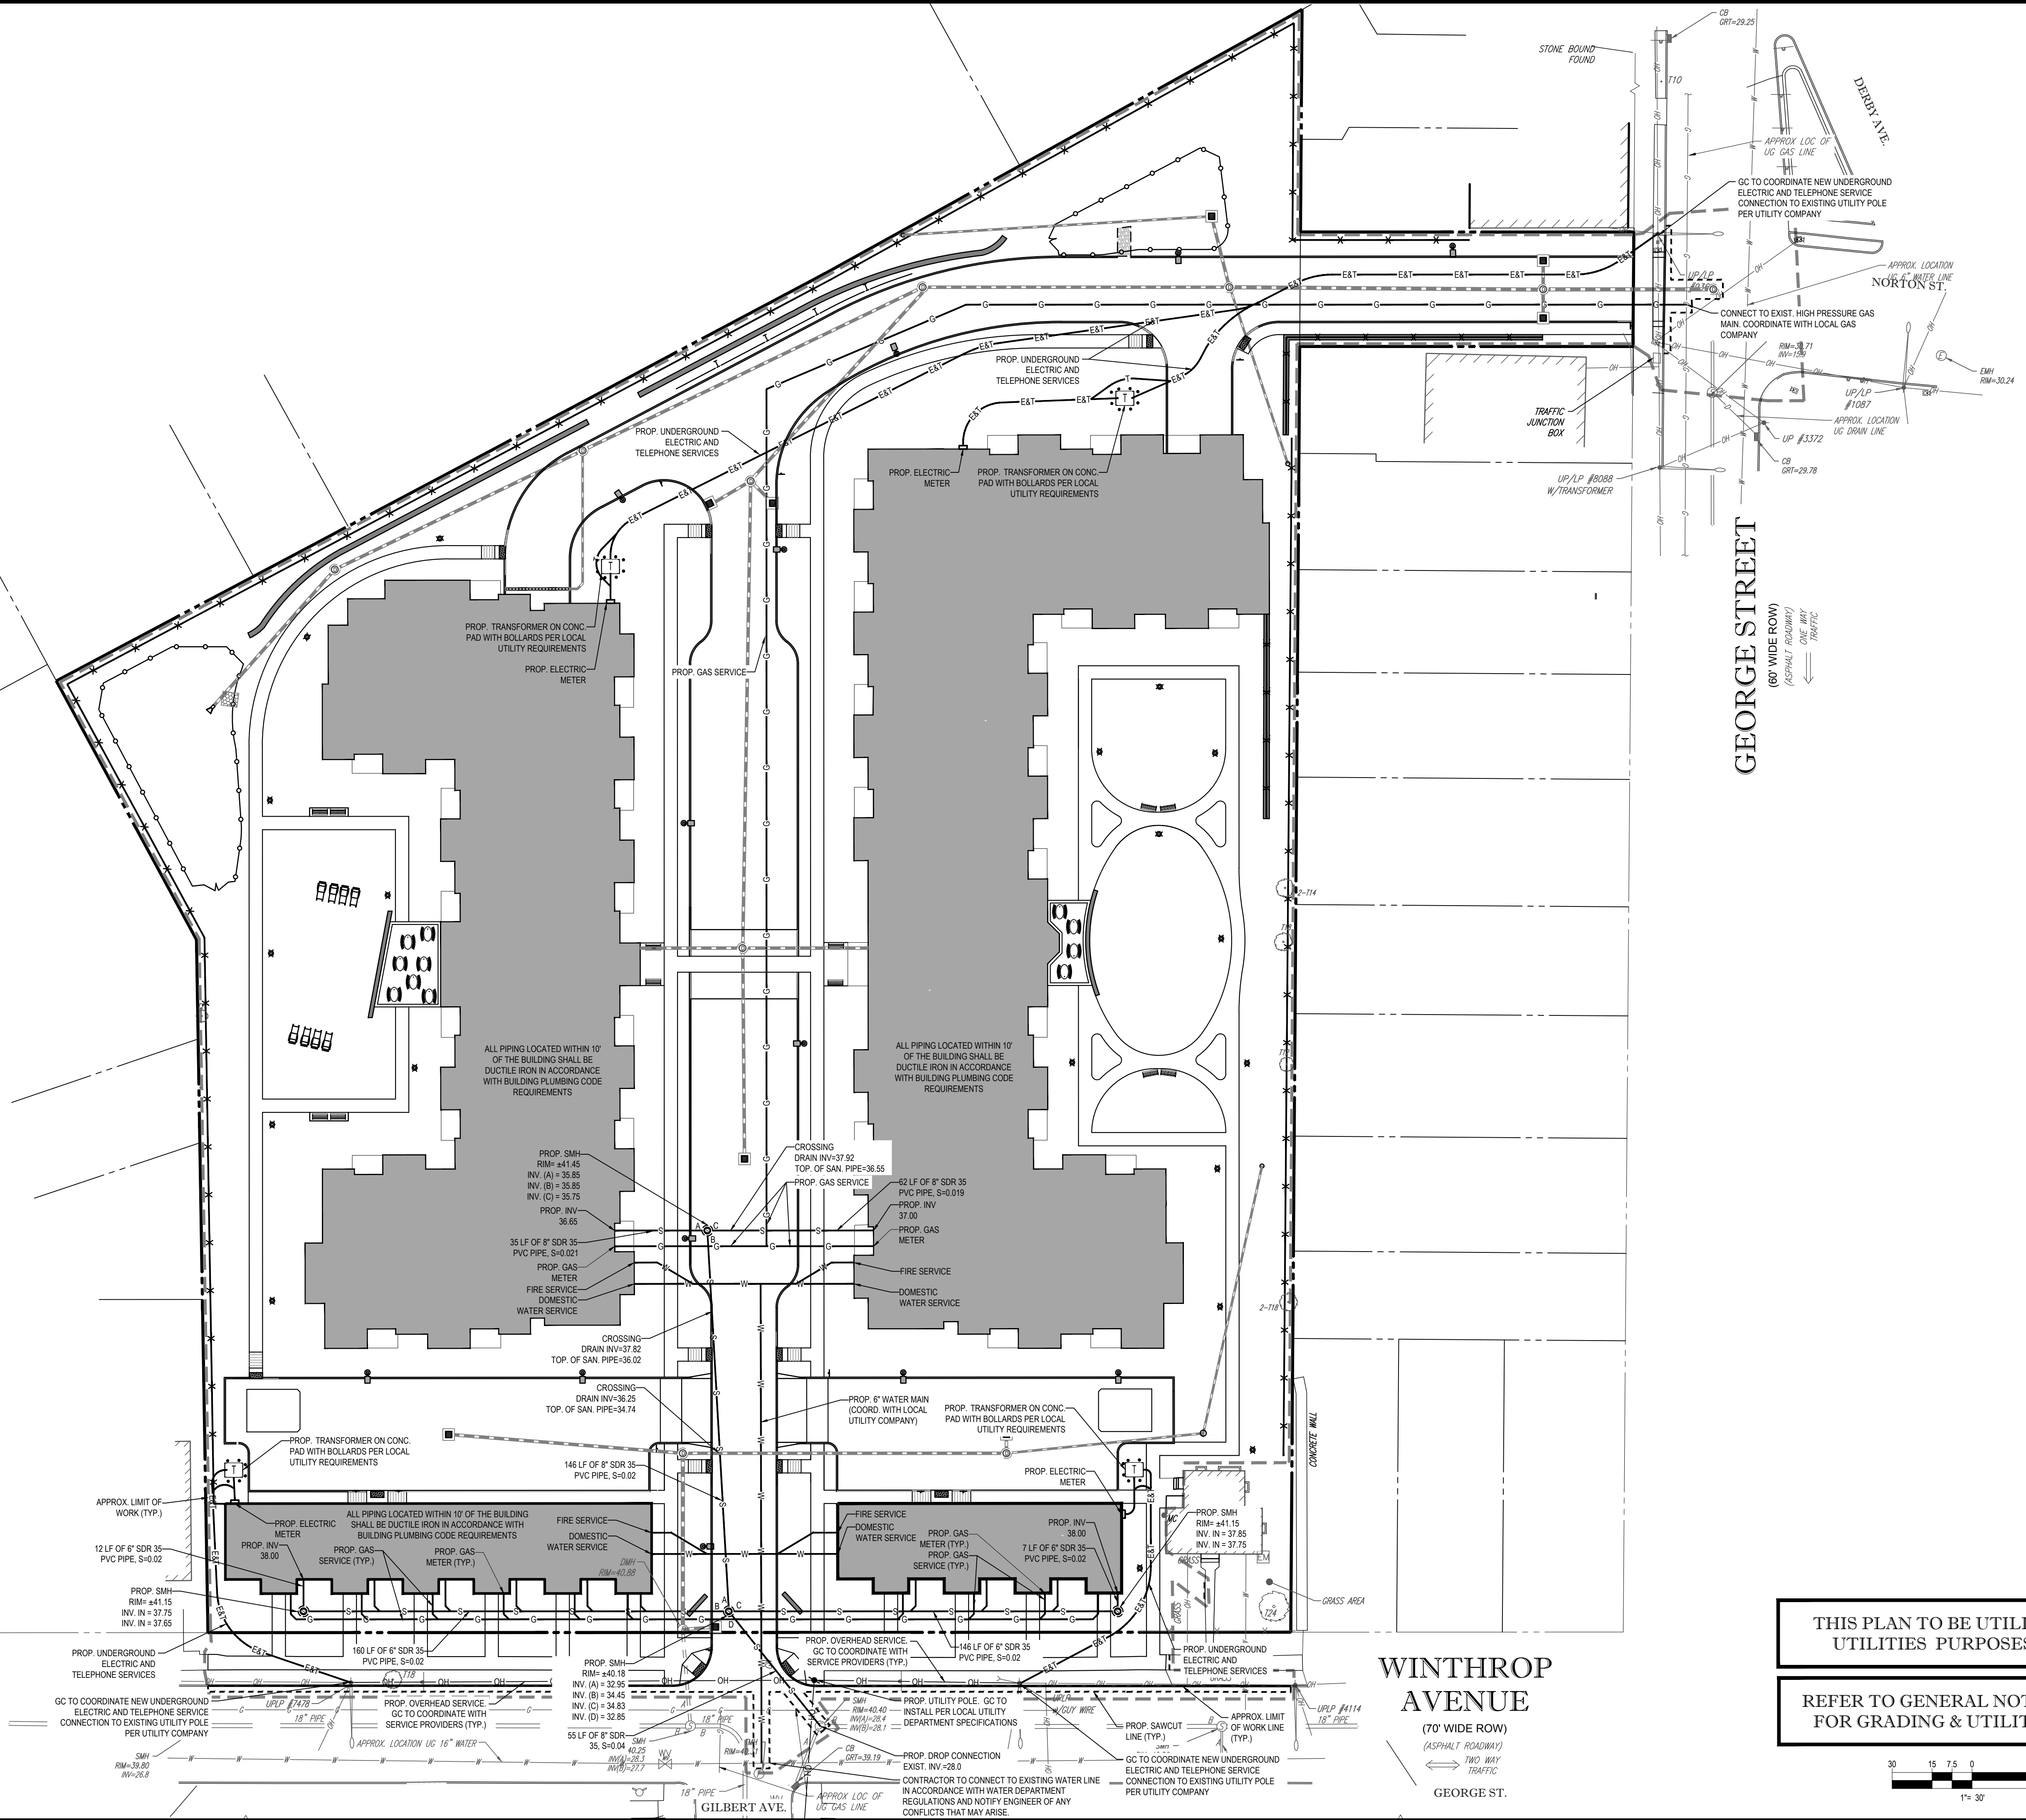

GEORGE STREET
(60' WIDE ROW)
(ASPHALT ROADWAY)
ONE WAY TRAFFIC

WINTHROP AVENUE
(70' WIDE ROW)
(ASPHALT ROADWAY)
TWO WAY TRAFFIC

 THIS PLAN TO BE UTILIZED FOR UTILITIES PURPOSES ONLY
REFER TO GENERAL NOTES SHEET FOR GRADING & UTILITY NOTES



Know what's below.
Call before you dig.

**BOHLER**
ENGINEERING

SITE CIVIL AND CONSULTING ENGINEERING
LAND SURVEYING DESIGN
SUSTAINABLE DESIGN
PERMITTING SERVICES
TRANSPORTATION SERVICES

CHARLOTTE, NC

ATLANTA, GA

SOUTH FLOIDA

DALLAS, TX

MEMPHIS, TN

INDIANAPOLIS, IN

CHICAGO, IL

PHILADELPHIA, PA

HOUSTON, TX

NEW YORK, NY

NEW JERSEY, NJ

NEW HAMPSHIRE, NH

MAINE, ME

VERMONT, VT

CONNECTICUT, CT

MASSACHUSETTS, MA

RHODE ISLAND, RI

NEW MEXICO, NM

UTAH, UT

ARIZONA, AZ

NEVADA, NV

CALIFORNIA, CA

OREGON, OR

WASHINGTON, WA

IDAHO, ID

MONTANA, MT

WYOMING, WY

NEBRASKA, NE

KANSAS, KS

OKLAHOMA, OK

MISSOURI, MO

ILLINOIS, IL

INDIANA, IN

MICHIGAN, MI

OHIO, OH

PENNSYLVANIA, PA

DELAWARE, DE

MARYLAND, MD

VIRGINIA, VA

NORTH CAROLINA, NC

SOUTH CAROLINA, SC

MISSISSIPPI, MS

ALABAMA, AL

LOUISIANA, LA

TEXAS, TX

REVISIONS			
REV	DATE	COMMENT	BY
1			
2			
3			
4			
5			
6			
7			
8			
9			
10			
11			
12			
13			
14			
15			

PRELIMINARY

PROJECT No.: W161042

DRAWN BY: WSJF

CHECKED BY: JF/AD

DATE: 09/07/18

SCALE: AS NOTED

CAD I.D.: W161042SS0

PROJECT: **SITE DEVELOPMENT PLANS**
FOR
CONNECTICUT HEALTH CARE HOLDINGS LLC
NEW HAVEN, CT
MAP #339, BLOCK #190, LOT #17
240 WINTHROP AVENUE
CITY OF NEW HAVEN
NEW HAVEN COUNTY,
CONNECTICUT

**BOHLER**
ENGINEERING

352 TURNPIKE ROAD
SOUTHBOROUGH, MA 01772
Phone: (508) 480-9900
Fax: (508) 480-9080
www.BohlerEngineering.com


J.G. SWERLING

PROFESSIONAL ENGINEER
MASSACHUSETTS LICENSE No. 41699
NEW HAMPSHIRE LICENSE No. 14699
MAINE LICENSE No. 13818
CONNECTICUT LICENSE No. 30796
RHODE ISLAND LICENSE No. 14295

SHEET TITLE:
UTILITY PLAN

SHEET NUMBER:
6
OF 14

REV 0 - 09/07/2018

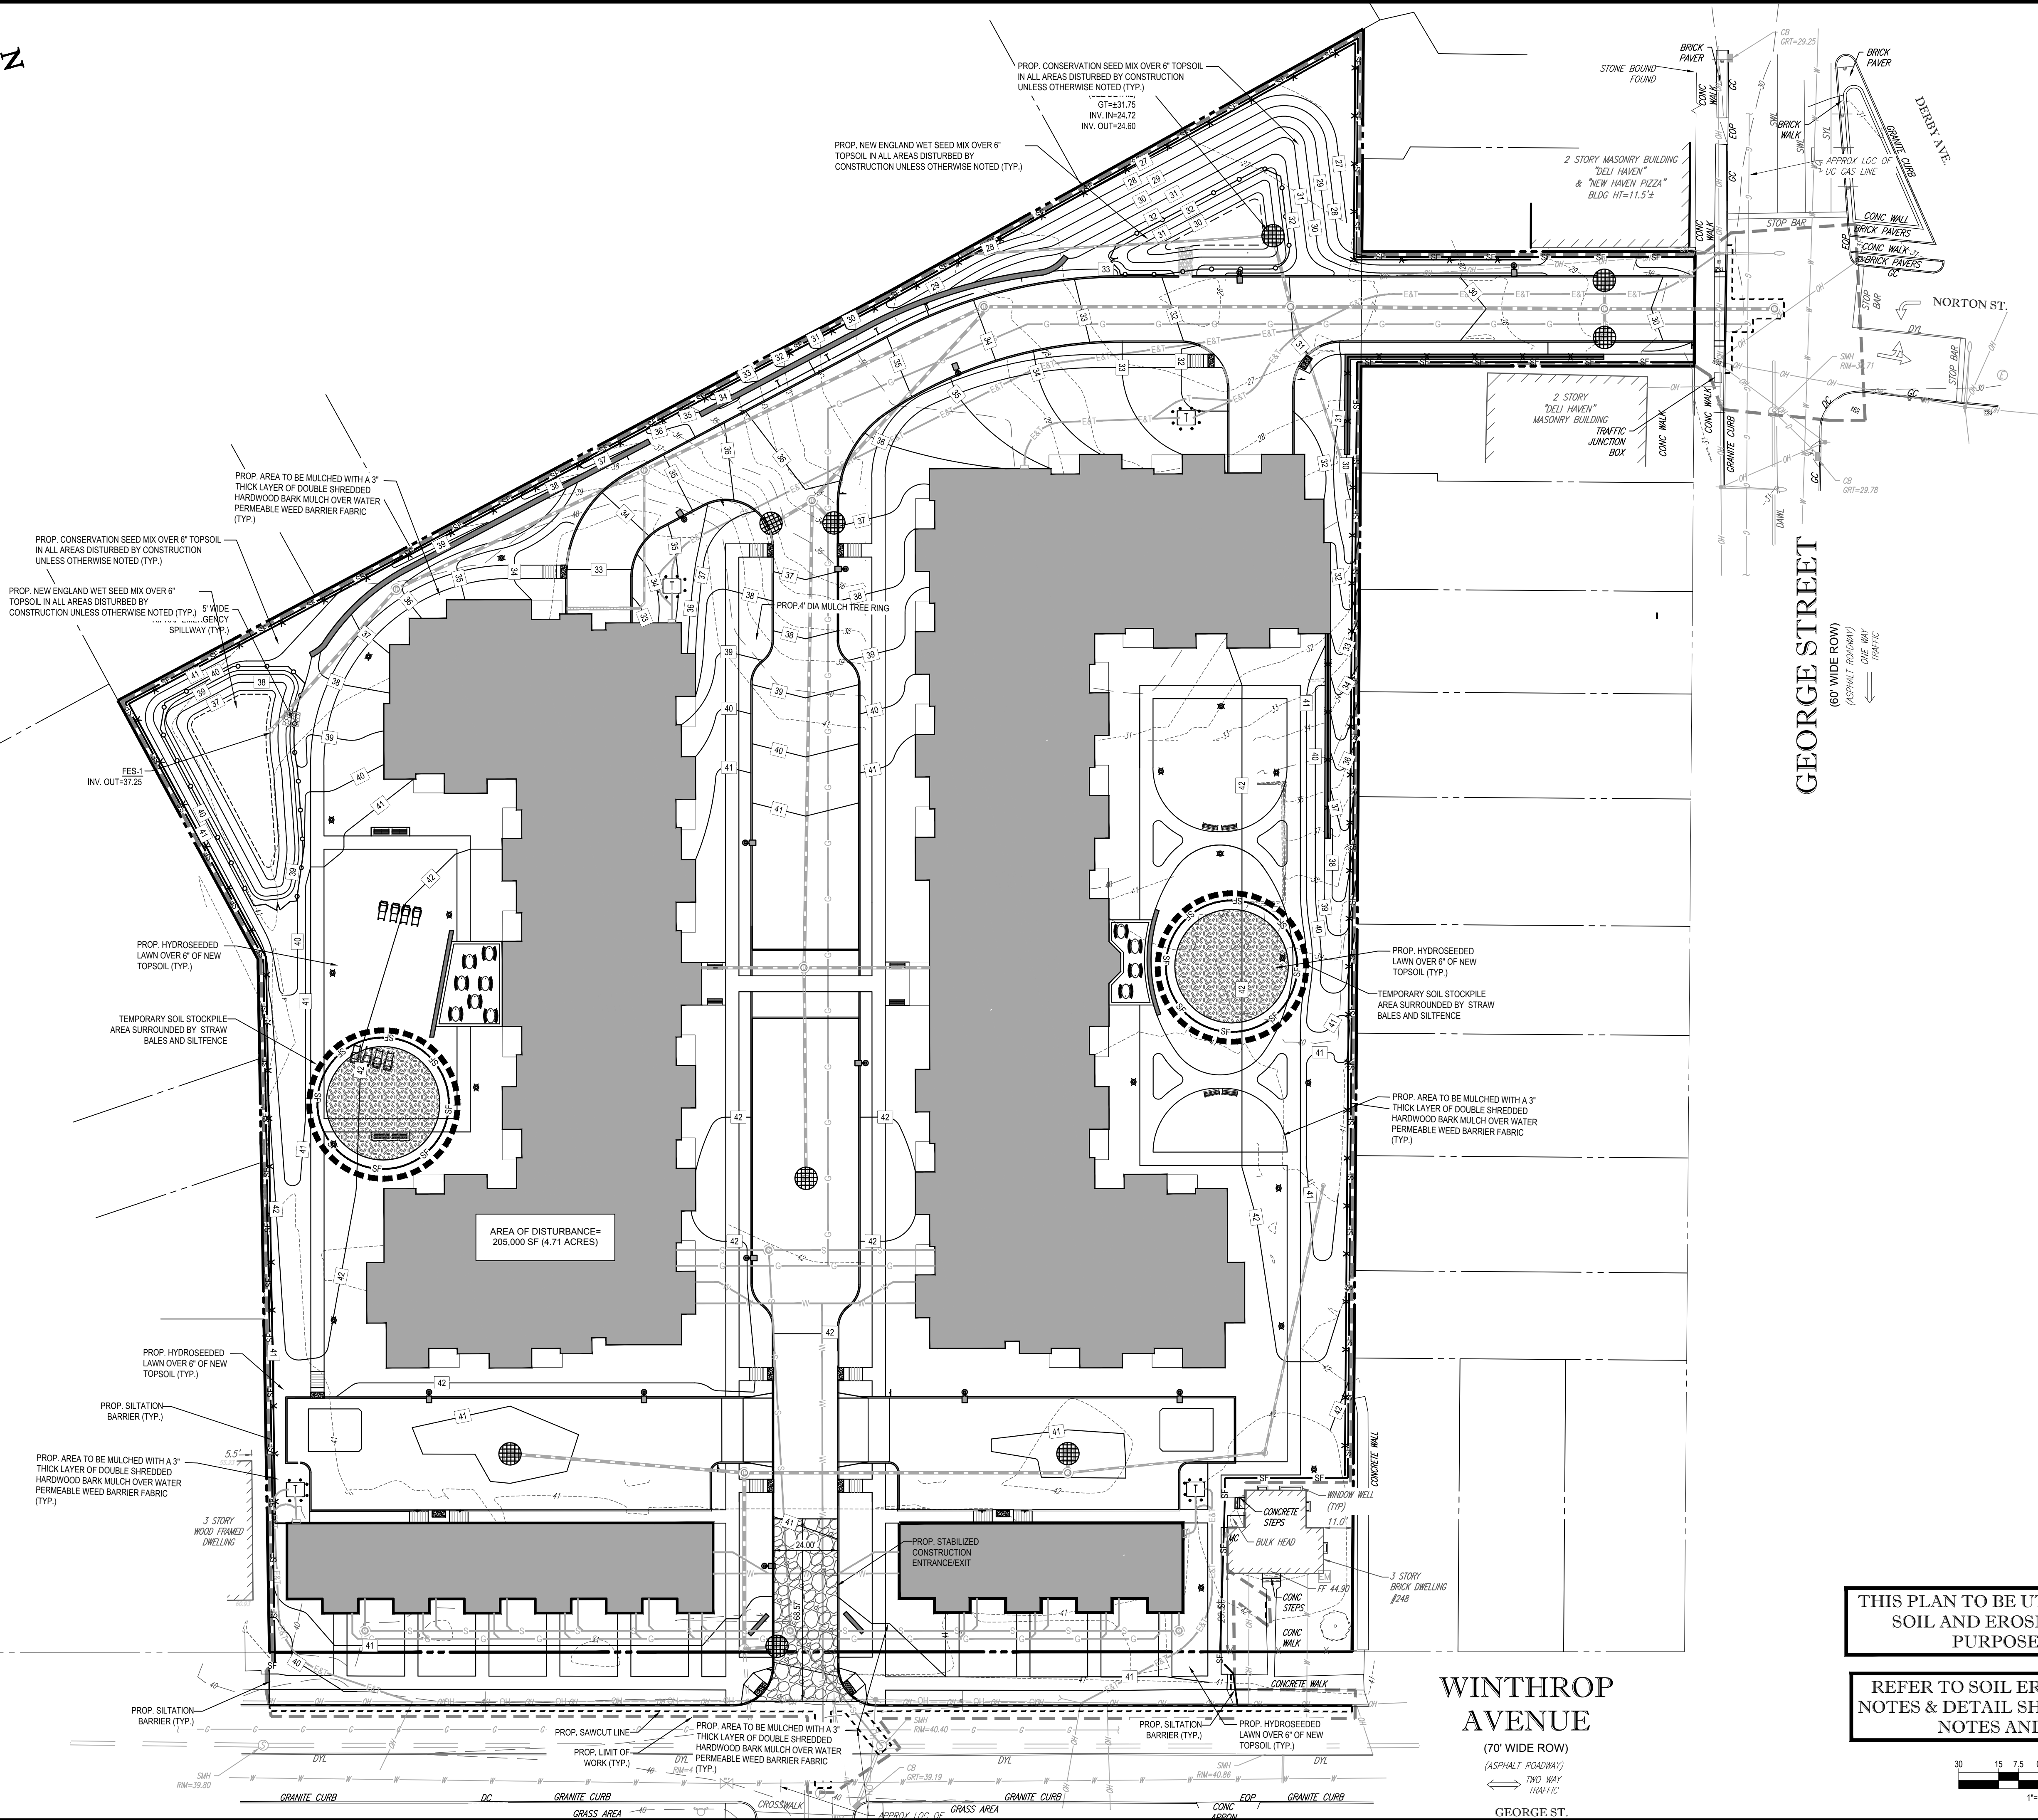

**Know what's below.
Call before you dig.**

(70' WIDE ROW)

(ASPHALT ROADWAY)

 TWO WAY TRAFFIC

GEORGE ST.

REV 0 - 09/07/2018

EROSION CONTROL NARRATIVE

- NARRATIVE:
- 1.1 PURPOSE
THE PROPOSED WORK WILL CONSIST OF CONSTRUCTION NECESSARY TO BUILD AN O'REILLY AUTOMOTIVE PARTS STORE WITH ALL ASSOCIATED PARKING.
- 1.2 DISTURBANCE
THE PROPOSED PROJECT WILL DISTURB APPROXIMATELY 0.81 - ACRES OF LAND.
- 1.3 SITE SPECIFIC CONCERNS
PREVENTION OF POLLUTION AND SEDIMENT ENTERING DOWNSTREAM WATERCOURSE(S) BY MEANS OF STORMWATER QUALITY UNIT BEFORE ENTERING THE WETLANDS.
- 1.4 CONSTRUCTION PHASING - AS INDICATED BELOW (1.6)
- 1.5 CONSTRUCTION SCHEDULE
THE ANTICIPATED CONSTRUCTION START IS SPRING/SUMMER OF 2016, WITH COMPLETION ANTICIPATED SIX TO TWELVE MONTHS AFTER THE START DATE. APPROPRIATE EROSION AND CONTROL MEASURES AS DESCRIBED HEREIN SHALL BE INSTALLED BY THE CONTRACTOR PRIOR TO THE COMMENCEMENT OF ALL CONSTRUCTION ACTIVITY. THE PROPERTY OWNER SHALL BE RESPONSIBLE FOR SAID INSTALLATION AND MAINTENANCE OF ALL EROSION CONTROL MEASURES DESCRIBED HEREIN.
- 1.6 CONSTRUCTION SEQUENCE
THE FOLLOWING CONSTRUCTION SEQUENCE IS RECOMMENDED:
-INSTALLATION OF STABILIZED CONSTRUCTION ENTRANCE/EXIT (AS SHOWN)
-INSTALLATION OF EROSION CONTROL BARRIER (STRAWBALES AND SILT FENCE) (AS SHOWN)
-INSTALLATION OF INLET PROTECTION (STRAWBALES) IN STREET (AS SHOWN)
-CLEARING AND GRUBBING IN AREAS DESIGNATED AS BEING REMOVED (IF NECESSARY)
-INSTALLATION OF TEMPORARY SWALES AND SEDIMENT BASINS (IF NECESSARY)
-EARTHWORK AND EXCAVATION/FILLING AS NECESSARY.
-STABILIZE PERMANENT LAWN AREAS AND SLOPES WITH TEMPORARY SEEDING
-CONSTRUCTION OF UTILITIES
-INSTALLATION OF INLET PROTECTION (STRAWBALES) ON ON-SITE UTILITIES (AS SHOWN)
-CONSTRUCTION OF BUILDINGS
-CONSTRUCTION OF ALL CURBING AND LANDSCAPE ISLANDS AS INDICATED ON THE PLANS.
-SPREAD TOPSOIL ON SLOPED AREAS AND SEED AND MULCH.
-FINAL GRADING OF ALL SLOPED AREAS.
-PLACE 4" TOPSOIL ON SLOPES AFTER FINAL GRADING COMPLETED. FERTILIZE, SEED, AND MULCH SEED MIXTURE TO BE INSTALLED REQUIRED.
-PAVE PARKING LOT.
-LANDSCAPING.
-REMOVE EROSION CONTROLS AS DISTURBED AREAS BECOME STABILIZED TO 70% STABILIZATION OR GREATER.
- 1.7 OTHER PERMITS
NONE REQUIRED
- 1.8 CONSERVATION PRACTICES
CONSERVATION PRACTICES INCLUDE LIMITING THE SCOPE OF THE PROJECT TO MINIMIZE ACTIVITIES WHICH REQUIRES BARE SOILS TO BE EXPOSED. 0.81 - ACRES OF LAND DISTURBANCE IS PROPOSED FOR THIS PROJECT.
- 1.9 SUPPORT DOCUMENTS
NO SUPPORTING DOCUMENTS.

G.C. REQUIREMENT NAME: _____
ORGANIZATION: _____

TEMPORARY CONTROL OF SEDIMENT AND EROSION:
THE OBJECTIVE OF TEMPORARY EROSION CONTROL DURING CONSTRUCTION IS TO MINIMIZE THE AREA OF EXPOSED SOIL, CONTROL RUNOFF RATE AND DIRECTION, AND PROVIDE FOR RAPID STABILIZATION OF EXPOSED AREAS. PRIOR TO ANY CONSTRUCTION ACTIVITY, TRENCHED SILTATION FENCE AND/OR STAKED HAY BALES WILL BE PLACED AROUND THE PROPOSED WORK AREAS. THE FENCE/ BARRIER WILL PROVIDE SEDIMENT CONTROL, AS WELL AS, PROVIDE A LIMIT OF CONSTRUCTION ACTIVITY. FURTHER, INLET PROTECTION WILL BE PLACED AT ALL EXISTING ON-SITE CATCH BASINS.

ANY EXCAVATED AND STOCKPILED TOPSOIL WILL BE CONTAINED WITHIN STAKED HAY BALES AND/OR FILTER FENCE. EROSION-PRONE AREAS LEFT EXPOSED FOR EXTENDED PERIODS (>30 DAYS) WILL BE MULCHED AND SEEDING FOR TEMPORARY VEGETATIVE COVER. AFTER CONSTRUCTION, ALL EXPOSED AREAS WILL BE GRADED, MULCHED AND RE-VEGETATED WITH APPROPRIATE GROUND COVER. THE SILT FENCE AND HAY BALES WILL REMAIN IN PLACE UNTIL GROUND COVER IS ESTABLISHED.

THROUGHOUT ALL PHASES OF CONSTRUCTION, THE EROSION CONTROL MEASURES WILL BE ROUTINELY INSPECTED AND CLEANED, REPAIRED, AND REPLACED AS NECESSARY. MAINTENANCE OF EROSION AND SEDIMENTATION CONTROL MEASURES IS CRITICAL TO THEIR EFFECTIVENESS. MAINTENANCE WILL BE AN ONGOING PROCESS DURING THE PERIOD OF CONSTRUCTION AND WILL CONTINUE UNTIL LONG-TERM VEGETATION IS ESTABLISHED. THE SPECIFIC EROSION AND SEDIMENTATION CONTROL MEASURES, WHICH INCLUDE A BARRIER OF TRENCHED SILTATION FENCE, STAKED HAY BALES, AND INLET PROTECTION WILL, THROUGHOUT ALL PHASES OF CONSTRUCTION, BE INSPECTED AT THE END OF EACH WORK DAY IF PRECIPITATION IS FORECAST AND AFTER EACH RAINFALL. AT THE END OF EACH WORK WEEK, PRIOR TO WEEKENDS, ALL EROSION AND SEDIMENT CONTROL MEASURES WILL BE INSPECTED.

THROUGHOUT THE CONSTRUCTION PROCESS, EXTRA STOCKS OF HAY BALES AND SILTATION FENCING WILL BE KEPT ON-SITE TO REPLACE THOSE THAT BECOME DAMAGED AND/OR DETERIORATED.

ANY EROSION AND SEDIMENT CONTROL MEASURES, WHICH UPON INSPECTION ARE FOUND TO BE DAMAGED, DETERIORATED OR NOT FUNCTIONING PROPERLY, WILL BE REPAIRED, REPLACED AND CORRECTED IMMEDIATELY AFTER INSPECTION.

AREAS, WHICH ARE MULCHED OR SEEDING FOR TEMPORARY VEGETATIVE COVER, WILL BE INSPECTED FOR PROPER COVER AT THE END OF EACH WORKDAY IF PRECIPITATION IS FORECAST AND ALSO PRIOR TO WEEKENDS. CONTRACTOR SHALL KEEP PAVING CLEAR AT ALL TIMES. ADDITIONAL SEEDING OR MULCH WILL BE PLACED AS NECESSARY.

THE TEMPORARY EROSION AND SEDIMENT CONTROL SYSTEMS WILL NOT BE REMOVED UNTIL ALL STORMWATER DRAINAGE SYSTEM COMPONENTS ARE IN PLACE, CLEANED AND WORKING PROPERLY AND UNTIL PERMANENT VEGETATIVE COVER AND OTHER STABILIZATION MEASURES ARE ESTABLISHED.

DESIGN, INSTALLATION, OPERATION, AND MAINTENANCE OF SOIL EROSION AND SEDIMENT CONTROL MEASURES WILL BE PERFORMED IN ACCORDANCE WITH REQUIREMENTS AND GUIDELINES SET FORTH BY THE CONNECTICUT DEPARTMENT OF ENVIRONMENTAL PROTECTION.

PERMANENT CONTROL OF SEDIMENT AND EROSION: (NOT A G.C. REQUIREMENT)
POTENTIAL LONG-TERM EROSION AND SEDIMENTATION IMPACTS WILL BE CONTROLLED BY THE USE OF THE EXISTING BMPs ON-SITE. THE EXISTING STORMWATER MANAGEMENT SYSTEM WAS DESIGNED TO CONTROL THE PEAK RATE OF RUNOFF AND THE OUTLETS OF THE STORMWATER COLLECTION SYSTEMS HAVE BEEN DESIGNED TO DISSIPATE AND DISPERSE THE RUNOFF AND PREVENT SCOURING OF THE RECEIVING AREA.

OPERATION AND MAINTENANCE PLAN: (NOT A G.C. REQUIREMENT)
A CHECKLIST OF ALL MAINTENANCE ITEMS WILL BE DEVELOPED AND USED FOR EACH STORMWATER TREATMENT SYSTEM. EACH TIME A SYSTEM UNDERGOES A CHECK OR MAINTENANCE PROCEDURE, IT WILL BE DOCUMENTED ON THE CHECKLIST. THE CHECKLISTS WILL BE KEPT ON-SITE IN A MAINTENANCE LOG.

THE PARKING LOTS WILL BE SWEEP PERIODICALLY TO REMOVE ACCUMULATED GRIT AND DEBRIS. SINCE MOST STORMWATER POLLUTANTS TRAVEL WITH THE SUSPENDED SOLIDS CONTAINED IN STORMWATER RUNOFF, SWEEPING WILL HELP REDUCE A PORTION OF THIS LOAD AS A SOURCE CONTROL. SWEEPING WILL ALSO HELP TO KEEP THE PARKING LOT FREE OF LITTER THAT CAN BE UNSIGHTLY AND MAY CLOG STORMWATER CONVEYANCE SYSTEMS. SWEEPING WILL OCCUR AT LEAST SEMIANNUALLY (ONCE IN THE SPRING AND ONCE IN THE FALL), OR MORE FREQUENTLY IF ACCUMULATED PARTICULATE MATTER IS OBSERVED.

CATCH BASIN SUMP WILL BE INSPECTED SEMIANNUALLY AND CLEANED WHEN HALF FULL OF SILT AND/OR DEBRIS.

FOR PARKING AREA, DRIVEWAY, AND PEDESTRIAN WALKWAY DE-ICING, A NON-SODIUM DE-ICING COMPOUND WILL BE USED. TYPICALLY, CALCIUM CHLORIDE IS THE PREFERRED ALTERNATIVE THAT IS BENIGN ENVIRONMENTALLY. THE NON-SODIUM SPECIFICATION ALLOWS THAT OTHER NON-HARMFUL SALTS OR DE-ICING AGENTS MAY BE USED.

THE GRASS SWALES AND DETENTION BASIN WILL BE INSPECTED AT LEAST SEMIANNUALLY AND CLEANED OF SEDIMENT/DEBRIS AS NECESSARY.

STORMWATER COLLECTION AND TREATMENT SYSTEM INSPECTION AND MAINTENANCE GUIDELINES:

(NOT A G.C. REQUIREMENT)
THE FOLLOWING GUIDELINES SHALL BE THE RESPONSIBILITY OF THE LEASE HOLDER BEGINNING THE FIRST YEAR PERIOD FOLLOWING CONSTRUCTION COMPLETION, AND SHALL BE FOLLOWED EVERY YEAR THEREAFTER.

STREET SWEEPING: ACCESS DRIVE AND PARKING AREA SWEEPING WILL BE COMPLETED AT LEAST TWICE A YEAR, ONCE IN THE FALL (OCT. TO NOV.) AND ONCE IN THE SPRING (MARCH TO APRIL).

CATCH BASINS: CATCH BASINS SHALL BE INSPECTED ON A SEMIANNUALLY BASIS AND CLEANED AT LEAST TWICE A YEAR, ONCE IN THE FALL AND ONCE IN THE SPRING, IMMEDIATELY AFTER THE STREET SWEEPING. SEDIMENT REMOVAL SHALL BE ACCOMPLISHED BY MEANS OF VACUUM PUMPING AND NOT BY MEANS OF A CLAMSHELL BUCKET. ALL CATCH BASINS SHALL BE CLEANED BY THE CONTRACTOR PRIOR TO COMPLETION OF WORK.

STOCKPILE CONTAINMENT/STABILIZATION NOTES

1. CONTRACTOR SHALL BE RESPONSIBLE FOR PROVIDING HAYBALES ON DOWN GRADIENT SIDE OF TEMPORARY LOAM STOCKPILE AREAS.

2. TEMPORARY LOAM STOCKPILES SHALL MAINTAIN A MAXIMUM 3:1 SLOPE TO PREVENT SOIL EROSION AND SEDIMENT MIGRATION.

3. CONTRACTOR SHALL BE RESPONSIBLE FOR PROVIDING APPROPRIATE LOAM/MATERIAL STOCKPILE CONTAINMENT AND STABILIZATION THROUGHOUT THE CONSTRUCTION SITE.

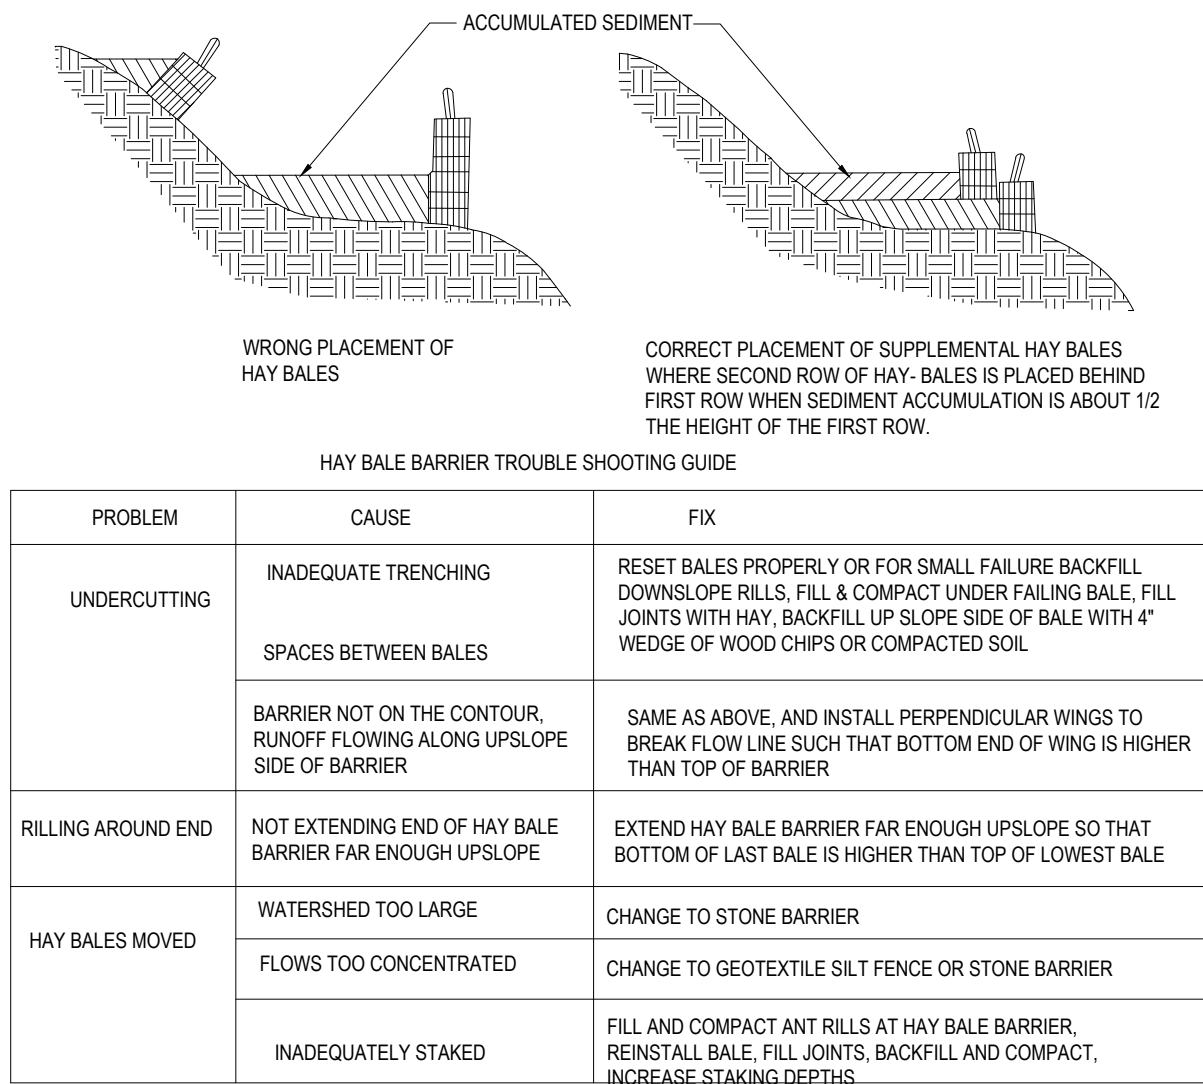


FIGURE HB-4 ADDING BACKUP HAYBALE BARRIER

TREE PROTECTION DURING CONSTRUCTION

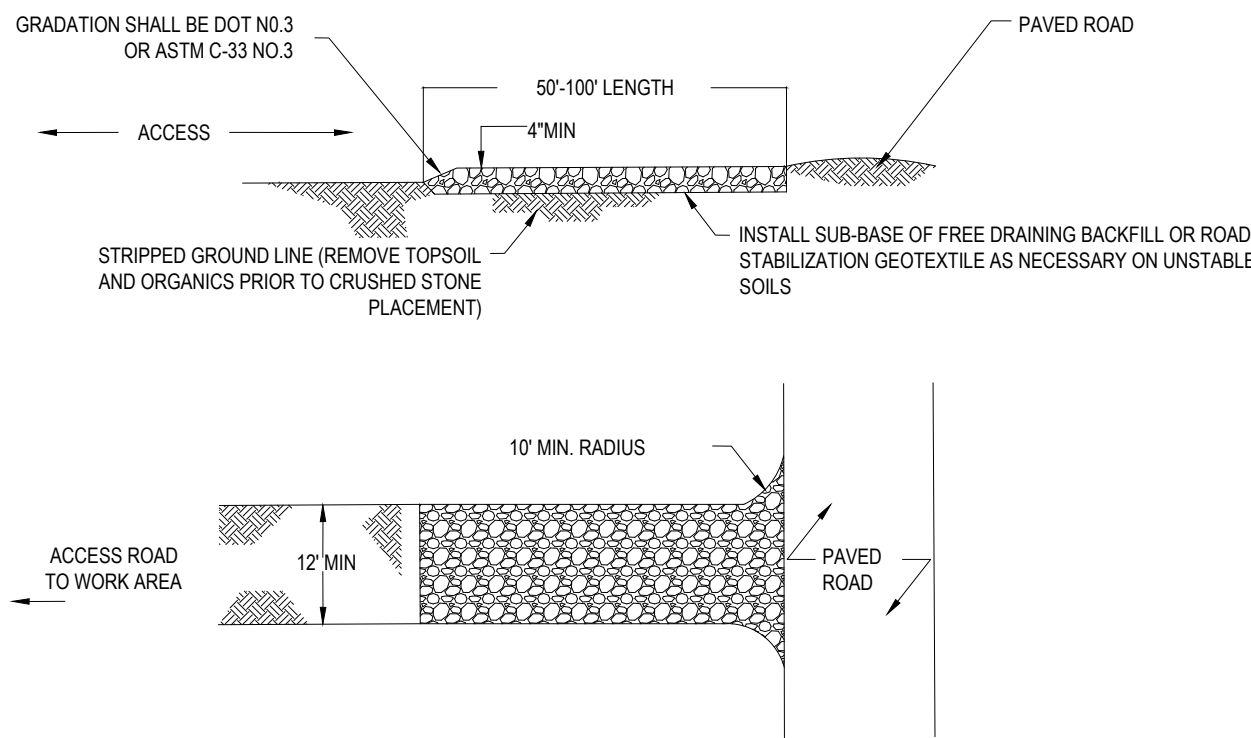


FIGURE CE-2 DIAGRAM OF TYPICAL CONSTRUCTION EXIT


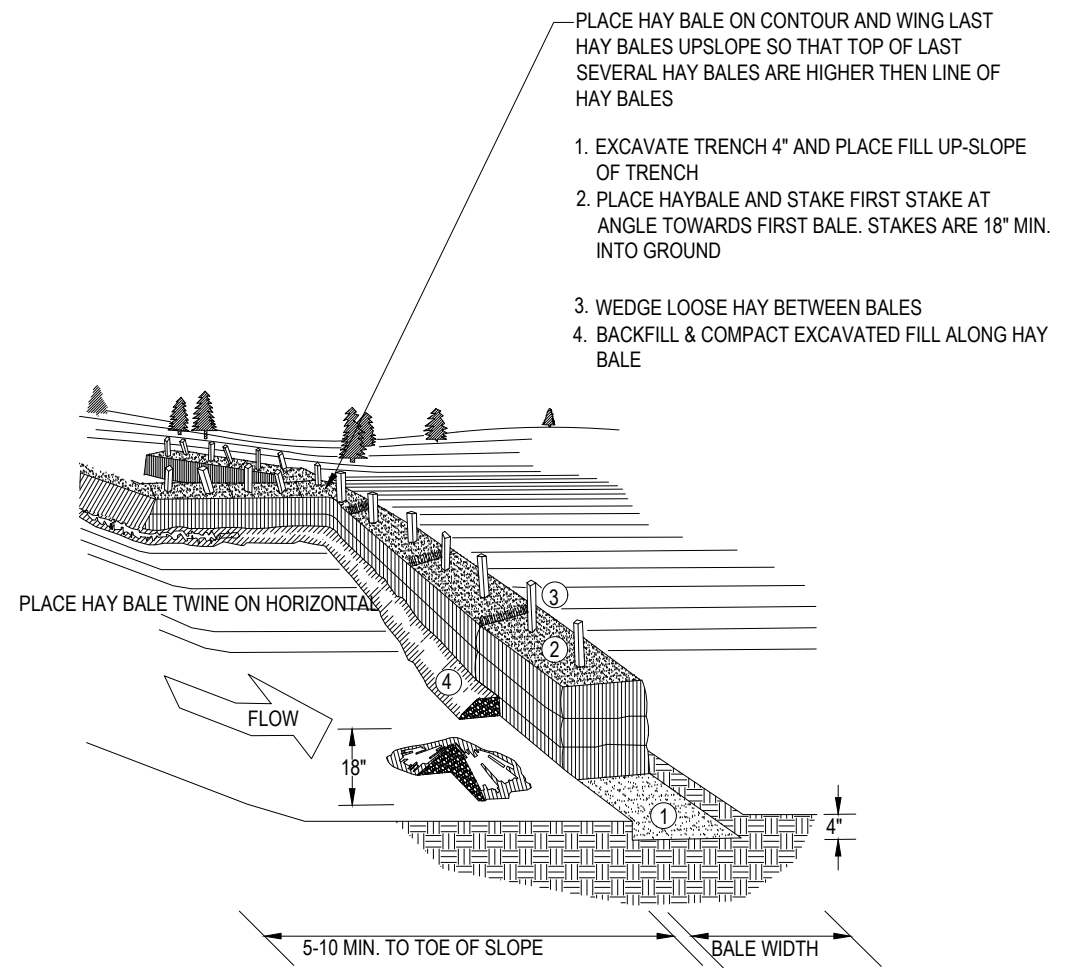


FIGURE HB-2 PLACEMENT AND CONSTRUCTION OF HAYBALE BARRIER

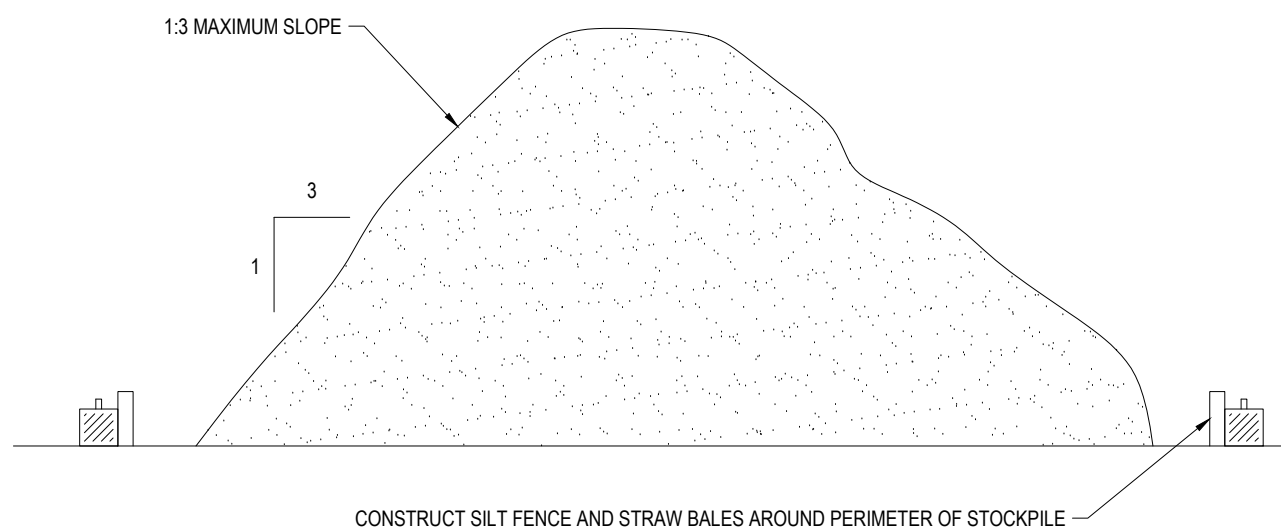

TEMPORARY STOCKPILE DETAIL

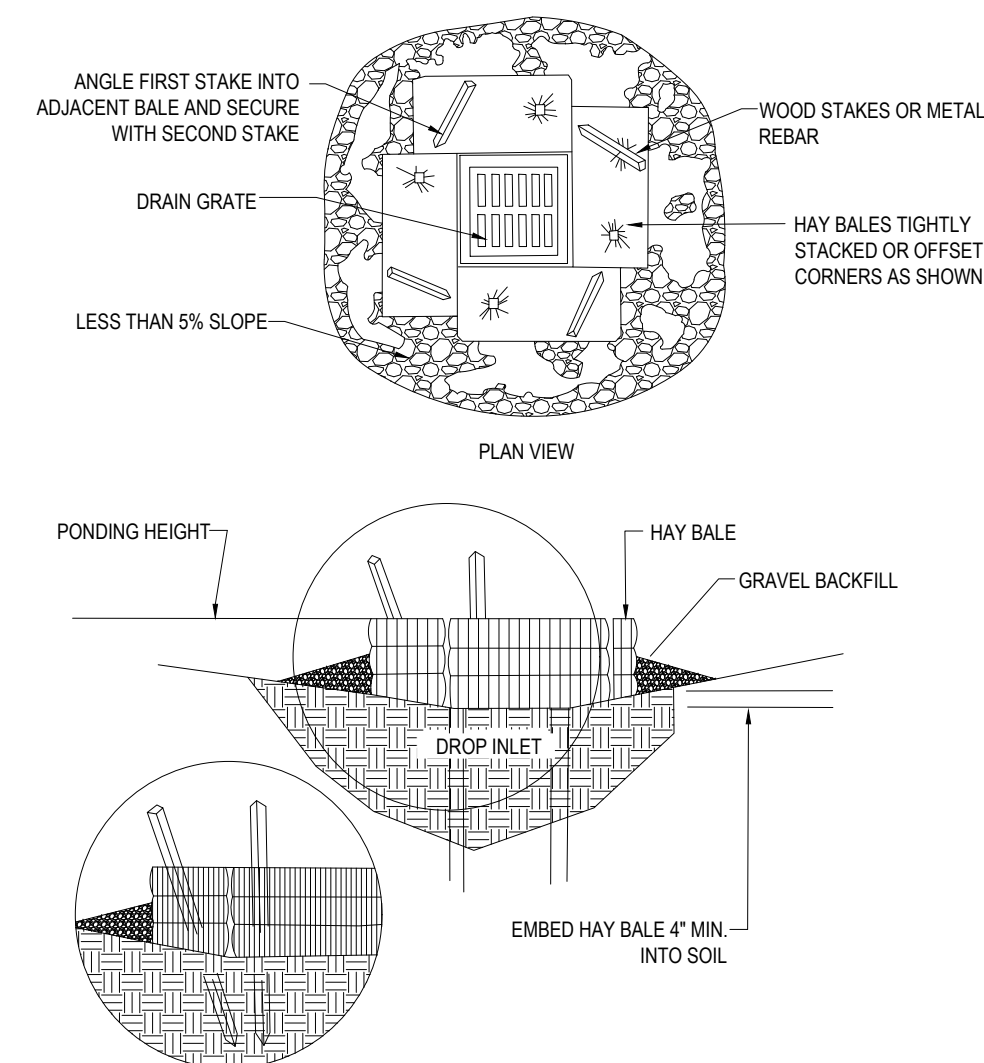


FIGURE HB-3 HAYBALE BARRIER AT CATCH BASIN IN HOLLOW

BOHLER ENGINEERING

SITE CIVIL AND CONSULTING ENGINEERING
LAND SURVEYING AND ARCHITECTURE
SUSTAINABLE DESIGN PERMITTING SERVICES TRANSPORTATION SERVICES

NEW YORK • NEW JERSEY • BALTIMORE, MD • CHARLOTTE, NC
PHILADELPHIA, PA • SOUTHERN MARYLAND • ATLANTA, GA
NEW ENGLAND • CENTRAL VIRGINIA • SOUTH FLORIDA
NEW YORK METRO • SOUTHEASTERN, PA • RALEIGH, NC
THE EXPANSION OF OUR SERVICE AREA HAS ALLOWED US TO SERVE OUR CLIENTS WITH THE BEST OF OUR TEAM. WE ARE CURRENTLY ACCEPTING NEW CLIENTS FOR CONSTRUCTION PROJECTS.

REVISIONS			
REV	DATE	COMMENT	BY
1			
2			
3			
4			
5			
6			
7			
8			
9			
10			
11			
12			
13			
14			
15			

PRELIMINARY

PROJECT No.: W161042
DRAWN BY: WSJF
CHECKED BY: JF/AD
DATE: 09/07/18
SCALE: AS NOTED
CAD I.D.: W161042SS0

PROJECT: **SITE DEVELOPMENT PLANS FOR CONNECTICUT HEALTH CARE HOLDINGS LLC**

NEW HAVEN, CT
MAP #339, BLOCK #190, LOT #17
240 WINTHROP AVENUE
CITY OF NEW HAVEN
NEW HAVEN COUNTY, CONNECTICUT

BOHLER ENGINEERING

352 TURNPIKE ROAD
SOUTHBOROUGH, MA 01772
Phone: (508) 480-9900
Fax: (508) 480-9080
www.BohlerEngineering.com

J.G. SWERLING

PROFESSIONAL ENGINEER
MASSACHUSETTS LICENSE No. 41697
NEW HAMPSHIRE LICENSE No. 14695
MAINE LICENSE No. 13818
CONNECTICUT LICENSE No. 30786
RHODE ISLAND LICENSE No. 1425

SHEET TITLE:
SOIL EROSION CONTROL NOTES & DETAILS SHEET



SHEET NUMBER:
8

OF 14

REV 0 - 09/07/2018



Know what's below.
Call before you dig.

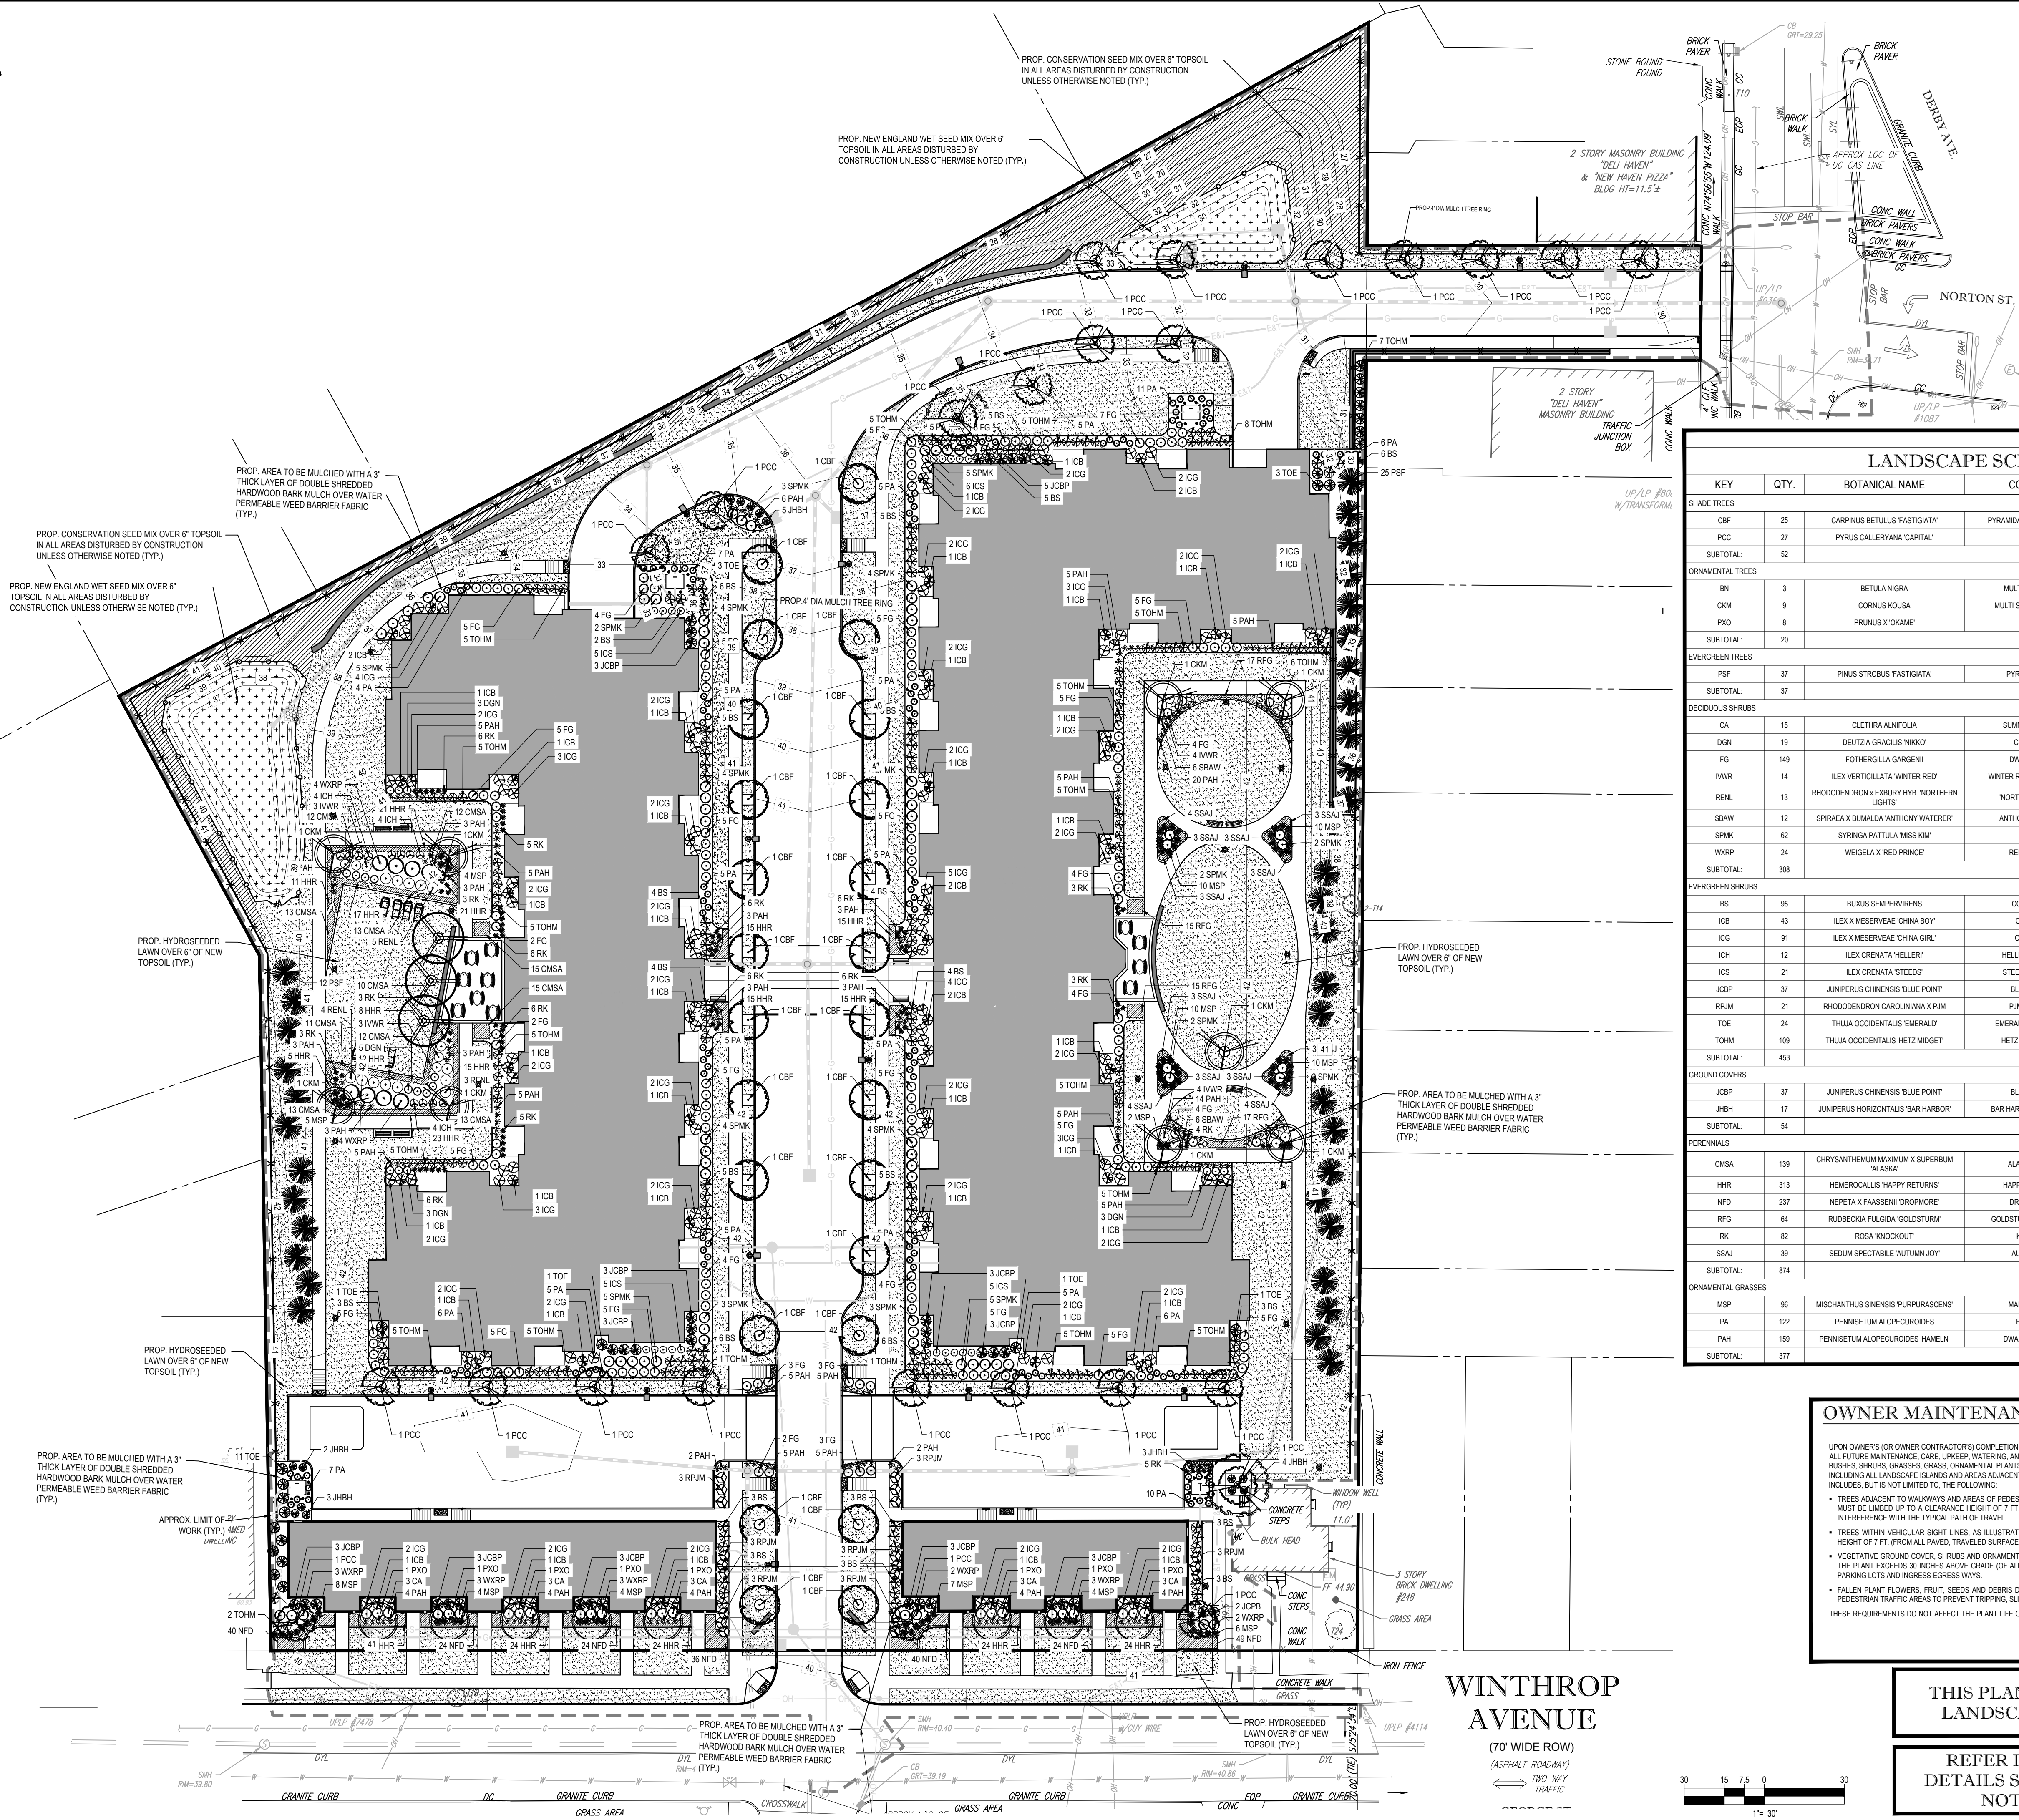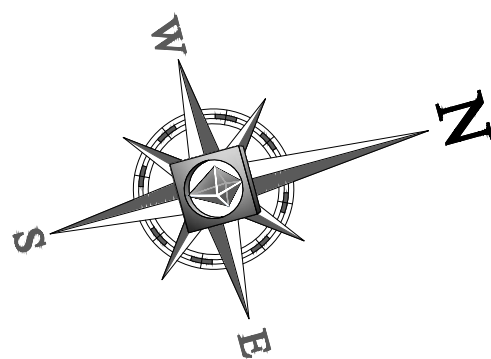

LANDSCAPE SCHEDULE					
KEY	QTY.	BOTANICAL NAME	COMMON NAME	SIZE	CONT.
SHADE TREES					
CBF	25	CARPINUS BETULUS 'FASTIGIATA'	PYRAMIDAL EUROPEAN HORNBEECH	2'-2 1/2' CAL.	B-B
PCC	27	PYRUS CALLERYANA 'CAPITAL'	CAPITAL PEAR	2'-2 1/2' CAL.	B-B
SUBTOTAL:					
ORNAMENTAL TREES					
BN	3	BETULA NIGRA	MULTI STEM RIVER BIRCH	12-14'	B-B
CKM	9	CORNUS KOUSA	MULTI STEM KOUSA DOGWOOD	8-10'	B-B
PXD	8	PRUNUS X 'OKAME'	OKAME CHERRY	2'-2 1/2' CAL.	B-B
SUBTOTAL:					
EVERGREEN TREES					
PSF	37	PINUS STROBUS 'FASTIGIATA'	PYRAMIDAL WHITE PINE	8-10'	B-B
SUBTOTAL:					
DECIDUOUS SHRUBS					
CA	15	CLETHRA ALNIFOLIA	SUMMERSWEET CLETHRA	24-30"	#3 CAN
DGN	19	DEUTZIA GRACILIS 'NINKO'	COMPACT DEUTZIA	18-24"	#2 CAN
FG	149	FOTHERGILLA GARGENII	DWARF FOTHERGILLA	18-24"	#3 CAN
IVWR	14	ILEX VERTICILLATA 'WINTER RED'	WINTER RED WINTERBERRY HOLLY	30-36"	#5 CAN
RENL	13	RHOODOENDRON X EXBURY HYB. 'NORTHERN LIGHTS'	NORTHERN LIGHTS' AZALEA	30-36"	#5 CAN
SBWA	12	SPIRAEA X BUMALDA 'ANTHONY WATERER'	ANTHONY WATERER SPIREA	18-24"	#3 CAN
SPMK	62	SYRINGA PATULUA 'MISS KIM'	MISS KIM LILAC	24-30"	B-B
WXP	24	WEIGELA X 'RED PRINCE'	RED PRINCE WEIGELA	3-4'	B-B
SUBTOTAL:					
EVERGREEN SHRUBS					
BS	95	BUXUS SEMPERVIRENS	COMMON BOXWOOD	30-36"	B-B
ICB	43	ILEX X MESERVEAE 'CHINA BOY'	CHINA BOY HOLLY	30-36"	#5 CAN
ICG	91	ILEX X MESERVEAE 'CHINA GIRL'	CHINA GIRL HOLLY	30-36"	B-B
ICH	12	ILEX CRENATA 'HELLER'	HELLER/JAPANESE HOLLY	15-18"	#3 CAN
ICS	31	ILEX CRENATA 'STEEDS'	STEEDS JAPANESE HOLLY	30-36"	#3 CAN
JCBP	27	JUNIPERUS CHINENSIS 'BLUE POINT'	BLUE POINT JUNIPER	4-5'	B-B
RPJM	21	RHOODOENDRON CAROLINIANA X P.J.M.	P.J.M. RHOODOENDRON	24-30"	B-B
TOE	24	THUJA OCCIDENTALIS 'EMERALD'	EMERALD GREEN ARBORVITAE	5-6'	B-B
TOHM	109	THUJA OCCIDENTALIS 'HETZ MIDGET'	HETZ MIDGET ARBORVITAE	18-24"	#3 CAN
SUBTOTAL:					
GROUND COVERS					
JCBP	37	JUNIPERUS CHINENSIS 'BLUE POINT'	BLUE POINT JUNIPER	4-5'	B-B
JHNB	17	JUNIPERUS HORIZONTALIS 'BAR HARBOR'	BAR HARBOR CREEPING JUNIPER	15-18' SPRD.	#3 CAN
SUBTOTAL:					
PERENNIALS					
CMSA	139	CHRYSANTHEMUM MAXIMUM X SUPERBUM 'ALASKA'	ALASKA SHASTA DAISY	2 GAL.	CONTAINER
HHR	313	HEMEROCALLIS 'HAPPY RETURNS'	HAPPY RETURNS DAYLILY	2 GAL.	CONTAINER
NFD	237	NEPETA X FAASSENII 'DROPMORE'	DROPMORE CAT MINT	2 GAL.	CONTAINER
RFG	64	RUDEBECKIA FULGIDA 'GOLDSTURM'	GOLDSTURMBLACK-EYED SUSAN	2 GAL.	CONTAINER
RK	82	ROSA 'KNOCKOUT'	KNOCKOUT ROSE	2 GAL.	CONTAINER
SSAJ	39	SEDUM SPECTABILE 'AUTUMN JOY'	AUTUMN JOY SEDUM	2 GAL.	CONTAINER
SUBTOTAL:					
ORNAMENTAL GRASSES					
MSP	96	MISCHANTHUS SINENSIS 'PURPURASCENS'	MAIDEN FLAME GRASS	2 GAL.	CONTAINER
PA	122	PENNISETUM ALOPECUROIDES	FOUNTAIN GRASS	2 GAL.	CONTAINER
PAH	159	PENNISETUM ALOPECUROIDES 'HAEMEL'	DWARF FOUNTAIN GRASS	2 GAL.	CONTAINER
SUBTOTAL:					

OWNER MAINTENANCE RESPONSIBILITIES

UPON OWNERS (OR OWNER CONTRACTORS) COMPLETION OF LANDSCAPING WORK, THE OWNER IS FULLY RESPONSIBLE FOR ALL FUTURE MAINTENANCE, CARE, UPKEEP, WATERING, AND TRIMMING OF ALL INSTALLED VEGETATION, PLANTS, TREES, SHRUBS, GRASSES, PERENNIALS, ORNAMENTAL PLANTS AND FLOWERS, FLOWERS, GROUND COVER, AND LANDSCAPING, INCLUDING ALL LANDSCAPE ISLANDS AND AREAS ADJACENT OR PART OF THE LANDSCAPED AREAS. THIS RESPONSIBILITY INCLUDES, BUT IS NOT LIMITED TO, THE FOLLOWING:

- TREES ADJACENT TO DRIVEWAYS AND AREAS OF PEDESTRIAN TRAFFIC MUST BE MAINTAINED TO ASSURE THAT ANY BRANCHES MUST BE TRIMMED UP TO A CLEARANCE HEIGHT OF 7 FT. (FROM ALL PEDESTRIAN SURFACES OR PRUNED BACK TO AVOID ANY INTERFERENCE WITH THE TYPICAL PATH OF TRAVEL).
- TREES WITHIN VEHICULAR SIGHT LINES, AS ILLUSTRATED ON THE LANDSCAPE PLAN, ARE TO BE TRIMMED TO A CLEARANCE HEIGHT OF 7 FT. (FROM ALL PAVED, TRAVELED SURFACES), OR AS OTHERWISE INDICATED ON THE PLANS.
- VEGETATIVE GROUND COVER, SHRUBS AND ORNAMENTAL PLANTS AND GRASSES MUST BE TRIMMED SO THAT NO PORTION OF THE PLANT EXCEEDS 30 INCHES ABOVE GRADE (OF ALL PAVED, TRAVELED SURFACES) ALONG AND WITHIN THE SIGHT LINES OF PARKING LOTS AND INGRESS-EGRESS WAYS.
- FALLEN PLANT FLOWERS, FRUIT, SEEDS AND DEBRIS DROPPINGS ARE TO BE REMOVED IMMEDIATELY FROM VEHICULAR AND PEDESTRIAN TRAFFIC AREAS TO PREVENT TRIPPING, SLIPPING OR ANY OTHER HAZARDS.

 
THESE REQUIREMENTS DO NOT AFFECT THE PLANT LIFE GUARANTEE. THE LANDSCAPE CONTRACTOR IS REQUIRED TO PROVIDE.

THIS PLAN TO BE UTILIZED FOR LANDSCAPE PURPOSES ONLY

REFER LANDSCAPE NOTES & DETAILS SHEET FOR LANDSCAPE NOTES AND DETAILS

WINTHROP AVENUE

(70' WIDE ROW)
(ASPHALT ROADWAY)
TWO WAY TRAFFIC



Know what's below.
Call before you dig.

BOHLER
ENGINEERING

SITE CIVIL/LANDSCAPE CONSULTING/ENGINEERING
LAND SURVEYING/DESIGN
SUSTAINABLE DESIGN

PERMITTING SERVICES
TRANSPORTATION SERVICES

- CHARLOTTE, NC
- BALTIMORE, MD
- BIRMINGHAM, AL
- CHICAGO, IL
- CINCINNATI, OH
- COLUMBIA, SC
- DALLAS, TX
- DENVER, CO
- FORT MYERS, FL
- HOUSTON, TX
- KANSAS CITY, MO
- LOS ANGELES, CA
- MEMPHIS, TN
- MIAMI, FL
- MINNEAPOLIS, MN
- NEW ORLEANS, LA
- NEW YORK, NY
- OKLAHOMA CITY, OK
- PHOENIX, AZ
- RICHMOND, VA
- SAN ANTONIO, TX
- SEATTLE, WA
- TAMPA, FL
- WASHINGTON, DC
- WICHITA, KS

REVISIONS			
REV	DATE	COMMENT	BY
1			
2			
3			
4			
5			
6			
7			
8			
9			
10			
11			
12			
13			
14			
15			

PRELIMINARY

PROJECT No.: W161042

DRAWN BY: WJ/AD

CHECKED BY: JF/AD

DATE: 09/07/18

SCALE: AS NOTED

CAD I.D.: W161042SS0

PROJECT: SITE DEVELOPMENT PLANS FOR CONNECTICUT HEALTH CARE HOLDINGS LLC

NEW HAVEN, CT

MAP #339, BLOCK #190, LOT #17

240 WINTHROP AVENUE

CITY OF NEW HAVEN

NEW HAVEN COUNTY, CONNECTICUT

BOHLER ENGINEERING

352 TURNPIKE ROAD

SOUTHBOROUGH, MA 01772

Phone: (508) 480-9900

Fax: (508) 480-9080

www.BohlerEngineering.com

M.J. MRVA

REGISTERED LANDSCAPE ARCHITECT

MASSACHUSETTS No. 1217

RHODE ISLAND No. 419

NEW YORK No. 002359

NEW HAMPSHIRE No. 108

CONNECTICUT No. 1359

SHEET TITLE: LANDSCAPE PLAN

SHEET NUMBER: 9

OF 14

REV 0 - 09/07/2018

SCOPE OF WORK:
THE LANDSCAPE CONTRACTOR SHALL BE REQUIRED TO PERFORM ALL CLEARING, FINISHED GRADING, SOIL PREPARATION, PERMANENT SEEDING OR SODDING, MULCHING AND PLANTING INCLUDING ALL LABOR, MATERIALS, TOOLS AND EQUIPMENT NECESSARY FOR THE COMPLETION OF THIS PROJECT, UNLESS OTHERWISE CONTRACTED BY THE GENERAL CONTRACTOR.

2. MATERIALS
A. GENERAL: ALL HARDSCAPE MATERIALS SHALL MEET OR EXCEED SPECIFICATIONS AS OUTLINED IN THE STATE DEPARTMENT OF TRANSPORTATION'S SPECIFICATIONS.
B. TOPSOIL - NATURAL, FRABLE, LOAMY SILT SOIL HAVING AN ORGANIC CONTENT NOT LESS THAN 5%, A PH RANGE BETWEEN 4.5-7.0. IT SHALL BE FREE OF DEBRIS, ROCKS LARGER THAN ONE INCH (1"), WOOD, ROOTS, VEGETABLE MATTER AND CLAY CLODS.
C. LAWN - ALL DISTURBED AREAS ARE TO BE TREATED WITH A MINIMUM 6" THICK LAYER OF TOPSOIL, OR AS DIRECTED BY THE LOCAL ORDINANCE OR CLIENT, AND SEED OR SODD IN ACCORDANCE WITH THE PERMANENT STABILIZATION METHODS INDICATED ON THE LANDSCAPE PLAN
1. LAWN SEED MIXTURE SHALL BE FRESH, CLEAN NEW CROP SEED
2. SOD SHALL BE STRONGLY ROOTED, WEED AND DISEASE/FEST FREE WITH A UNIFORM THICKNESS. SOD INSTALLED ON SLOPES GREATER THAN 4:1 SHALL BE PEGGED TO HOLD SOIL IN PLACE.
D. MULCH - ALL PLANTING BEDS SHALL BE MULCHED WITH A 3" THICK LAYER OF DOUBLE SHREDDED HARDWOOD BARK MULCH, UNLESS OTHERWISE STATED ON THE LANDSCAPE PLAN AND/OR LANDSCAPE PLAN NOTES/DETAILS.

E. FERTILIZER
FERTILIZER SHALL BE DELIVERED TO THE SITE MIXED AS SPECIFIED IN THE ORIGINAL, UNOPENED STANDARD BAGS SHOWING WEIGHT, ANALYSIS AND NAME OF MANUFACTURER.
FERTILIZER SHALL BE STORED IN A WEATHERPROOF PLACE SO THAT IT CAN BE KEPT DRY PRIOR TO USE.
IF FOR THE PURPOSE OF BIDDING, ASSUME THAT FERTILIZER SHALL BE 10% NITROGEN, 6% PHOSPHORUS AND 4% POTASSIUM BY WEIGHT. A FERTILIZER SHOULD NOT BE SELECTED WITHOUT A SOIL TEST PERFORMED BY A CERTIFIED SOIL LABORATORY.

F. PLANT MATERIAL
1. ALL PLANTS SHALL IN ALL CASES CONFORM TO THE REQUIREMENTS OF THE "AMERICAN STANDARD FOR NURSERY STOCK" (ANSI Z60.1), LATEST EDITION, AS PUBLISHED BY THE AMERICAN NURSERY & LANDSCAPE ASSOCIATION (FORMERLY THE AMERICAN ASSOCIATION OF NURSERYMEN).
2. ALL PLANT MATERIAL NAMES SHALL TAKE PRECEDENCE OVER COMMON NAMES FOR ANY AND ALL PLANT MATERIAL.
3. ALL PLANTS SHALL BE LEGIBLY TAGGED WITH THE PROPER NAME AND SIZE. TAGS ARE TO REMAIN ON AT LEAST ONE PLANT OF EACH SPECIES FOR VERIFICATION PURPOSES DURING THE FINAL INSPECTION.
4. TREES WITH ABRASION OF THE BARK, SUN SCALDS, DISFIGURATION OR FRESH CUTS OF LIMBS OVER 1 1/2", WHICH HAVE NOT BEEN COMPLETELY CALLED, SHALL BE REJECTED.
5. PLANTS SHALL NOT BE FOUND WITH WIRE OR ROPE AT ANY TIME SO AS TO DAMAGE THE BARK OR GROWTH.
6. PLANTS SHALL BE PLACED AROUND THE PERIMETER OF THE ROOTS. EXISTING TREES SHALL BE MONITORED ON A REGULAR BASIS FOR ADDITIONAL ROOT OR BRANCH DAMAGE AS A RESULT OF CONSTRUCTION. ROOTS SHALL NOT BE LEFT EXPOSED FOR MORE THAN ONE (1) DAY. CONTRACTOR SHALL WATER EXISTING TREES AS NEEDED TO PREVENT SHOCK OR DECLINE.
7. SYSTEMS AND BE FREE OF DISEASE, INSECTS, PESTS, EGGS OR LARVAE.
8. VI. CALIPER MEASUREMENTS OF NURSERY GROWN TREES SHALL BE TAKEN AT A POINT ON THE TRUNK SIX INCHES (6") ABOVE THE NATURAL GRADE FOR TREES UP TO AND INCLUDING A FOUR INCH (4") CALIPER SIZE. IF THE CALIPER AT SIX INCHES (6") ABOVE THE GROUND EXCEEDS FOUR INCHES (4") IN CALIPER, THE CALIPER SHOULD BE MEASURED AT A POINT 12" ABOVE THE NATURAL GRADE.
9. VII. SHRUBS SHALL BE MEASURED TO THE AVERAGE HEIGHT OR SPREAD OF THE SHRUB, AND NOT TO THE LONGEST BRANCH.
10. VIII. TREES AND SHRUBS SHALL BE HANDLED WITH CARE BY THE ROOT BALL.

3. GENERAL WORK PROCEDURES
A. CONTRACTOR TO UTILIZE WORKMANS LIKE INDUSTRY STANDARDS IN PERFORMING ALL LANDSCAPE CONSTRUCTION. THE SITE IS TO BE LEFT IN A CLEAN STATE AT THE END OF EACH WORKDAY. ALL DEBRIS, MATERIALS AND TOOLS SHALL BE PROPERLY STORED, STOCKPILED OR DISPOSED OF.
B. WASTE MATERIALS AND DEBRIS SHALL BE COMPLETELY DISPOSED OF AT THE CONTRACTOR'S EXPENSE. DEBRIS SHALL NOT BE BURIED, INCLUDING ORGANIC MATERIALS, BUT SHALL BE REMOVED COMPLETELY FROM THE SITE.
C. SITE PREPARATIONS
A. BEFORE AND DURING PRELIMINARY GRADING AND FINISHED GRADING, ALL WEEDS AND GRASSES SHALL BE DUG OUT BY THE ROOTS AND DISPOSED OF IN ACCORDANCE WITH GENERAL WORK PROCEDURES OUTLINED HEREIN.
B. ALL EXISTING TREES TO REMAIN SHALL BE PRUNED TO REMOVE ANY DAMAGED BRANCHES. THE ENTIRE LIMB OF ANY DAMAGED BRANCH SHALL BE CUT OFF AT THE BRANCH COLLAR. CONTRACTOR SHALL ENSURE THAT CUTS ARE SMOOTH AND STRAIGHT. ANY EXPOSED ROOTS SHALL BE CUT BACK WITH CLEAN, SHARP TOOLS AND SHALL BE PLACED AROUND THE PERIMETER OF THE ROOTS. EXISTING TREES SHALL BE MONITORED ON A REGULAR BASIS FOR ADDITIONAL ROOT OR BRANCH DAMAGE AS A RESULT OF CONSTRUCTION. ROOTS SHALL NOT BE LEFT EXPOSED FOR MORE THAN ONE (1) DAY. CONTRACTOR SHALL WATER EXISTING TREES AS NEEDED TO PREVENT SHOCK OR DECLINE.
C. CONTRACTOR SHALL ARRANGE TO HAVE A UTILITY STAKE-OUT TO LOCATE ALL UNDERGROUND UTILITIES PRIOR TO INSTALLATION OF ANY LANDSCAPE MATERIAL. UTILITY COMPANIES SHALL BE CONTACTED THREE (3) DAYS PRIOR TO THE BEGINNING OF WORK.
D. TREE PROTECTION
A. CONTRACTOR SHALL BE RESPONSIBLE FOR THE PROTECTION OF ALL EXISTING TREES TO REMAIN. A TREE PROTECTION ZONE SHALL BE ESTABLISHED AT THE DRIP LINE OR AT THE LIMIT OF CONSTRUCTION DISTURBANCE, WHICHEVER IS GREATER. LOCAL STANDARDS THAT MAY REQUIRE A MORE STRICT TREE PROTECTION ZONE SHALL BE HONORED.
B. A FORTY-EIGHT INCH (48") HIGH WOODEN SNOW FENCE OR ORANGE COLORED HIGH-DENSITY VISI-FENCE, OR APPROVED EQUAL, MOUNTED ON STEEL POSTS SHALL BE PLACED ALONG THE BOUNDARY OF THE TREE PROTECTION ZONE. POSTS SHALL BE LOCATED AT A MAXIMUM OF EIGHT FEET (8') ON CENTER OR AS INDICATED WITHIN THE TREE PROTECTION ZONE.
C. WHEN THE TREE PROTECTION FENCING HAS BEEN INSTALLED, IT SHALL BE INSPECTED BY THE APPROVING AGENCY PRIOR TO DEMOLITION, GRADING, TREE CLEARING OR CONSTRUCTION. THE FENCING ALONG THE TREE PROTECTION ZONE SHALL BE REGULARLY INSPECTED BY THE LANDSCAPE CONTRACTOR AND MAINTAINED UNTIL ALL CONSTRUCTION ACTIVITY HAS BEEN COMPLETED.
D. AT NO TIME SHALL MACHINERY, DEBRIS, FALLEN TREES OR OTHER MATERIALS BE PLACED, STOCKPILED OR LEFT STANDING IN THE TREE PROTECTION ZONE.

6. SOIL MODIFICATIONS
A. CONTRACTOR SHALL ATTAIN A SOIL TEST FOR ALL AREAS OF THE SITE PRIOR TO CONDUCTING ANY PLANTING. SOIL TESTS SHALL BE PERFORMED BY A CERTIFIED SOIL LABORATORY.
B. LANDSCAPE CONTRACTOR SHALL REPORT ANY SOIL OR DRAINAGE CONDITIONS CONSIDERED DETRIMENTAL TO THE GROWTH OF PLANT MATERIAL. SOIL MODIFICATIONS, AS SPECIFIED HEREIN, MAY NEED TO BE APPROVED BY THE LANDSCAPE CONTRACTOR DEPENDING ON SITE CONDITIONS.
C. THE FOLLOWING AMENDMENTS AND QUANTITIES ARE ANTICIPATED AND ARE FOR BIDDING PURPOSES ONLY. COMPOSITION OF AMENDMENTS SHOULD BE REVISED DEPENDING ON THE OUTCOME OF A TOPSOIL ANALYSIS PERFORMED BY A CERTIFIED SOIL LABORATORY.
1. TO INCREASE A SANDY SOIL'S ABILITY TO RETAIN WATER AND NUTRIENTS, THOROUGHLY TILL ORGANIC MATTER INTO THE TOP 6-12" USE COMPOSTED BARK COMPOSTED LEAF MULCH
OR PEAT MOSS. ALL PRODUCTS SHOULD BE COMPOSTED TO A DARK COLOR AND BE FREE OF PIECES WITH IDENTIFIABLE LEAF OR WOOD STRUCTURE. AVOID MATERIAL WITH A PH HIGHER THAN 7.5.
2. TO INCREASE DRAINAGE, MODIFY HEAVY CLAY OR SILT (MORE THAN 40% CLAY OR SILT) BY ADDING COMPOSTED PINE BARK (UP TO 30% BY VOLUME) AND/OR AGRICULTURAL GYPSSUM.
3. CORSE SAND MAY BE USED IF ENOUGH IS ADDED TO BRING THE SAND CONTENT TO MORE THAN 60% OF THE TOTAL MIX. SUBSURFACE DRAINAGE LINES MAY NEED TO BE ADDED TO INCREASE DRAINAGE.
3.1. MODIFY EXISTING SANDY SOILS (MORE THAN 85%) BY ADDING ORGANIC MATTER AND/OR DRY, SHREDDED CLAY LOAM UP TO 30% OF THE TOTAL MIX.

7. FINISHED GRADING
A. UNLESS OTHERWISE CONTRACTED, THE LANDSCAPE CONTRACTOR SHALL BE RESPONSIBLE FOR THE INSTALLATION OF TOPSOIL AND THE ESTABLISHMENT OF FINE GRADING WITHIN THE DISTURBANCE AREA OF THE SITE.
B. LANDSCAPE CONTRACTOR SHALL VERIFY THAT SUBGRADE FOR INSTALLATION OF TOPSOIL HAS BEEN ESTABLISHED. THE SUBGRADE OF THE SITE MUST MEET THE FINISHED GRADE LESS THE REQUIRED TOPSOIL THICKNESS (*1").
C. ALL LAWN AND PLANTING AREAS SHALL BE GRADED TO A SMOOTH, EVEN AND UNIFORM PLANE WITH NO ABRUPT CHANGE OF SURFACE AS DEPICTED WITHIN THIS SET OF CONSTRUCTION PLANS, UNLESS OTHERWISE DIRECTED BY THE PROJECT ENGINEER OR LANDSCAPE ARCHITECT.
D. ALL PLANTING AREAS SHALL BE GRADED AND MAINTAINED TO ALLOW FREE FLOW OF SURFACE WATER IN AND AROUND THE PLANTING BEDS. STANDING WATER SHALL NOT BE PERMITTED IN PLANTING BEDS.

8. TOPSOILING
A. CONTRACTOR SHALL PROVIDE A 6" THICK MINIMUM LAYER OF TOPSOIL, OR AS DIRECTED BY THE LOCAL ORDINANCE OR CLIENT, IN ALL PLANTING AREAS. TOPSOIL SHOULD BE SOAD OVER A PREPARED SURFACE IN A UNIFORM LAYER TO ACHIEVE THE DESIRED COMPACTED THICKNESS.
B. ON-SITE TOPSOIL MAY BE USED TO SUPPLEMENT THE TOTAL AMOUNT REQUIRED. TOPSOIL FROM THE SITE MAY BE REJECTED IF IT HAS NOT BEEN PROPERLY REMOVED, STORED AND PROTECTED PRIOR TO CONSTRUCTION.
C. CONTRACTOR SHALL FURNISH TO THE APPROVING AGENCY AN ANALYSIS OF BOTH IMPORTED AND ON-SITE TOPSOIL TO BE UTILIZED IN ALL PLANTING AREAS. THE PH AND NUTRIENT ANALYSIS MAY NEED TO BE ADJUSTED THROUGH SOIL MODIFICATIONS AS NEEDED TO ACHIEVE THE REQUIRED LEVELS AS SPECIFIED IN THE MATERIALS SECTION ABOVE.

ALL LAWN AREAS ARE TO BE CULTIVATED TO A DEPTH OF SIX INCHES (6"). ALL DEBRIS EXCEPT FROM EXCAVATION AND CULTIVATION SHALL BE DISPOSED OF IN ACCORDANCE WITH GENERAL WORK PROCEDURES SECTION ABOVE. THE FOLLOWING SHALL BE TILLED INTO THE TOP FOUR INCHES (4") IN TWO DIRECTIONS (QUANTITIES BASED ON 1,000 SQUARE FOOT AREA - FOR BID PURPOSES ONLY [SEE SPECIFICATION 6.A]):

- I. 20 POUNDS "GRO-POWER" OR APPROVED SOIL CONDITIONER/FERTILIZER
- II. 20 POUNDS NITRO-FORM (COURSE) 38-0-0 BLUE CHIP OR APPROVED NITROGEN FERTILIZER

E. THE SPREADING OF TOPSOIL SHALL NOT BE CONDUCTED UNDER MUDDY OR FROZEN CONDITIONS.

9. PLANTING

A. INSURE THAT IT IS FEASIBLE. PLANT MATERIAL SHALL BE PLANTED ON THE DAY OF DELIVERY. IN THE EVENT THAT THIS IS NOT POSSIBLE, LANDSCAPE CONTRACTOR SHALL PROTECT UNPLANTED PLANT MATERIAL. PLANTS SHALL NOT REMAIN UNPLANTED FOR LONGER THAN A THREE DAY PERIOD AFTER DELIVERY. PLANTS THAT WILL NOT BE PLANTED FOR A PERIOD OF TIME GREATER THAN THREE DAYS SHALL BE HEALED IN WITH TOPSOIL OR MULCH TO HELP PRESERVE ROOT MOISTURE.

B. PLANTING OPERATIONS SHALL BE PERFORMED DURING PERIODS WITHIN THE PLANTING SEASON WHEN WEATHER AND SOIL CONDITIONS ARE SUITABLE AND IN ACCORDANCE WITH ACCEPTED LOCAL PRACTICE. PLANTS SHALL NOT BE INSTALLED IN TOPSOIL THAT IS IN A MUDDY OR FROZEN CONDITION.

C. ANY INJURED ROOTS OR BRANCHES SHALL BE PRUNED TO MAKE CLEAN-CUT ENDS PRIOR TO PLANTING UTILIZING CLEAN, SHARP TOOLS. ONLY INJURED OR DISEASED BRANCHING SHALL BE REMOVED.

D. ALL PLANTING CONTAINERS, BASKETS AND NON-BIODEGRADABLE MATERIALS SHALL BE REMOVED FROM ROOT BALLS DURING PLANTING. NATURAL FIBER BURLAP MUST BE CUT FROM AROUND THE TRUNK OF THE TREE AND FOLDED DOWN AGAINST THE ROOT BALL PRIOR TO BACKFILLING.

E. POSITION TREES AND SHRUBS AT THEIR INTENDED LOCATIONS AS PER THE PLANS AND SECURE THE APPROVAL OF THE LANDSCAPE ARCHITECT PRIOR TO EXCAVATING PITS, MAKING NECESSARY ADJUSTMENTS AS DIRECTED.

F. PRIOR TO THE ISSUANCE OF ANY CERTIFICATE OF OCCUPANCY, THE PROPOSED LANDSCAPE, AS SHOWN ON THE APPROVED LANDSCAPE PLAN, MUST BE INSTALLED, INSPECTED AND APPROVED BY THE APPROVING AGENCY. THE APPROVING AGENCY SHALL TAKE INTO ACCOUNT SEASONAL CONSIDERATIONS IN THIS REGARD AS FOLLOWS:

- I. PLANTS: MARCH 15 TO DECEMBER 15
- II. LAWN: MARCH 15 TO JUNE 15 OR SEPT. 1 TO DECEMBER 1

PLANTINGS REQUIRED FOR A CERTIFICATE OF OCCUPANCY SHALL BE PROVIDED DURING THE NEXT APPROPRIATE SEASON AT THE MUNICIPALITY'S DISCRETION. CONTRACTOR SHOULD CONTACT APPROVING AGENCY FOR POTAL SUBSTITUTIONS.

G. FURTHERMORE, THE FOLLOWING TREE VARIETIES ARE USUALLY SUSCEPTIBLE TO WINTER DAMAGE, WITH TRANSPLANT SHOCK AND THE SEASONAL LACK OF NITROGEN AVAILABILITY, THE RISK OF PLANT LOSS IS GREATLY INCREASED. IT IS NOT RECOMMENDED THAT THESE SPECIES BE PLANTED DURING THE FALL PLANTING SEASON:

E. ACER RUBRUM	PLATANUS X ACERIFOLIA
BETULA VARIETIES	POPULUS VARIETIES
CARPINUS VARIETIES	PRINUS VARIETIES
CRATAEGUS VARIETIES	PYRUS VARIETIES
KOELREUTERIA	QUERCUS VARIETIES
LIQUIDAMBAR STYRACIFLUA	TILIA TOMENTOSA
LIRIODENDRON TULIPIFERA	ZELKOVA VARIETIES

H. PLANTING PITS SHALL BE DUG WITH LEVEL BOTTOMS, WITH THE FLOWING TWICE THE DIAMETER OF ROOT BALL. THE ROOT BALL SHALL REST ON UNDISTURBED GRADE. EACH PLANT PIT SHALL BE BACKFILLED IN LAYERS WITH THE FOLLOWING PREPARED SOIL, MIXED THOROUGHLY:

- I. 1 PART FINEST MOSS
- II. 1 PART COMPOSTED COW MANURE BY VOLUME
- III. 3 PARTS TOPSOIL BY VOLUME
- IV. 21 GRAMS AGRIFORM PLANTING TABLETS (OR APPROVED EQUIV.) AS FOLLOWS:
 - A) 2 TABLETS PER 1 GALLON PLANT
 - B) 3 TABLETS PER 5 GALLON PLANT
 - C) 4 TABLETS PER 15 GALLON PLANT
 - D) LARGER PLANTS: 2 TABLETS PER 1/2" CALIPER OF TRUNK

I. FILL PREPARED SOIL AROUND BALL OF PLANT HALF-WAY AND INSERT PLANT TABLETS. COMPLETE BACKFILL AND WATER THOROUGHLY.

J. ALL PLANTS SHALL BE PLANTED SO THAT THE TOP OF THE ROOT BALL, THE POINT AT WHICH THE ROOT FLARE BEGINS, IS SET AT GROUND LEVEL AND IN THE CENTER OF THE PIT. NO SOIL IS TO BE PLACED DIRECTLY ON TOP OF THE ROOT BALL.

K. ALL PROPOSED TREES DIRECTLY ADJACENT TO WALKWAYS OR DRIVEWAYS SHALL BE PRUNED AND MAINTAINED TO A MINIMUM BRANCHING HEIGHT OF 7' FROM GRADE.

L. GROUND COVER AREAS SHALL RECEIVE A 1/4" LAYER OF HUMUS RAKED INTO THE TOP 1" OF PREPARED SOIL PRIOR TO PLANTING. ALL GROUND COVER AREAS SHALL BE WEEDED AND TREATED WITH A PRE-EMERGENT CHEMICAL AS PER MANUFACTURER'S RECOMMENDATION.

M. NO PLANT, EXCEPT GROUND COVERS, GRASSES OR VINES, SHALL BE PLANTED LESS THAN TWO FEET (2') FROM EXISTING STRUCTURES AND SIDEWALKS.

N. NO PLANTING AREAS AND PLANTING PITS SHALL BE MULCHED AS SPECIFIED HEREIN TO FILL THE ENTIRE BED AREA OR SAUCER. NO MULCH IS TO TOUCH THE TRUNK OF THE TREE OR SHRUB.

O. ALL PLANTING AREAS SHALL BE WATERED IMMEDIATELY UPON INSTALLATION IN ACCORDANCE WITH THE WATERING SPECIFICATIONS AS LISTED HEREIN.

10. TRANSPLANTING (WHEN REQUIRED)

A. ALL TRANSPLANTS SHALL BE DUG WITH INTACT ROOT BALLS CAPABLE OF SUSTAINING THE PLANT.

B. IF PLANTS ARE TO BE STOCKPILED BEFORE REPLANTING, THEY SHALL BE HEALED IN WITH MULCH OR SOIL, ADEQUATELY WATERED AND PROTECTED FROM EXTREME HEAT, SUN AND WIND.

C. PLANTS SHALL NOT BE DUG FOR TRANSPLANTING BETWEEN APRIL 10 AND JUNE 30.

D. UPON REPLANTING, BACKFILL SOIL SHALL BE AMENDED WITH FERTILIZER AND ROOT GROWTH HORMONE.

E. TRANSPLANTS SHALL BE GUARANTEED FOR THE LENGTH OF THE GUARANTEE PERIOD SPECIFIED HEREIN.

F. IF TRANSPLANTS DIE, SHRUBS AND TREES LESS THAN SIX INCHES (6") DBH SHALL BE REPLACED IN KIND. TREES GREATER THAN SIX INCHES (6") DBH MAY BE REQUIRED TO BE REPLACED IN ACCORDANCE WITH THE MUNICIPALITY'S TREE REPLACEMENT GUIDELINES.

11. WATERING

A. NEW PLANTINGS OR LAWN AREAS SHALL BE ADEQUATELY IRRIGATED BEGINNING IMMEDIATELY AFTER PLANTING. WATER SHALL BE APPLIED TO EACH TREE AND SHRUB IN SUCH MANNER AS NOT TO DISTURB BACKFILL, AND TO THE EXTENT THAT ALL MATERIALS IN THE PLANTING HOLE ARE THOROUGHLY SATURATED. WATERING SHALL CONTINUE AT LEAST UNTIL PLANTS ARE ESTABLISHED.

B. SITE OWNER SHALL PROVIDE WATER IF AVAILABLE ON SITE AT TIME OF PLANTING. IF WATER IS NOT AVAILABLE ON SITE, CONTRACTOR SHALL SUPPLY ALL NECESSARY WATER. THE USE OF WATERING BAGS IS RECOMMENDED FOR ALL NEWLY PLANTED TREES.

C. IF AN IRRIGATION SYSTEM HAS BEEN INSTALLED ON THE SITE, IT SHALL BE USED TO WATER PROPOSED PLANT MATERIAL, BUT ANY FAILURE OF THE SYSTEM DOES NOT ELIMINATE THE CONTRACTOR'S RESPONSIBILITY OF MAINTAINING THE DESIRED MOISTURE LEVEL FOR VIGOROUS, HEALTHY GROWTH.

12. GUARANTEE

A. THE LANDSCAPE CONTRACTOR SHALL GUARANTEE ALL PLANTS FOR A PERIOD OF 1 YEAR FROM COMPLETION OF LANDSCAPE INSTALLATION BY THE APPROVING AGENCY. THE CONTRACTOR SHALL SUPPLY THE OWNER WITH A MAINTENANCE BOND FOR TEN PERCENT (10%) OF THE VALUE OF THE LANDSCAPE INSTALLATION WHICH WILL BE RELEASED AT THE CONCLUSION OF THE GUARANTEE PERIOD AND WHEN A FINAL INSPECTION HAS BEEN COMPLETED AND APPROVED BY THE OWNER OR AUTHORIZED REPRESENTATIVE.

B. ANY DEAD OR DYING PLANT MATERIAL SHALL BE REPLACED FOR THE LENGTH OF THE GUARANTEE PERIOD. REPLACEMENT OF PLANT MATERIAL SHALL BE CONDUCTED AT THE FIRST SUCCEEDING PLANTING SEASON. ANY DEBRIS SHALL BE DISPOSED OF OFF-SITE, WITHOUT EXCEPTION.

C. TREES AND SHRUBS SHALL BE MAINTAINED BY THE CONTRACTOR DURING CONSTRUCTION AND THROUGHOUT THE 90 DAY MAINTENANCE PERIOD AS SPECIFIED HEREIN. CULTIVATION, WEEDING, WATERING AND THE PREVENTATIVE TREATMENTS SHALL BE PERFORMED AS NECESSARY TO KEEP PLANT MATERIAL IN GOOD CONDITION AND FREE OF INSECTS AND DISEASE.

D. LAWNS SHALL BE MAINTAINED THROUGHOUT WATERING, FERTILIZING, WEEDING, MOVING, TRIMMING AND OTHER OPERATIONS SUCH AS ROLLING, REGARDING AND REPLANTING AS REQUIRED TO ESTABLISH A SMOOTH, ACCEPTABLE LAWN, FREE OF ERODED OR BARE AREAS.

13. CLEANUP

A. UPON THE COMPLETION OF ALL LANDSCAPE INSTALLATION AND BEFORE THE FINAL ACCEPTANCE, THE CONTRACTOR SHALL REMOVE ALL UNUSED MATERIALS, EQUIPMENT AND DEBRIS FROM THE SITE. ALL PAVED AREAS SHALL BE CLEANED.

B. THE SITE SHALL BE CLEANED AND LEFT IN A NEAT AND ACCEPTABLE CONDITION AS APPROVED BY THE OWNER OR AUTHORIZED REPRESENTATIVE.

14. MAINTENANCE (ALTERNATIVE BID):

A. 90 DAY MAINTENANCE PERIOD SHALL COMMENCE AT THE END OF ALL LANDSCAPE INSTALLATION OPERATIONS. THE 90 DAY MAINTENANCE PERIOD ENSURES TO THE OWNER/OPERATOR THAT THE NEWLY INSTALLED LANDSCAPING HAS BEEN MAINTAINED AS SPECIFIED ON THE APPROVED LANDSCAPE PLAN. UNTIL THE INITIAL 90 DAY MAINTENANCE PERIOD HAS EXPIRED, THE OWNER/OPERATOR MAY REQUEST THAT BIDDERS SUBMIT AN ALTERNATE MAINTENANCE BID FOR A MONTHLY MAINTENANCE CONTRACT. THE ALTERNATE MAINTENANCE CONTRACT WILL ENCOMPASS ANY WORK THAT IS CONSIDERED APPROPRIATE TO ENSURE THAT PLANT AND LAWN AREAS ARE HEALTHY AND MAINTAINED TO THE APPROVAL OF THE OWNER/OPERATOR.

NOTES:

- 1) NO SOIL OR MULCH SHALL BE PLACED AGAINST ROOT COLLAR OF PLANT.
- 2) REMOVE ALL NON-BIODEGRADABLE MATERIALS AND ROPE FROM TRUNK & TOP OF ROOT BALL. FOLD BURLAP BACK 1/3 FROM ROOT BALL.
- 3) PLANTING DEPTH SHALL BE THE SAME AS GROWN IN NURSERY.
- 4) THOROUGHLY SOAK THE TREE ROOT BALL AND ADJACENT PREPARED SOIL SEVERAL TIMES DURING THE FIRST MONTH AFTER PLANTING AND REGULARLY THROUGHOUT THE FOLLOWING TWO SUMMERS.
- 5) THE BOTTOM OF PLANTING HILL EXCAVATIONS SHOULD BE ROUGH TO AVOID MATTING OF SOIL LAYERS AS NEW SOIL IS ADDED. IT IS PREFERABLE TO TILL THE FIRST LIFT (2 TO 3 IN.) OF PLANTING SOIL INTO THE SUBSOIL.
- 6) REFER TO THE CHART "GENERAL RANGE OF SOIL MODIFICATIONS & VOLUMES FOR VARIOUS SOIL CONDITIONS" TO DETERMINE MINIMUM WIDTH OF PREPARED SOIL (X).
- 7) SUBSTITUTE ARBORVITAE STAKING SYSTEM WHEN SPECIFIED.

REINFORCED RUBBER HOSE (1/2" DIA. BLACK)

FOLD BURLAP AWAY FROM TOP OF ROOT BALL

12 GAUGE GALVANIZED WIRE GUY'S TWISTED

2" DIA. HARDWOOD STAKES 23 TREE HLT. 3 PER TREE

TWICE THE WIDTH OF ROOTBALL FOR PREPARED SOIL FOR TREES.

PREPARED SOIL FOR TREES
1 PART PEAT MOSS
1 PART COW MANURE
3 PARTS TOPSOIL
(RECOMMENDATION ONLY. SEE SOIL MOD. CHART)

UNDISTURBED SUBGRADE

DIG WIDE, SHALLOW HOLE WITH TAMPED SIDES

TAMP SOIL SOLIDLY AROUND BASE OF ROOT BALL

AVOID PURCHASING TREES WITH TWO LEADERS OR REMOVE ONE AT PLANTING; OTHERWISE, DO NOT PRUNE TREE AT PLANTING EXCEPT FOR SPECIFIC STRUCTURAL CORRECTIONS.

SET ROOT BALL FLUSH TO GRADE OR SEVERAL INCHES HIGHER IN POORLY DRAINING SOILS.


4" BUILT-UP EARTH SAUCER

3" DOUBLE SHREDDED HARDWOOD BARK MULCH (UNLESS OTHERWISE SPECIFIED) (DO NOT PLACE MULCH IN CONTACT WITH TREE TRUNK)


LANDSCAPE FABRIC AS SPECIFIED.

ALL PLANTING CONTAINERS, BASKETS AND NON-BIODEGRADABLE MATERIALS SHALL BE REMOVED FROM ROOT BALLS.


SET ROOT BALL ON UNDISTURBED SOIL IN BOTTOM OF HOLE

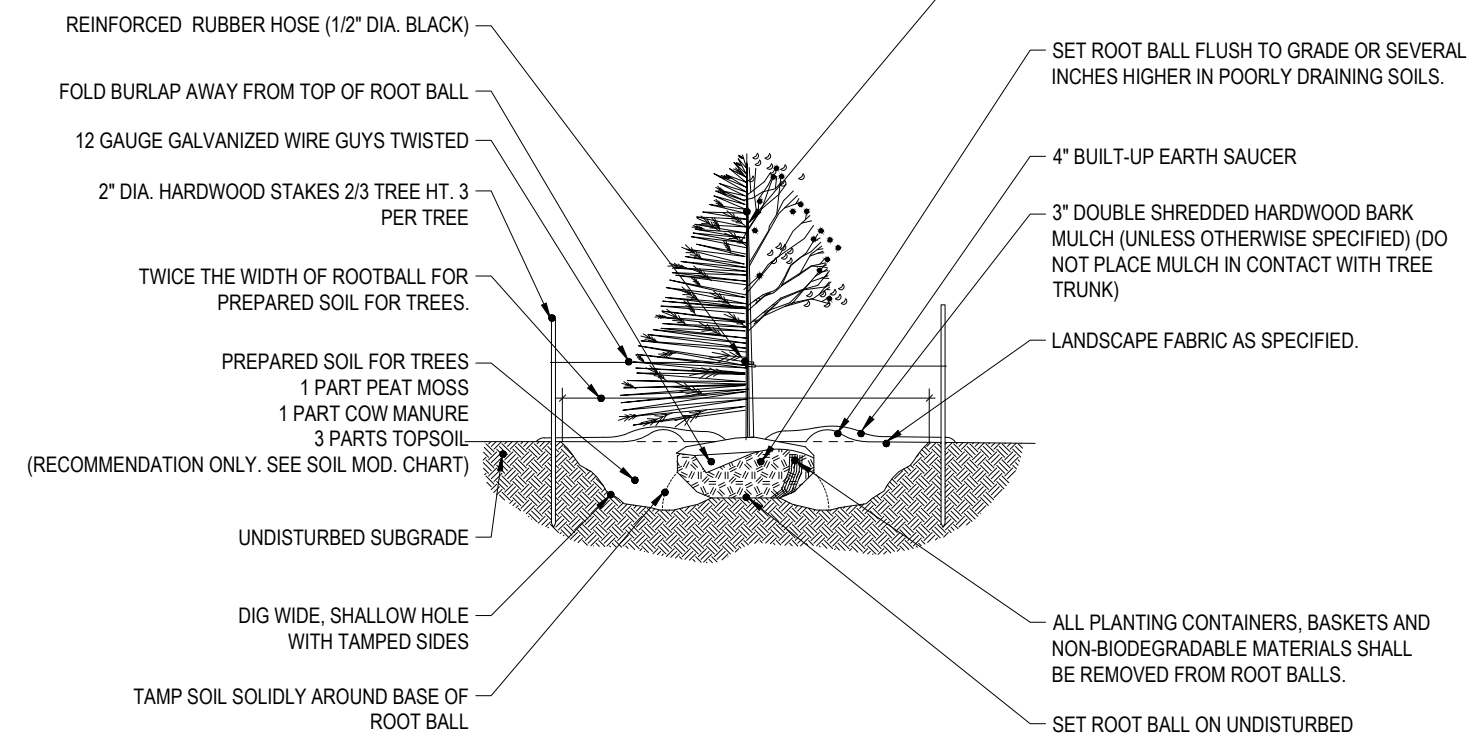

N.T.S

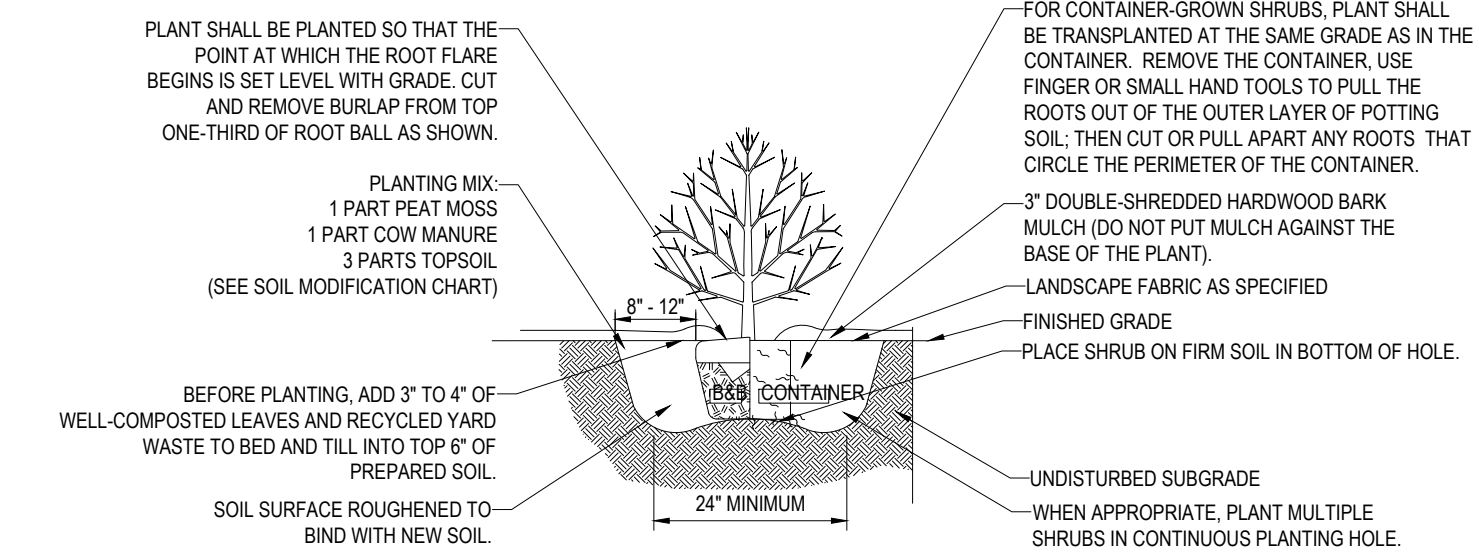

N.T.S.

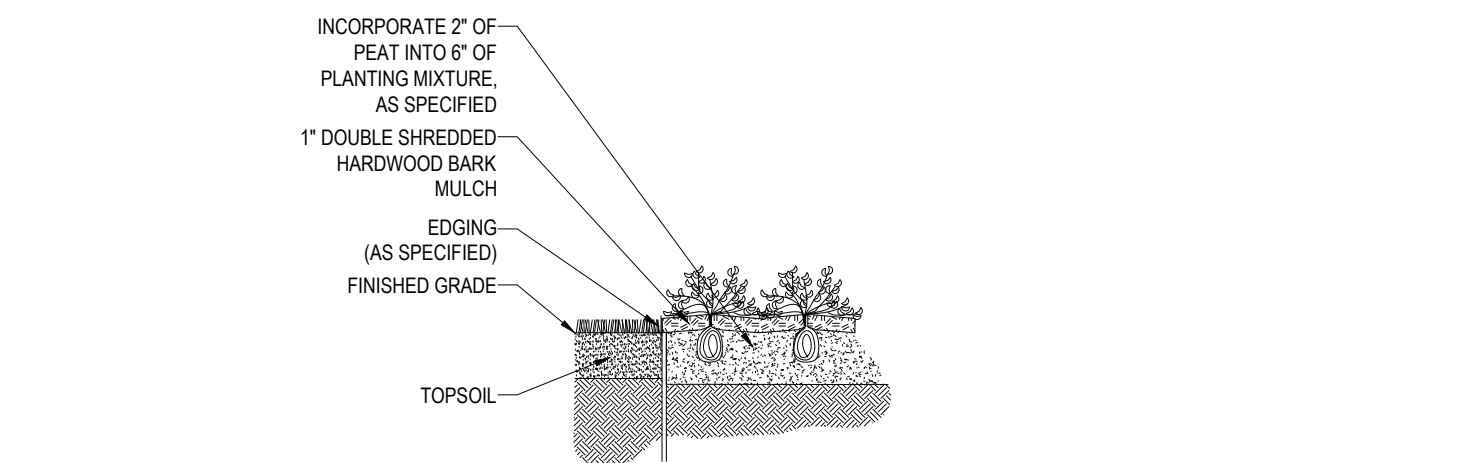


NOTES:

1. ANY TREE INSTALLED WITHIN 10 FT. OF NEW CONCRETE SIDEWALKS SHOULD BE INSTALLED WITH BIO-BARRIER ROOT BARRIER FABRIC AS SHOWN
2. TREES SHALL BE INSTALLED ACCORDING TO THE APPROPRIATE PLANTING DETAIL.

Labels in diagram:

- TREE
- SEE DECIDUOUS OR EVERGREEN TREE DETAIL FOR PLANTING PURPOSES
- 10' MAX.
- CONC. SIDEWALK
- BIO-BARRIER ROOT BARRIER FABRIC OR APPROVED EQUAL
- BIO-BARRIER ROOT BARRIER FABRIC TO BE INSTALLED TO THE DEPTH OF THE BOTTOM OF STONE BASE COURSE OR 10" WHICHEVER IS GREATER

I

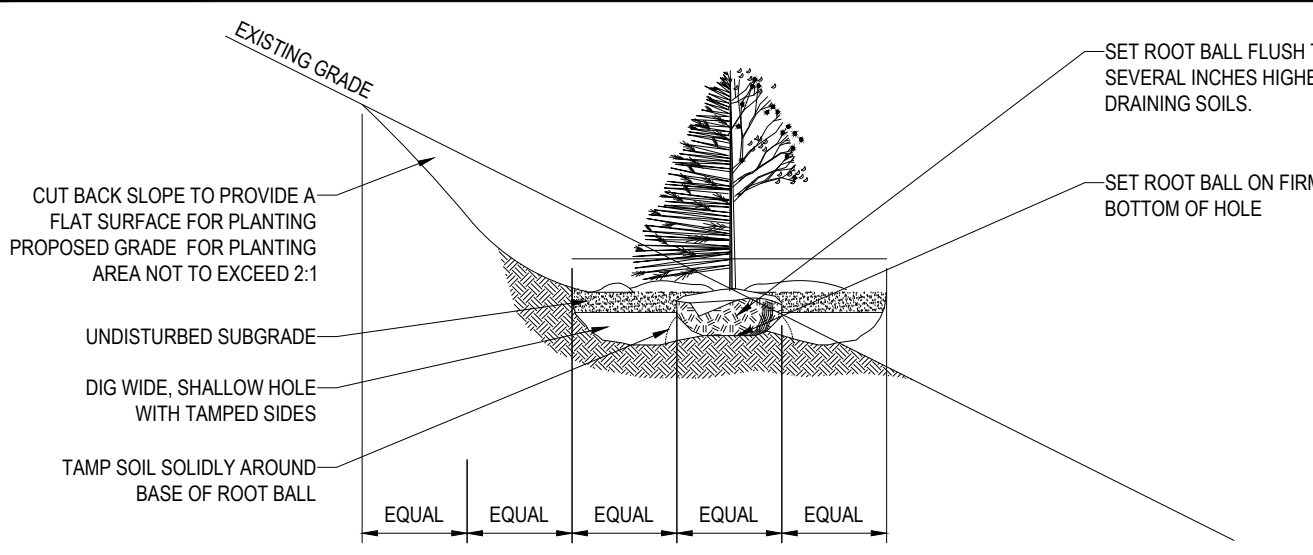[illegible]

REVISIONS			
REV	DATE	COMMENT	BY
1			
2			
3			
4			
5			
6			
7			
8			
9			
10			
11			
12			
13			
14			
15			

11

PROJECT No.:	W161042
DRAWN BY:	WS/JF
CHECKED BY:	JF/AD
DATE:	09/07/18
SCALE:	AS NOTED
CAD I.D.:	W161042SS0

PROJECT: **SITE
DEVELOPMENT
PLANS
—FOR—
CONNECTICUT
HEALTH CARE
HOLDINGS LLC**

**NEW HAVEN, CT
MAP #339, BLOCK #190, LOT #17
240 WINTHROP AVENUE
CITY OF NEW HAVEN
NEW HAVEN COUNTY,
CONNECTICUT**



BOHLER
ENGINEERING

352 TURNPIKE ROAD
SOUTHBOROUGH, MA 01772

Phone: (508) 480-9900
Fax: (508) 480-9080

www.BohlerEngineering.com

M.J. MRVA

**REGISTERED
LANDSCAPE ARCHITECT**



MASSACHUSETTS No. 1217
RHODE ISLAND No. 419
NEW YORK No. 002359
NEW HAMPSHIRE No. 109
CONNECTICUT No. 1359

SHEET TITLE:

LANDSCAPE
NOTES &
DETAILS SHEET

SHEET NUMBER:
10
OF 14

REV 0 - 09/07/2018

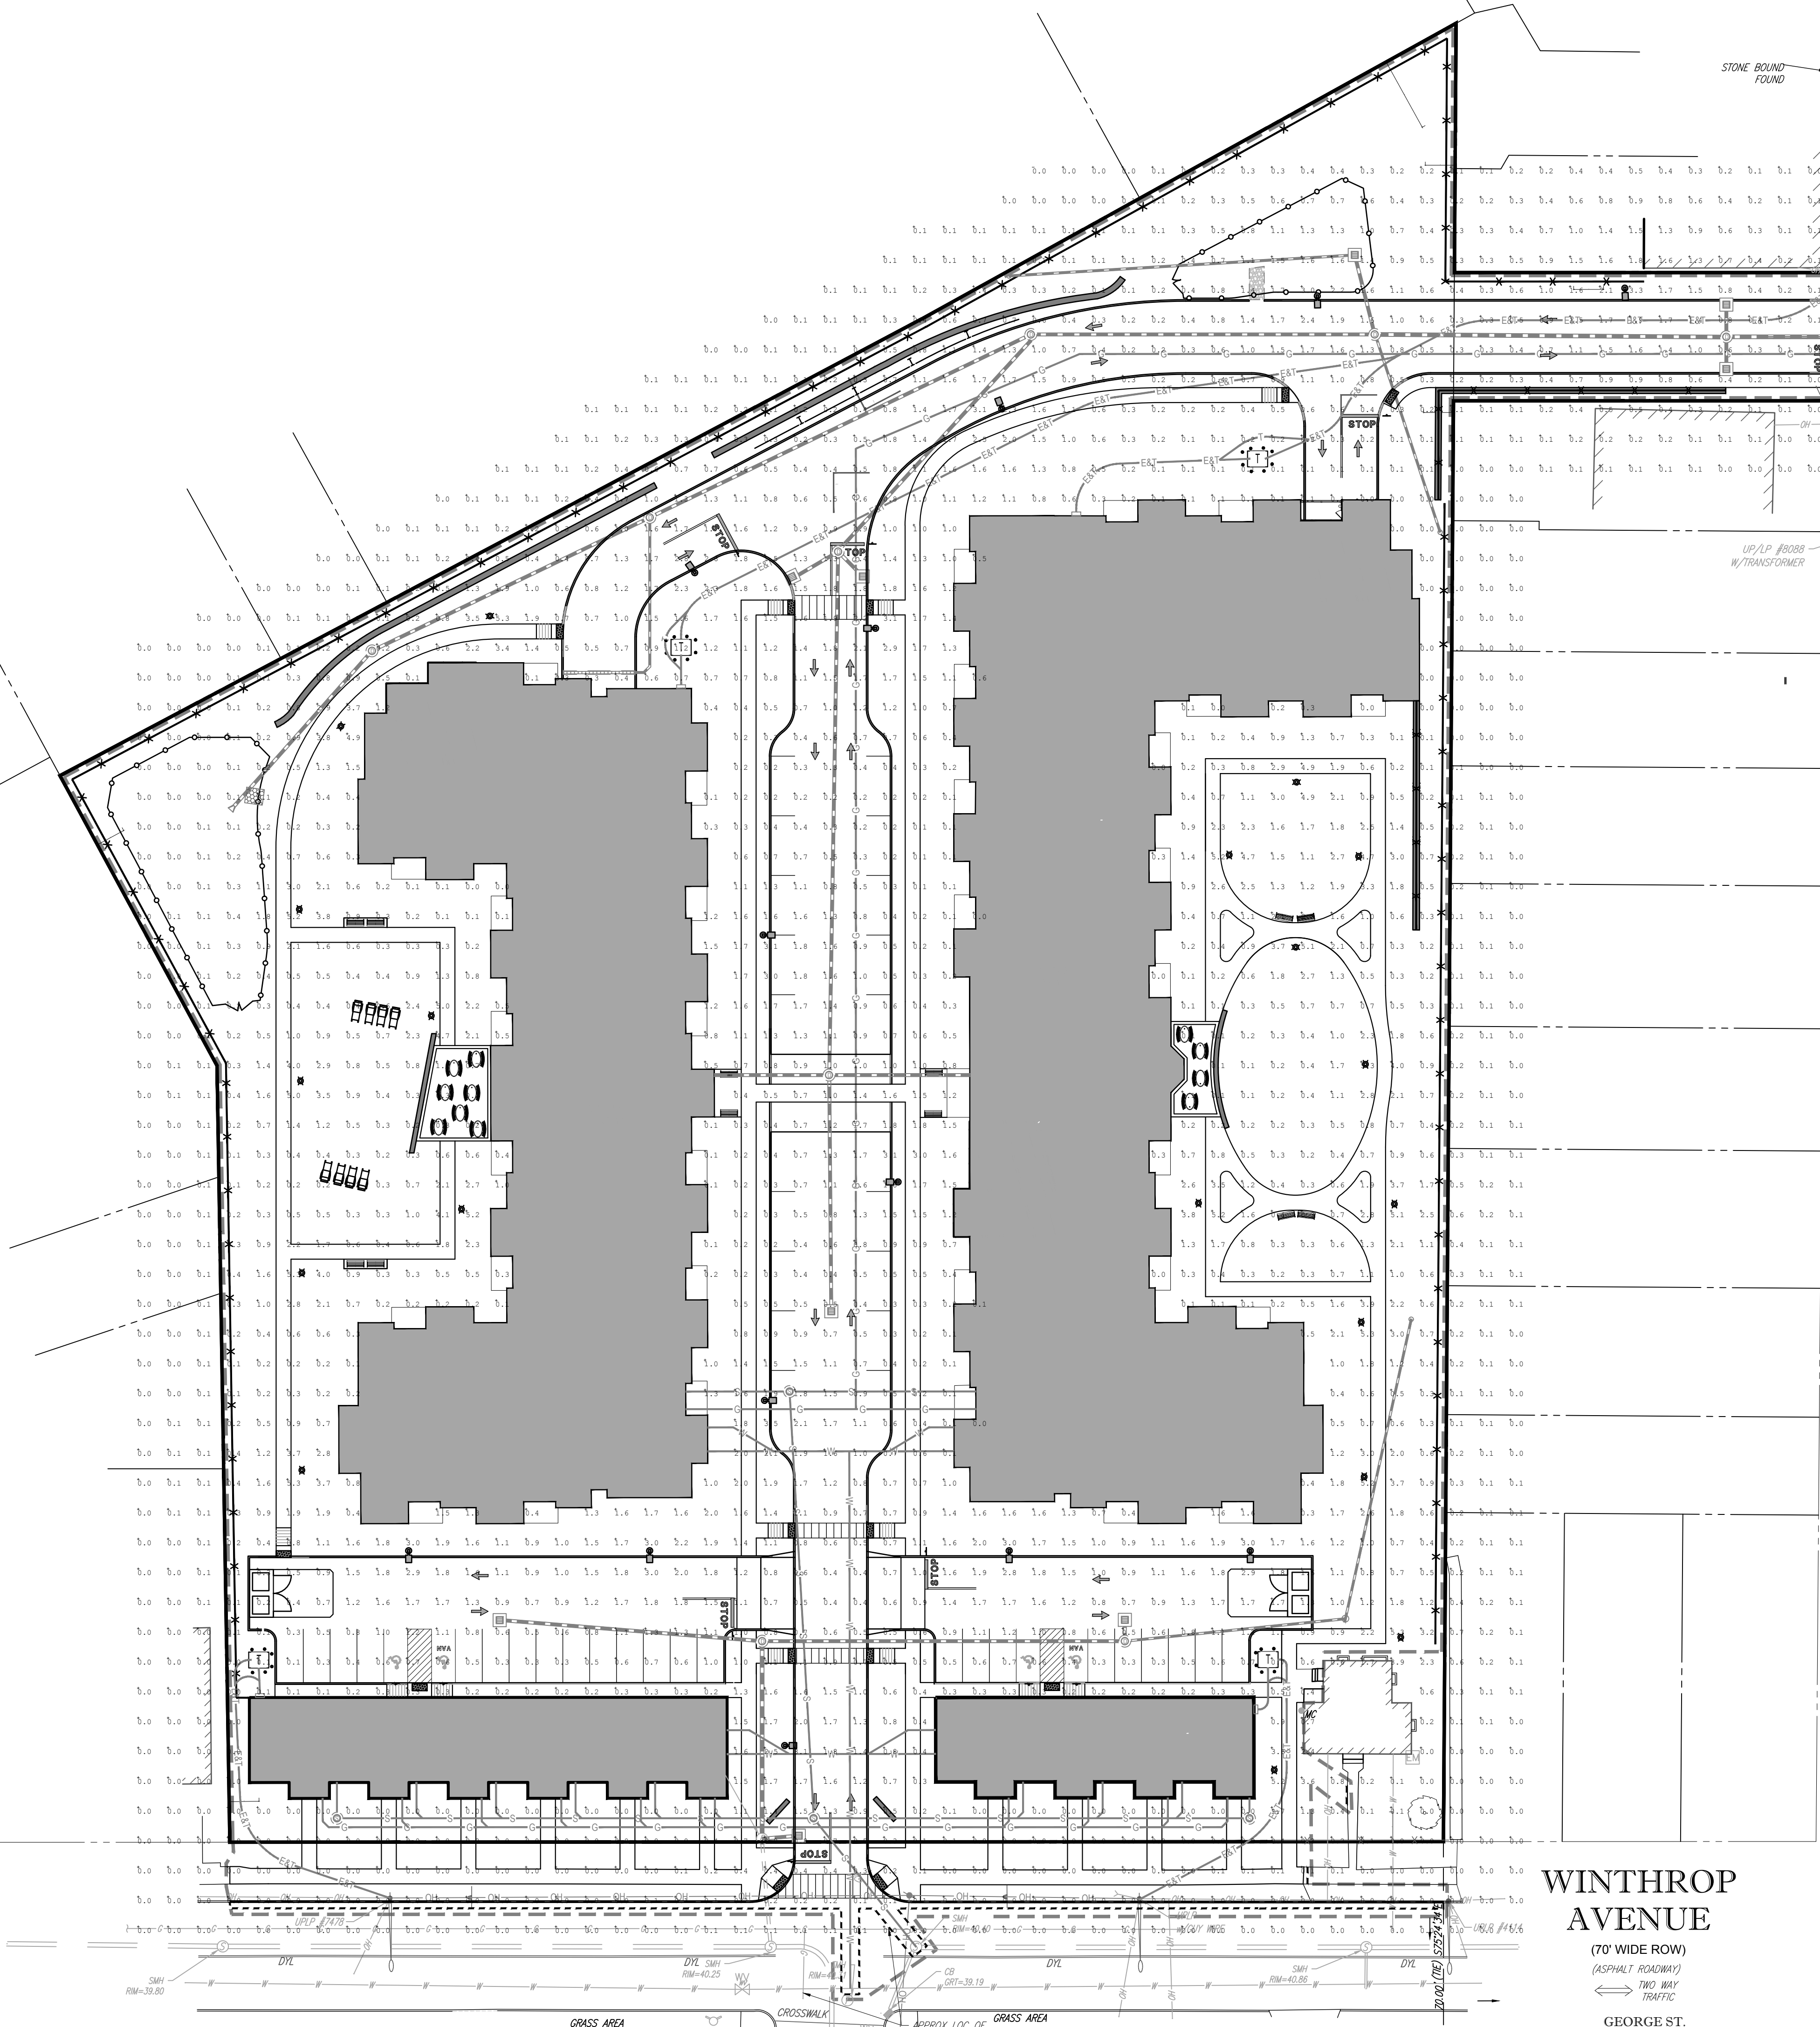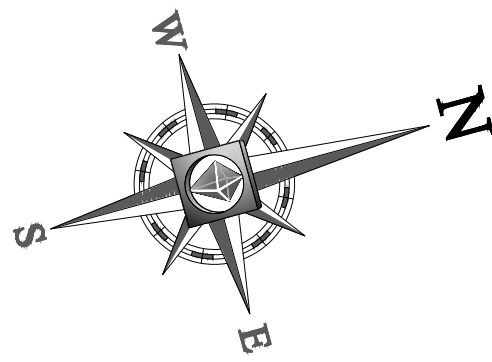


LIGHTING NOTES:

1. THIS LIGHTING PLAN DEPICTS PROPOSED SUSTAINED ILLUMINATION LEVELS CALCULATED USING DATA PROVIDED BY THE NOTED MANUFACTURER(S). ACTUAL SUSTAINED SITE ILLUMINATION LEVELS AND PERFORMANCE OF LUMINAIRES MAY VARY DUE TO VARIATIONS IN WEATHER, ELECTRICAL VOLTAGE, TOLERANCE IN LAMPS, THE SERVICE LIFE OF EQUIPMENT AND LUMINAIRES AND OTHER RELATED VARIABLE FIELD CONDITIONS.
2. THE LIGHT LOSS FACTORS USED IN THESE LIGHTING CALCULATIONS ARE 0.90 FOR ALL LED LUMINAIRES, 0.80 FOR ALL HIGH PRESSURE SODIUM LUMINAIRES OR 0.72 FOR ALL METAL HALIDE LUMINAIRES UNLESS OTHERWISE SPECIFIED. THESE FACTORS ARE INDICATIVE OF TYPICAL LIGHTING INDUSTRY MODELING STANDARDS.
3. THE LIGHTING VALUES AND CALCULATION POINTS DEPICTED ON THIS PLAN ARE ALL ANALYZED ON A HORIZONTAL GEOMETRIC PLANE AT ELEVATION ZERO (GROUND LEVEL) UNLESS OTHERWISE NOTED. THE VALUES DEPICTED ON THIS PLAN ARE IN FOOTCANDLES.
4. THE LUMINAIRES, LAMPS AND LENSES MUST BE REGULARLY INSPECTED/MAINTAINED TO ENSURE THAT THEY FUNCTION PROPERLY. THIS WORK SHOULD INCLUDE, BUT NOT BE LIMITED TO, FREQUENT VISUAL INSPECTIONS, CLEANING OF LENSES, AND RELAMPING (IF NECESSARY) AT LEAST ONCE EVERY SIX (6) MONTHS. FAILURE TO FOLLOW THE ABOVE STEPS COULD CAUSE THE LUMINAIRES, LAMPS AND LENSES TO FAIL PROPERLY TO FUNCTION.
5. WHERE APPLICABLE, THE EXISTING CONDITION LIGHT LEVELS ILLUSTRATED ARE REPRESENTATIVE OF AN APPROXIMATION UTILIZING LABORATORY DATA FOR SIMILAR FIXTURES, UNLESS ACTUAL FIELD MEASUREMENTS ARE TAKEN WITH A LIGHT METER AND ARE, CONSEQUENTLY, APPROXIMATIONS ONLY. DUE TO FACTORS SUCH AS FIXTURE MAINTENANCE, EQUIPMENT TOLERANCES, WEATHER CONDITIONS, ETC. ACTUAL LIGHT LEVELS MAY DIFFER. EXISTING LIGHT LEVELS DEPICTED ON THIS PLAN SHOULD BE CONSIDERED APPROXIMATE.
6. THIS LIGHTING PLAN IS INTENDED TO SHOW THE LOCATIONS AND TYPE OF LUMINAIRES, ONLY. POWER SYSTEM, CONDUITS, WIRING, VOLTAGES AND OTHER ELECTRICAL COMPONENTS ARE THE RESPONSIBILITY OF THE ARCHITECT, MEP AND/OR LIGHTING CONTRACTOR, AS INDICATED IN THE CONSTRUCTION CONTRACT DOCUMENTS. THESE ITEMS MUST BE INSTALLED AS REQUIRED BY STATE AND LOCAL REGULATIONS. LIGHT POLE BASES ARE THE RESPONSIBILITY OF THE STRUCTURAL ENGINEER, AS INDICATED IN THE CONSTRUCTION CONTRACT DOCUMENTS. CONTRACTOR IS RESPONSIBLE FOR INSTALLING LIGHTING FIXTURES AND APPURTENANCES IN ACCORDANCE WITH ALL APPLICABLE BUILDING AND ELECTRICAL CODES AND ALL OTHER APPLICABLE RULES, REGULATIONS, LAWS AND STATUTES.
7. CONTRACTOR MUST BRING TO DESIGNER'S ATTENTION, PRIOR TO THE COMMENCEMENT OF CONSTRUCTION, ANY LIGHT LOCATIONS THAT CONFLICT WITH DRAINAGE, UTILITIES, OR OTHER STRUCTURES.
8. IT IS LIGHTING CONTRACTOR'S RESPONSIBILITY TO COORDINATE WITH THE PROJECT ARCHITECT OR OWNER REGARDING THE POWER SOURCE(S) FROM WITHIN THE BUILDING, AND TIMING DEVICES NECESSARY TO MEET THE DESIGN INTENT.
9. THE LIGHTING CONTRACTOR SHALL COMPLY WITH ALL APPLICABLE CONTRACTOR REQUIREMENTS INDICATED IN THE SITE PLAN, INCLUDING BUT NOT LIMITED TO, GENERAL NOTES, GRADING AND UTILITY NOTES, SITE SAFETY, AND ALL GOVERNMENTAL RULES, LAWS, ORDINANCES, REGULATIONS AND THE LIKE.
10. THE CONTRACTOR MUST VERIFY THAT INSTALLATION OF LIGHTING FIXTURES COMPLIES WITH THE REQUIREMENTS FOR SEPARATION FROM OVERHEAD ELECTRICAL WIRES PER STATE REGULATIONS.
11. WHEN A BANK ATM IS INCLUDED IN THE PLAN, THE LIGHTING DESIGN REPRESENTS BOHLER'S UNDERSTANDING AND INTERPRETATION OF THE REGULATORY LIGHTING LEVELS INTENDED BY PUBLISHED STANDARDS.
12. UPON OWNER'S ACCEPTANCE OF THE COMPLETED PROJECT, THE OWNER SHALL BE RESPONSIBLE FOR ALL MAINTENANCE, SERVICING, REPAIR AND INSPECTION OF THE LIGHTING SYSTEM AND ALL OF ITS COMPONENTS AND RELATED SYSTEMS, TO ENSURE ADEQUATE LIGHTING LEVELS ARE PRESENT AND FUNCTIONING AT ALL TIMES.

NUMERIC SUMMARY						
LABEL	CALCTYPE	UNITS	AVG	MAX	MIN	AVG/MIN
AREA SUMMARY	ILLUMINANCE	FC	0.85	5.3	0.1	


LUMINAIRE SCHEDULE					
SYMBOL	QTY	ARRANGEMENT	LUMENS	LLF	DESCRIPTION
☉	13	SINGLE	8945	0.90	STERNBERG 1521 LED OMEGA SERIES 94W LED - 18' MOUNTING HEIGHT
☉	19	SINGLE	3998	0.90	BEGA-US 56W LED - 12' MOUNTING HEIGHT

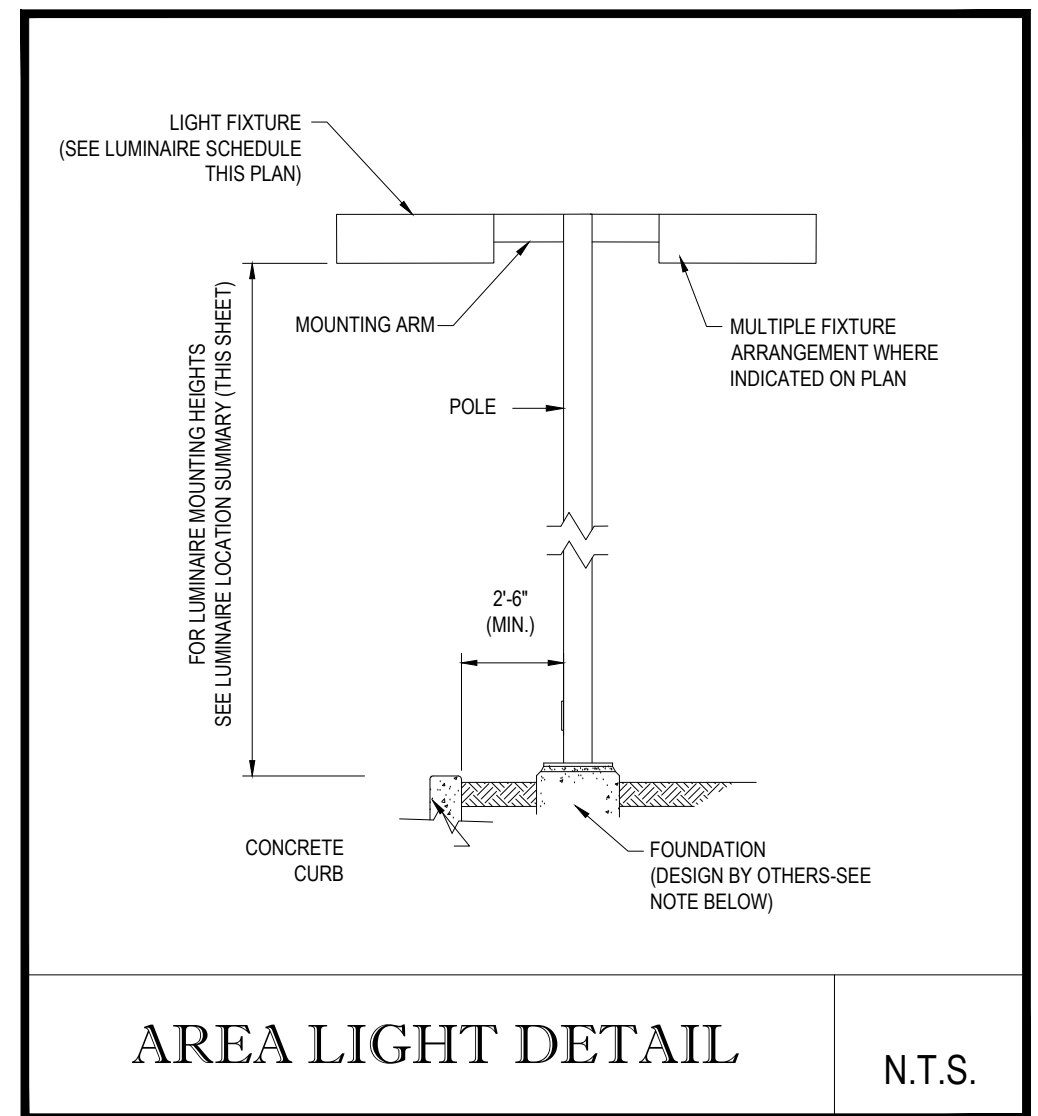

NOTE: THIS DETAIL IS FOR BID AND BUDGETARY PURPOSES ONLY. CONTRACTOR SHALL BE RESPONSIBLE FOR HAVING A FOUNDATION DESIGN PREPARED BY A QUALIFIED STRUCTURAL ENGINEER CONSIDERING LIGHTING MANUFACTURER REQUIREMENTS, LOCAL WIND LOADS AND SITE SPECIFIC SOIL PARAMETERS.

- SOME SITE CONDITIONS AND/OR LOCATIONS MAY REQUIRE VIBRATION DAMPENING MEASURES AS DETERMINED BY A STRUCTURAL ENGINEER.
- THE STRUCTURAL ENGINEER SHALL BE NOTIFIED OF THE INTENT TO MOUNT ANYTHING TO THE POLE, ASIDE FROM THE LIGHT FIXTURES, INCLUDING BUT NOT LIMITED TO CAMERAS, BANNERS, FLAGS, SIGNAGE, ETC. AS IT WILL IMPACT THE POLE AND FOUNDATION DESIGN.

THIS PLAN TO BE UTILIZED FOR LIGHTING PURPOSES ONLY

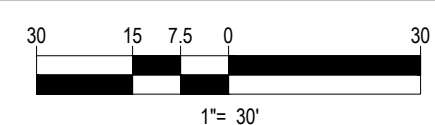

WINTHROP AVENUE
(70' WIDE ROW)
(ASPHALT ROADWAY)
← TWO WAY TRAFFIC →
GEORGE ST.



BOHLER
ENGINEERING

SITE CIVIL AND CONSULTING ENGINEERING
LAND SURVEYING AND CONSTRUCTION
SUSTAINABLE DESIGN
TRANSPORTATION SERVICES

- UTAH
- ARIZONA
- NEW MEXICO
- COLORADO
- CALIFORNIA
- OREGON
- WASHINGTON
- IDAHO
- MONTANA
- WYOMING
- NEVADA
- UTAH
- ARIZONA
- NEW MEXICO
- COLORADO
- CALIFORNIA
- OREGON
- WASHINGTON
- IDAHO
- MONTANA
- WYOMING
- NEVADA

- ALABAMA
- ALASKA
- ARIZONA
- ARKANSAS
- CALIFORNIA
- CONNECTICUT
- DELAWARE
- FLORIDA
- GEORGIA
- ILLINOIS
- INDIANA
- IOWA
- KANSAS
- KENTUCKY
- LOUISIANA
- MAINE
- MARYLAND
- MASSACHUSETTS
- MICHIGAN
- MINNESOTA
- MISSISSIPPI
- MISSOURI
- MONTANA
- NEBRASKA
- NEVADA
- NEW HAMPSHIRE
- NEW JERSEY
- NEW MEXICO
- NEW YORK
- NORTH CAROLINA
- NORTH DAKOTA
- OHIO
- OKLAHOMA
- OREGON
- PENNSYLVANIA
- RHODE ISLAND
- SOUTH CAROLINA
- SOUTH DAKOTA
- TENNESSEE
- TEXAS
- UTAH
- VERMONT
- VIRGINIA
- WASHINGTON
- WISCONSIN
- WYOMING

REVISIONS			
REV	DATE	COMMENT	BY
1			
2			
3			
4			
5			
6			
7			
8			
9			
10			
11			
12			
13			
14			
15			

PRELIMINARY

PROJECT No.: W161042
DRAWN BY: WSJF
CHECKED BY: JFAD
DATE: 09/07/18
SCALE: AS NOTED
CAD I.D.: W161042SS0

PROJECT: **SITE DEVELOPMENT PLANS FOR CONNECTICUT HEALTH CARE HOLDINGS LLC**
NEW HAVEN, CT
MAP #339, BLOCK #190, LOT #17
240 WINTHROP AVENUE
CITY OF NEW HAVEN
NEW HAVEN COUNTY, CONNECTICUT



BOHLER
ENGINEERING

352 TURNPIKE ROAD
SOUTHBOROUGH, MA 01772
Phone: (508) 480-9900
Fax: (508) 480-9080
www.BohlerEngineering.com

J.G. SWERLING

PROFESSIONAL ENGINEER
MASSACHUSETTS LICENSE No. 41691
NEW HAMPSHIRE LICENSE No. 14695
MAINE LICENSE No. 13818
CONNECTICUT LICENSE No. 30786
RHODE ISLAND LICENSE No. 1425

SHEET TITLE:
LIGHTING PLAN


SHEET NUMBER:
11
OF 14

REV 0 - 09/07/2018

P:\161042\Drawings\Plan Set\REV\W161042SS0.dwg, 11-Light, 10/26/2014, 4:26:00 PM, jfswerling_xenox510-1.pcd, User:JSA, 11


811

Know what's below.
Call before you dig.

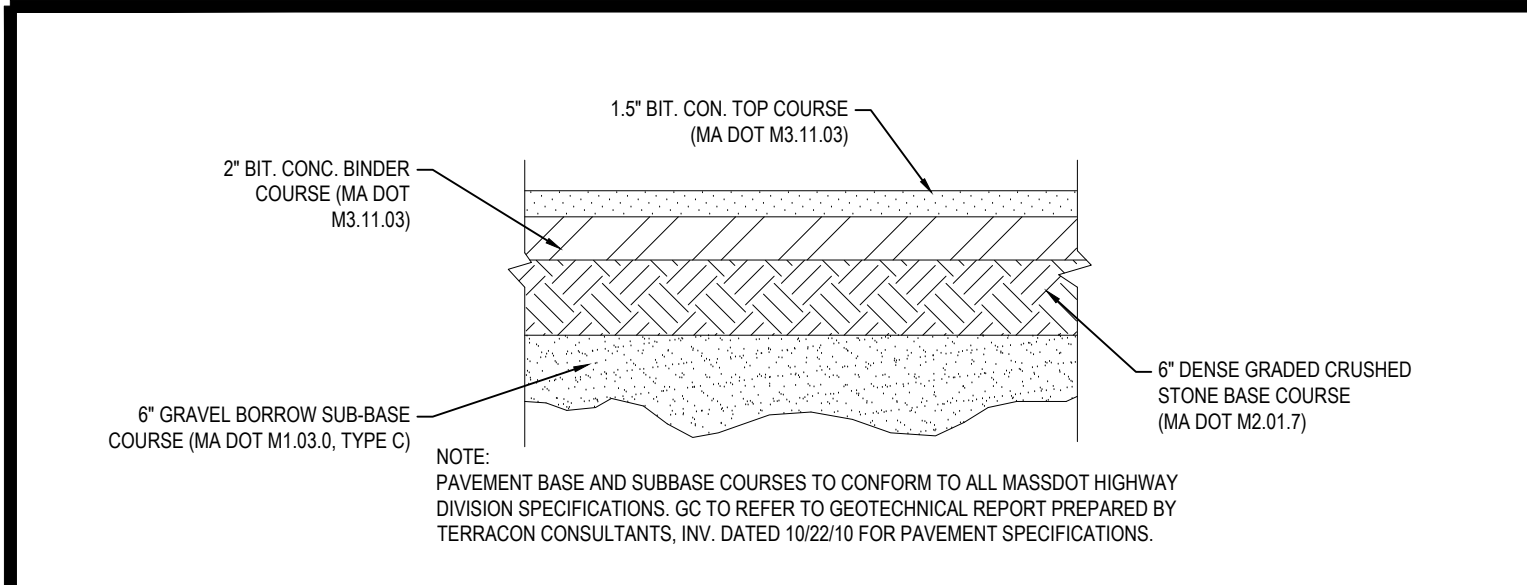


TYPICAL PAVEMENT SECTION

N.T.S.

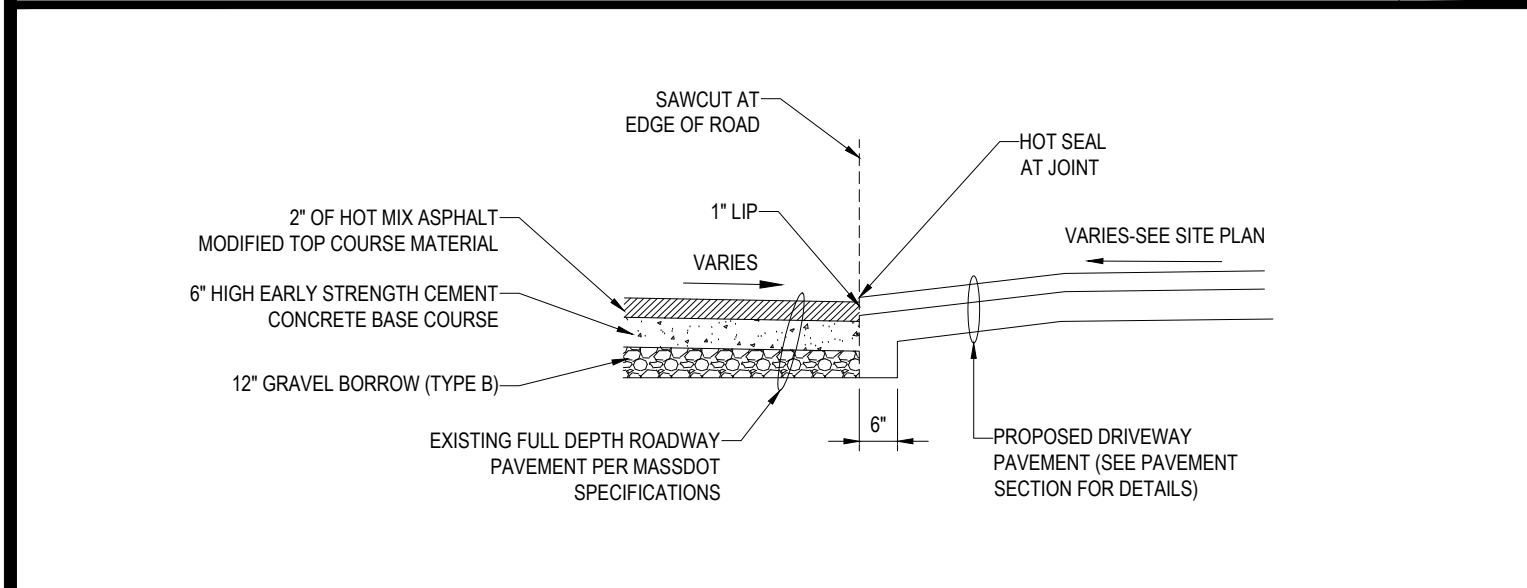


DRIVEWAY CONSTRUCTION DETAIL

N.T.S.

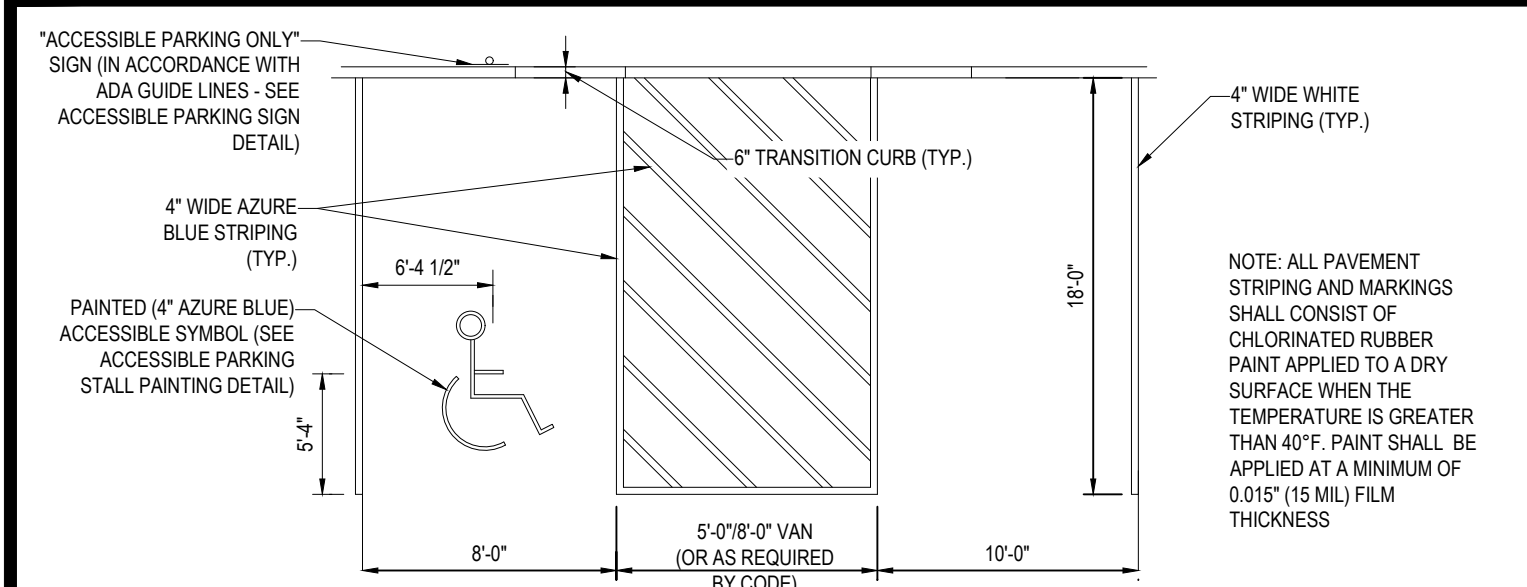


ACCESSIBLE STALL MARKINGS & PARKING LOT STRIPING DETAIL

N.T.S.

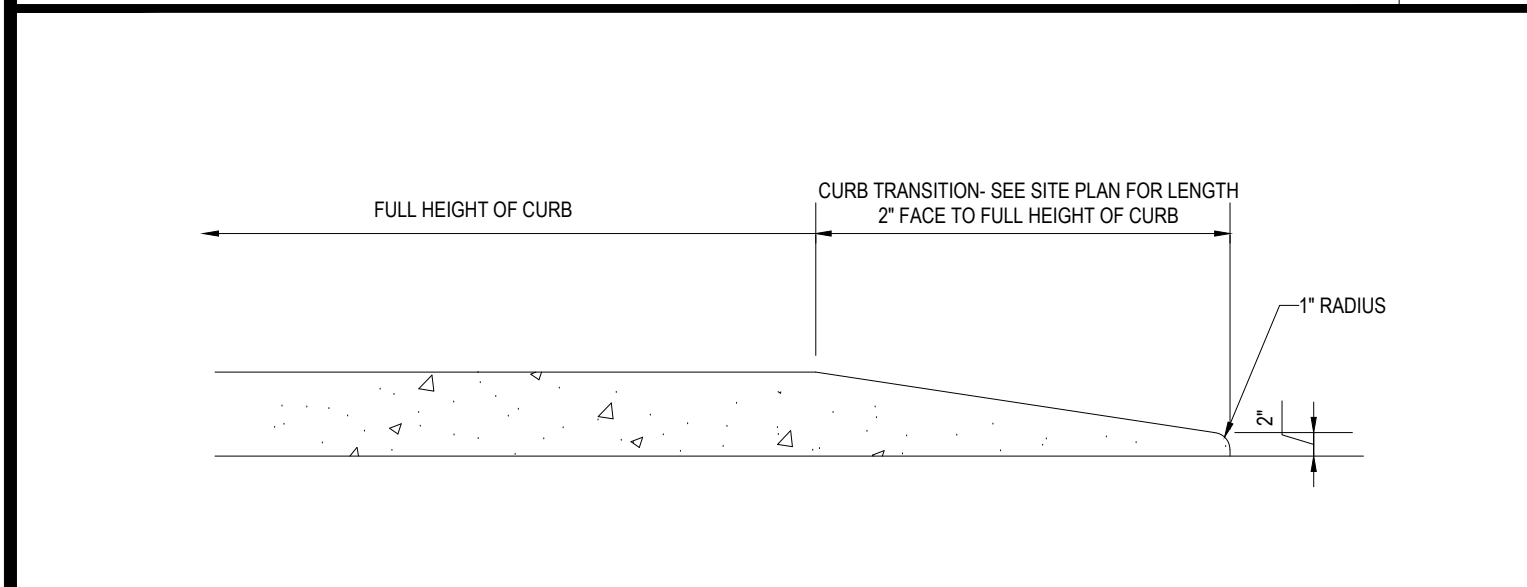


TRANSITION CURB DETAIL

N.T.S.

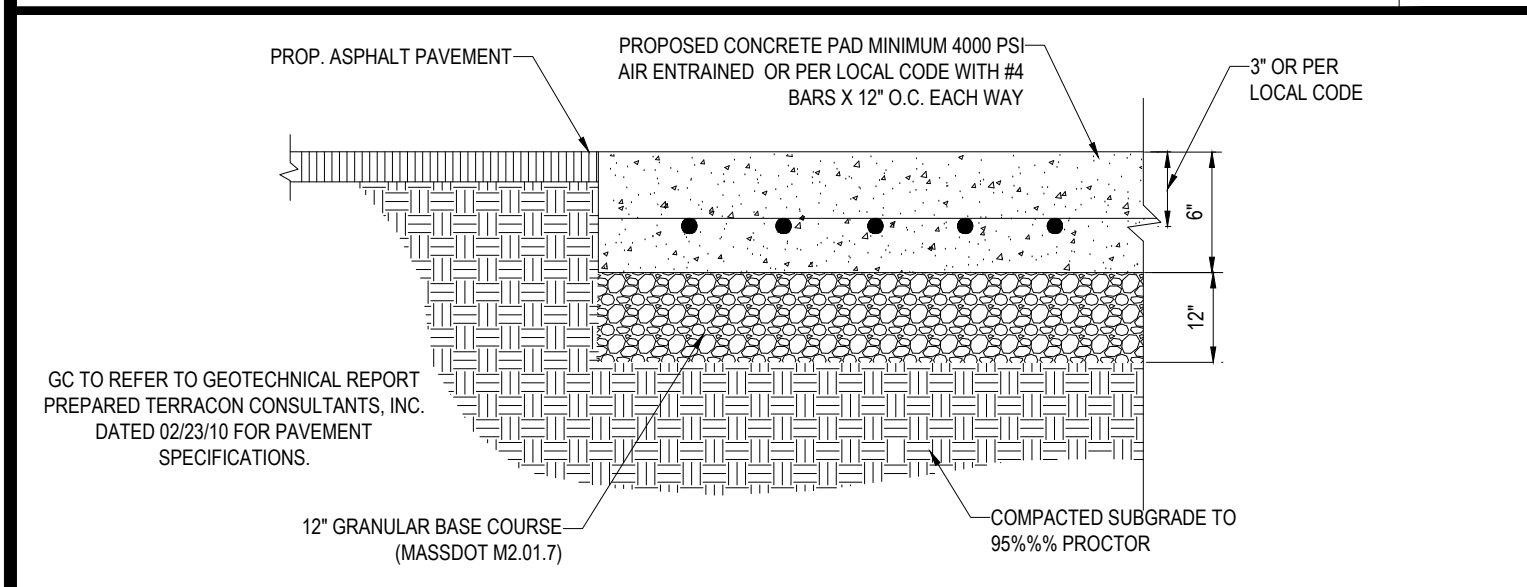


DUMPSTER PAD DETAIL

N.T.S.

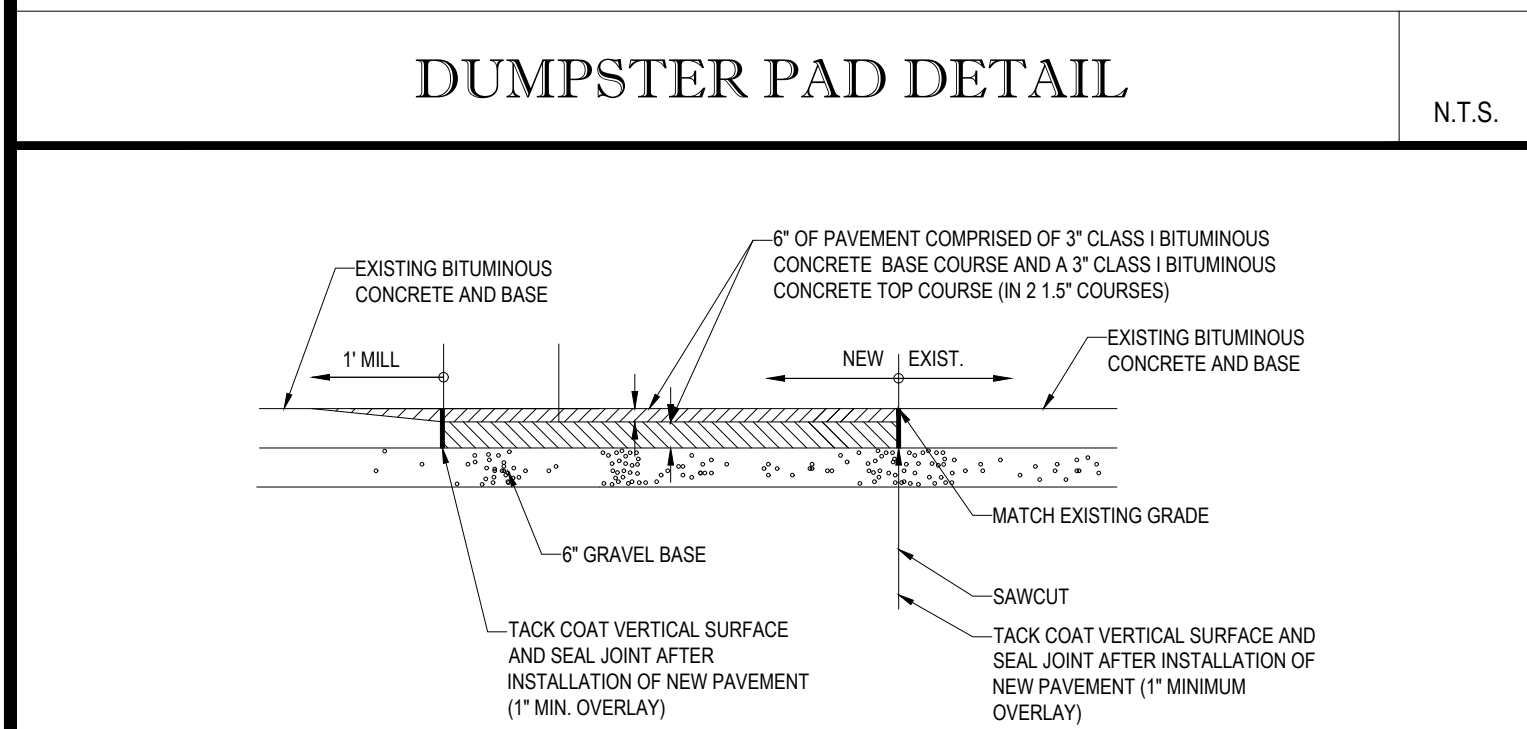


ROADWAY PATCHING DETAIL

N.T.S.

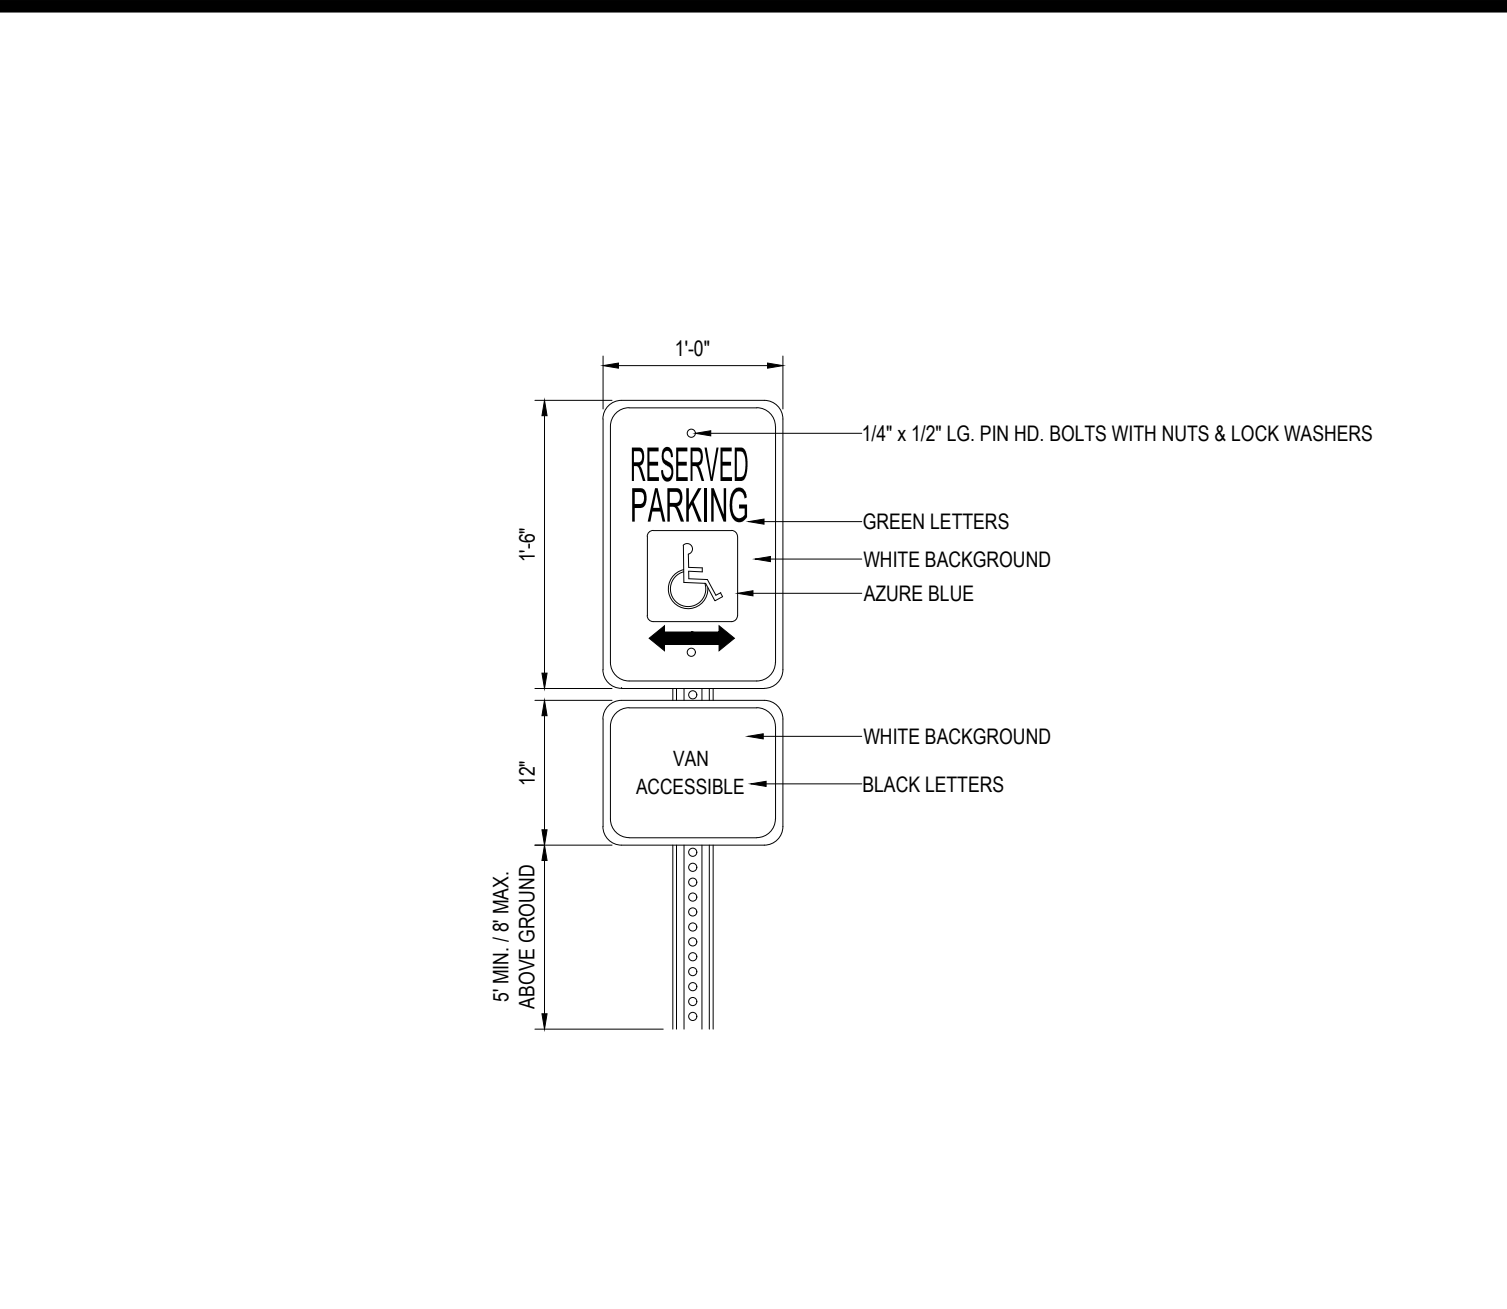


ACCESSIBLE PARKING SIGN DETAIL

N.T.S.

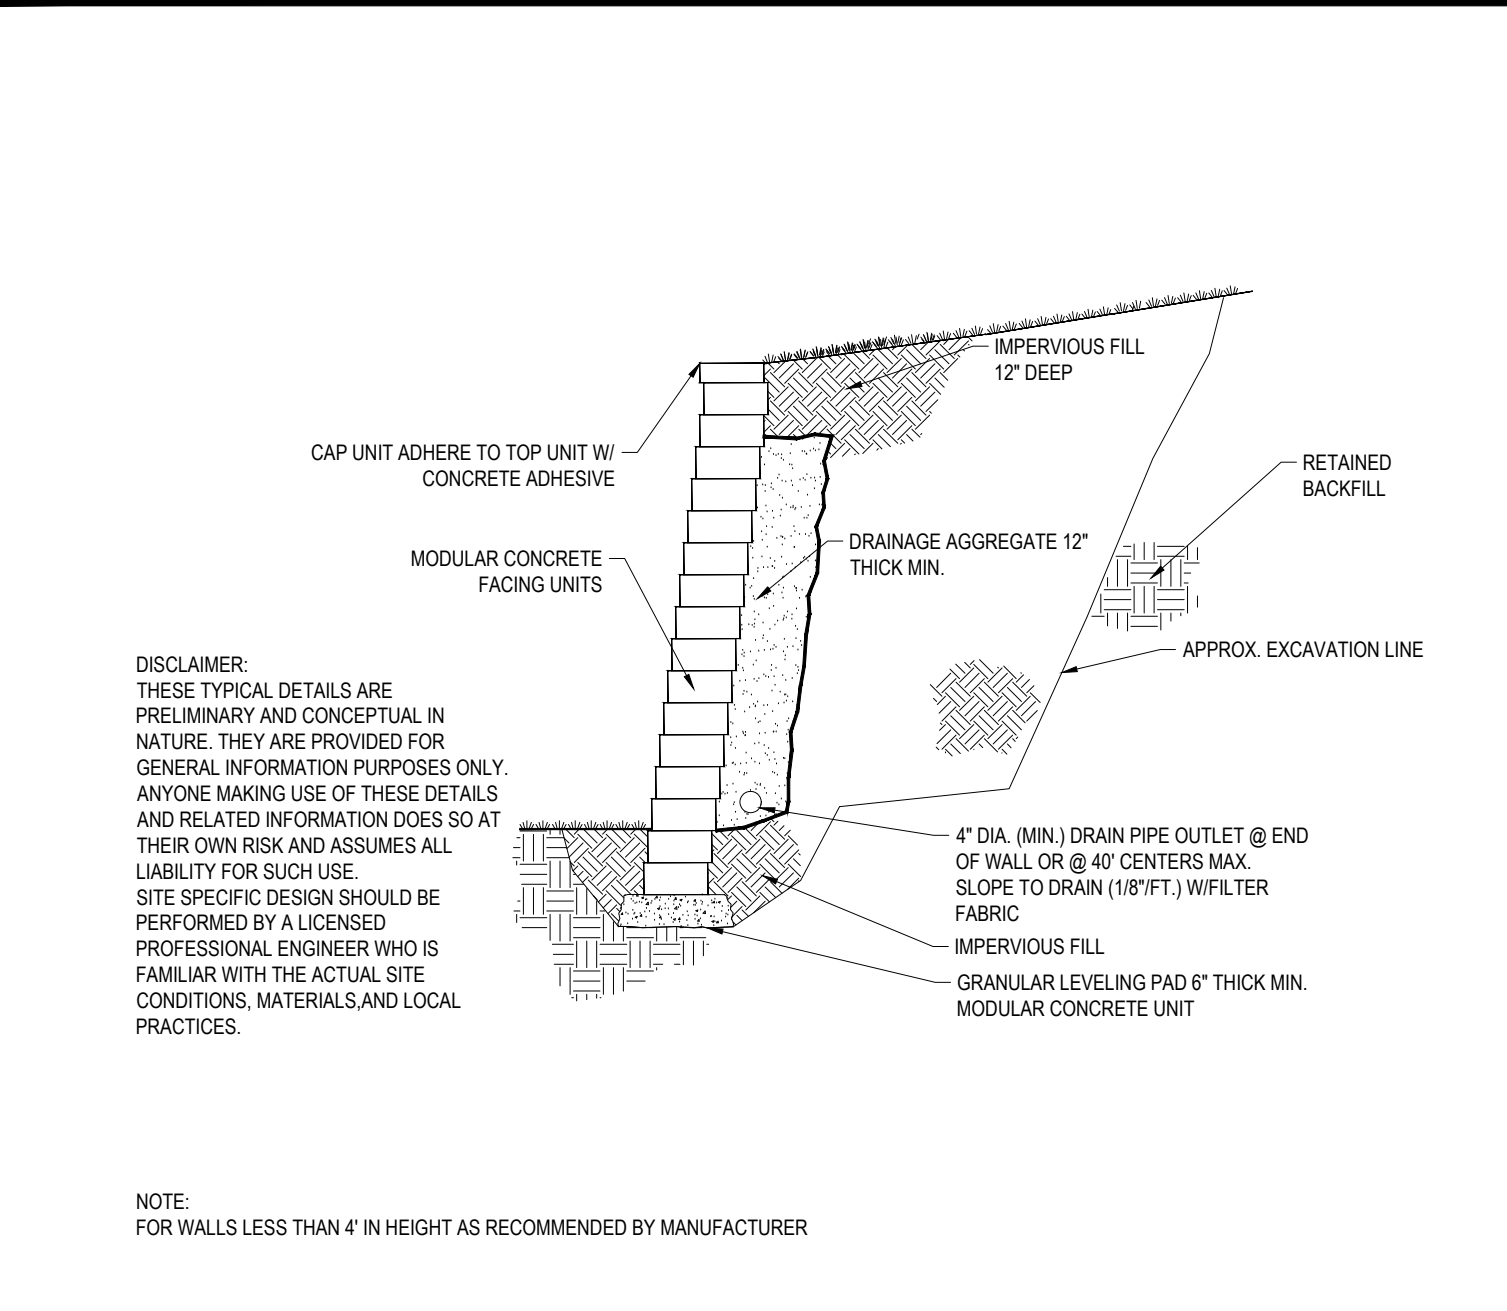


VERSA-LOK REINFORCED RETAINING WALL DETAIL (OR EQUAL)

N.T.S.

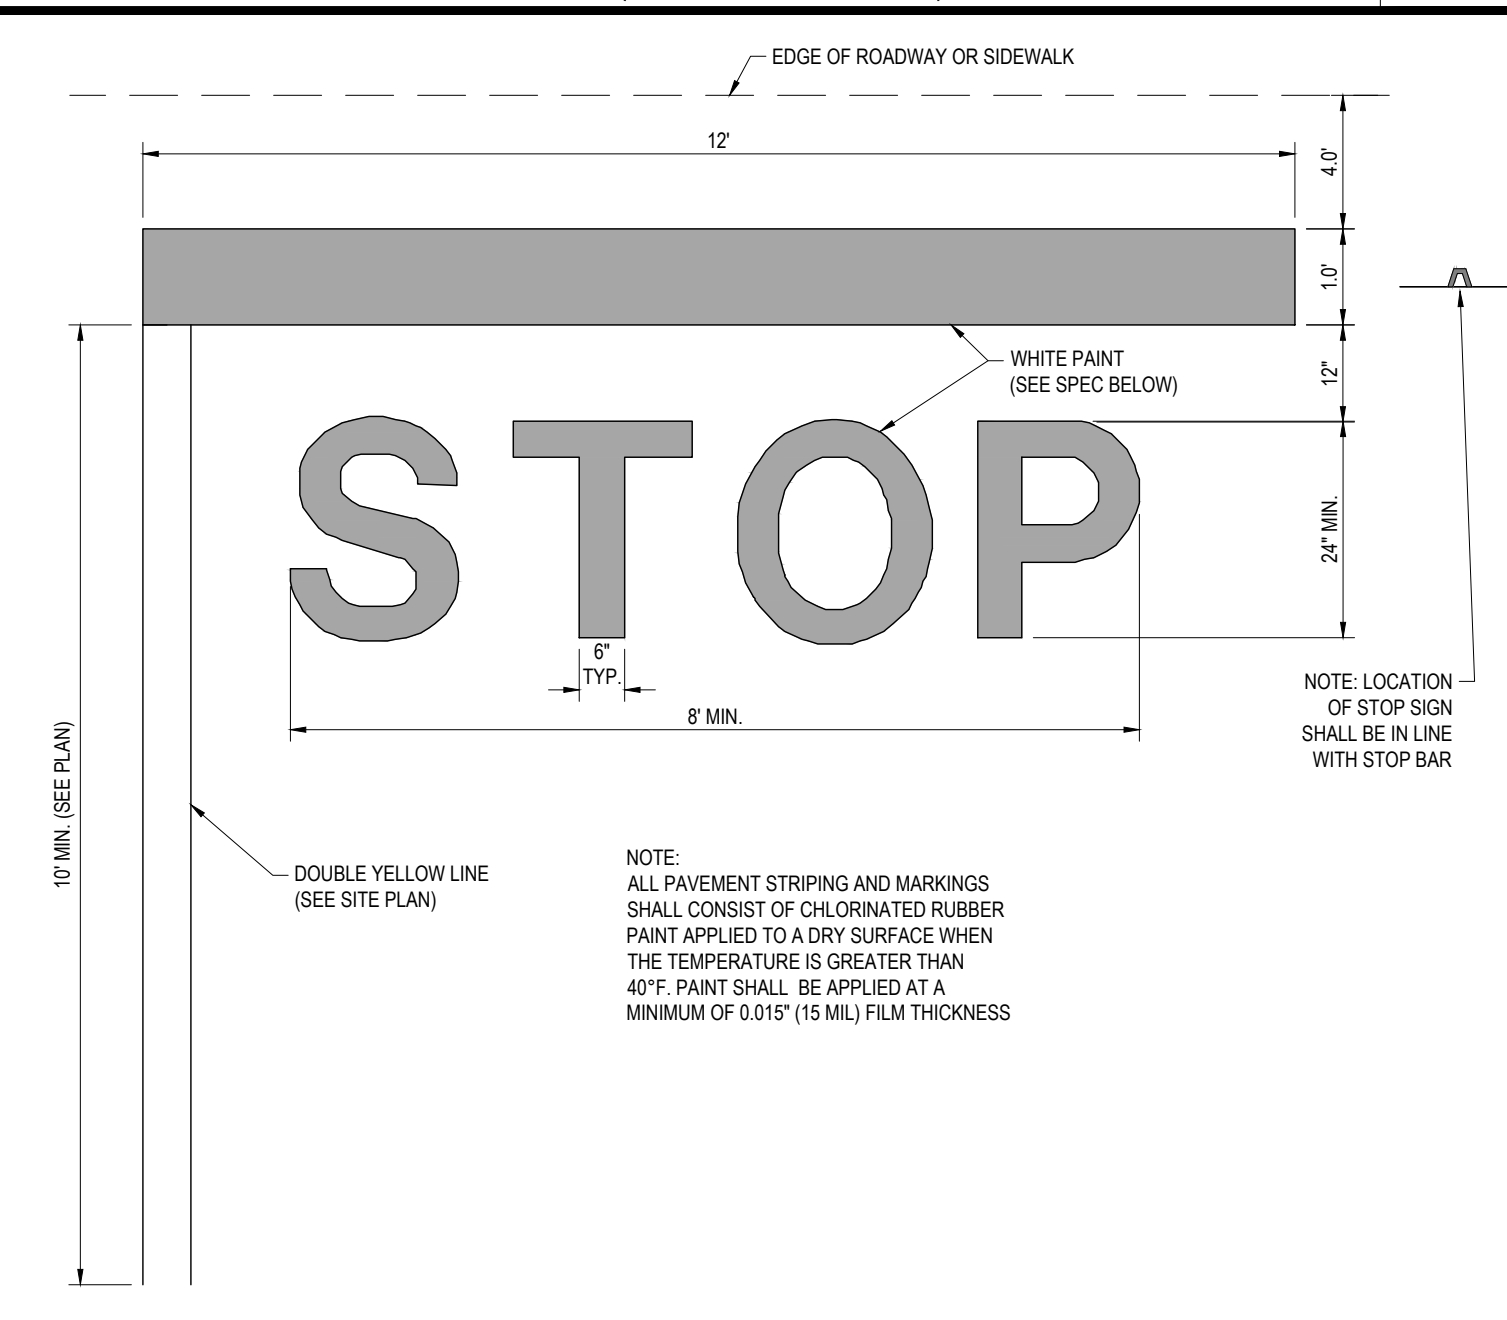


'STOP' BAR DETAIL

N.T.S.

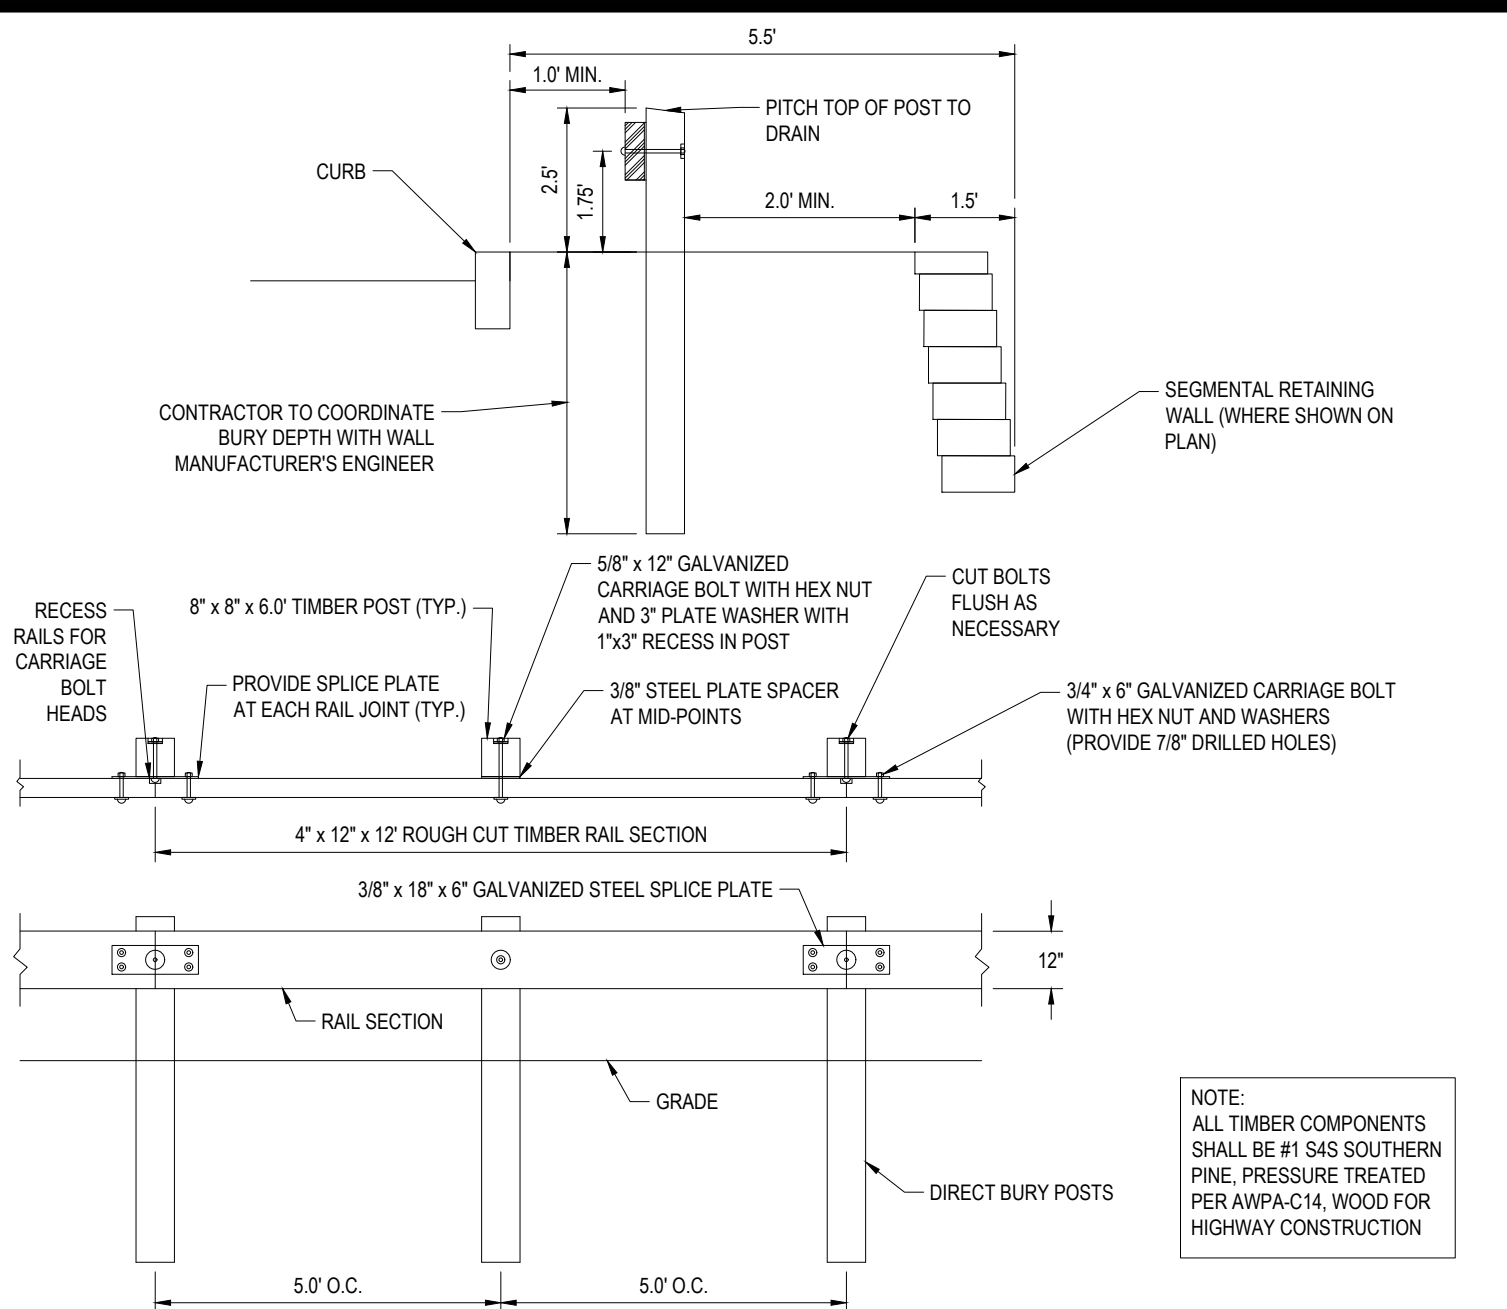


WOOD TIMBER GUIDE RAIL

N.T.S.

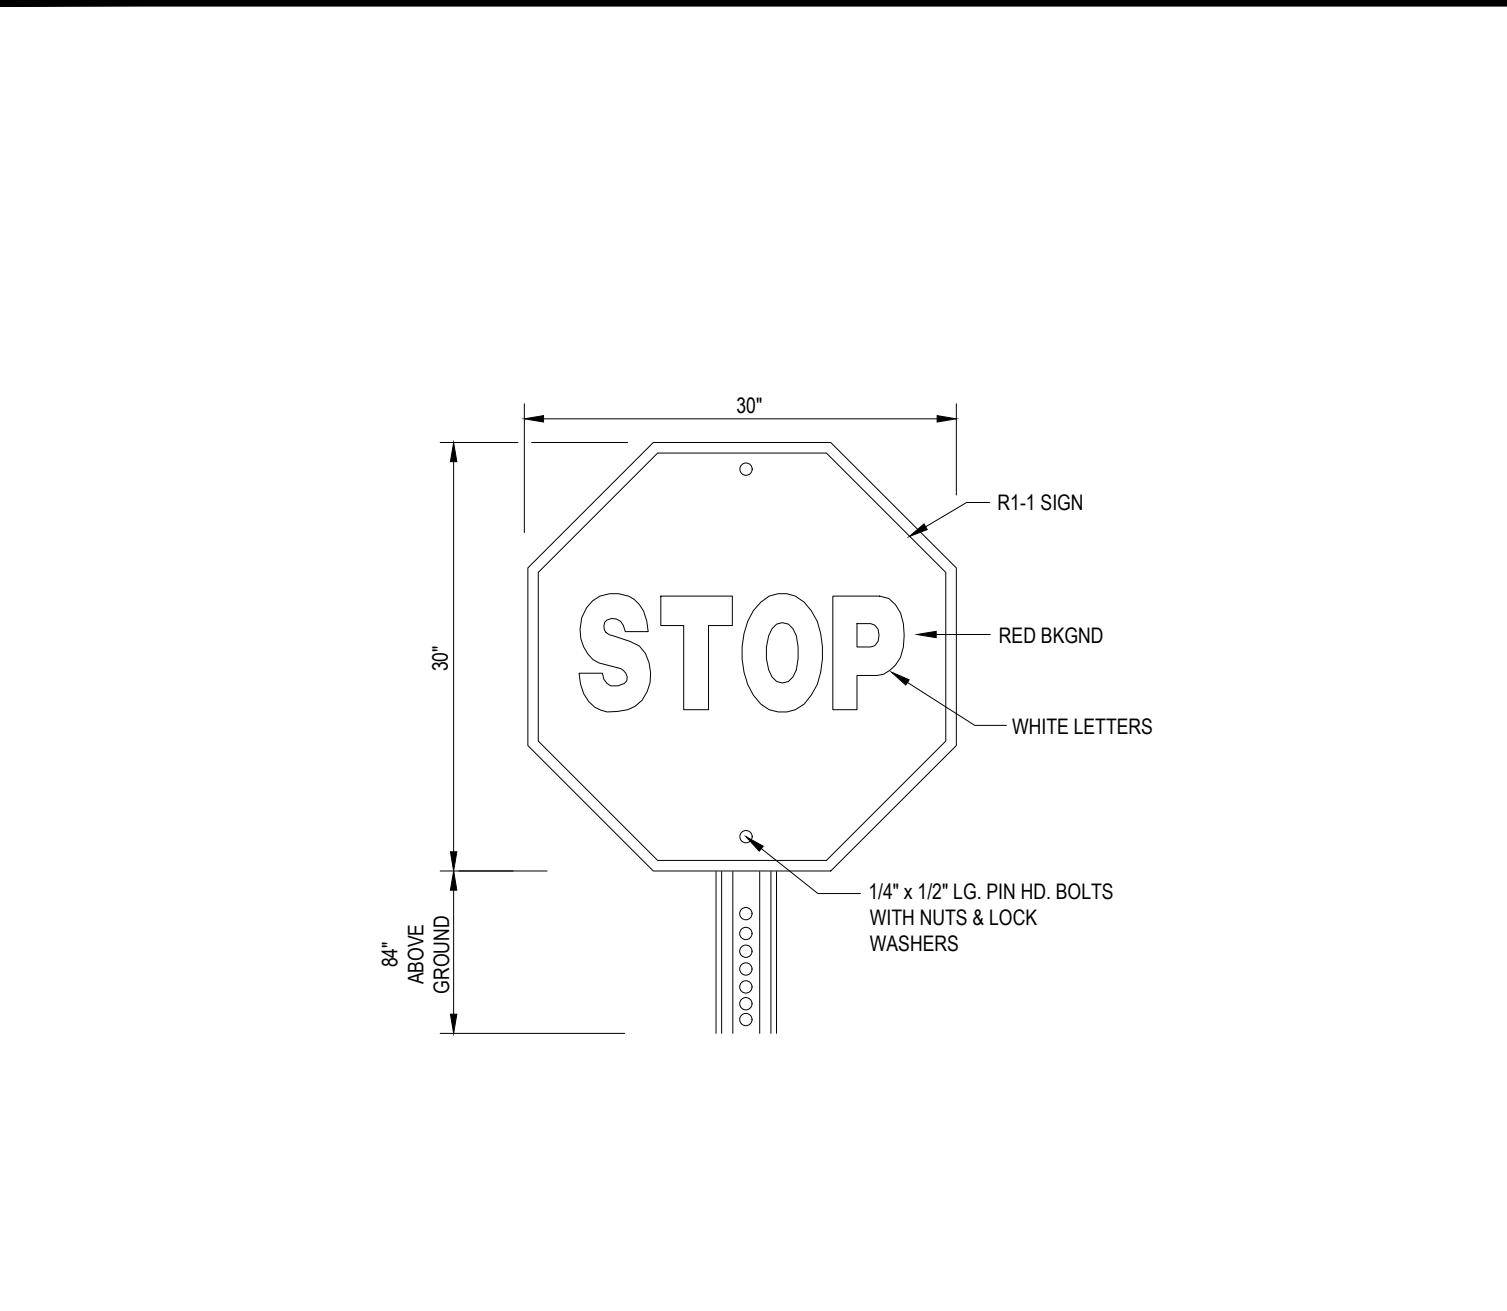


'STOP' SIGN

N.T.S.

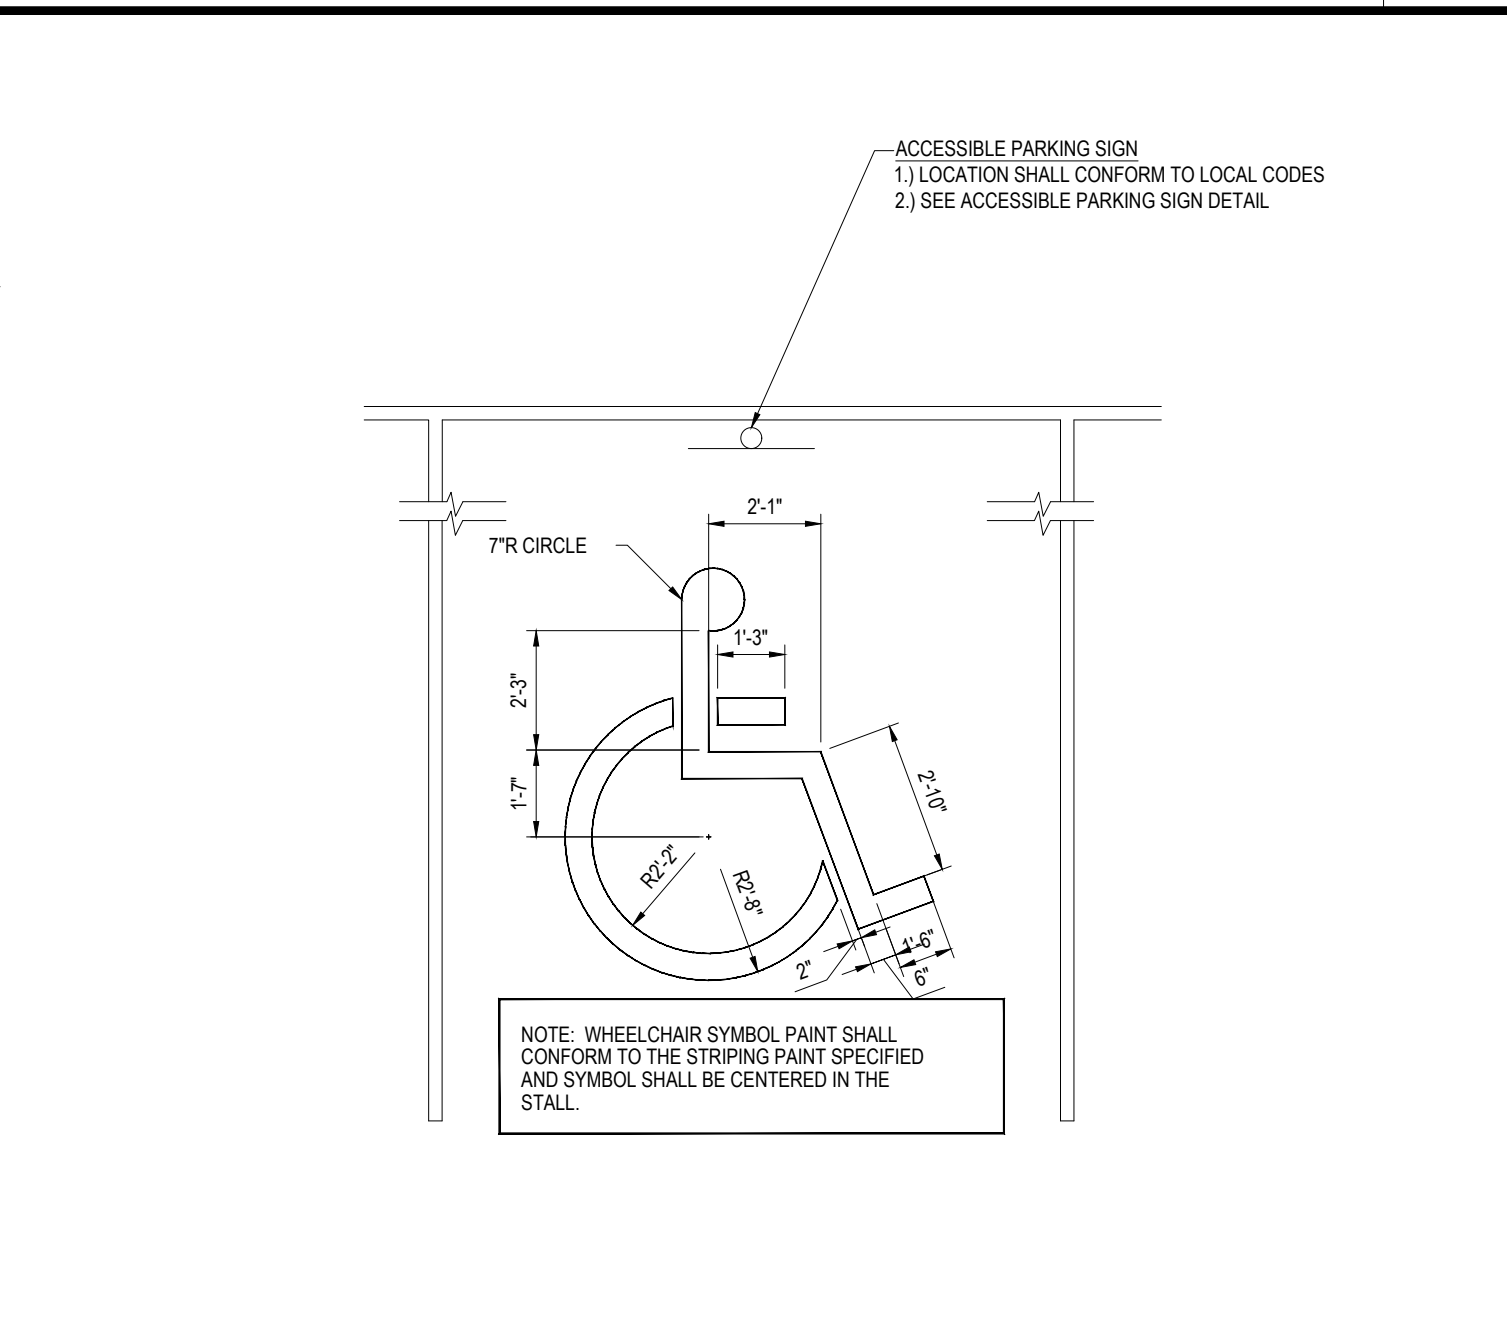


ACCESSIBLE PARKING STALL PAINTING DETAIL

N.T.S.

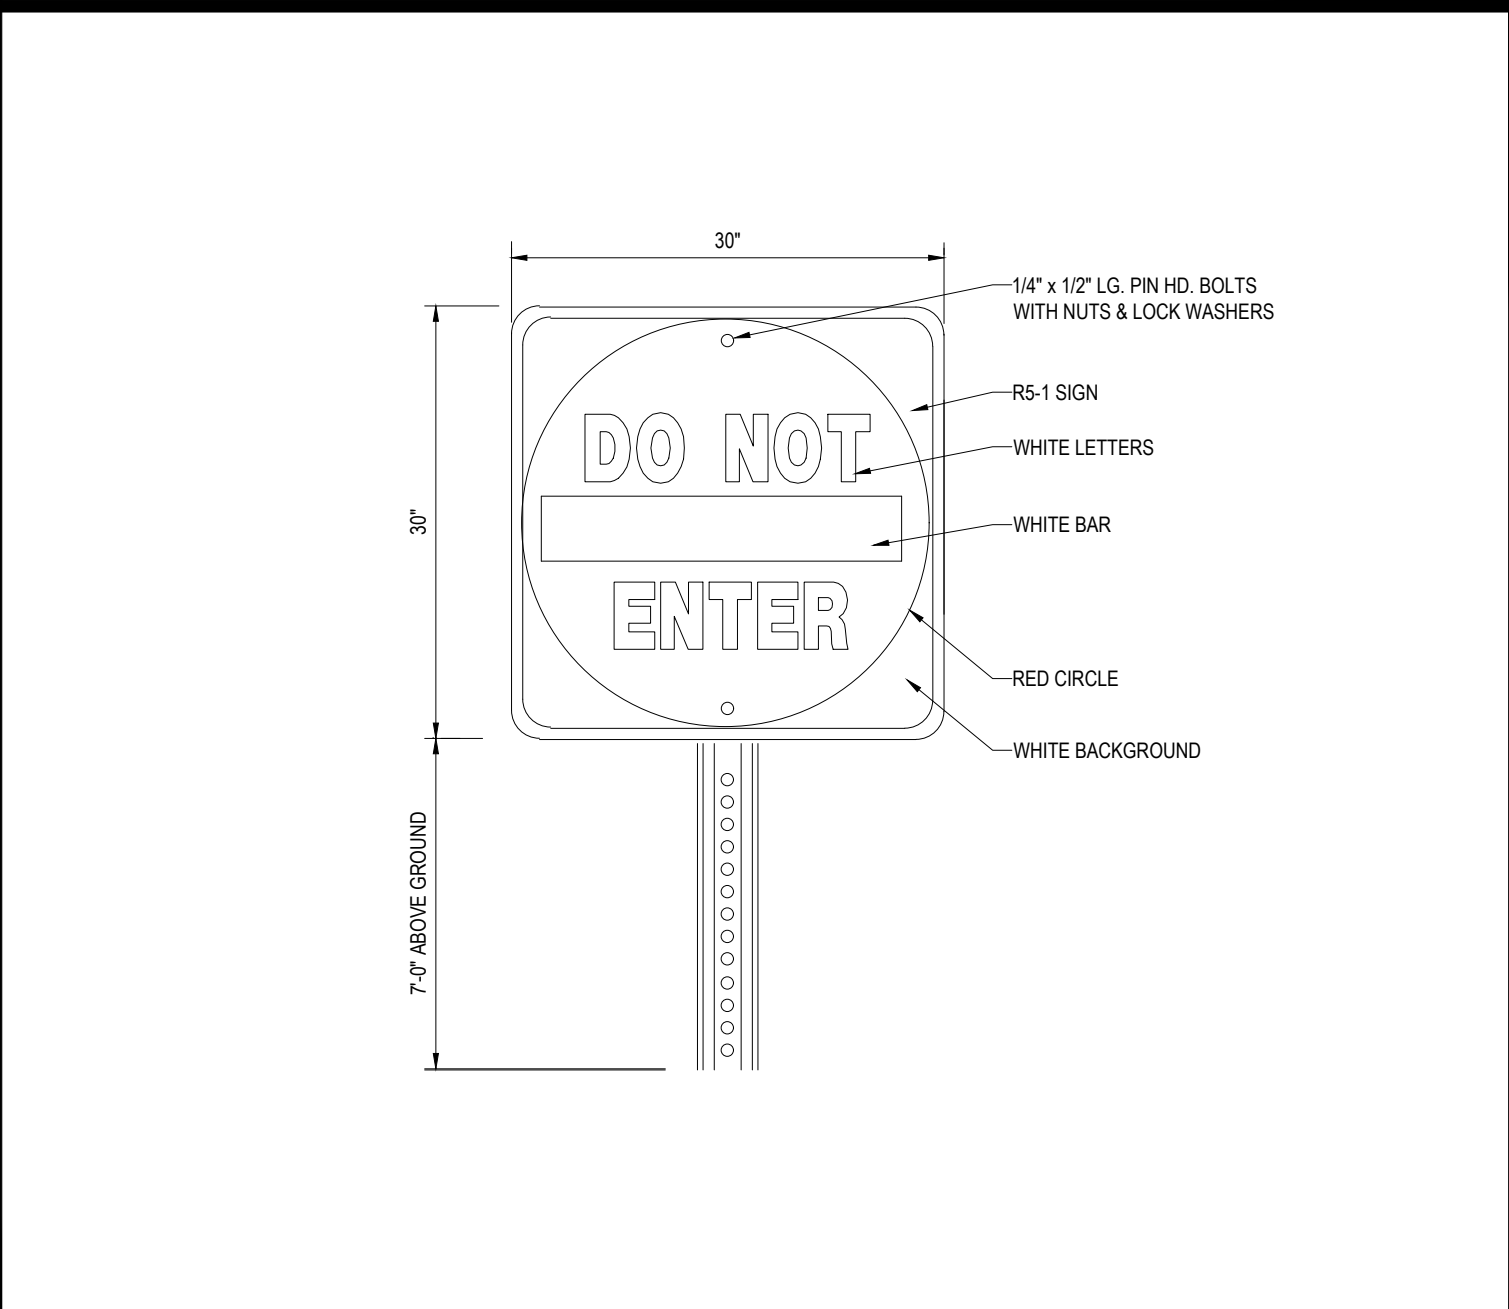


"DO NOT ENTER" SIGN

N.T.S.

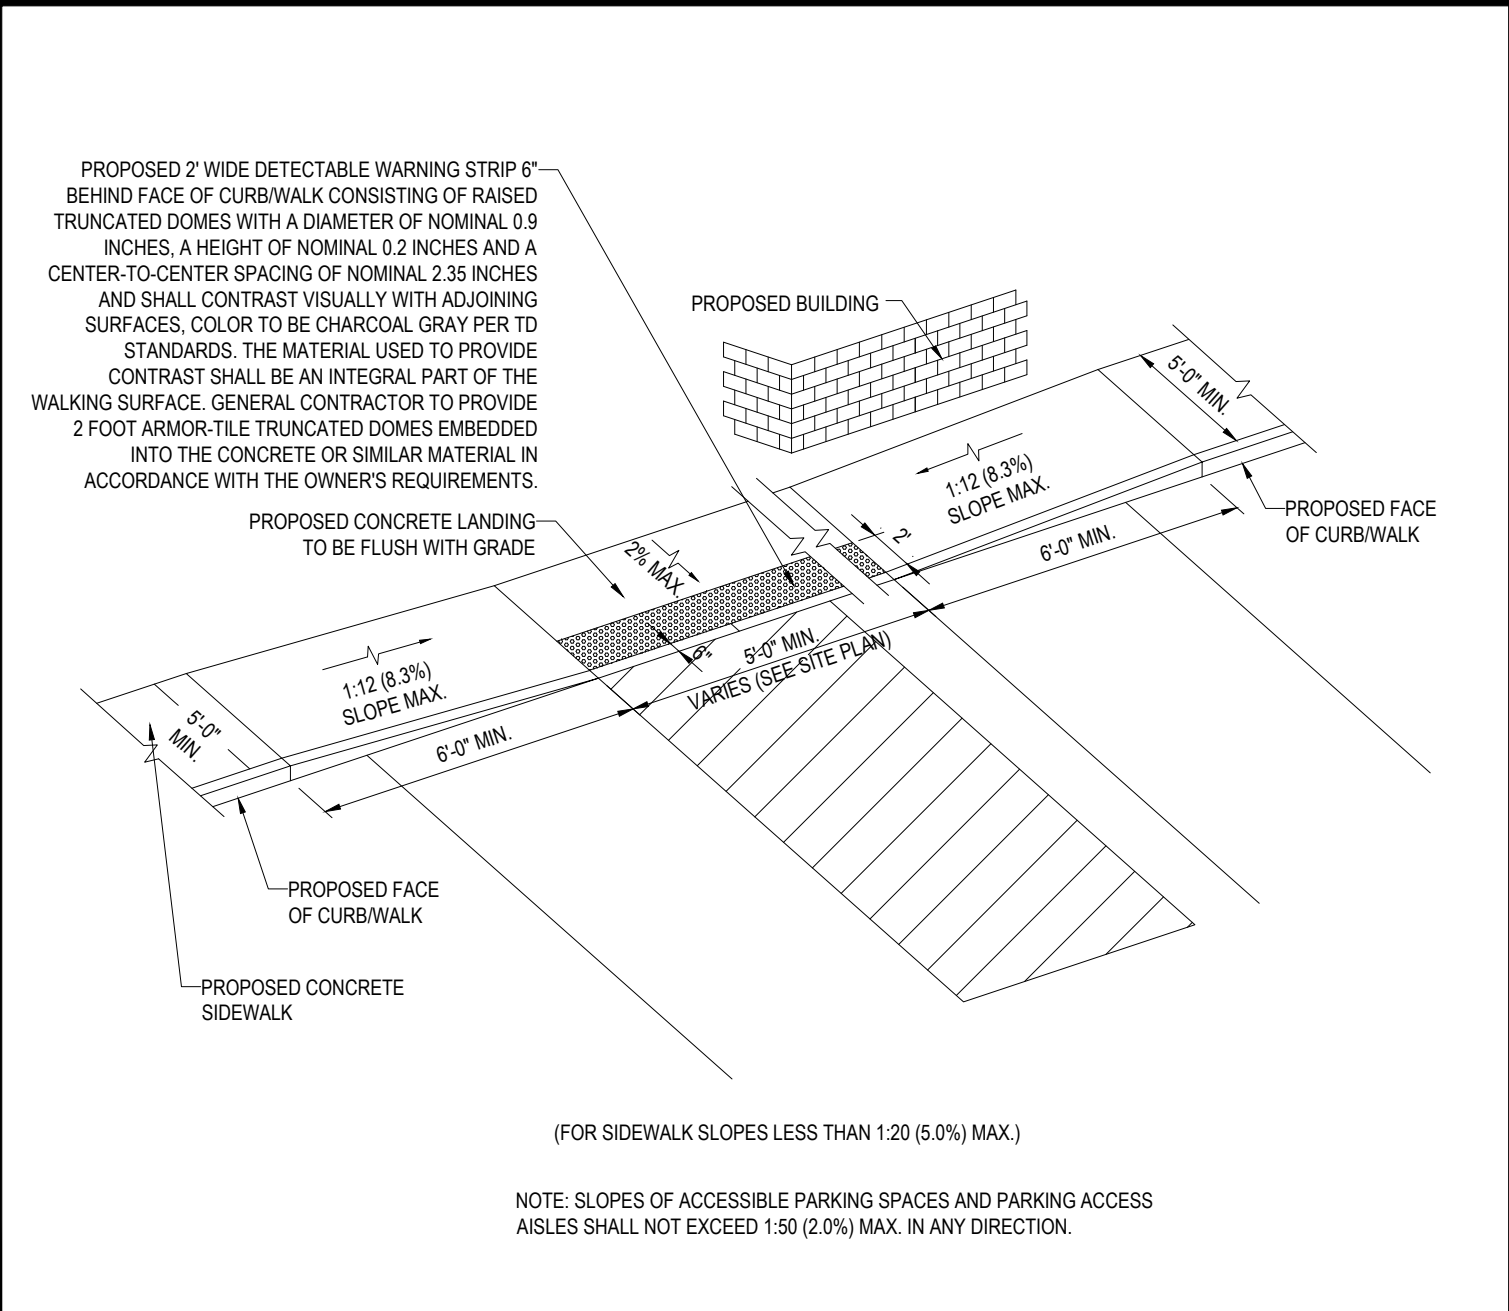

SLOPED WALK DETAIL

N.T.S.

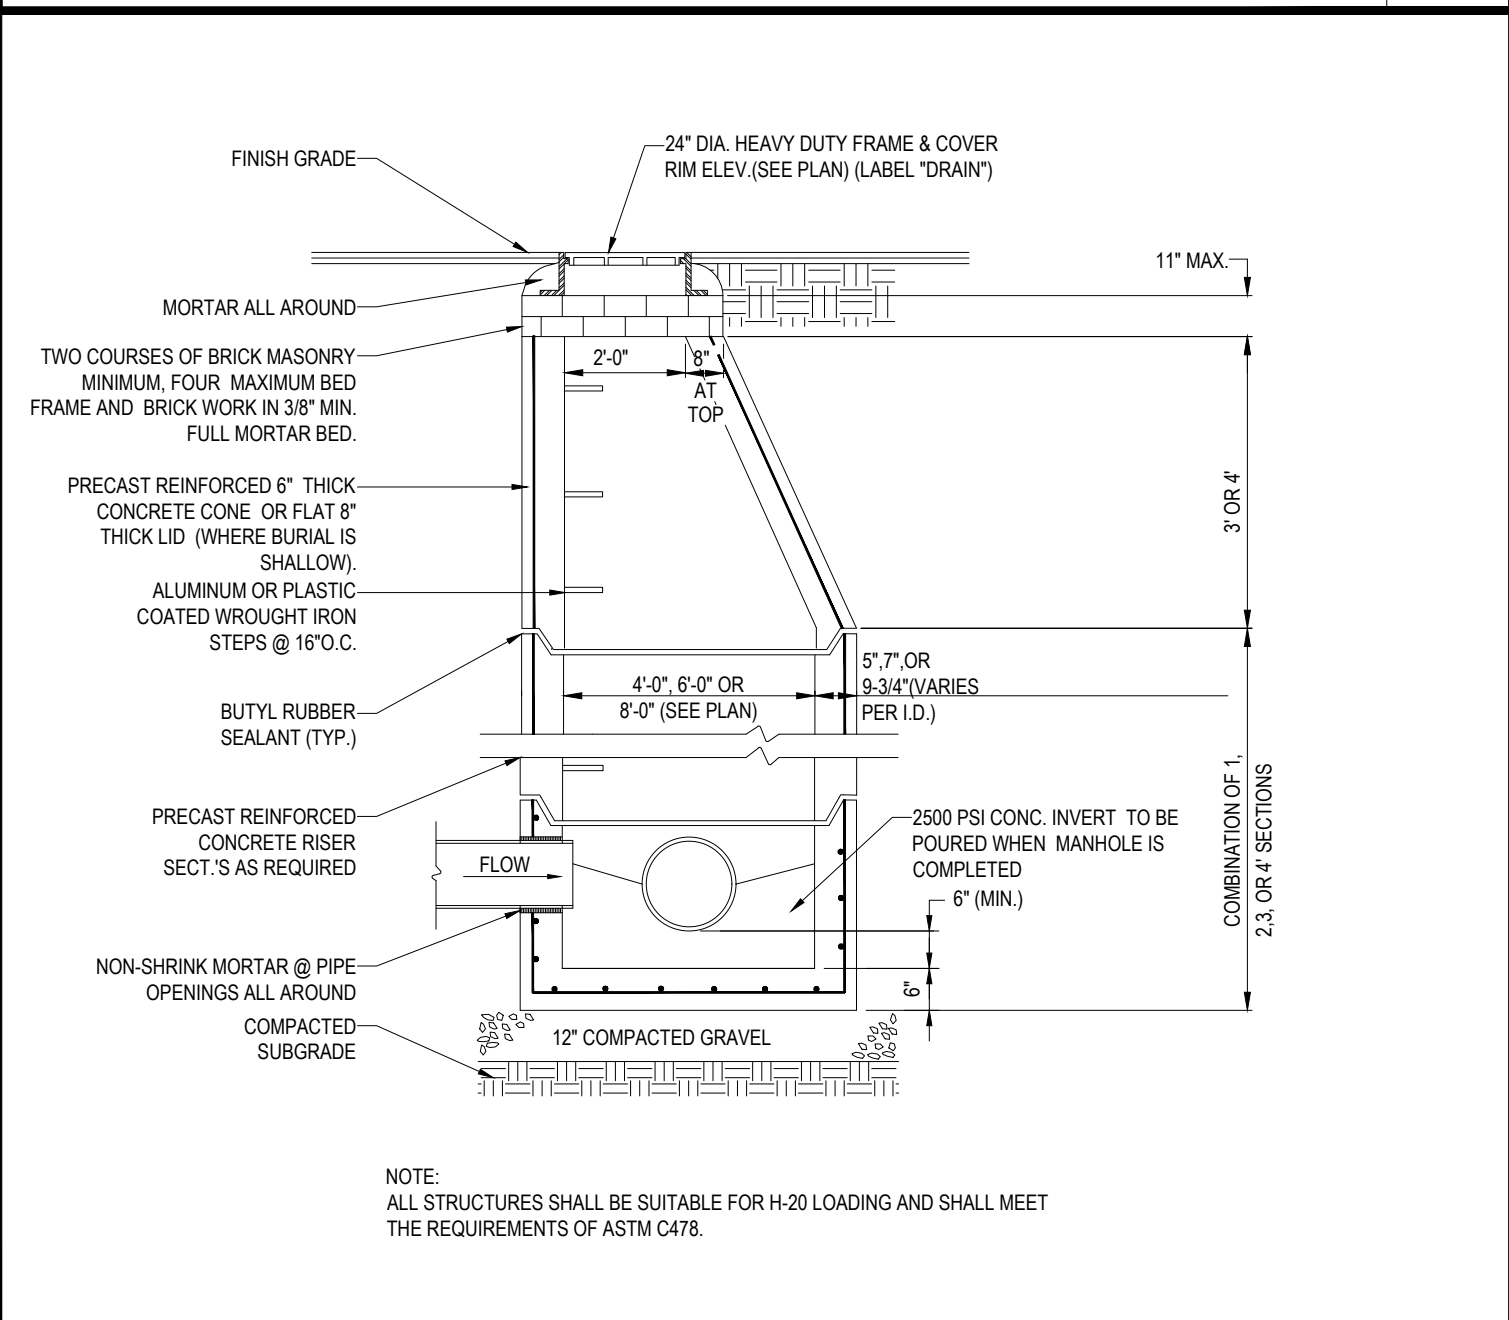

TYP. PRECAST CONCRETE MANHOLE STORM DRAIN

N.T.S.

BOHLER
ENGINEERING

1000 STATE STREET, SUITE 200
NEW HAVEN, CT 06511
TEL: (203) 539-1100
WWW.BOHLENGINEERING.COM

SITE CIVIL AND CONSULTING ENGINEERING
LAND SURVEYING DESIGN
SUSTAINABLE DESIGN
PERMITTING SERVICES
TRANSPORTATION SERVICES

- BOSTON, MA
- CHICAGO, IL
- CINCINNATI, OH
- DALLAS, TX
- DENVER, CO
- HOUSTON, TX
- KANSAS CITY, MO
- LOS ANGELES, CA
- MIAMI, FL
- MINNEAPOLIS, MN
- NEW YORK, NY
- PHILADELPHIA, PA
- PORTLAND, ME
- RICHMOND, VA
- SEATTLE, WA
- TAMPA, FL
- WASHINGTON, DC
- WICHITA, KS

REVISIONS			
REV	DATE	COMMENT	BY
1			
2			
3			
4			
5			
6			
7			
8			
9			
10			
11			
12			
13			
14			
15			

PRELIMINARY

PROJECT No.: W161042
DRAWN BY: WS/JF
CHECKED BY: JF/AD
DATE: 09/07/18
SCALE: AS NOTED
CAD I.D.: W161042SS0

PROJECT: **SITE DEVELOPMENT PLANS FOR CONNECTICUT HEALTH CARE HOLDINGS LLC**

NEW HAVEN, CT
MAP #339, BLOCK #190, LOT #17
240 WINTHROP AVENUE
CITY OF NEW HAVEN
NEW HAVEN COUNTY, CONNECTICUT

BOHLER
ENGINEERING

352 TURNPIKE ROAD
SOUTHBOROUGH, MA 01772
Phone: (508) 480-9900
Fax: (508) 480-9900
www.BohlerEngineering.com


J.G. SWERLING

PROFESSIONAL ENGINEER
MASSACHUSETTS LICENSE No. 41699
NEW HAMPSHIRE LICENSE No. 14699
MAINE LICENSE No. 13816
CONNECTICUT LICENSE No. 30786
RHODE ISLAND LICENSE No. 1425

SHEET TITLE:
CONSTRUCTION DETAIL SHEET

SHEET NUMBER:
12
OF 14

REV 0 - 09/07/2018

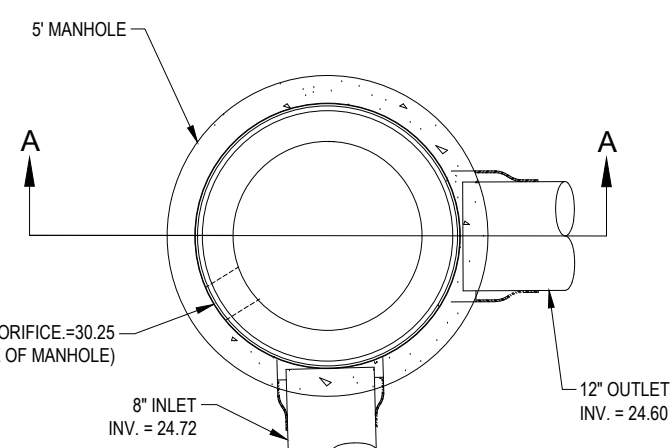

N.T.S



N.T.S.




N.T.S

- | SIEVE SIZE | PERCENT PASSING |
|--------------|-----------------|
| 2 INCH | 100 |
| 3/4" | 70-100 |
| 1/4" | 50-80 |
| U.S. NO. 40 | 15-30 |
| U.S. NO. 100 | 0-5 |
| U.S. NO. 200 | 0-3 |

REV	DATE	COMMENT	B
1			
2			
3			
4			
5			
6			
7			
8			
9			
10			
11			
12			
13			
14			
15			

PROJECT No.:	W16104
DRAWN BY:	WS/LJ
CHECKED BY:	JF/A
DATE:	09/07/1
SCALE:	AS NOTE
CAD I.D.:	W161042SS

NEW HAVEN, CT
MAP #339, BLOCK #190, LOT #17
240 WINTHROP AVENUE
CITY OF NEW HAVEN
NEW HAVEN COUNTY,
CONNECTICUT

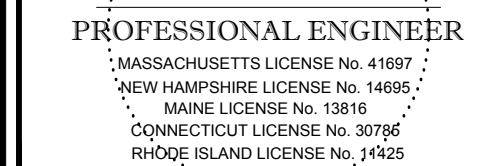


SHEET NUMBER

REV 0 - 09/07/2018



N.T.S

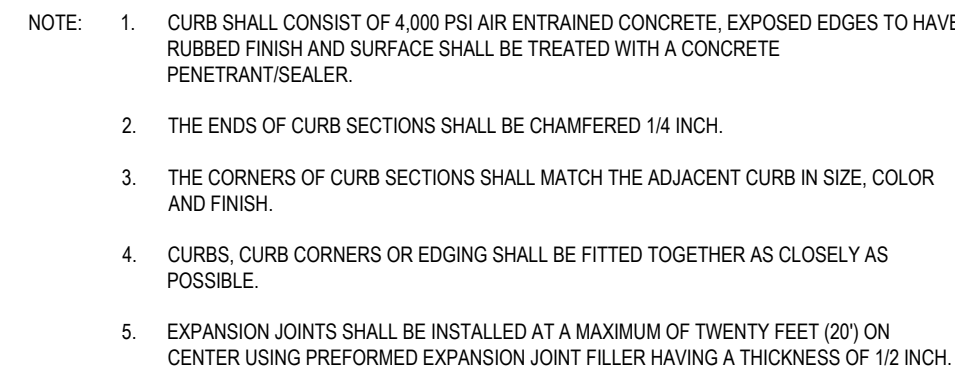

N.T.S.



 
N.T.S.



N.T.S.




N.T.S














N.T.S.



N.T.S.

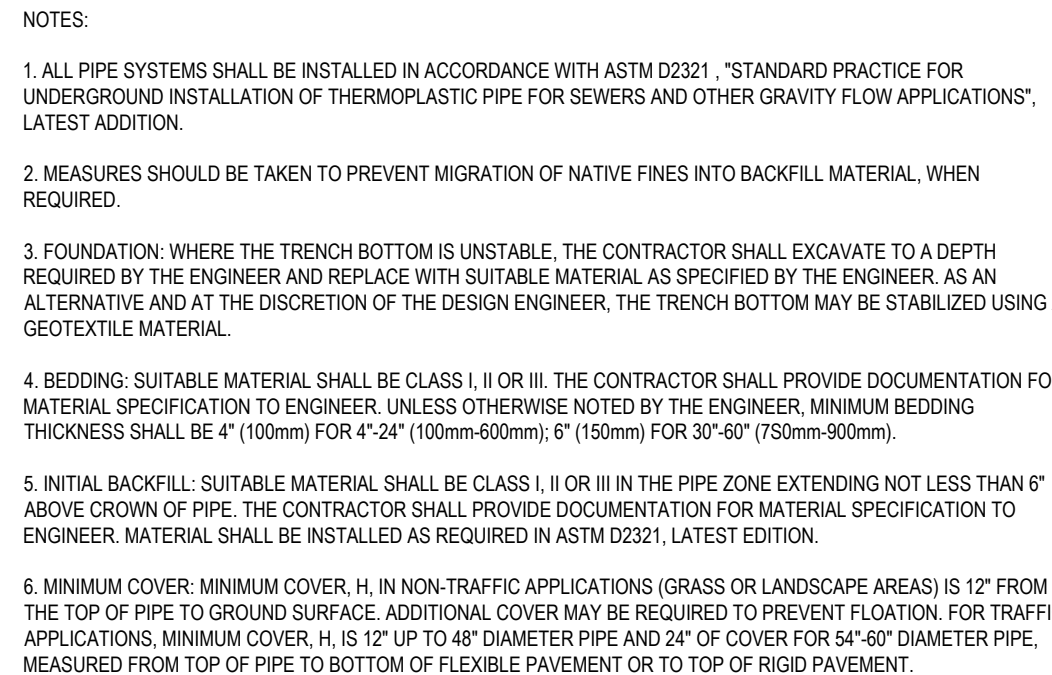

N.T.S

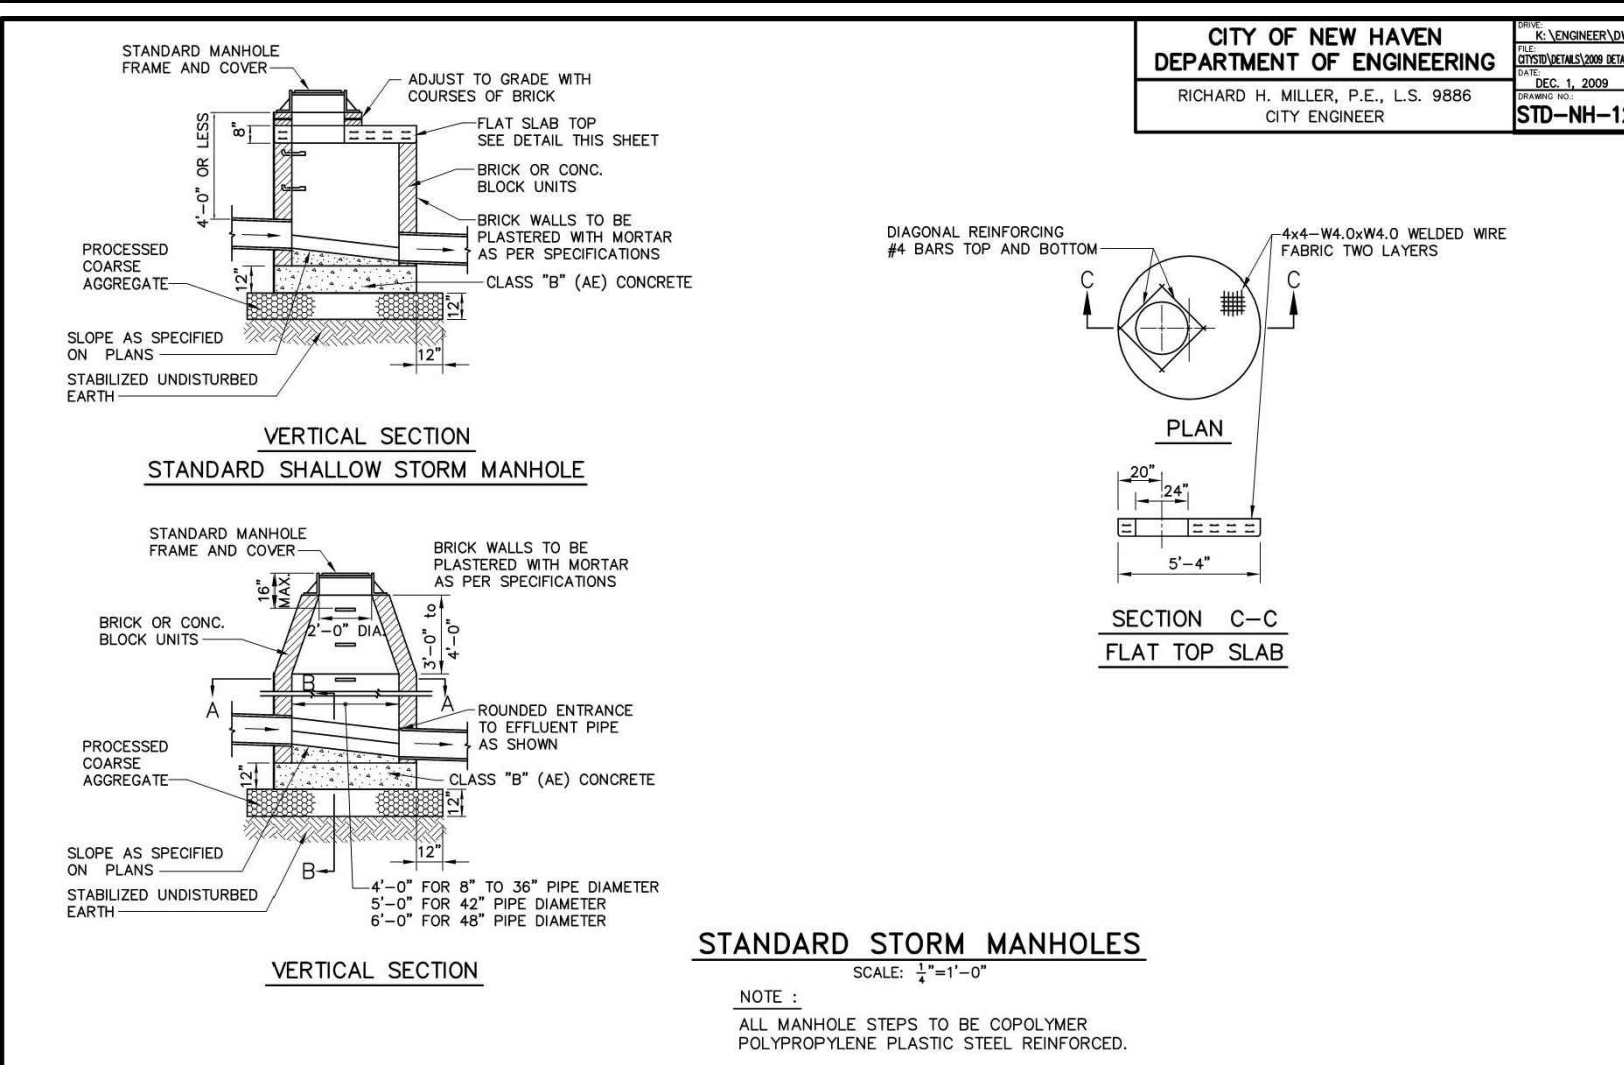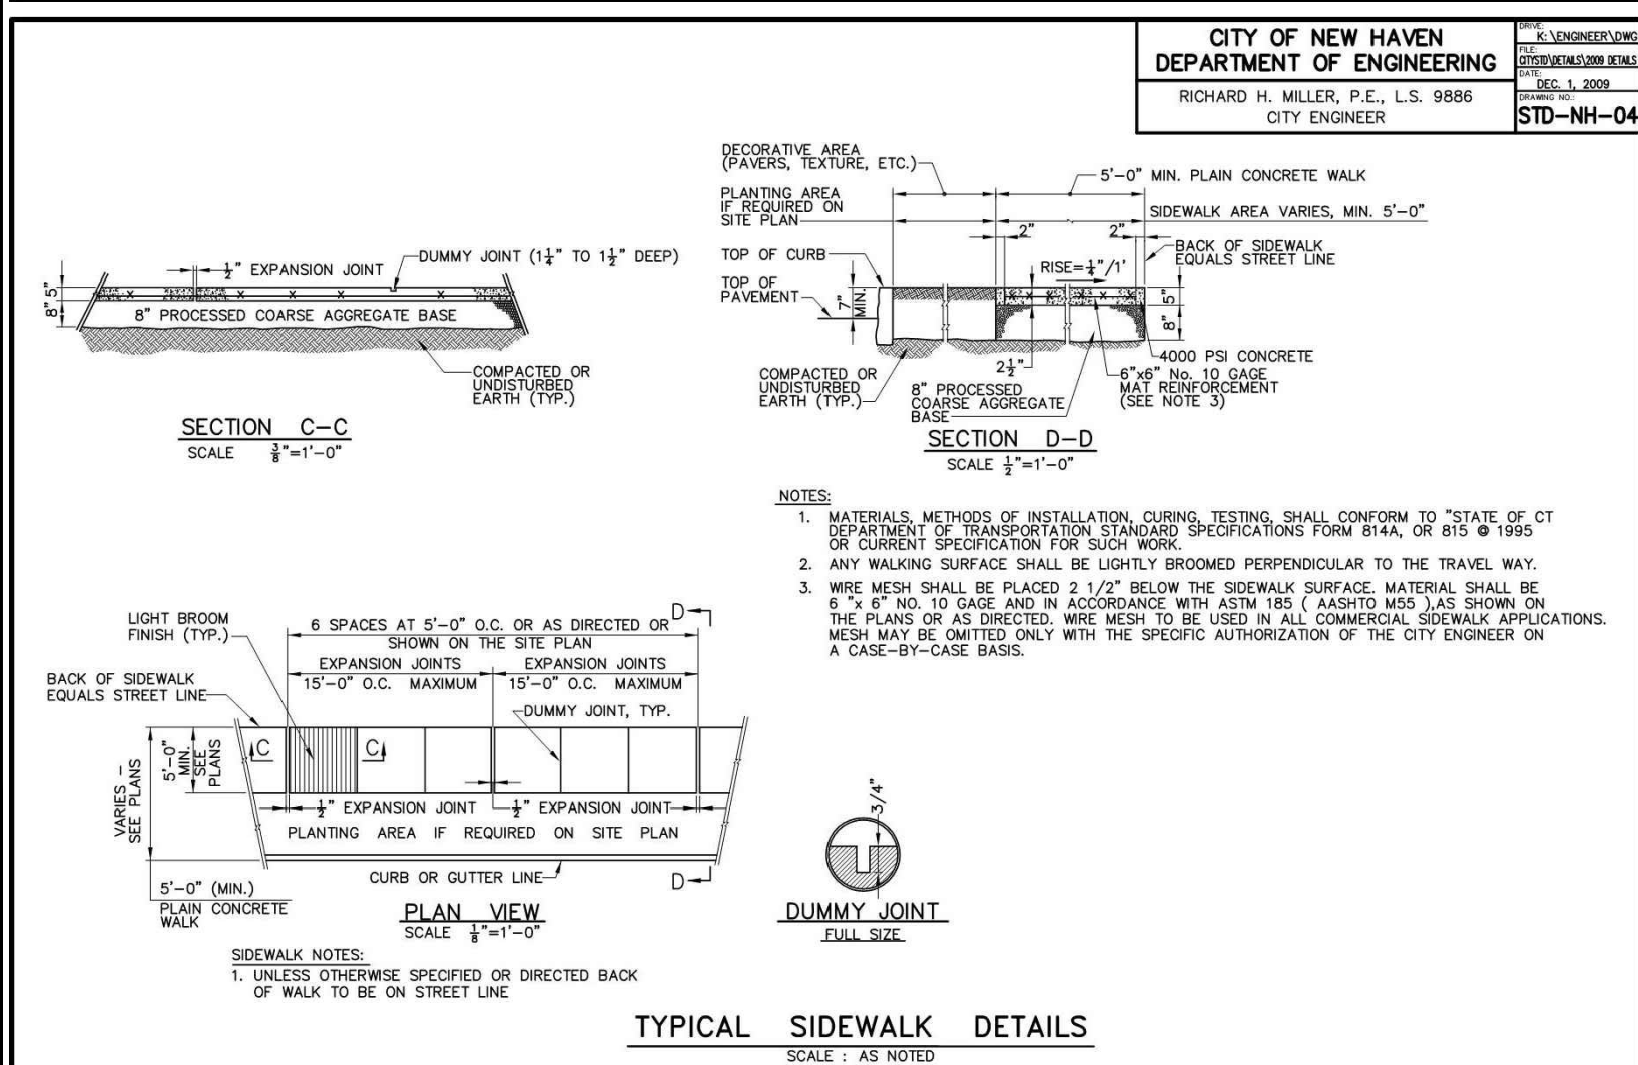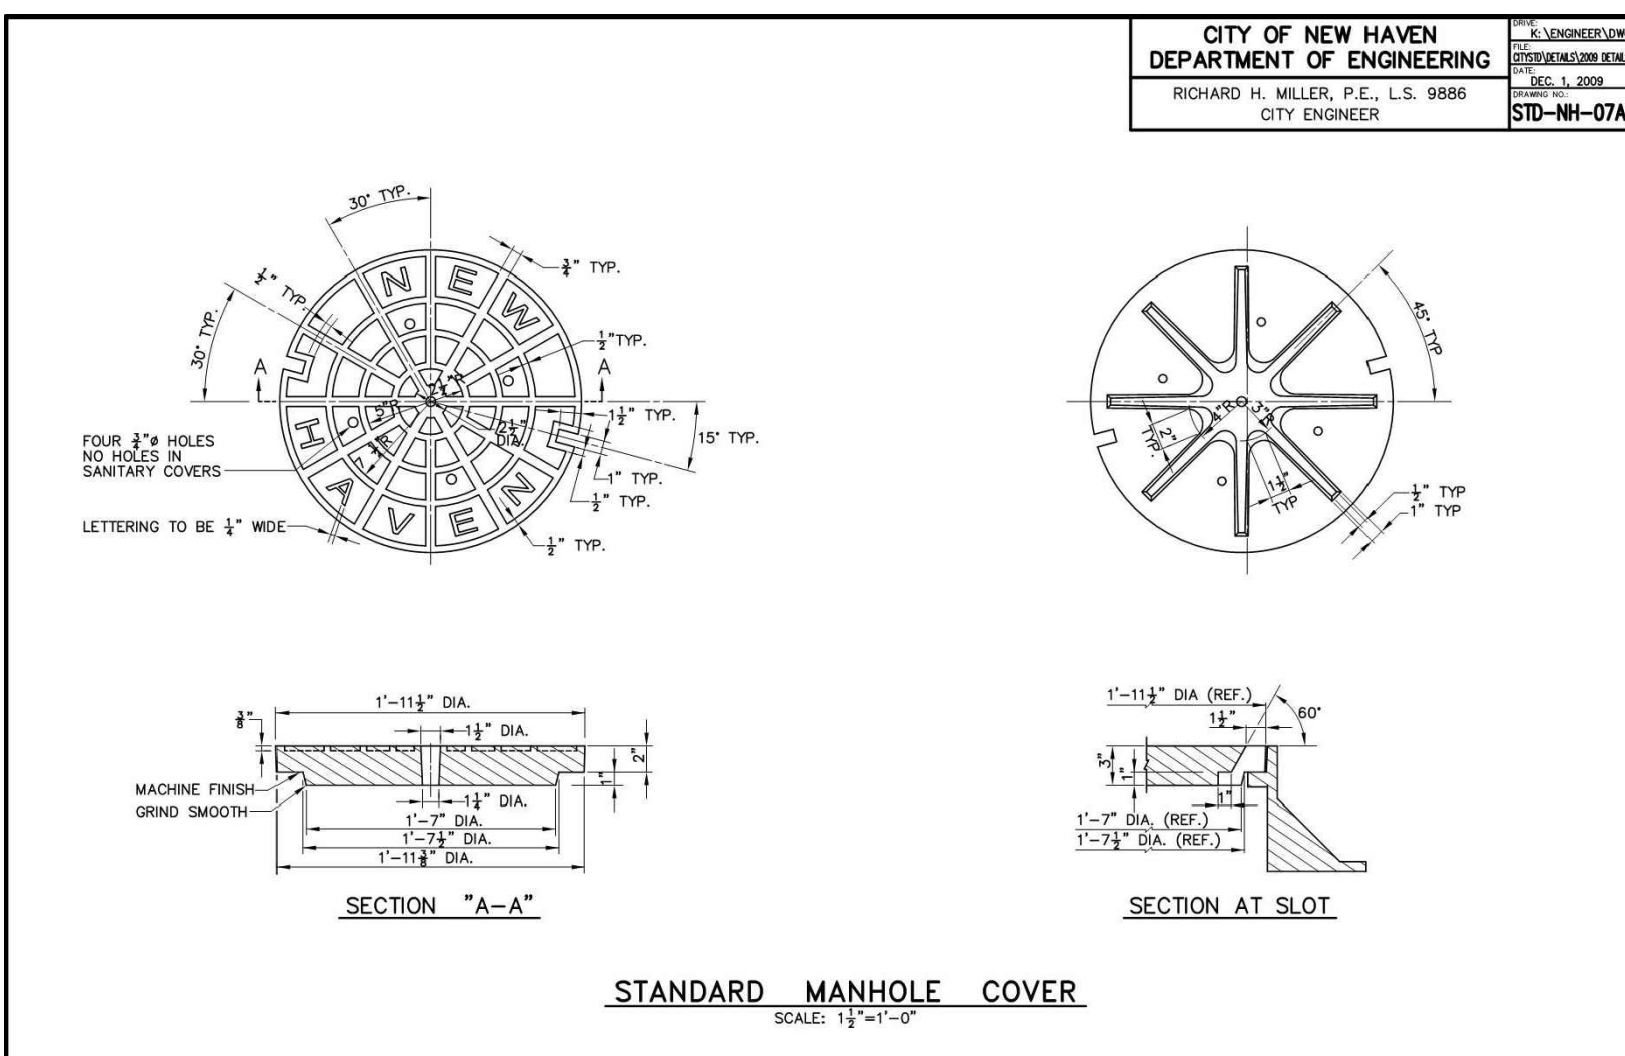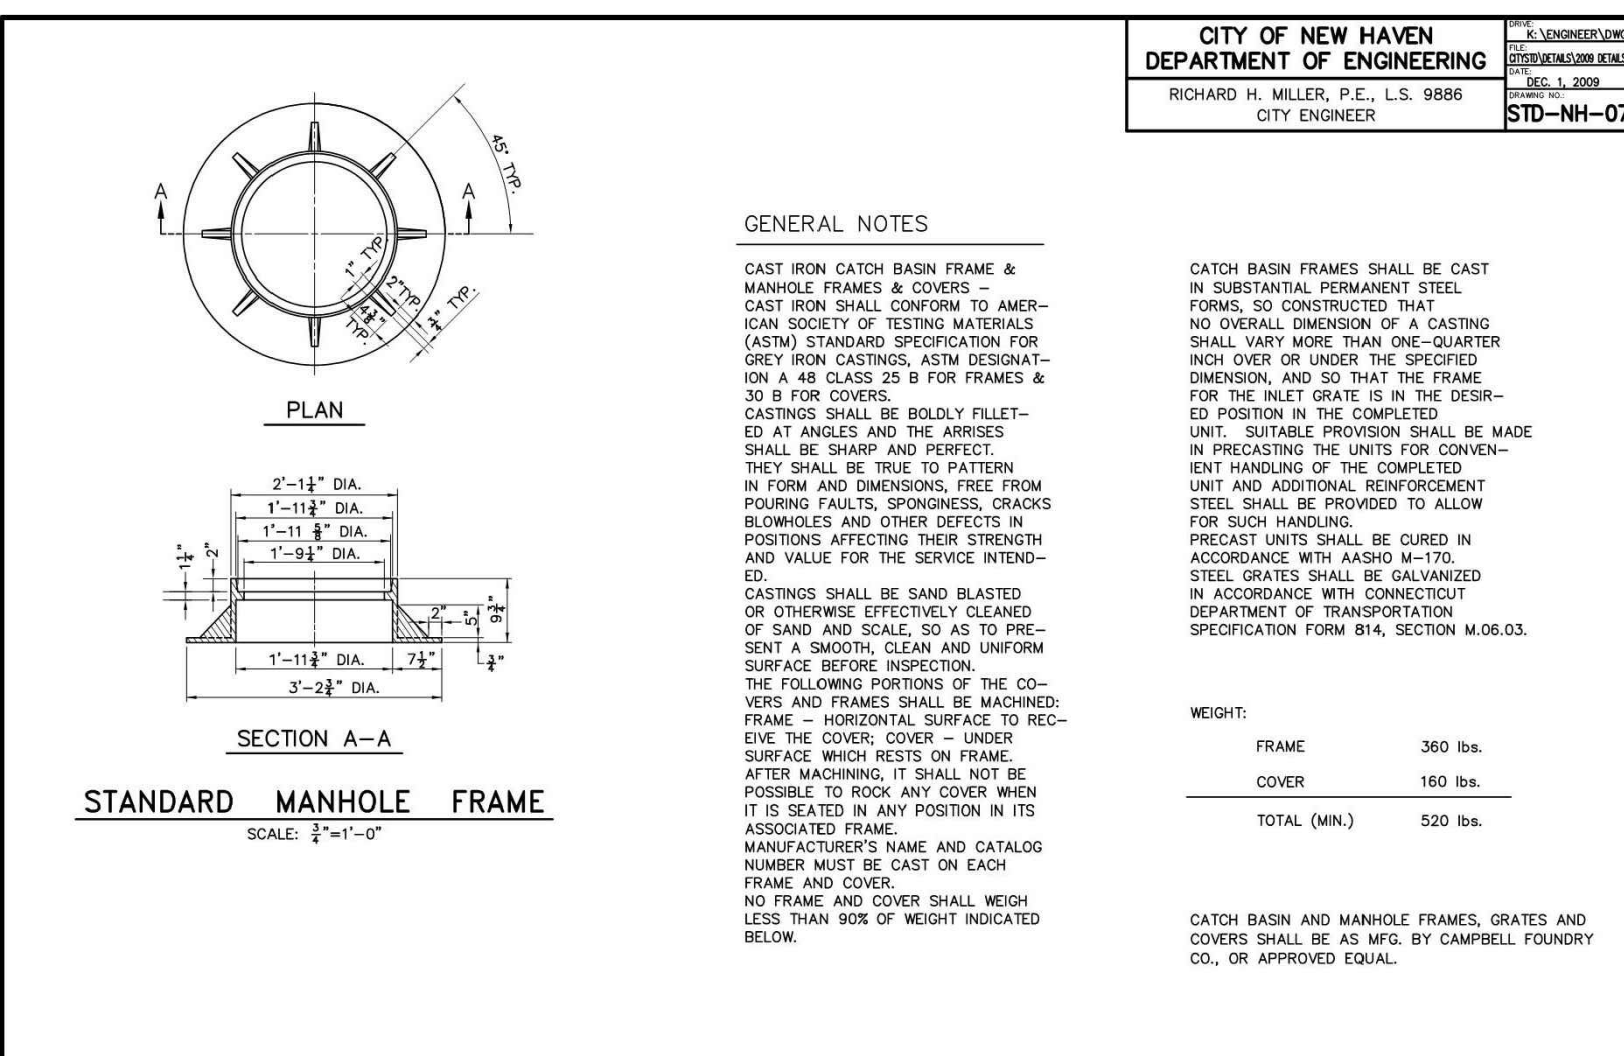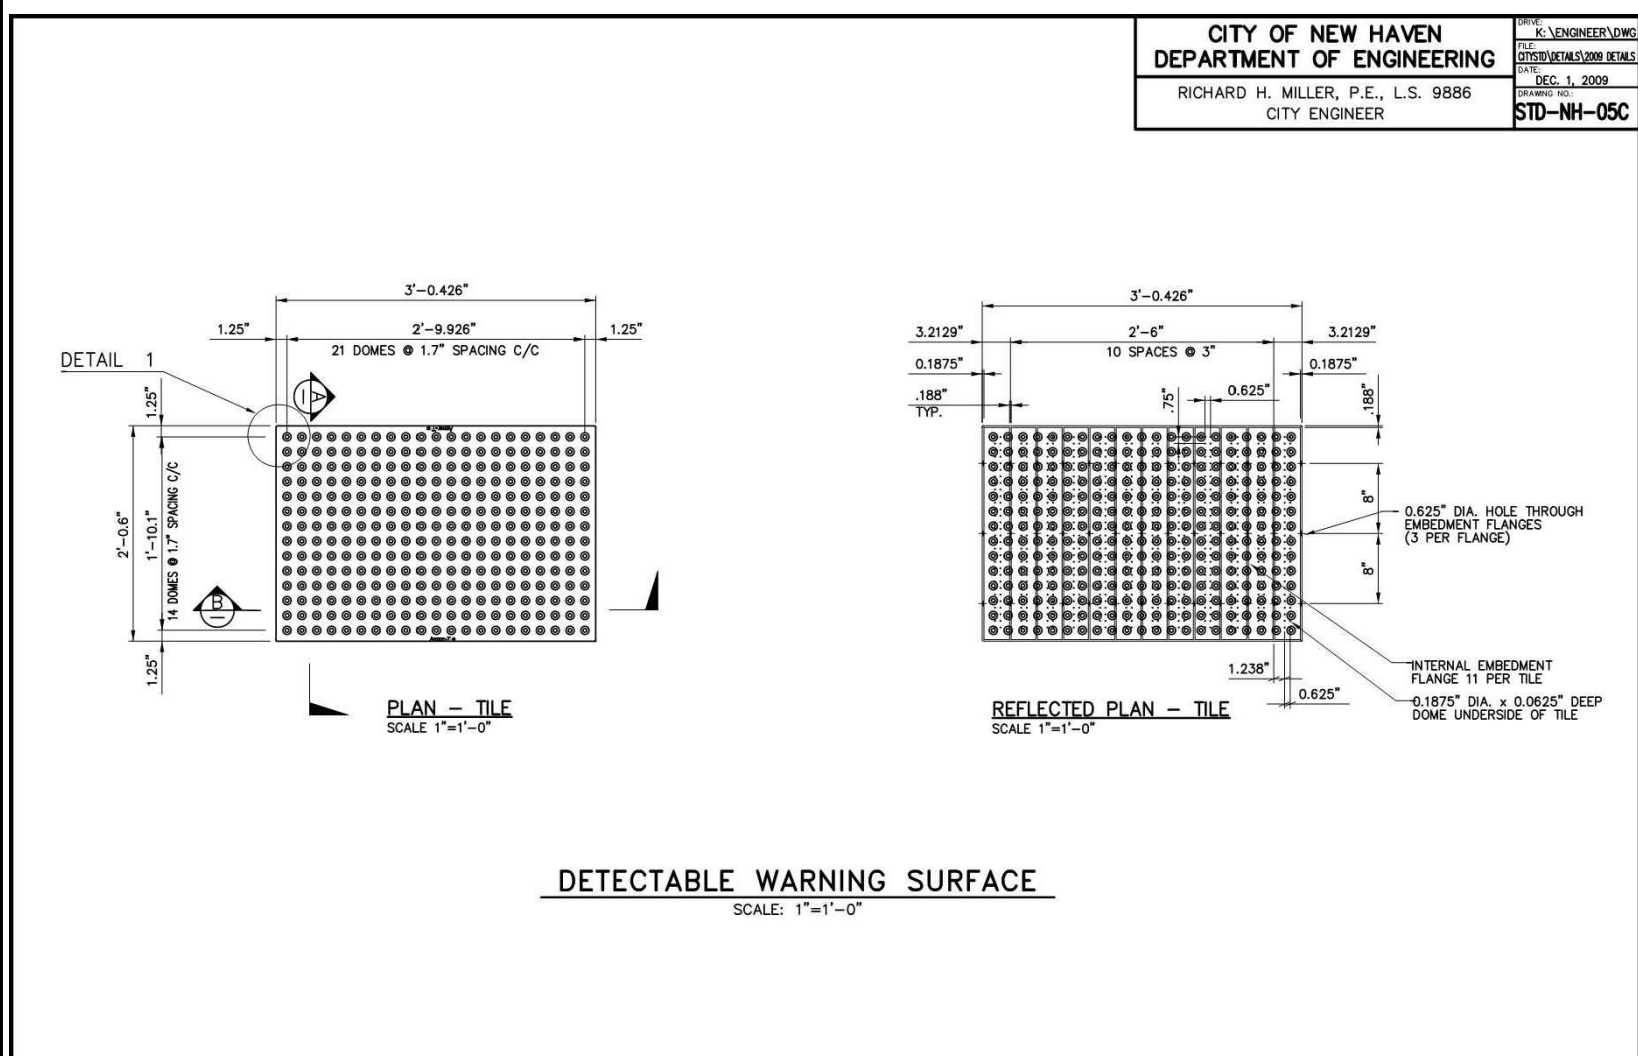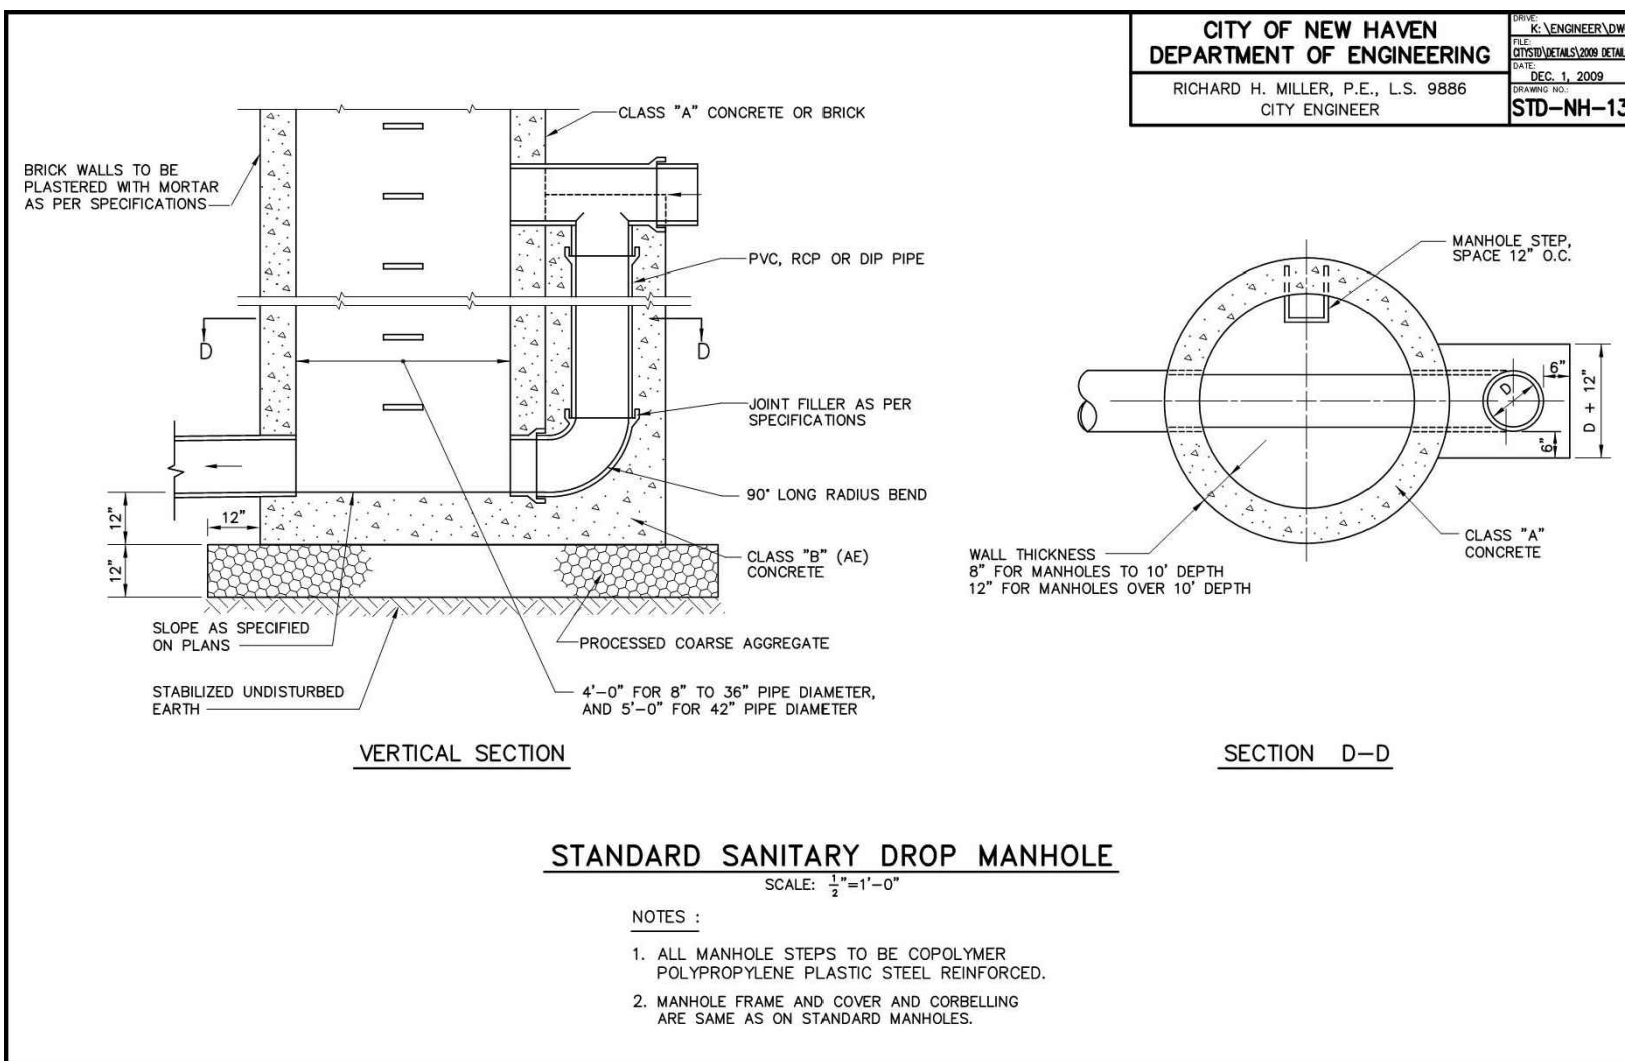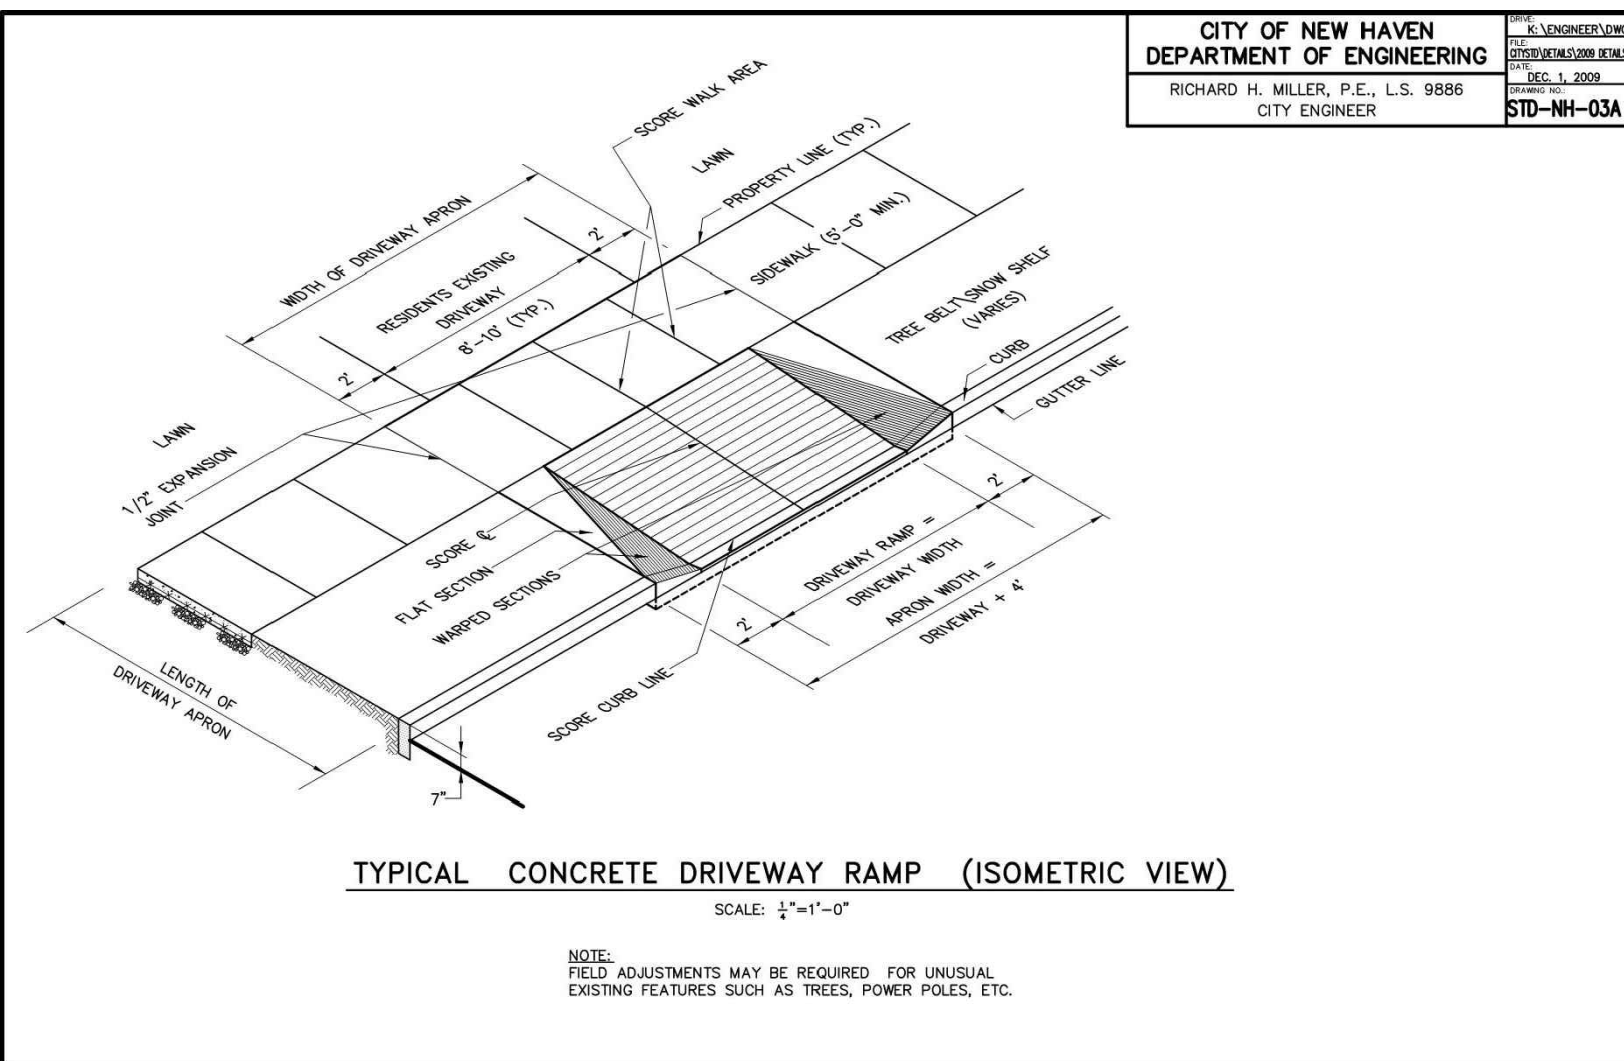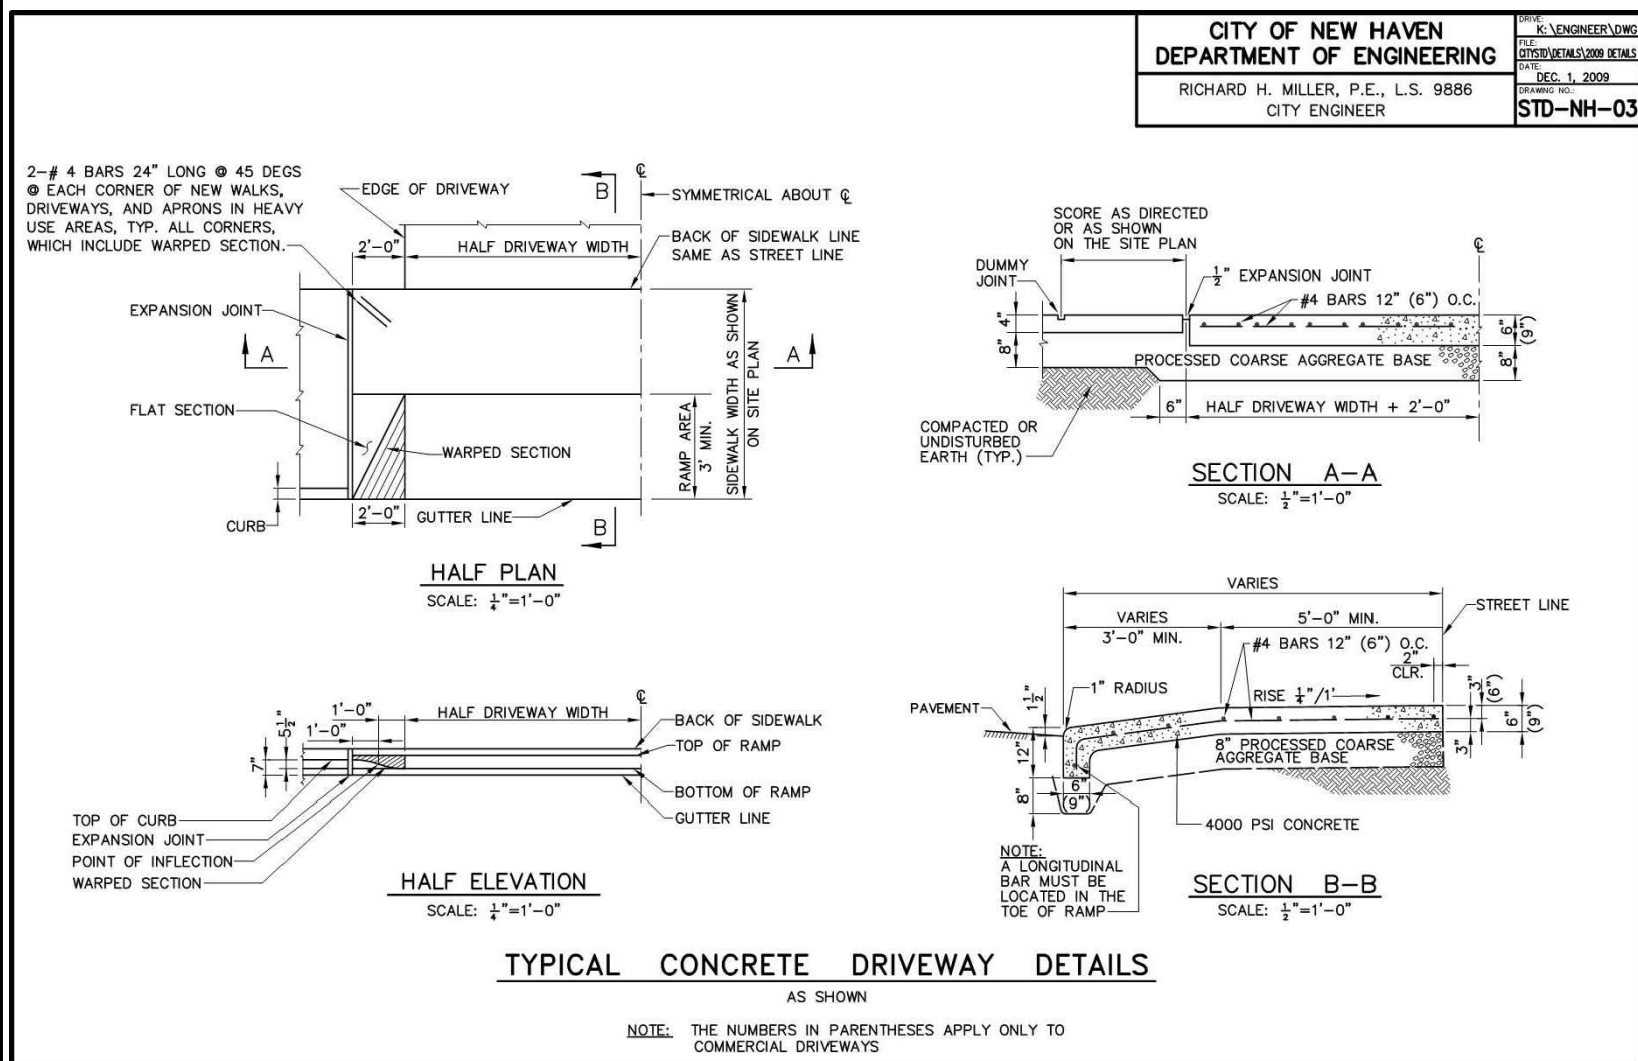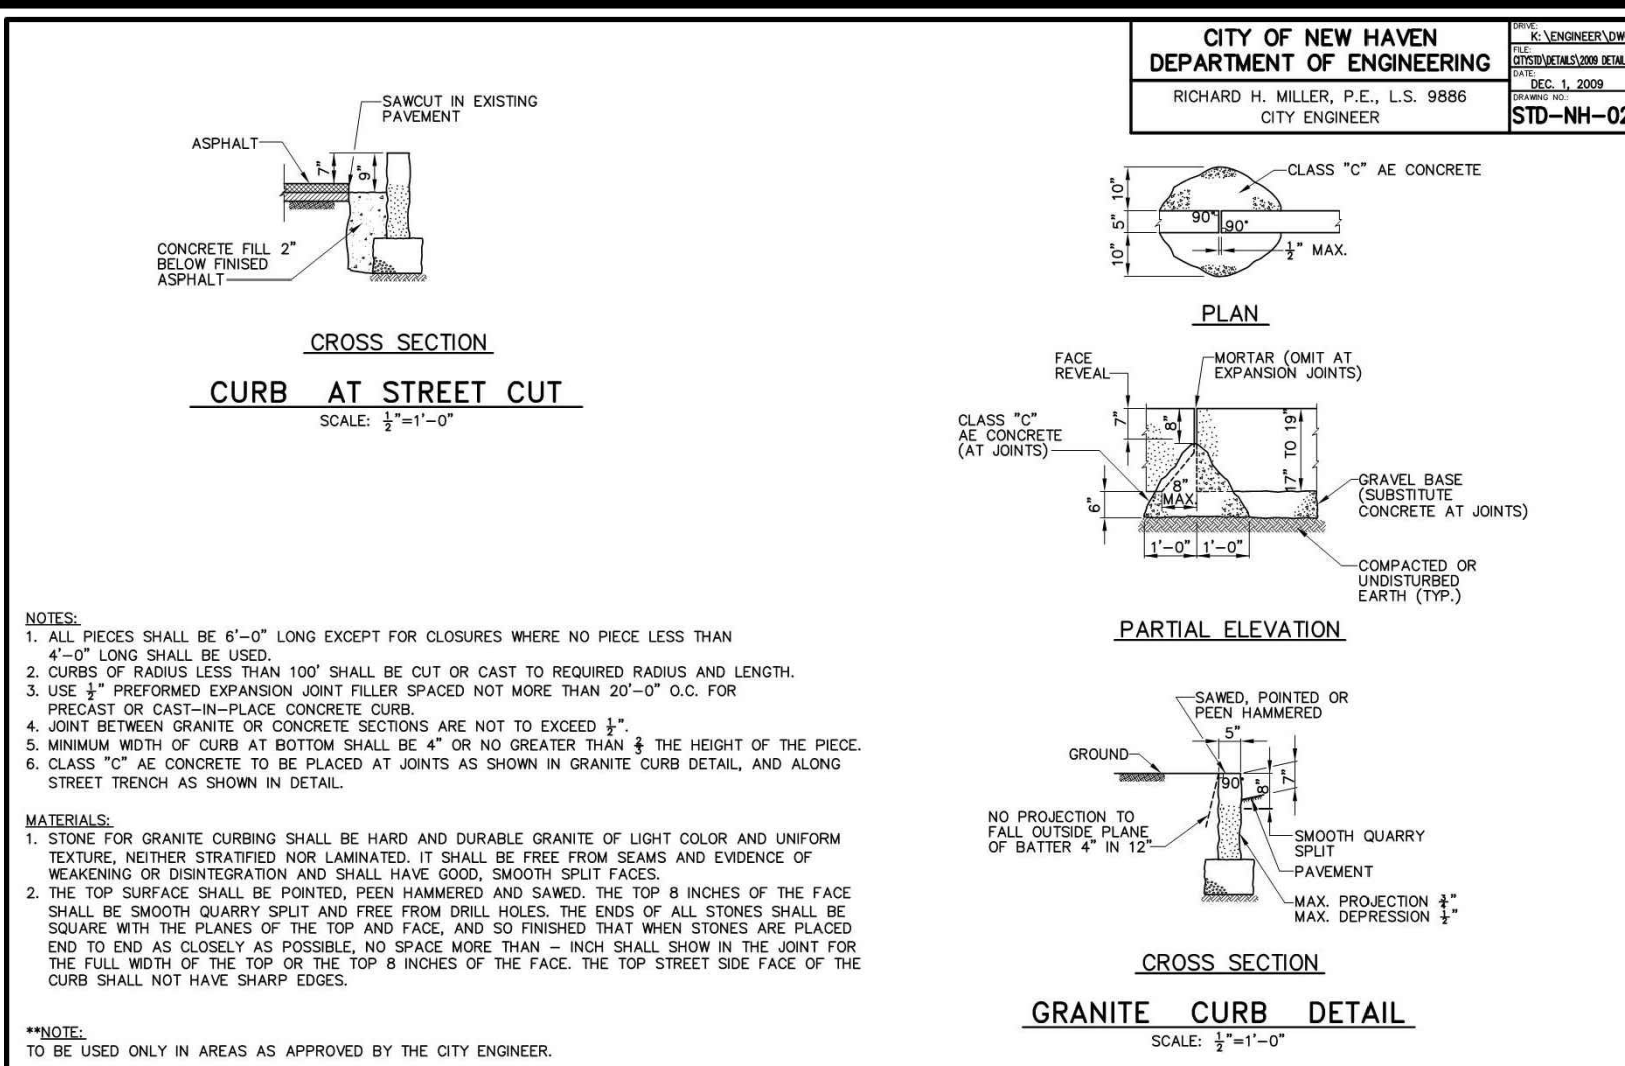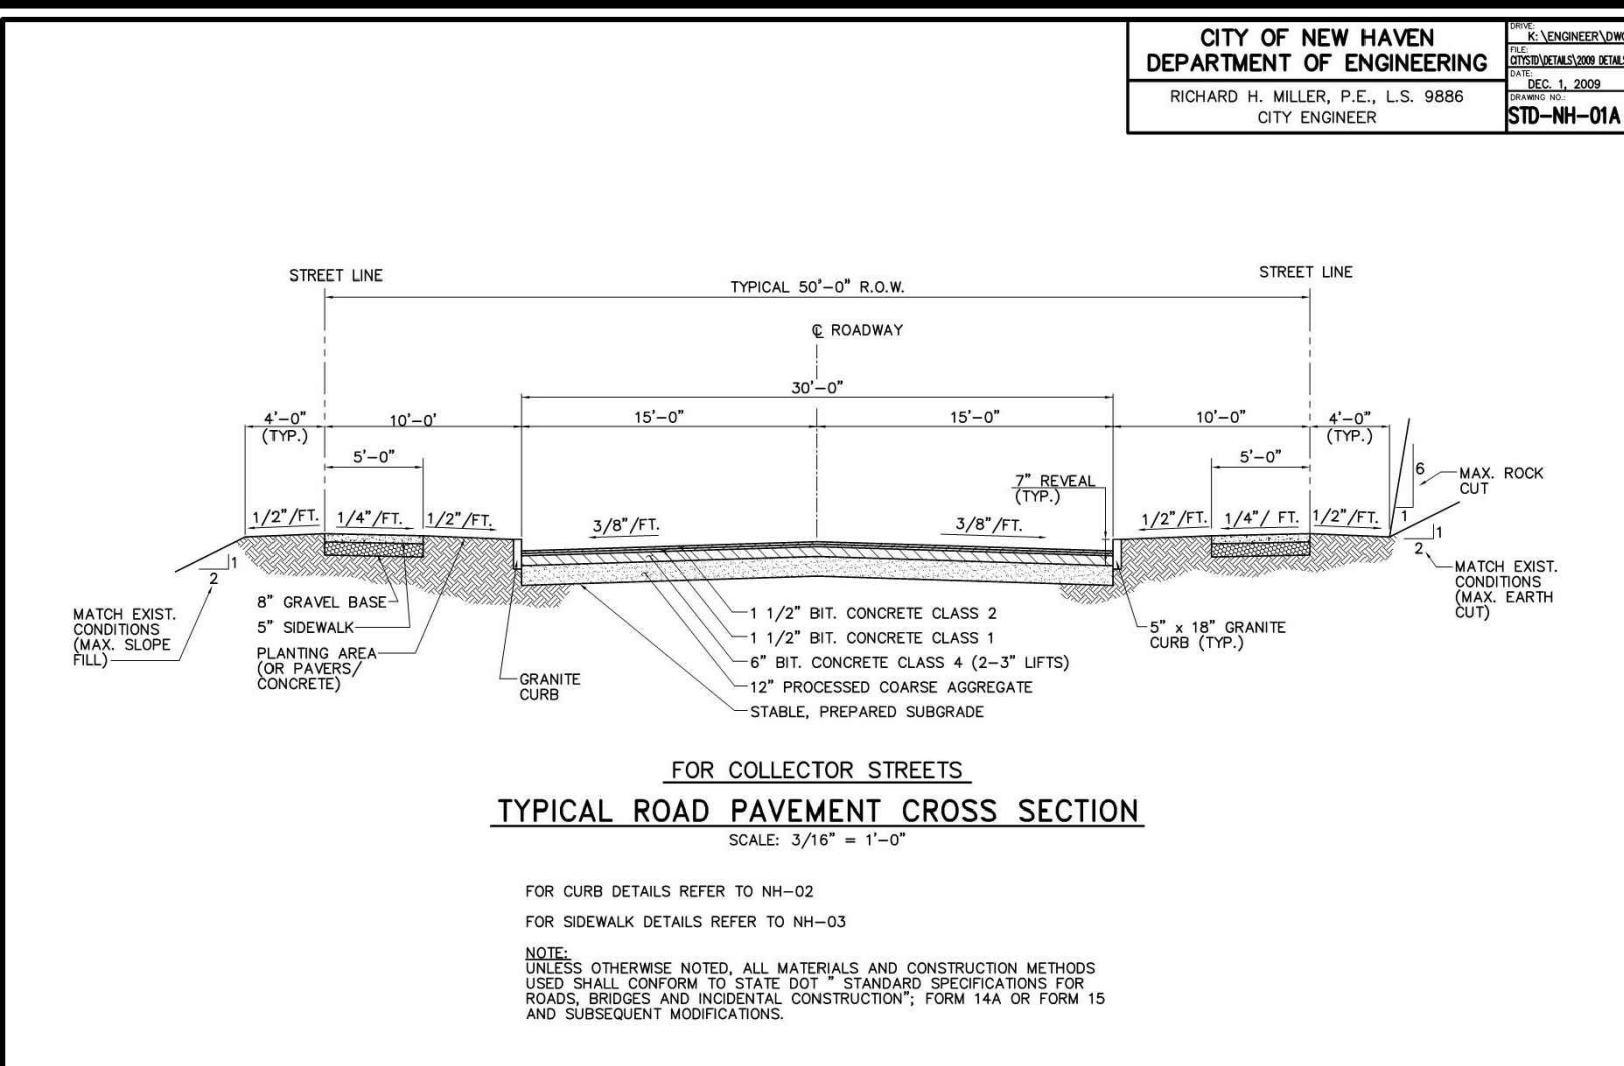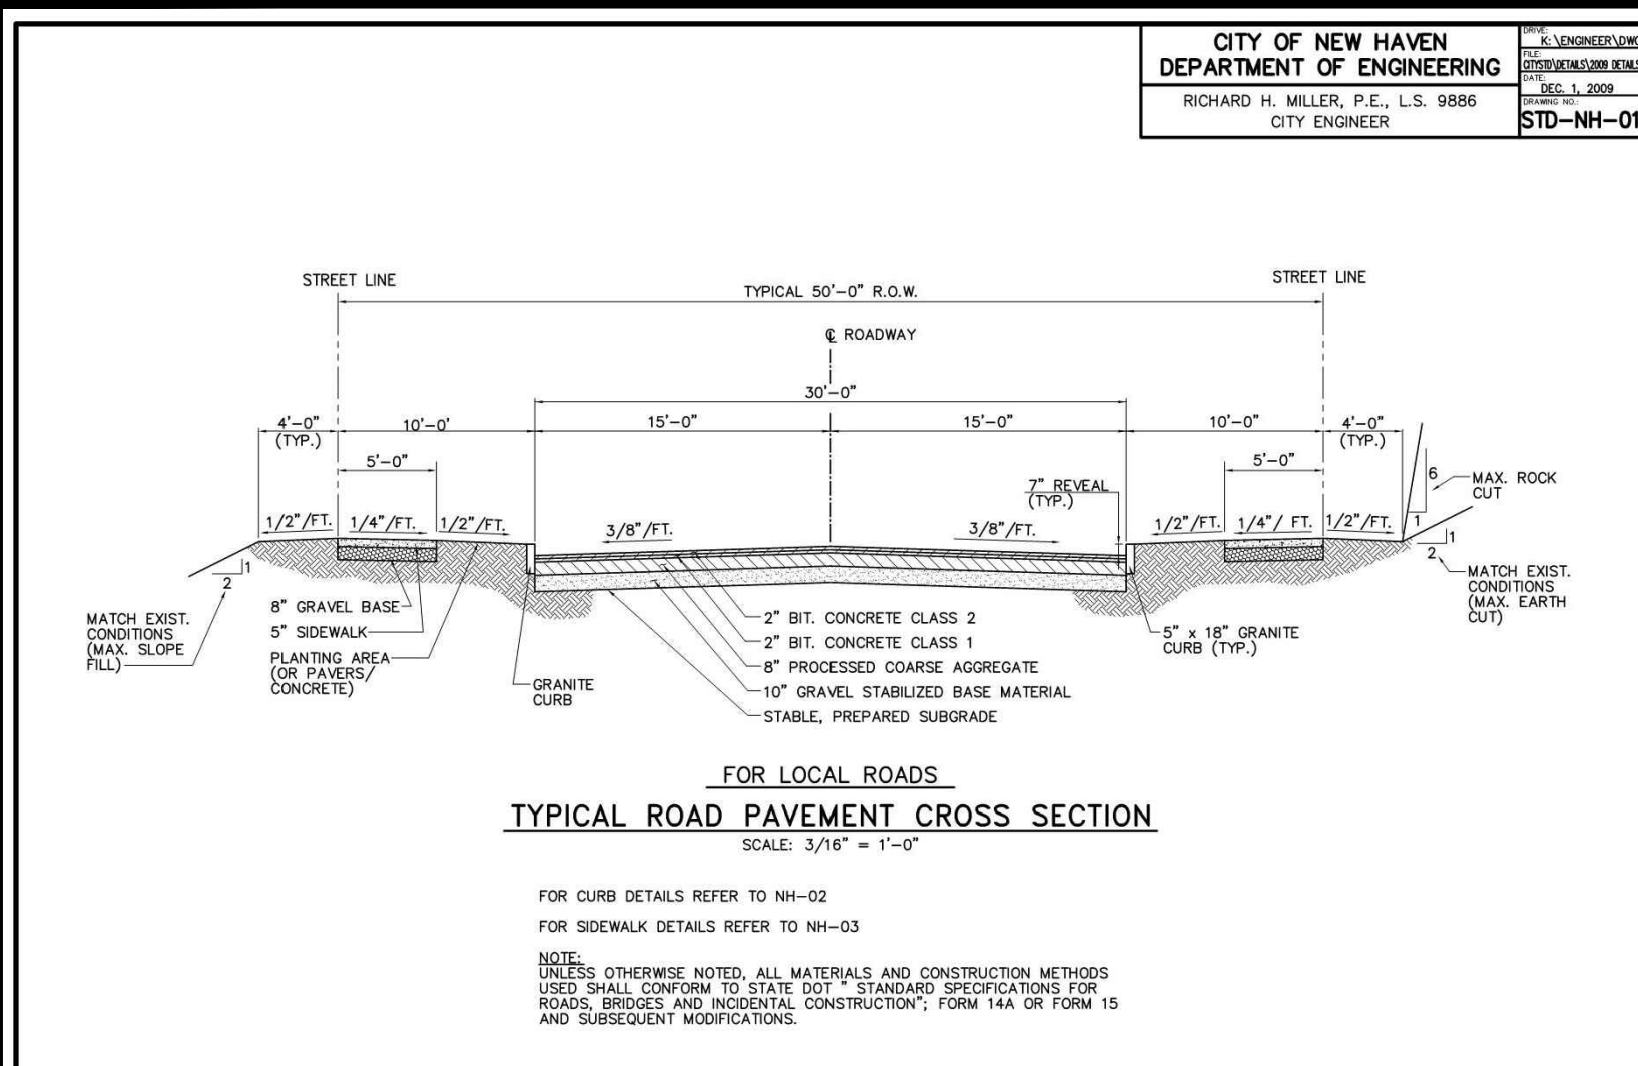

REVISIONS			
REV	DATE	COMMENT	BY
1			
2			
3			
4			
5			
6			
7			
8			
9			
10			
11			
12			
13			
14			
15			

PRELIMINARY

PROJECT No.:	W161042
DRAWN BY:	WS/JF
CHECKED BY:	JF/AD
DATE:	09/07/18
SCALE:	AS NOTED
CAD I.D.:	W161042SS0

PROJECT: **SITE
DEVELOPMENT
PLANS
—FOR—
CONNECTICUT
HEALTH CARE
HOLDINGS LLC**

NEW HAVEN, CT
MAP #339, BLOCK #190, LOT #17
240 WINTHROP AVENUE
CITY OF NEW HAVEN
NEW HAVEN COUNTY,
CONNECTICUT



BOHLER
ENGINEERING

352 TURNPIKE ROAD
SOUTHBOROUGH, MA 01772
Phone: (508) 480-9900
Fax: (508) 480-9080
www.BohlerEngineering.com

J.G. SWERLING

PROFESSIONAL ENGINEER

MASSACHUSETTS LICENSE No. 41697
NEW HAMPSHIRE LICENSE No. 14695
MAINE LICENSE No. 13816
CONNECTICUT LICENSE No. 30796
RHODE ISLAND LICENSE No. 1425


SHEET TITLE:

CONSTRUCTION DETAIL SHEET

SHEET NUMBER:

14
OF 14

REV 0 - 09/07/2018

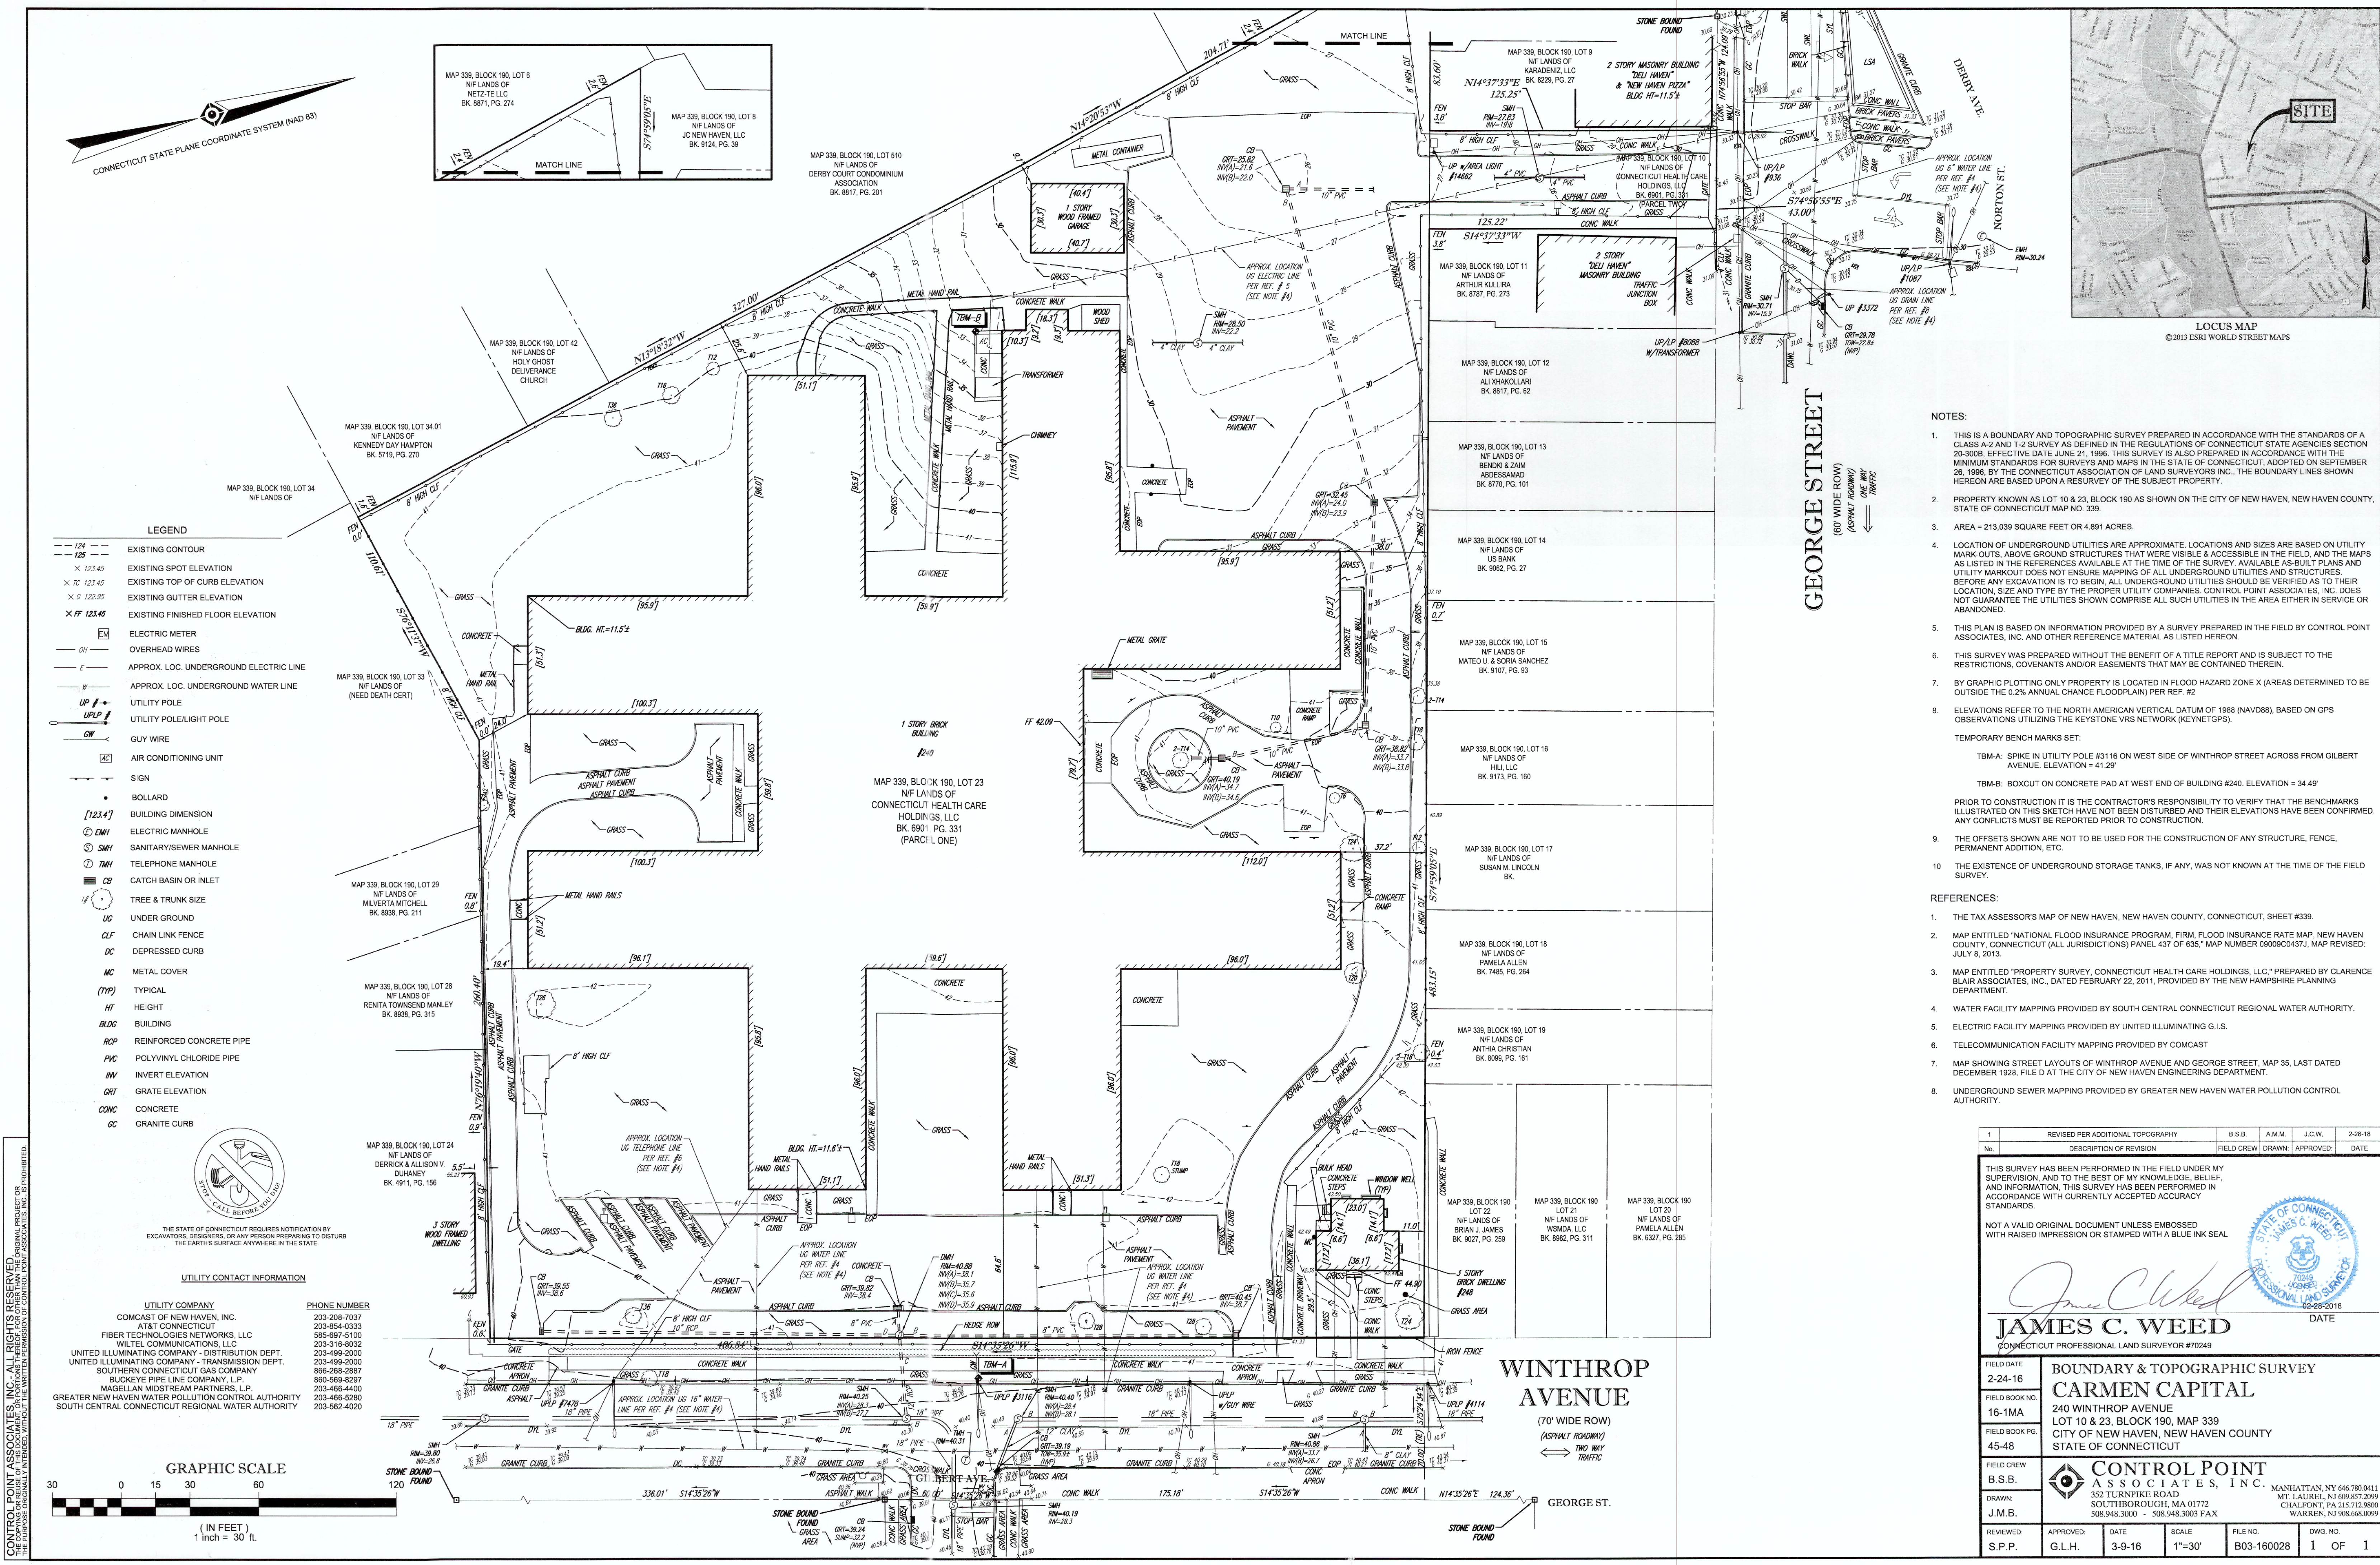

- NOTES:
- THIS IS A BOUNDARY AND TOPOGRAPHIC SURVEY PREPARED IN ACCORDANCE WITH THE STANDARDS OF A CLASS A-2 AND T-2 SURVEY AS DEFINED IN THE REGULATIONS OF CONNECTICUT STATE AGENCIES SECTION 20-300B, EFFECTIVE DATE JUNE 21, 1996. THIS SURVEY IS ALSO PREPARED IN ACCORDANCE WITH THE MINIMUM STANDARDS FOR SURVEYS AND MAPS IN THE STATE OF CONNECTICUT, ADOPTED ON SEPTEMBER 28, 1996, BY THE CONNECTICUT ASSOCIATION OF LAND SURVEYORS, INC. THE BOUNDARY LINES SHOWN HEREON ARE BASED UPON A RESURVEY OF THE SUBJECT PROPERTY.
 - PROPERTY KNOWN AS LOT 10 & 23, BLOCK 190 AS SHOWN ON THE CITY OF NEW HAVEN, NEW HAVEN COUNTY, STATE OF CONNECTICUT MAP NO. 339.
 - AREA = 213.039 SQUARE FEET OR 4.891 ACRES.
 - LOCATION OF UNDERGROUND UTILITIES ARE APPROXIMATE. LOCATIONS AND SIZES ARE BASED ON UTILITY MARK-OUTS, ABOVE GROUND STRUCTURES THAT WERE VISIBLE & ACCESSIBLE IN THE FIELD, AND THE MAPS AS LISTED IN THE REFERENCES AVAILABLE AT THE TIME OF THE SURVEY. AVAILABLE AS-BUILT PLANS AND UTILITY MARK-OUT DOES NOT ENSURE MAPPING OF ALL UNDERGROUND UTILITIES AND STRUCTURES. BEFORE ANY EXCAVATION IS TO BEGIN, ALL UNDERGROUND UTILITIES SHOULD BE VERIFIED AS TO THEIR LOCATION, SIZE AND TYPE BY THE PROPER UTILITY COMPANIES. CONTROL POINT ASSOCIATES, INC. DOES NOT GUARANTEE THE UTILITIES SHOWN COMPRISE ALL SUCH UTILITIES IN THE AREA EITHER IN SERVICE OR ABANDONED.
 - THIS PLAN IS BASED ON INFORMATION PROVIDED BY A SURVEY PREPARED IN THE FIELD BY CONTROL POINT ASSOCIATES, INC. AND OTHER REFERENCE MATERIAL AS LISTED HEREON.
 - THIS SURVEY WAS PREPARED WITHOUT THE BENEFIT OF A TITLE REPORT AND IS SUBJECT TO THE RESTRICTIONS, COVENANTS AND/OR EASEMENTS THAT MAY BE CONTAINED THEREIN.
 - BY GRAPHIC PLOTTING ONLY PROPERTY IS LOCATED IN FLOOD HAZARD ZONE X (AREAS DETERMINED TO BE OUTSIDE THE 0.2% ANNUAL CHANCE FLOODPLAIN) PER REF. #2
 - ELEVATIONS REFER TO THE NORTH AMERICAN VERTICAL DATUM OF 1988 (NAVD88), BASED ON GPS OBSERVATIONS UTILIZING THE KEYSTONE VRS NETWORK (KEYNETGPS).
- TEMPORARY BENCH MARKS SET:
- TBM-A: SPIKE IN UTILITY POLE #3116 ON WEST SIDE OF WINTHROP STREET ACROSS FROM GILBERT AVENUE. ELEVATION = 41.29'
- TBM-B: BOXCUT ON CONCRETE PAD AT WEST END OF BUILDING #240. ELEVATION = 34.49'
- PRIOR TO CONSTRUCTION IT IS THE CONTRACTOR'S RESPONSIBILITY TO VERIFY THAT THE BENCHMARKS ILLUSTRATED ON THIS SKETCH HAVE NOT BEEN DISTURBED AND THEIR ELEVATIONS HAVE BEEN CONFIRMED. ANY CONFLICTS MUST BE REPORTED PRIOR TO CONSTRUCTION.
- THE OFFSETS SHOWN ARE NOT TO BE USED FOR THE CONSTRUCTION OF ANY STRUCTURE, FENCE, PERMANENT ADDITION, ETC.
 - THE EXISTENCE OF UNDERGROUND STORAGE TANKS, IF ANY, WAS NOT KNOWN AT THE TIME OF THE FIELD SURVEY.
- REFERENCES:
- THE TAX ASSESSOR'S MAP OF NEW HAVEN, NEW HAVEN COUNTY, CONNECTICUT, SHEET #339.
 - MAP ENTITLED "NATIONAL FLOOD INSURANCE PROGRAM, FIRM, FLOOD INSURANCE RATE MAP, NEW HAVEN COUNTY, CONNECTICUT (ALL JURISDICTIONS) PANEL 437 OF 635," MAP NUMBER 9000900437J, MAP REVISED: JULY 8, 2013.
 - MAP ENTITLED "PROPERTY SURVEY, CONNECTICUT HEALTH CARE HOLDINGS, LLC," PREPARED BY CLARENCE BLAIR ASSOCIATES, INC., DATED FEBRUARY 22, 2011, PROVIDED BY THE NEW HAMPSHIRE PLANNING DEPARTMENT.
 - WATER FACILITY MAPPING PROVIDED BY SOUTH CENTRAL CONNECTICUT REGIONAL WATER AUTHORITY.
 - ELECTRIC FACILITY MAPPING PROVIDED BY UNITED ILLUMINATING G.I.S.
 - TELECOMMUNICATION FACILITY MAPPING PROVIDED BY COMCAST.
 - MAP SHOWING STREET LAYOUTS OF WINTHROP AVENUE AND GEORGE STREET, MAP 35, LAST DATED DECEMBER 1928, FILE D AT THE CITY OF NEW HAVEN ENGINEERING DEPARTMENT.
 - UNDERGROUND SEWER MAPPING PROVIDED BY GREATER NEW HAVEN WATER POLLUTION CONTROL AUTHORITY.

1	REVISED PER ADDITIONAL TOPOGRAPHY	B.S.B.	A.M.M.	J.C.W.	2-28-18
No.	DESCRIPTION OF REVISION	FIELD CREW	DRAWN	APPROVED	DATE
THIS SURVEY HAS BEEN PERFORMED IN THE FIELD UNDER MY SUPERVISION, AND TO THE BEST OF MY KNOWLEDGE, BELIEF, AND INFORMATION, THIS SURVEY HAS BEEN PERFORMED IN ACCORDANCE WITH CURRENTLY ACCEPTED ACCURACY STANDARDS.					
NOT A VALID ORIGINAL DOCUMENT UNLESS EMBOSSED WITH RAISED IMPRESSION OR STAMPED WITH A BLUE INK SEAL					
DATE 02-28-2018					

FIELD DATE 2-24-16	BOUNDARY & TOPOGRAPHIC SURVEY CARMEN CAPITAL 240 WINTHROP AVENUE LOT 10 & 23, BLOCK 190, MAP 339 CITY OF NEW HAVEN, NEW HAVEN COUNTY STATE OF CONNECTICUT				
FIELD BOOK NO. 16-1MA					
FIELD BOOK PG. 45-48					
FIELD CREW B.S.B.					
DRAWN J.M.B.	332 TURNPIKE ROAD SOUTHBOROUGH, MA 01772 508-945-3000 - 508-948-3003 FAX				
REVIEWED S.P.P.	APPROVED G.L.H.	DATE 3-9-16	SCALE 1"=30'	FILE NO. B03-160028	DWG. NO. 1 OF 1