


10100 DARDEN HILL RD, Bldg 4
Austin, TX 78737
all building to be built to IBC 2018
all fire code references to IFC 2018

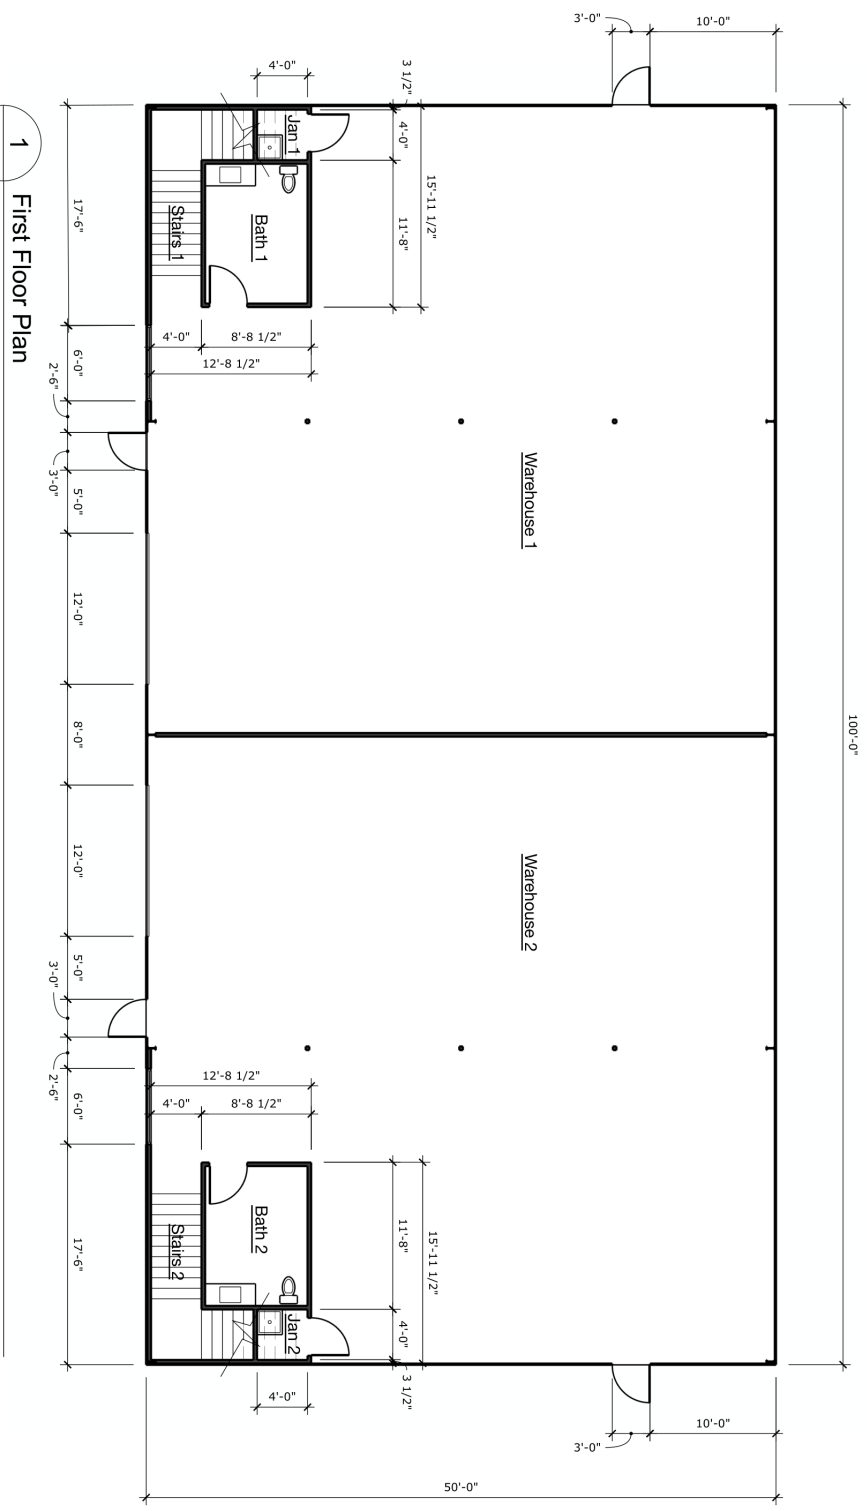

1 First Floor Plan
A.101 Scale: 1/8" = 1'-0" @ 11x17