


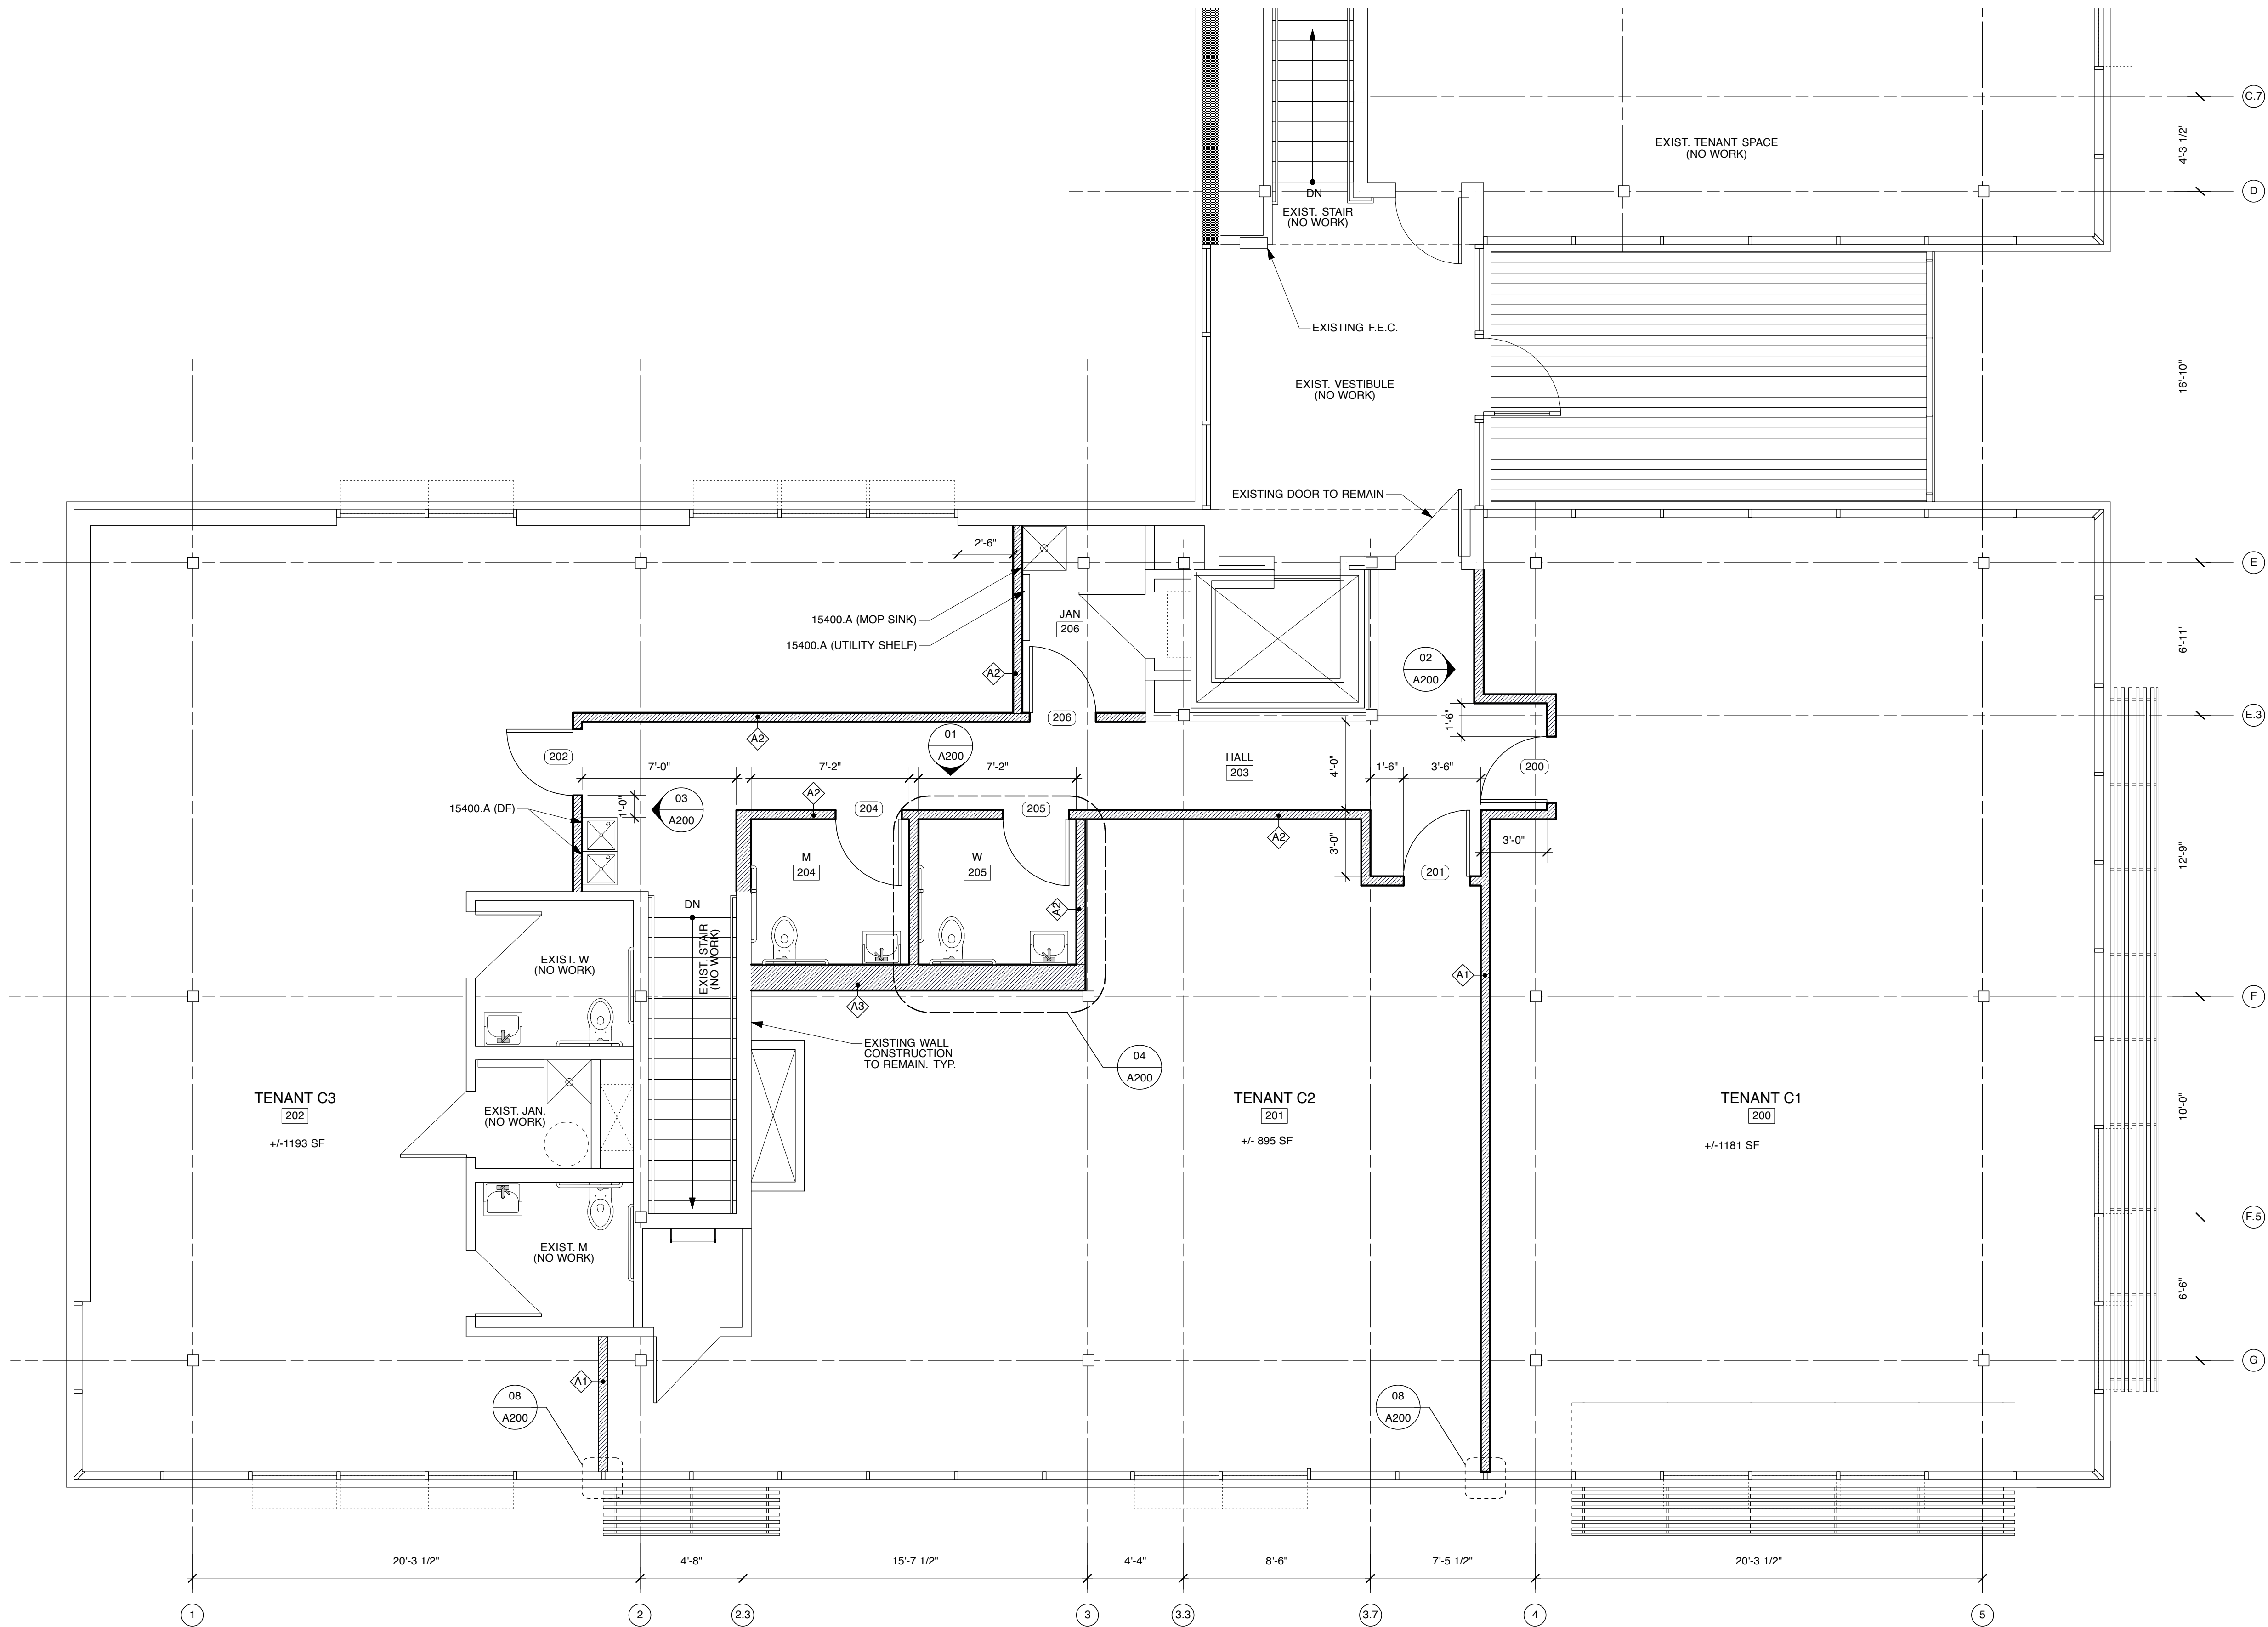

DIVISION 03 - CONCRETE

03300.A CAST-IN-PLACE CONC. (EXISTING)

DIVISION 04 - MASONRY (NOT USED)

DIVISION 05 - METALS (NOT USED)

DIVISION 06 - WOODS AND PLASTICS

06100.A DIMENSIONAL LUMBER

06100.B WOOD BLOCKING

DIVISION 07 - THERMAL & MOISTURE PROTECTION

07210.A BATT INSULATION

07841.A THRU-PENETRATION FIRESTOP

07842.A FIRE-RESISTIVE JOINT SYSTEMS

07920.A JOINT SEALANT

07920.B BACKER ROD

DIVISION 08 - DOORS AND WINDOWS

08211.A FLUSH WOOD DOORS

08710.A DOOR HARDWARE

08800.A GLAZING - CLEAR

08830.A MIRROR

08830.B MIRROR SUPPORT TRIM

DIVISION 09 - FINISHES

09111.A METAL STUD

09111.B METAL FURRING CHANNEL

09111.C METAL TRACK / RUNNER

09260.A GYPSUM WALLBOARD

09260.B WATER RESISTANT GYPSUM BOARD

09260.C TEAR AWAY BEAD

09260.D J BEAD

09912.A INTERIOR PAINTING

09960.A EPOXY FLOOR COATING

DIVISION 10 - SPECIALTIES

10155.A METAL TOILET COMPARTMENTS

10520.A FIRE EXTINGUISHER AND CABINET

10801.A TP DISPENSER

10801.B TOWEL DISPENSER / WASTE

10801.C GRAB BAR

10801.D NAPKIN DISPOSAL

10801.E UNDERLAVATORY GUARD

10801.F SOAP DISPENSER

DIVISION 11 - EQUIPMENT (NOT USED)

DIVISION 12 - FURNISHINGS (NOT USED)

DIVISION 13 - SPECIAL CONTRUCTION (NOT USED)

DIVISION 14 - CONVEYING SYSTEMS (NOT USED)

DIVISION 15 - MECHANICAL

15400.A PLUMBING FIXTURE (RE: PLUMB.)

15400.B FLOOR DRAIN (RE: PLUMB.)

15700.A MECHANICAL EQUIPMENT (RE: MECH)

15700.A DUCT (RE: MECH)

DIVISION 16 - ELECTRICAL

16000.A INTERIOR LIGHT FIXTURE (RE: ELEC)

16000.B EXTERIOR LIGHT FIXTURE (RE: ELEC)

16000.C J BOX (RE: ELEC)

16000.D ELECTRICAL PANEL (RE: ELEC)

16000.E LIGHTING CONTROLS

KEYNOTES

01 2ND FLOOR PLAN

RE: 01/A050

CONSULTANTS:

M/E/P:
LANKFORD & ASSOCIATES
1730 WALNUT STREET
KANSAS CITY, MISSOURI 64108
TEL: 816-221-1411
FAX: 816-221-1429

CODE CONSULTANT:
CODE CONSULTING SERVICES
103 WISTERIA
SMITHVILLE, MISSOURI 64089
TEL: 816-985-9669
FAX: 816-532-1558

ISSUE PACKAGE:

SCHEMATIC PRICING SET
PERMIT SET

DATE:

10.22.09
05.27.10



DAVID RUSSELL DOWELL
ARCHITECT
LICENSE NO. A-2009030386

508 WEST 75TH STREET

501 WEST 75TH STREET, KANSAS CITY, MISSOURI 64114

PROJECT #0707
DRAWN BY: SSA / MH
CHECKED BY: DD/JS

el dorado

ARCHITECTURAL CORPORATION
MO LICENSE NO. 2004006230

310 avenida cesar e chavez kansas city missouri 64108 p 816 474 3838 f 816 474 0836 www.eldoradoarchitects.com

PLAN

A100