

**CRAWFORD,
WILLIAMS
ENGINEERING, Inc.**
CA 7029

6989 PROFESSIONAL PKWY. E.
SARASOTA, FLORIDA 34240
tel [941] 907-0103 fax [941] 907-0152


MECHANICAL
ELECTRICAL
PLUMBING
& FIRE

© 2022 CRAWFORD WILLIAMS ENGINEERING, INC.

HVAC LEGEND

- 12"x12" RECTANGULAR DUCT
- 12"x9" RIGID ROUND DUCT
- 12"x9" FLEXIBLE DUCT
- SUPPLY DIFFUSER
- RETURN OR EXHAUST GRILLE
- EXHAUST GRILLE
- CEILING EXHAUST FAN
- GRILLE MARK CFM
- FIRE DAMPER

**INBAR
ARCHITECTURE, AIA**
FLORIDA LICENSE NO. AA0002701
2831 RINGLING BLVD, SUITE E-117
SARASOTA, FLORIDA 34237
PHONE & FAX: (941) 951-2816
CELL PHONE: (941) 350-9939
EMAIL: inbararchitecture@gmail.com

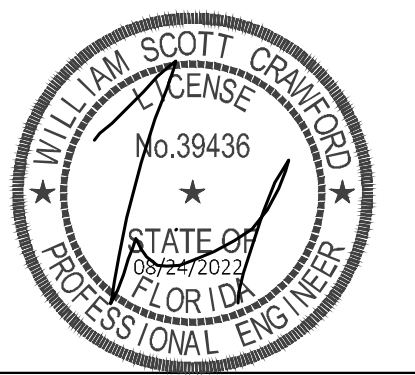


REVISIONS

No.	Description	Date

OWNER APPROVALS

No.	Description	Date
	D	

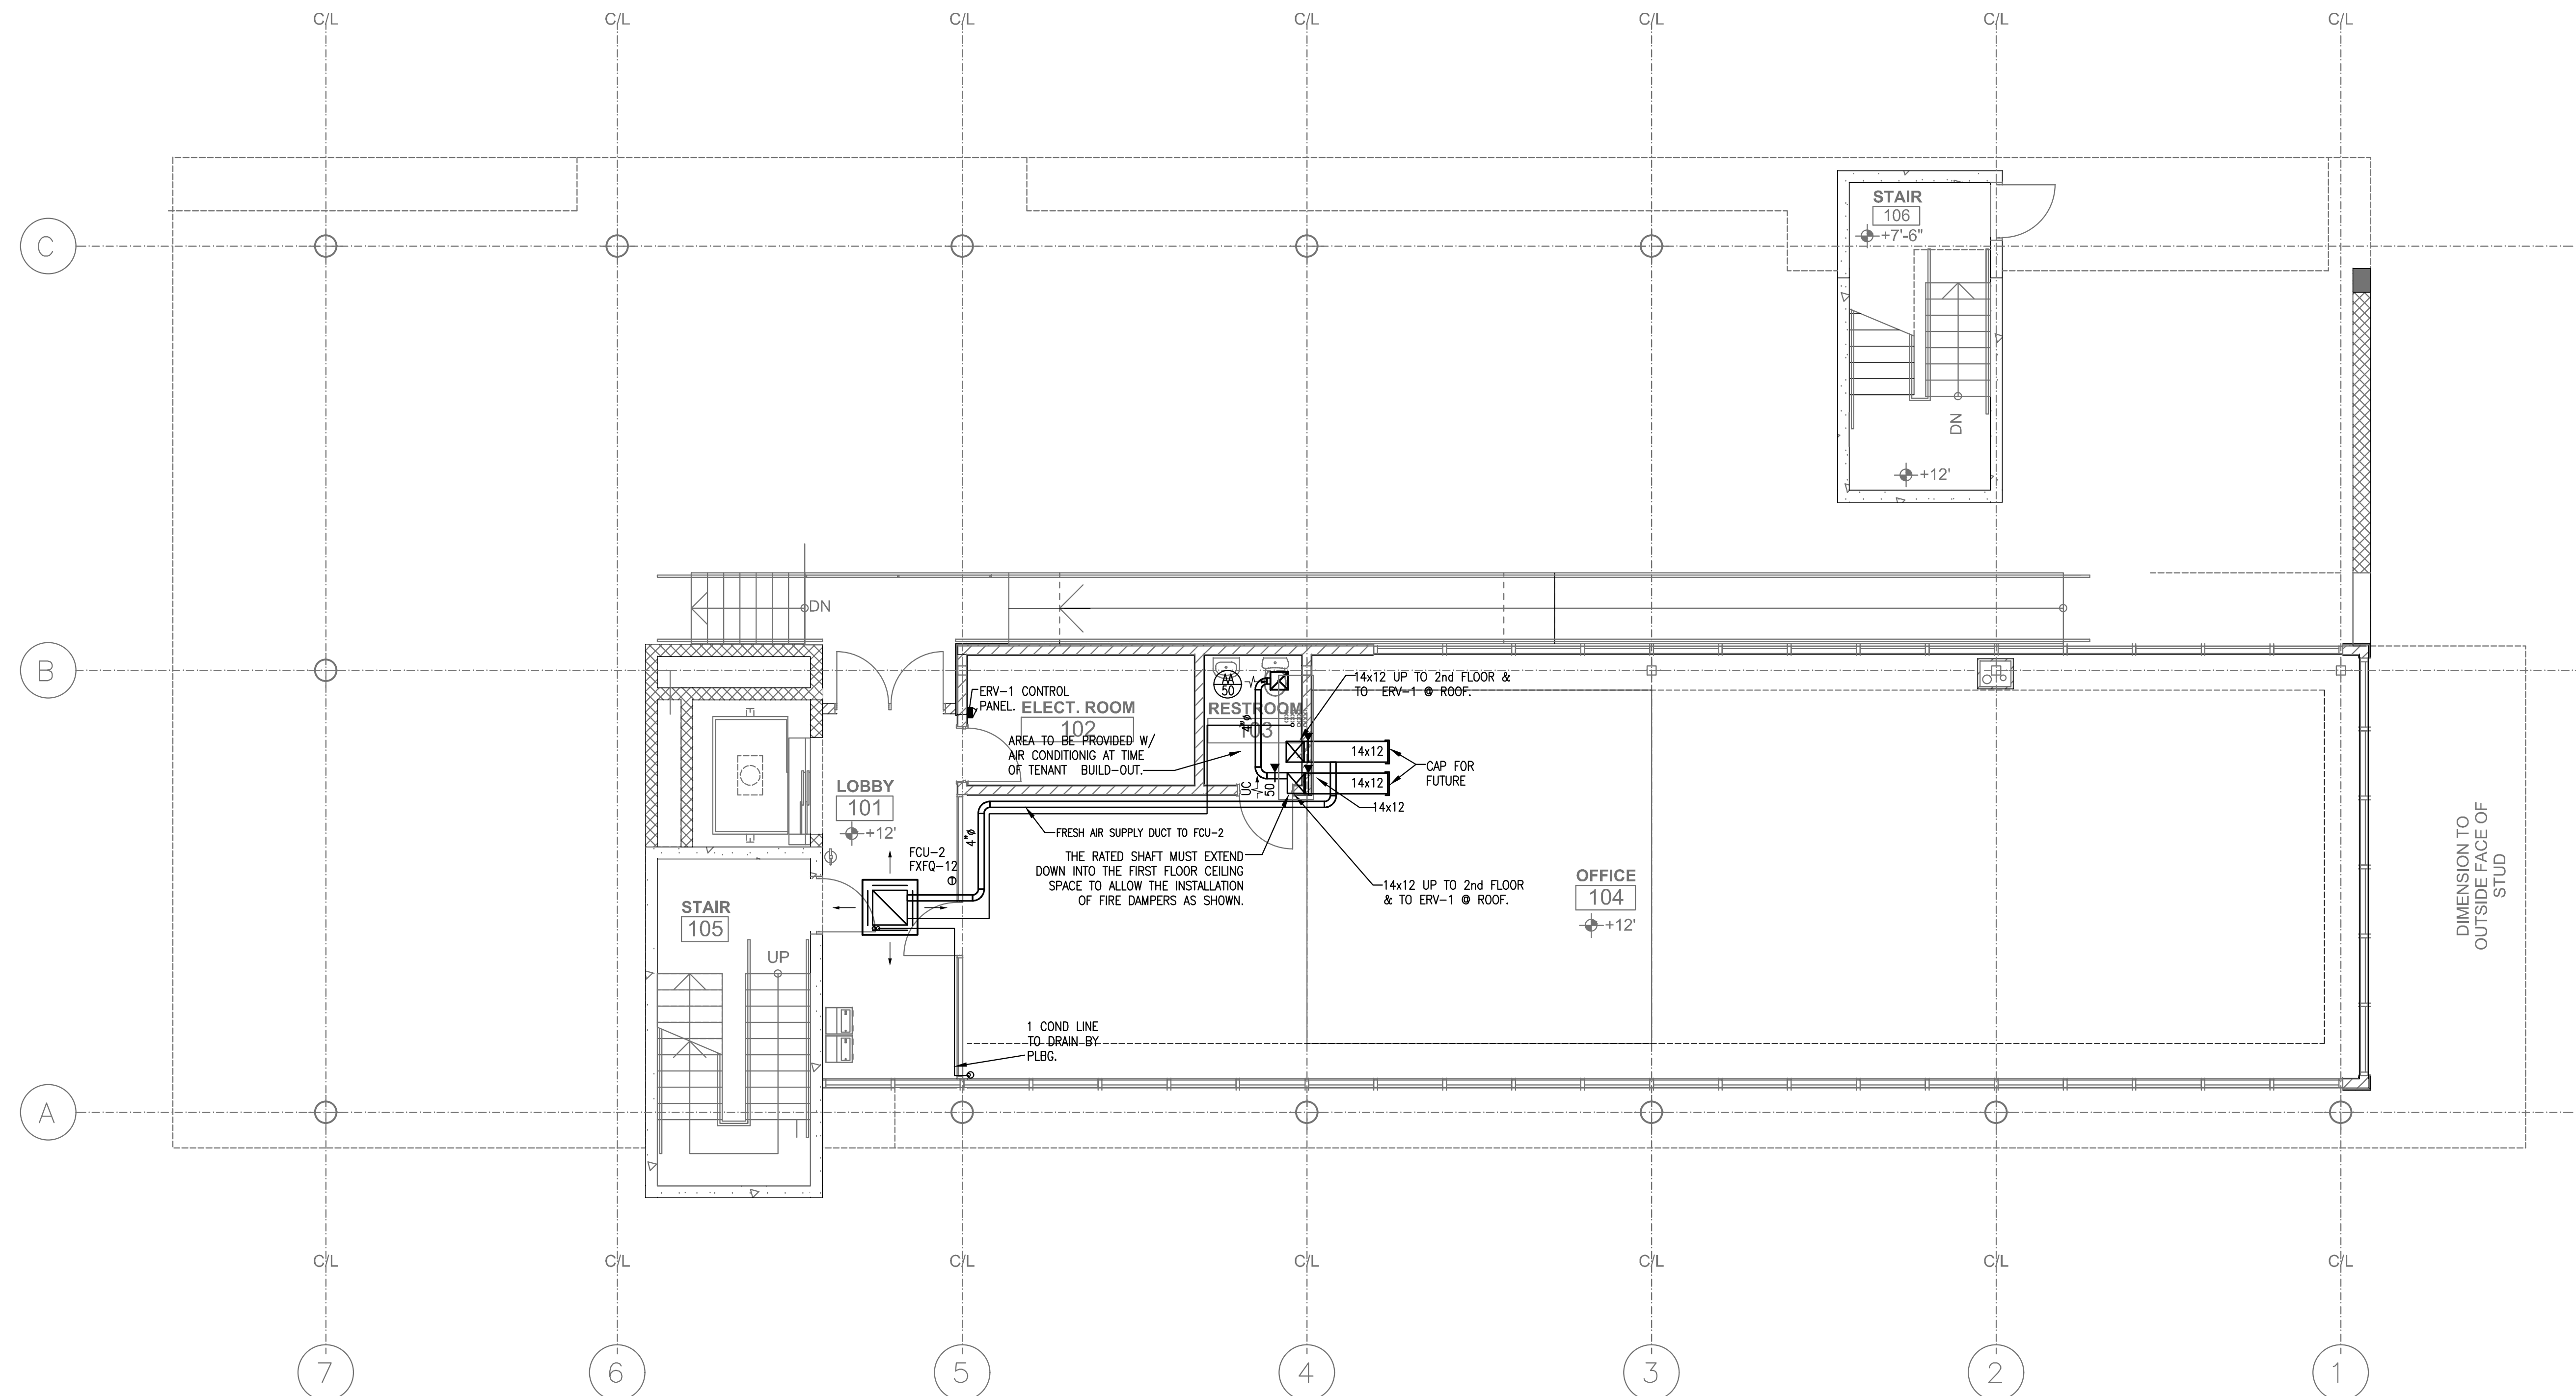

FIRST FLOOR H.V.A.C. PLAN
SCALE: 3/16" = 1'-0"

TO THE BEST OF THE ENGINEER'S KNOWLEDGE, SAID PLANS AND SPECIFICATIONS COMPLY WITH THE APPLICABLE BUILDING CODES AND THE APPLICABLE MINIMUM FIRE SAFETY STANDARDS AS DETERMINED IN ACCORDANCE WITH CHAPTERS 553 AND 633, FLORIDA STATUTES.

PROPOSED NEW HOME FOR:

NOKOMIS MEDICAL CENTER
498 S. TAMiami TRl.
NOKOMIS, FL.

PERMIT #

FIRST FLOOR
HVAC PLAN

Sheet Title


Drawing Name:	NOKOMIS OFFICE
Design:	CWE
Issues:	08/24/2022
Job No.:	2203

Sheet Number:

M-1


CRAWFORD, WILLIAMS ENGINEERING, Inc.
 MECHANICAL ELECTRICAL PLUMBING & FIRE
 CA 7029
 6889 PROFESSIONAL PKWY. E.
 SARASOTA, FLORIDA 34240
 tel (941) 907-0103 fax (941) 907-0152
 © 2022 CRAWFORD WILLIAMS ENGINEERING, INC.

INBAR ARCHITECTURE, AIA
 FLORIDA LICENSE NO. AA0002701
 2831 RINGLING BLVD, SUITE E-117
 SARASOTA, FLORIDA 34237
 PHONE & FAX: (941) 951-2816
 CELL PHONE: (941) 350-5939
 EMAIL: inbararchitecture@gmail.com

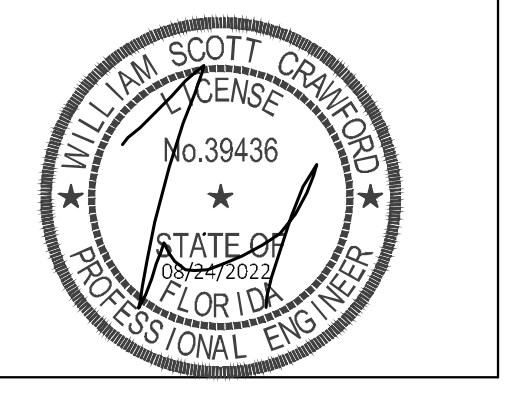

HVAC LEGEND

- 12"x12" RECTANGULAR DUCT
- 12" RIGID ROUND DUCT
- 12" FLEXIBLE DUCT
- SUPPLY DIFFUSER
- RETURN OR EXHAUST GRILLE
- EXHAUST GRILLE
- CEILING EXHAUST FAN
- GRILLE MARK
- FIRE DAMPER

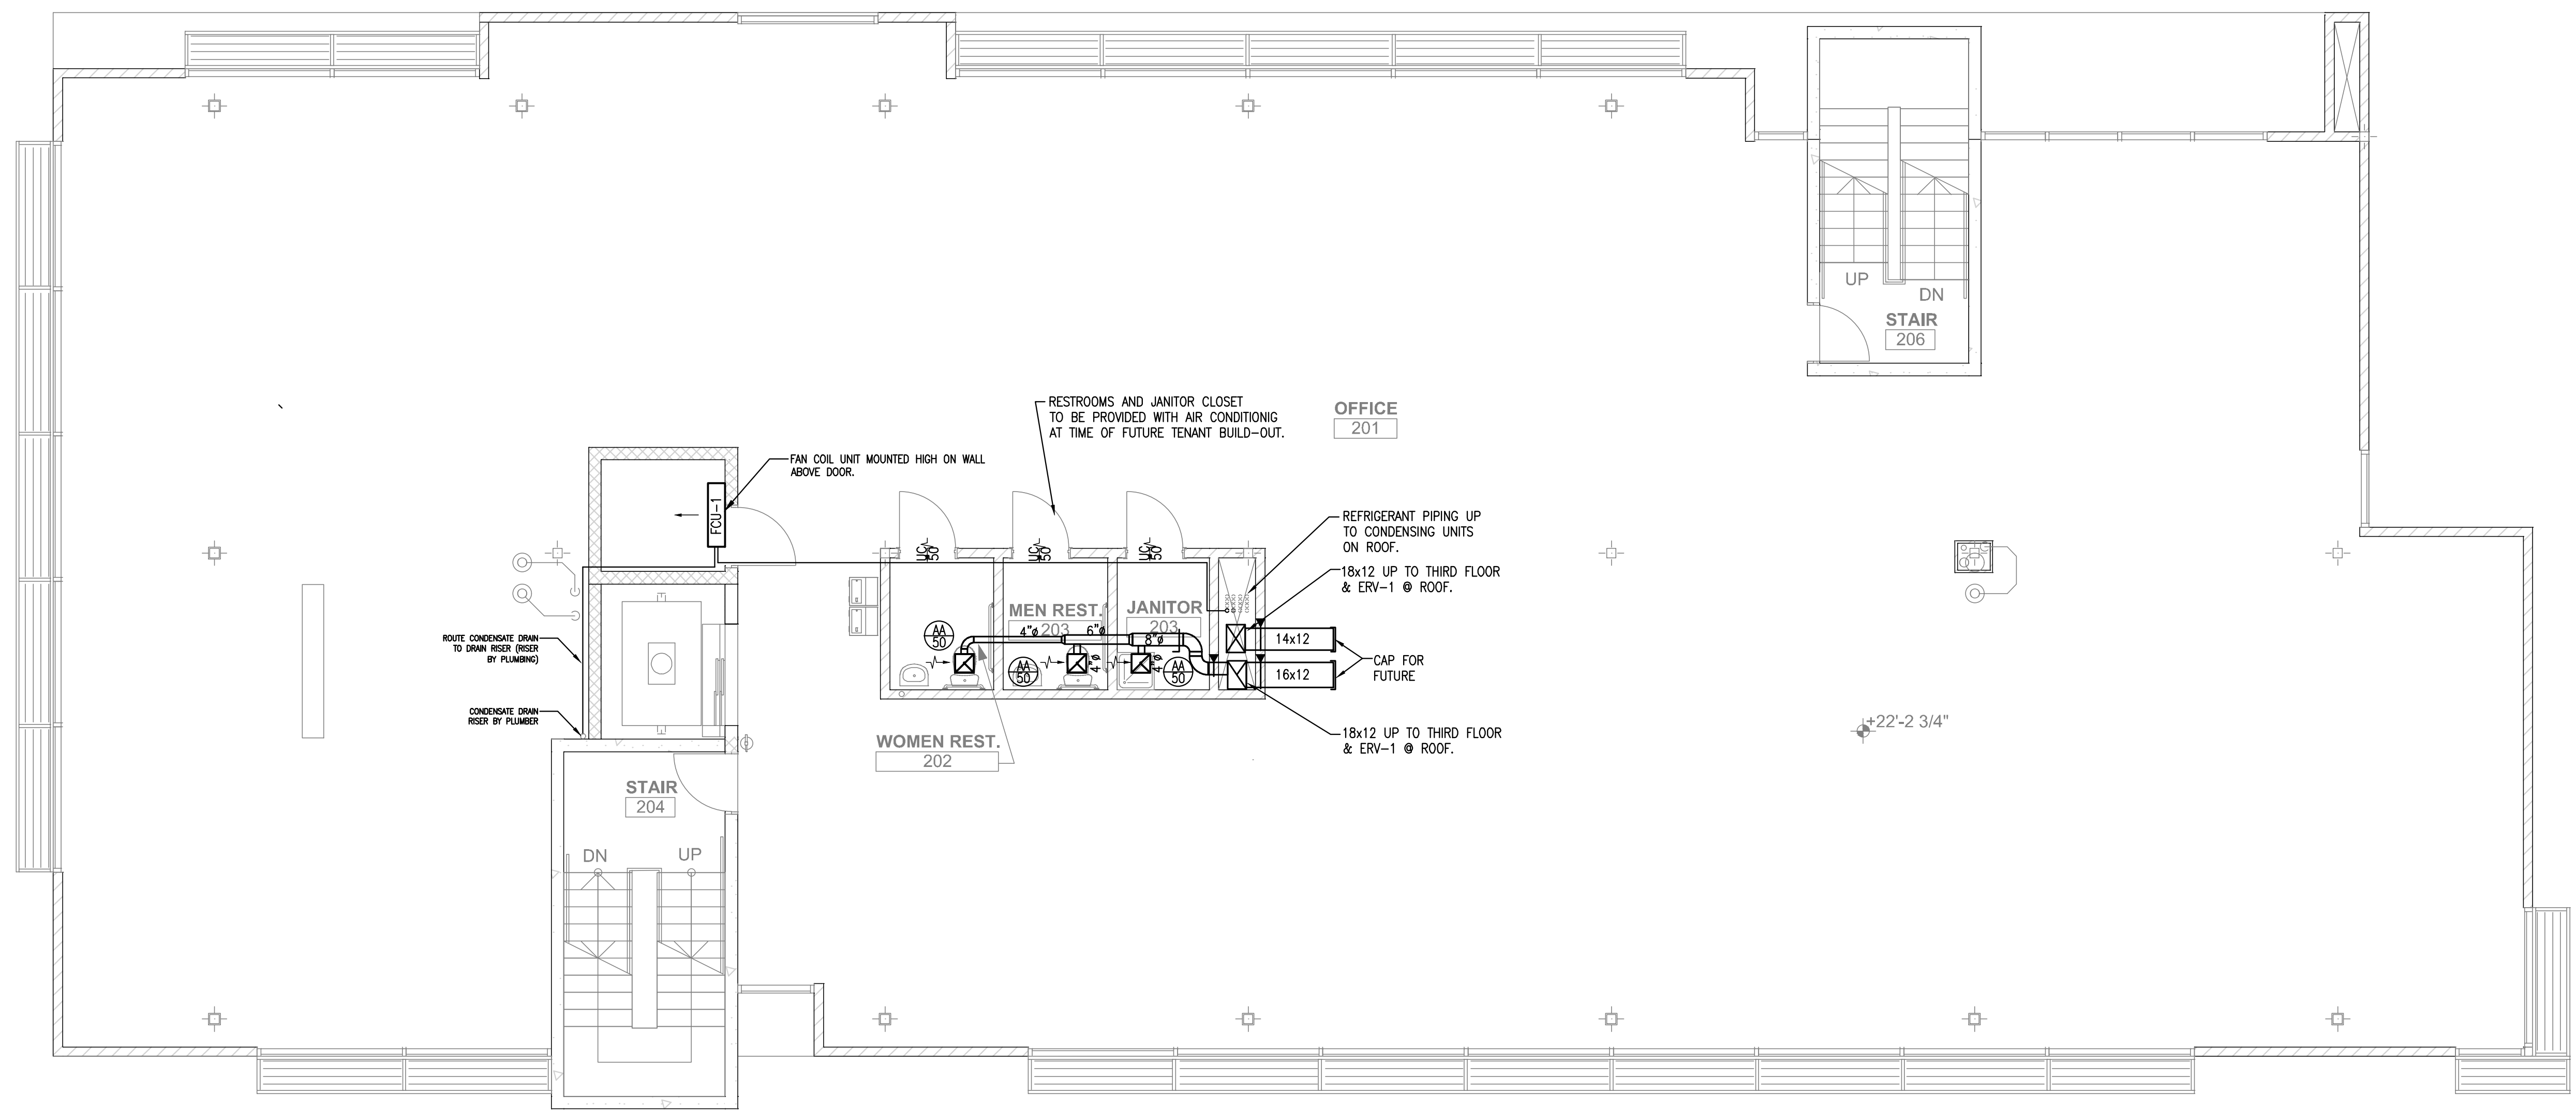

SECOND FLOOR H.V.A.C. PLAN
 SCALE: 3/16" = 1'-0"

TO THE BEST OF THE ENGINEER'S KNOWLEDGE, SAID PLANS AND SPECIFICATIONS COMPLY WITH THE APPLICABLE BUILDING CODES AND THE APPLICABLE MINIMUM FIRE SAFETY STANDARDS AS DETERMINED IN ACCORDANCE WITH CHAPTERS 553 AND 633, FLORIDA STATUTES.

REVISIONS

No.	Description	Date

OWNER APPROVALS

No.	Description	Date
	D	

PROPOSED NEW HOME FOR:
NOKOMIS MEDICAL CENTER
 498 S. TAMiami TRl.
 NOKOMIS, FL.


PERMIT #

Sheet Title

SECOND FLOOR
 HVAC PLAN







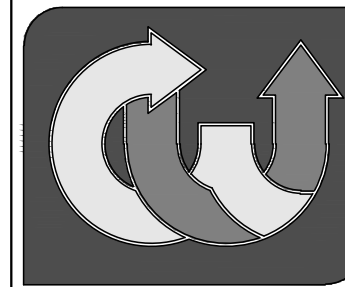


Drawing Name: NOKOMIS OFFICE
 Design: CWE
 Issues: 08/24/2022
 Job No.: 2203
 Sheet Number:

  M-2




CRAWFORD, WILLIAMS ENGINEERING, Inc.
 MECHANICAL ELECTRICAL PLUMBING & FIRE
 CA 7029
 6889 PROFESSIONAL PKWY. E. SARASOTA, FLORIDA 34240
 tel (941) 907-0103 fax (941) 907-0152
 © 2022 CRAWFORD WILLIAMS ENGINEERING, INC.

HVAC LEGEND

-  12"x12" RECTANGULAR DUCT
-  12" RIGID ROUND DUCT
-  12" FLEXIBLE DUCT
-  SUPPLY DIFFUSER
-  RETURN OR EXHAUST GRILLE
-  EXHAUST GRILLE
-  CEILING EXHAUST FAN
-  GRILLE MARK
-  FIRE DAMPER

INBAR ARCHITECTURE, AIA
 FLORIDA LICENSE NO. AA0002701
 2831 RINGLING BLVD, SUITE E-117
 SARASOTA, FLORIDA 34237
 PHONE & FAX: (941) 951-2816
 CELL PHONE: (941) 350-5939
 EMAIL: inbararchitecture@gmail.com

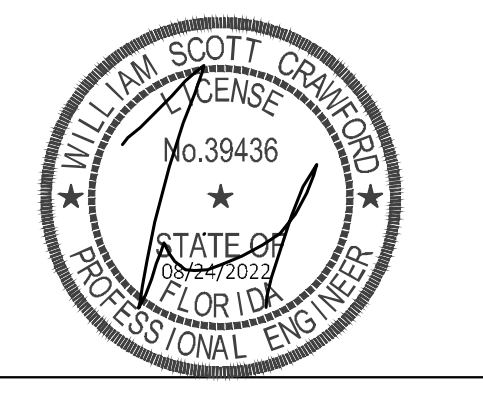


REVISIONS

No.	Description	Date

OWNER APPROVALS

No.	Description	Date
	D	

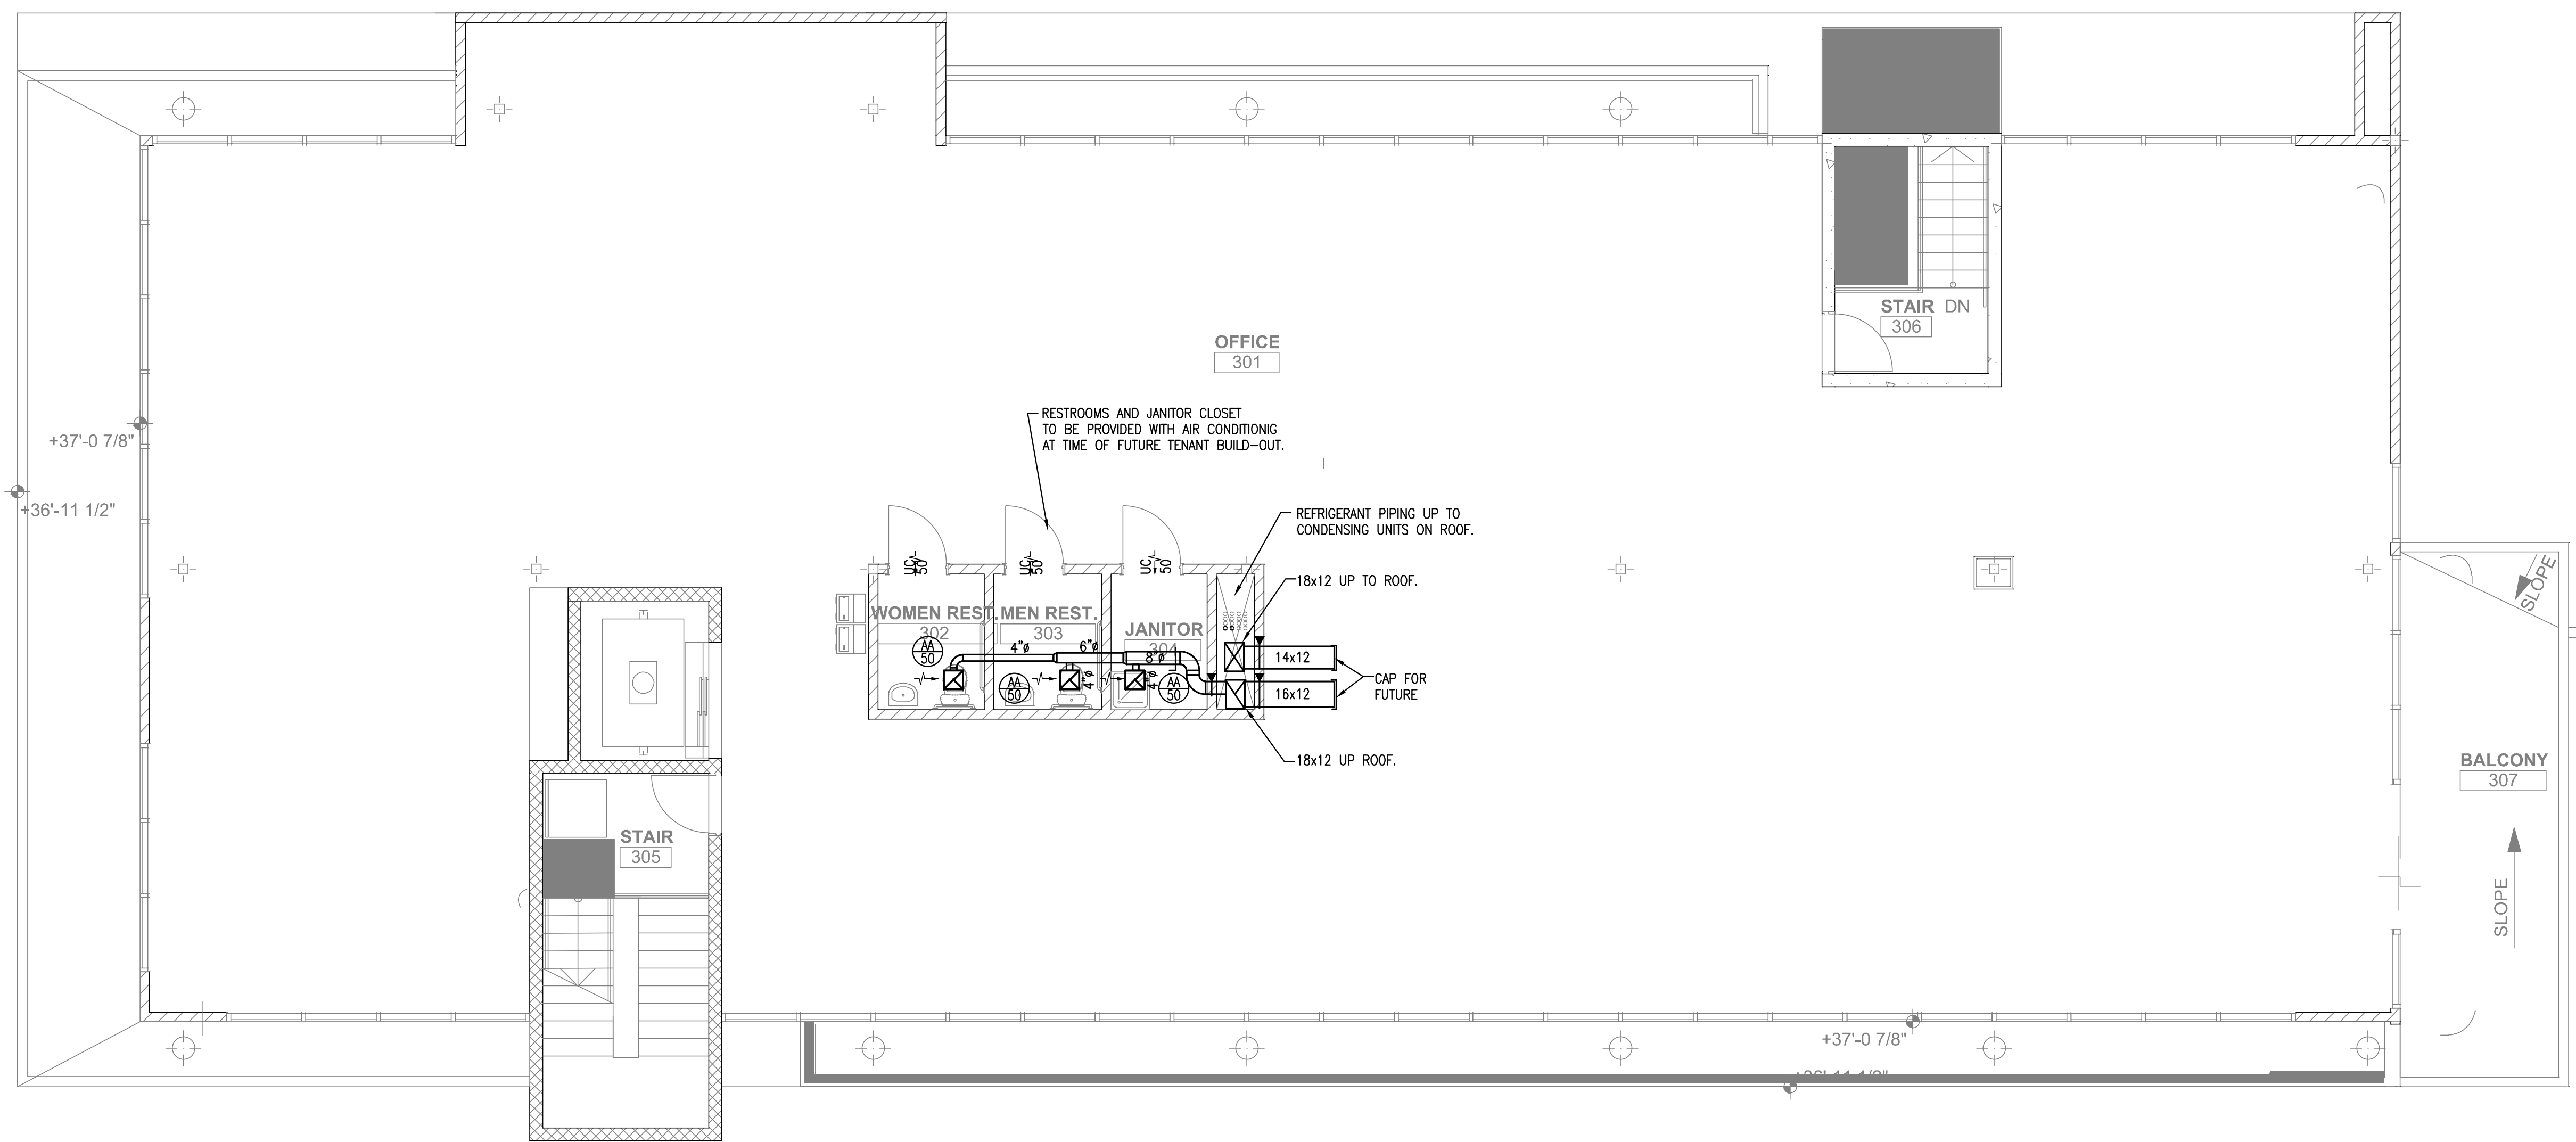

THIRD FLOOR H.V.A.C. PLAN
 SCALE: 3/16" = 1'-0"

TO THE BEST OF THE ENGINEER'S KNOWLEDGE, SAID PLANS AND SPECIFICATIONS COMPLY WITH THE APPLICABLE BUILDING CODES AND THE APPLICABLE MINIMUM FIRE SAFETY STANDARDS AS DETERMINED IN ACCORDANCE WITH CHAPTERS 553 AND 633, FLORIDA STATUTES

PROPOSED NEW HOME FOR:
NOKOMIS MEDICAL CENTER
 498 S. TAMiami TRl.
 NOKOMIS, FL.

PERMIT #

THIRD FLOOR
 HVAC PLAN

Drawing Name: NOKOMIS OFFICE
 Design: CWE
 Issues: 08/24/2022
 Job No.: 2203

Sheet Number:
M-3

