

A/C

XFR

W.H.

SINK

COUNTER

Sink

Sample Receiving

MECH. R.M.

A/C

HOOD

PANEL

XFR

CHILLER

FILTER

CHILLER

COUNTER

PANEL

STUB THRU WALL CHILL PIPE

Sample prep
Jsh Grinding
A/T Test
Rotas

FOYER

COUNTER

BRICK VENEER

8" BLOCK

30'-3"

6'-8"

22'-0"


25'-0"

1'-1"

14'-0"

BREEZWAY

EXIST. GAS METER

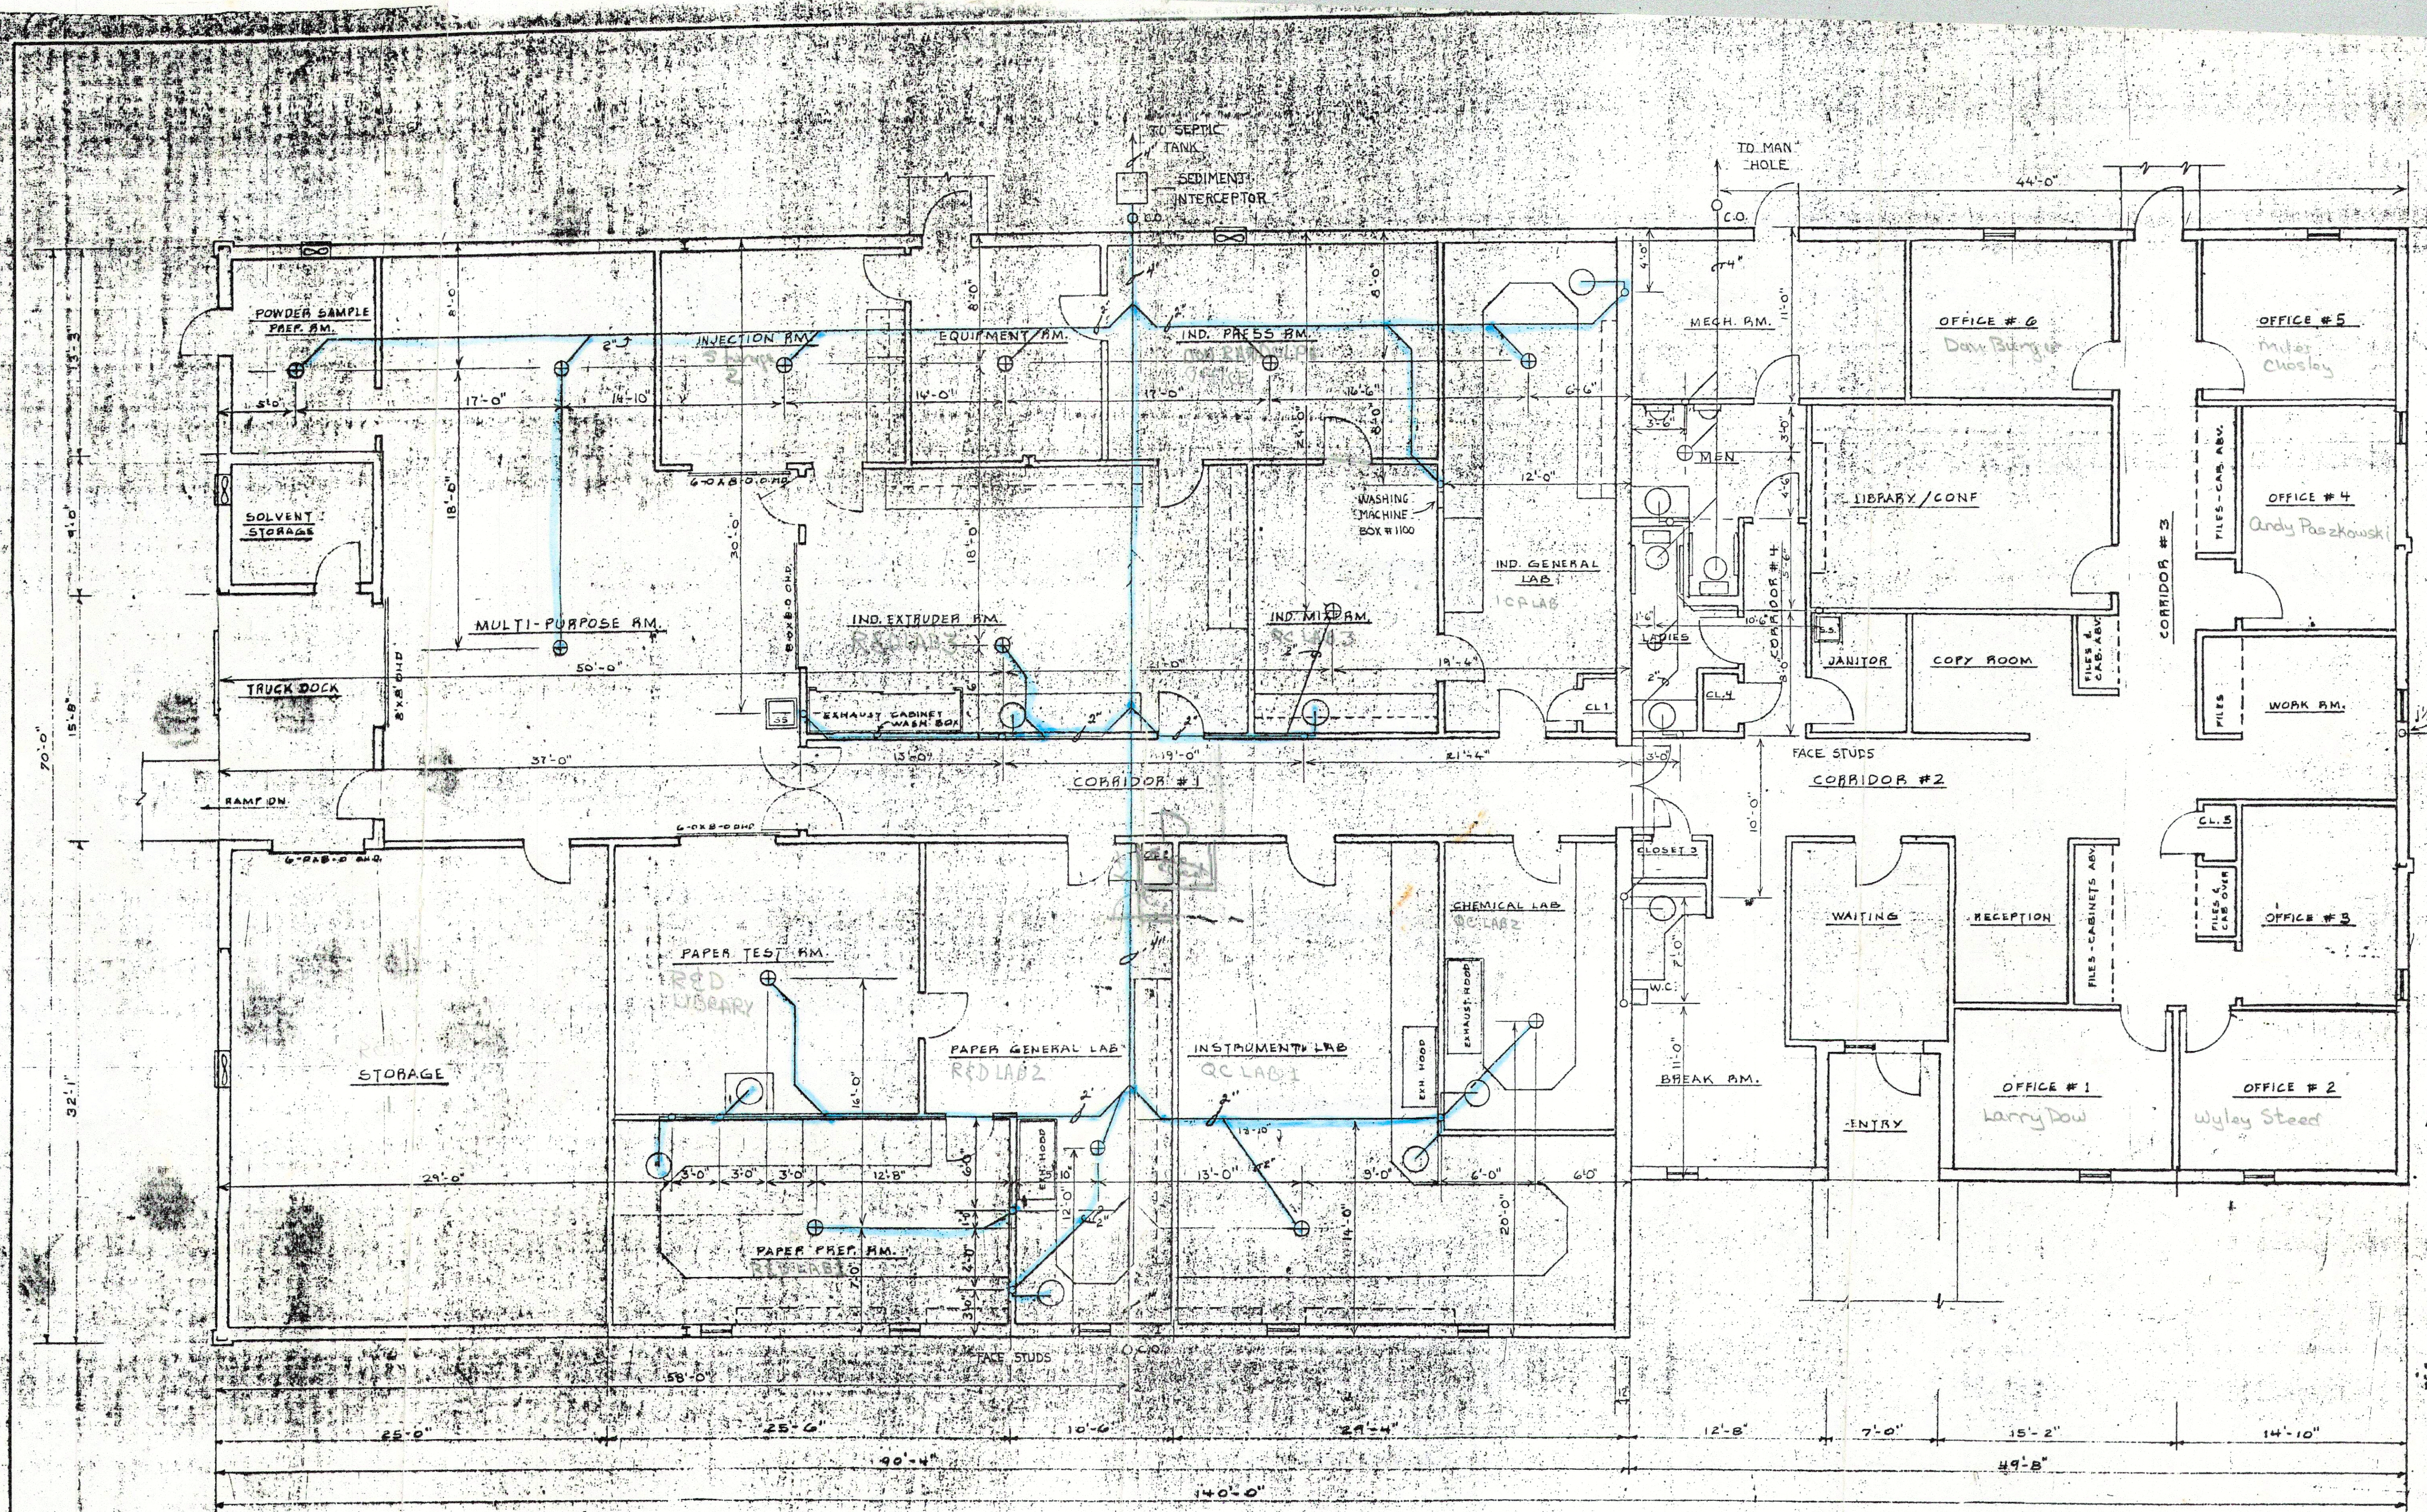


DRAIN PLAN
SCALE: 3/16" = 1'-0"

DESIGNED BY CENTRAL ELECTRIC CO.

REVISIONS			
REV. NO.	CHANGE	DATE	APPROVED BY
	AS BUILT		

DRAWING PREPARED FOR: MR. GENE GOREE
 NAME: CYPRUS-THOMPSON, WIENMAN
 ADDRESS: CARTERSVILLE, GA.
 PROJECT: NEW LABORATORY
 DATE: 7-17-84 DRAWN BY: N. SIMS CHECKED BY: [Signature]
GARNER BROTHERS CO
 PHONE 234-6334 ROME, GA P.O. BOX 2225
 TITLE: DRAIN PLAN
 DWNG. No. B426 SHT. No. 7 OF 11

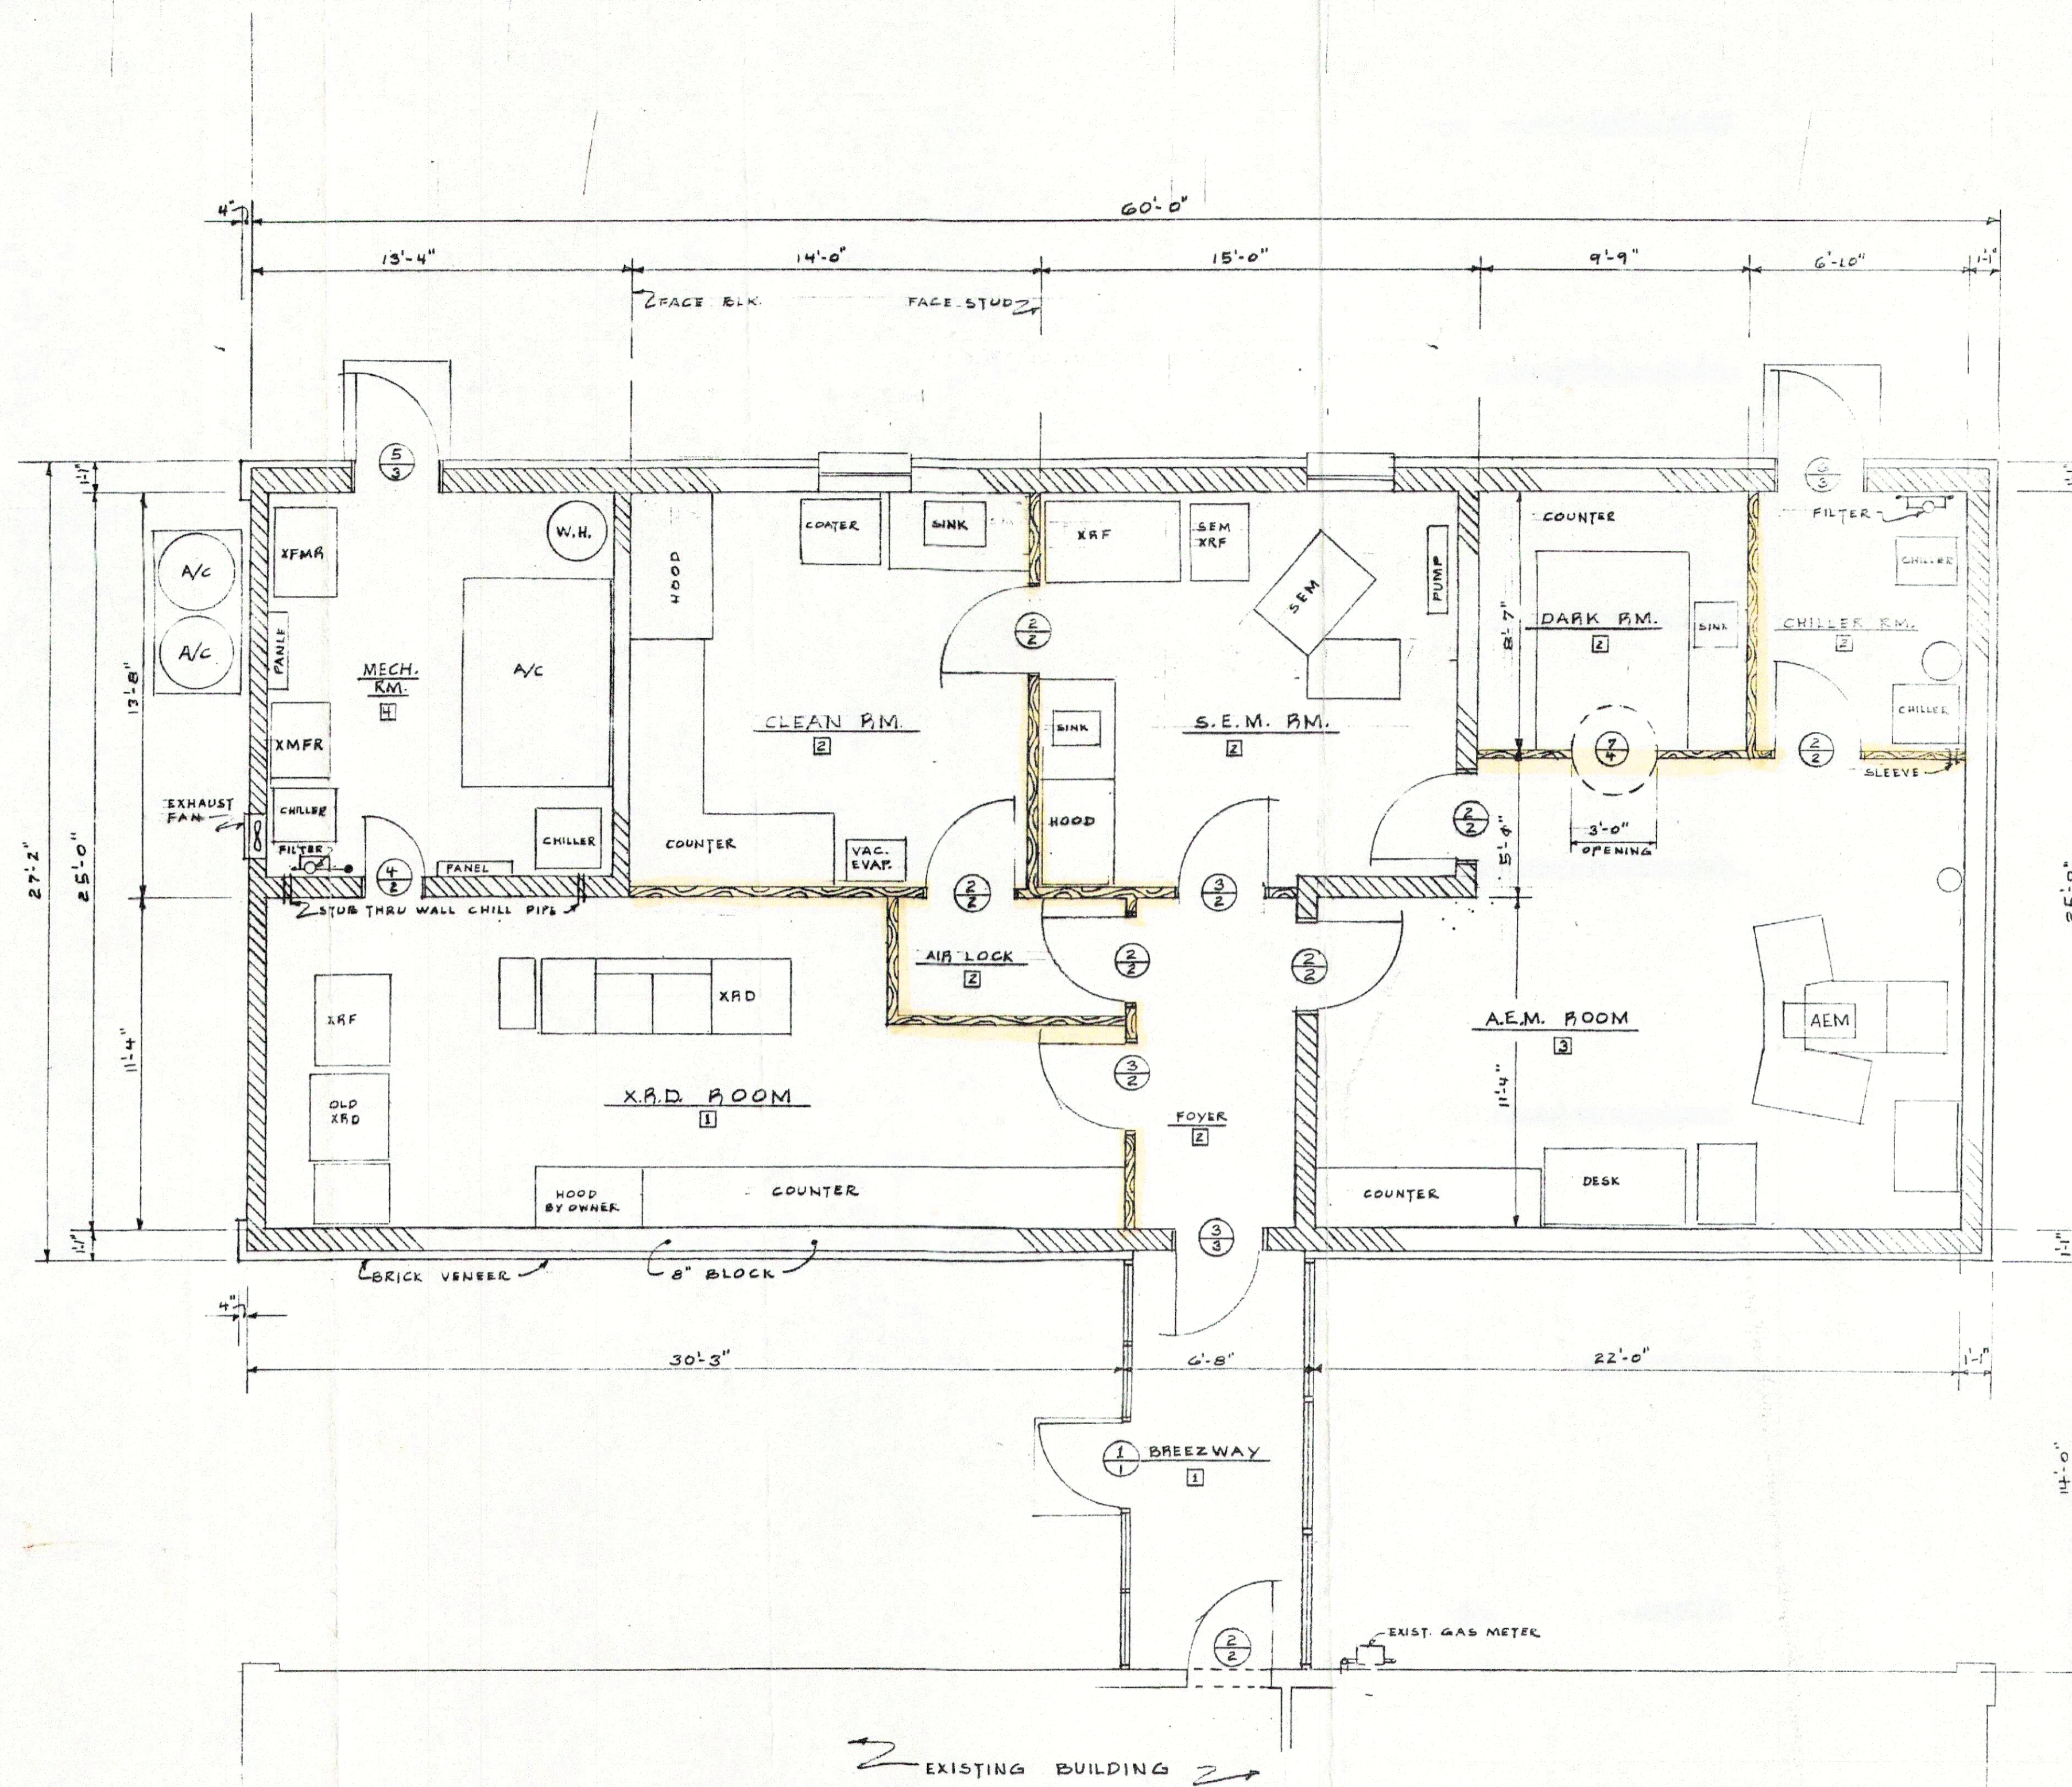

FINISH SCHEDULE				
#	FLOOR	BASE	WALLS	CEIL. HT. / CEIL.
1	VINYL TILE	VINYL	PAINTED	8'-0" LAY-IN
2	DO	DO	DO	8'-0" PAINTED GYP. BD.
3	DO	DO	DO	9'-4" DO
4	EXP. CONC.	NONE	DO	VARIES EXP. STEEL

DOOR SCHEDULE			
#	TYPE	SIZE	GLASS / REMARKS
1	ALUMINUM	36 X 66	FULL
2	WOOD	DO	NONE WOOD FRAME
3	WOOD	DO	TOP HALF
4	DO	28 X 66	NONE
5	STEEL	36 X 66	NONE 18" SQ. LOUVER
6	DO	DO	DO

HARDWARE	
1	THUMB BOLT
2	PASSAGE SET
3	KEY IN KNOB
4	BY OWNER

FLOOR PLAN
1/4" = 1'-0"

REVISIONS			
REV. NO.	CHANGE	DATE	AUTHORIZED BY
1	DOOR LOCATIONS	6-11-87	DLGEN

DRAWING PREPARED FOR: MR. RICHARD ZAZENSKY	
NAME	CYPRUS INDUSTRIAL MINERALS
ADDRESS	CARTERSVILLE, GA.
PROJECT	PRODUCT CERTIFICATION LAB
DATE	6-3-87
DRAWN BY	BEN
CHECKED BY	
GARNER BROTHERS CO.	
PHONE	234-6334 ROME, GA. P.O. BOX 2225
TITLE	FLOOR PLAN
DWG. No.	18802
SHT. No.	1 OF 6