


**NOT FOR CONSTRUCTION**  
[CONTRACTOR TO FIELD VERIFY EXISTING  
CONDITIONS PRIOR TO PRICING THIS PLAN]

**PLAN LEGEND**

- EXISTING TO REMAIN
- WALL
  - PARTIAL HEIGHT WALL
  - WINDOW / SIDELIGHT
  - DOOR AND FRAME
- NEW / RELOCATED
- WALL
  - PARTIAL HEIGHT WALL
  - WINDOW / SIDELIGHT
  - BUILT-IN CASEWORK/  
PLUMBING FIXTURE
  - DOOR AND FRAME  
N = NEW METAL DOOR AND  
FRAME

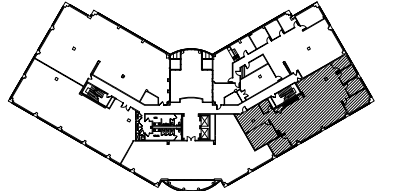

**SPEC SUITE**

LAKE POINTE IV | SUITE 210 | 8520 ALLISON POINTE BLVD. INDIANAPOLIS, IN 46240



3,714 RSF

2023.040  
DATE: 03.03.23  
PROJECT MGR: BNH  
SCALE: 1/8" = 1'-0"  
REVISION: Δ

**NOT FOR CONSTRUCTION**  
[CONTRACTOR TO FIELD VERIFY EXISTING  
CONDITIONS PRIOR TO PRICING THIS PLAN]



**PLAN LEGEND**

EXISTING TO BE REMOVED

- WALL
- - - DOOR AND FRAME

EXISTING TO REMAIN

- WALL
- DOOR AND FRAME

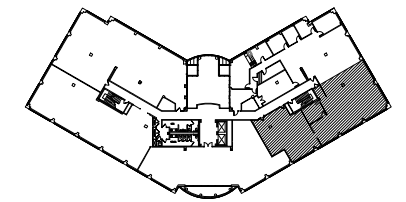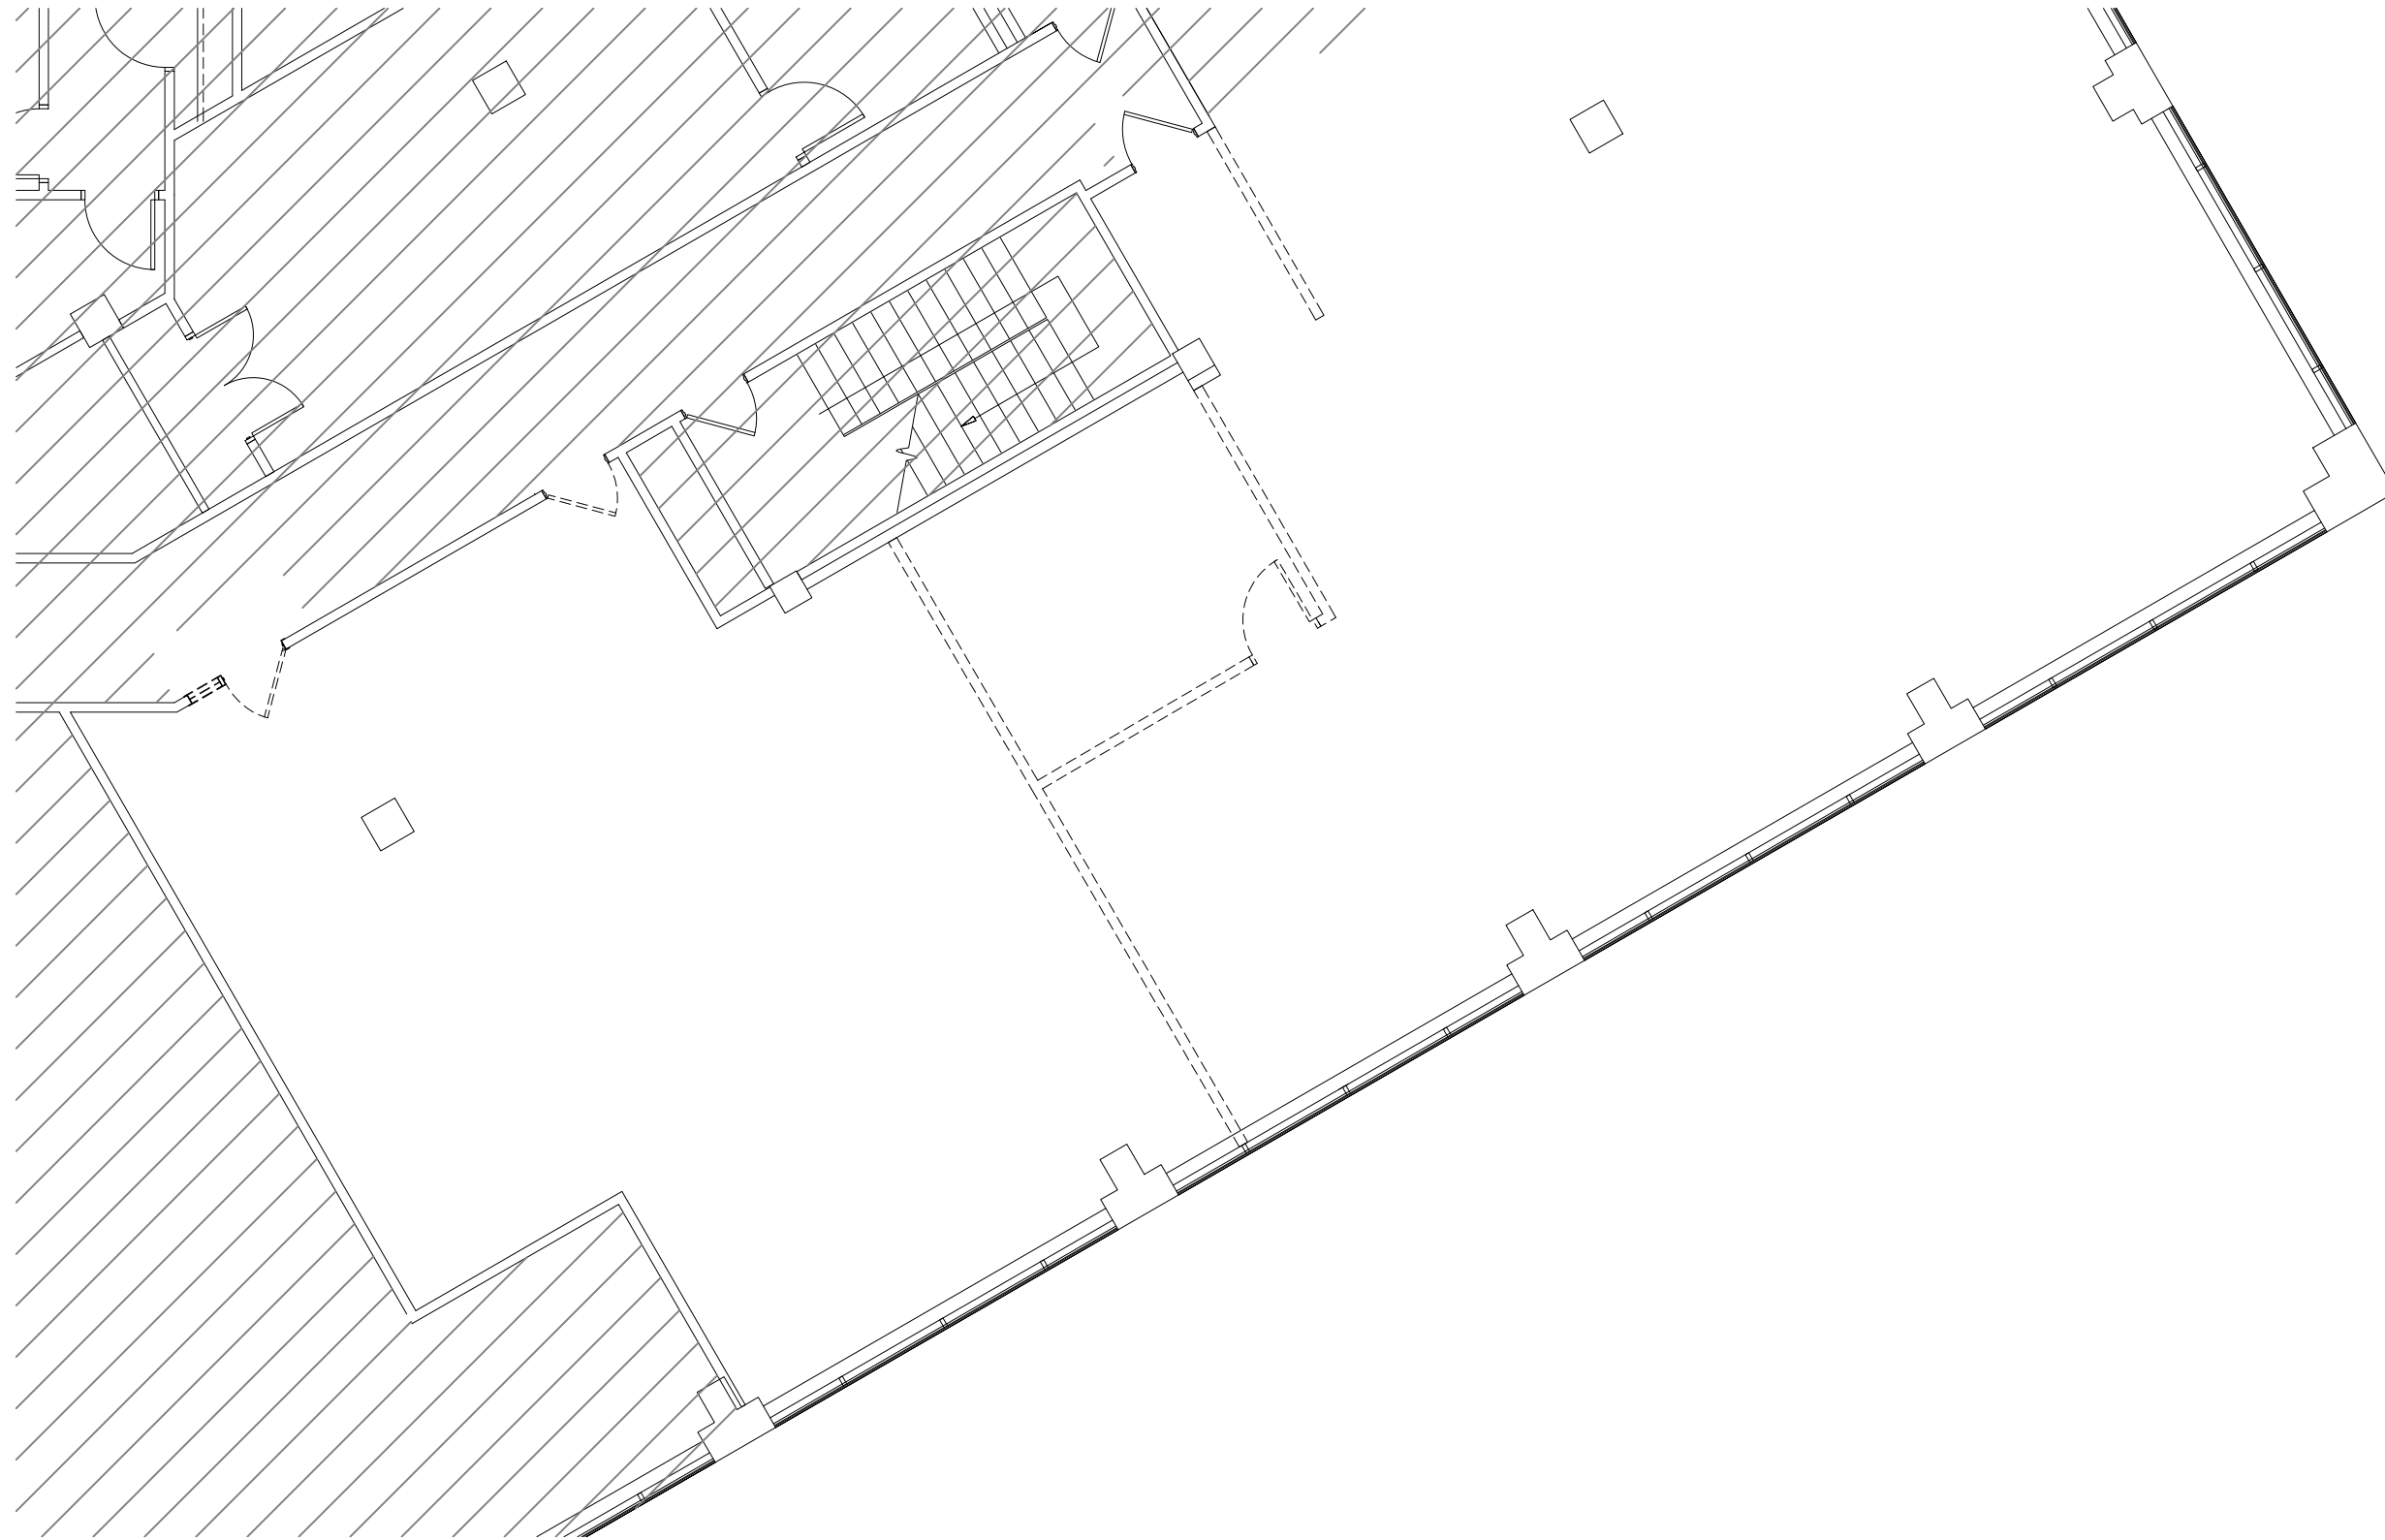

**DECONSTRUCTION  
SPEC SUITE**

LAKE POINTE IV | SUITE 210 | 8520 ALLISON POINTE BLVD. INDIANAPOLIS, IN 46240



3,714 RSF

REVISION  $\Delta$

SCALE: 1/8" = 1'-0"

PROJECT MGR: BNH

DATE: 03.03.23

2023.040