


RECEIVED  
VILLAGE OF HEMPSTEAD  
2006 SEP -8 AM 10:13  
BUILDING DEPARTMENT

BUILDING DEPARTMENT  
INC. VILLAGE OF HEMPSTEAD  
THESE PLANS ARE ACCEPTED AS PROPOSED  
CONSTRUCTION BUT EXAMINATION DOES NOT  
MEAN APPROVAL OR ANY LIABILITY  
THEREFORE THEY MUST MEET ALL  
REQUIREMENTS OF ALL APPLICABLE LAWS  
OR ORDINANCES WHETHER OR NOT CORRECTLY  
OR INCORRECTLY SHOWN.

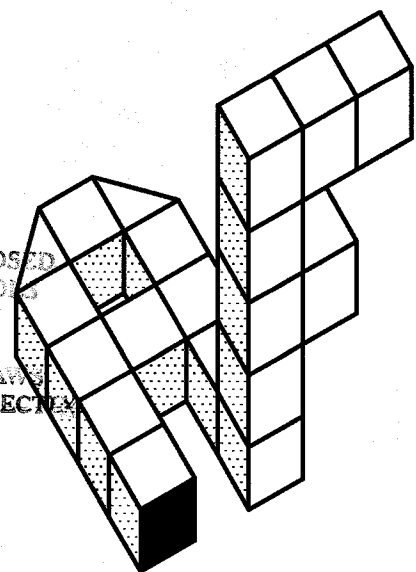

ART & FORM

ARCHITECTURE

158 Broadway (Route 110)


Amityville, NY 11701

631-264-8972 FAX 631-264-8989

E-mail: adam@artandform.com

THESE PLANS ARE AN  
INSTRUMENT OF SERVICE  
AND OR THE PROPERTY  
OF THE ARCHITECT  
INFRINGEMENTS WILL  
BE PROSECUTED.

| DATE     | DESCRIPTION              | BY  | CHK. |
|----------|--------------------------|-----|------|
| 08-24-05 | ISSUED TO BUILDING DEPT. | JCM |      |
| 09-24-05 | ISSUED TO PLANNING BOARD | JCM |      |

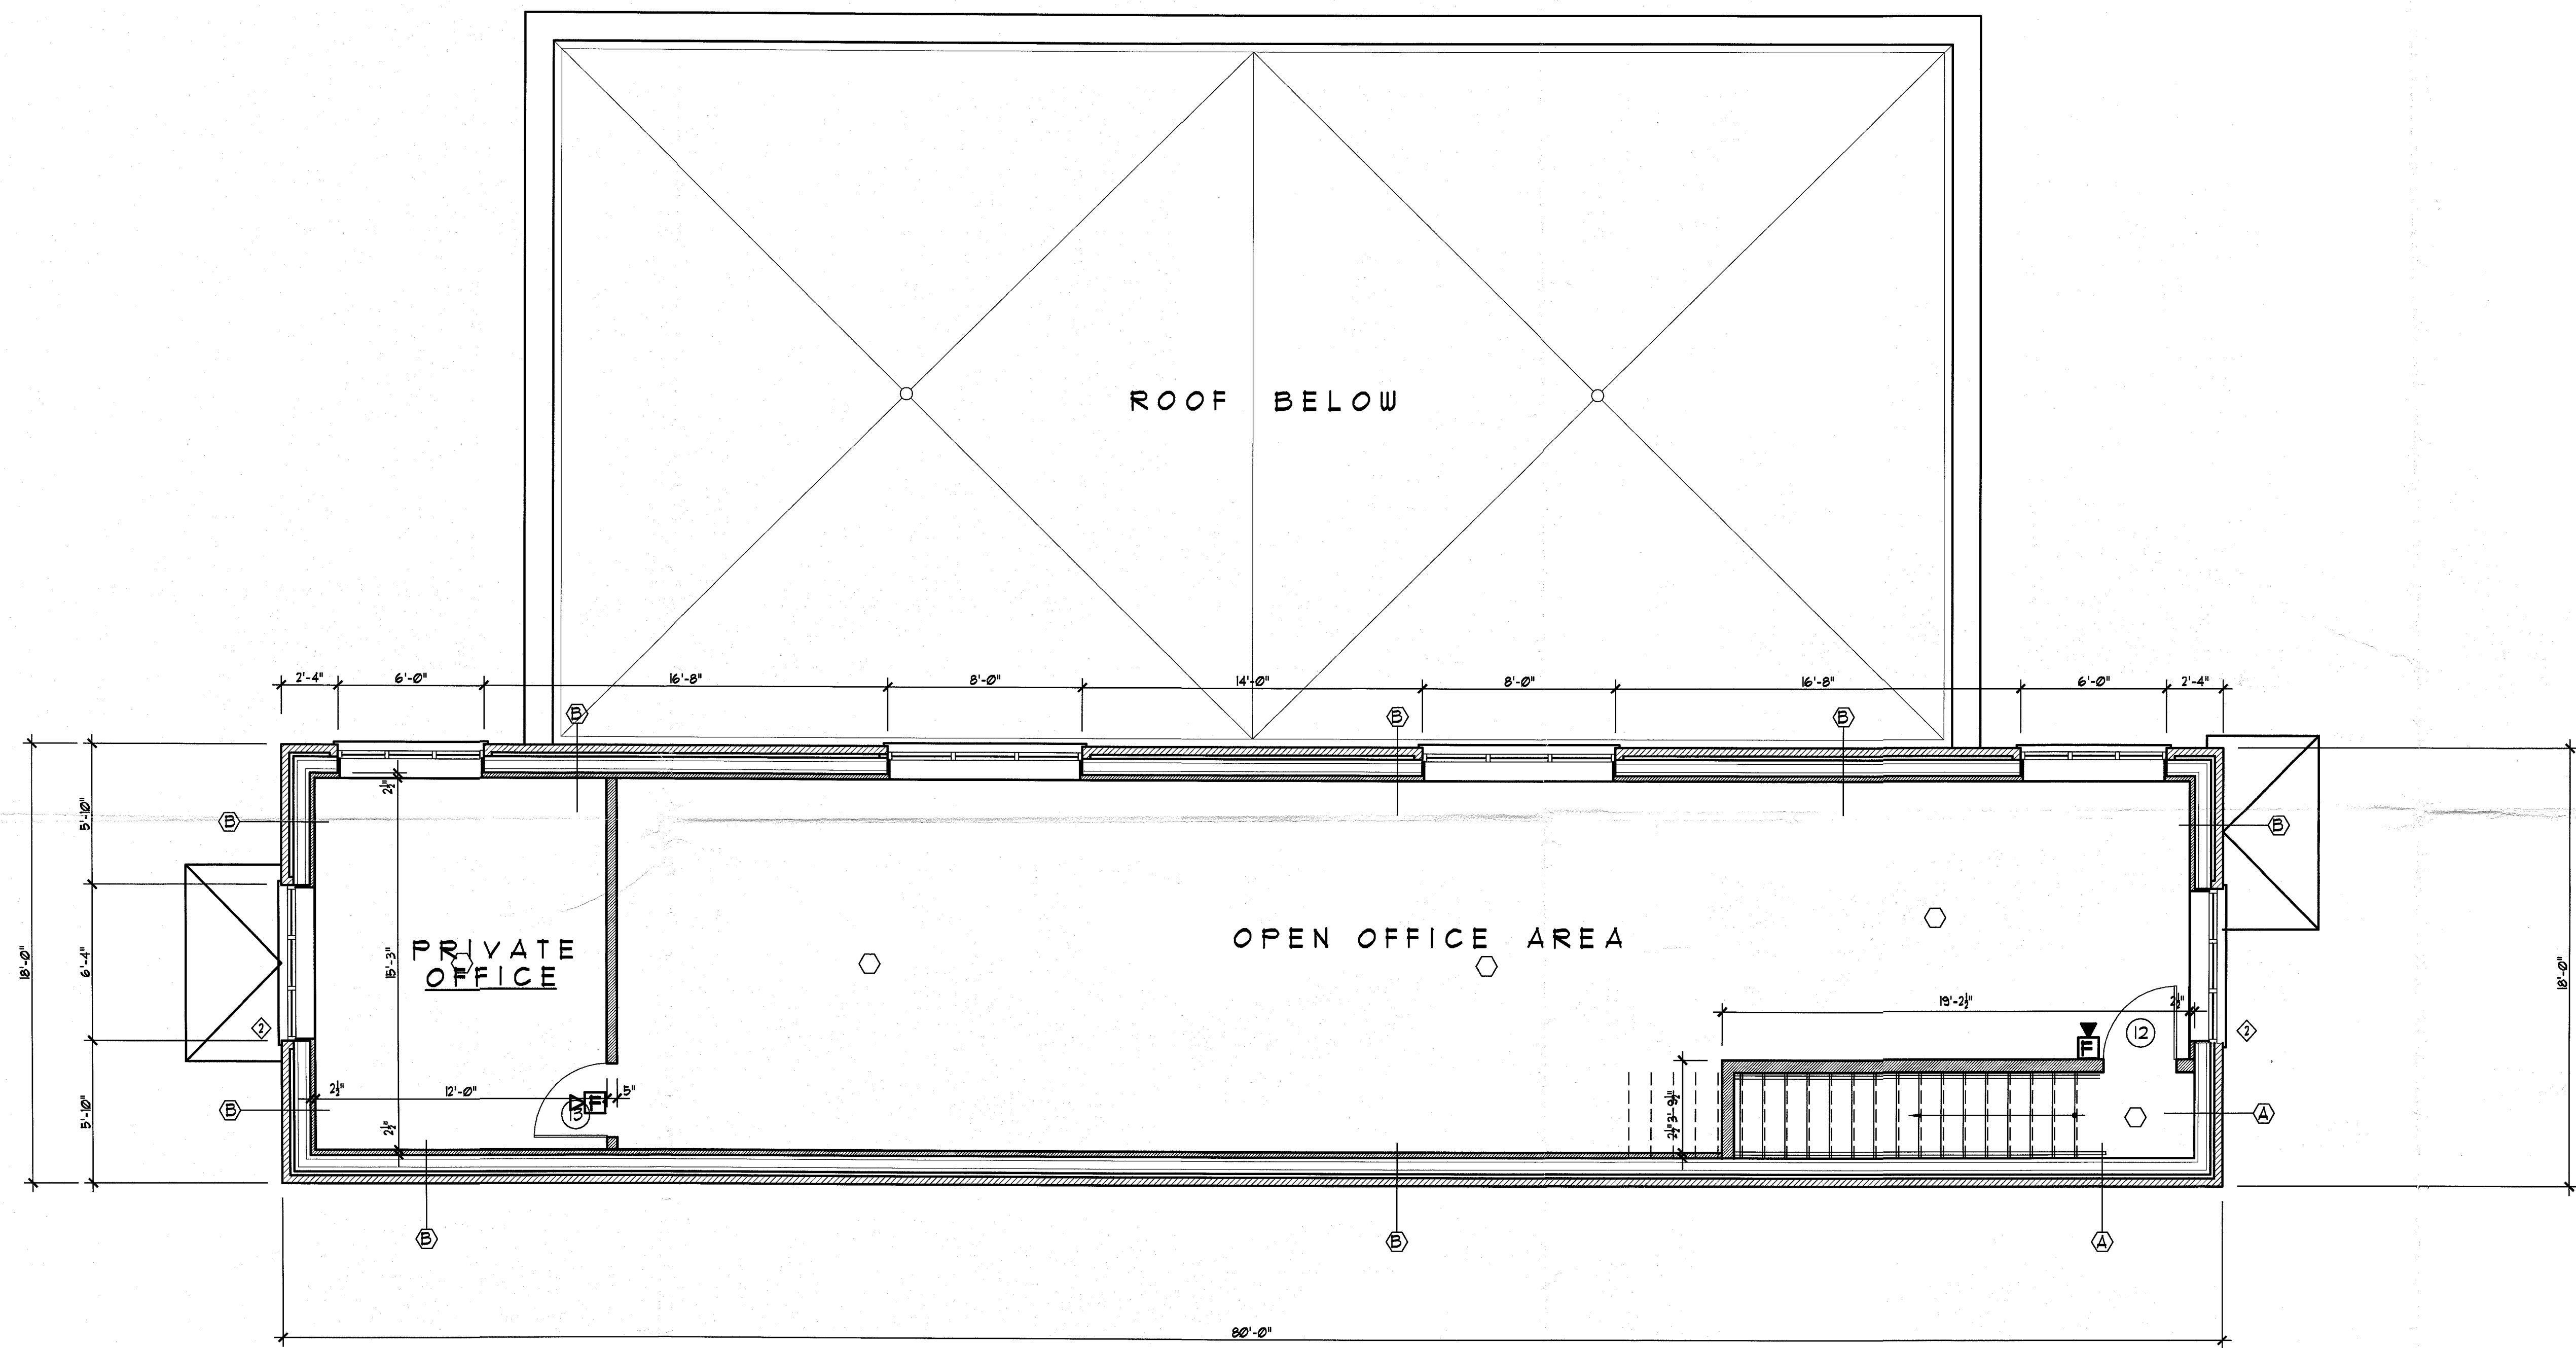


SECOND FLOOR PLAN

SCALE 1/4" = 1'-0"


LINTEL SCHEDULE

- ◆ I 1/8"x5 1/2"x12" CONTINUOUS BEARING PLATE  
MINIMUM 8" BEARING • EACH END
- ◆ LL (3) 3 1/2"x3 1/2"x5/8" MINIMUM 4" BEARING  
• EACH END


PARTITION LEGEND

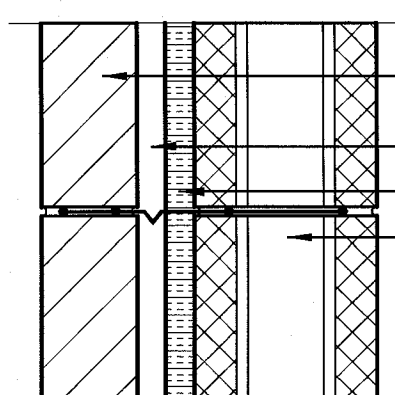


A

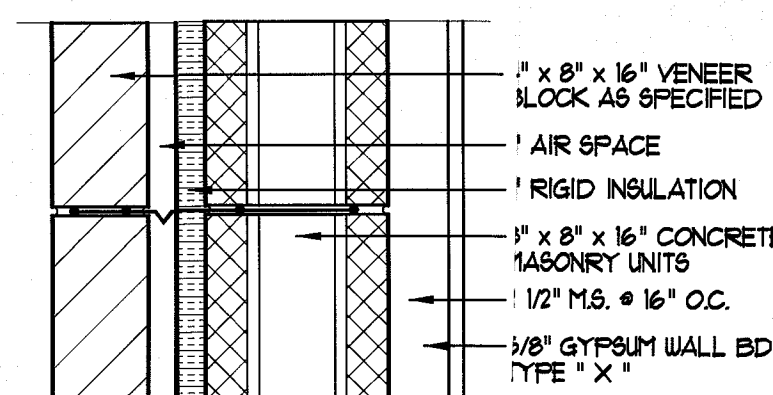

B

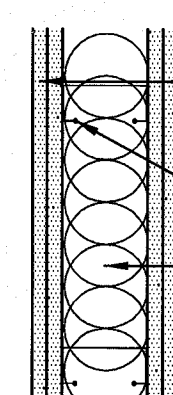

C

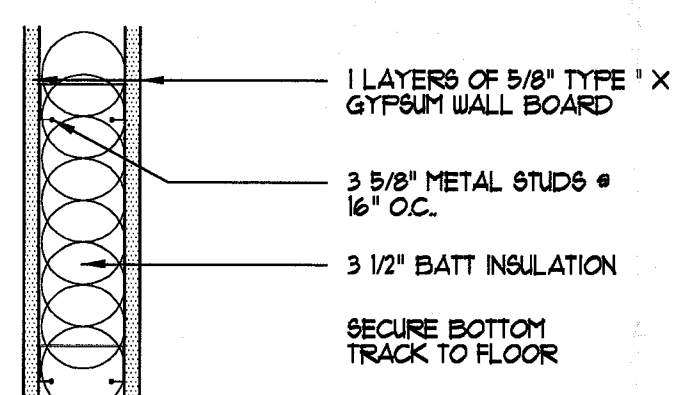

D

CROSS CONNECTION CONTROL DEVICE  
REQUIRED AT WATER SERVICE  
BACKFLOW PREVENTER  
NEW YORK STATE DEPT. OF HEALTH

SPRINKLER SYSTEM  
REQUIRED

ELECTRICAL PERMIT REQUIRED  
PLUMBING PERMIT REQUIRED

SMOKE AND FIRE  
DETECTOR DRAWING IS APPROVED  
SYSTEMS FOR CONSTRUCTION  
PERMIT NO. 23784

DATE SEP 11 2006

BUILDING DEPARTMENT  
INC. VILLAGE OF HEMPSTEAD, NY

PROPOSED NEW BUILDING FOR:  
CENTRAL AUTO SERVICE

PENNSULA BOULEVARD  
HEMPSTEAD, NEW YORK



DRAWN BY:  
JCM  
CHECKED BY:  
M.A.S.  
DATE:  
08-16-05  
PERMIT NO.  
23784  
DRAWING TITLE:

A-3