

PENNSYLVANIA:

One Doughboy Square
3400 Butler Street
Pittsburgh, PA 15201
Tel: 412.683.3230
Fax: 412.683.3563

WEST VIRGINIA:

265 High Street, Suite 7
Morgantown, WV 26505
Tel: 304.602.7880
Fax: 304.212.5393

ENGINEER LOGO


PRE-SCHEMATIC DESIGN FOR
207 HIGH STREET OFFICE
MORGANTOWN, WEST VIRGINIA

SEAL:

NOT FOR CONSTRUCTION

Drawn By: Author	Edited By: Designer	Checked By: Checker
---------------------	------------------------	------------------------

REVISIONS:

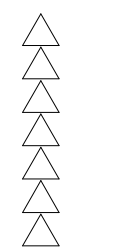

DATE:
Issue Date

PROJECT NUMBER:
Project Number

OWNER / CLIENT:
Owner

DRAWING TITLE:
FIRST FLOOR PLAN

DRAWING NUMBER:

A-101

Department Legend


- Common Area
- Conference
- Office
- Restroom
- Utility



① First Floor Plan
1/8" = 1'-0"

Department Legend

- Common Area
- Conference
- Office
- Restroom
- Utility

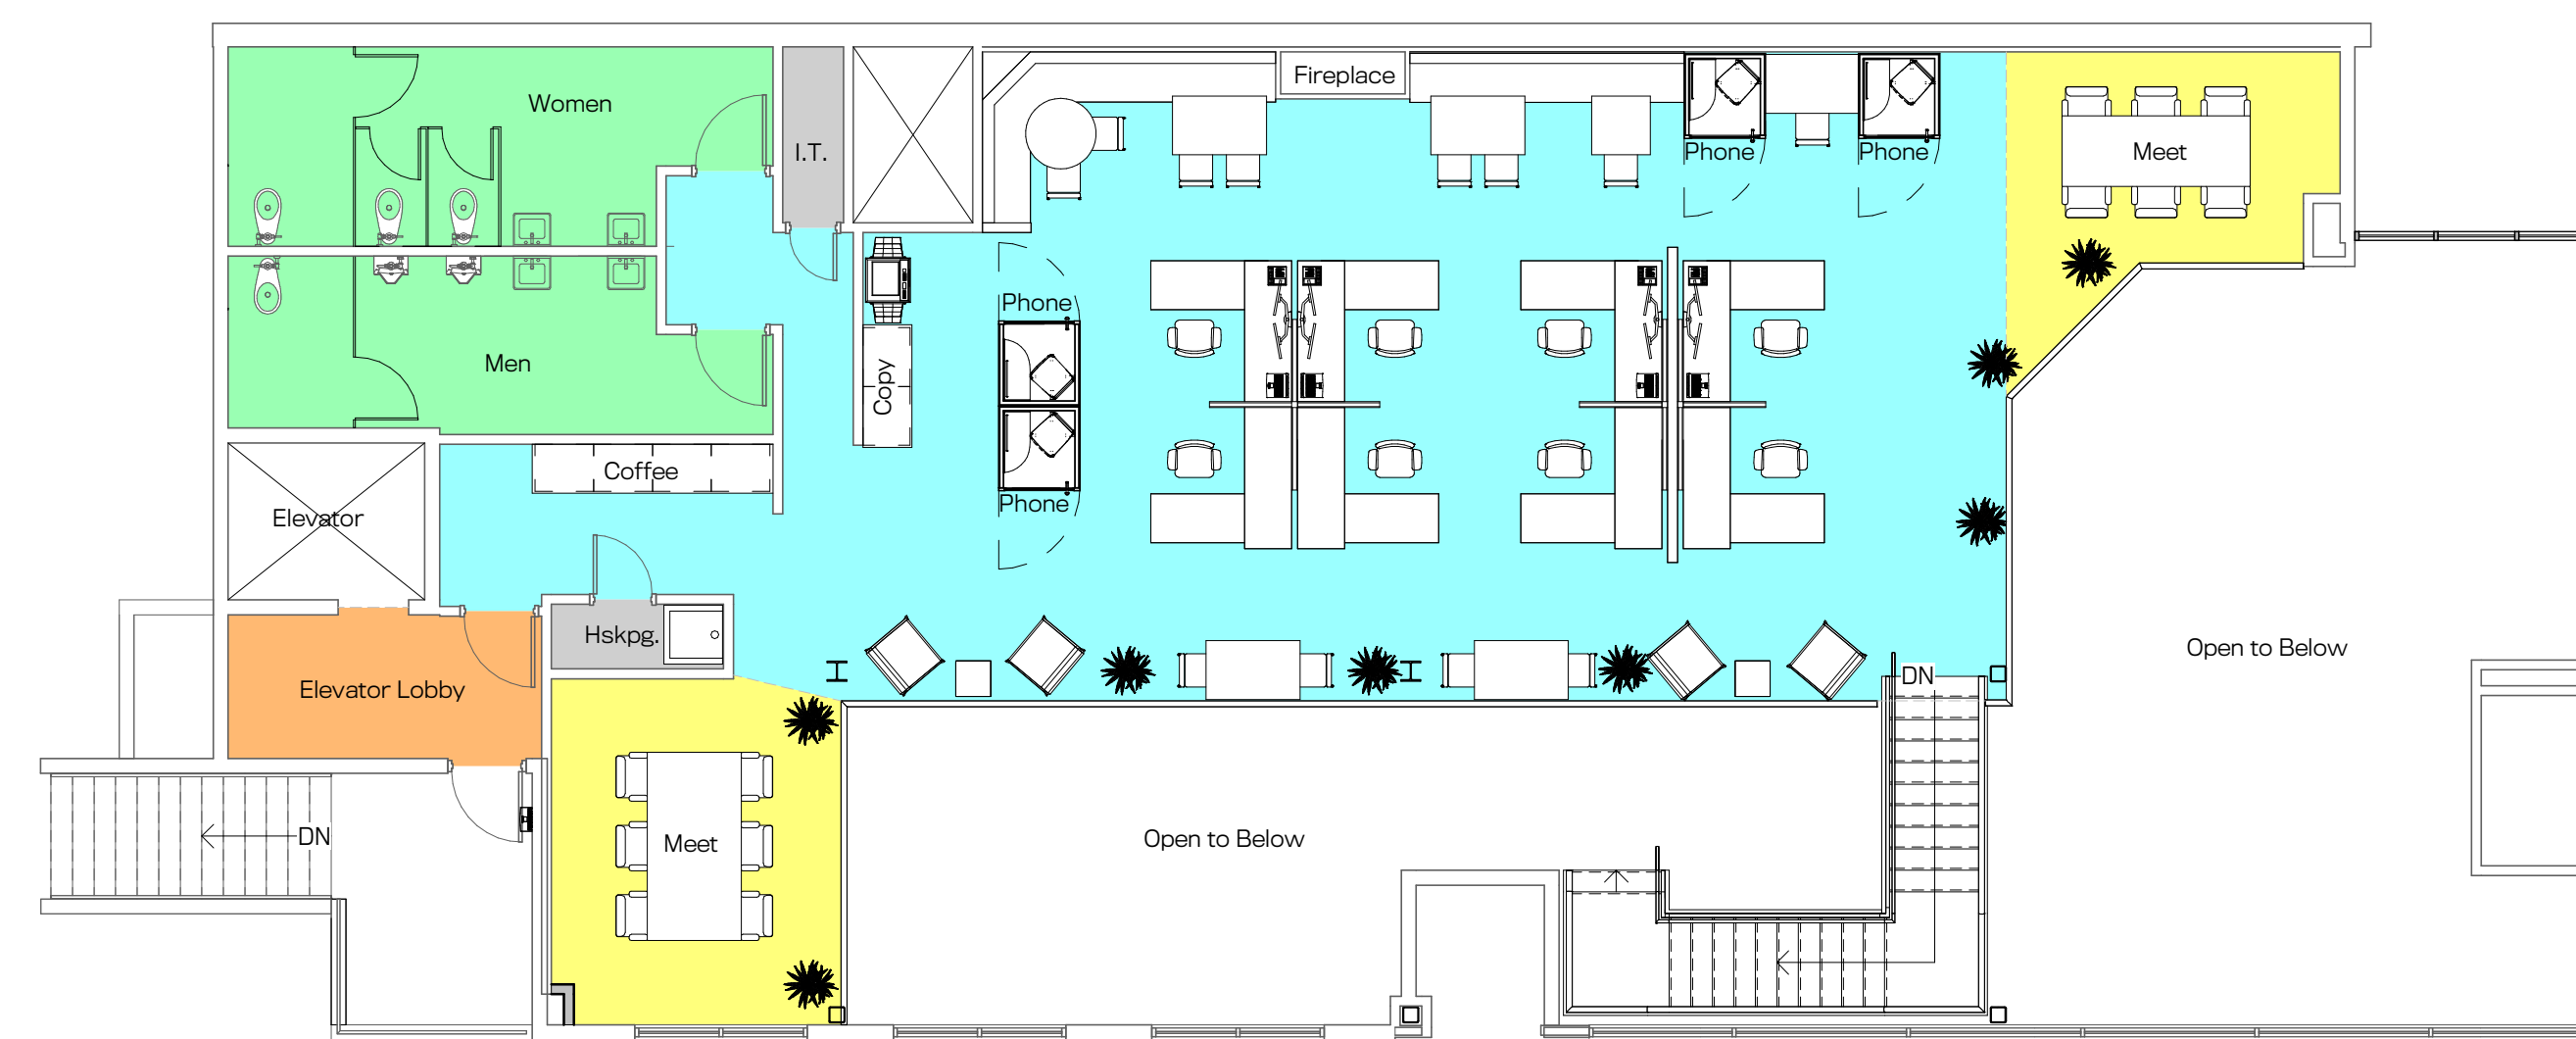

② Second Floor Plan
1/8" = 1'-0"