


REVISIONS		
NO.	DATE	DESCRIPTION
0	03/26/2021	PERMIT BID SET


HVAC FLOOR PLAN

M-101

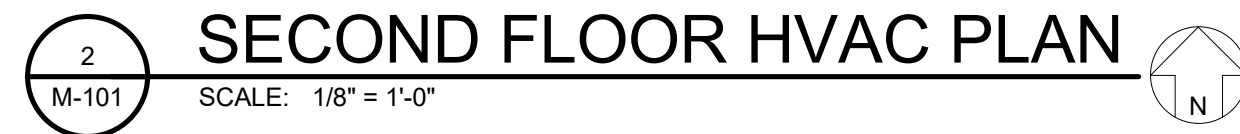

- 1
M-101
- # FIRST FLOOR HVAC PLAN
- SCALE: 1/8" = 1'-0"
- N



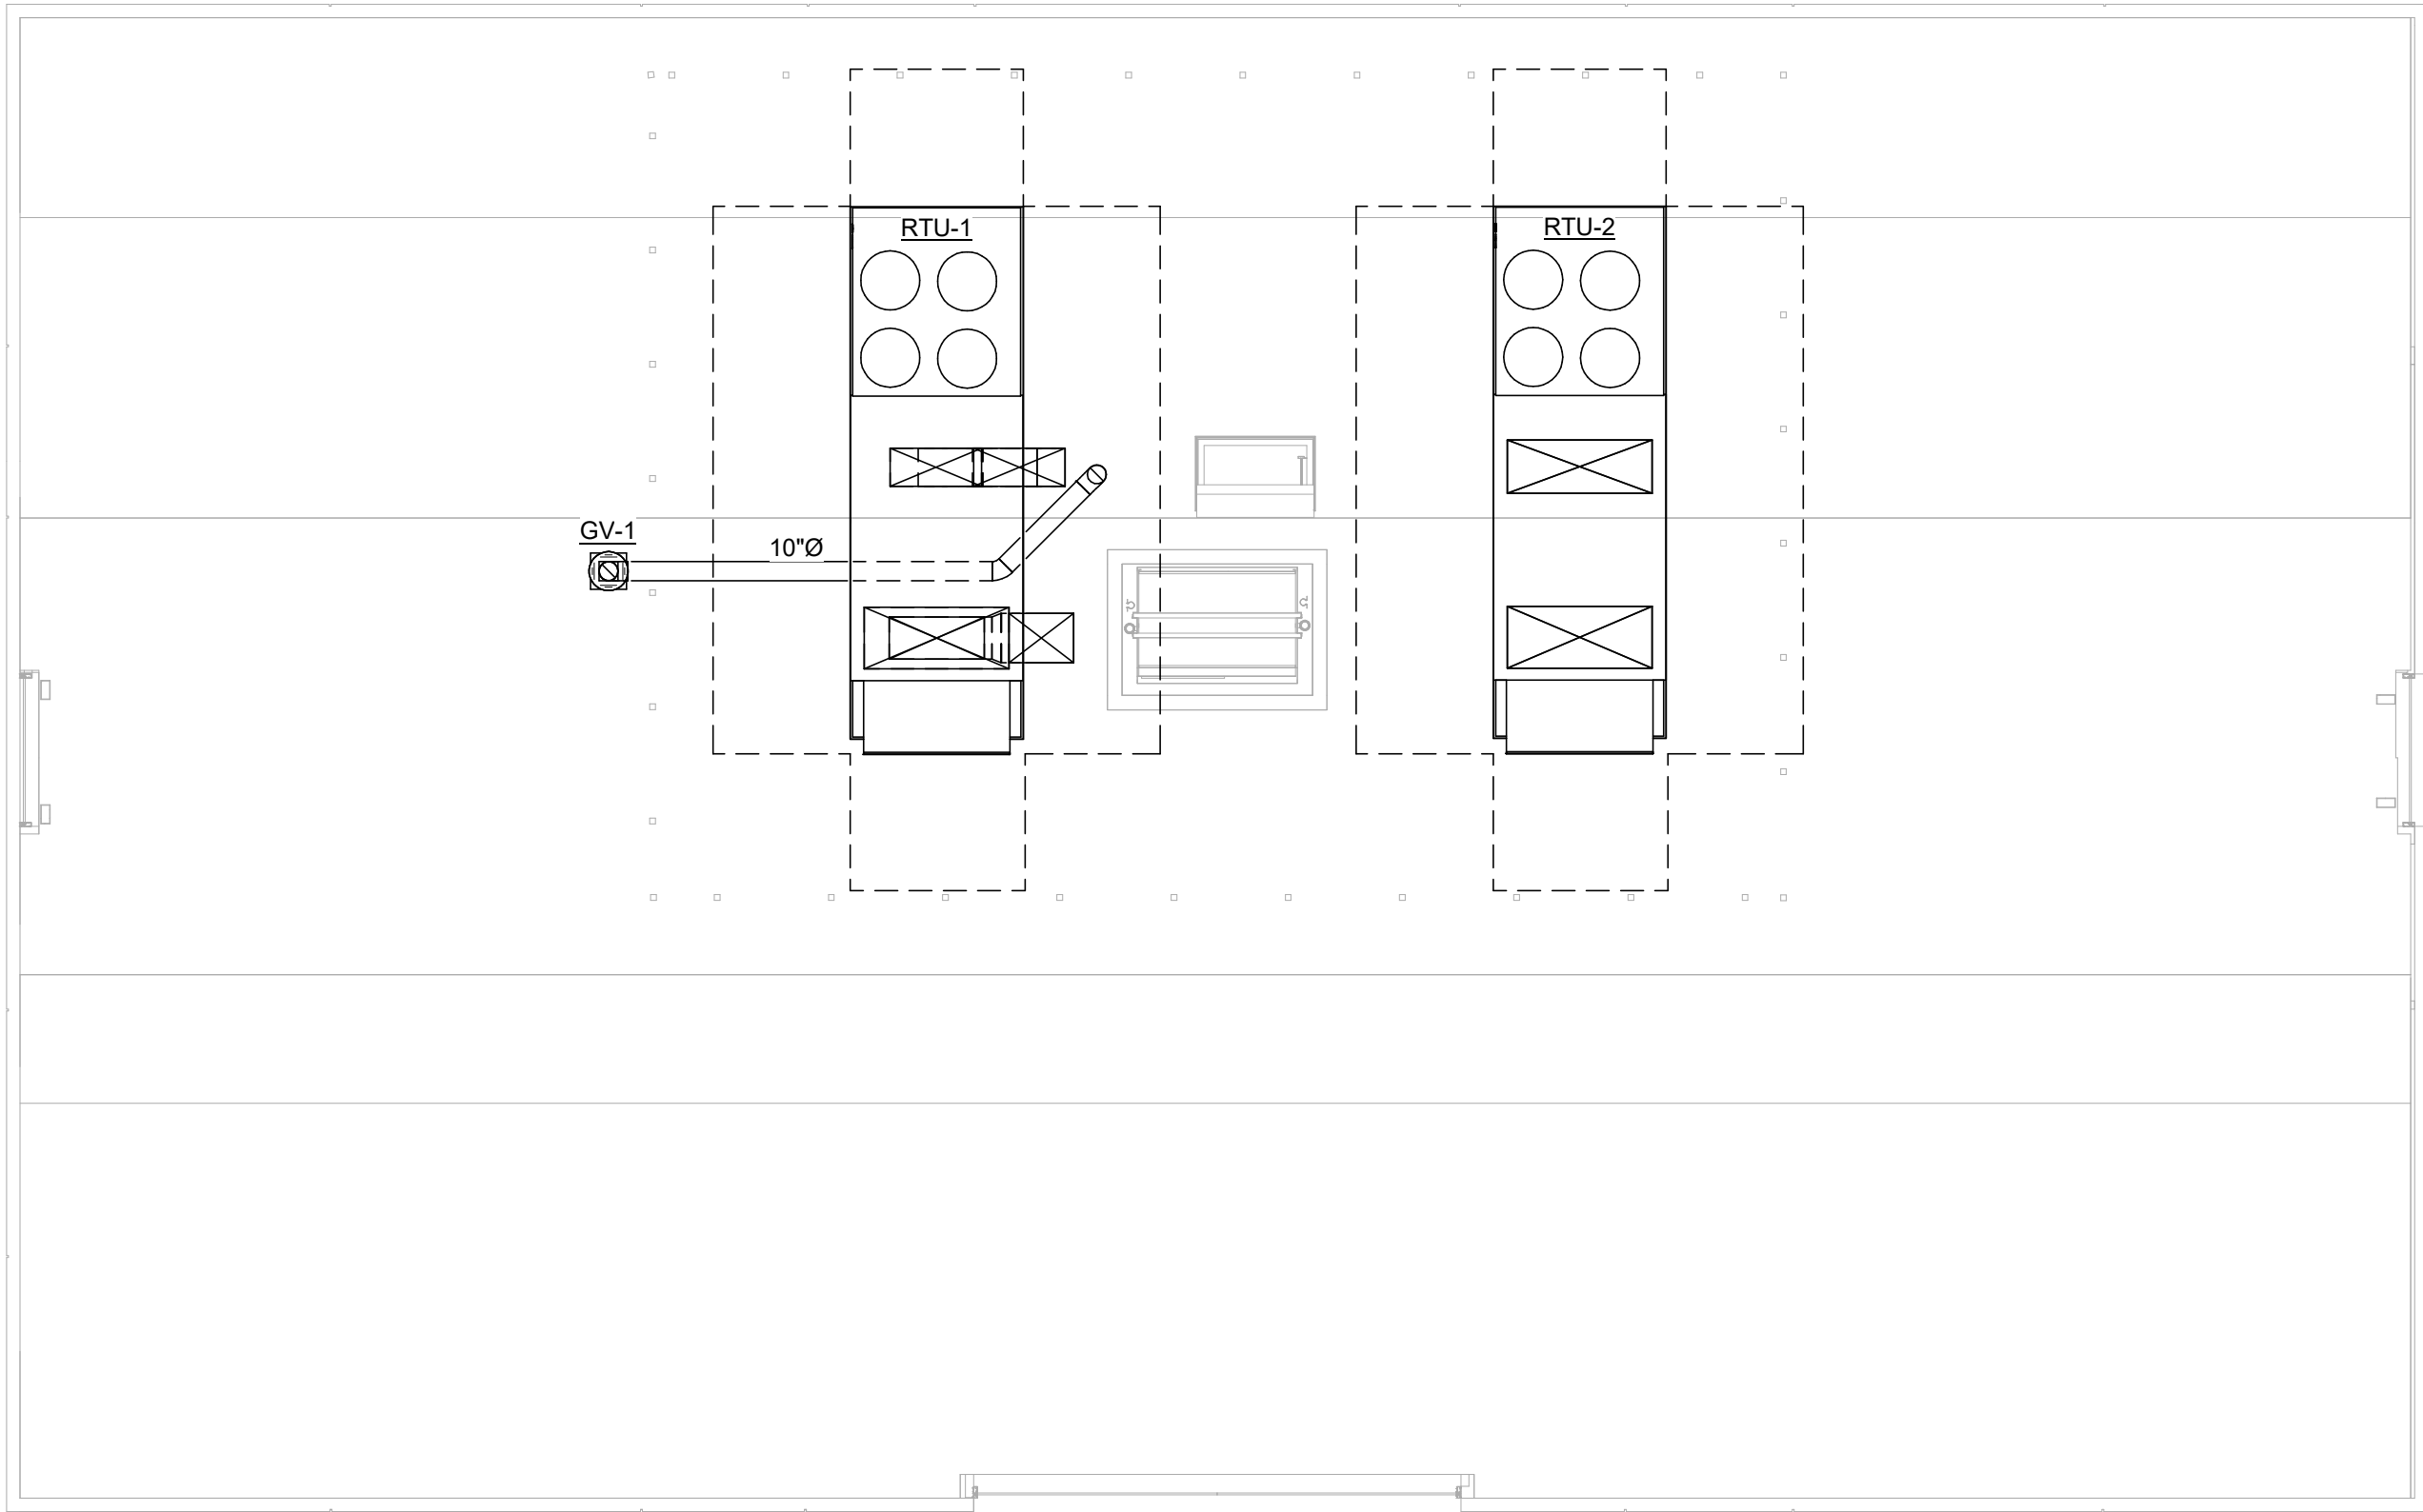


1
M-102

HVAC ROOF PLAN

SCALE: 1/8" = 1'-0"

N

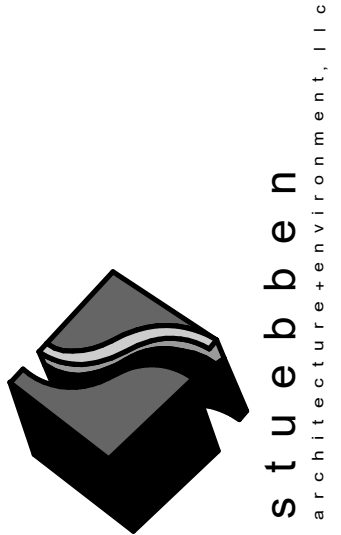

301 W. Bay Street,
Suite 1400
Jacksonville, FL 32202
904.229.5057
#A426003342

IKN

4266 PABLO
PROFESSIONAL CT
JACKSONVILLE FL
32224

REVISIONS		
NO.	DATE	DESCRIPTION
0	03/26/2021	PERMIT BID SET



McVEIGH & MANGUM
ENGINEERING · INC
Atlanta · Charlotte · Jacksonville · Raleigh
www.McVeighMangum.com
9133 R.G. Skinner Parkway
Jacksonville, Florida 32256
Ph: (904) 483-5200
email: mail@McVeighMangum.com
CA 6330
Eng. of Record: Kenneth L. Gonzalez License No. 61015

DESIGNER
Designer

ISSUE DATE
2021-03-26

DOCUMENT EDITOR
Author

SCALE
AS INDICATED



**HVAC ROOF
PLAN**

M-102

1
M-201

CONCEALED DUCTWORK INSTALLATION DETAIL

SCALE: NTS

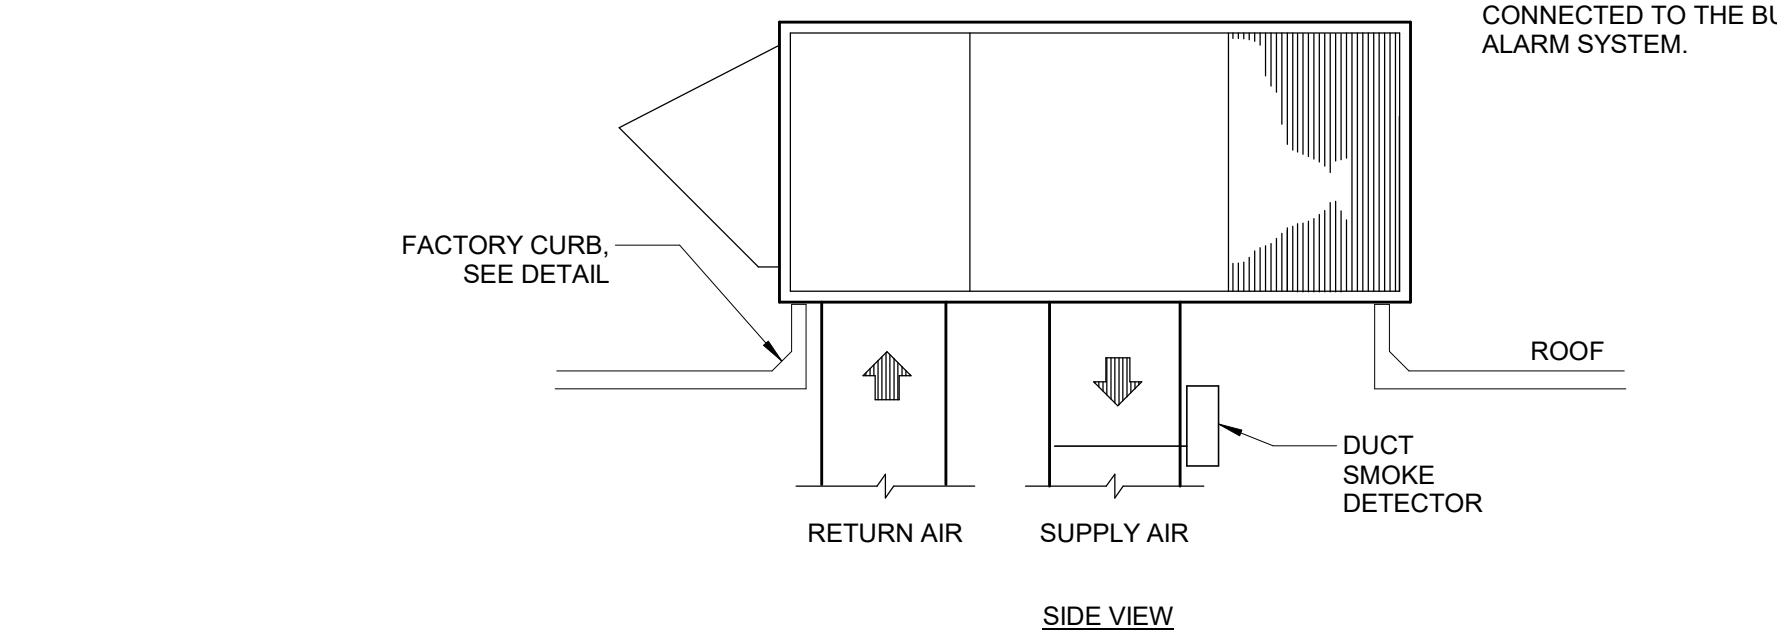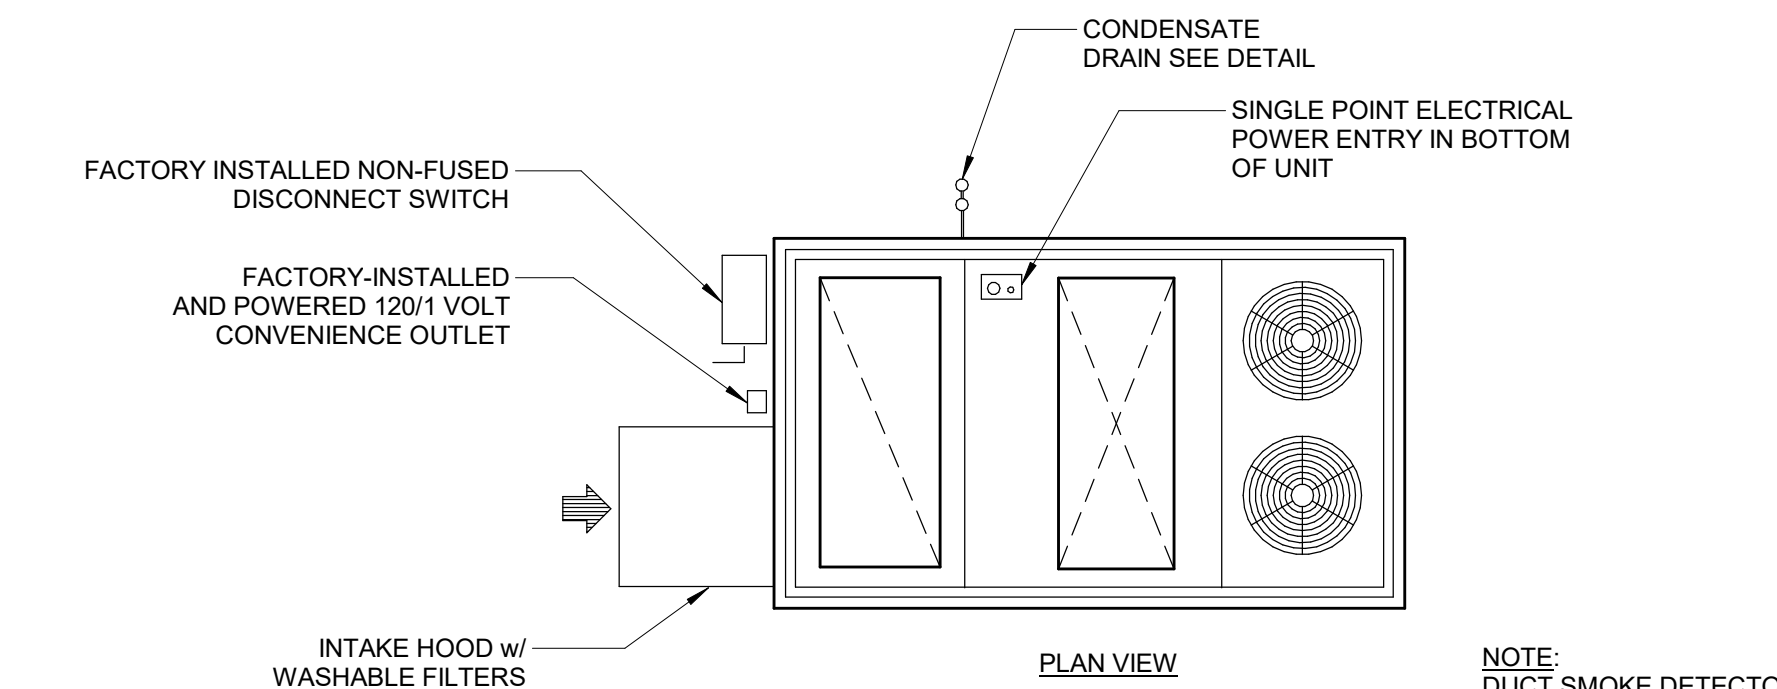

5
M-201

ROOFTOP UNIT DETAIL


SCALE: NTS



2
M-201

DUCT SUPPORT DETAIL


SCALE: NTS

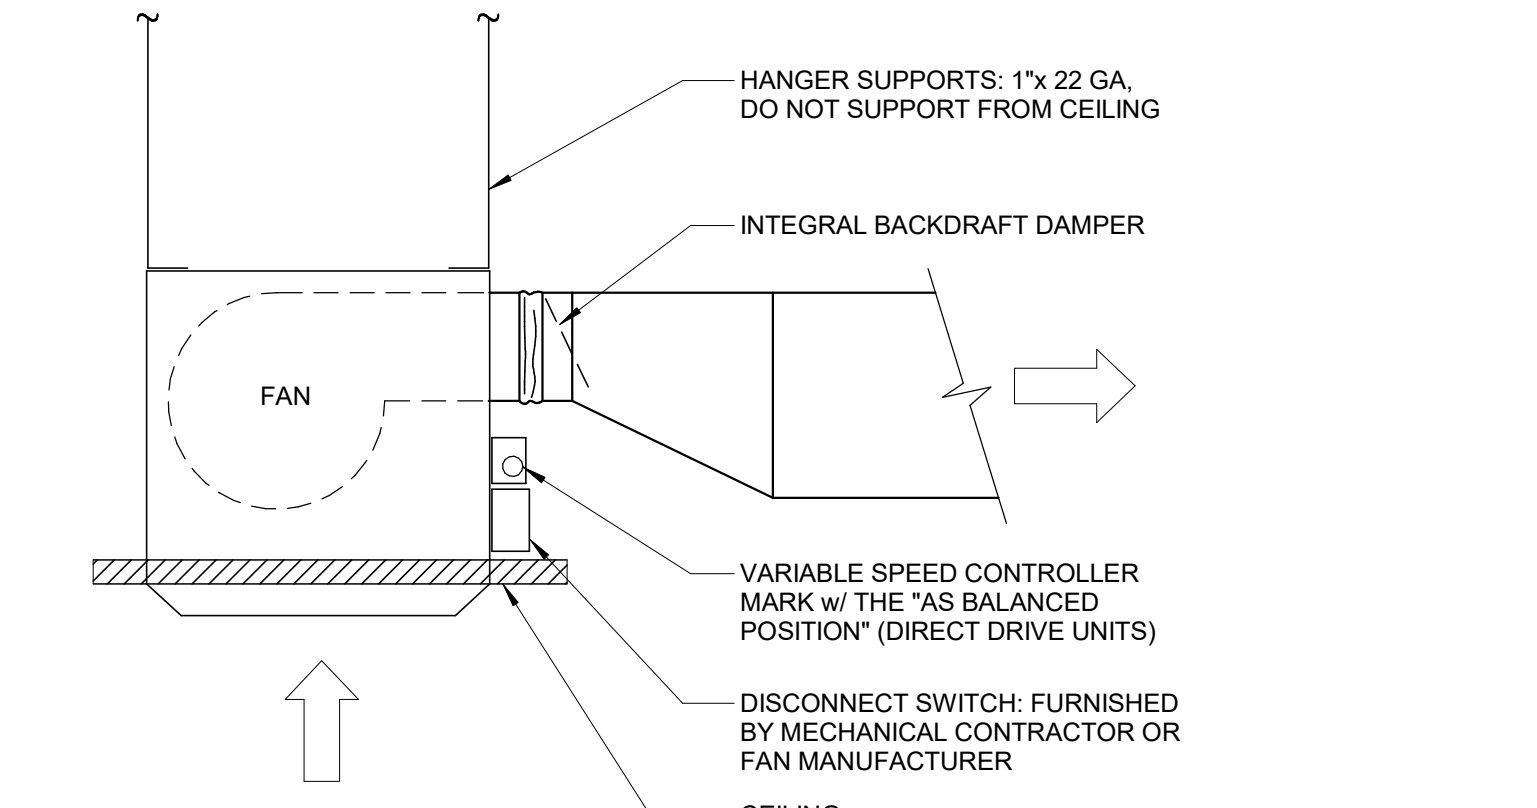

6
M-201

CEILING MOUNTED FAN DETAIL

SCALE: NTS

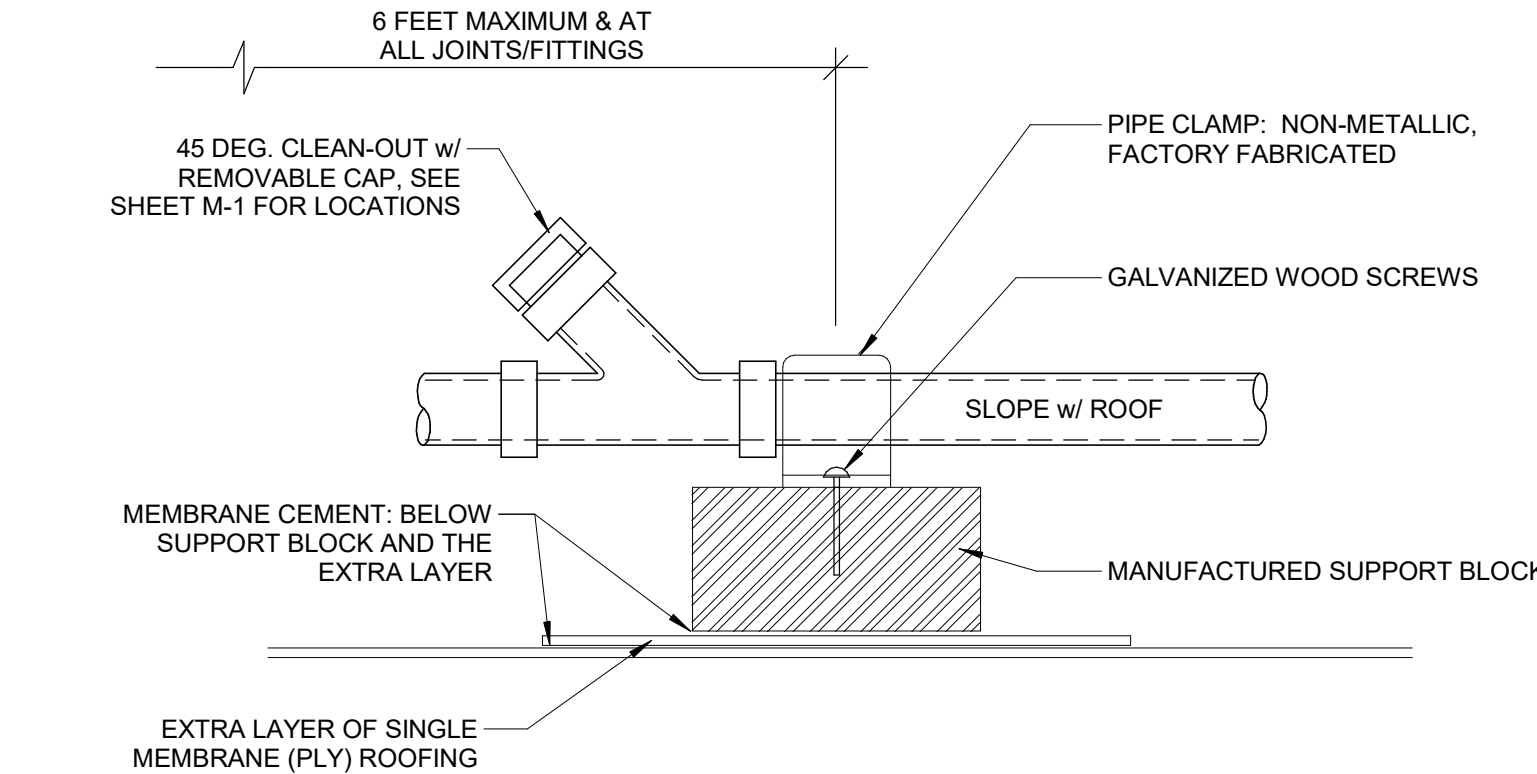

7
M-201


CONDENSATE DRAIN PIPE SUPPORT DETAIL

SCALE: NTS

4
M-201

DUCT MOUNTED SMOKE DETECTOR DIAGRAM

SCALE: NTS

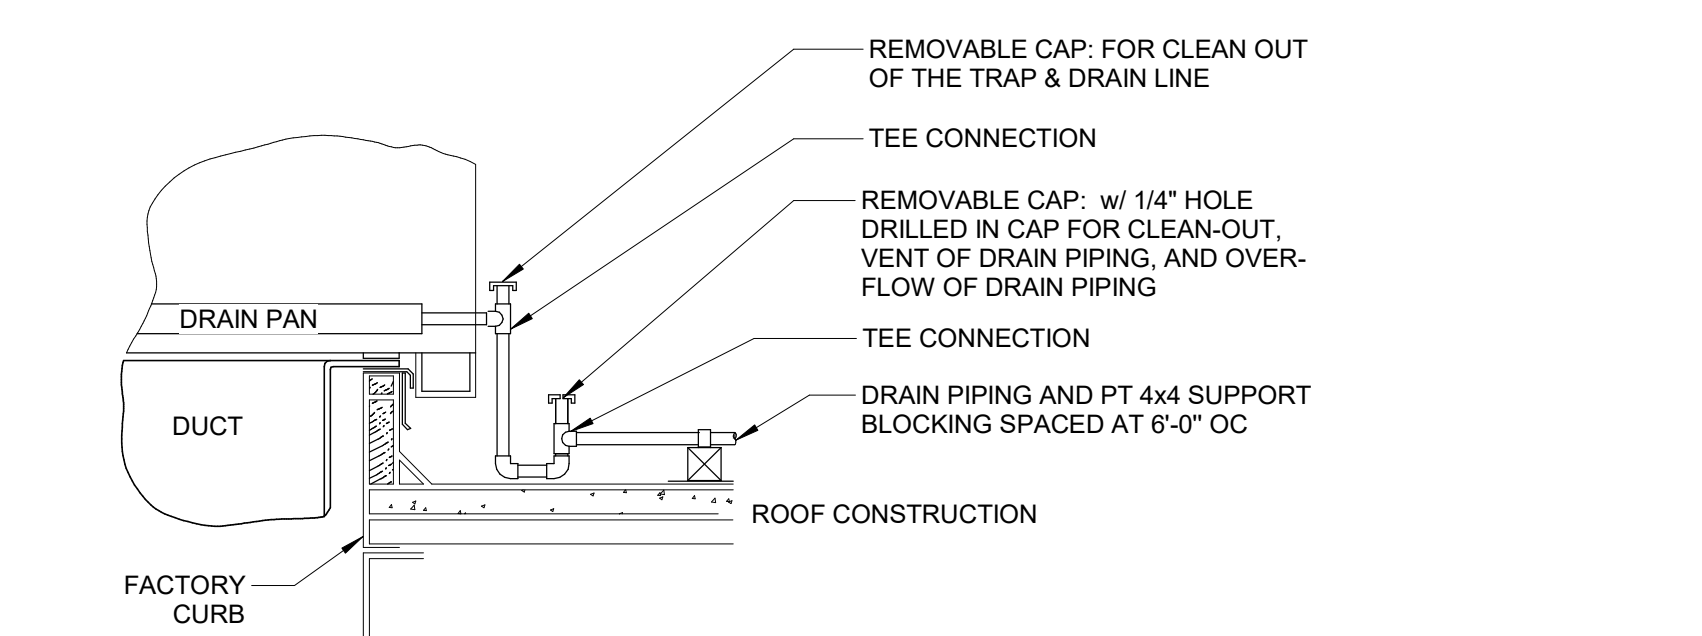

8
M-201

ROOFTOP UNIT CONDENSATE DRAIN DETAIL

SCALE: NTS



McVEIGH & MANGUM
ENGINEERING · INC
Atlanta · Charlotte · Jacksonville · Raleigh
www.McVeighMangum.com
9133 R.G. Skinner Parkway
Jacksonville, Florida 32256
Ph: (904) 483-5200
email: mail@McVeighMangum.com
CA 6330
Eng. of Record: Kenneth L. Gonzalez License No. 61015

301 W. Bay Street,
Suite 1408
Jacksonville, FL 32202
904.229.5057
904.260.3342

IKN


4266 PABLO
PROFESSIONAL CT
JACKSONVILLE FL
32224

REVISIONS		
NO.	DATE	DESCRIPTION
0	03/26/2021	PERMIT BID SET

DESIGNER
Designer
ISSUE DATE
2021-03-26
DOCUMENT EDITOR
Author
SCALE:
AS INDICATED


DETAILS

M-201

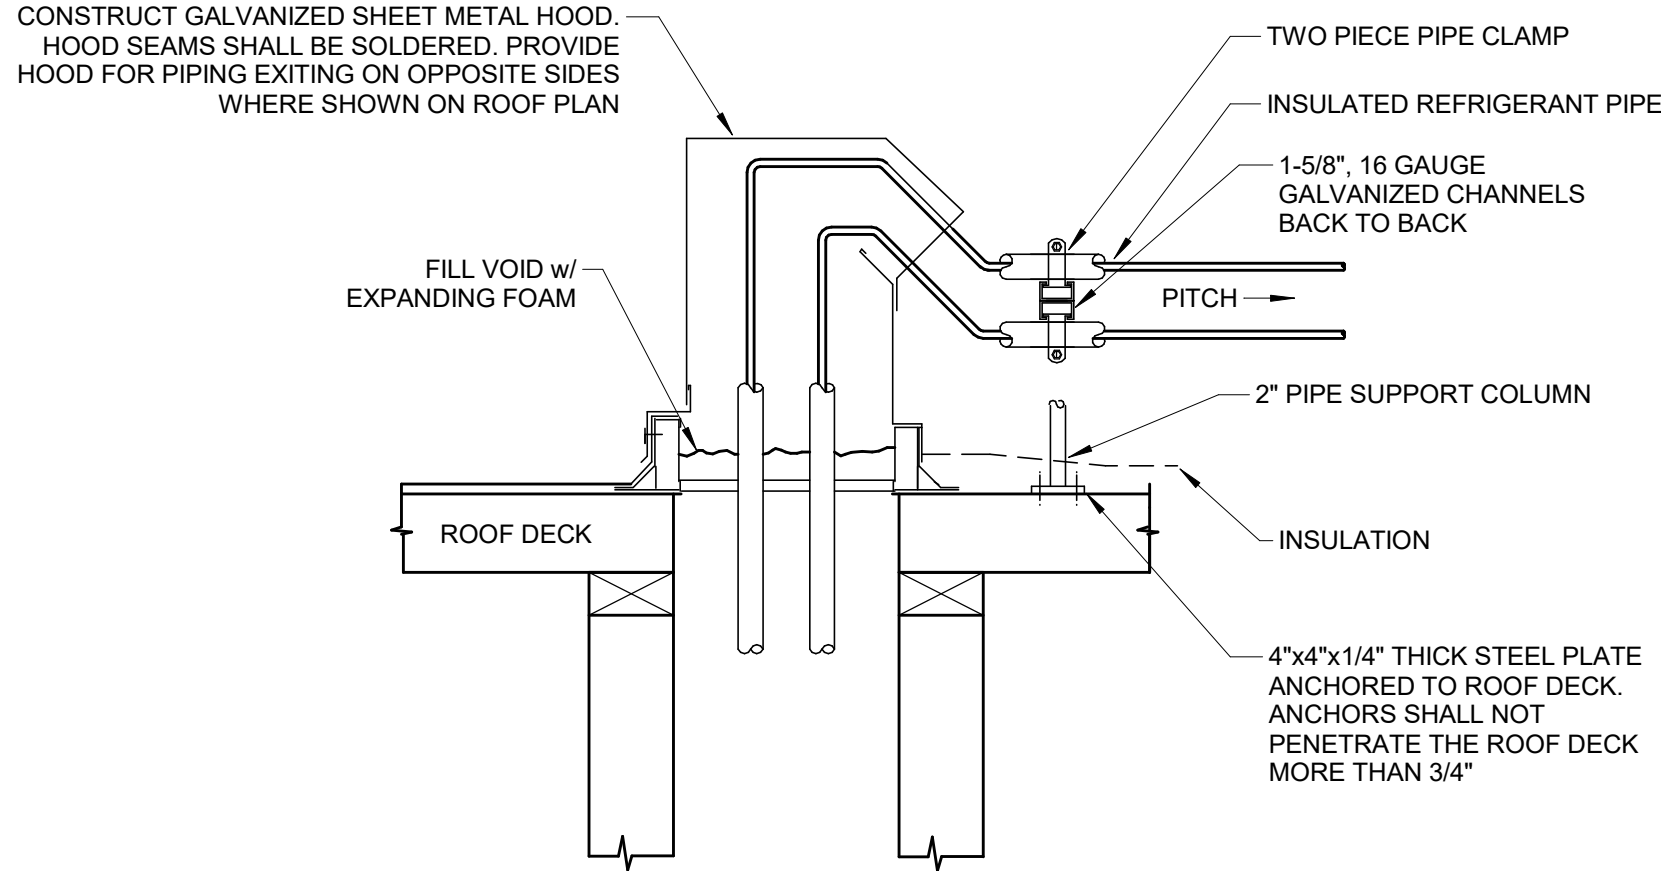


- NOTES:
1. FLASH AROUND PIPING SUPPORT COLUMN.
 2. PIPING SHALL BE SLOPED TOWARD THE CONDENSING UNITS.
 3. PIPING INSULATION SHALL BE FINISHED w/ TWO COATS OF UV RESISTANT COATING.

1
M-202
REFRIGERANT PIPING ROOF CURB
SCALE: 1/4" = 1'-0"

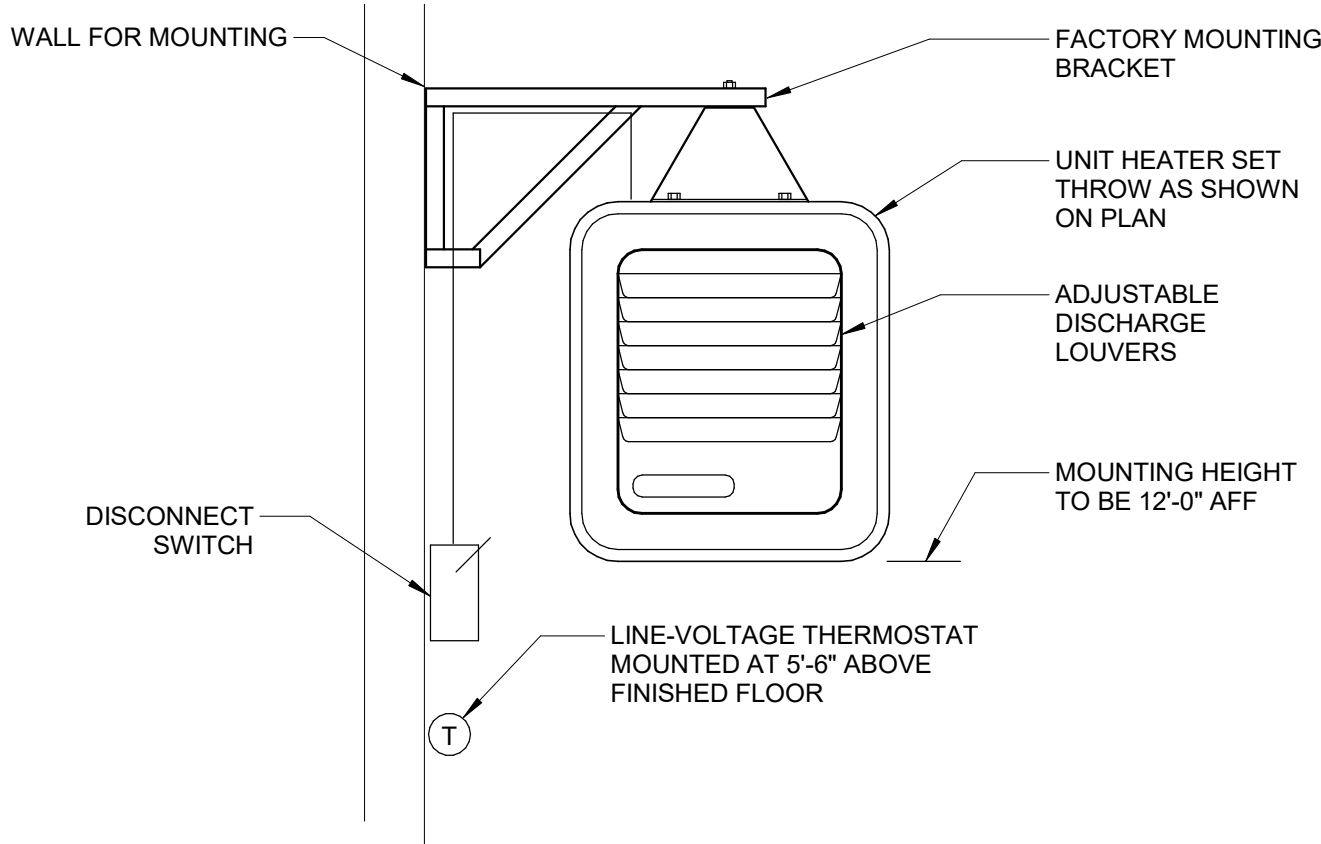

2
M-202
ELECTRIC UNIT HEATER DETAIL
SCALE: NTS

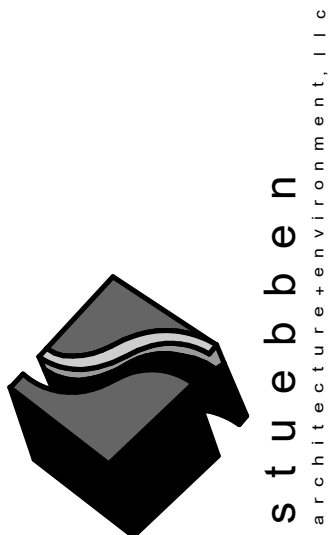

301 W. Bay Street,
Suite 1408
Jacksonville, FL 32202
904.229.5057
904.260.3342

IKN

4266 PABLO
PROFESSIONAL CT
JACKSONVILLE FL
32224

REVISIONS

NO.	DATE	DESCRIPTION
0	03/26/2021	PERMIT BID SET

DESIGNER Designer
ISSUE DATE 2021-03-26
DOCUMENT EDITOR Author
SCALE AS INDICATED

DETAILS

M-202

McVEIGH & MANGUM
ENGINEERING · INC
Atlanta · Charlotte · Jacksonville · Raleigh
www.McVeighMangum.com
9133 R.G. Skinner Parkway
Jacksonville, Florida 32256
Ph: (904) 483-5200
email: mail@McVeighMangum.com
CA 6330 License No. 61015
Eng. of Record: Kenneth L. Gonzalez