

NOT FOR CONSTRUCTION
[CONTRACTOR TO FIELD VERIFY EXISTING
CONDITIONS PRIOR TO PRICING THIS PLAN]



PLAN LEGEND

EXISTING TO REMAIN

- WALL
- PARTIAL HEIGHT WALL
- WINDOW / SIDELIGHT
- DOOR AND FRAME

NEW / RELOCATED

- WALL
- PARTIAL HEIGHT WALL
- WINDOW / SIDELIGHT
- BUILT-IN CASEWORK/
PLUMBING FIXTURE
- DOOR AND FRAME
 - R = RELOCATED FROM
DECONSTRUCTION, PAINTED
 - N = NEW TO MATCH EXISTING
 - G = FRAMELESS GLASS SYSTEM

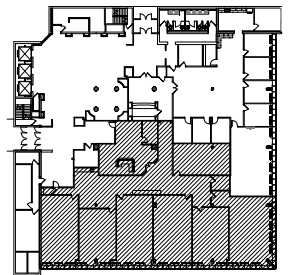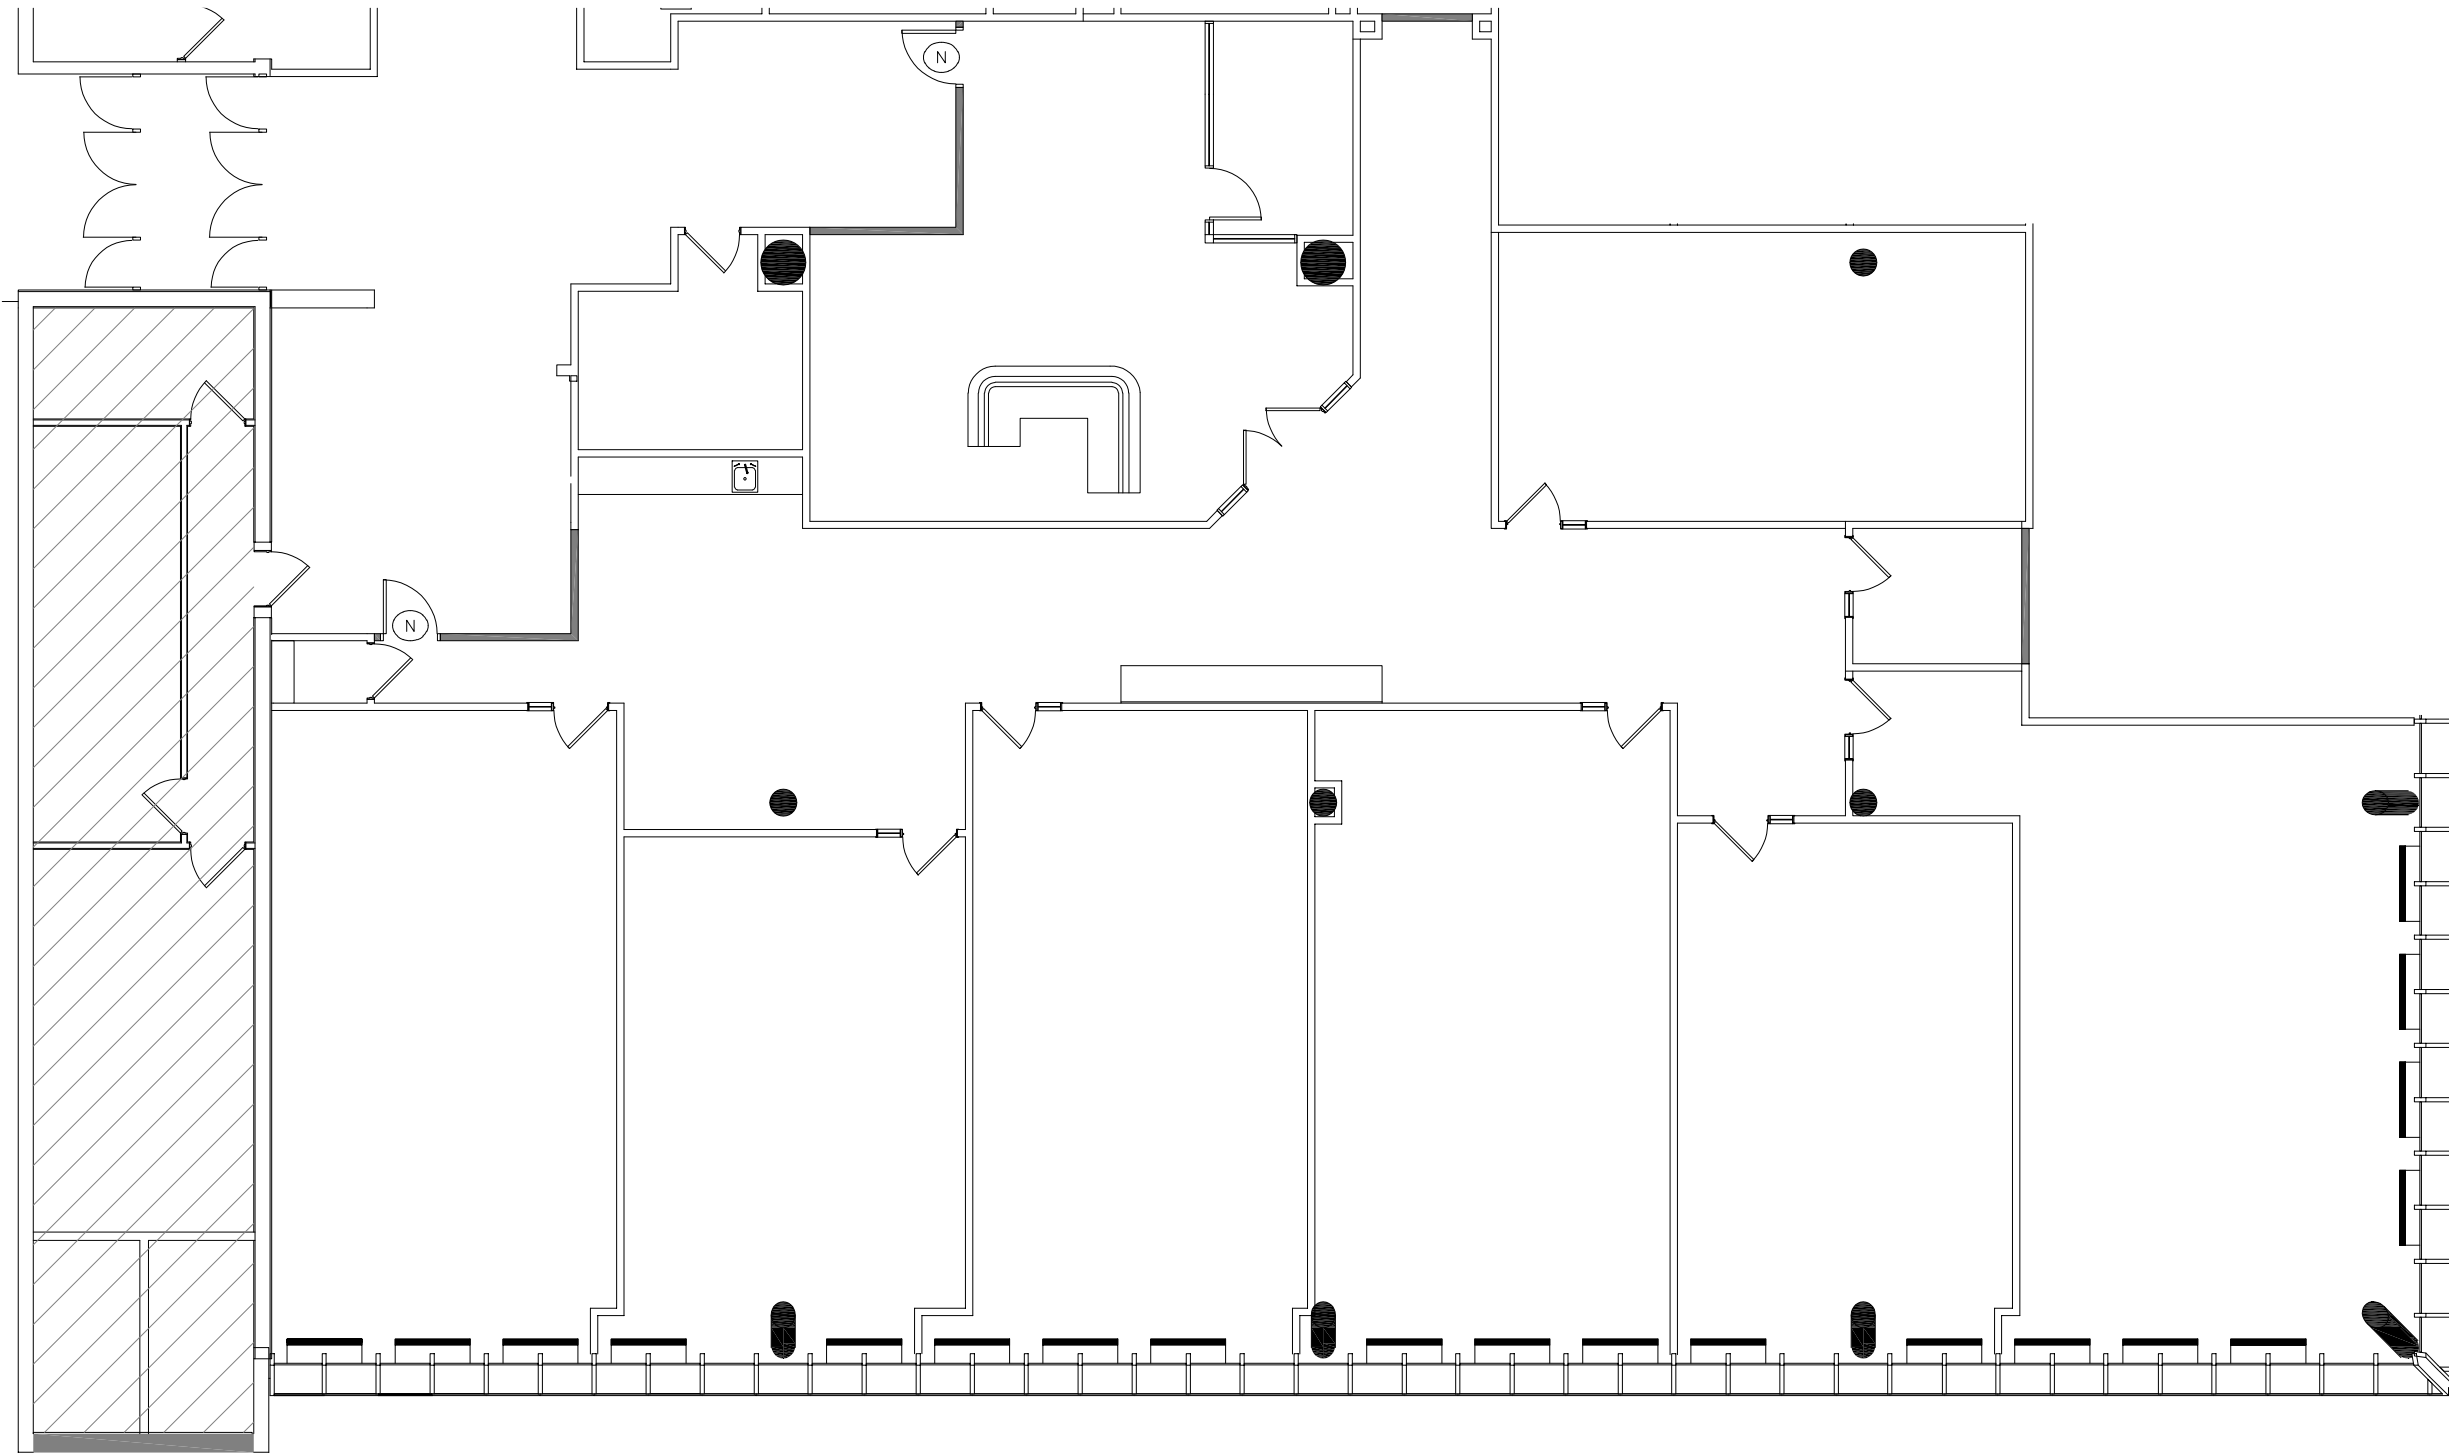

VACANCY

THE PYRAMIDS - PYRAMID 3 | 1ST FLOOR | 3500 DEPAUW BLVD, INDIANAPOLIS, IN 46268



8,369 RSF

SCALE: 3/32" = 1'-0"

PROJECT MGR: AS

DATE: 03.28.25

2025.103