



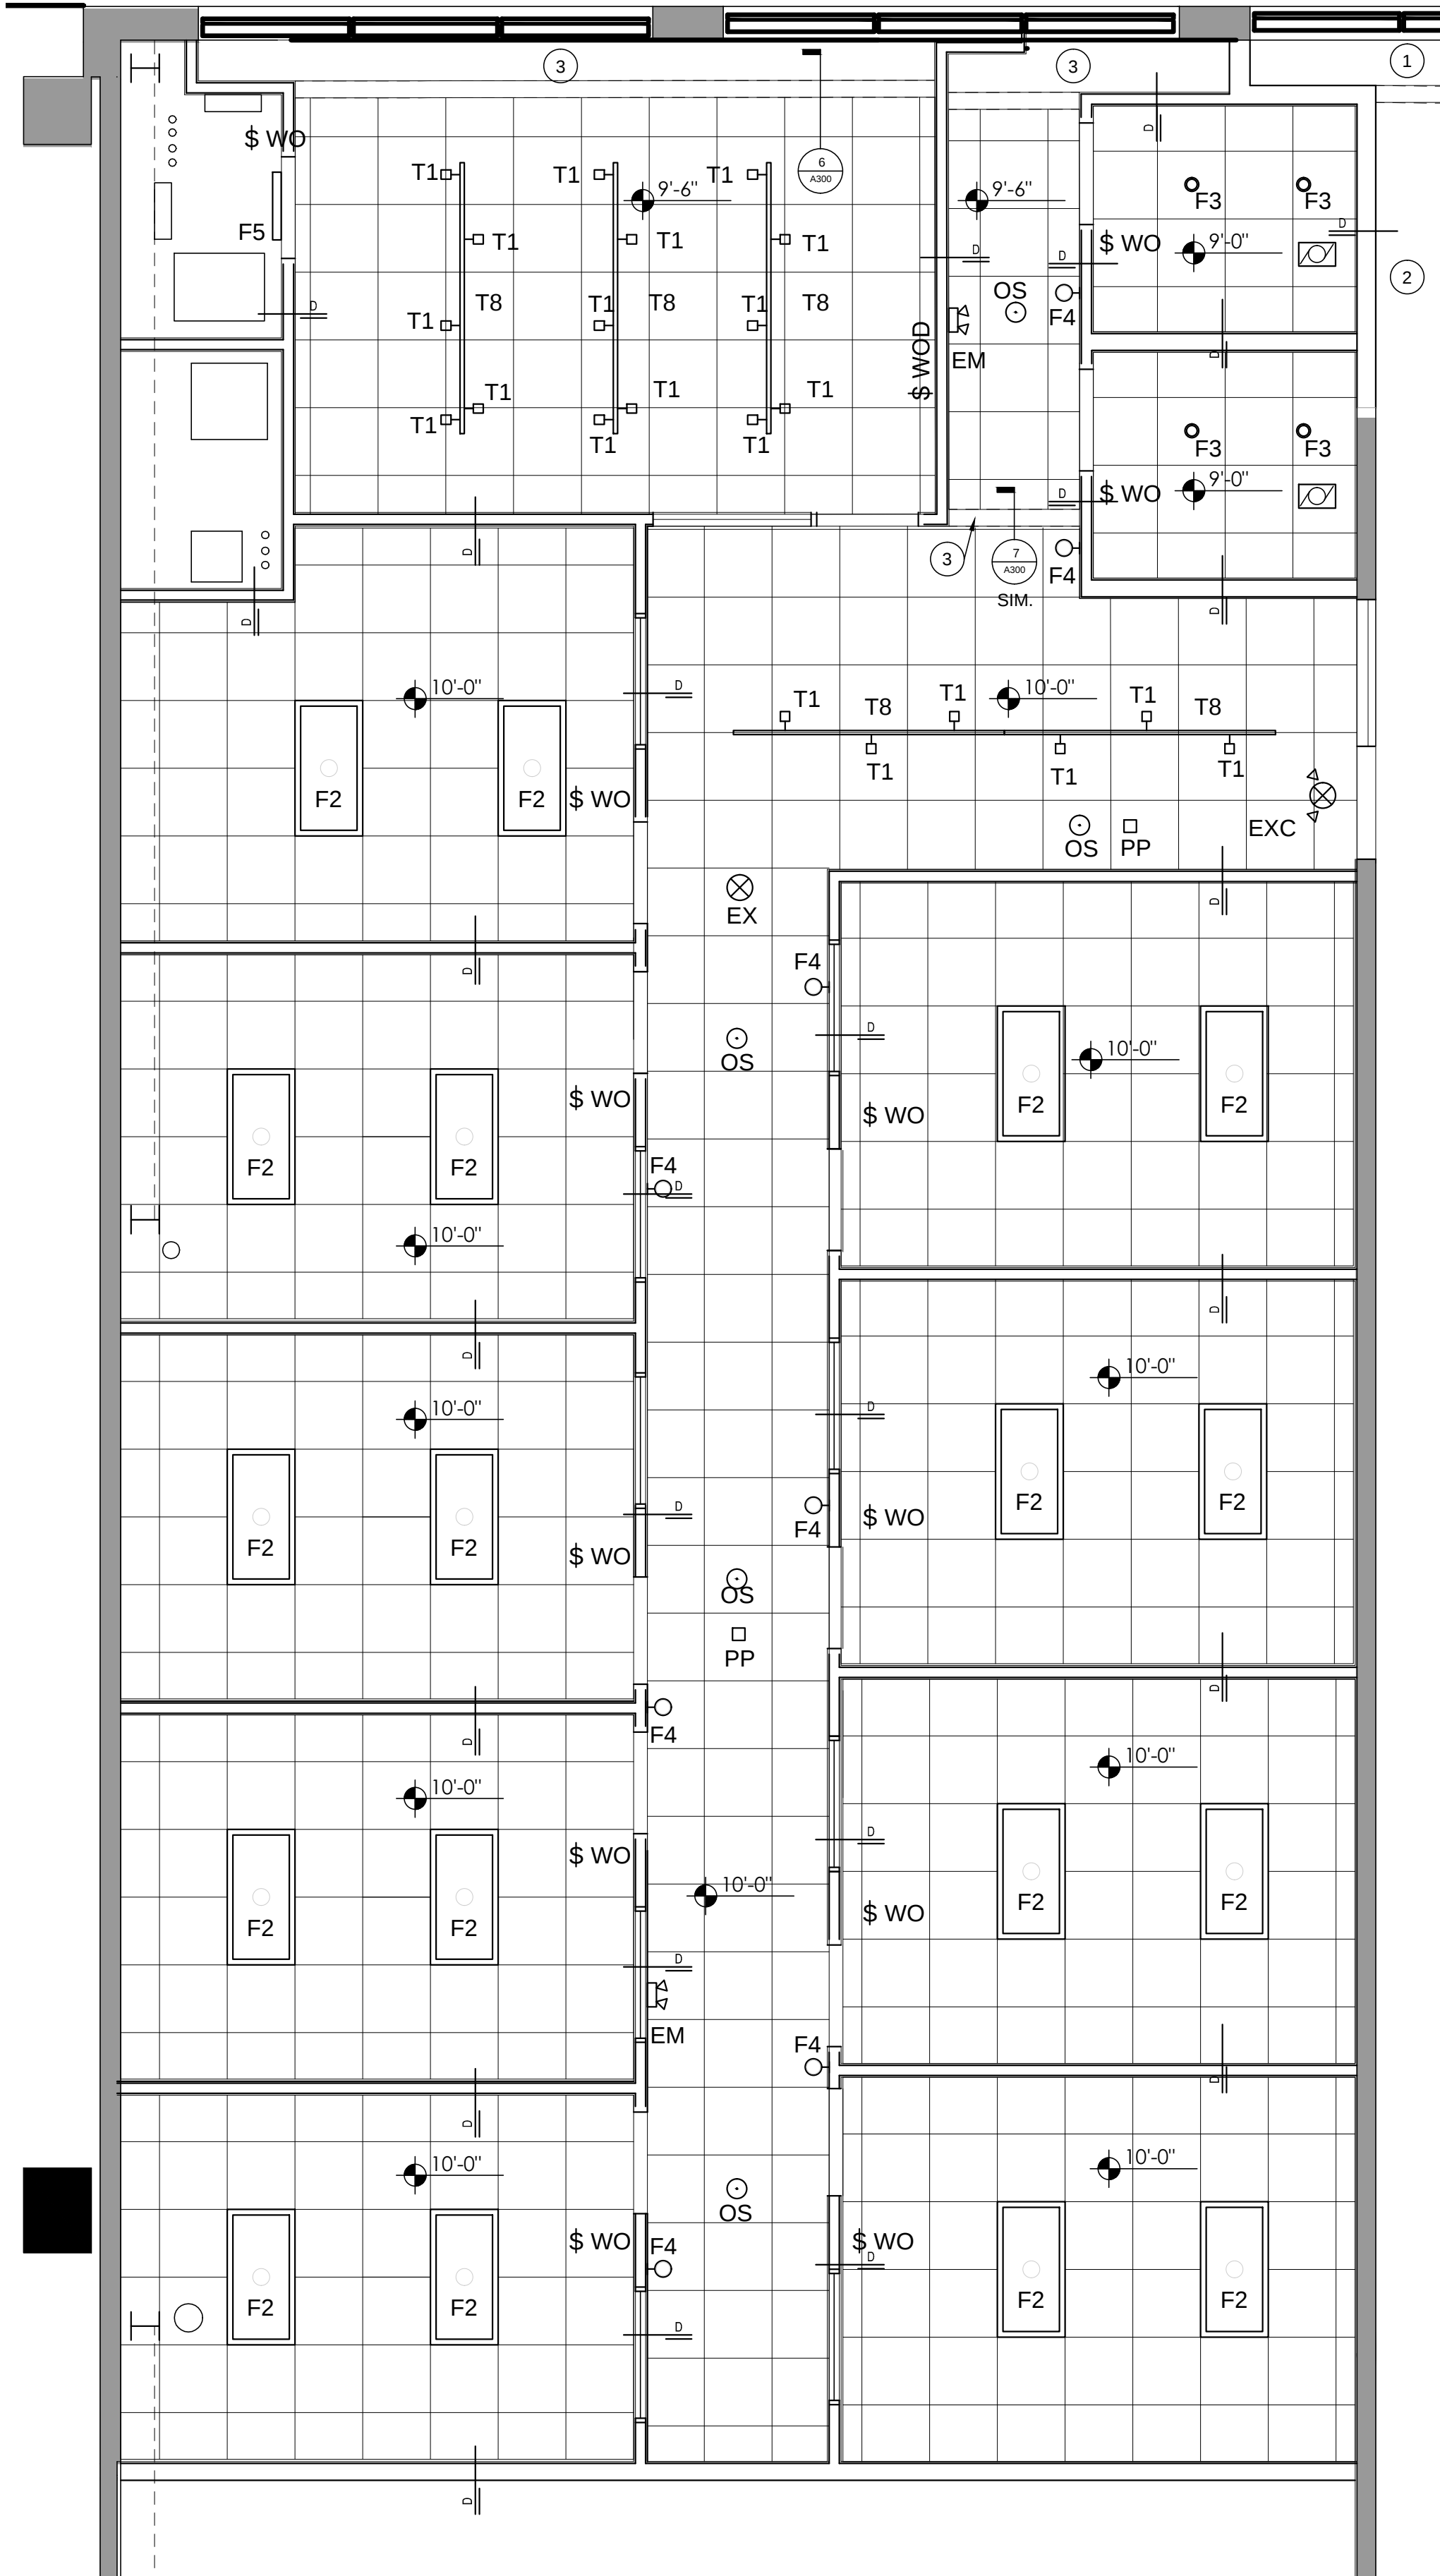

02
A200

Reflected Ceiling Plan

1/4" = 1'-0"

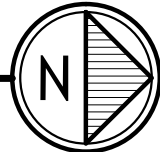

GENERAL CEILING NOTES

- A. ALL WALLS EXTEND TO DECK IF NOT NOTED OTHERWISE:
- C WALLS TO UNDERSIDE OF LAY-IN CEILING
 - E WALLS TO 6" ABOVE CEILING HEIGHT
 - 4 WALLS TO 4" ABOVE CEILING HEIGHT
 - D WALLS TO DECK ABOVE
- B. LIGHT FIXTURES AND DIFFUSERS ON DRAWINGS SHOWN FOR LOCATION ONLY. COORDINATE WITH MECHANICAL AND ELECTRICAL DRAWINGS FOR EXACT SPECIFICATIONS AND VERIFICATION OF QUANTITY.
- C. ALL CEILINGS ARE TO BE INSTALLED AT +10'-0" A.F.F. IF NOT NOTED OTHERWISE.
- D. CENTER ACOUSTICAL CEILING PANELS IN EACH DIRECTION WITHIN THE MAIN PORTION OF ANY ROOM OR SPACE, UNLESS INDICATED OTHERWISE.
- E. TURN DOWN SPRINKLER HEADS AND ADD ESCUTCHEON RINGS AS REQUIRED.

FIXTURE RESPONSIBILITY LEGEND


C.F.C.I.	T.F.C.I.
CONTRACTOR FURNISHED, CONTRACTOR INSTALLED	TENANT FURNISHED, CONTRACTOR INSTALLED

LIGHT FIXTURE SCHEDULE AND LEGEND

	F2	LPEC24-LED-HO-WW 2x4
	F3	R38 ROUGH-IN / LED DK6RT-11W840-DIM-G5 IES
	F4	LED UP/DOWN WALL SCONCE 14W FLOOD / 14W FLOOD / 28 WATTS TOTAL
	F5	2' LED MOUNT ON WALL OVER DOOR, WL2-12L-E21-LP835 OR EQUAL
	T8	8 FOOT TRACK SECTION WITH POWER FEED
	OS	DUAL TECH CEILING OCCUPANCY SENSOR
	T1	CTL8030 TRACK HEAD WITH LED11WPAR30_WFL_840K-DIM-G61
	PP	POWER PACK
	\$ WO	PIR WALL OCCUPANCY SENSOR
	\$ WOD	0-10V DIMMING SWITCH AND PIR WALL OCCUPANCY SENSOR COMBO
	EX	DL113927 LED EXIT SIGN WITH RED LETTER
	EXC	DL104920 REMOTE CAPABLE COMBO EXIT EMERGENCY WITH RED LETTER
	EM	DL105310 TWIN LAMP EMERGENCY UNIT - LED
		EXHAUST FAN, ROUTE TO EXTERIOR. RESTROOM FANS SHALL BE INTERLOCKED WITH RESTROOM LIGHT SWITCH FOR SIMULTANEOUS OPERATION.
		2 X 2 CEILING TILE TBD

REF. CEILING PLAN KEYED NOTES


- 1 EXISTING GYPSUM BOARD BULKHEAD TO BE REPAIRED AS REQUIRED AND PAINTED.
- 2 PROTECT EXISTING CEILING GRID, LIGHTING, SPRINKLER HEADS AS REQUIRED FOR A FULLY FINISHED AND FUNCTIONING SYSTEM IN BUILDING EGRESS CORRIDOR.
- 3 GYPSUM BOARD BULKHEAD PAINTED.

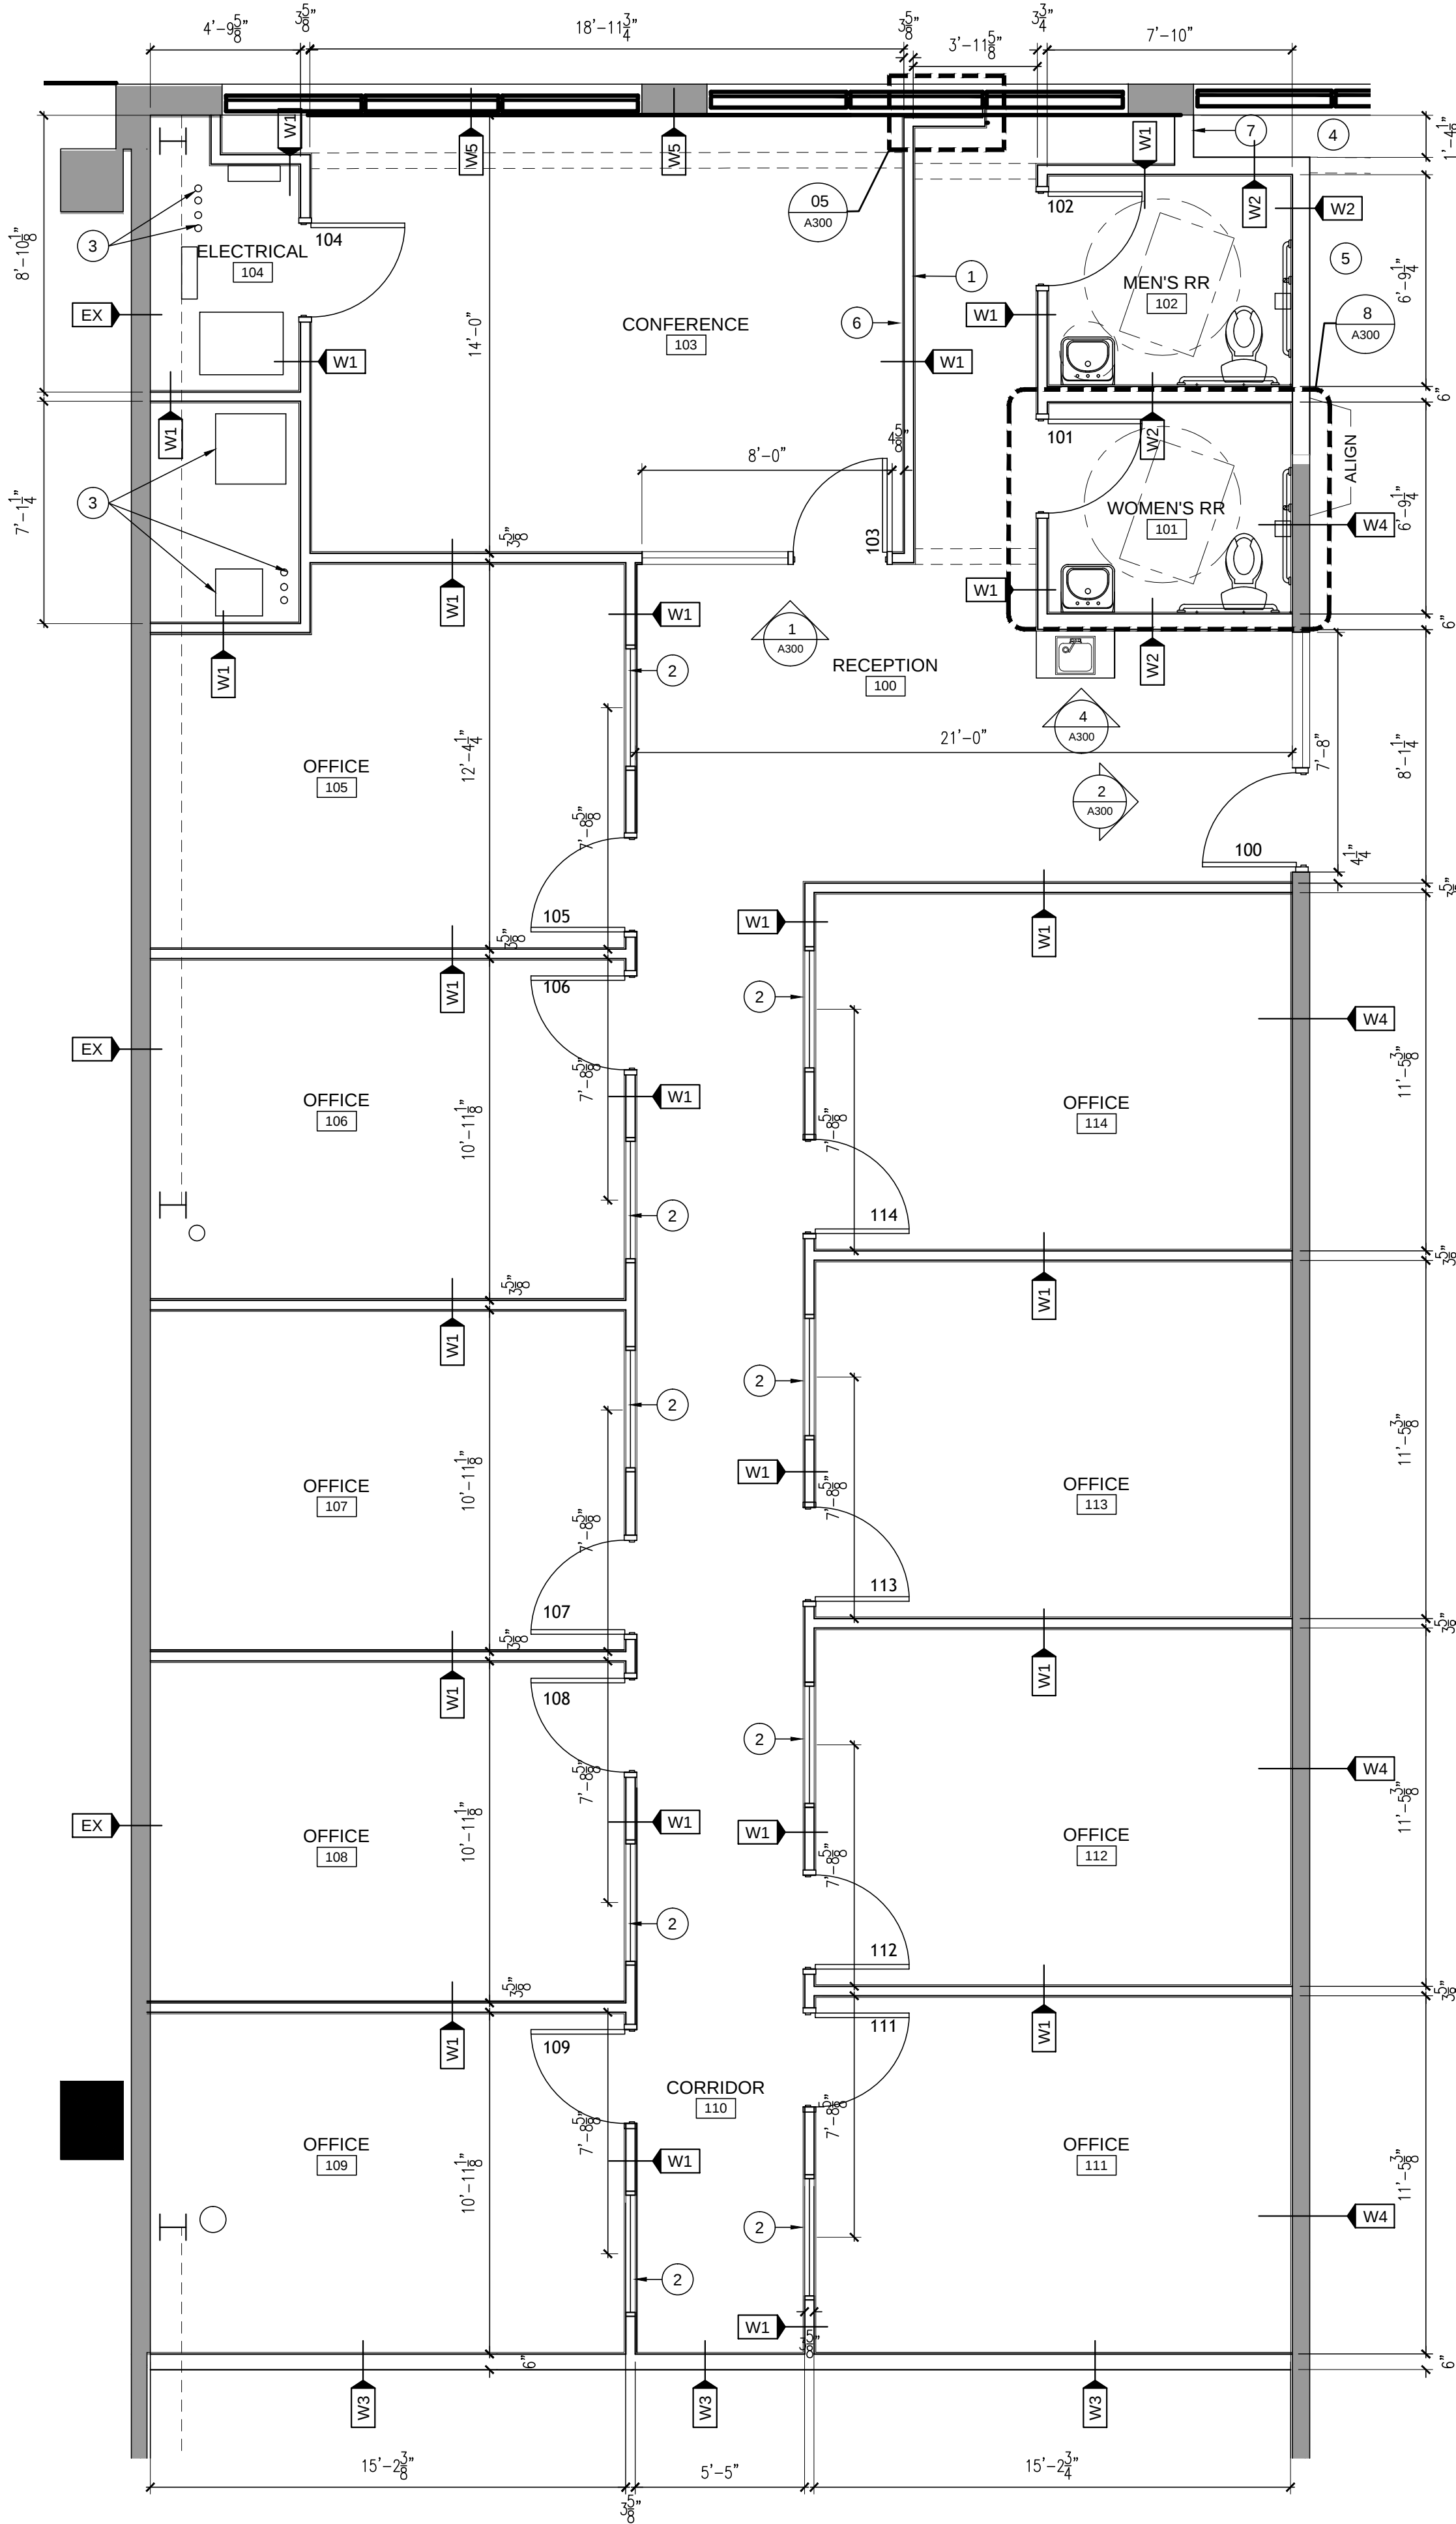

01
A200

Floor Plan

1/4" = 1'-0"

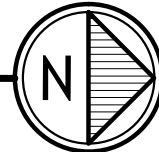

GENERAL NOTES

- A. ALL DIMENSIONS ARE FROM FACE OF EXISTING FINISHED FACE TO FACE OF NEW STUD WALL OR FACE TO FACE OF NEW STUD WALL. ANY DIMENSIONS NOT SHOWN OR DEEMED QUESTIONABLE ARE TO BE VERIFIED WITH ARCHITECT. DO NOT SCALE DRAWINGS.
- B. SEE WALL TYPE LEGEND FOR WALL CONSTRUCTION.
- C. PROVIDE WOOD BLOCKING SUPPORT AS REQUIRED. ALL CONCEALED WOOD BLOCKING TO BE FIRE RETARDED TREATED WOOD
- D. COORDINATE WORK OF THIS TRADE WITH OTHER TRADES.
- E. ALL WORK SHALL BE PERFORMED IN STRICT COMPLIANCE WITH ALL APPLICABLE CODES, LAWS AND ORDINANCES.
- F. CONTACT RESPECTIVE UTILITY COMPANY FOR EXACT LOCATION OF SERVICES PRIOR TO START OF CONSTRUCTION. PROTECT EXISTING SERVICE DURING CONSTRUCTION.
- G. PATCH AND REPAIR SURROUNDING WALL SURFACES AT ANY NEW OPENING AND PAINT TO MATCH EXISTING FINISHES. EXISTING CORRIDOR SHALL BE PAINTED TO MATCH THE SURROUNDING FINISHES.
- I. DOOR AND FRAME NUMBERS CORRESPOND TO ROOM NUMBERS. WHERE MORE THAN ONE DOOR OCCURS IN A ROOM, A SUFFIX HAS BEEN ADDED (I.E. 1000A). REFERENCE DOOR SCHEDULE.
- J. CAULK JUNCTURES BETWEEN DIFFERENT MATERIALS (I.E. STOREFRONT AND GYPSUM BOARD).
- K. EACH CONTRACTOR SHALL PROVIDE ALL BARRICADES, ETC. AS REQUIRED BY LAW, CODE OR ORDINANCE AND AS OTHERWISE REQUIRED.
- L. ALL STEEL STUDS ARE TO BE BRACED ACCORDING TO MANUFACTURER'S LIMITING HEIGHT L/ OVER 240.
- M. REMOVE ALL TRASH AND DEBRIS FROM THE JOB SITE DAILY.
- N. ALL METAL STUD WALLS WHICH EXTEND TO DECK SHALL BE CONSTRUCTED WITH A CONTINUOUS SLIP TRACK AT TOP OF WALL. TRACK SHALL BE SIZED TO ALLOW FOR MINIMUM DECK DEFLECTION OF 1/2".
- O. PROVIDE RECESSED FIRE EXTINGUISHERS AS REQUIRED BY LOCAL CODE.

WALL TYPE LEGEND

- W1 — 3-5/8" X 20 GA. METAL STUDS AT 16" O.C. WITH 5/8" GYPSUM WALLBOARD EACH SIDE AND SOUND ATTENUATION BLANKETS IN EACH STUD CAVITY. EXTEND GYP BD. TO DECK ONE SIDE. LEVEL 4 FINISH.
- W2 — 6" X 20 GA. METAL STUDS AT 16" O.C. WITH 5/8" GYPSUM WALLBOARD EACH SIDE AND SOUND ATTENUATION BLANKETS IN EACH STUD CAVITY. PROVIDE MOISTURE RESISTANT GYP. BD. AT "WET" SIDE. LEVEL 4 FINISH
- W3 — 6" X 20 GA. METAL STUDS AT 16" O.C. WITH 5/8" GYPSUM WALLBOARD TENANT SIDE ONLY AND SOUND ATTENUATION BLANKETS IN EACH STUD CAVITY. LEVEL 4 FINISH
- W4 — EXISTING 6" STUD WALL TO RECEIVE SOUND ATTENUATION BLANKETS IN EACH STUD CAVITY AND 5/8" GYPSUM WALLBOARD TENANT SIDE ONLY. LEVEL 4 FINISH
- W5 — EXISTING STUD WALL AT FACADE TO RECEIVE 5/8" GYPSUM WALLBOARD. LEVEL 4 FINISH.
- EX — EXISTING WALL CONSTRUCTION TO REMAIN. ENSURE WALLS FINISHED TO LEVEL 4.

- * ALL WALL TYPES SHALL BE W1 UNLESS NOTED OTHERWISE.
- * FOR WALL HEIGHTS, REFERENCE REFLECTED CEILING PLANS.
- * PROVIDE MOISTURE RESISTANT GYPSUM BOARD AT ALL "WET" LOCATIONS.

PLAN NOTES

- 1 FIRE EXTINGUISHER LOCATION PROVIDE FULLY OR PARTIALLY RECESSED CABINET
- 2 SEE 3/A300 FOR TYPICAL WINDOW ELEVATION, MANUFACTURED WINDOW SPECIFICATION PROVIDED BY LANDLORD.
- 3 EXISTING DUCTWORK, WATER LINES TO REMAIN.
- 4 ALIGN "TURN BACK" WITH EXISTING BULKHEAD IN CORRIDOR.
- 5 PROTECT BUILDING EGRESS CORRIDOR FLOOR FINISH DURING DEMOLITION / CONSTRUCTION.
- 6 PROVIDE BLOCKING FOR TV @ 83".
- 7 ALIGN WALL WITH MULLION.

THE EDGE SUITE 250
8890 EAST 116TH STREET
FISHERS, IN 46038


date | issue

03.30.17 PERMIT

reflected ceiling plan
floor plan

A200

© COPYRIGHT SODA. LLC.

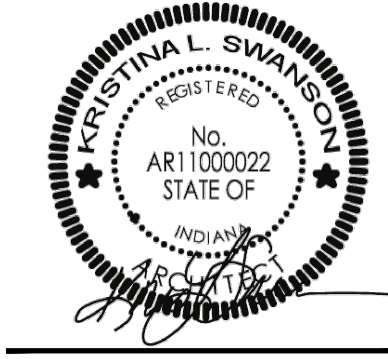

soda
swanson office of design + architecture llc

Carmel, IN | kris@swansonoffice.com | t: 317.324.8855