

COR3 Design, LLC

Commercial, Office, Retail, Restaurant, Real Estate Development

201 RiverPlace Suite 401 Greenville, SC 29601

Phone: 864.451.5288

Fax: 864.990.3085

www.cor3design.com

Consultants: STRUCTURAL


PLUMBING LWI Consulting Engineers 870 Cleveland St, STE 1D Greenville, SC 29601 864.271.6535

MECHANICAL LWI Consulting Engineers 870 Cleveland St, STE 1D Greenville, SC 29601 864.271.6535

ELECTRICAL RWL 116 South Pleasantburg Drive Greenville, SC 29607 864.233.8844

Project Title: BEALLS OUTFITTERS #984 FAYETTEVILLE 1406 HUNTSVILLE HWY FAYETTEVILLE, TN 37334

Client Logo:

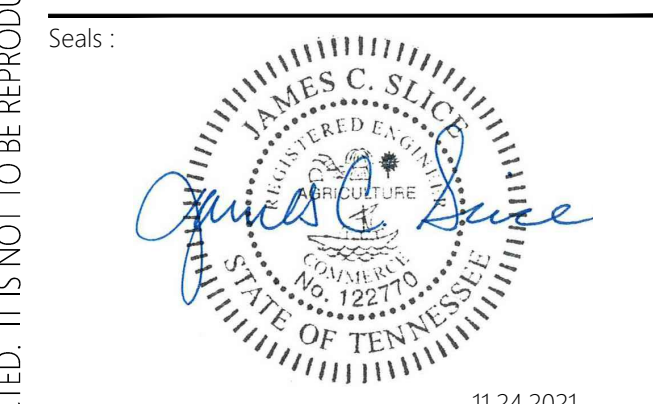

Revisions: 11.24.2021 Issue for Permit

Project Number: 21093 Phase: CD Date: 11.24.2021 Drawn By:

Checked By:



Sheet Number: E101

Sheet Title: POWER PLAN

ELECTRICIAN IS TO VERIFY WHAT ALL EXISTING ELECTRICAL GEAR IS FEEDING AND COORDINATE WITH BURKE'S PM



D11 MEZZANINE POWER PLAN

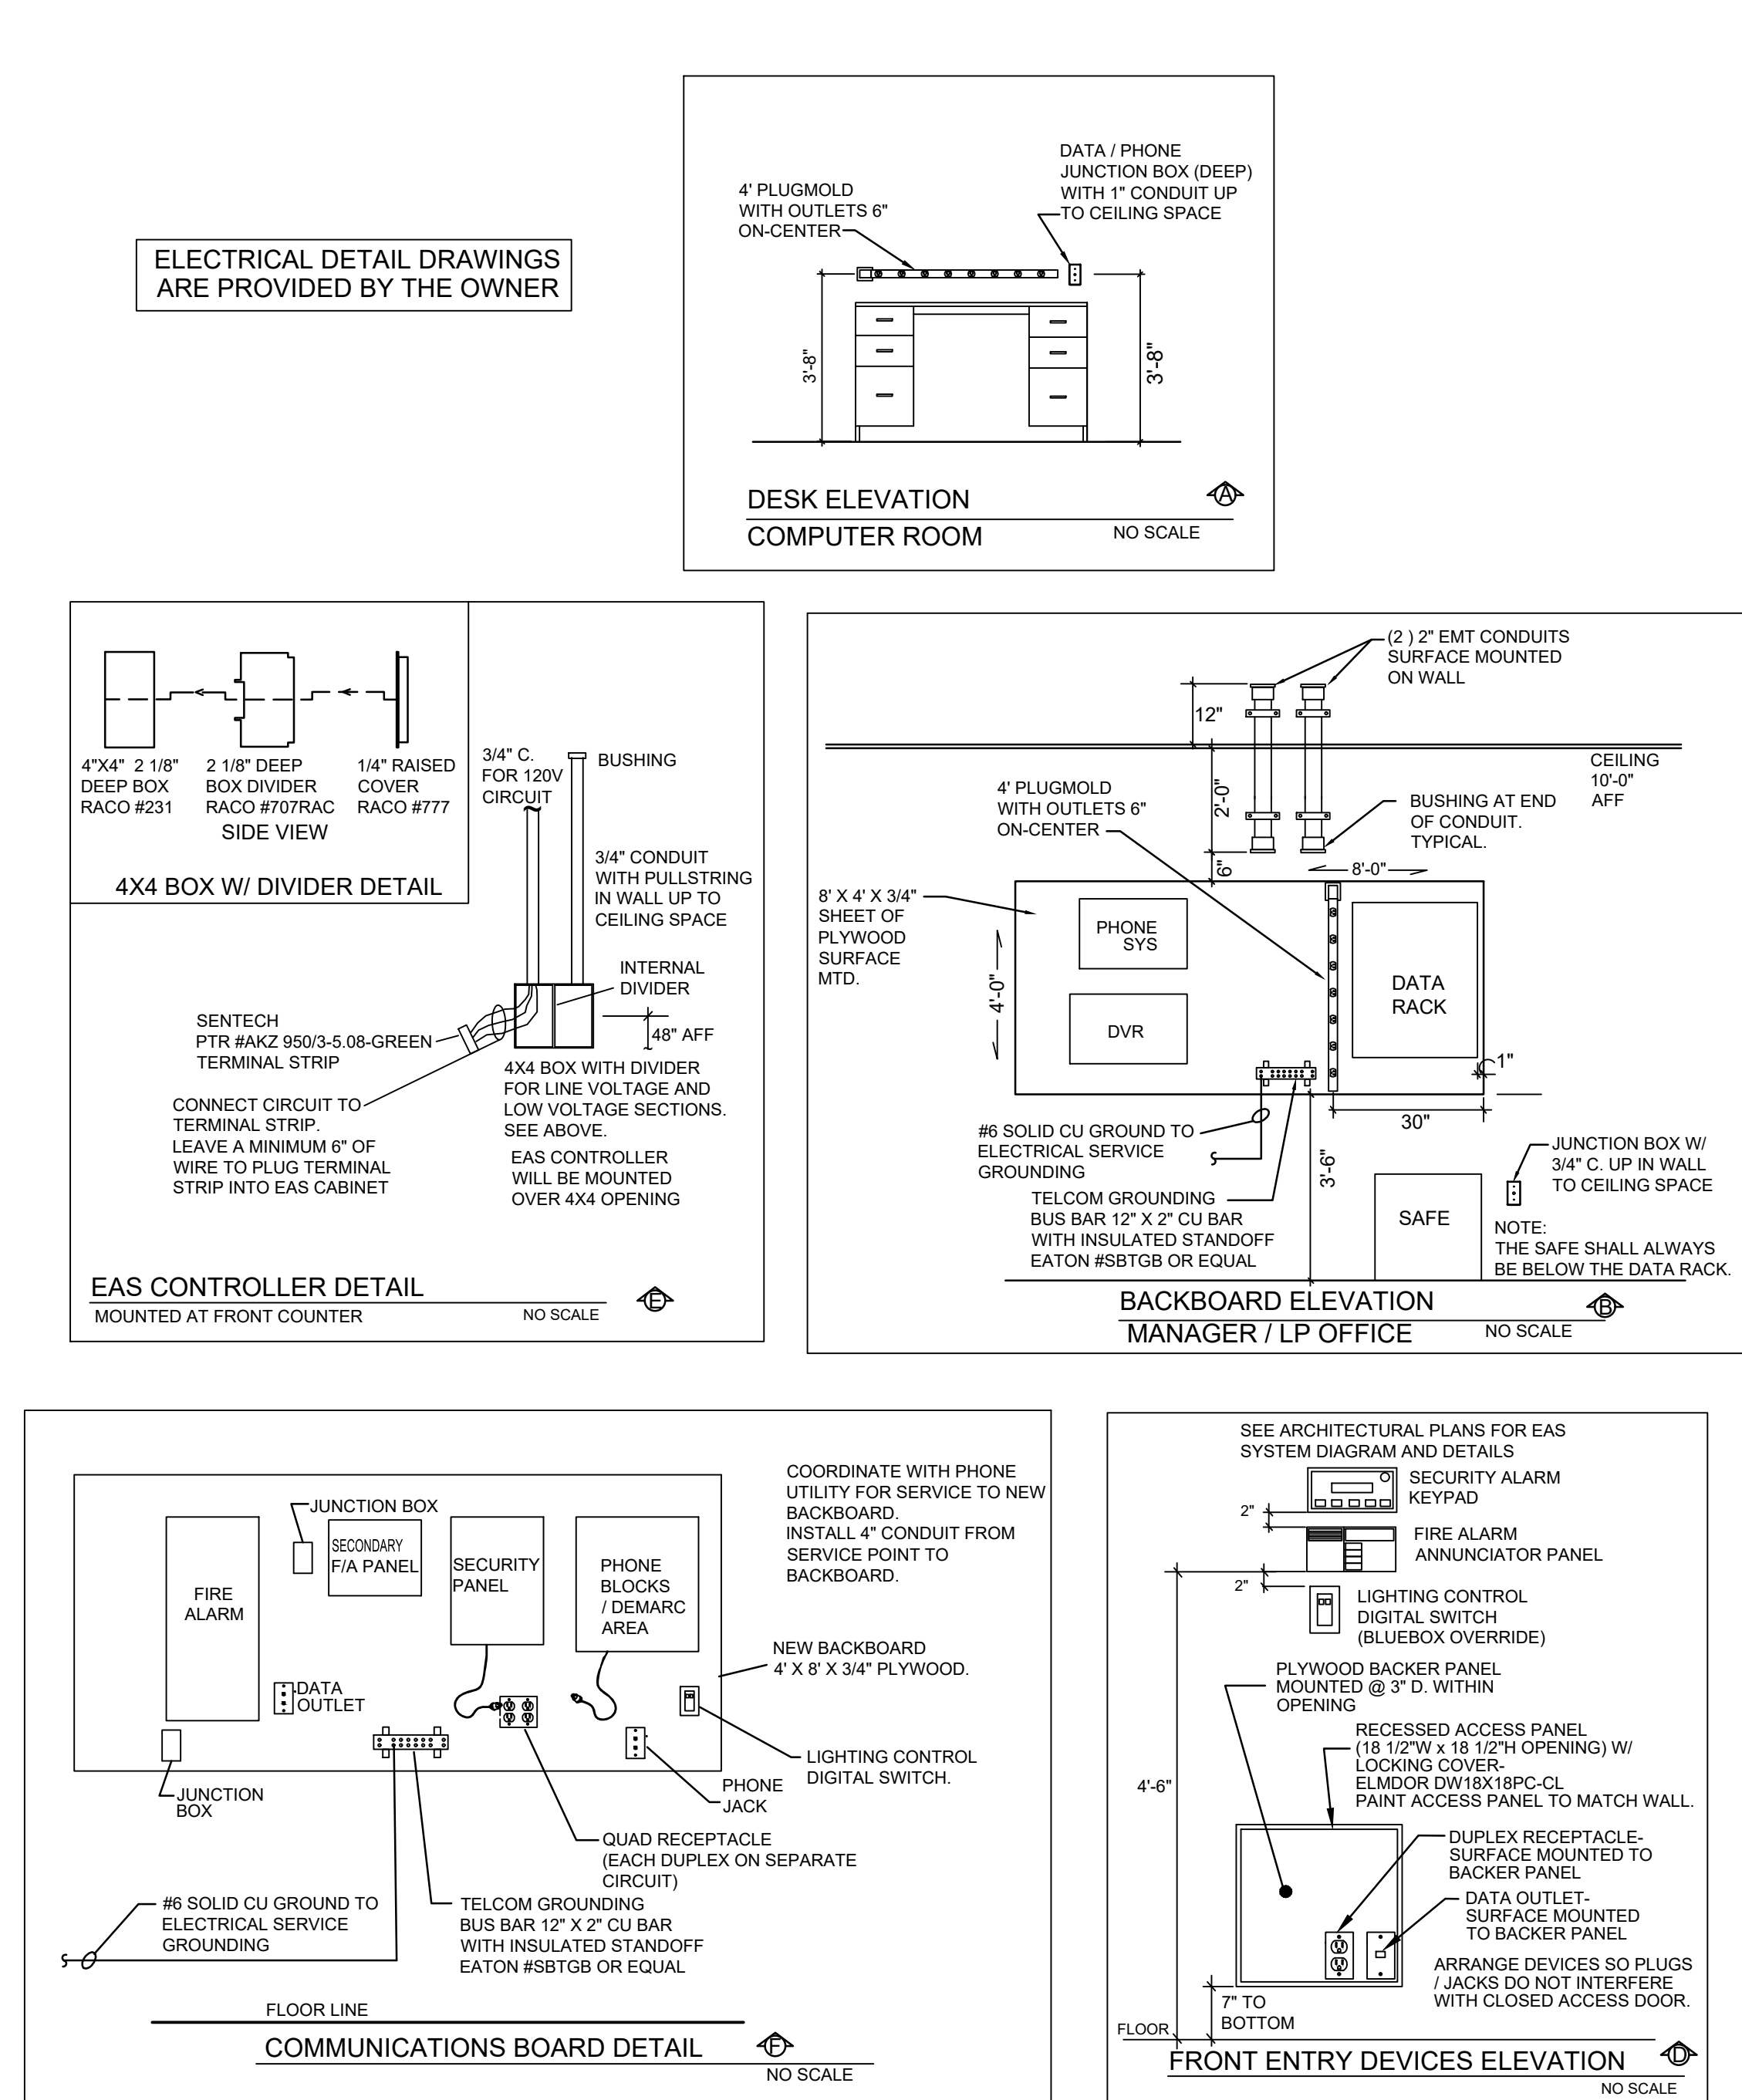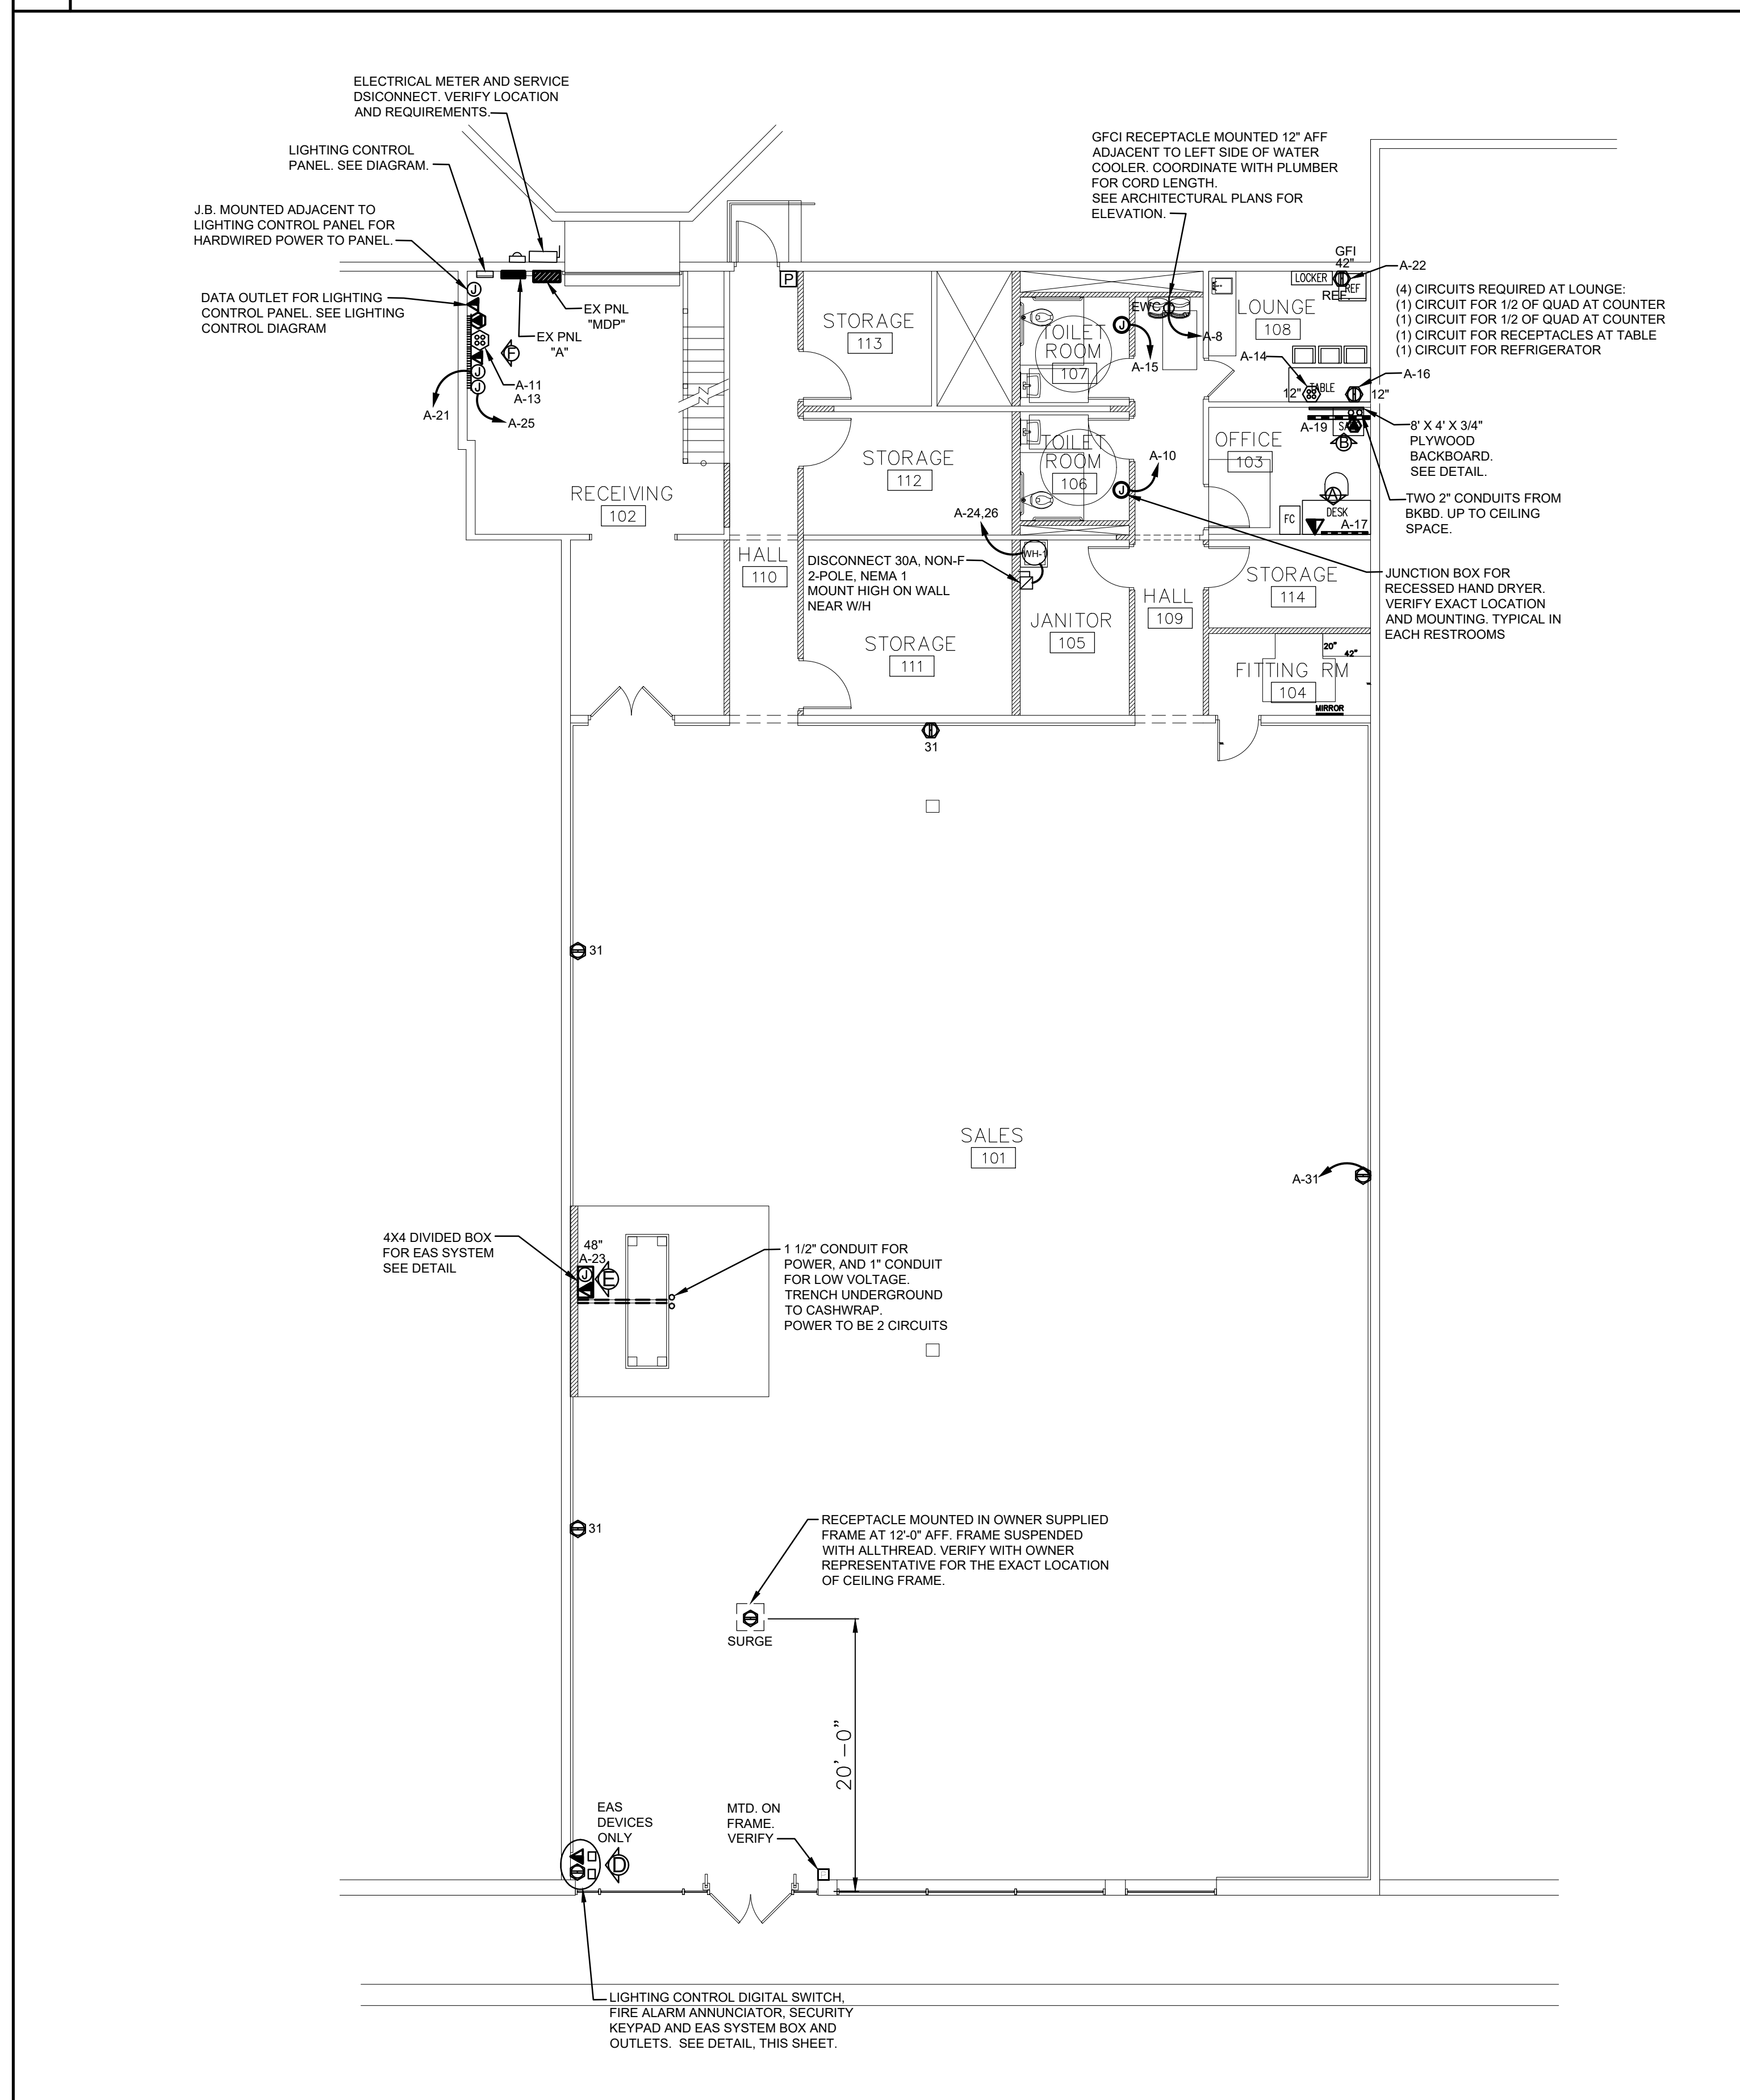

ELECTRICAL LEGEND table with symbols and descriptions for Duplex Receptacle, Quad Receptacle, Comm. Outlet for Safe, Plugmold, GFCI, Junction Box, Disconnect, and Fire Alarm Pull Station.

ELECTRICAL PROJECT REQUIREMENTS

- 1. THE CONTRACTOR SHALL ARRANGE AND PAY FOR ALL PERMITS AND INSPECTIONS REQUIRED IN THIS WORK.
2. ALL WORK SHALL BE DONE IN ACCORDANCE WITH THESE PLANS, SPECIFICATIONS, LOCAL, STATE AND NATIONAL CODES...
3. THE ELECTRICAL CONTRACTOR SHALL FURNISH ALL LABOR, MATERIALS, EQUIPMENT AND TOOLS TO PERFORM ELECTRICAL WORK AS SHOWN, NOTED OR SCHEDULED FOR A COMPLETE INSTALLATION.
...
22. THE ELECTRICAL CONTRACTOR SHALL BE RESPONSIBLE FOR VERIFYING ALL EXISTING CONDITIONS.