



IF THESE PLANS DO NOT BEAR THE SEAL OF THE REGISTERED ARCHITECT, THEY ARE CONSIDERED PRELIMINARY AND ARE NOT TO BE USED FOR CONSTRUCTION OR RECORDING. THESE PLANS ARE COPYRIGHTED AND ARE SUBJECT TO COPYRIGHT PROTECTION AS AN "ARCHITECTURAL WORK" UNDER SECTION 102.1(b) OF THE CALIFORNIA CONSTITUTION AND UNDER FEDERAL COPYRIGHT LAW. ANY UNAUTHORIZED REPRODUCTION OR USE OF THESE PLANS WITHOUT THE WRITTEN PERMISSION OF THE ARCHITECT IS STRICTLY PROHIBITED AND WILL BE PROSECUTED TO THE FULL EXTENT OF THE LAW. THE ARCHITECT ASSUMES NO LIABILITY FOR ANY DAMAGE, INCLUDING CONSEQUENTIAL DAMAGES, ARISING FROM THE USE OF THESE PLANS. THE DESIGN UNDER SUCH PROTECTION AS ARCHITECTURAL WORK UNDER SECTION 102.1(b) OF THE CALIFORNIA CONSTITUTION AND UNDER FEDERAL COPYRIGHT LAW. ANY UNAUTHORIZED REPRODUCTION OR USE OF THESE PLANS WITHOUT THE WRITTEN PERMISSION OF THE ARCHITECT IS STRICTLY PROHIBITED AND WILL BE PROSECUTED TO THE FULL EXTENT OF THE LAW. THE ARCHITECT ASSUMES NO LIABILITY FOR ANY DAMAGE, INCLUDING CONSEQUENTIAL DAMAGES, ARISING FROM THE USE OF THESE PLANS.

| ELECTRICAL FIXTURE SCHEDULE | | NOTE: ALL INSTALLED LUMINAIRES SHALL BE HIGH EFFICACY, EITHER LISTED BY SOURCE TYPE OR BY BEING JAB-2016 CERTIFIED AND LABELED. SEE TABLE 150.2-A OF 2016 CEC, PART 6. | |
|-----------------------------|------------------|------------------------------------------------------------------------------------------------------------------------------------------------------------------------|-------|
| 110V GFI | ⊖ | CAN LIGHT | ⊞ |
| 110V WEATHER PROTECTED GFI | ⊖(WP) | LIGHT | ⊞ |
| 220V | ⊖ | TRACK LIGHTS | ⊞-⊞-⊞ |
| DB | ⊞ | WALL LIGHT | ⊞- |
| CHIMES | ⊞ | SPOTLIGHT | ⊞/P |
| PHONE | ⊞ | MOTION SENSOR/PHOTOCONTROL | ⊞ |
| TV | ⊞ | CARBON MONOXIDE ALARM | ⊞ CM |
| FAN VTO | ⊖ | 110V SMOKE ALARM | ⊞ SA |
| SWITCH | ⊞ | WHOLE HOUSE FAN | ⊞ |
| 3-WAY | ⊞ ³ | | |
| 4-WAY | ⊞ ⁴ | | |
| DIMMER | ⊞ ^{DMR} | | |
| | | VACANCY SENSOR | ⊞ VC |
| | | CEILING REGISTER | ⊞ |
| | | GAS | ⊞ |
| | | THERMOSTAT | ⊞ |
| | | SPEAKER | ⊞ |
| | | UNDER CAB FLUOR | ⊞ |
| | | 2X4 FLUOR | ⊞ |
| | | CEIL FAN | ⊞ |

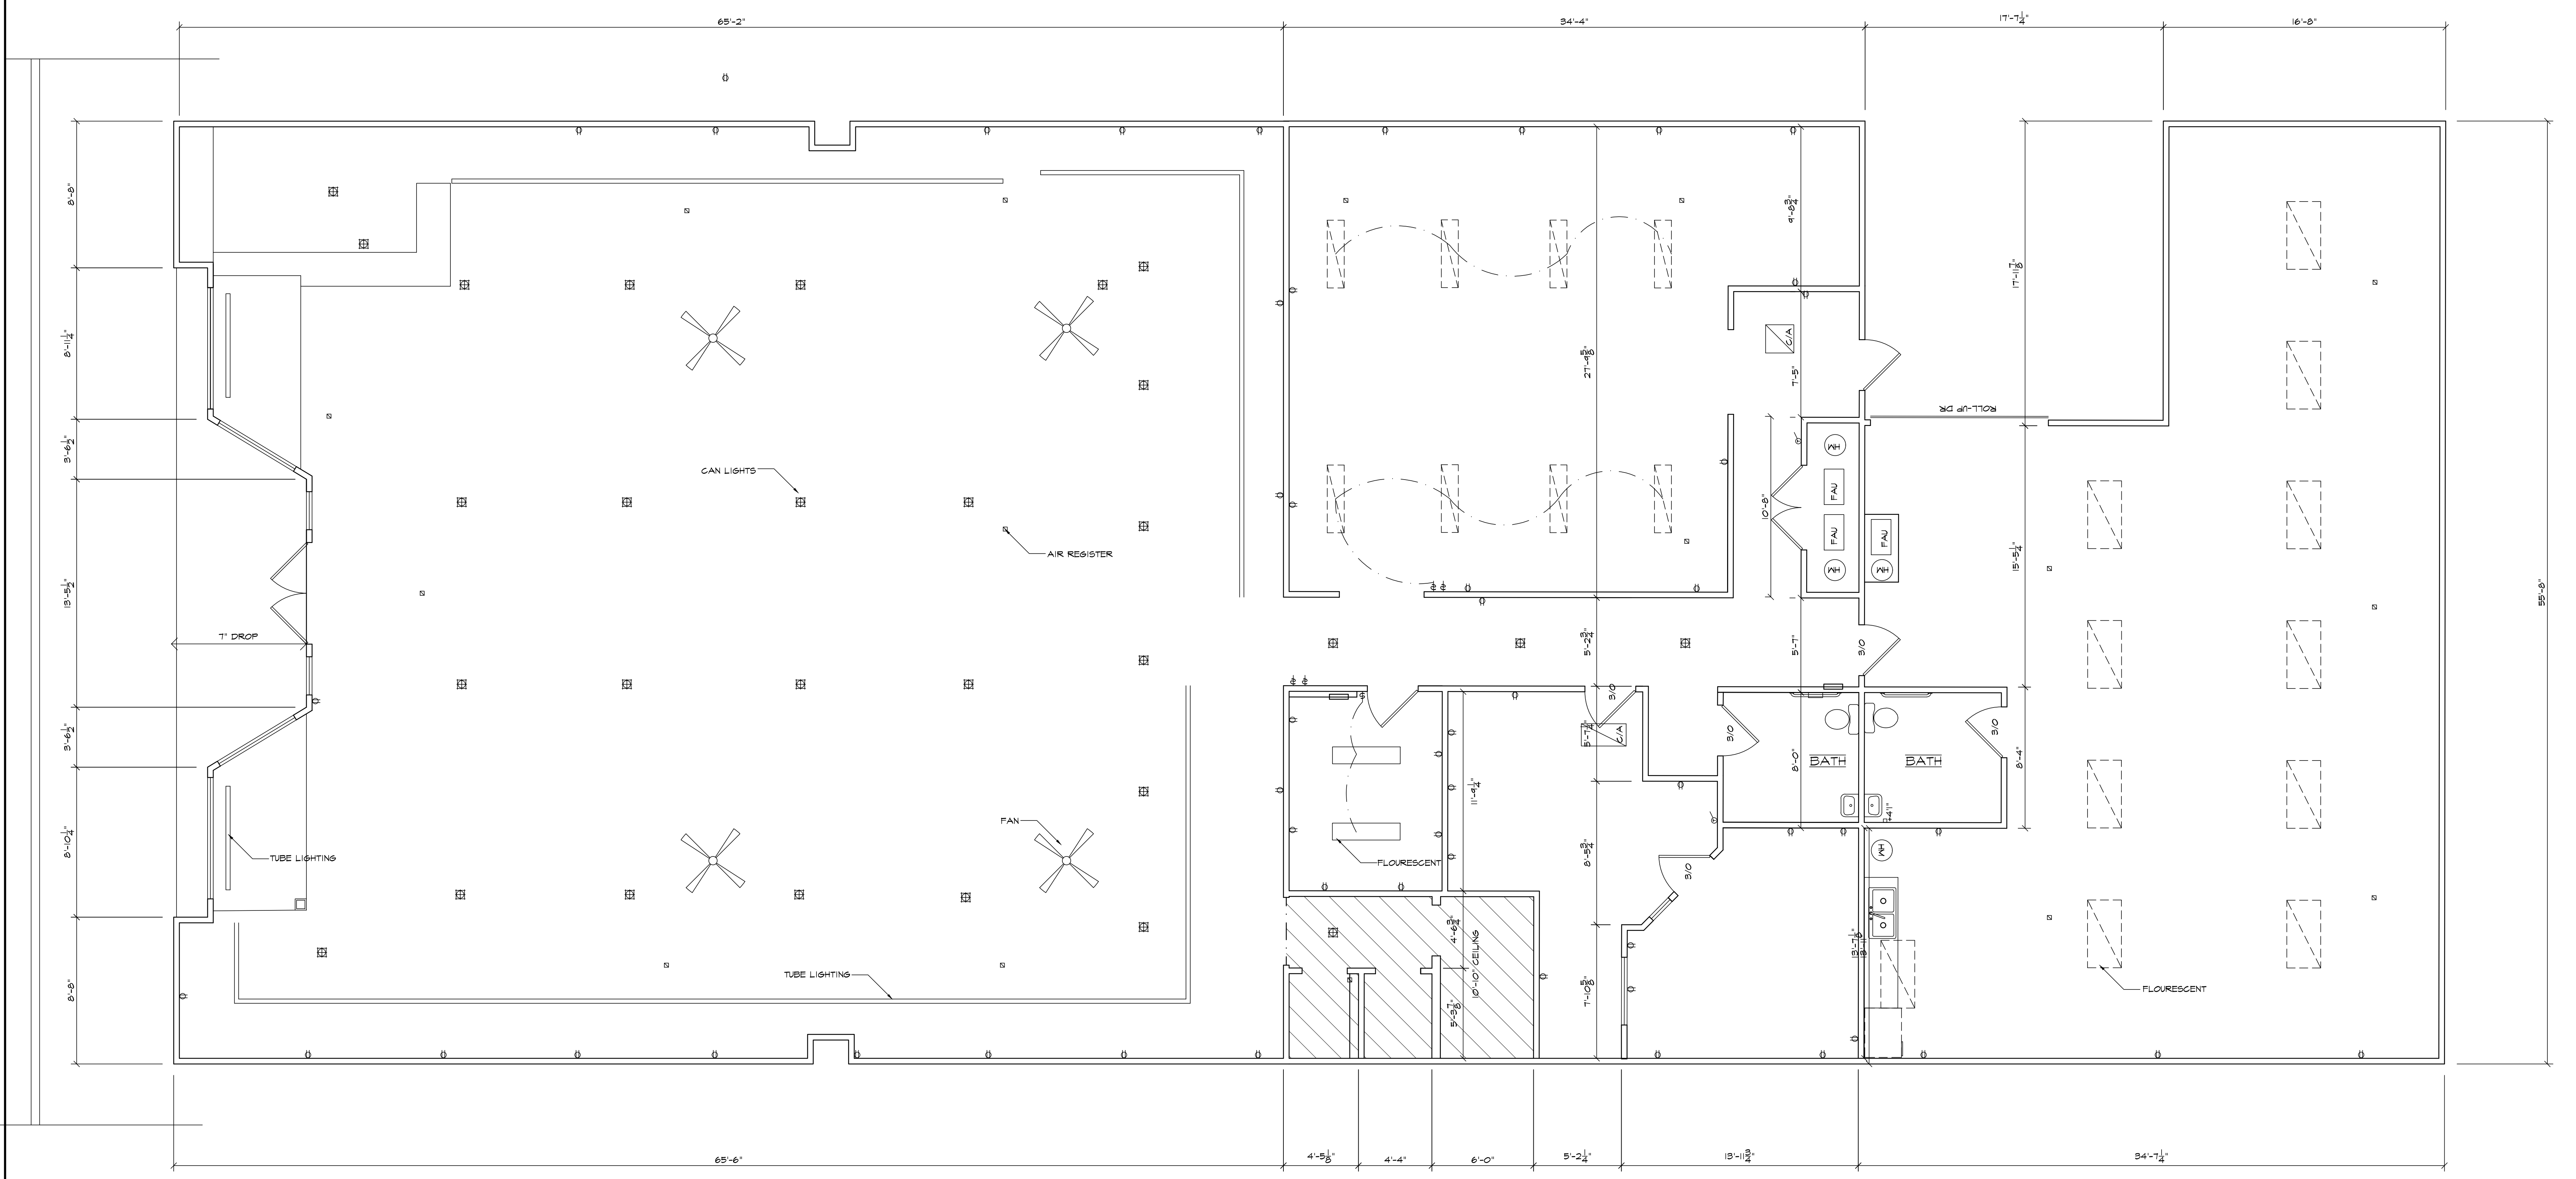

ASBUILT FLOOR PLAN
SCALE 1/4"=1'-0"

| REVISIONS: |
|------------|
| |
| |
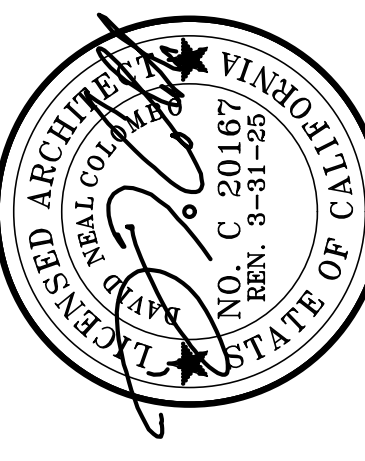

PROJECT JOB NAME:
NEUFELD 3RD ST.
111 3RD ST., SANTA ROSA, CA.

INTEGRATED DESIGN
804 COLLEGE AVE., SANTA ROSA, CA 95404
(707) 568-0106 Fax (707) 568-5592

| | |
|-----------|-----------|
| CHK BY: | ⊞ COLVARD |
| DRAWN BY: | ⊞ LAVOIE |
| SHEET NO. | A1 |
| OF: | 02 |
| DATE: | 10-24 |
| JOB NO. | 2024-06 |