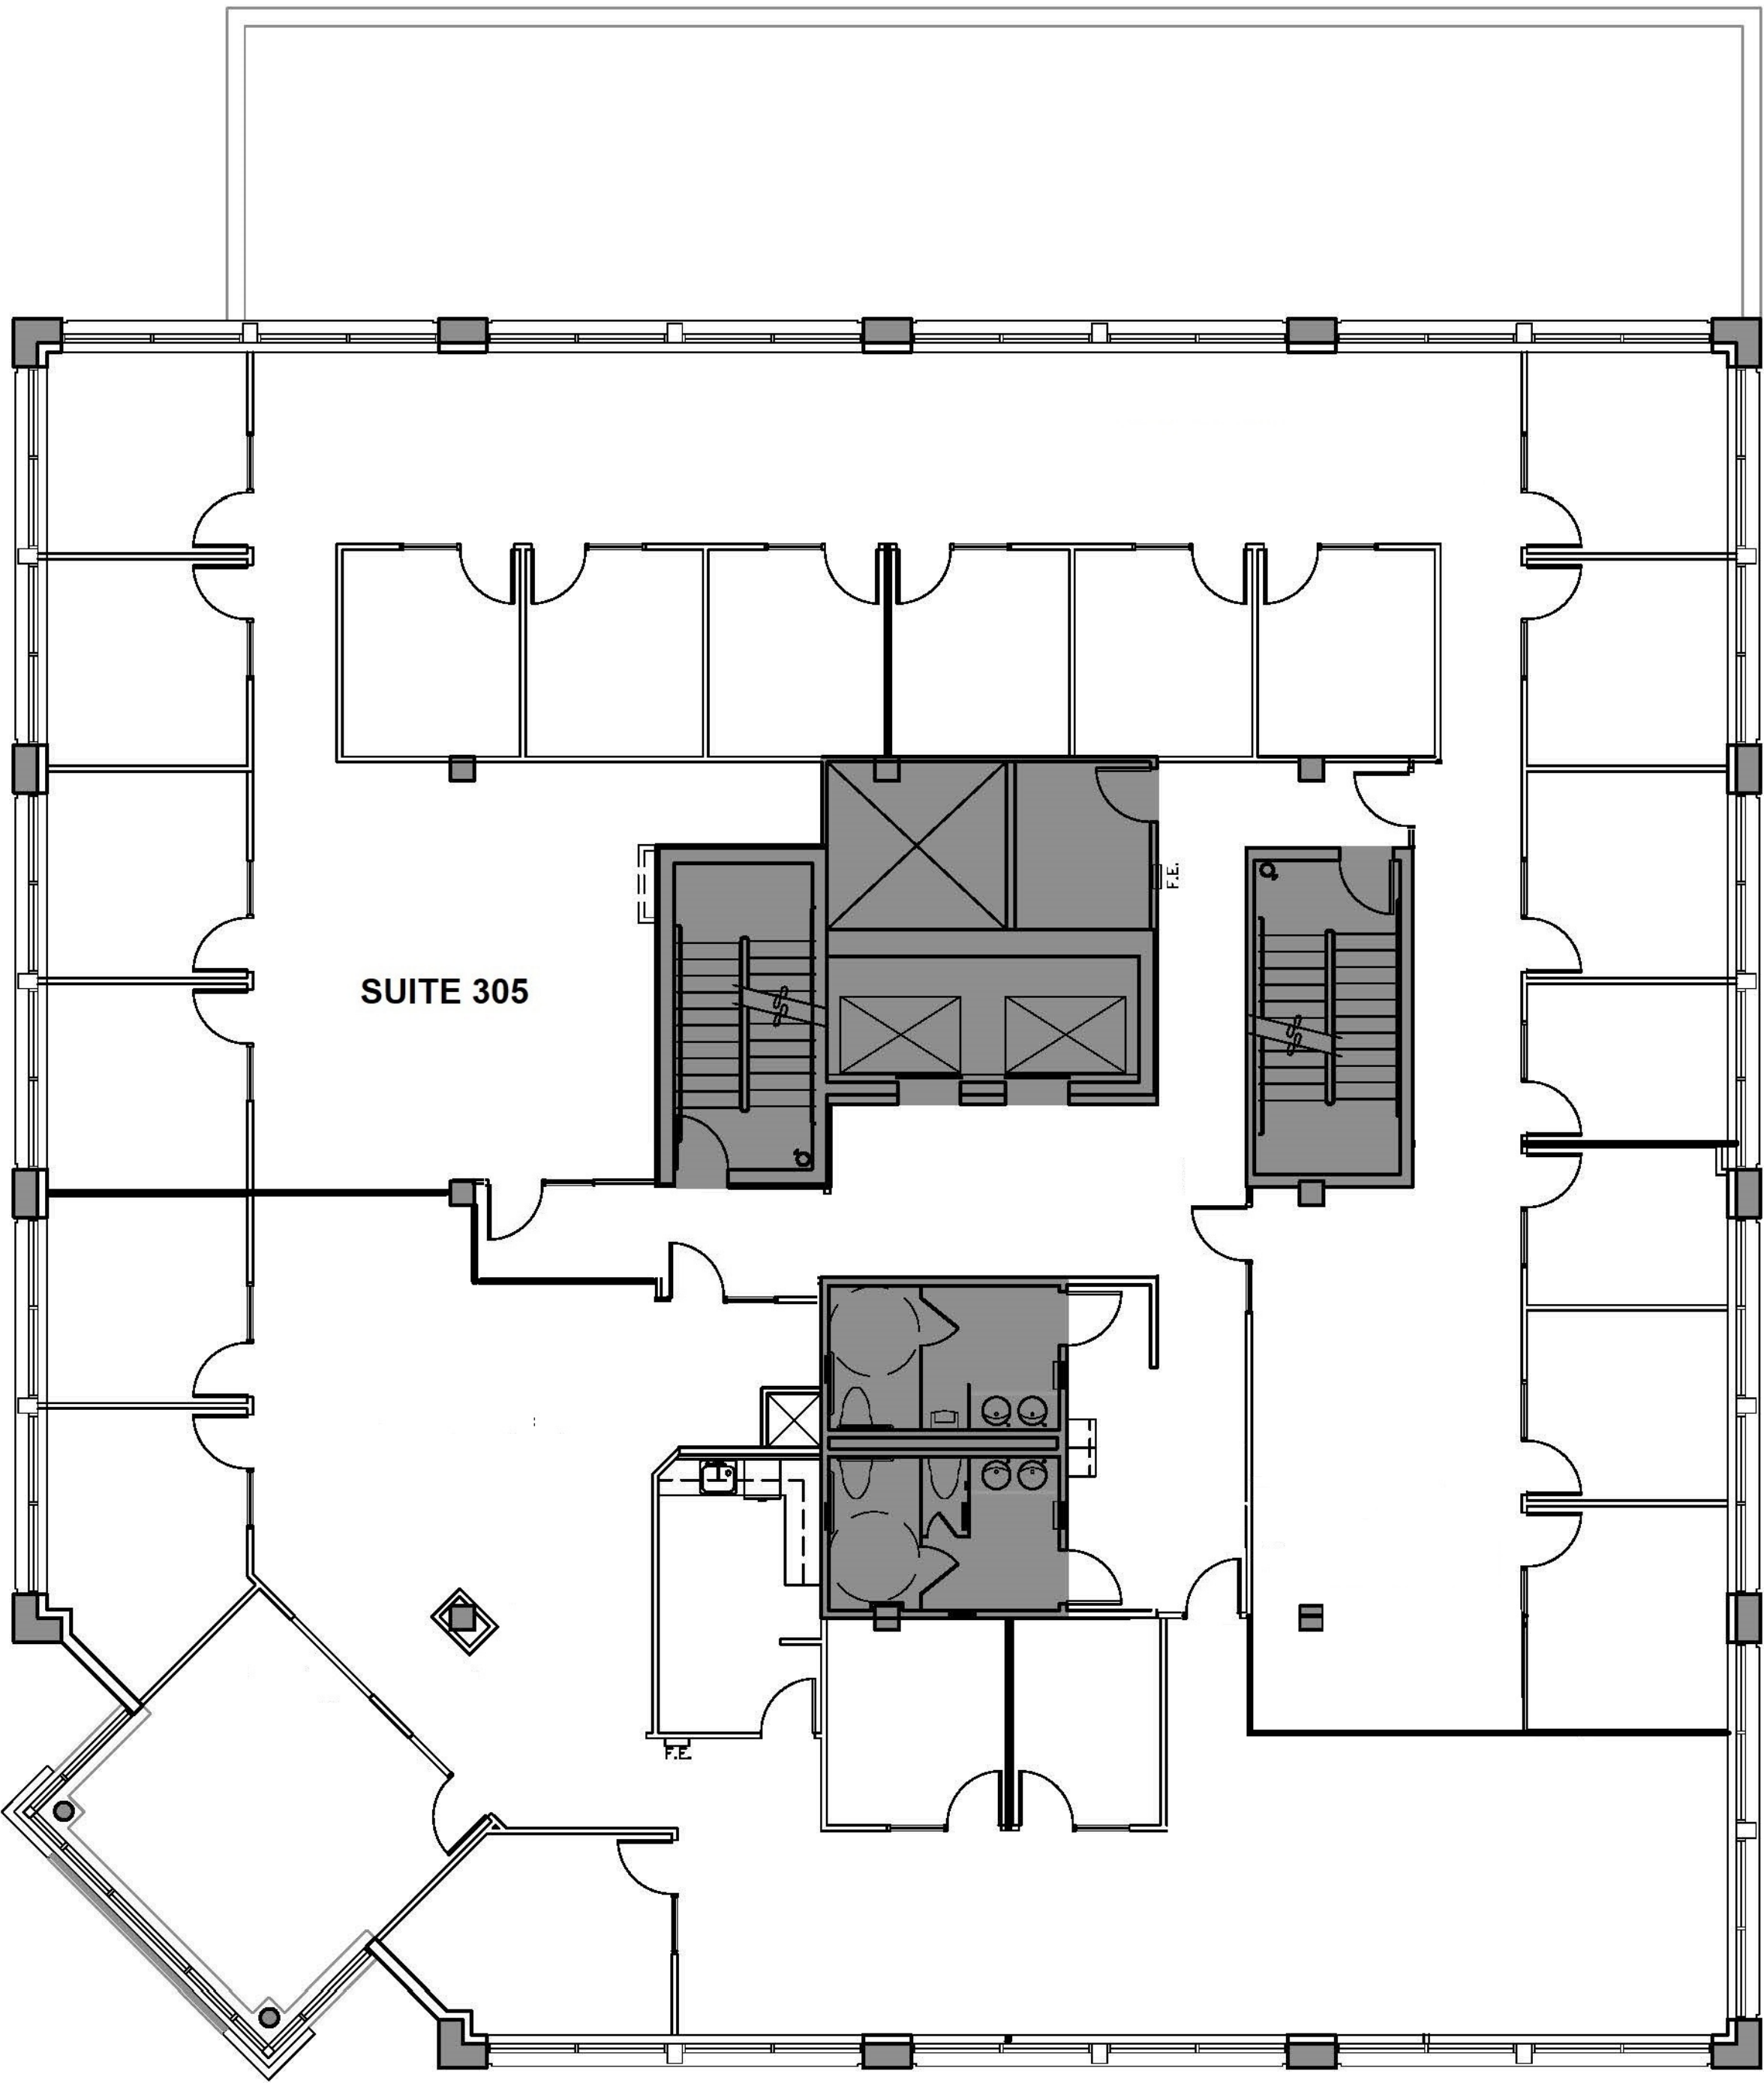


DEMOLITION SYMBOLS

- EXISTING CONSTRUCTION TO BE REMOVED
- EXISTING CONSTRUCTION TO REMAIN

GENERAL DEMOLITION NOTES

1. REFER TO CONSTRUCTION PLAN AND CEILING PLAN FOR EXTENT OF DEMOLITION.
2. SAVE AND STORE ALL LIGHT FIXTURES, EXIT SIGNS, DOORS & HARDWARE FOR RE-USE, UON.
3. SAVE ALL EXISTING PLUMBING FIXTURES FOR RE-USE, UON.
4. REMOVE ALL TELEPHONE, ELECTRICAL, AND DATA OUTLETS, FIXTURES, PANELS, ETC FROM ALL DEMOLISHED PARTITIONS. REMOVE ALL CORRESPONDING CABLES, CONDUIT, WIRING, ETC. ALL THE WAY BACK TO THE ORIGINATING SOURCE, UON.

KEYED SHEET NOTES

- REMOVE PORTION OF EXISTING PARTITION.

Tenant:

45TH STREET PLAZA  
1100 NE 46TH STREET, SUITE 300  
SEATTLE, WA

A Tenant Improvement for:  
**THE BLUME COMPANY**  
617 EASTLAKE AVE E, STE 340  
SEATTLE, WA 98109

**burgess design | interiors + architecture**

1326 Fifth Avenue, Suite 400, Seattle, Washington 98101 T: (206) 587.7120 F: (206) 587.7122

**All reproduction & intellectual property rights reserved c 2013**

Professional seal

| No. | Issue Description | Date |
|-----|-------------------|------|
|     |                   |      |
|     |                   |      |
Drawn by: TS Project Manager: TS

Project No: 13-0199-00

Original drawing is 24" x 36". Scale entities accordingly if reduced