



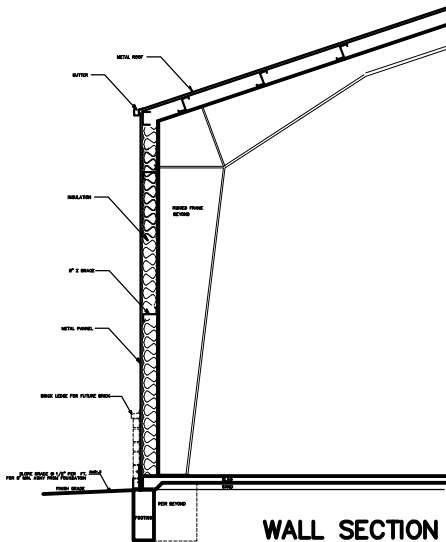


WALL SECTION

GENERAL NOTES

- CONTRACTOR SHALL FIELD VERIFY CONDITIONS AND DIMENSIONS PRIOR TO WORK AND SHALL BE RESPONSIBLE FOR WORK AND MATERIALS INCLUDING THOSE FURNISHED BY SUBCONTRACTORS. CONTRACTOR SHALL ACCEPT PREMISES AS FOUND. OWNER ASSUMES NO RESPONSIBILITY FOR THE CONDITIONS AT THE TIME OF BIDDING OR THEREAFTER.
- CONSTRUCTION SHALL COMPLY WITH APPLICABLE BUILDING CODES.
- CONTRACTOR SHALL REPORT TO THE ARCHITECT INCONSISTENCIES OR OMISSIONS DISCOVERED. THE MEANS OF CORRECTION SHALL FIRST BE APPROVED BY THE ARCHITECT AND OWNER.
- GENERAL BUILDING PERMITS WILL BE PAID FOR BY OWNER. OTHER FEES AND PERMITS SHALL BE SECURED BY THE CONTRACTOR OR SUB. DIRECTLY RESPONSIBLE.
- DERBIES SHALL BE REMOVED FROM PREMISES AND AREAS SHALL BE LEFT IN A "BROOM" CLEAN CONDITION AT ALL TIMES.
- CONTRACTOR SHALL TAKE NECESSARY PRECAUTIONS TO ENSURE SAFETY.
- CONTRACTOR SHALL PROVIDE BLOCKING AS REQUIRED FOR MOUNTING OBJECTS ON WALLS.
- SILICONE CAULK SHALL BE USED AT THE FOLLOWING LOCATIONS:
 - METAL DOOR
 - WINDOW FRAMES, SILLS AND JAMBS
 - CONDUIT AND PIPE PENETRATIONS AT WALLS, FLOOR AND CEILINGS
 - PLUMBING FIXTURES
 - JUNCTURE OF MILLWORK (CABS, SHELVES)
- FOR CONSTRUCTION DETAILS NOT SHOWN USE THE MANUFACTURERS STANDARD
- ALL EXTERIOR DOORS WILL BE EQUIPPED WITH PANIC HARDWARE
- ALL FIRE RATED WALLS SHALL HAVE ALL PENETRATIONS FILLED WITH FIRE CAULK

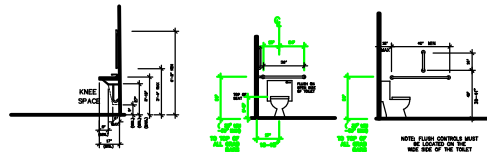

NOTE:
ALL SWITCHES AND THERMOSTATS SHALL BE INSTALLED AT 48 INCHES ABOVE THE FLOOR. SWITCHES AND ELECTRICAL PLUGS ABOVE CABINETS SHALL BE AT 44 INCHES. PLUGS ON WALLS SHALL BE MOUNTED 10 INCHES OR GREATER ABOVE THE FLOOR. (MEASURED FROM THE CENTER OF THE BOTTOM PLUG)

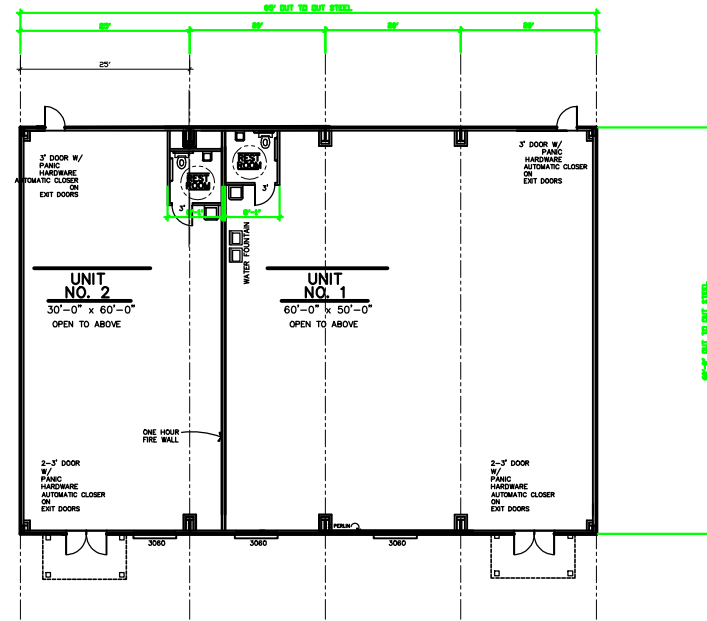

FIRST FLOOR FRAMING PLAN

SCALE: 1/8" = 1'-0"

DRAWN BY:
STEVIE STEWART ARCHITECT
1203 WEST 10TH STREET
AMARILLO, TEXAS 79101
(806) 342-4848

0 BUSINESS PARK DRIVE
AMARILLO, TEXAS



DATE	
REVISION	
BY	
CHECKED	
DATE	
PLAN NO.	1700
DATE	JAN. 2017

A-3