




22515 HESLIP DR.  
NOVI, MI 48375  
P:734.326.1210 F:734.326.1217

DATE: 08-17-23 SCALE: 3/8" = 1'-0" DRAWN BY: MJS

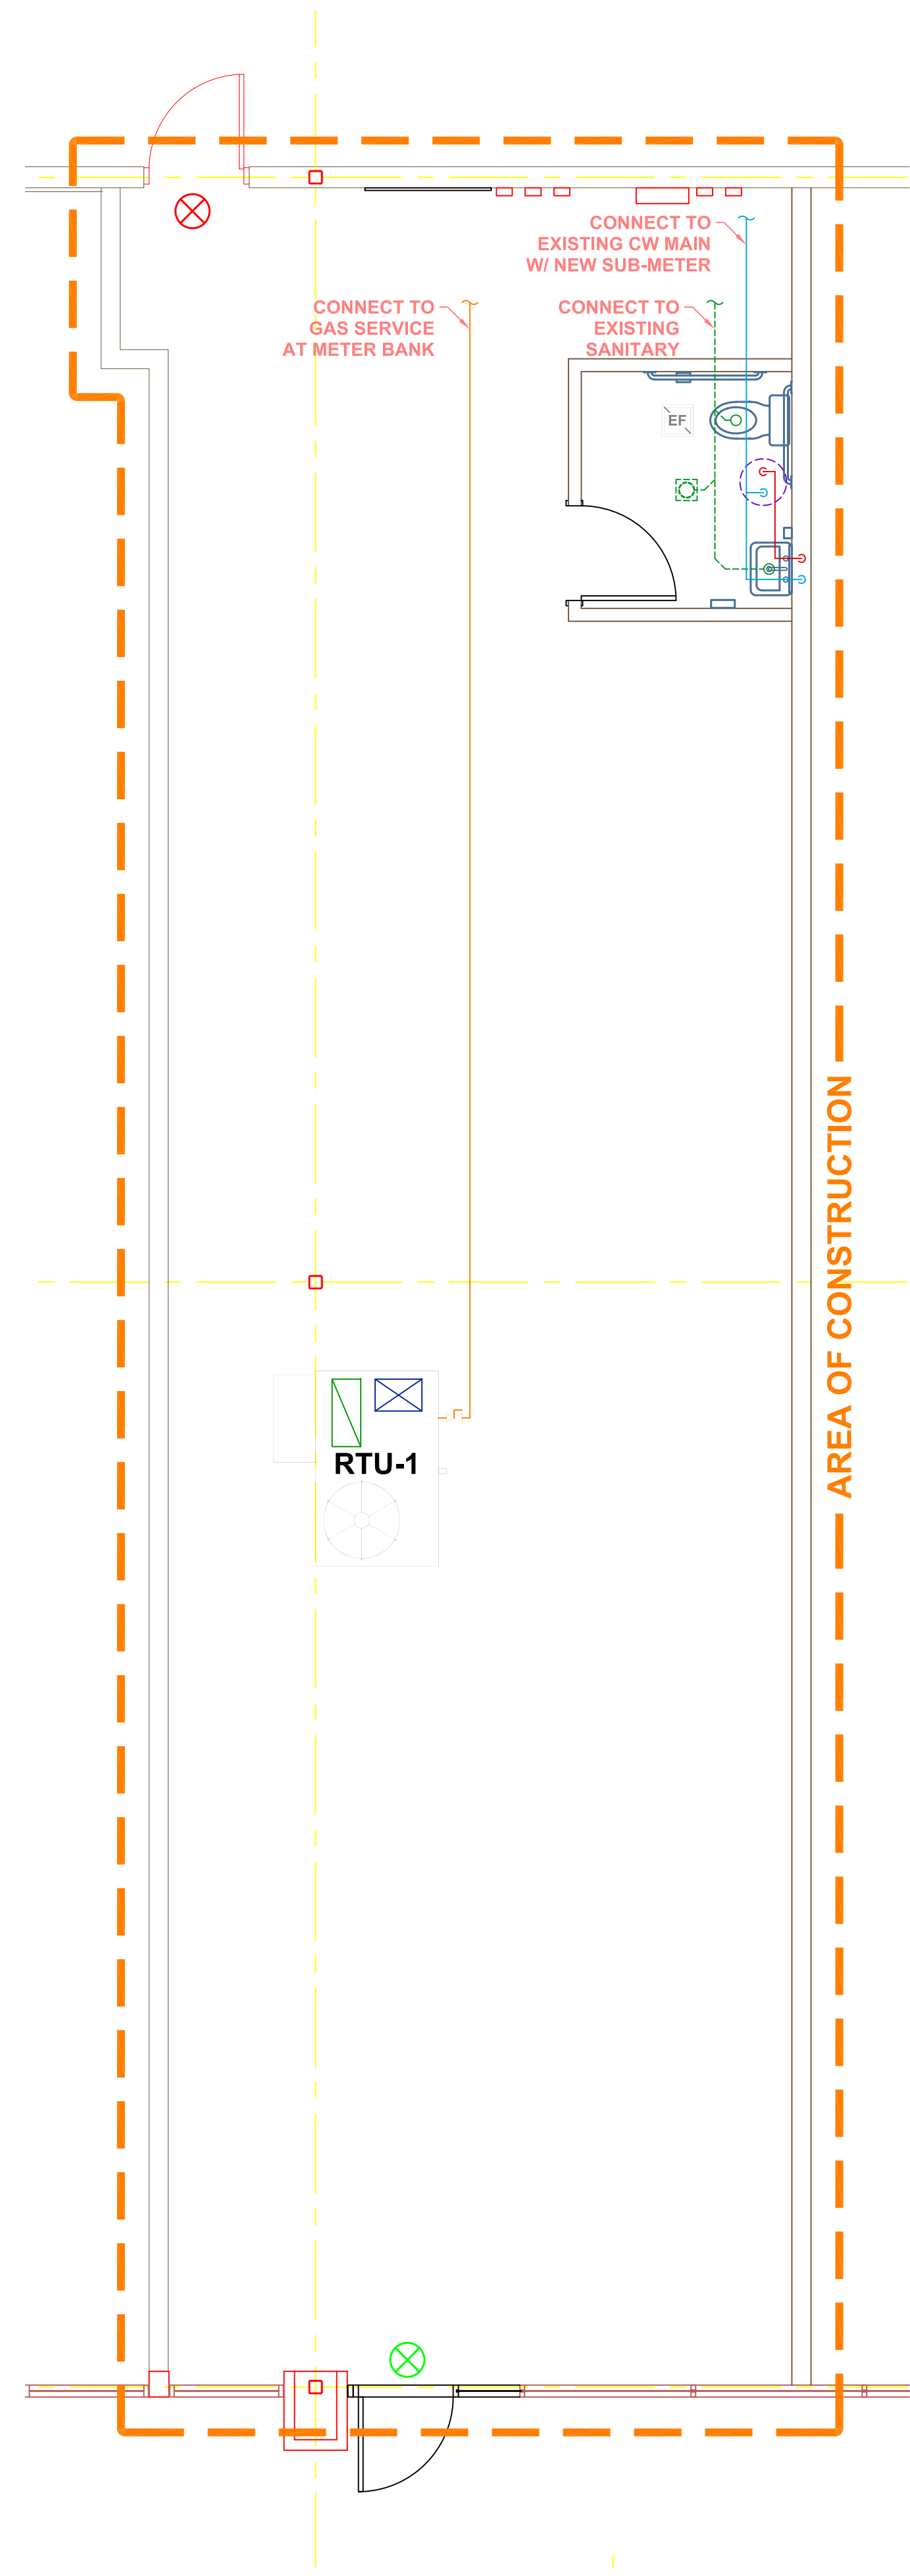

ROOFTOP UNIT/HVAC EQUIPMENT SCHEDULE																	
TAG	MANUF.	MODEL	TONNAGE	COOLING MBH		HEATING MBH		ELECTRICAL							DIMENSIONS	WEIGHT	NOTES
				TOTAL	SENS.	IN	OUT	TOTAL CFM	OUTSIDE AIR (MIN.)	PHASE	VOLTAGE	MCA	MOC	MOP			
RTU-1	BRYANT	580JP09D180A2A0AD	4	106.82	83.82	120	98	3800	---	3	460	42	50	74 1/2" x 46 1/2" x 33 1/2"	543 LBS		


EXHAUST FAN SCHEDULE									
TAG	MANUFACTURER & MODEL NUMBER	AREA SERVED	CFM	ESP "WC	DRIVE TYPE	FAN TYPE	ELECTRICAL		NOTES
							HP / WATTS	VOLTS / PHASE	
EF-1	BROAN 679	TOILET	70	0.25	DIRECT	CEILING-MOUNT	---	115V / 1PH	

PLUMBING FIXTURE SCHEDULE			
UNIT ID	BARRIER FREE	MANUFACTURER/ MODEL NO.	MANUFACTURER/ MODEL NO.
LAV-1	Y	WALL-MOUNT ADA SINK W/ FAUCET	PROFLO SINK M#: PF5514WH FAUCET M#: PFWSC4744CP
SK-1	Y	STAINLESS STEEL DROP-IN SINK W/ FAUCET	PROFLO SINK M#: PFSR252263BP FAUCET M#: PFX308
WC-1	Y	FLOOR-MOUNT ADA TANK-TYPE WATER CLOSET W/ SEAT	PROFLO M#: PF1403T
WH-1	---	6-GALLON ELECTRIC WATER HEATER	BRADFORD WHITE M#: RE16U6

PROPOSED HVAC & PLMB PLAN

**VACANT SPACE**

43303 CRESCENT BLVD.  
NOVI, MI 48375

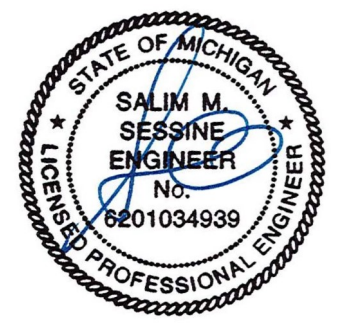

NOTES:	DATE:

**MP-002**