


IT IS A VIOLATION OF THE NYS EDUCATION LAW FOR ANY PERSON, UNLESS HE IS ACTING UNDER THE DIRECTION OF A LICENSED PROFESSIONAL ENGINEER OR LAND SURVEYOR, TO ALTER THIS DOCUMENT. IF A DOCUMENT BEARING THE SEAL OF AN ENGINEER OR LAND SURVEYOR IS ALTERED, THE ALTERING ENGINEER OR LAND SURVEYOR SHALL AFFIX TO THE DOCUMENT HIS/HER SEAL, AND THE NOTATION "ALTERED BY" FOLLOWED BY HIS/HER SIGNATURE, THE DATE OF THE ALTERATION, AND A SPECIFIC DESCRIPTION OF THE ALTERATION.

IT IS A VIOLATION OF THE NYS EDUCATION LAW FOR ANY PERSON, UNLESS HE IS ACTING UNDER THE DIRECTION OF A LICENSED PROFESSIONAL ENGINEER OR LAND SURVEYOR, TO ALTER THIS DOCUMENT. IF A DOCUMENT BEARING THE SEAL OF AN ENGINEER OR LAND SURVEYOR IS ALTERED, THE ALTERING ENGINEER OR LAND SURVEYOR SHALL AFFIX TO THE DOCUMENT HIS/HER SEAL, AND THE NOTATION "ALTERED BY" FOLLOWED BY HIS/HER SIGNATURE, THE DATE OF THE ALTERATION, AND A SPECIFIC DESCRIPTION OF THE ALTERATION.

ECN #	REV	ZONE	DESCRIPTION	DATE	BY	APPVD

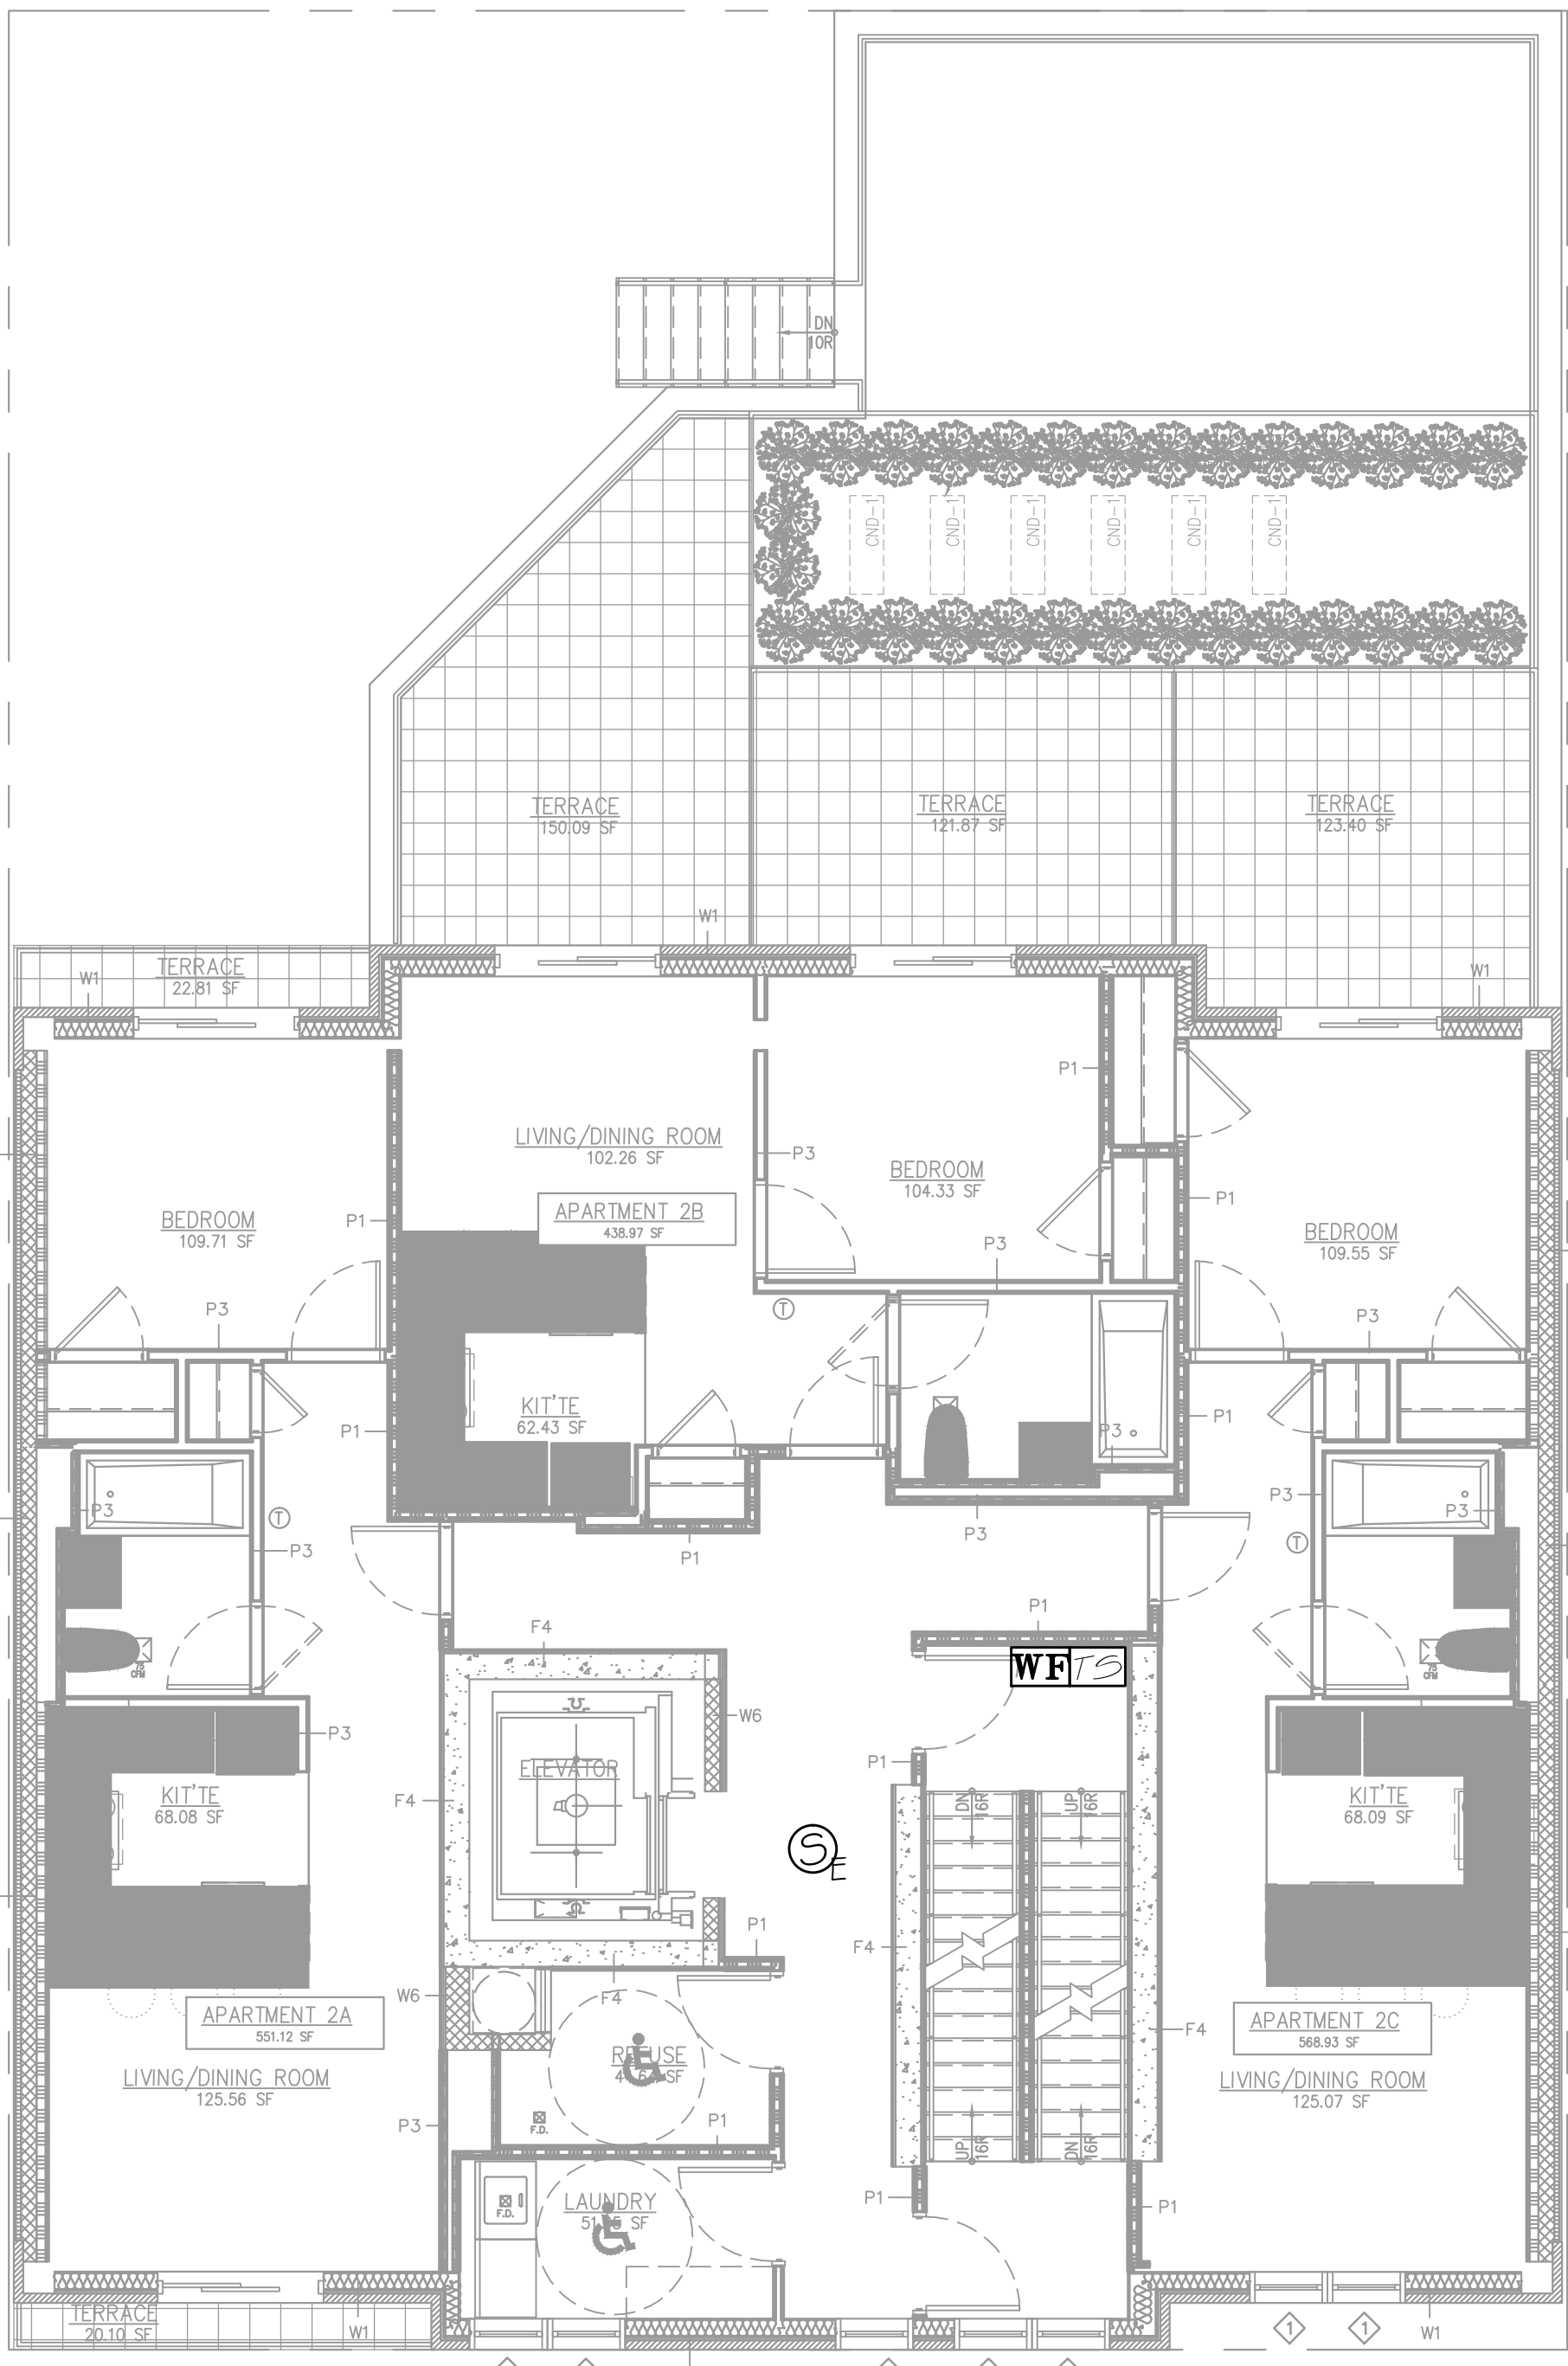


2nd FLOOR PLAN

	NEW SMOKE DETECTOR CEILING MOUNTED (UL LISTED) 2 PLACES THIS PAGE
	NEW SMOKE DETECTOR CEILING MOUNTED WITH ELEVATOR RECALL CAPABILITY (UL LISTED) 4 PLACES THIS PAGE
	NEW CLASS III MANUAL PULL STATION (UL LISTED) 1 PLACE THIS PAGE
	NEW TAMPER SWITCH (UL LISTED) 9 PLACES THIS PAGE
	NEW DRY SYSTEM WATER FLOW PRESSURE SWITCH (UL LISTED) 1 PLACE THIS PAGE
	NEW SENSOR (UL LISTED) DRY SYSTEM HIGH PRESSURE 1 PLACE THIS PAGE
	NEW SENSOR (UL LISTED) DRY SYSTEM LOW PRESSURE 1 PLACE THIS PAGE
	NEW WET SYSTEM WATER FLOW PADDLE SWITCH (UL LISTED) 3 PLACES THIS PAGE


ATTENTION CONTRACTOR
CONFIRM COMPATIBILITY OF ALL DEVICES
WITH EXISTING BUILDING FIRE ALARM
CONTROL PANEL.

DESIGNED BY G.MORTMAN	DATE 4/10/15	AUTOMATED DESIGN CONSULTANTS 15 HARDS CRABBLE HILL ROAD CHAPPAQUA, NY 10514 (914) 238-1702	TITLE FIRE ALARM PLANS FLOORS C-R	
DRAWN BY G.MORTMAN	DATE 4/10/15			
CHECKED BY	DATE			
APPROVED BY	DATE		CLIENT CHRIS PAPA, RA 22-02 STEINWAY STREET ASTORIA NY 11105 718-777-5200 516-482-4820	
SEAL		PROJECT 25-34 31st STREET QUEENS NY 11102 MIXED USE MULTI-DWELLING	DOB BAR CODE	
		DOB STAMPS		
			DWG. #	REV.
			FA-001.00	
		PROJECT # 150201	SCALE 1/8"=1'	SHT. 1 OF 3

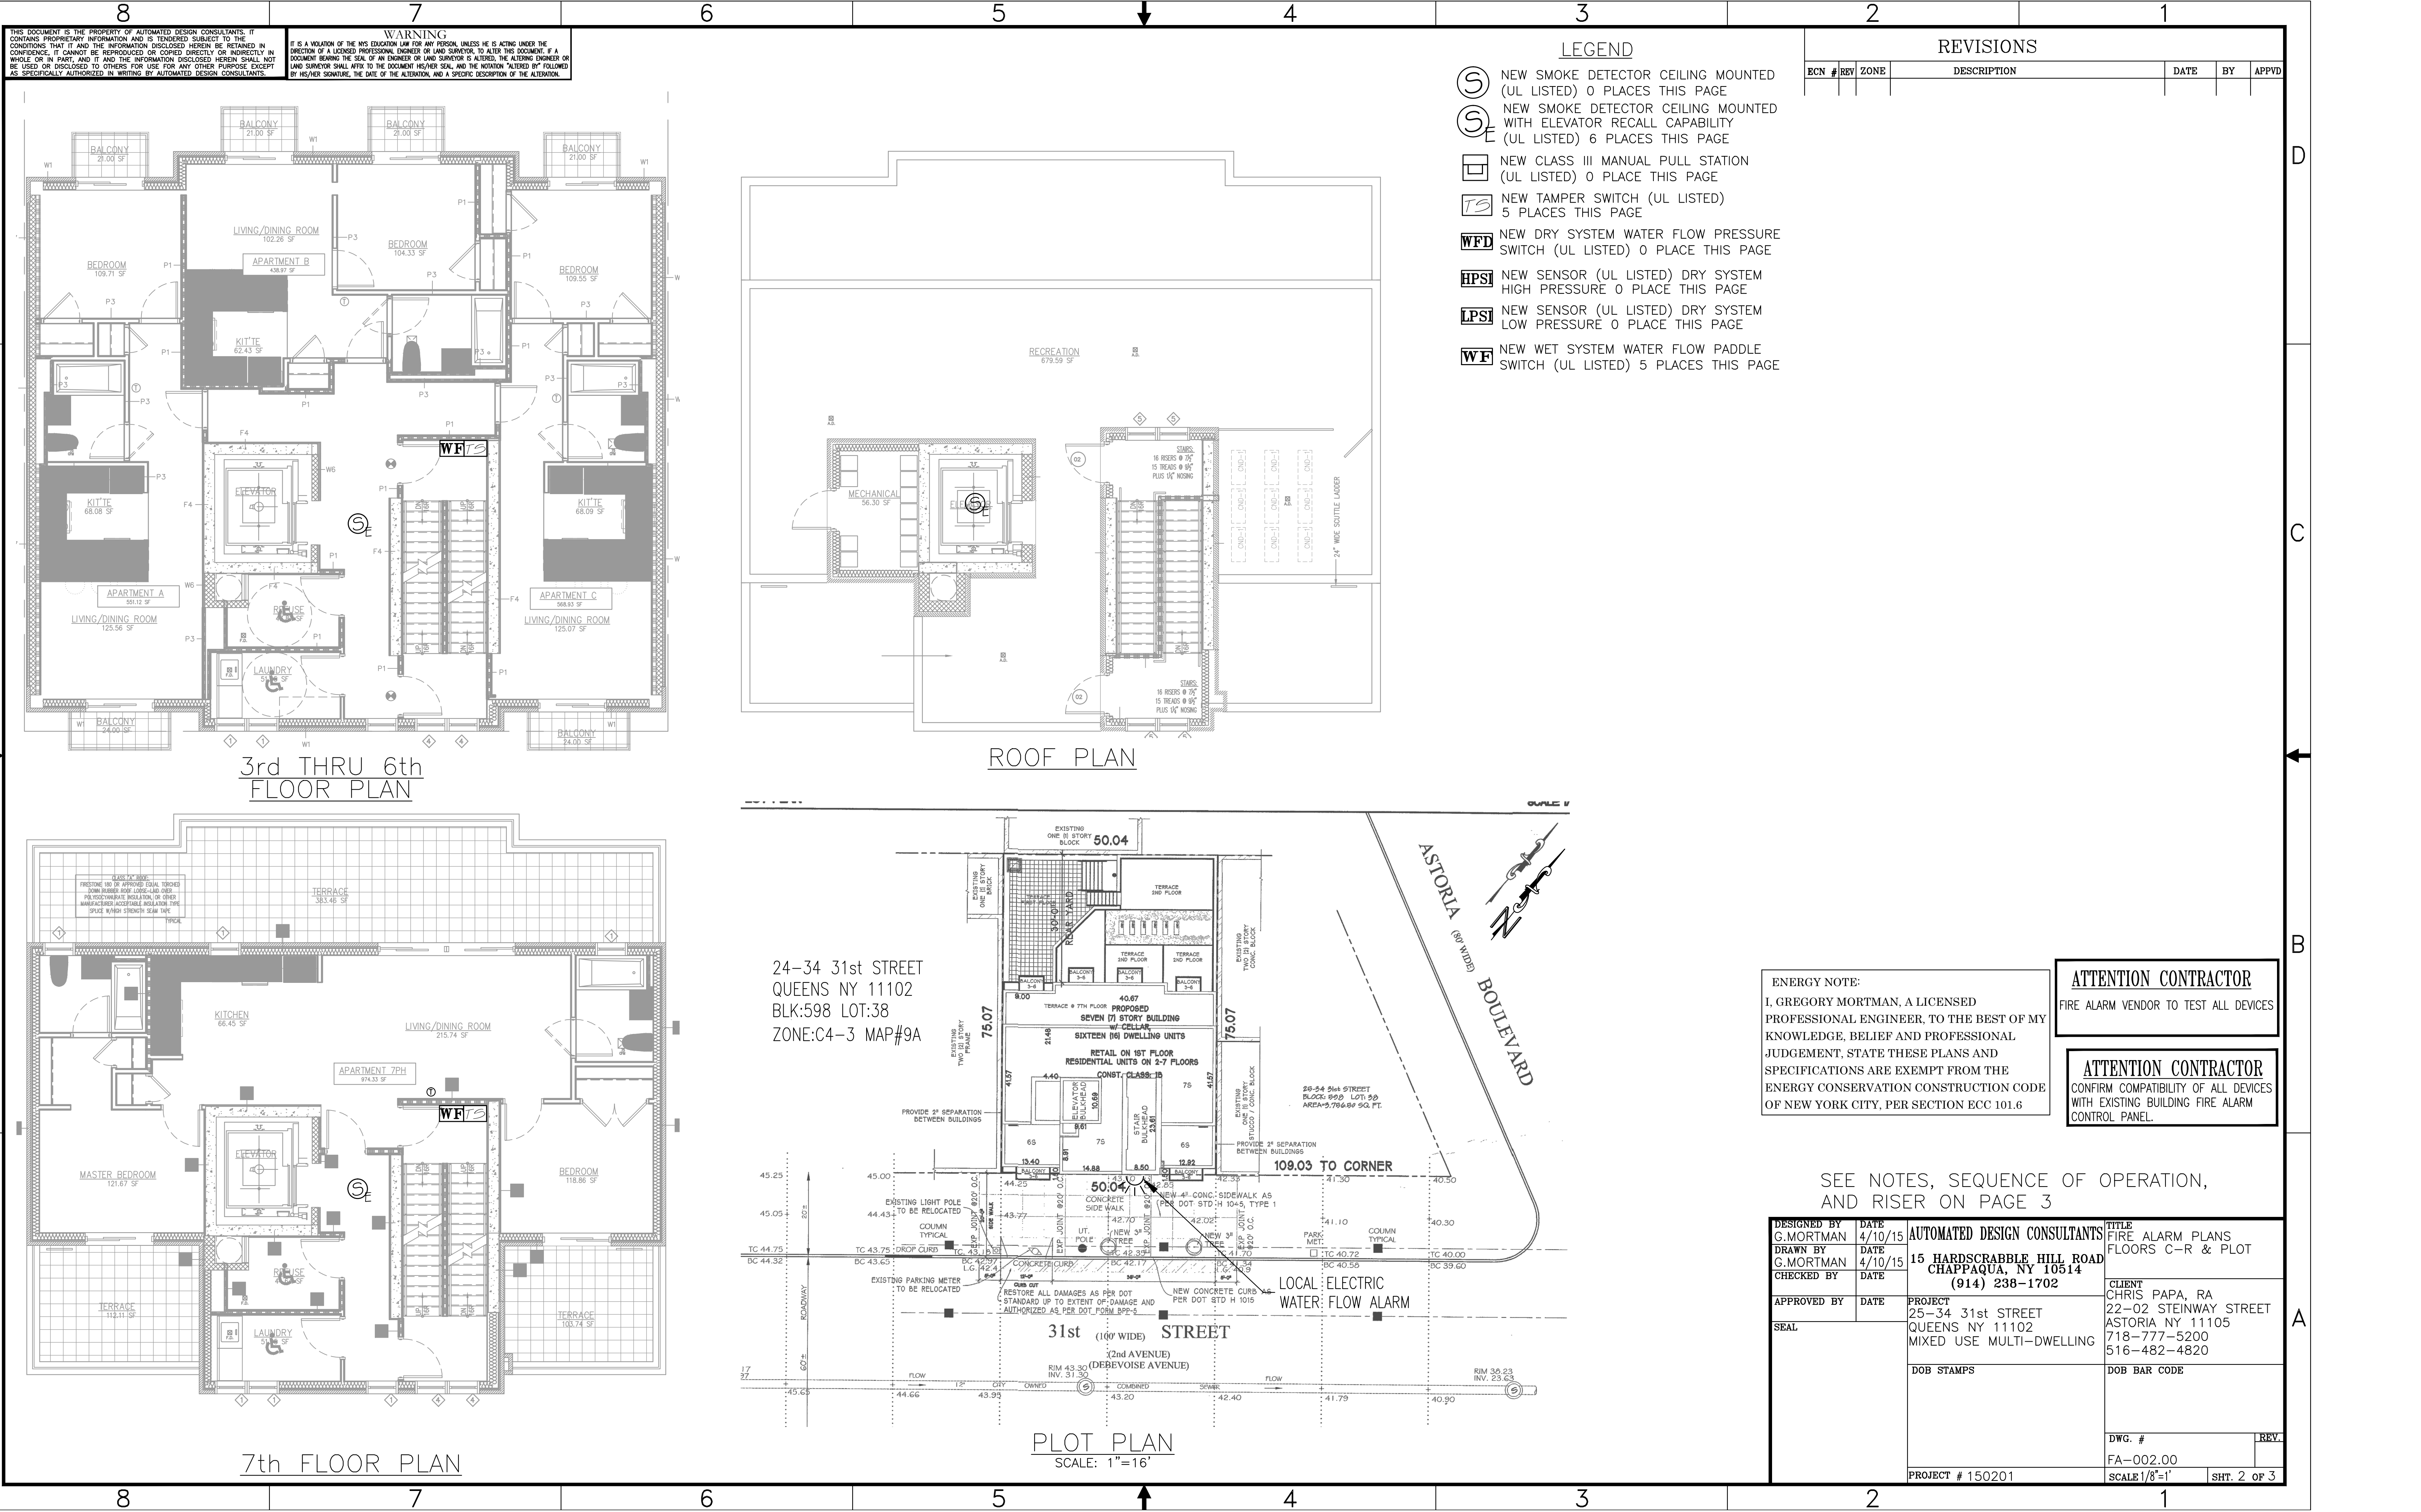

A

THIS DOCUMENT IS THE PROPERTY OF AUTOMATED DESIGN CONSULTANTS, INC. IT CONTAINS PROPRIETARY INFORMATION AND IS LOANED TO YOU BY THE COMPANY. IT IS TO BE USED ONLY FOR THE PROJECT AND SITE SPECIFICALLY AUTHORIZED IN WRITING BY AUTOMATED DESIGN CONSULTANTS, INC. IF IT IS A VIOLATION OF THE NYS EDUCATION LAW FOR ANY PERSON, UNLESS HE IS ACTING UNDER THE DIRECTION OF A LICENSED PROFESSIONAL ENGINEER OR LAND SURVEYOR, TO ALTER THIS DOCUMENT. IF A DOCUMENT BEARING THE SEAL OF AN ENGINEER OR LAND SURVEYOR IS ALTERED, THE ALTERING ENGINEER OR LAND SURVEYOR SHALL AFFIX TO THE DOCUMENT HIS/HER SEAL, AND THE NOTATION "ALTERED BY" FOLLOWED BY HIS/HER SIGNATURE, THE DATE OF THE ALTERATION, AND A SPECIFIC DESCRIPTION OF THE ALTERATION.

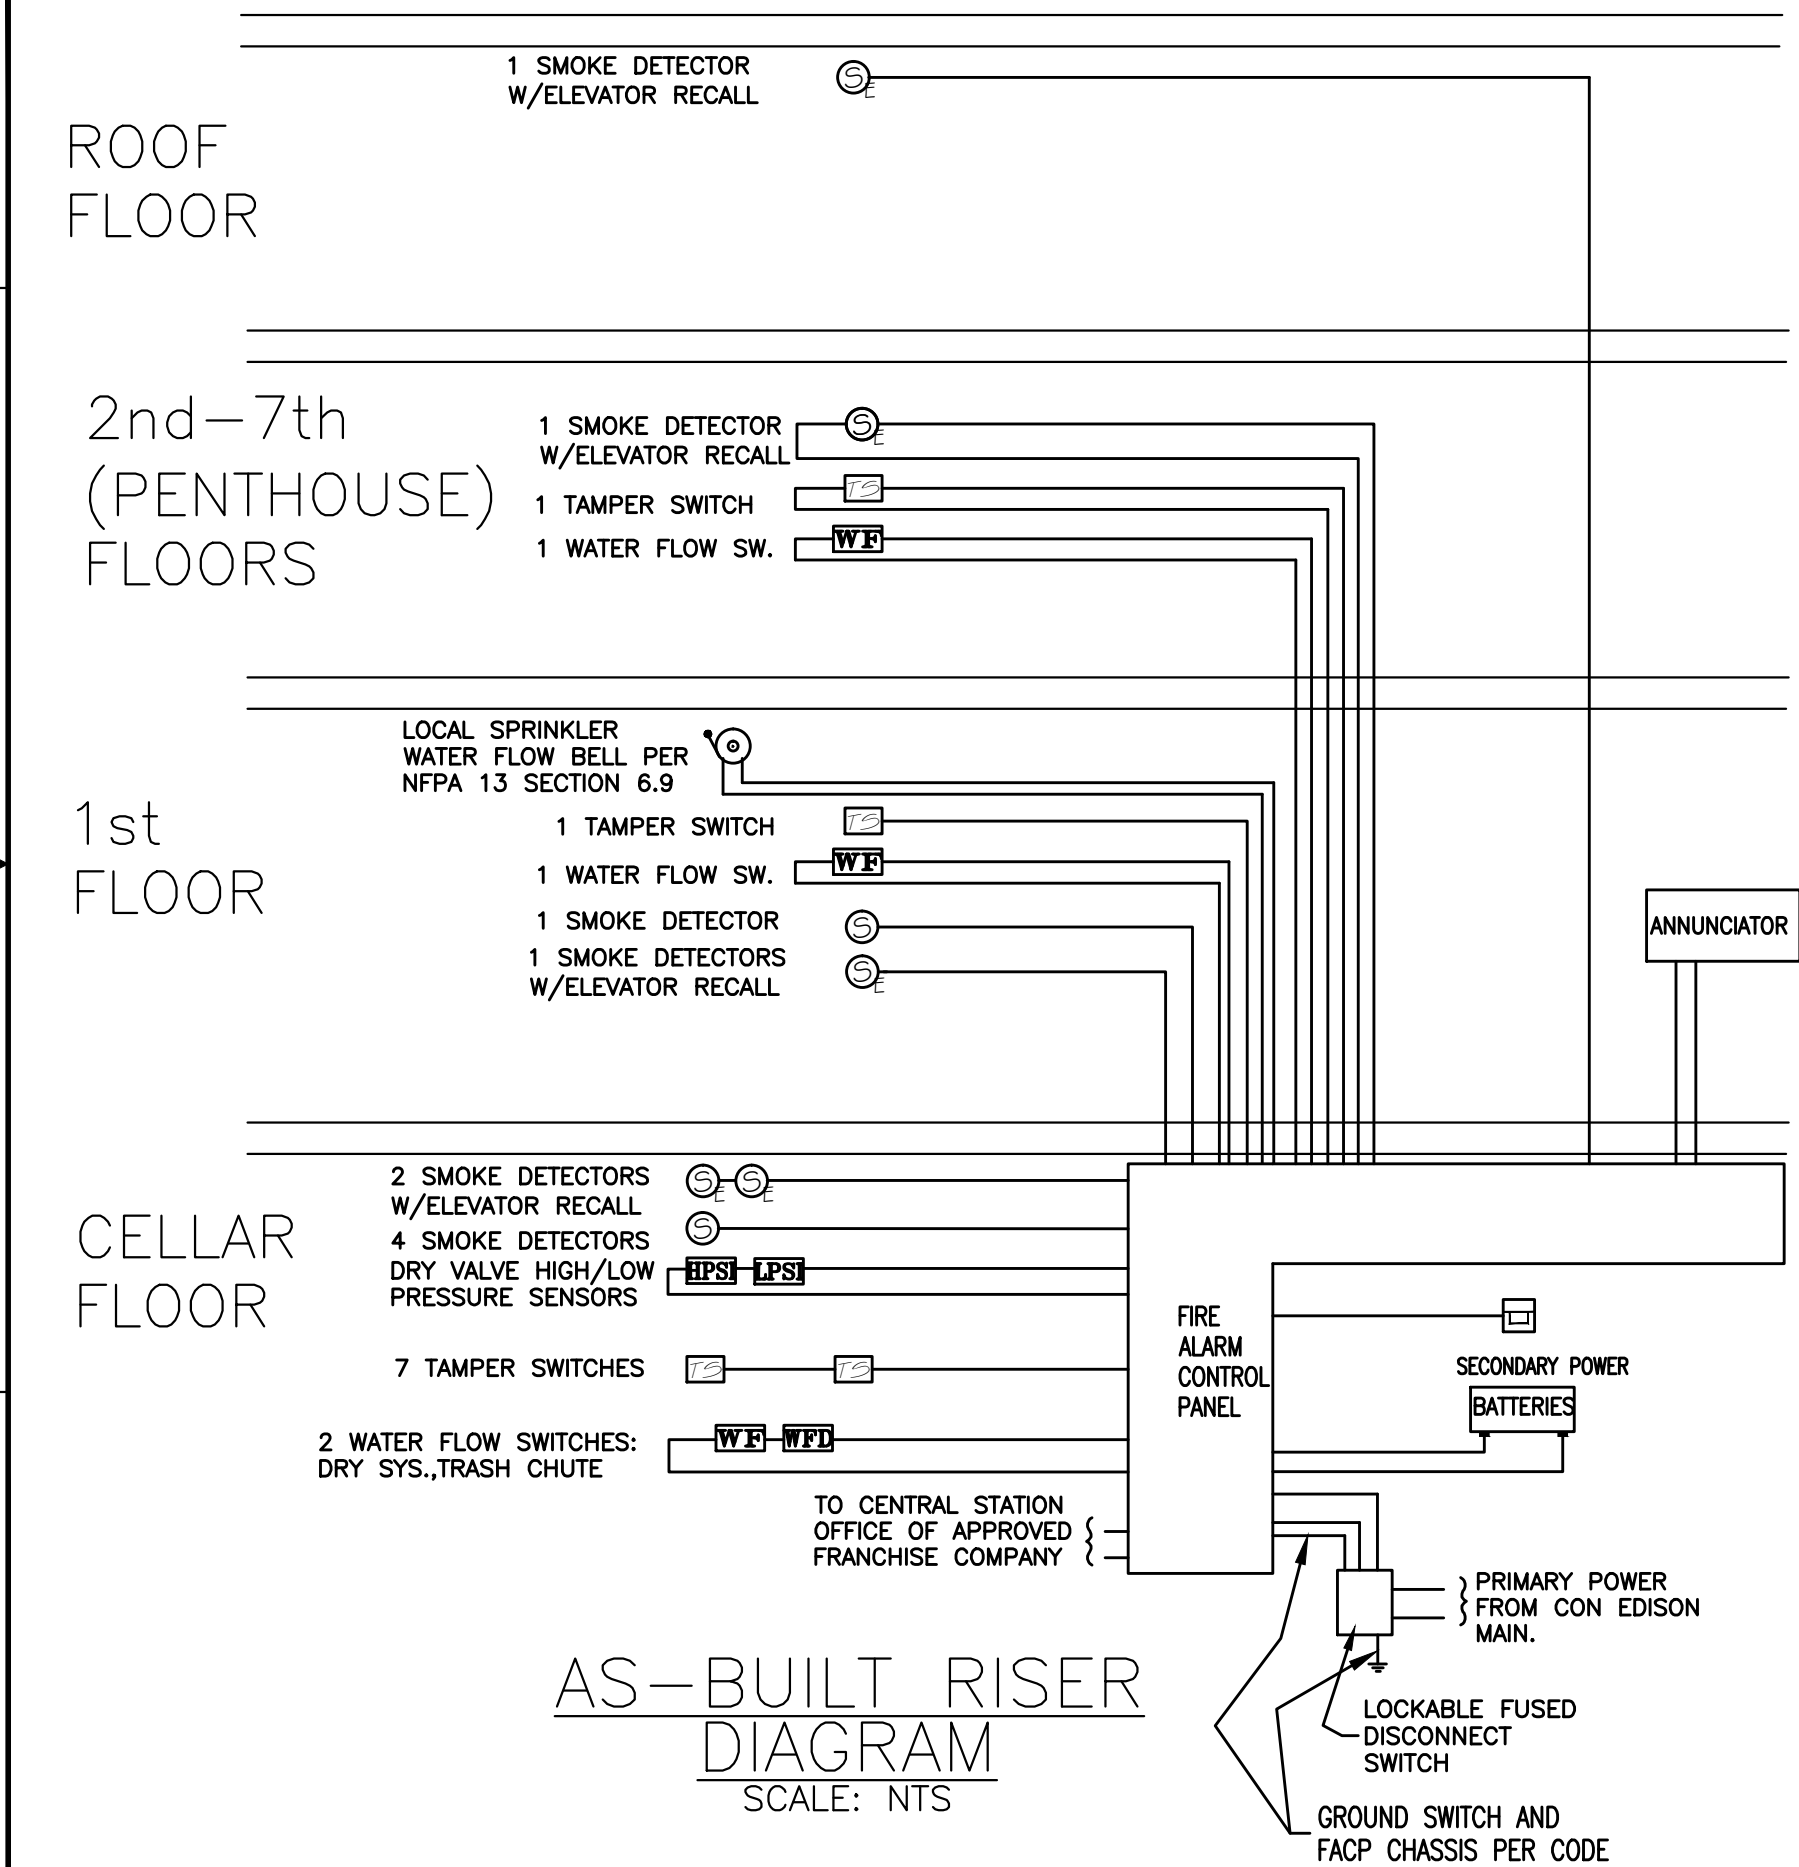

AS-BUILT RISER
DIAGRAM
SCALE: NTS

- LEGEND**
- NEW SMOKE DETECTOR CEILING MOUNTED (UL LISTED) 2 PLACES TOTAL
 - NEW SMOKE DETECTOR CEILING MOUNTED WITH ELEVATOR RECALL CAPABILITY (UL LISTED) 10 PLACES TOTAL
 - NEW CLASS III MANUAL PULL STATION (UL LISTED) 1 PLACE TOTAL
 - NEW TAMPER SWITCH (UL LISTED) 14 PLACES TOTAL
 - NEW DRY SYSTEM WATER FLOW PRESSURE SWITCH (UL LISTED) 1 PLACE TOTAL
 - NEW SENSOR (UL LISTED) DRY SYSTEM HIGH PRESSURE 1 PLACE TOTAL
 - NEW SENSOR (UL LISTED) DRY SYSTEM LOW PRESSURE 1 PLACE TOTAL
 - NEW WET SYSTEM WATER FLOW PADDLE SWITCH (UL LISTED) 8 PLACES TOTAL

REVISIONS						
ECN	#	REV	ZONE	DESCRIPTION	DATE	BY

SEQUENCE OF OPERATION						
	Area Smoke Detector	Water Flow Switch	Trouble Condition Dry High/low PSI, etc.	CLASS III Manual Pull Station	Elevator lobby, machine room, and/or top of shaft smoke detector	Tamper switch
Display alert @ Annunciator with area indication	X	X		X	X	
Automatic Alarm signal to central office	X	X		X	X	
Manual Alarm signal to central office				X		
Trouble signal to central office			X			
Supervisory Signal to central office						X
Activates local water flow bell		X				
Recall elevator to designated floor		X		X	X	

I, BRENDAN LALLY, NYS FIRE ALARM INSTALLER #, CERTIFY THAT THE FIRE ALARM SYSTEM FILED UNDER PW-1 NO. 320727031 HAS BEEN INSTALLED AS PER THE APPROVED PLANS, TESTED, AND OPERATES AS DESIGNED, AND IN ACCORDANCE WITH THE INPUT/OUTPUT PROGRAMMING MATRIX

NYS FIRE ALARM INSTALLER

DESIGNED BY G.MORTMAN	DATE 4/10/15	AUTOMATED DESIGN CONSULTANTS 15 HARDSCRABBLE HILL ROAD CHAPPAQUA, NY 10514 (914) 238-1702	TITLE FIRE ALARM PLANS AS-BUILT	
DRAWN BY G.MORTMAN	DATE 4/10/15		CLIENT CHRIS PAPA, RA 22-02 STEINWAY STREET ASTORIA NY 11105 718-777-5200 516-482-4820	
CHECKED BY	DATE		PROJECT 25-34 31st STREET QUEENS NY 11102 MIXED USE MULTI-DWELLING	
APPROVED BY	DATE	PROJECT # 150201		DOB BAR CODE
SEAL		DOB STAMPS		DWG. # FA-100.00
		SCALE N/A		SHT. 1 OF 1