


FIRE PROTECTION PLAN NOTES


- EXISTING SPRINKLER HEADS IN AREA OF WORK TO BE DEMOLISHED. REUSE EXISTING SPRINKLER HEAD POINTS OF CONNECTION FOR NEW WORK.
- PROVIDE NEW SPRINKLER HEADS IN AREA OF WORK. REUSE DEMOLISHED SPRINKLER HEAD POINT OF CONNECTION AS NEW POINT OF CONNECTION FOR NEW SPRINKLER HEADS WHERE POSSIBLE.

FIRE PROTECTION
GENERAL NOTES


- PROVIDE NEW SPRINKLER HEADS IN AREA OF WORK. CONTRACTOR SHALL REUSE EXISTING FP MAINS AND BRANCH PIPING FOR NEW WORK WHERE POSSIBLE.
- ROUTING OF NEW BRANCH PIPING SHALL COORDINATE WITH EXISTING STRUCTURAL, UTILITIES AND MECHANICAL DUCTWORK.
- CONTRACTOR SHALL BE REQUIRED TO PROVIDE SPRINKLER SHOP DRAWINGS TO BE SUBMITTED TO ENGINEER AND BUILDING DEPARTMENT.

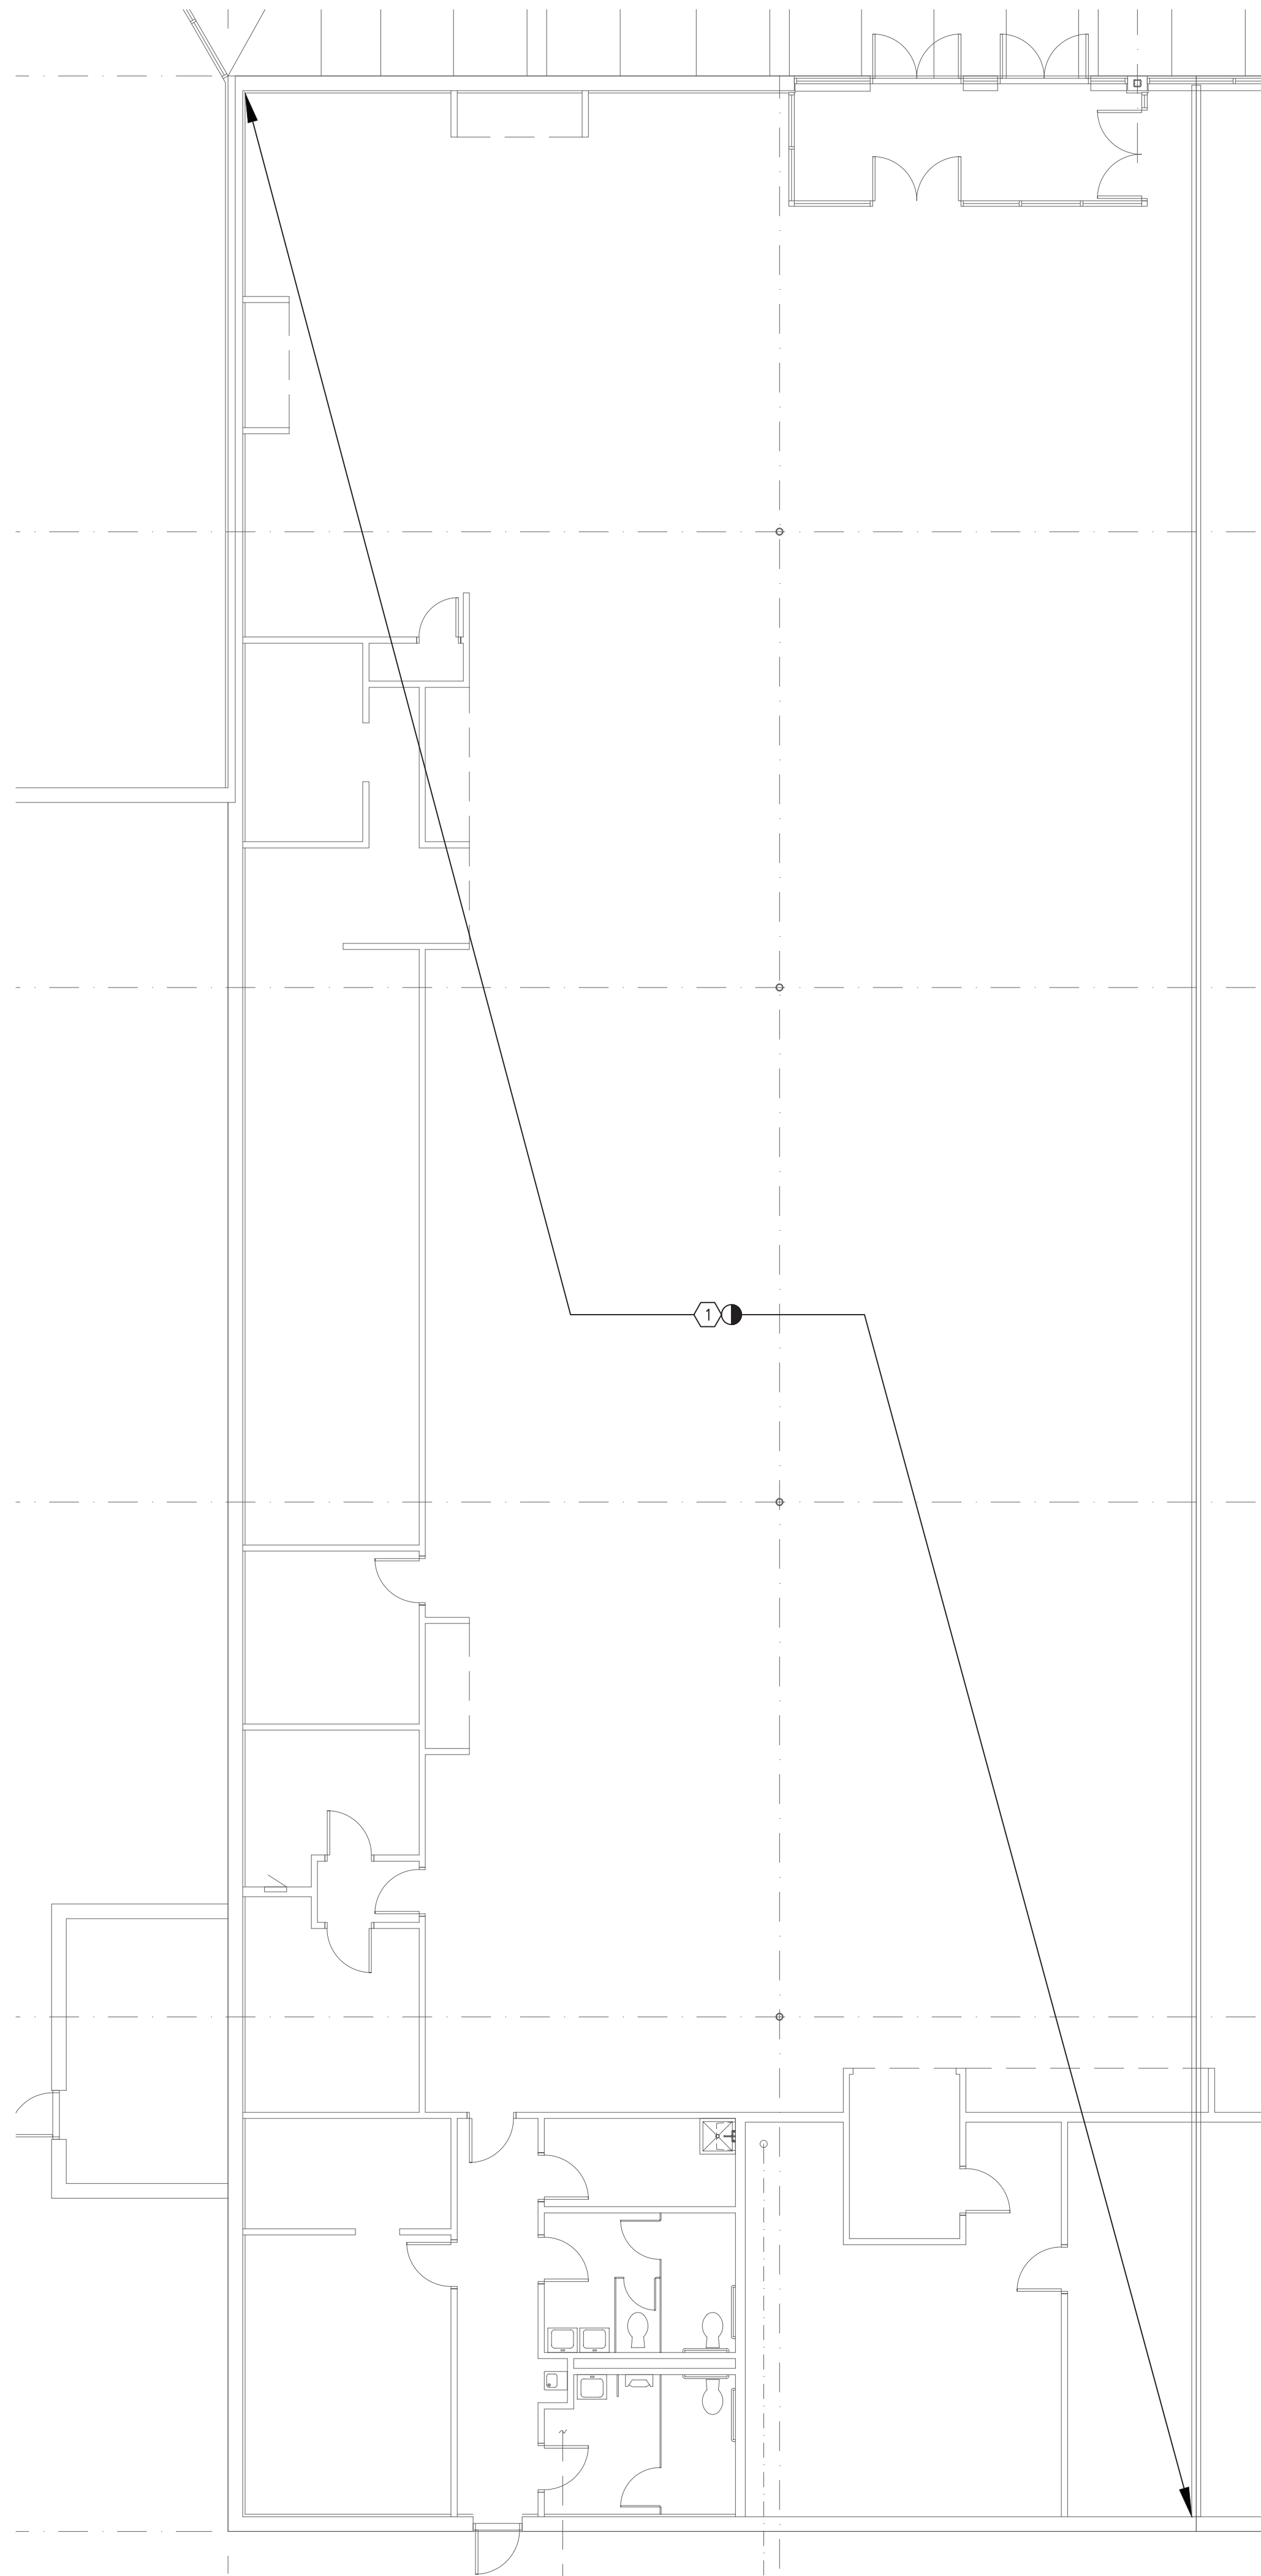

1 FIRE PROTECTION DEMOLITION PLAN
SCALE: 1/8" = 1'-0"

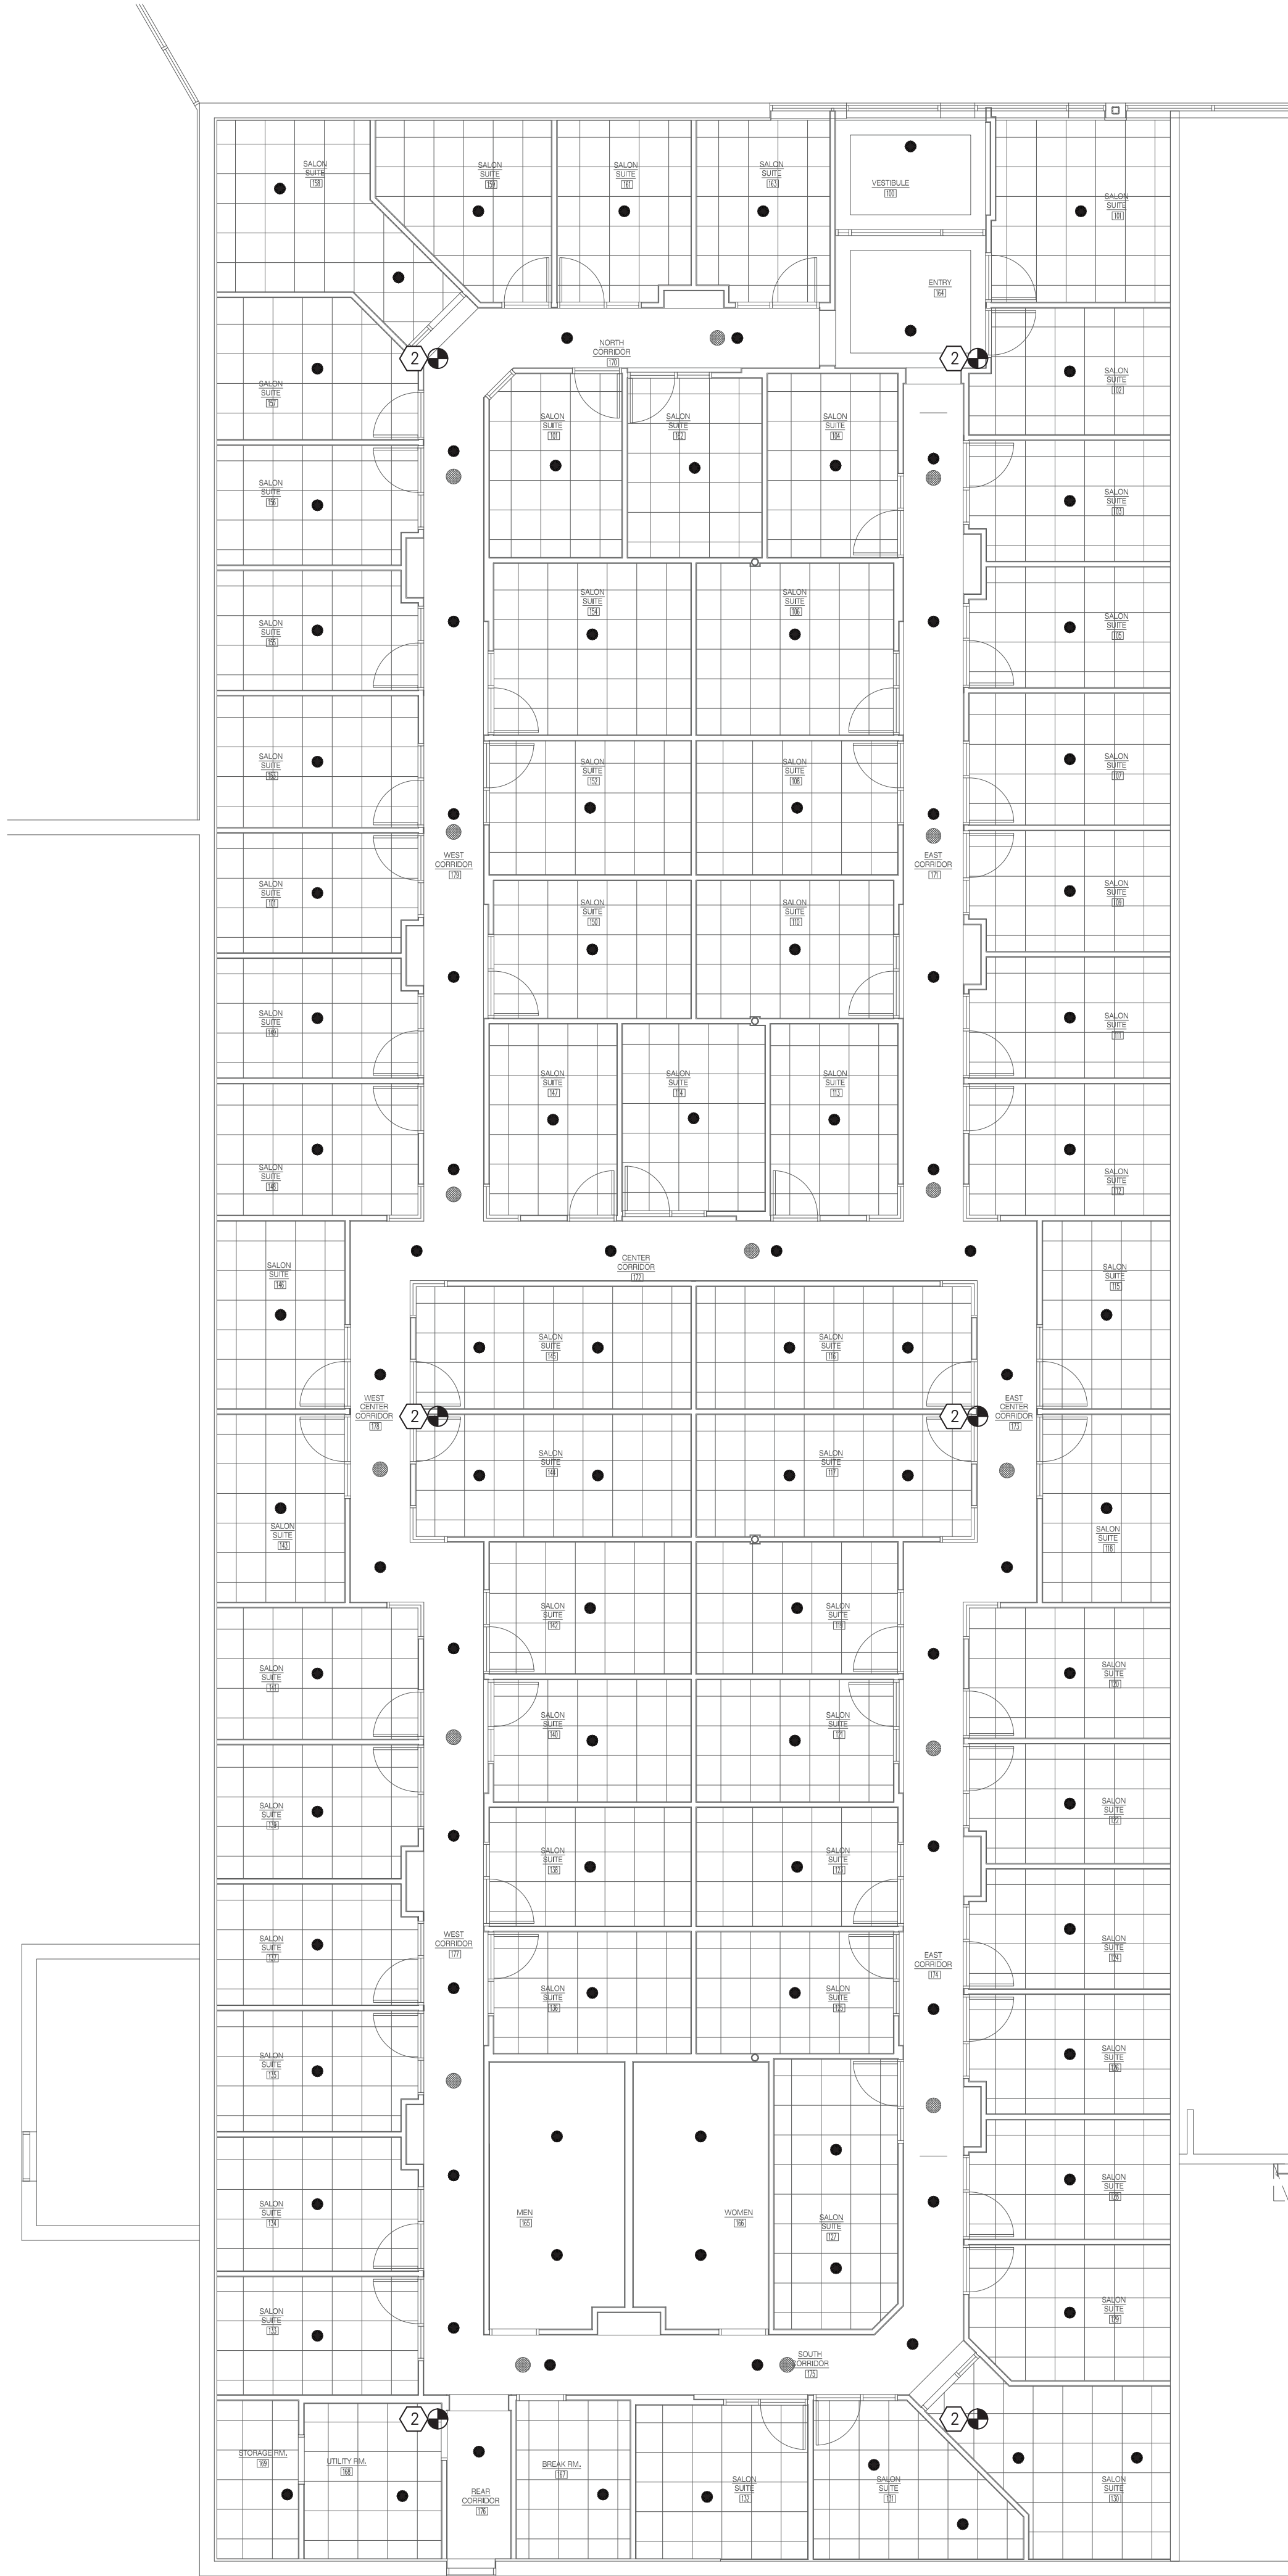

2 FIRE PROTECTION PLAN
SCALE: 1/8" = 1'-0"

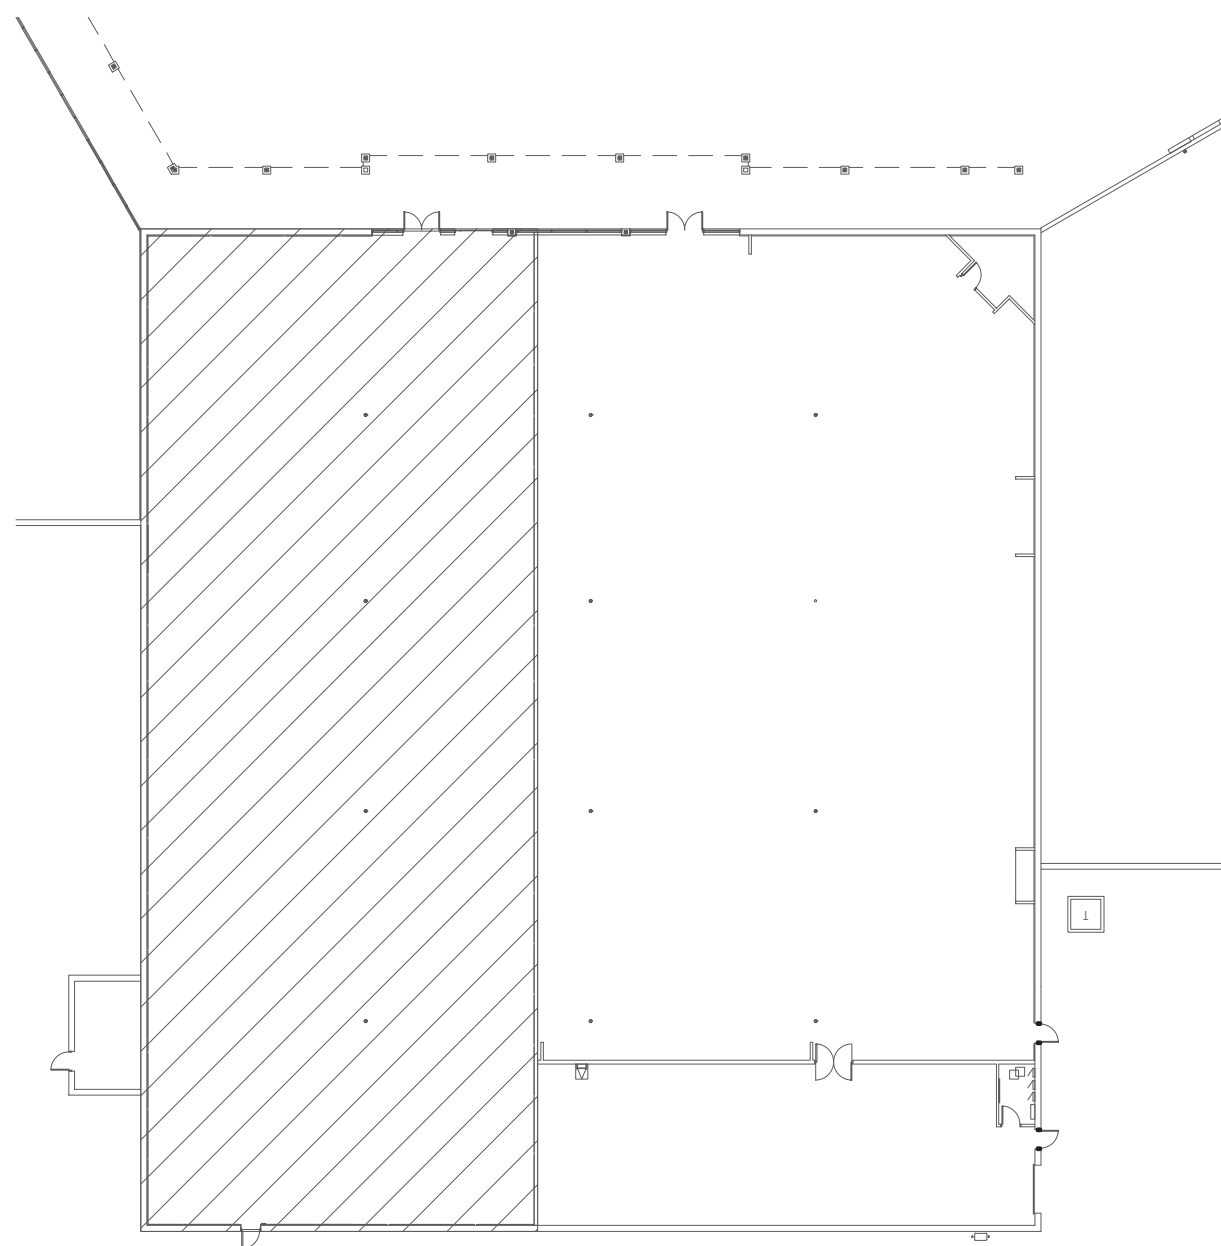

3 KEYPLAN
NOT TO SCALE