


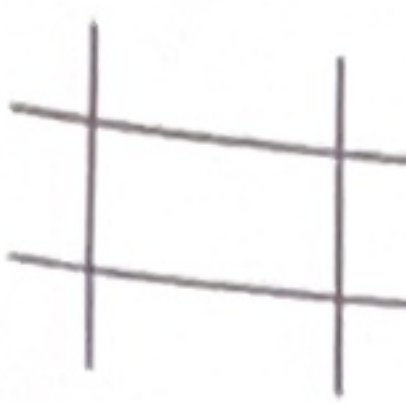





 



LEGEND

-  = NEW 2x4 DROP CEILING SYSTEM
-  = NEW FLOOR. LIGHT FIXTURE
-  = ILLUMINATED EXIT SIGN
-  = EMERGENCY LIGHTING w/ BATT. BACK-UP
-  = NEW ELECTRICAL OUTLET
-  = EXISTING ELECTRICAL OUTLET
-  = NEW FIRE-RATED DIVISING WALL
-  = EXISTING PARTITION
-  = NEW DOOR w/ H.C. ACCESSIBLE H'DW'R.
-  = LIGHT SWITCH

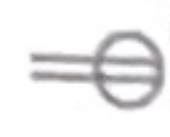

FLOOR
WATER
NO SCALE

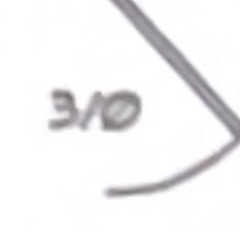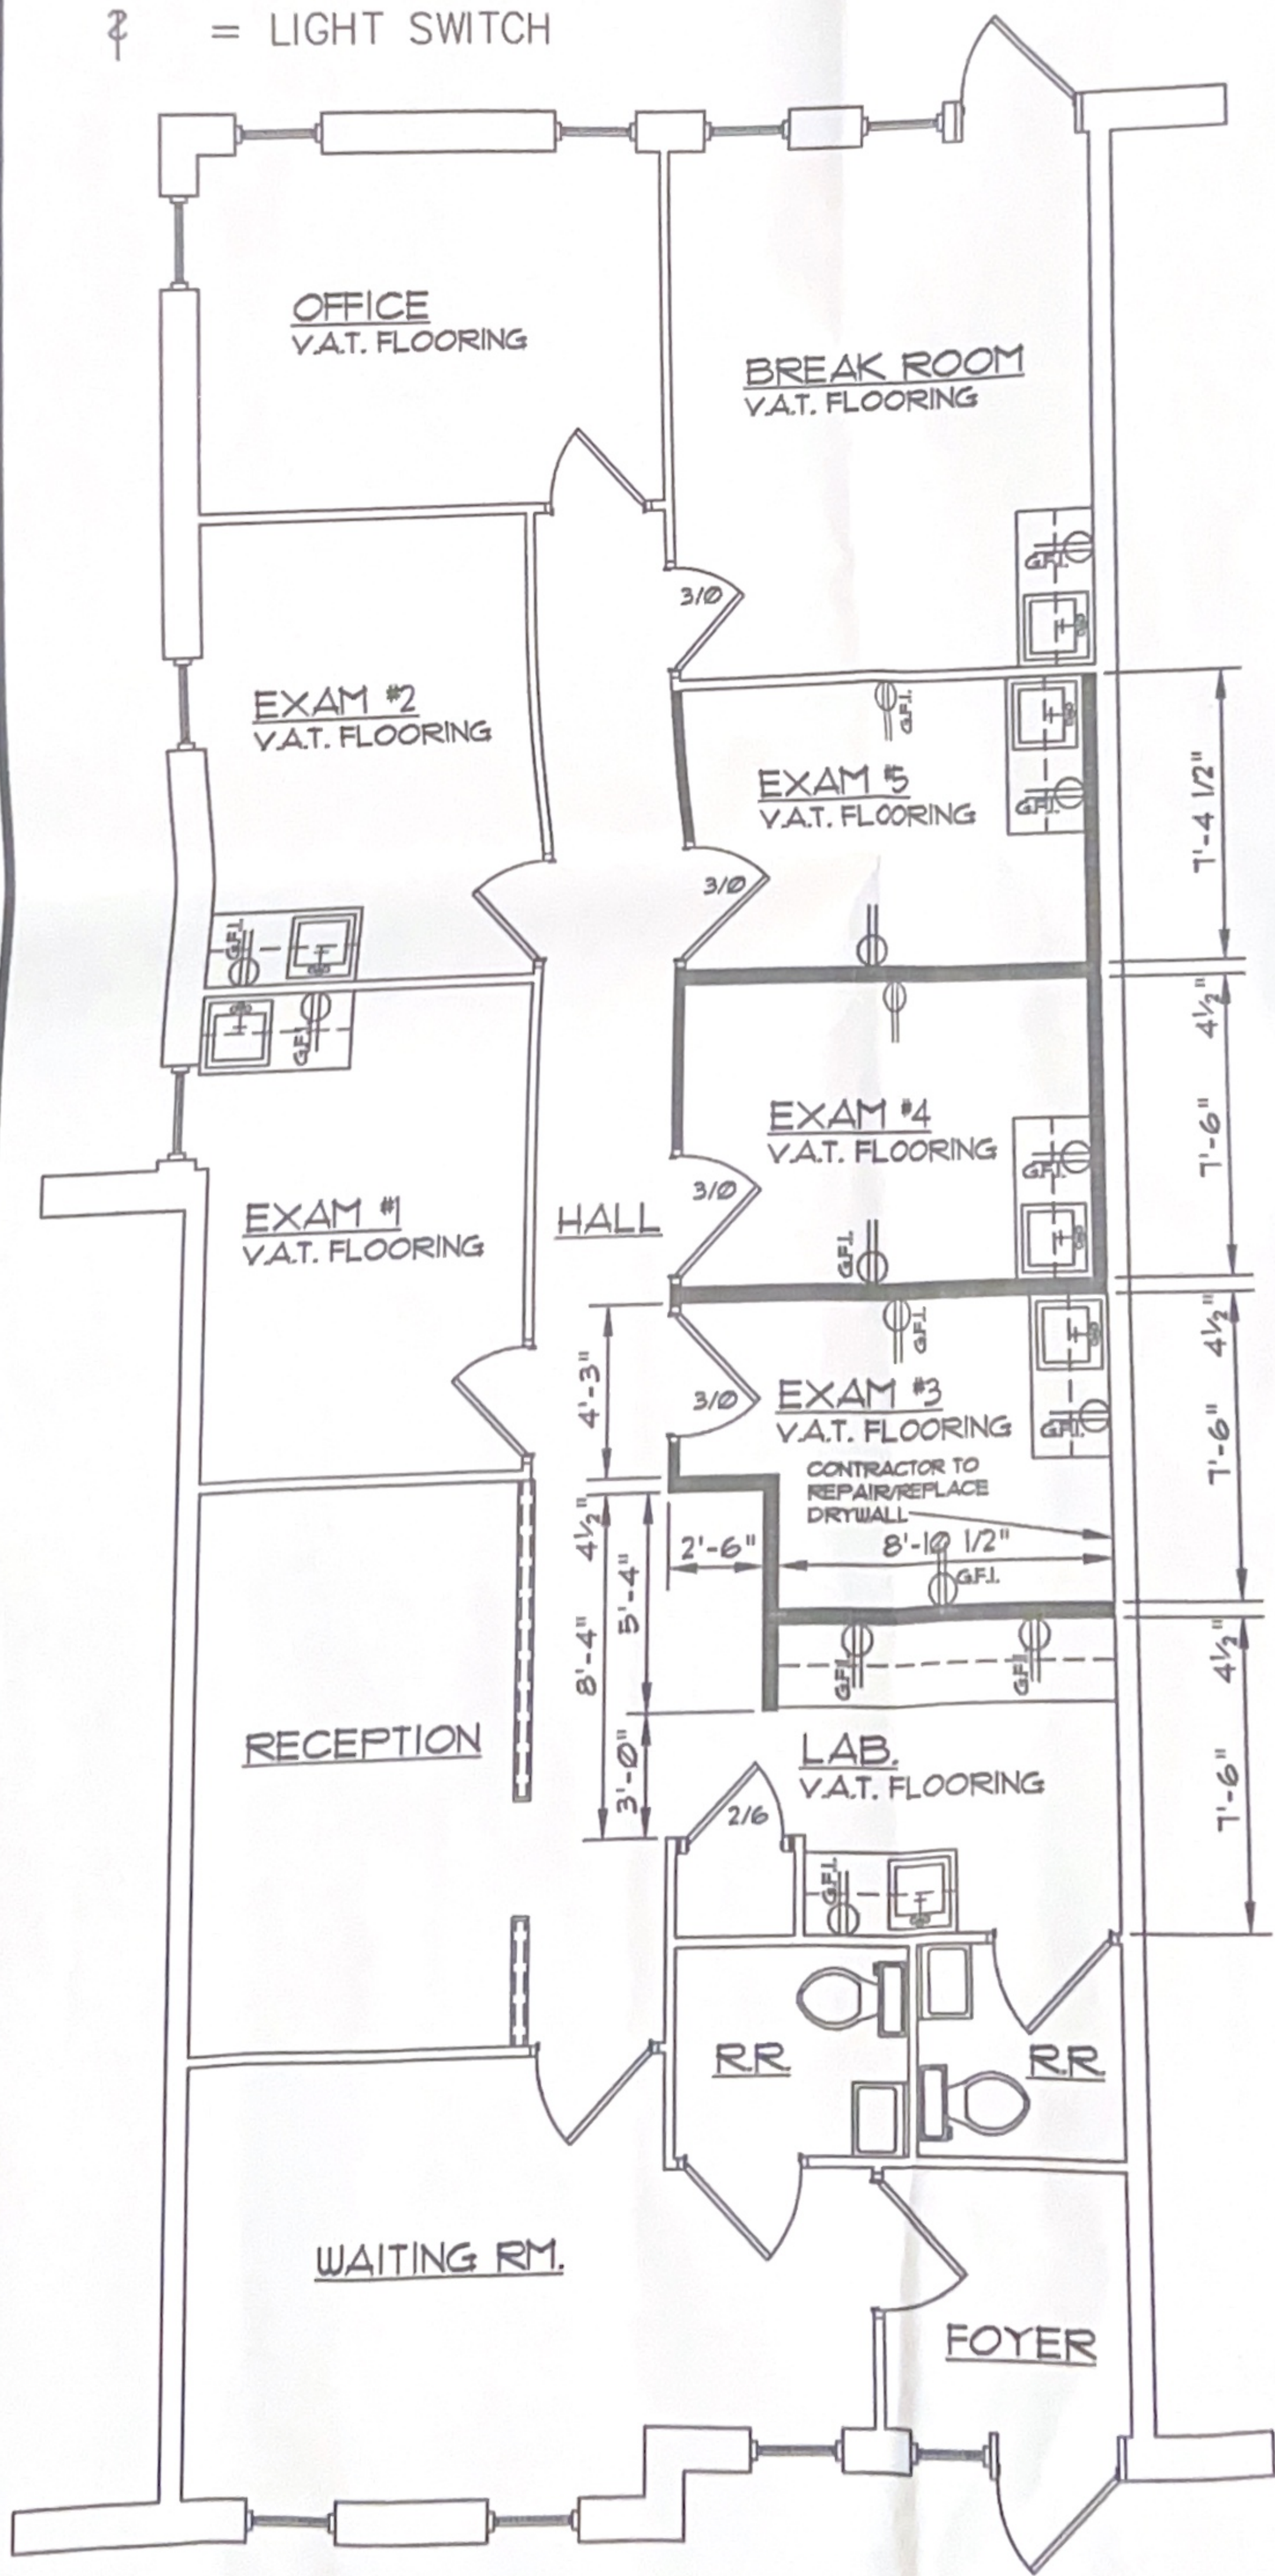

FLOOR PLAN
SCALE = 1/4" = 1'-0"