


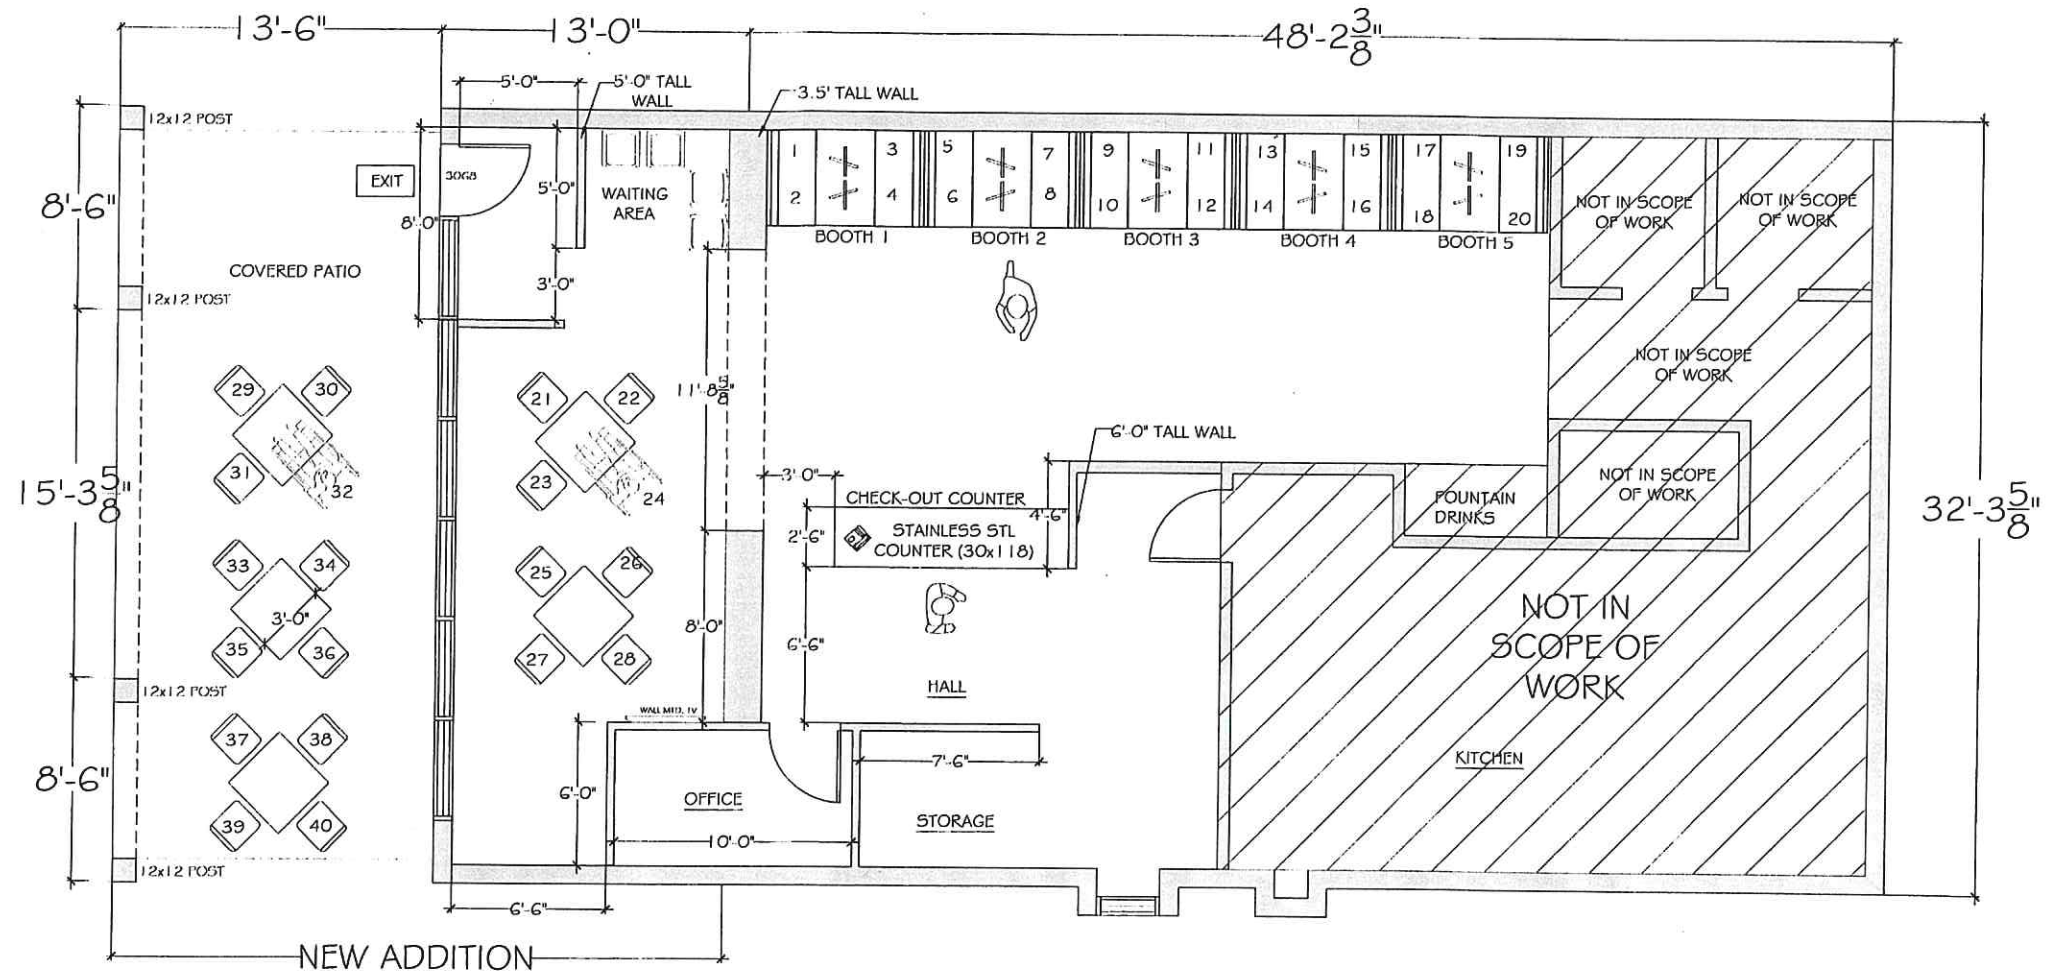

1 PROPOSED FLOOR PLAN
SCALE: $\frac{1}{4}" = 1' 0"$





QUAN SMITH
HCDG
6337 RAVENDALE LANE
DALLAS, TEXAS
504.975.8521
q_smith@harvestcodegroup.com


ISSUES AND REVISIONS

NO.	DESCRIPTION
01	ISSUE DATE: 11.25.16

4717 GUS THOMASSON
ADDITION
FAST FOOD RESTAURANT
MESQUITE, TX 75150

SHEET NUMBER:
112116
ISSUE DATE:
11.25.16
ELECTRICAL
PLAN

A1.5

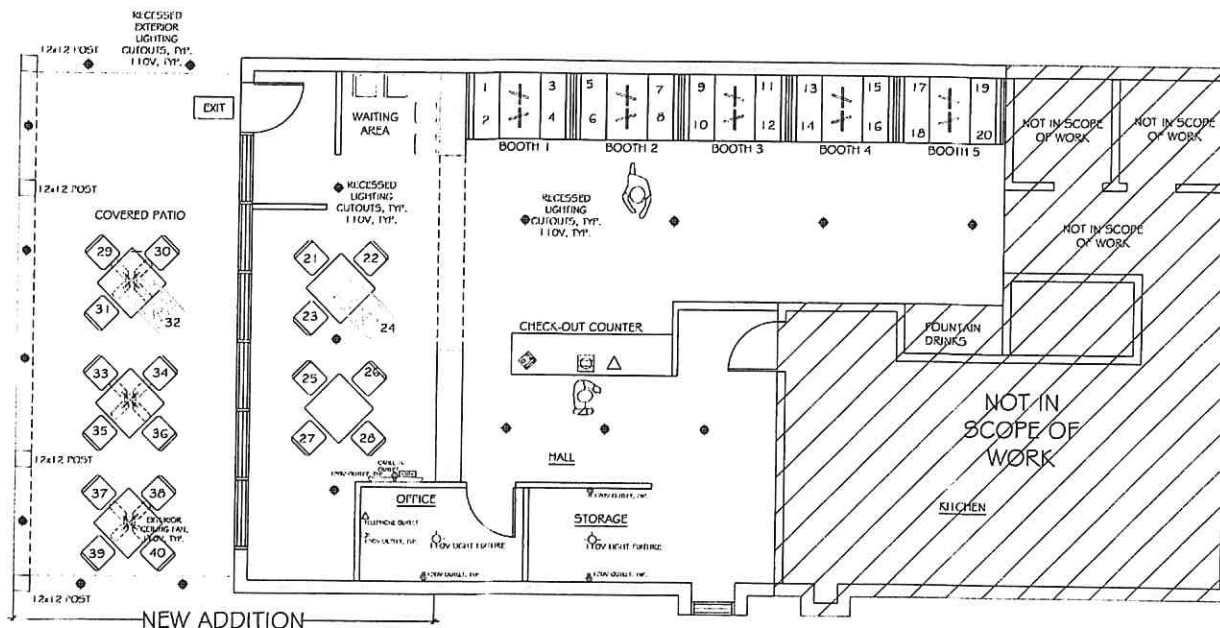

1 ELECTRICAL PLAN
SCALE: 1/4" = 1'-0"

PLAN NORTH

- #### ELECTRICAL NOTES
1. ALL WORK SHALL BE DONE IN ACCORDANCE WITH THE LOCAL ELECTRICAL CODES.
 2. THE CONTRACTOR SHALL BE RESPONSIBLE FOR OBTAINING ALL NECESSARY PERMITS AND INSURANCE COVERAGE. THE CONTRACTOR SHALL BE RESPONSIBLE FOR OBTAINING ALL NECESSARY PERMITS AND INSURANCE COVERAGE.
 3. THE CONTRACTOR SHALL BE RESPONSIBLE FOR OBTAINING ALL NECESSARY PERMITS AND INSURANCE COVERAGE.
 4. THE CONTRACTOR SHALL BE RESPONSIBLE FOR OBTAINING ALL NECESSARY PERMITS AND INSURANCE COVERAGE.
 5. THE CONTRACTOR SHALL BE RESPONSIBLE FOR OBTAINING ALL NECESSARY PERMITS AND INSURANCE COVERAGE.
 6. THE CONTRACTOR SHALL BE RESPONSIBLE FOR OBTAINING ALL NECESSARY PERMITS AND INSURANCE COVERAGE.
 7. THE CONTRACTOR SHALL BE RESPONSIBLE FOR OBTAINING ALL NECESSARY PERMITS AND INSURANCE COVERAGE.
 8. THE CONTRACTOR SHALL BE RESPONSIBLE FOR OBTAINING ALL NECESSARY PERMITS AND INSURANCE COVERAGE.
 9. THE CONTRACTOR SHALL BE RESPONSIBLE FOR OBTAINING ALL NECESSARY PERMITS AND INSURANCE COVERAGE.
 10. THE CONTRACTOR SHALL BE RESPONSIBLE FOR OBTAINING ALL NECESSARY PERMITS AND INSURANCE COVERAGE.

LEGEND	SYMBOLS
1. LIGHTING AND POWER SYMBOLS	2. ELECTRICAL SYMBOLS
3. ELECTRICAL SYMBOLS	4. ELECTRICAL SYMBOLS
5. ELECTRICAL SYMBOLS	6. ELECTRICAL SYMBOLS
7. ELECTRICAL SYMBOLS	8. ELECTRICAL SYMBOLS
9. ELECTRICAL SYMBOLS	10. ELECTRICAL SYMBOLS
11. ELECTRICAL SYMBOLS	12. ELECTRICAL SYMBOLS
13. ELECTRICAL SYMBOLS	14. ELECTRICAL SYMBOLS
15. ELECTRICAL SYMBOLS	16. ELECTRICAL SYMBOLS
17. ELECTRICAL SYMBOLS	18. ELECTRICAL SYMBOLS
19. ELECTRICAL SYMBOLS	20. ELECTRICAL SYMBOLS
21. ELECTRICAL SYMBOLS	22. ELECTRICAL SYMBOLS
23. ELECTRICAL SYMBOLS	24. ELECTRICAL SYMBOLS
25. ELECTRICAL SYMBOLS	26. ELECTRICAL SYMBOLS
27. ELECTRICAL SYMBOLS	28. ELECTRICAL SYMBOLS
29. ELECTRICAL SYMBOLS	30. ELECTRICAL SYMBOLS
31. ELECTRICAL SYMBOLS	32. ELECTRICAL SYMBOLS
33. ELECTRICAL SYMBOLS	34. ELECTRICAL SYMBOLS
35. ELECTRICAL SYMBOLS	36. ELECTRICAL SYMBOLS
37. ELECTRICAL SYMBOLS	38. ELECTRICAL SYMBOLS
39. ELECTRICAL SYMBOLS	40. ELECTRICAL SYMBOLS