
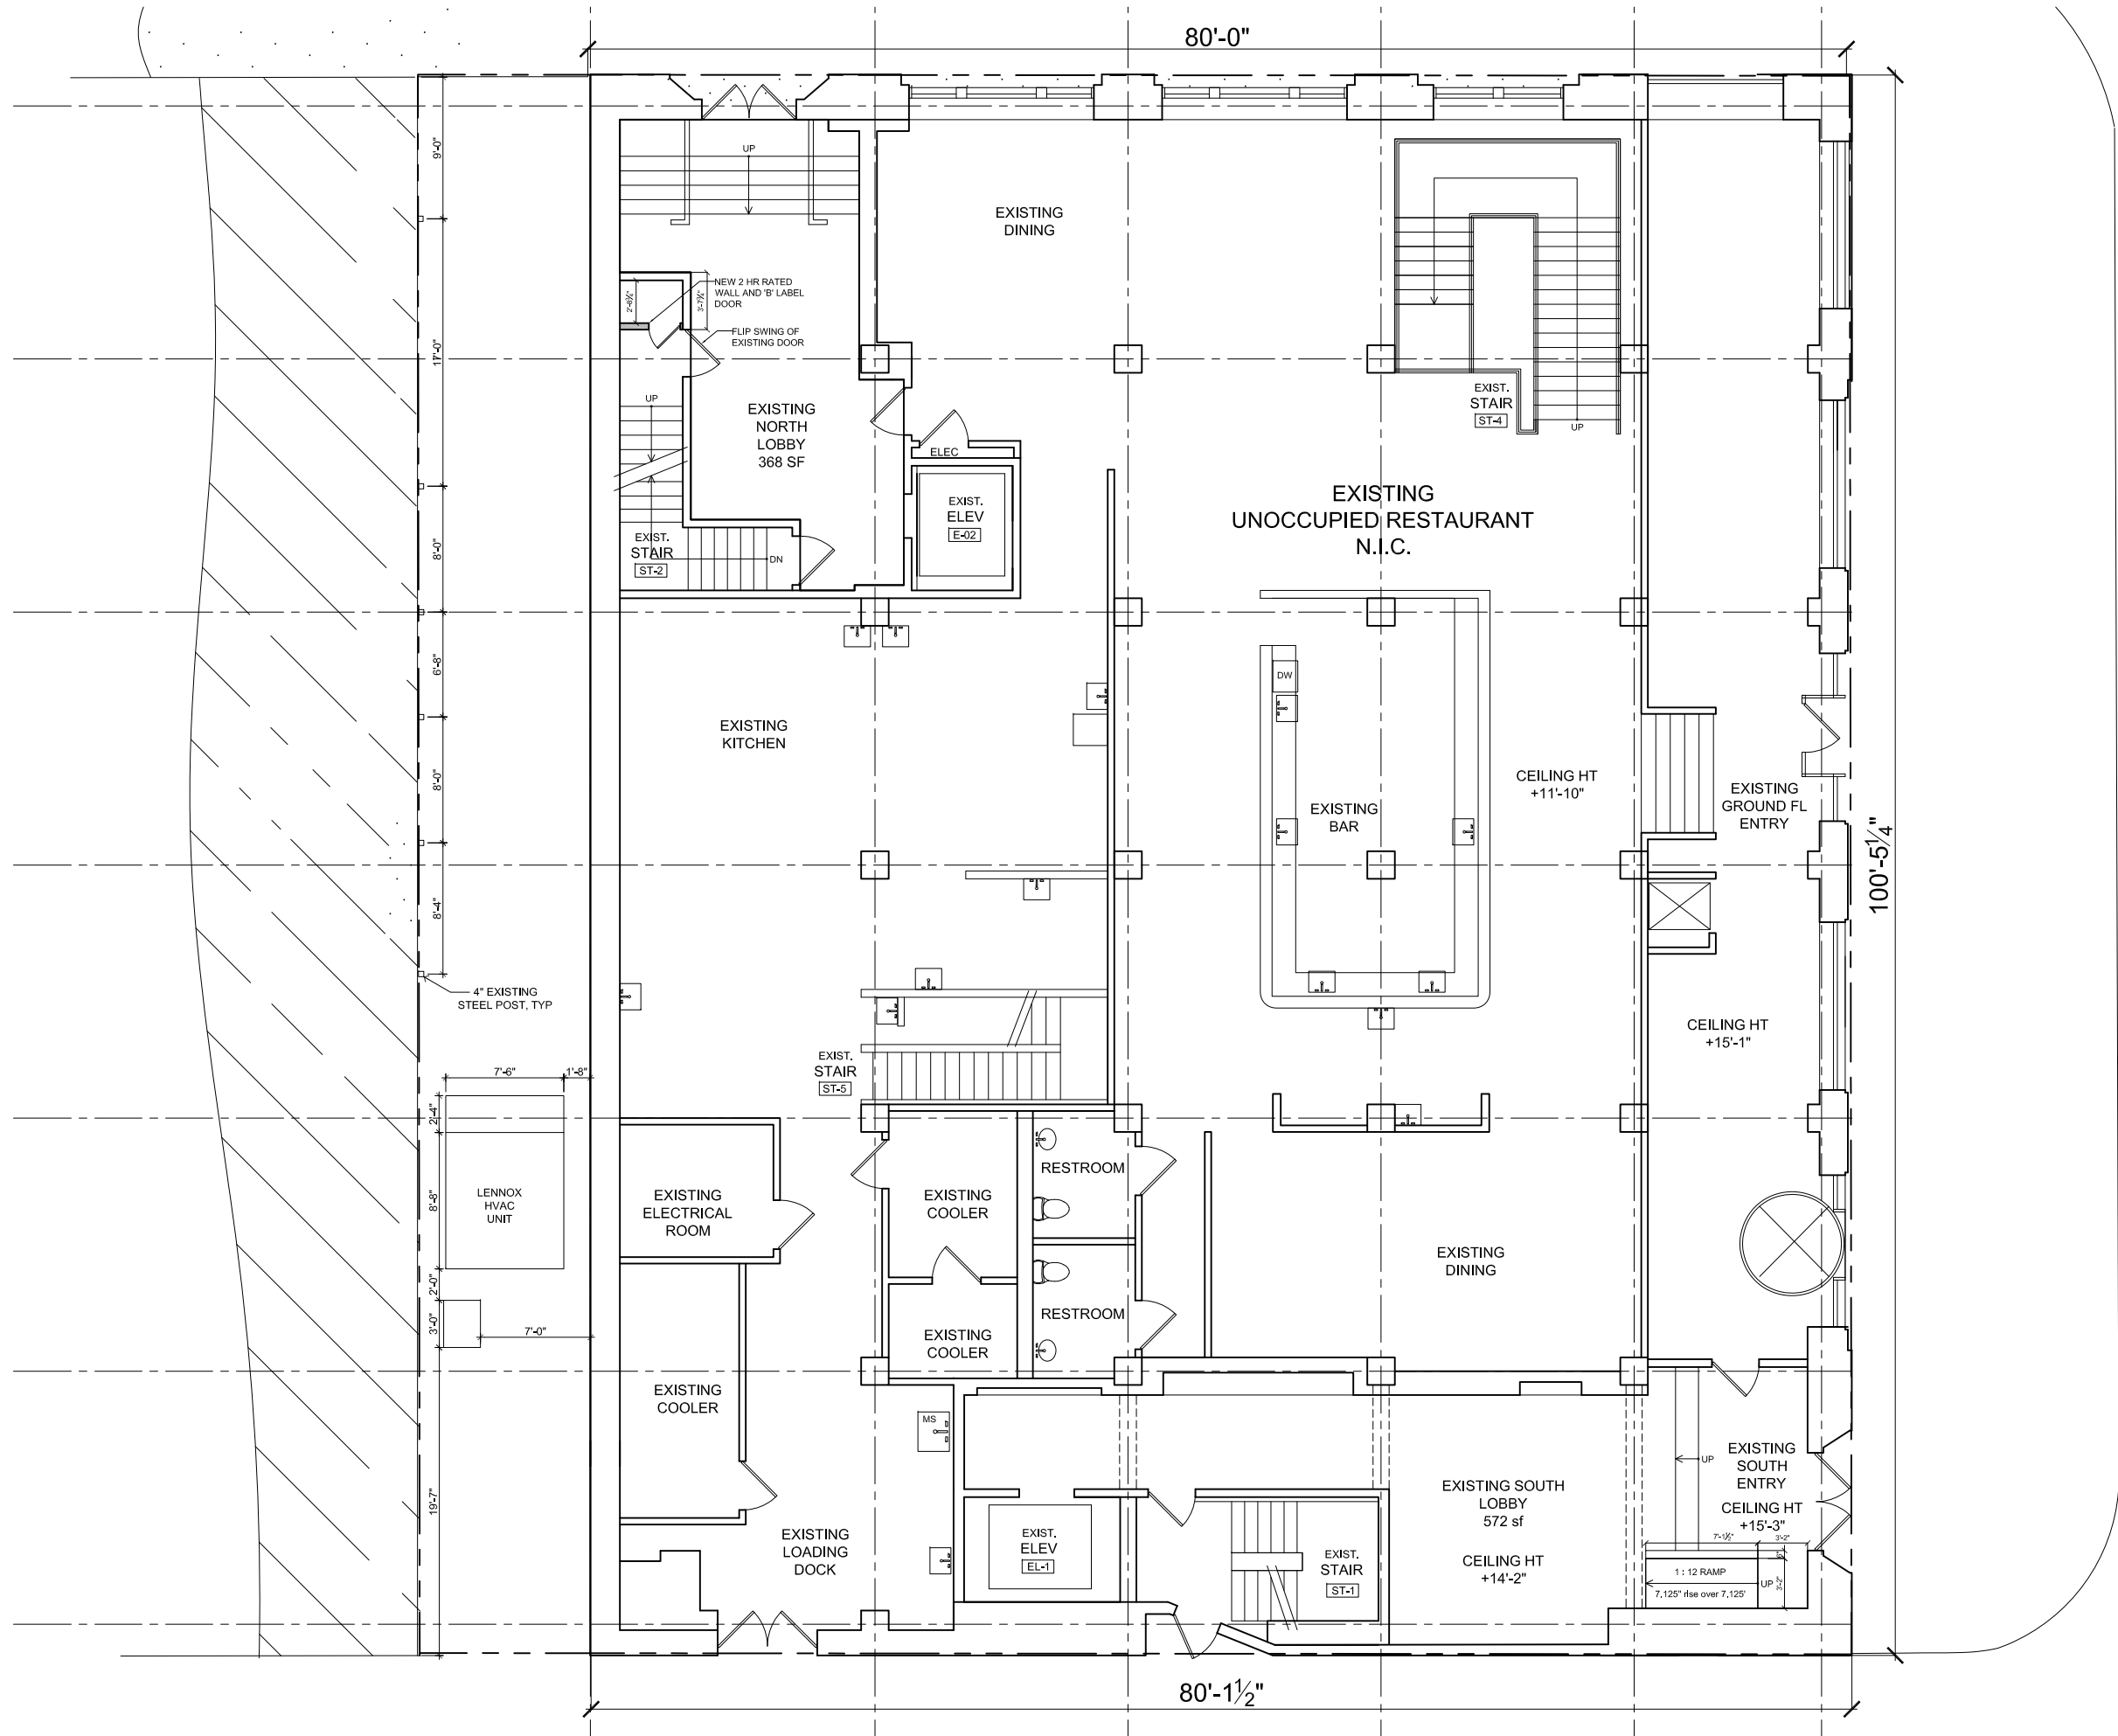


0 1 5 10   
 SCALE: 3/32" = 1'-0" PRINTED AT 11X17  
 (c) LAURA GARCIA DESIGN LLC

N. LASALLE ST.

NOTE: GRAY SCALE PLUMBING FIXTURES INDICATE EXISTING PIPING LOCATIONS ONLY

**BASEMENT EXISTING**  
 540 N LASALLE ST  
 09 APRIL 2020




0 1 5 10

SCALE: 3/32" = 1'-0" PRINTED AT 11X17  
 SCALE: 3/16" = 1'-0" PRINTED AT 24X36  
 (c) LAURA GARCIA DESIGN LLC

N. LASALLE ST.

CONCRETE SLAB THICKNESS  
 BETWEEN FLOORS 1 AND 2: 10"


GROUND FL EXISTING  
 540 N LASALLE ST  
 09 APRIL 2020

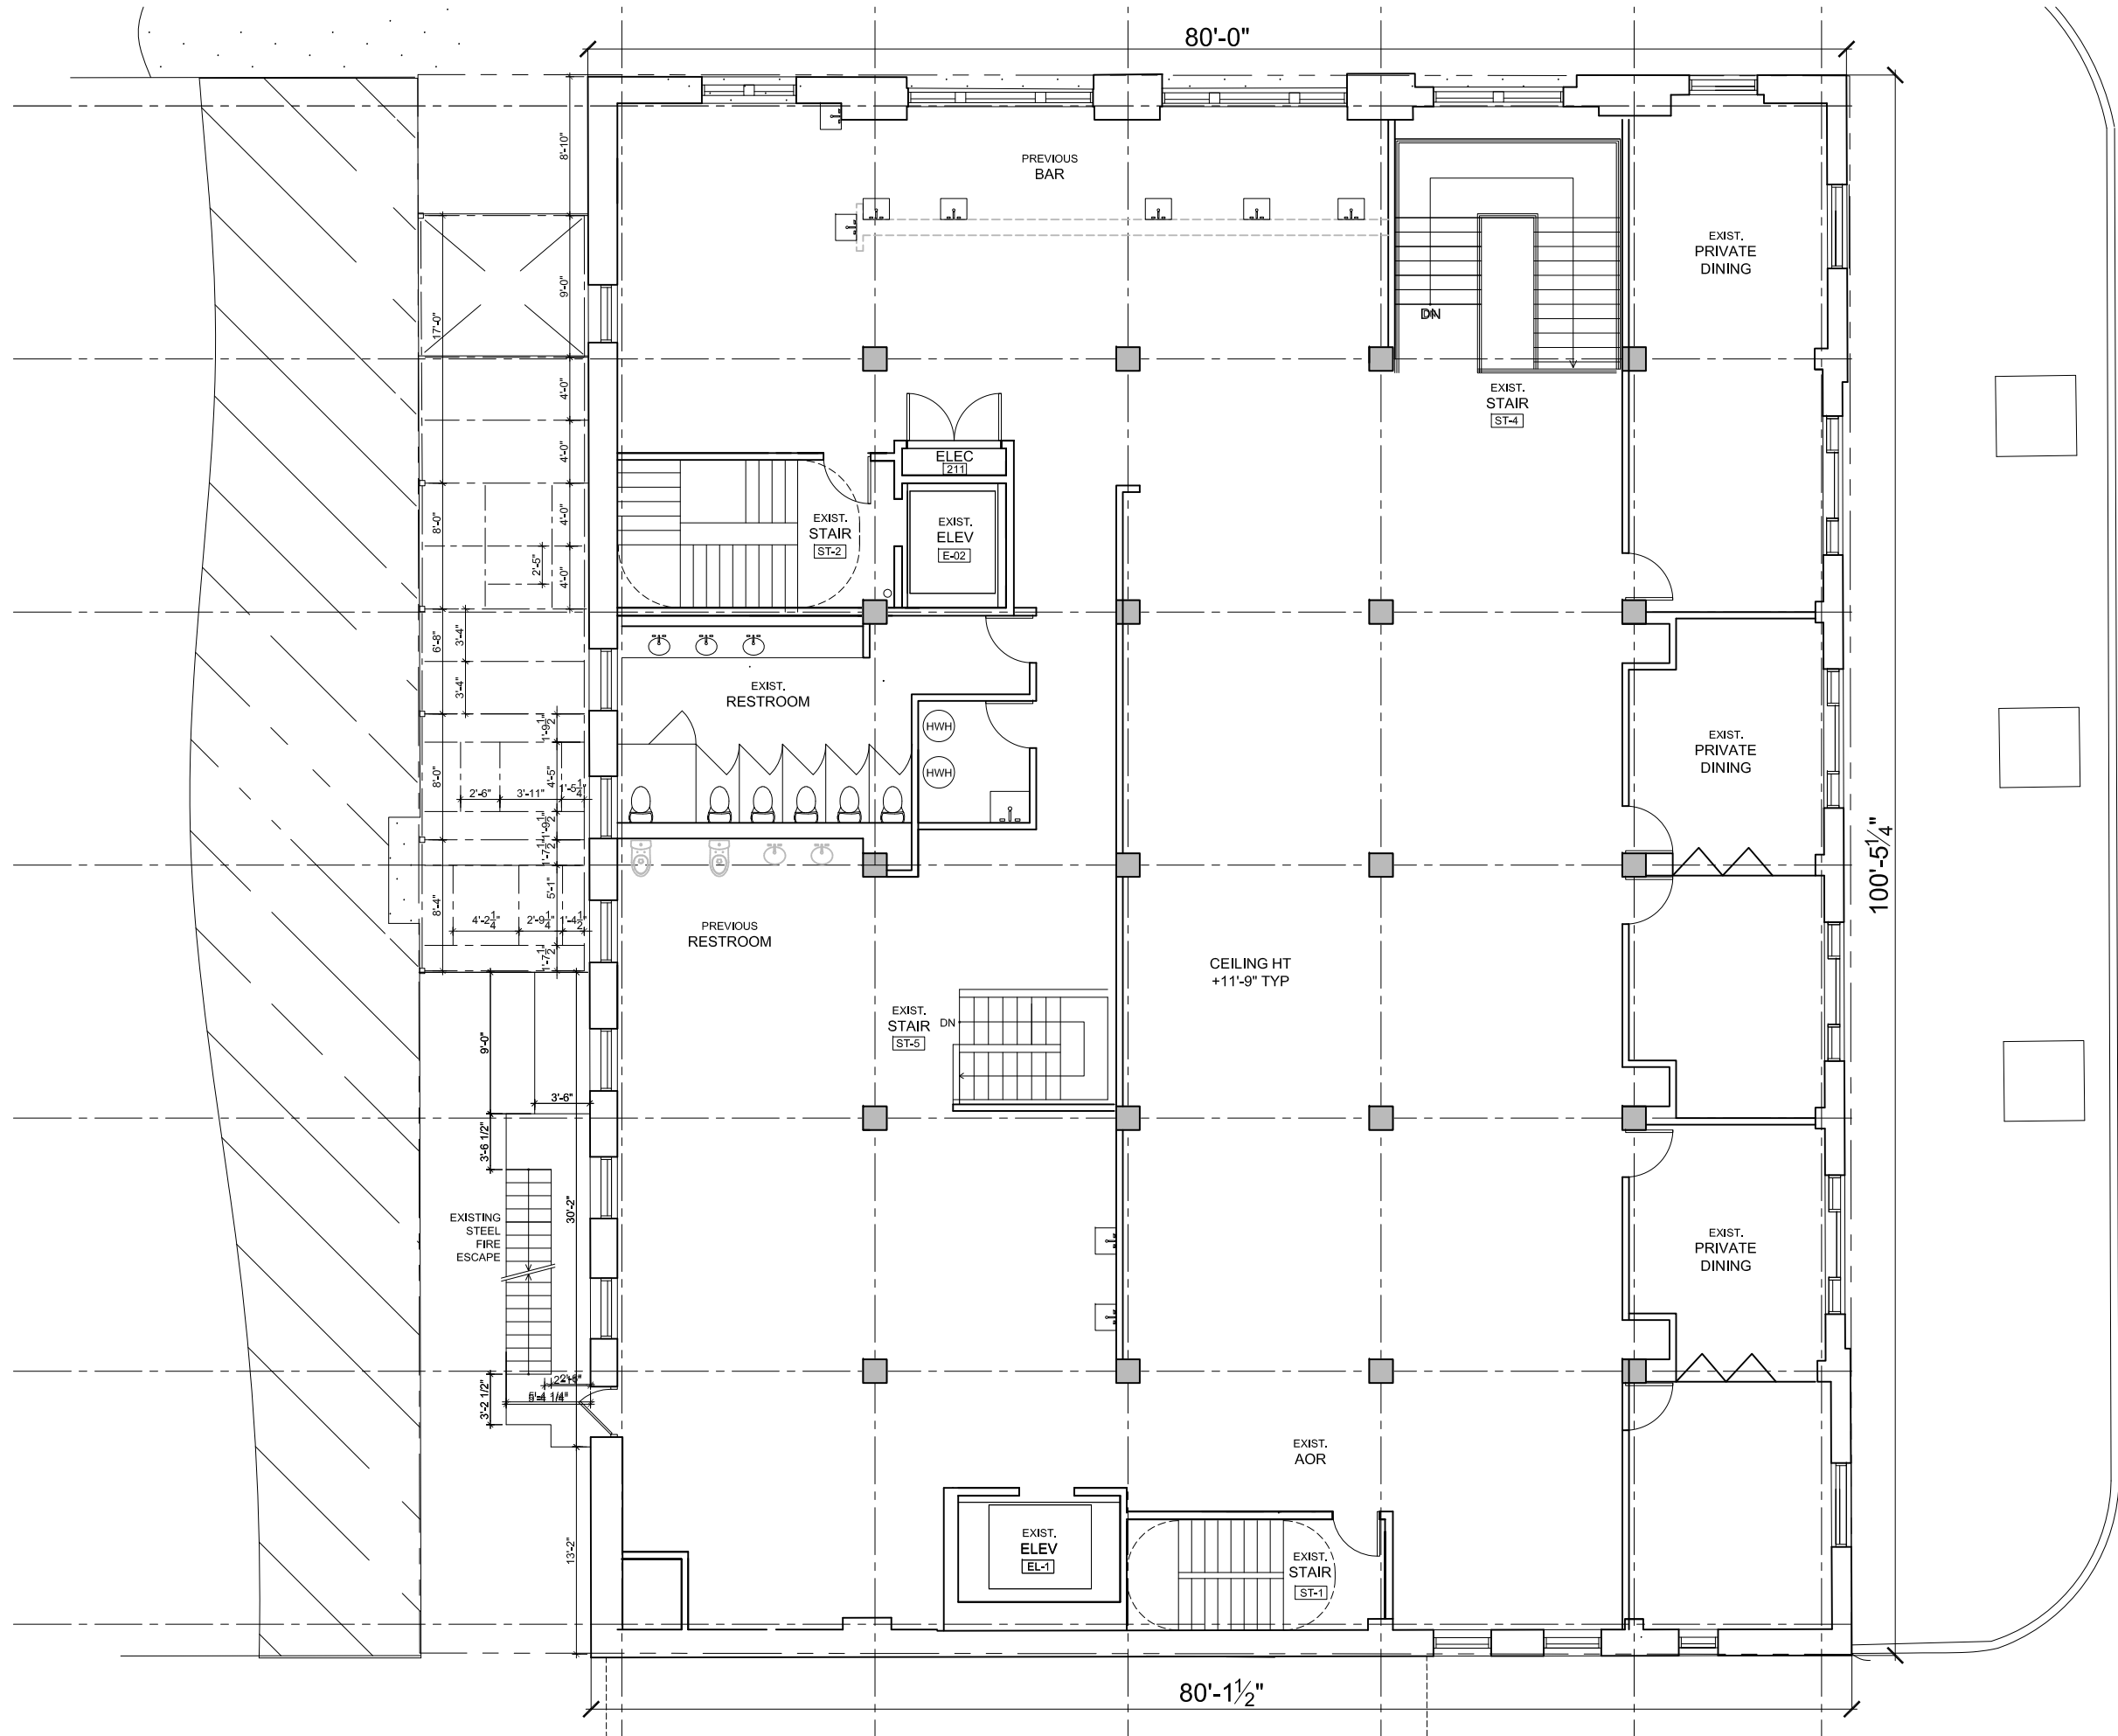



0 1 5 10  
 SCALE: 3/32" = 1'-0" PRINTED AT 11X17  
 (c) LAURA GARCIA DESIGN LLC

N. LASALLE ST.

 
**FLOOR 2 EXISTING**  
 540 N LASALLE ST  
 09 APRIL 2020

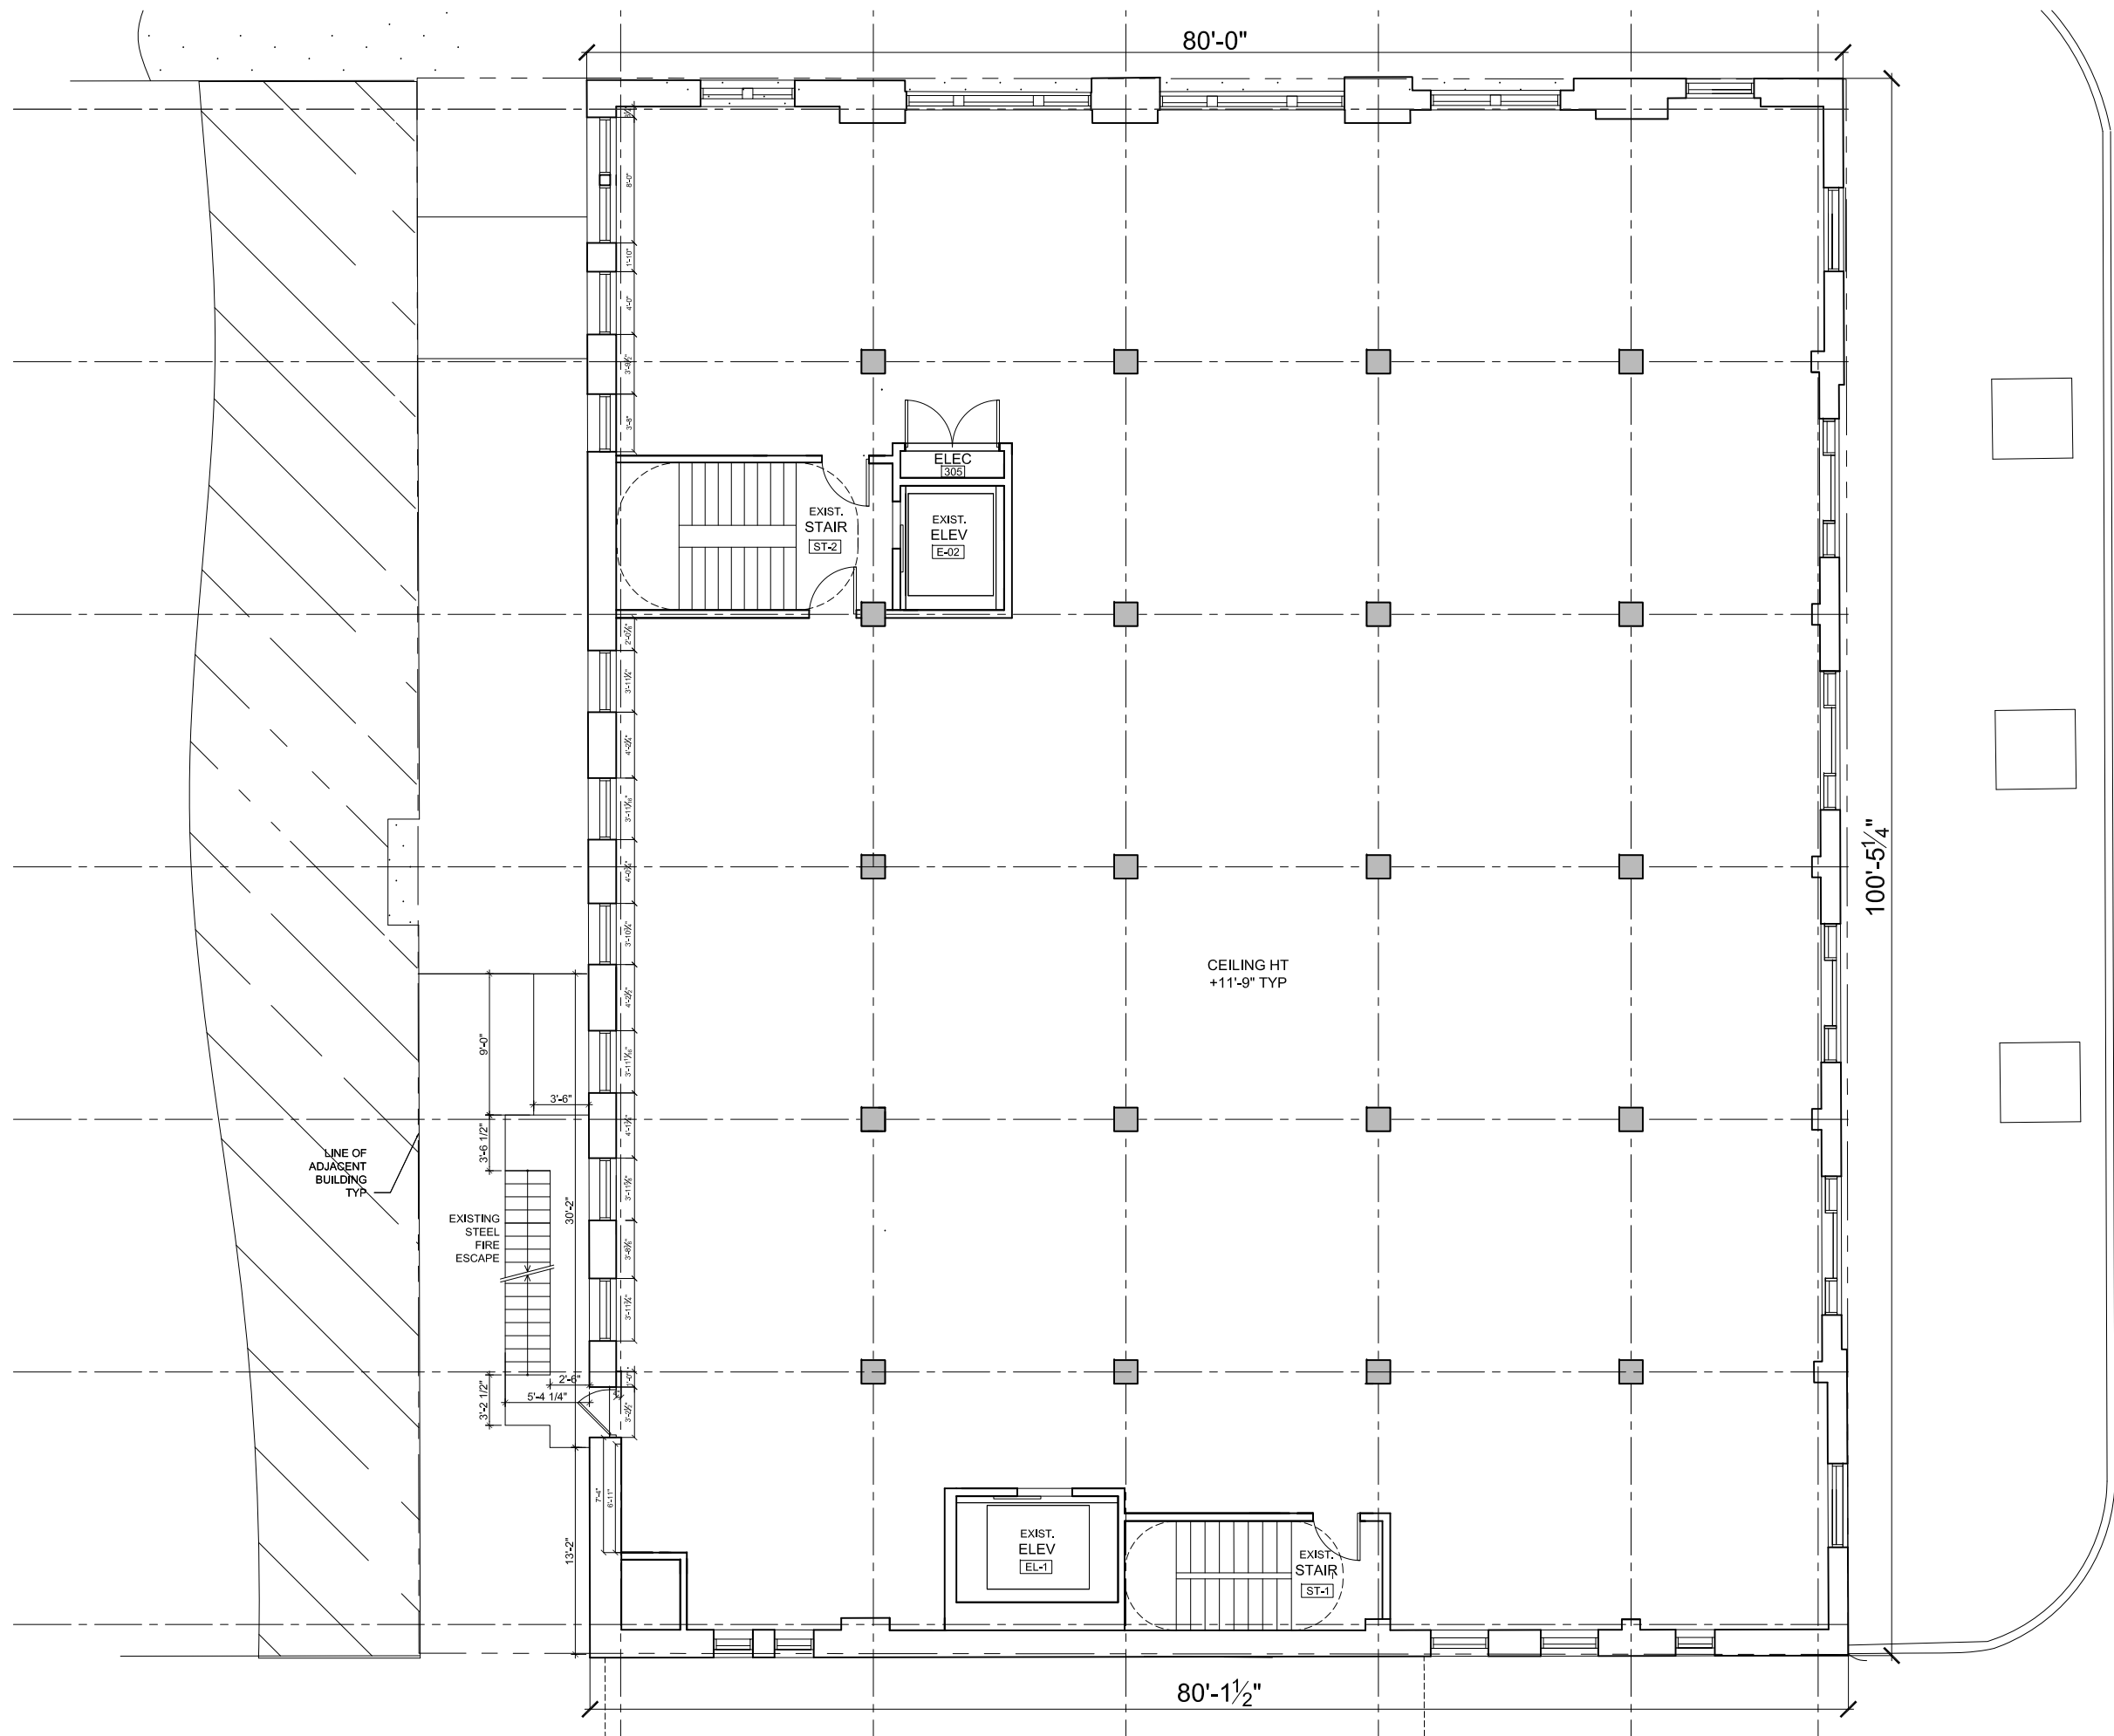


  
 SCALE: 3/32" = 1'-0" PRINTED AT 11X17  
 SCALE: 3/16" = 1'-0" PRINTED AT 24X36  
 (c) LAURA GARCIA DESIGN LLC

N. LASALLE ST.

**FLOOR 3 EXISTING**  
 540 N LASALLE ST  
 09 APRIL 2020

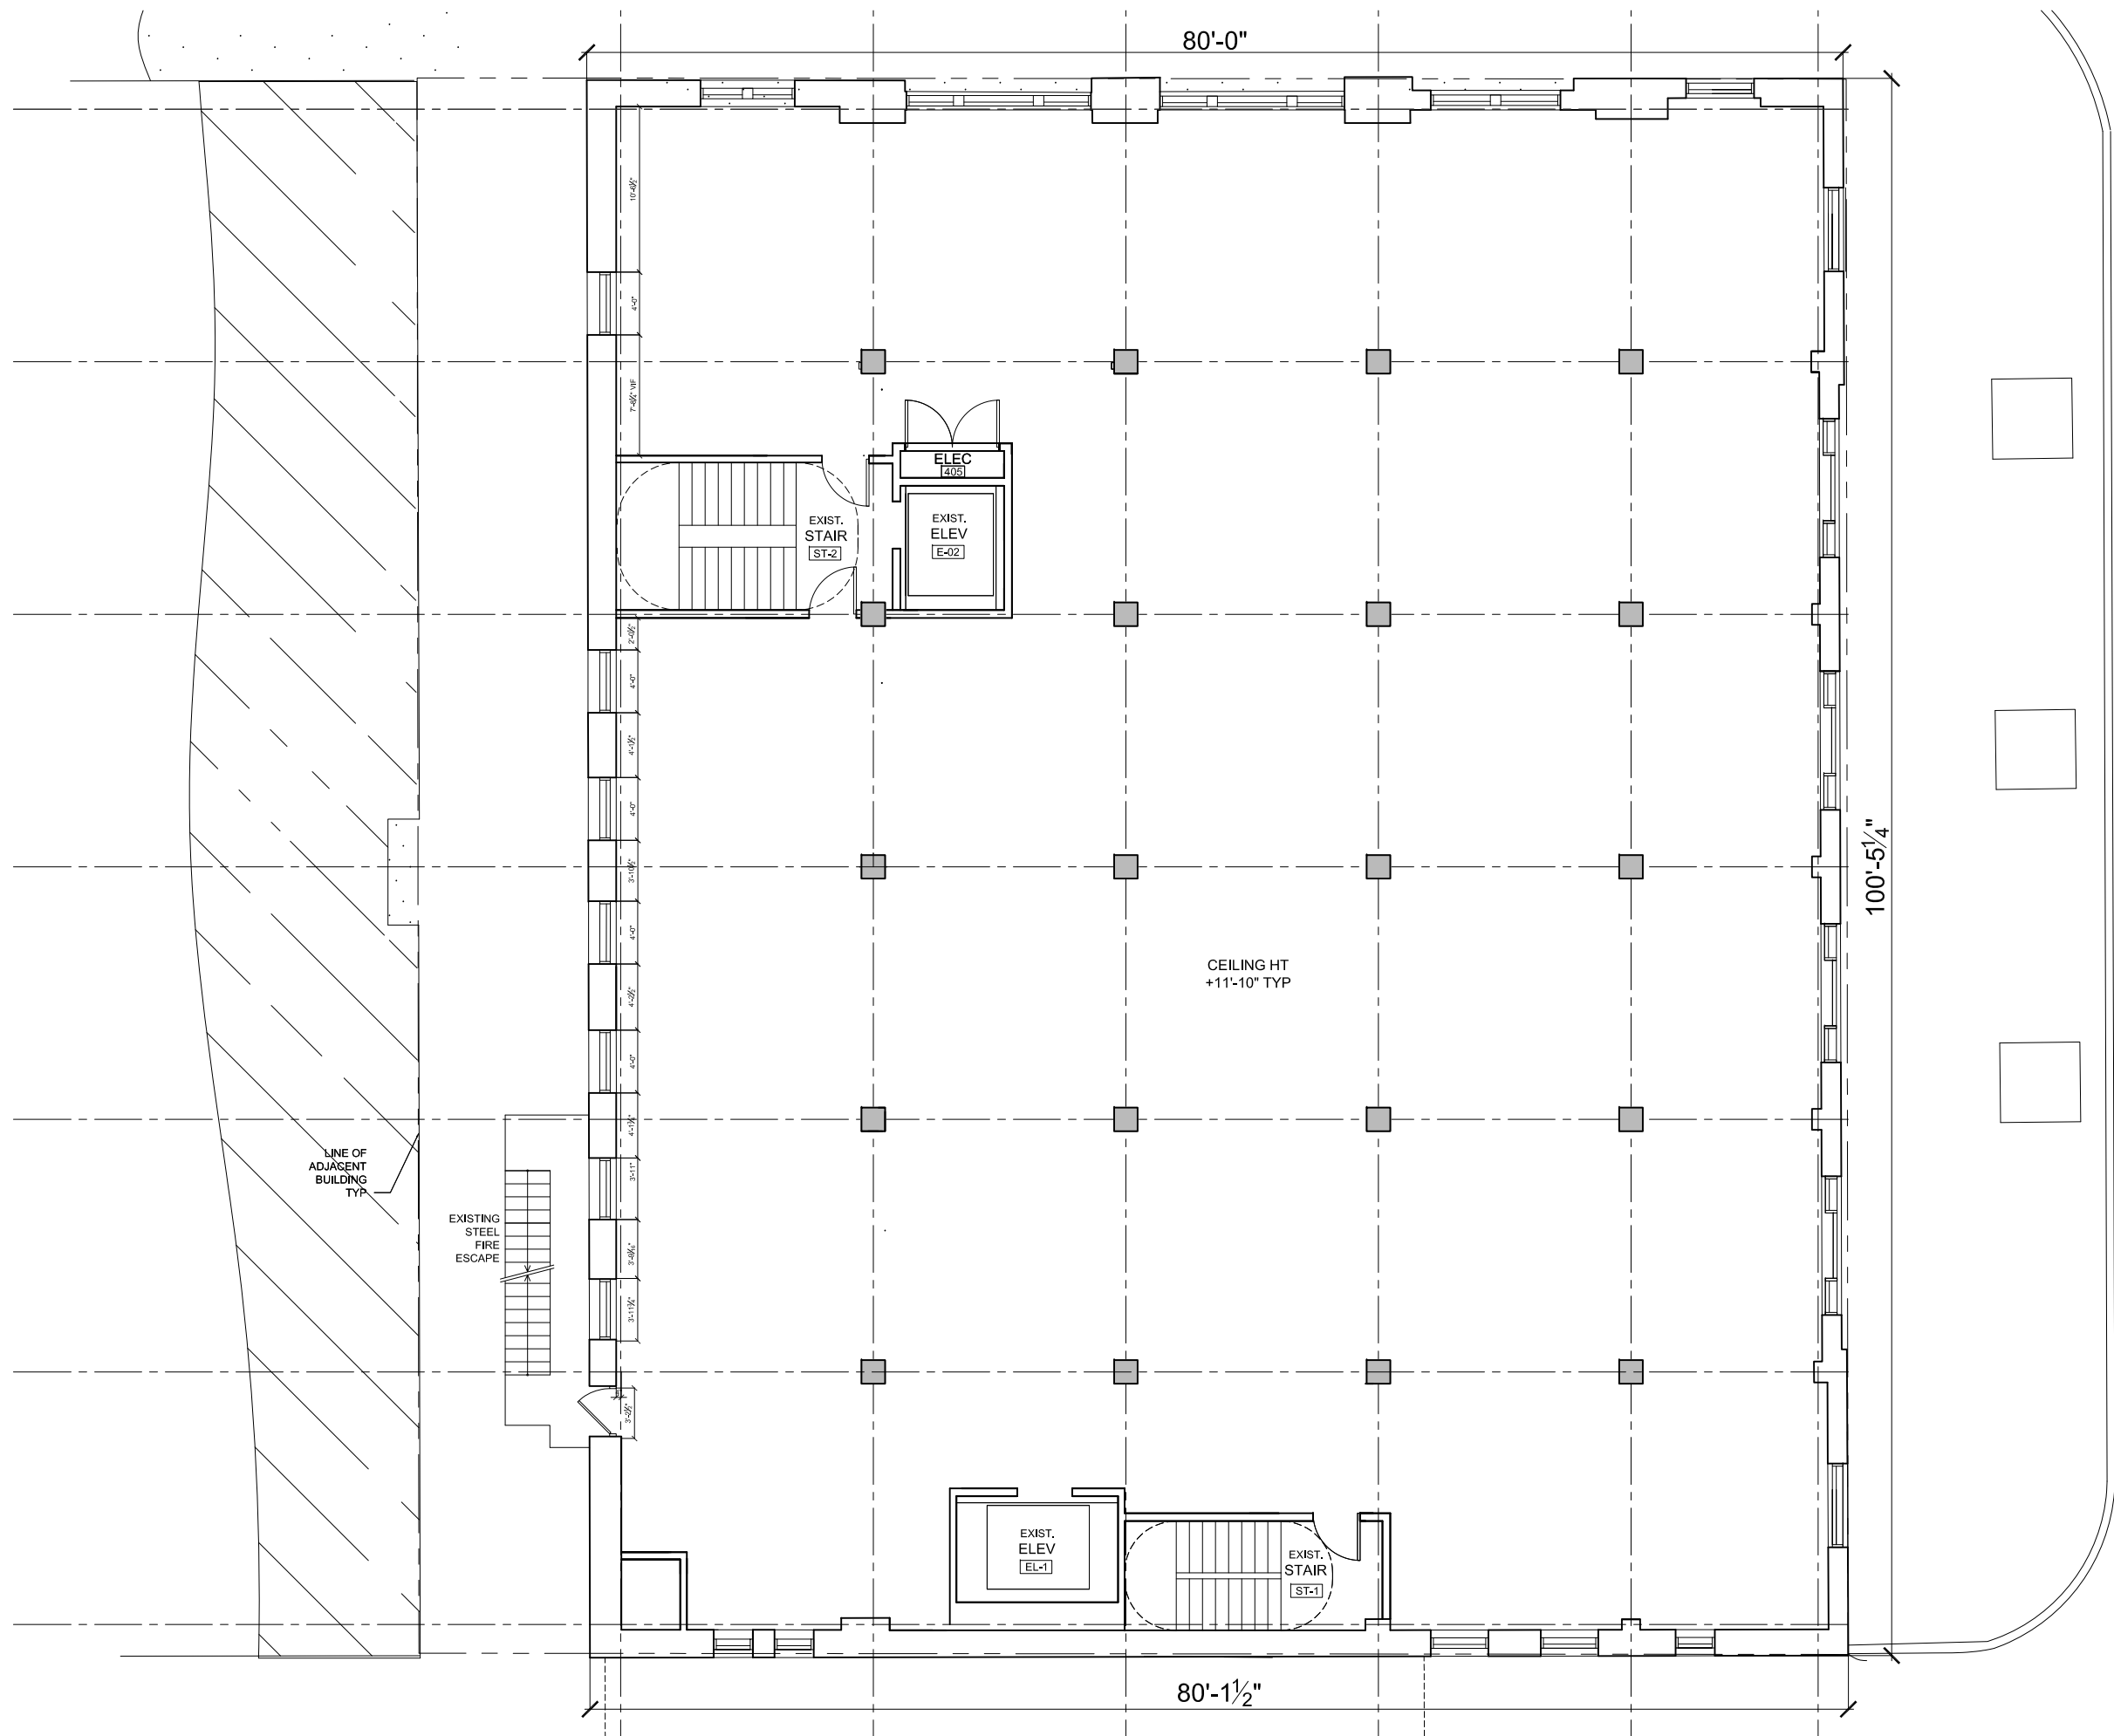


SCALE: 3/32" = 1'-0" PRINTED AT 11X17
   
 (c) LAURA GARCIA DESIGN LLC

NET AREA TO BE REMODELED:
   
 6976 SF

N. LASALLE ST.

**FLOOR 4 EXISTING**
  
 540 N LASALLE ST
   
 09 APRIL 2020

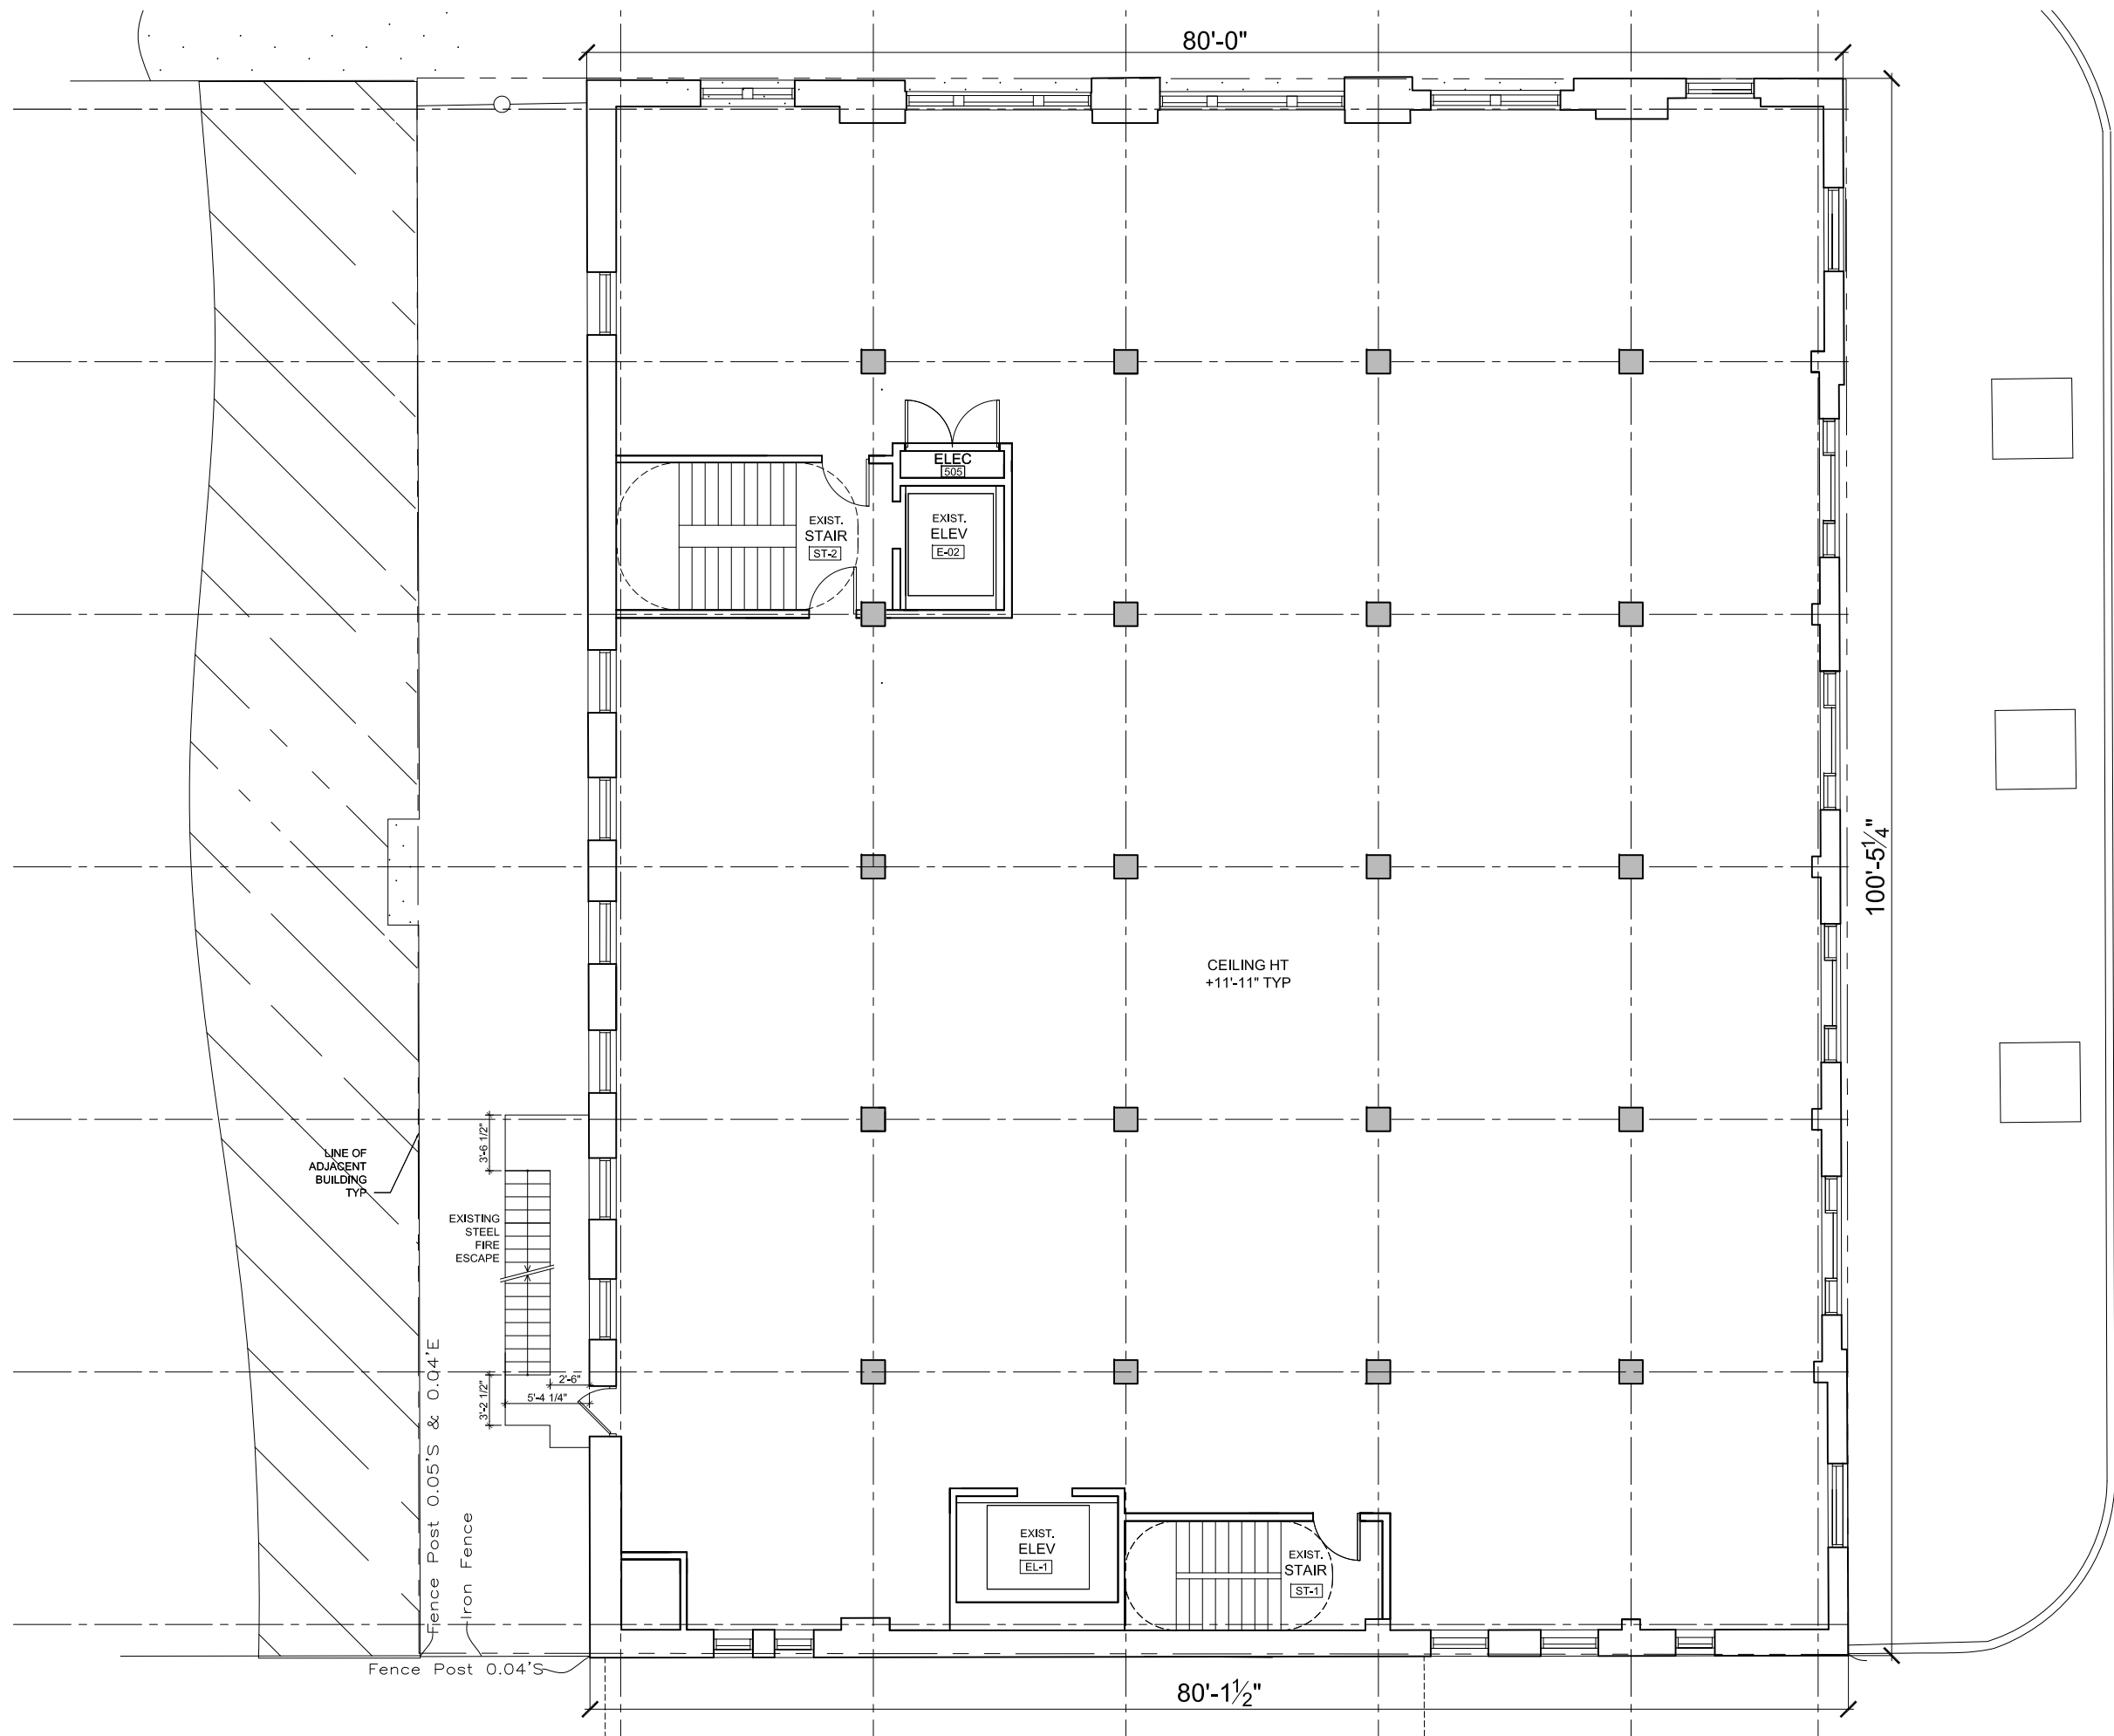


SCALE: 3/32" = 1'-0" PRINTED AT 11X17
   
 (c) LAURA GARCIA DESIGN LLC

NET AREA TO BE REMODELED:
   
 6976 SF

N. LASALLE ST.

**FLOOR 5 EXISTING**
  
 540 N LASALLE ST
   
 09 APRIL 2020

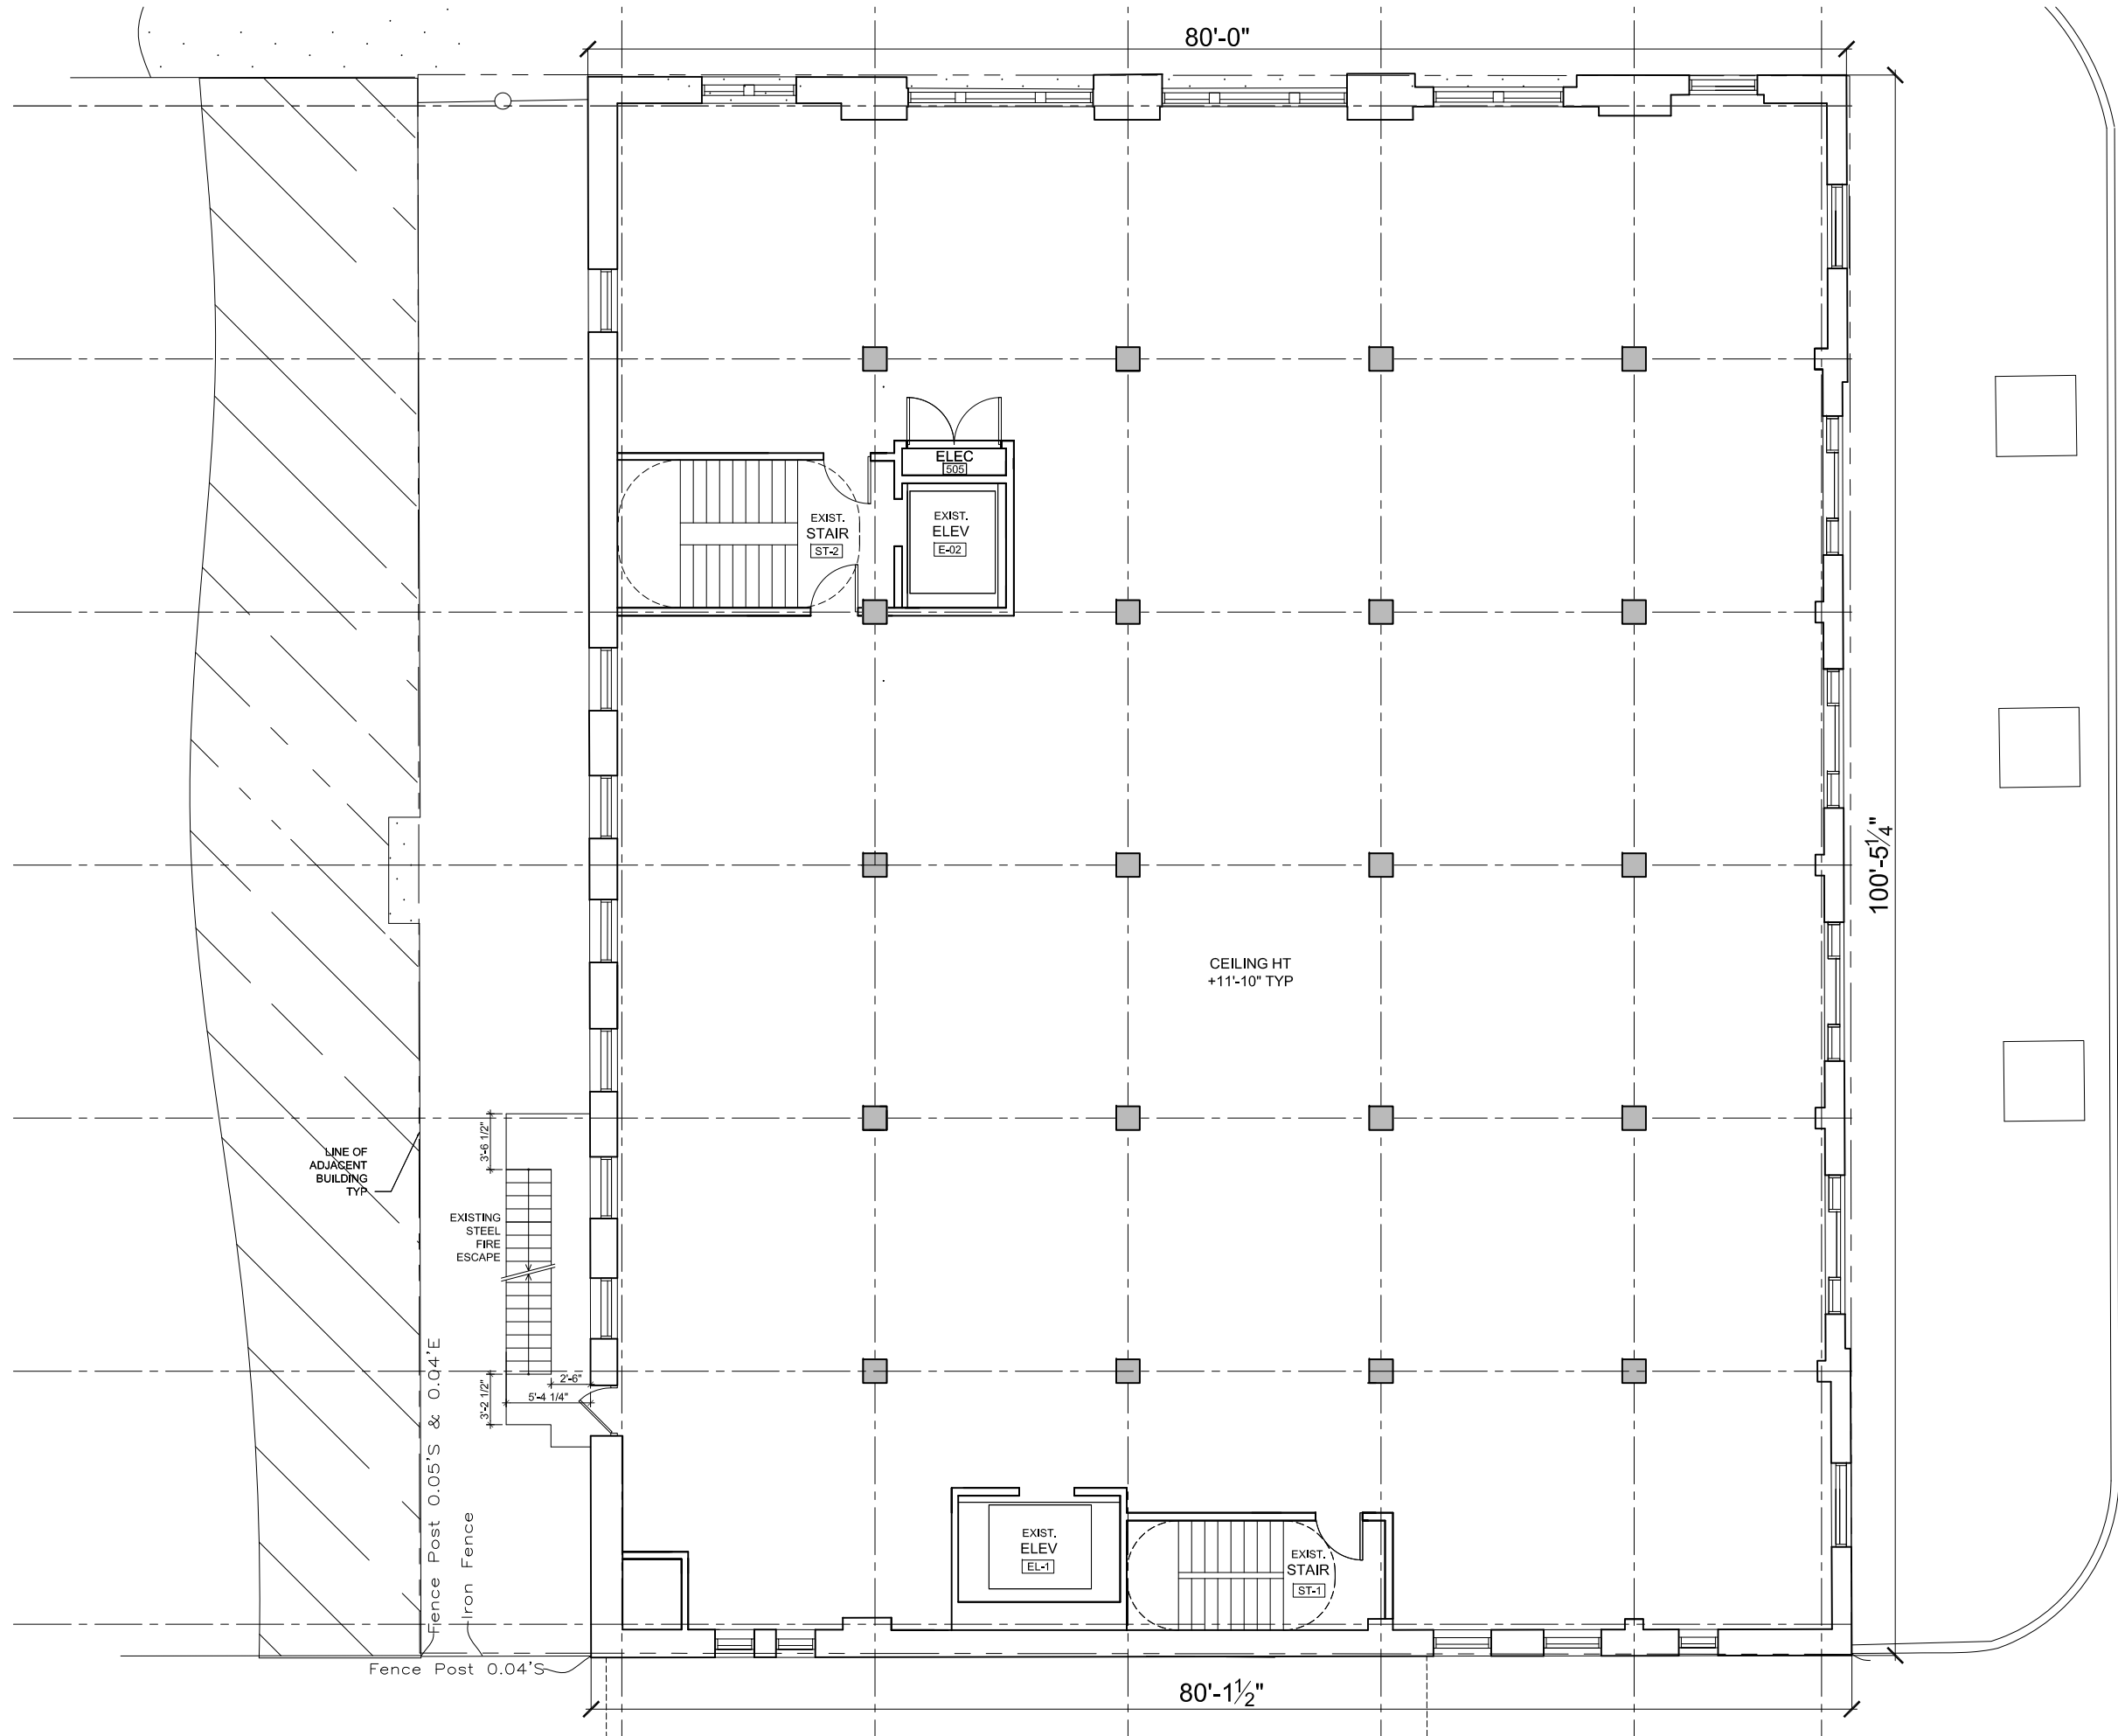


SCALE: 3/32" = 1'-0" PRINTED AT 11X17
   
 (c) LAURA GARCIA DESIGN LLC

NET AREA TO BE REMODELED:
   
 6976 SF

N. LASALLE ST.

**FLOOR 6 EXISTING**
  
 540 N LASALLE ST
   
 09 APRIL 2020

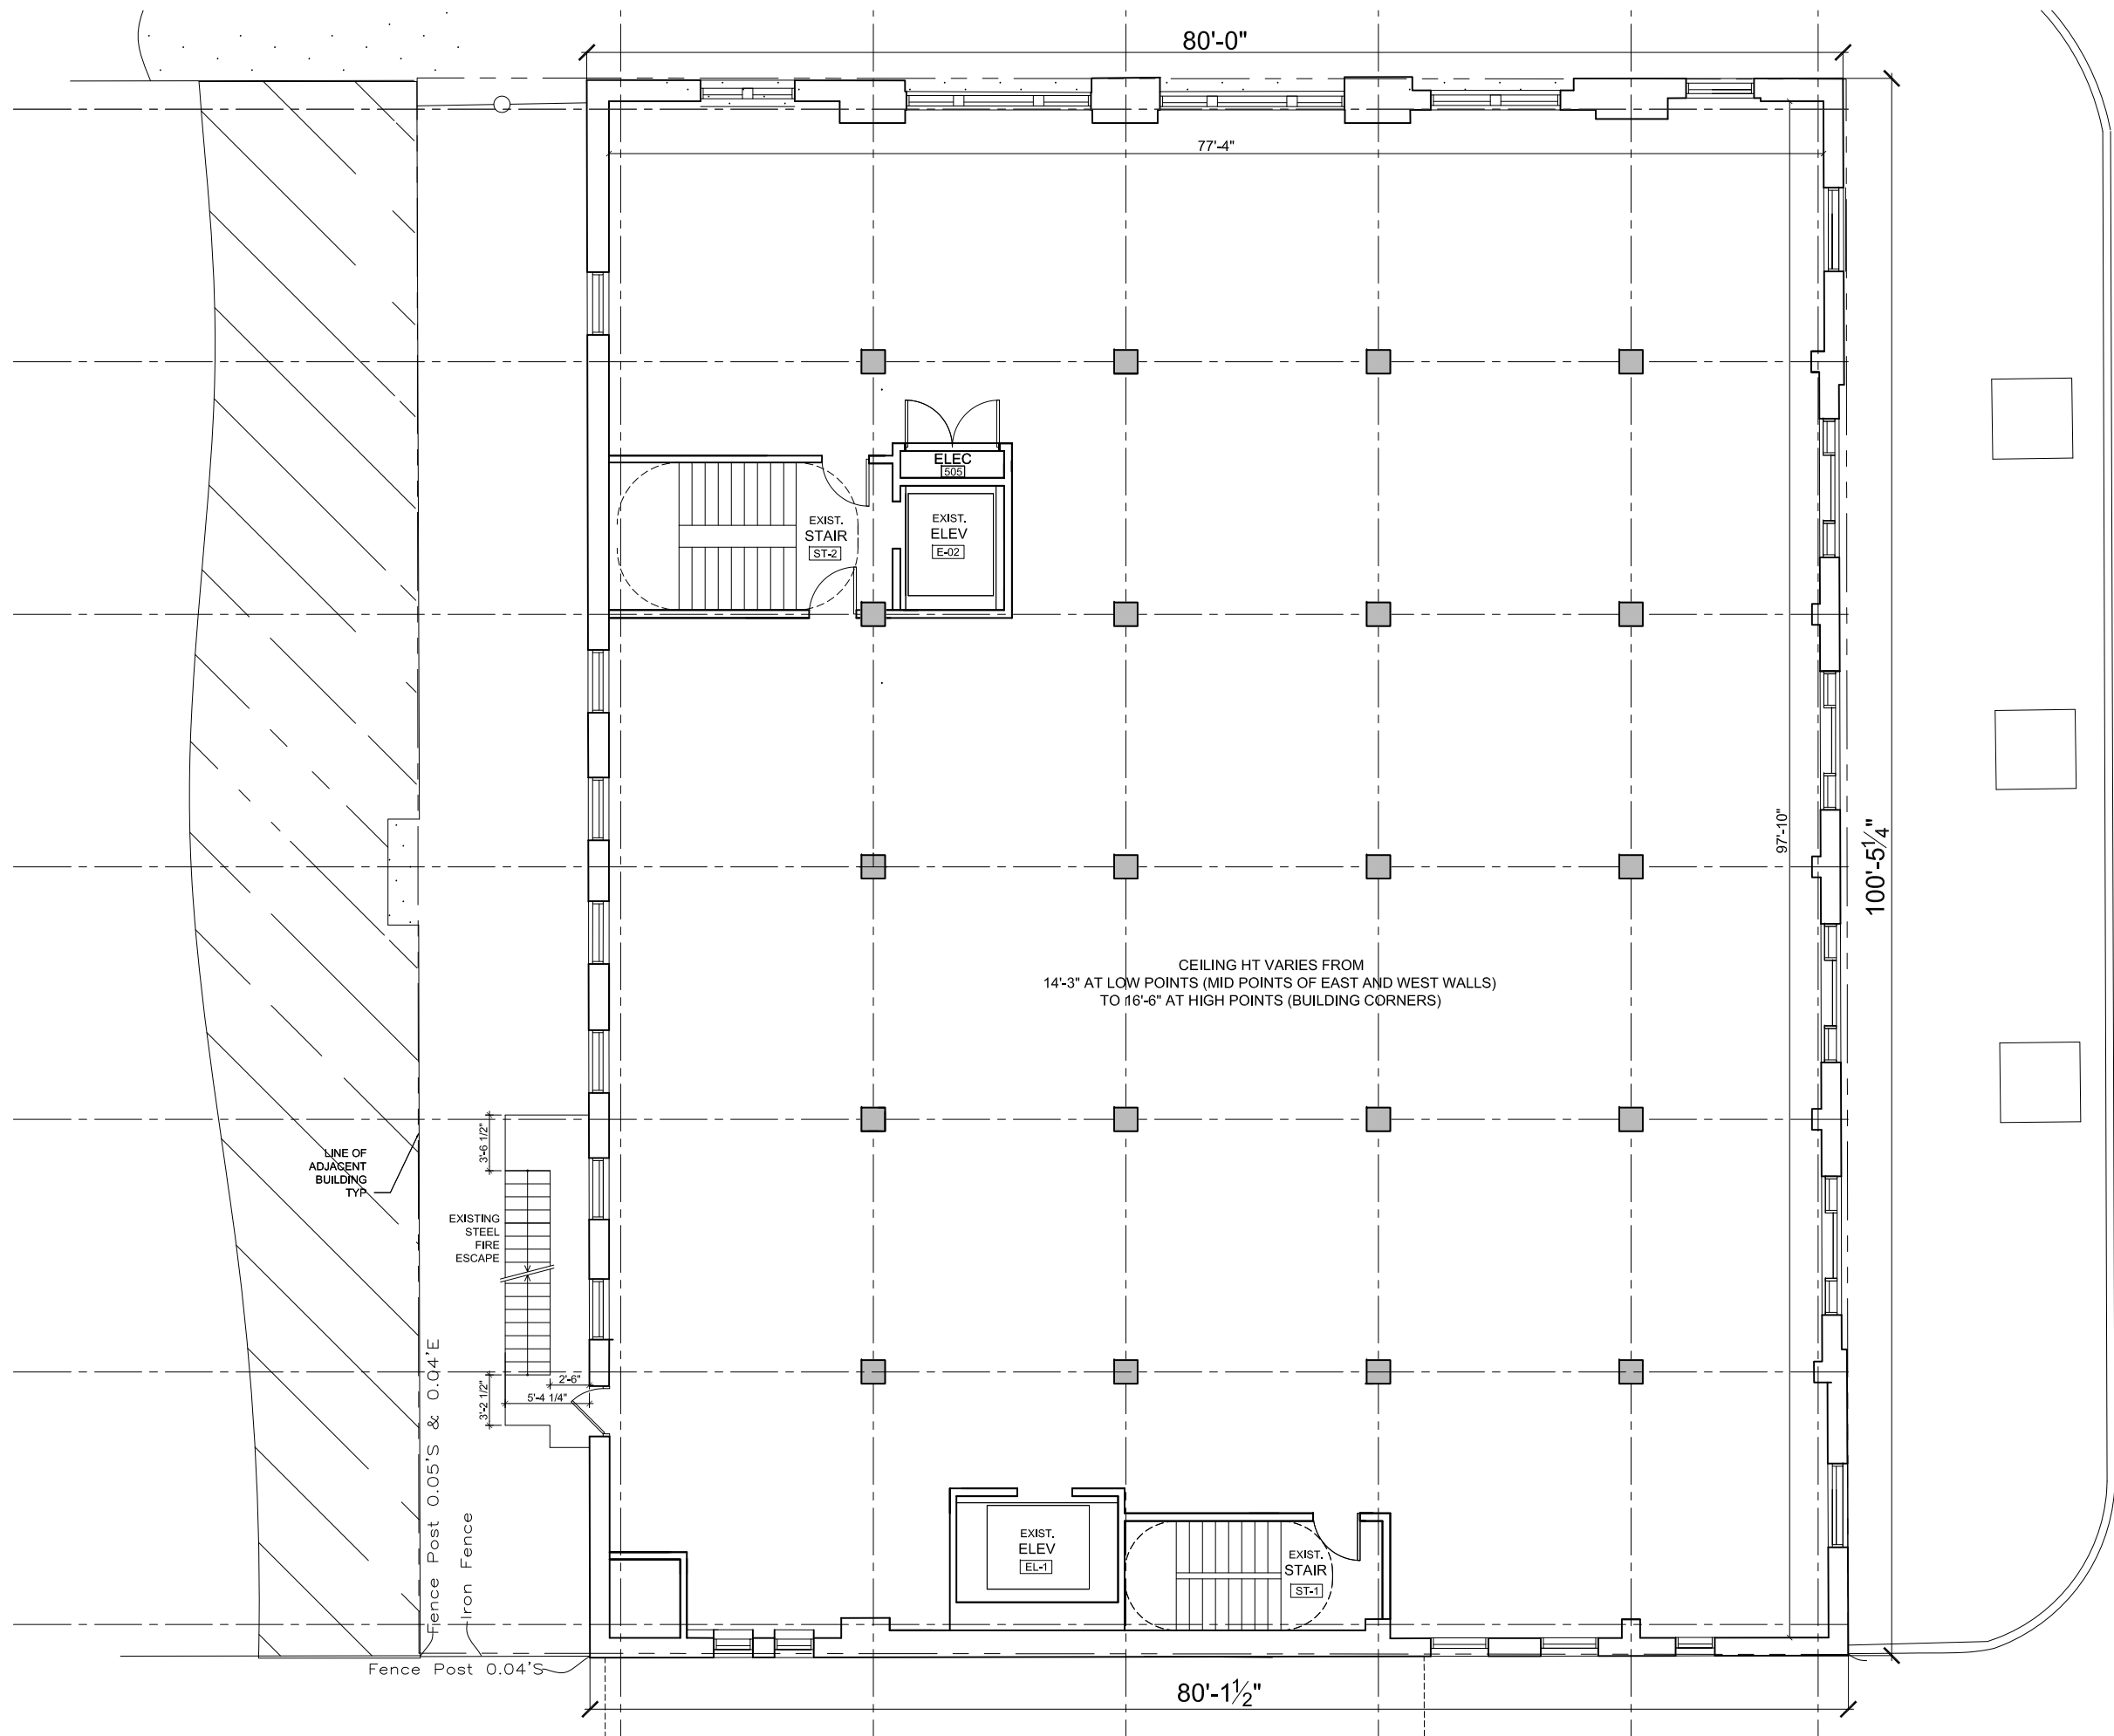


SCALE: 3/32" = 1'-0" PRINTED AT 11X17
   
 (c) LAURA GARCIA DESIGN LLC

NET AREA TO BE REMODELED:
   
 6976 SF

N. LASALLE ST.

**FLOOR 7 EXISTING**
  
 540 N LASALLE ST
   
 09 APRIL 2020

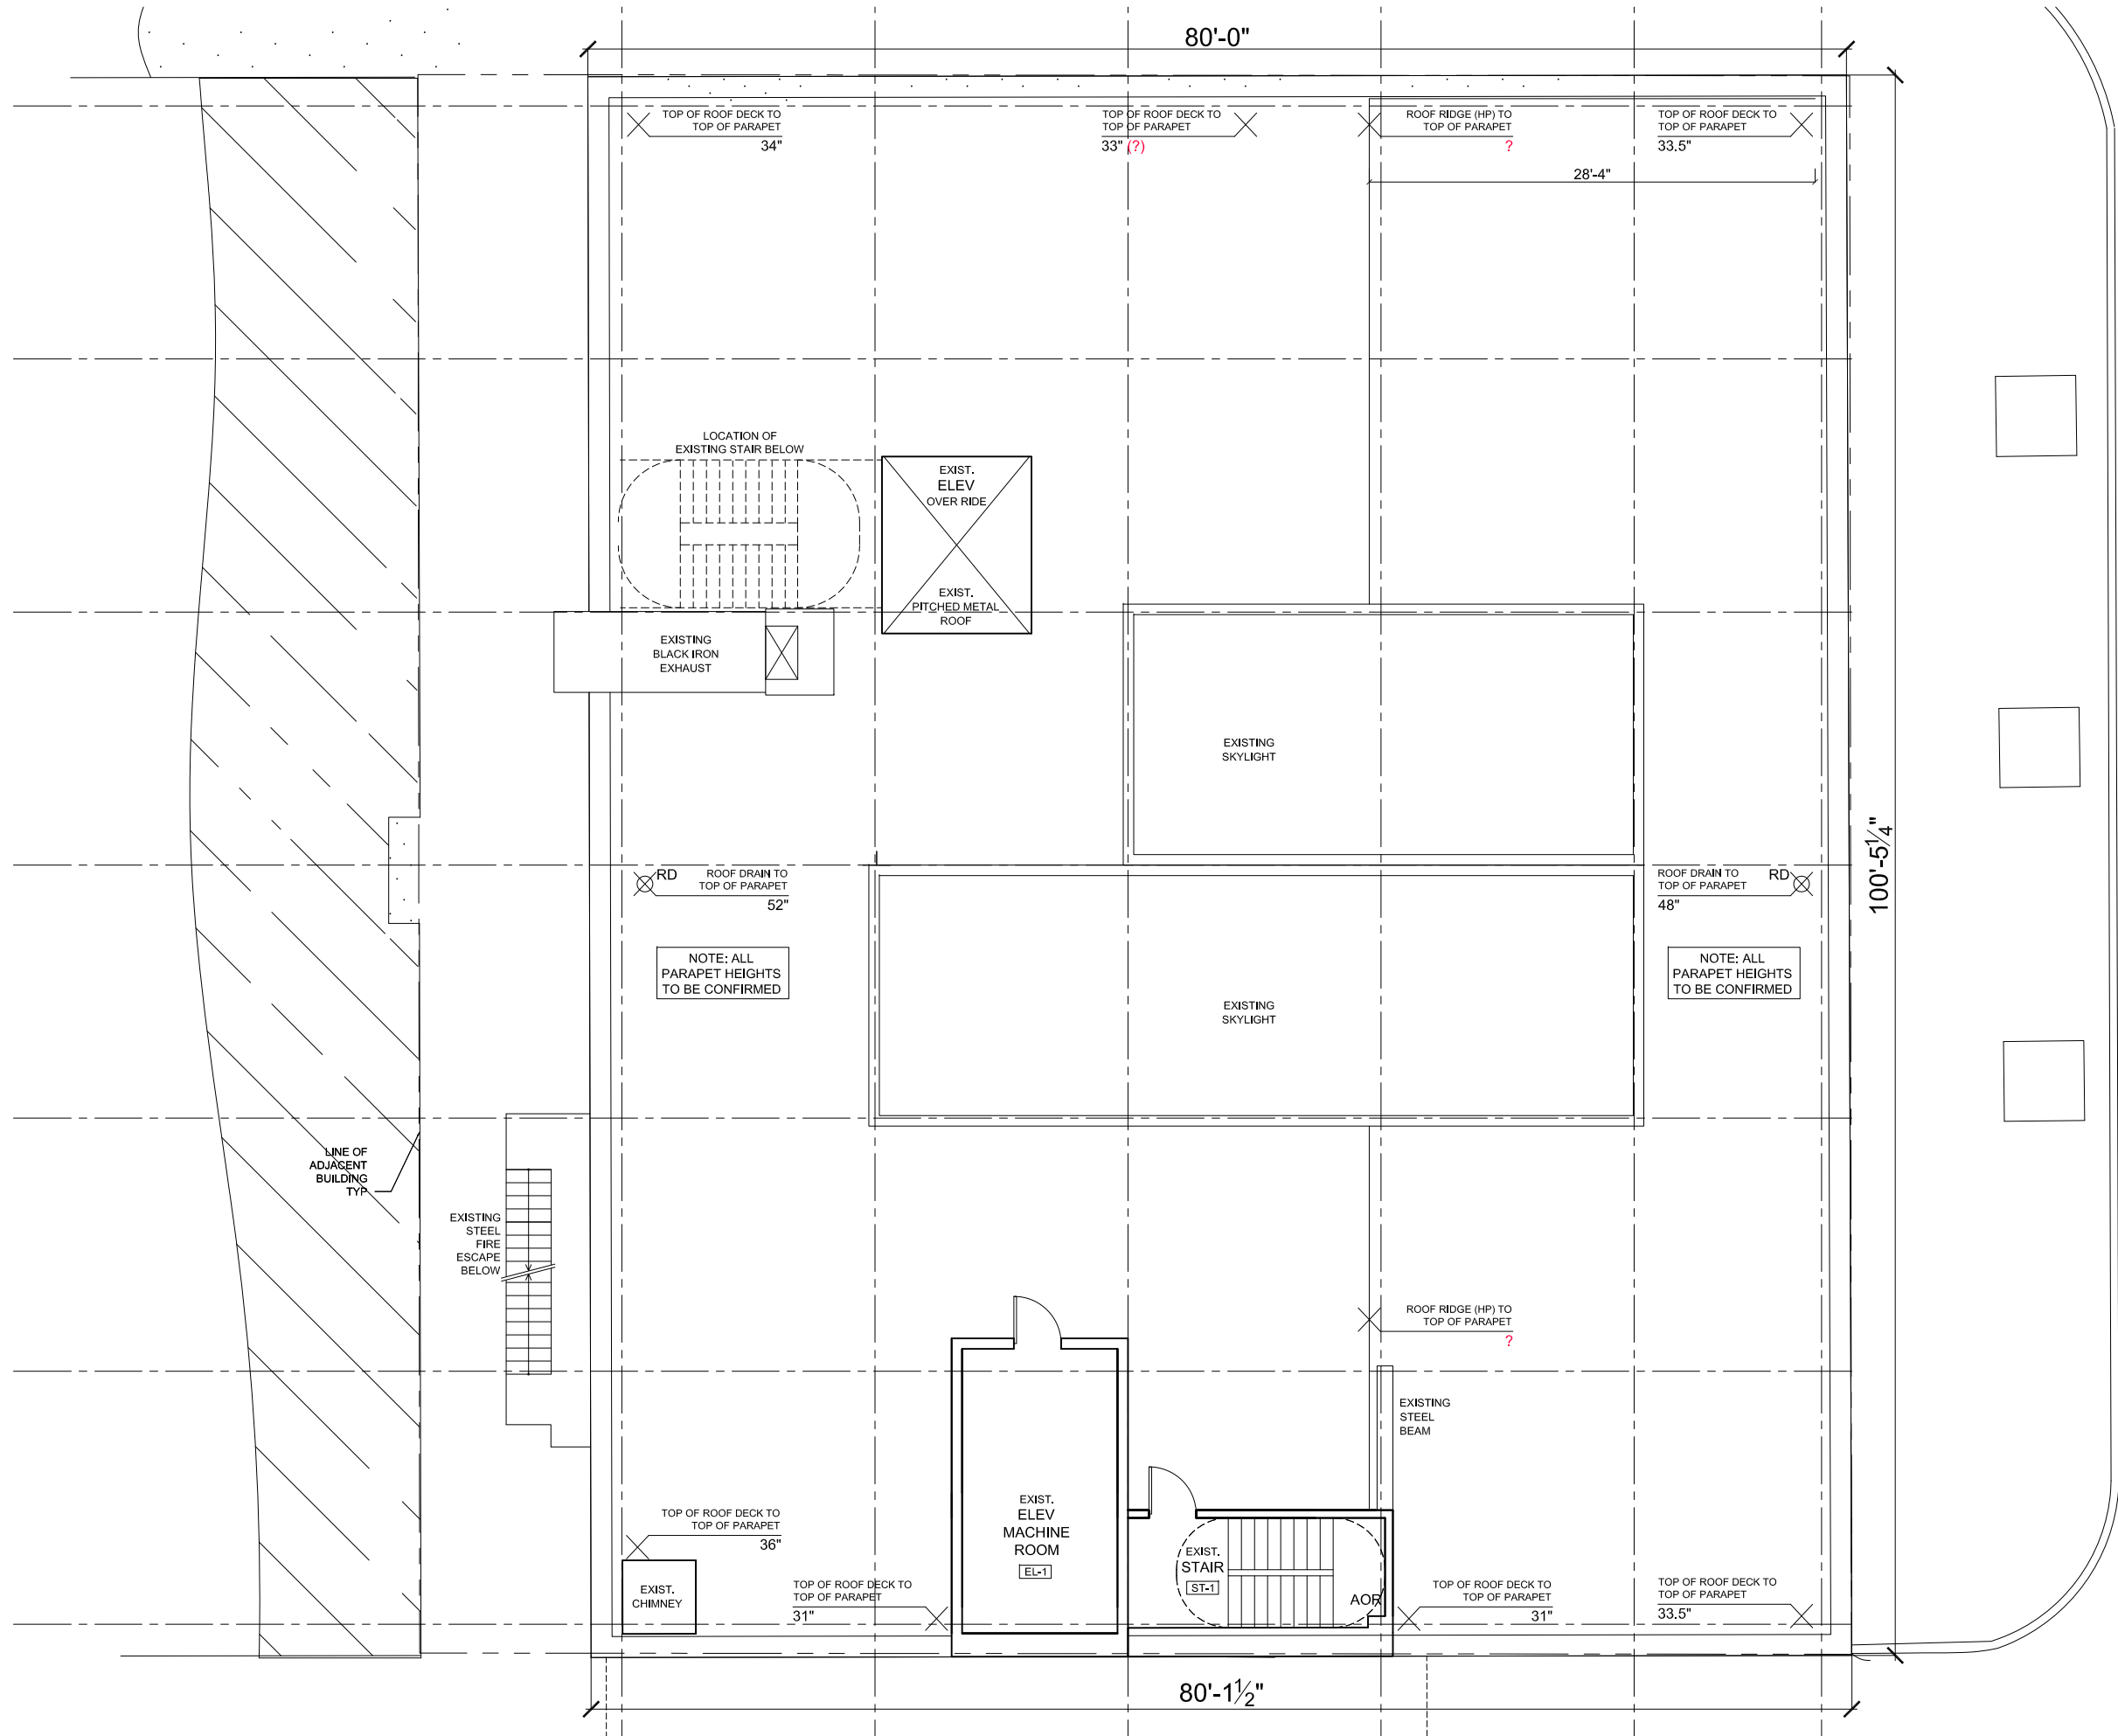

0 1 5 10  
 SCALE: 3/32" = 1'-0" PRINTED AT 11X17  
 (c) LAURA GARCIA DESIGN LLC

N. LASALLE ST.

FLOOR 8 (ROOF) EXISTING  
 540 N LASALLE ST  
 09 APRIL 2020