

CEILING LEGEND

ALL CEILINGS ARE TO BE SMOOTH GYP. BOARD


4" FLUORESCENT SUSPENDED DP-LIGHT

RECESSED CAN LIGHT

HANGING LIGHT FIXTURE

MALL-MOUNTED LIGHT ABOVE LAVATORY

TOILET EXHAUST FAN

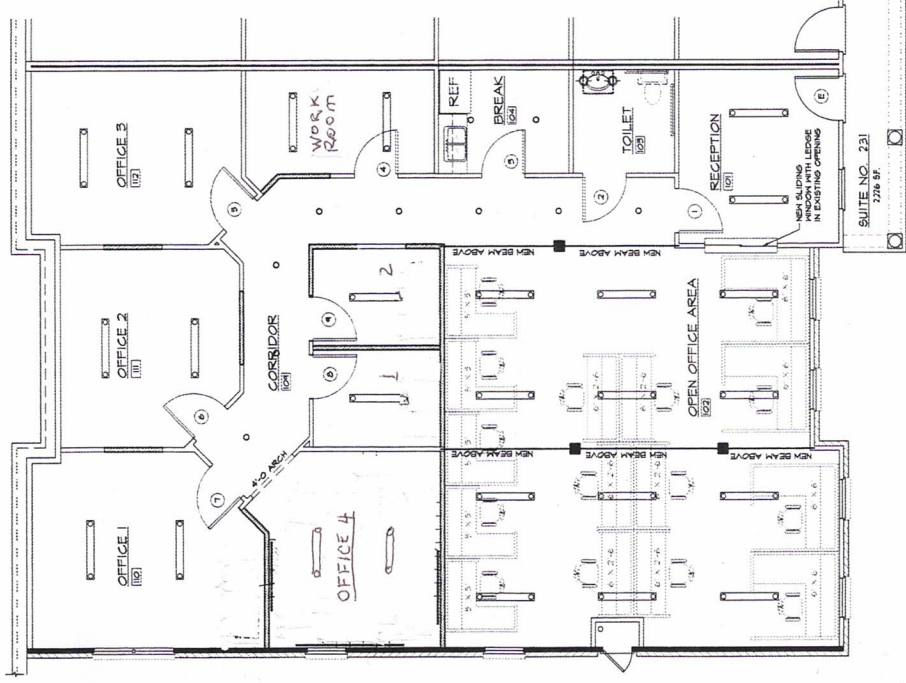

2

CEILING / LIGHTING PLAN

SCALE: 1/4" = 1'-0"

WALL LEGEND


EXISTING WALL TO BE DEVELOPED

EXISTING WALL TO REMAIN

NEW INTERIOR WALL

2" x 4" WOOD STUDS @ 16" O.C. @ 1/2" GYP. BOARD EACH SIDE TO STRUCTURE ABOVE

SEE DETAIL DRAWING

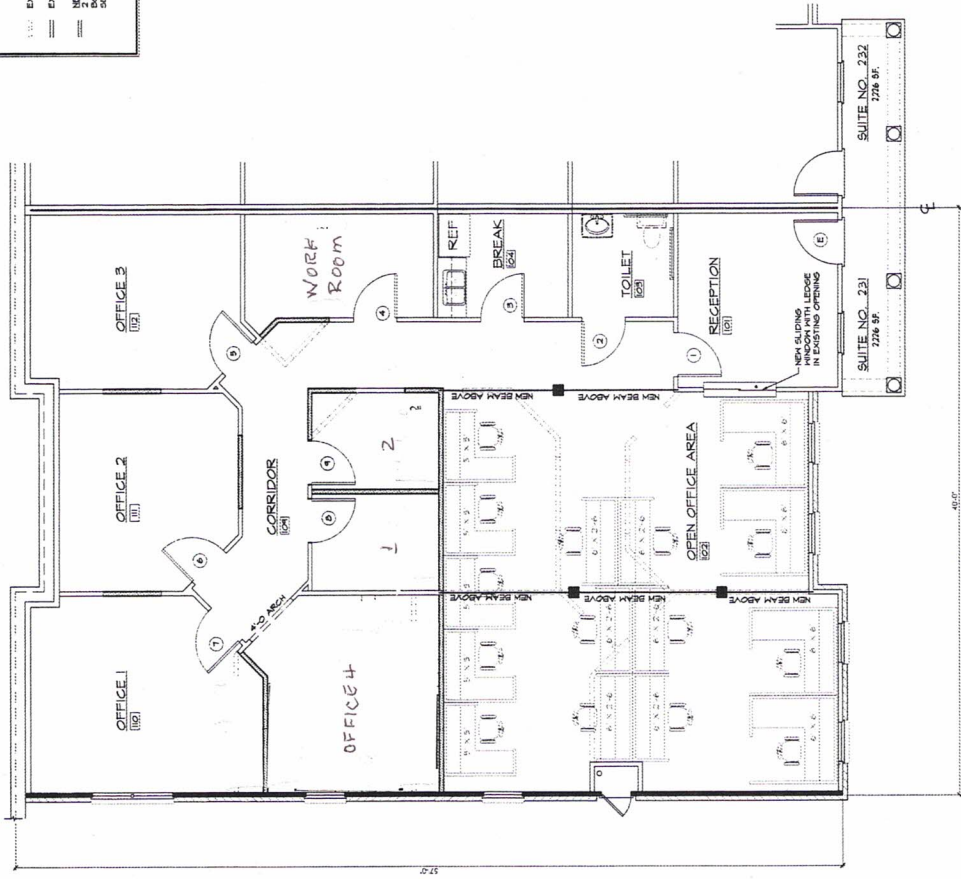

1

FIRST FLOOR PLAN

SCALE: 1/4" = 1'-0"

PCA

PRECISION COMMERCIAL ARCHITECTS, INC.

ARCHITECTURE - SPACE PLANNING - CONSULTING

1000 ALPHARETTA ROAD, SUITE 200

ALPHARETTA, GEORGIA 30022

P: (770) 378-2500 F: (770) 378-0710

EXPANSION FOR

NORTHSIDE PSYCHOLOGICAL SERVICES

AT

NORTH POINT PARK

5755 NORTH POINT PARKWAY

SUITE 200

ALPHARETTA, GEORGIA 30022

PROJECT NO. 12-2124

DATE: 18 JULY 2003

SHEET

DRAWN BY: C.N.

CHECKED BY: C.N.

A-1