

 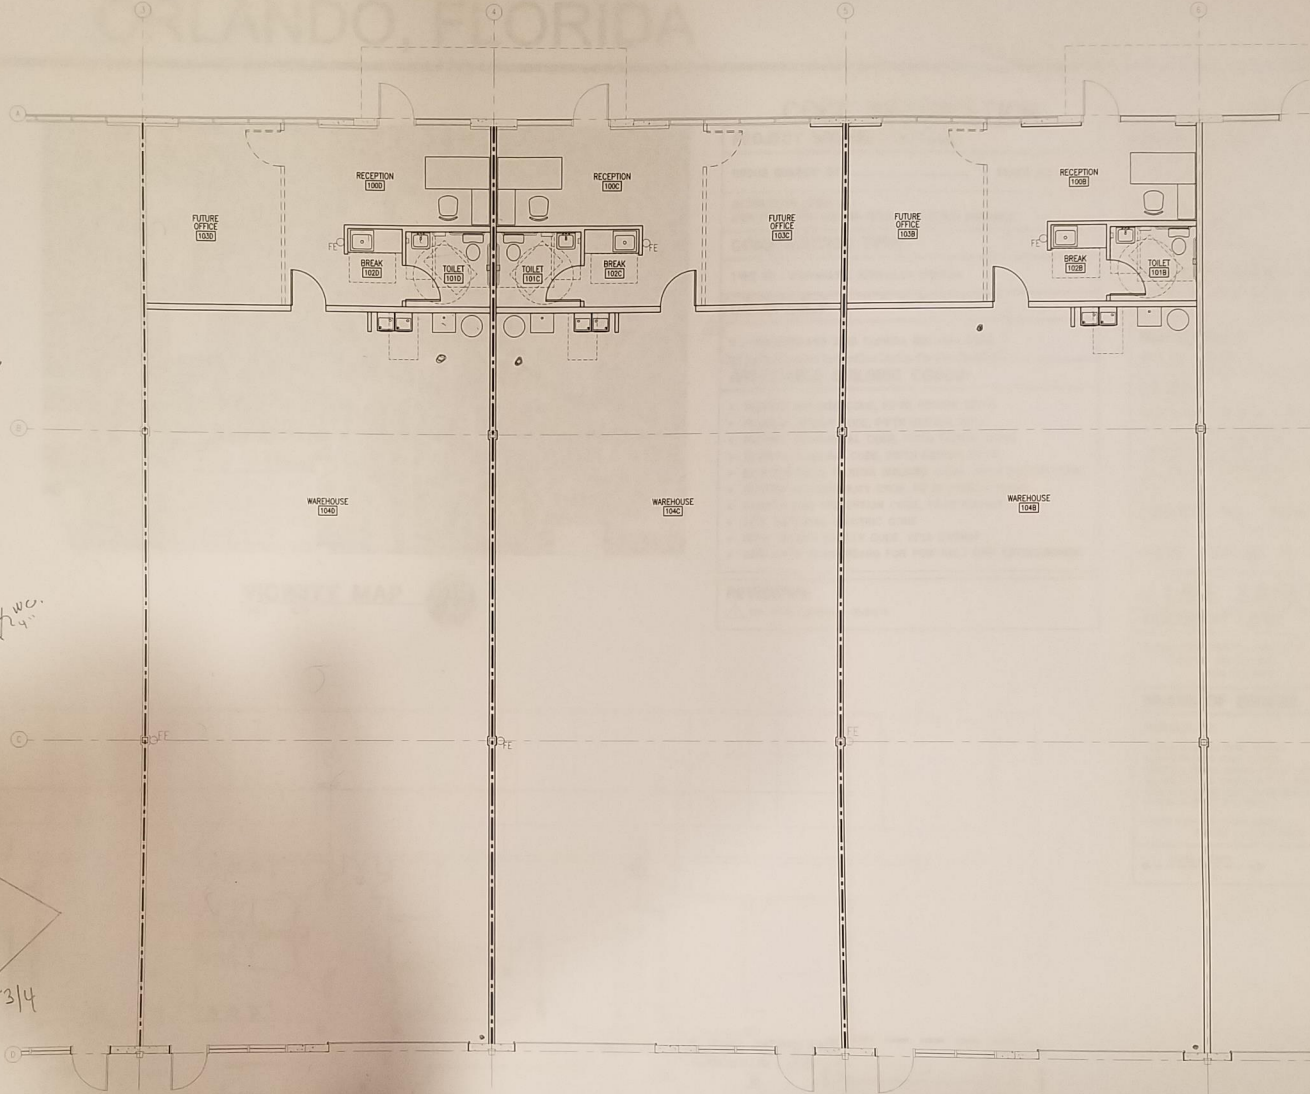


SHADE ROAD
ORLANDO, FLORIDA

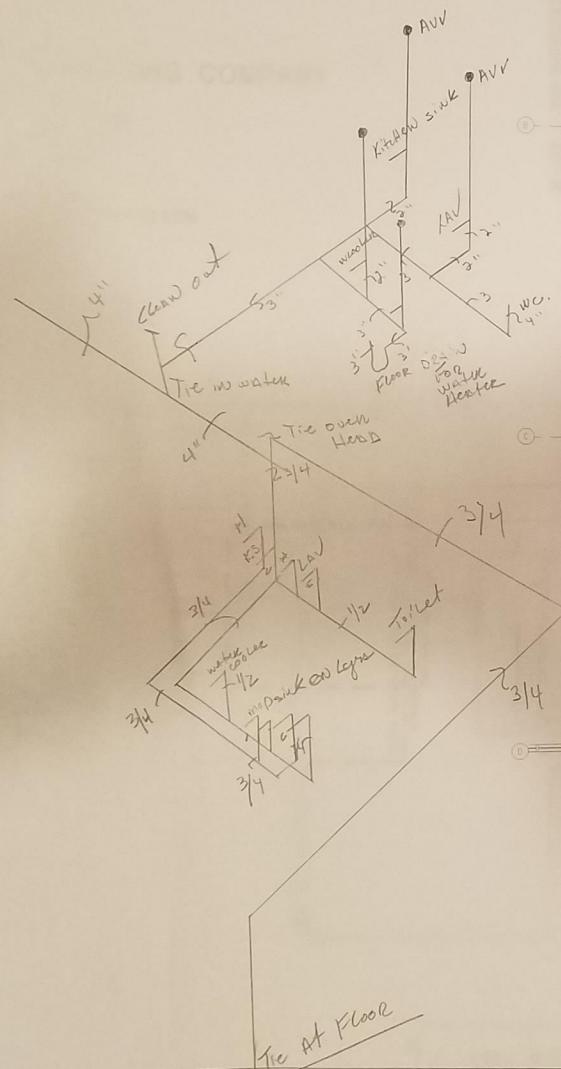

1 PLUMBING PLAN
SCALE: 3/16" = 1'-0"



Lee & Associates

130 W. Central Blvd., Suite 340
Orlando, Florida 32801
TEL: 407.363.6136

Project:
**SPEC SUITE
INTERIOR
IMPROVEMENT
VANTAGE PT.
576 MONROE RD
SANFORD, FL
32771**

Scope Drawings:
These drawings indicate the general scope of the project, the dimensions of the building, the major architectural elements and the type of structural, mechanical and electrical systems.
The drawings do not necessarily indicate or describe all work required for full performance completion of the project. On the basis of the general indicated or described, the contractors shall furnish and complete the work required for the proper execution and completion of the work.

Drawing Title:

Revisions:

Issue Date: 9/23/16
Drawn By: MJA

Certified By:

Drawing Number:

Project Number:

16107