
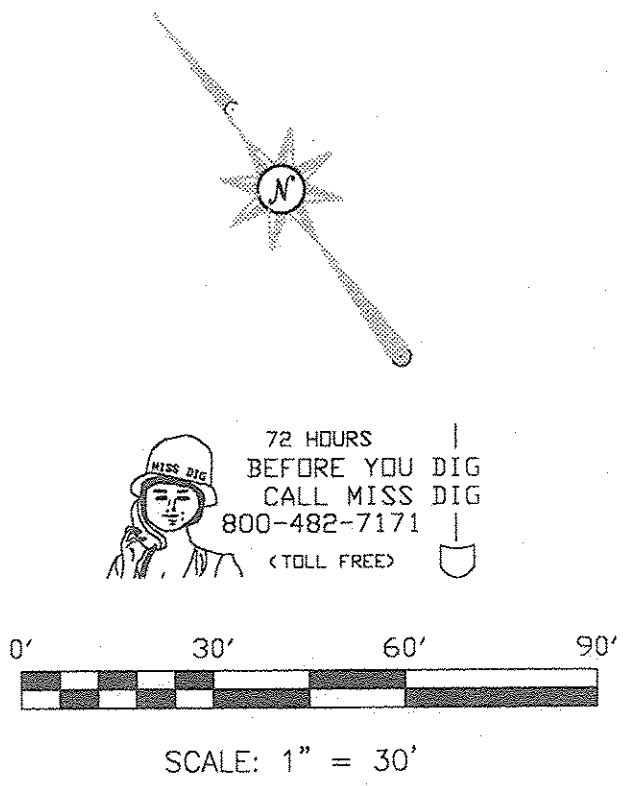


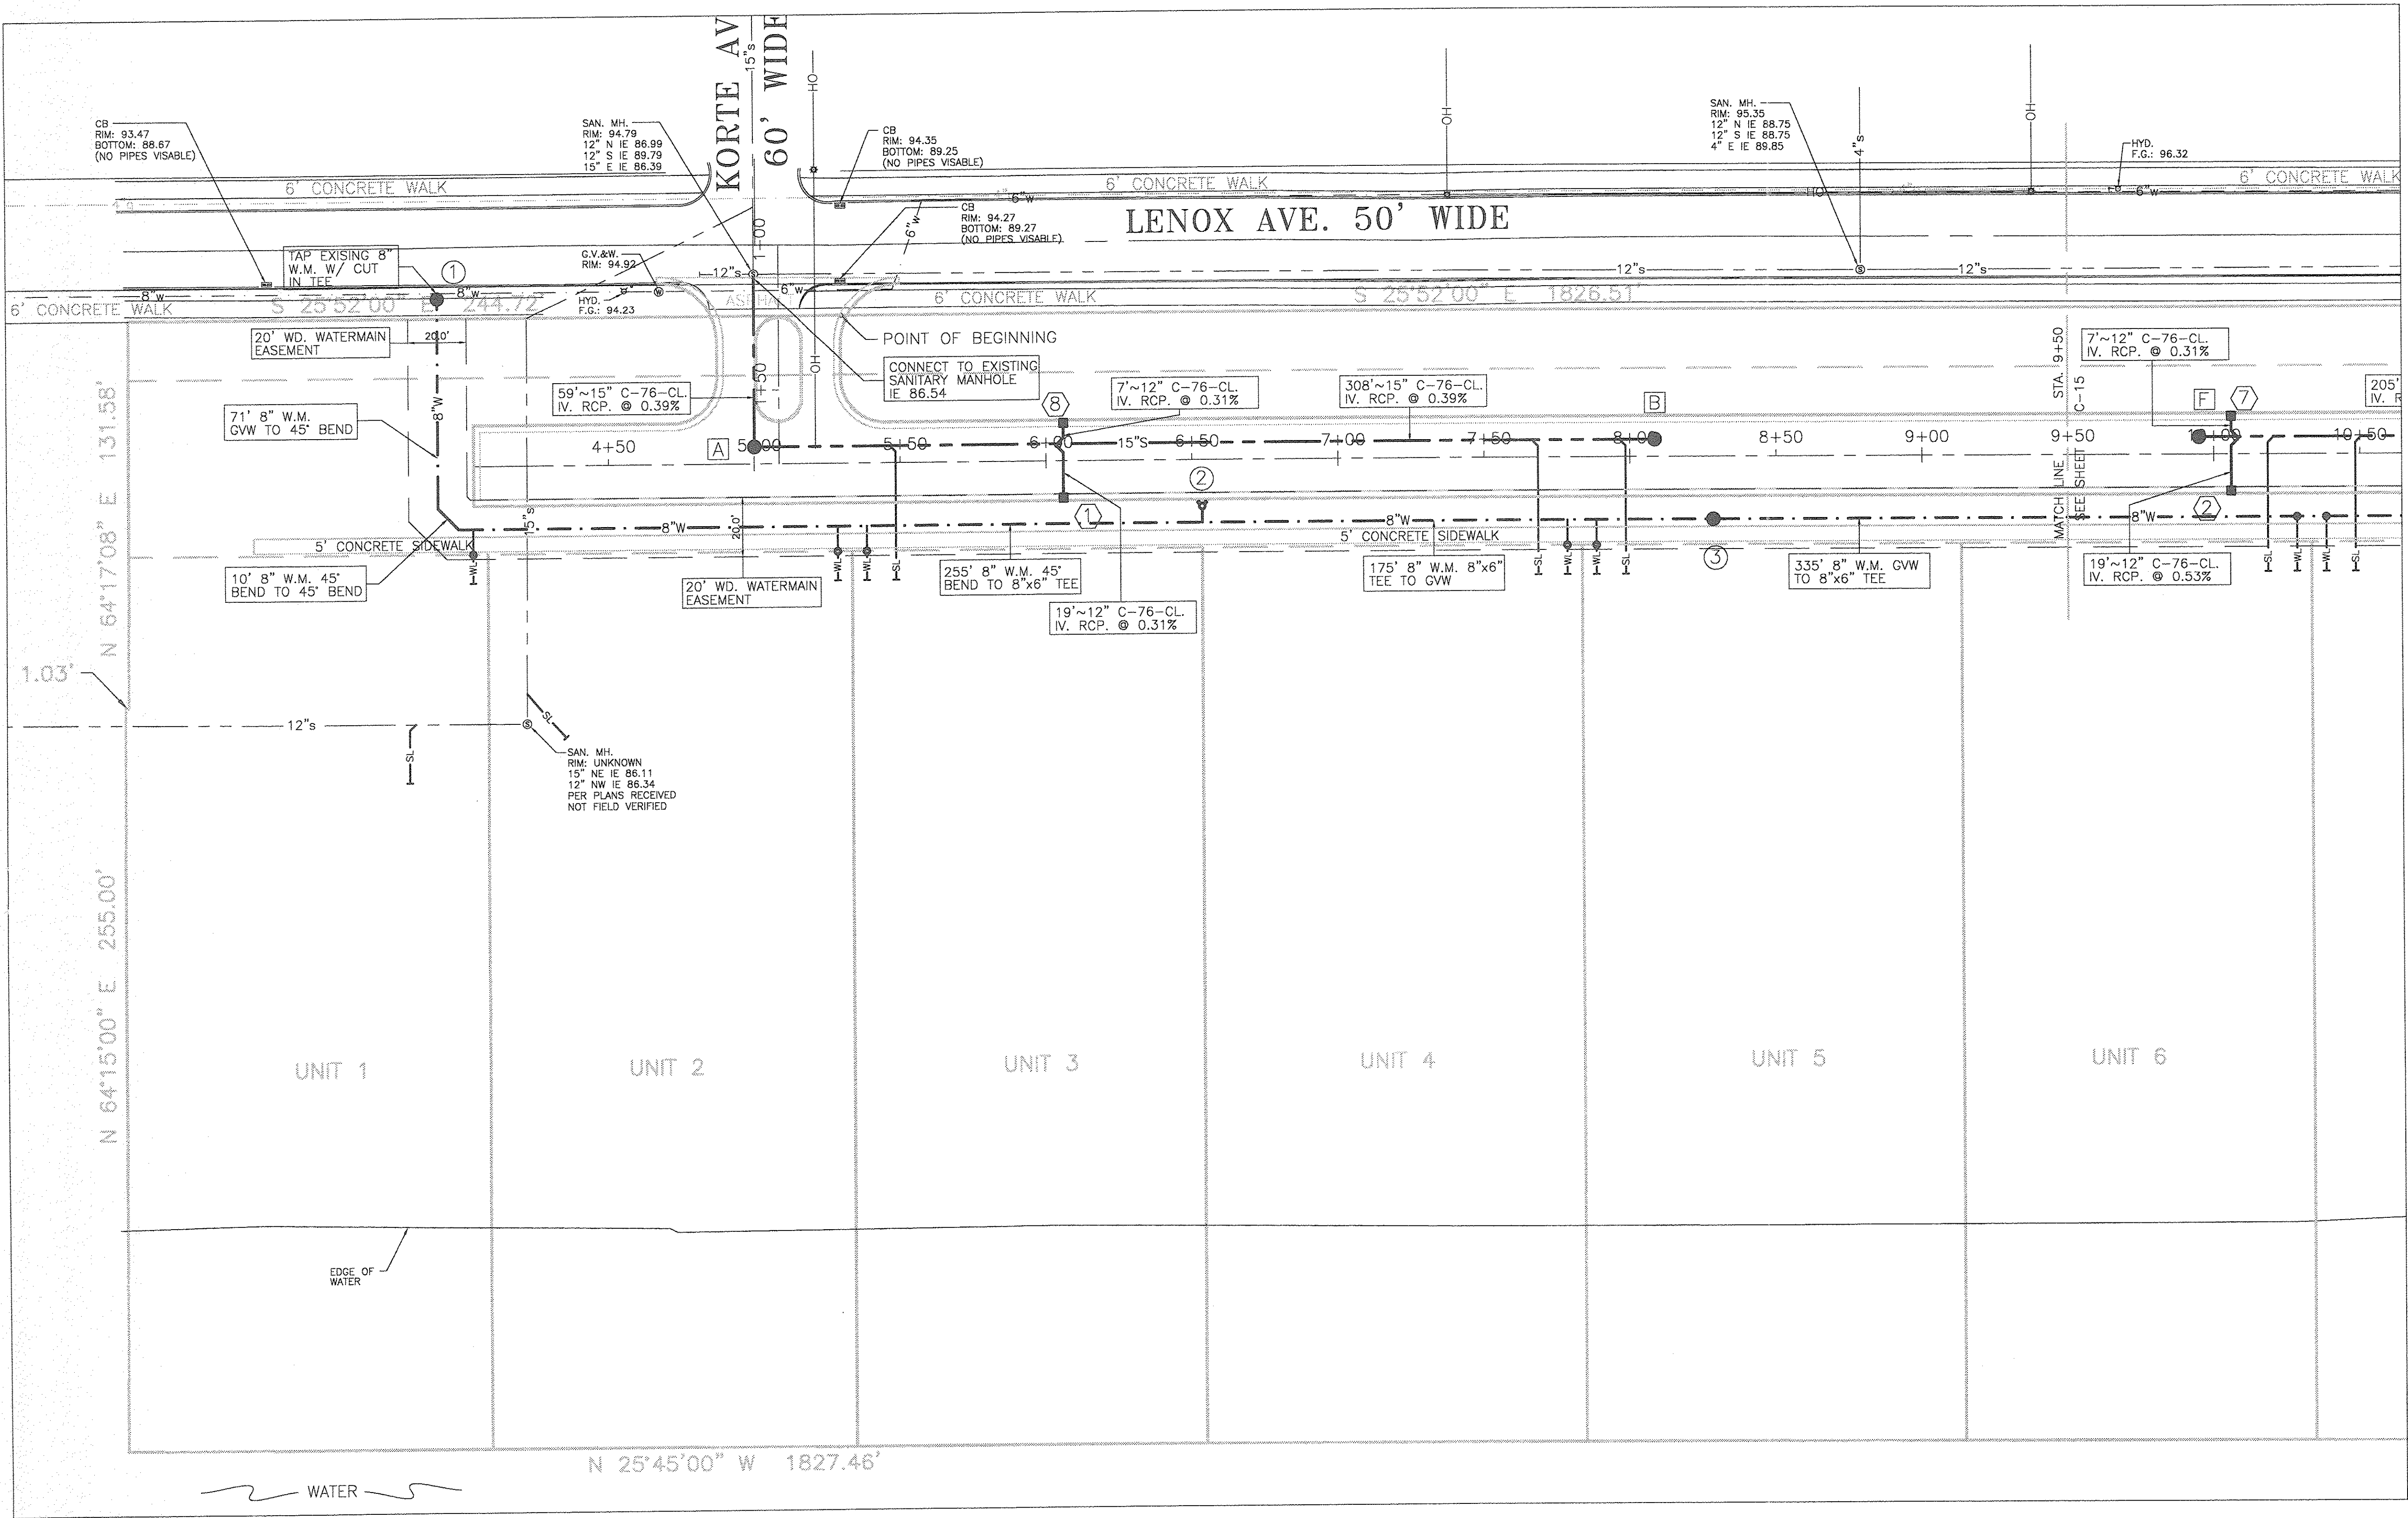

STRUCTURE LEGEND

- ☒ SANITARY MANHOLE
- ☒ CATCH BASIN
- ☒ WATER STRUCTURE

DWSD SYSTEM ACCEPTANCE		
DESIGNED	REVIEWED	DATE
HEAD ENGR-DES.		
CONSTRUCTION INSPECTED:		
HEAD ENGR-FLD.		
PERMIT No.	LS#	
MDNR	D JOB#	
MDPH	DRWG/REF#	
R/W#	SEWER	
	WATER	

UTILITY COMPANIES

- SBC AMERITECH MICHIGAN
JEFF COLLARD
100 SOUTH MAIN STREET
ROOM 314
MT. CLEMENS, MI 48043-2374
(586) 466-1024

DTE ENERGY
SERVICE PLANNING
HELEN LEE
2000 SECOND AVE. (518 S.B.)
DETROIT, MI 48226
(313) 235-9043
(313) 235-9366 FAX
- MICHIGAN CONSOLIDATED GAS
DRAFTING CLERK
MAIN REPLACEMENT TEAM
NOBLE SECOND FLOOR
3200 HOBSON
DETROIT, MI 45201
(313) 577-7236
(313) 577-7061 FAX

COMCAST CONSTRUCTION
RUSTY KEMPER
12775 LYNDON AVENUE
DETROIT, MI 48227-3982
(313) 934-2600 EXT. 440
(313) 934-5782 FAX
- DETROIT WATER & SEWERAGE DEPARTMENT
ENGINEERING GROUPS
1420 WASHINGTON BLVD.
SUITE 100
DETROIT, MI 48226
(313) 964-9800
(313) 964-9810 FAX

GENERAL NOTES

- IN COMPLIANCE WITH PUBLIC ACT 53 OF THE STATE OF MICHIGAN (EFFECTIVE) AUGUST 1, 1974 THE CONTRACTOR SHALL NOTIFY IN ADVANCE OF CONSTRUCTION (72 HOURS/3 WORKING DAYS) ALL PUBLIC AND PRIVATE UTILITY OWNERS HAVE EXISTING FACILITIES IN OR NEAR THE IMMEDIATE WORKING AREA FOR CONVENIENCE. THE KNOWN UTILITY OWNERS ARE LISTED. THIS LISTING DOES NOT, HOWEVER RELIEVE THE CONTRACTOR OF THE RESPONSIBILITY OF VERIFYING UTILITY LOCATIONS AND NOTIFYING ALL UTILITY OWNERS AND MISS DIG. PHONE: 1-800-482-7171
- ALL WATERMAIN TO BE DUTILE IRON CLASS 56 WITH A POLYETHYLENE WRAP IN ACCORDANCE WITH DWSD STANDARDS.
- ALL WATERMAINS TO BE INSTALLED WITH A MINIMUM OF 5'-0" OF COVER.
- CONCRETE THRUST BLOCKS SHALL BE PLACED ON ALL FITTINGS.
- ALL WATERMAIN WORK IS TO BE DONE IN ACCORDANCE WITH DETROIT WATER AND SEWERAGE DEPARTMENT'S STANDARD AND SPECIFICATIONS, PERMIT AND INSPECTION.
- ROOF DOWNSPOUTS ARE NOT TO BE DIRECTLY CONNECTED TO THE SEWER SYSTEM.

WATER SERVICE NOTE

A. SINGLE FAMILY DOMESTIC WATER SERVICE LEADS SHALL BE 1" TYPE "K" COPPER.



ISSUE DATE	9/1/06
REVISIONS	
CLIENT:	MORGAN DEVELOPMENT LLC
	36150 DEQUINDRE
	SUITE 600
	STERLING HEIGHTS, MI 48310

9800 ANN ARBOR ROAD, WEST
PLYMOUTH, MI 48170
PHONE: (734) 415-9850
FAX: (734) 415-9857
www.glsurveyor.com

GLA
SURVEYORS &
ENGINEERS

UTILITY PLAN 1
LENOX WATERFRONT ESTATES
LENOX AVENUE
WAYNE COUNTY, CITY OF DETROIT, MICHIGAN

ISSUED FOR REVIEW ONLY		
FILE NO.: 2791	DWG.: ENG SITE PLAN	
DESIGNED BY: S.A.S.		SHEET No. C-14
DRAWN BY: S.A.S.		
CHECKED BY: L.P.R.		
SCALE: 1" = 30'		

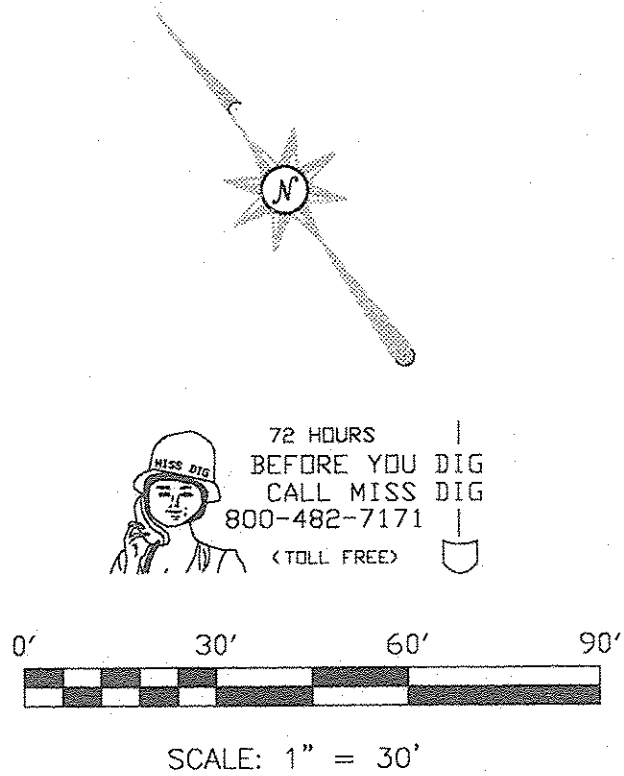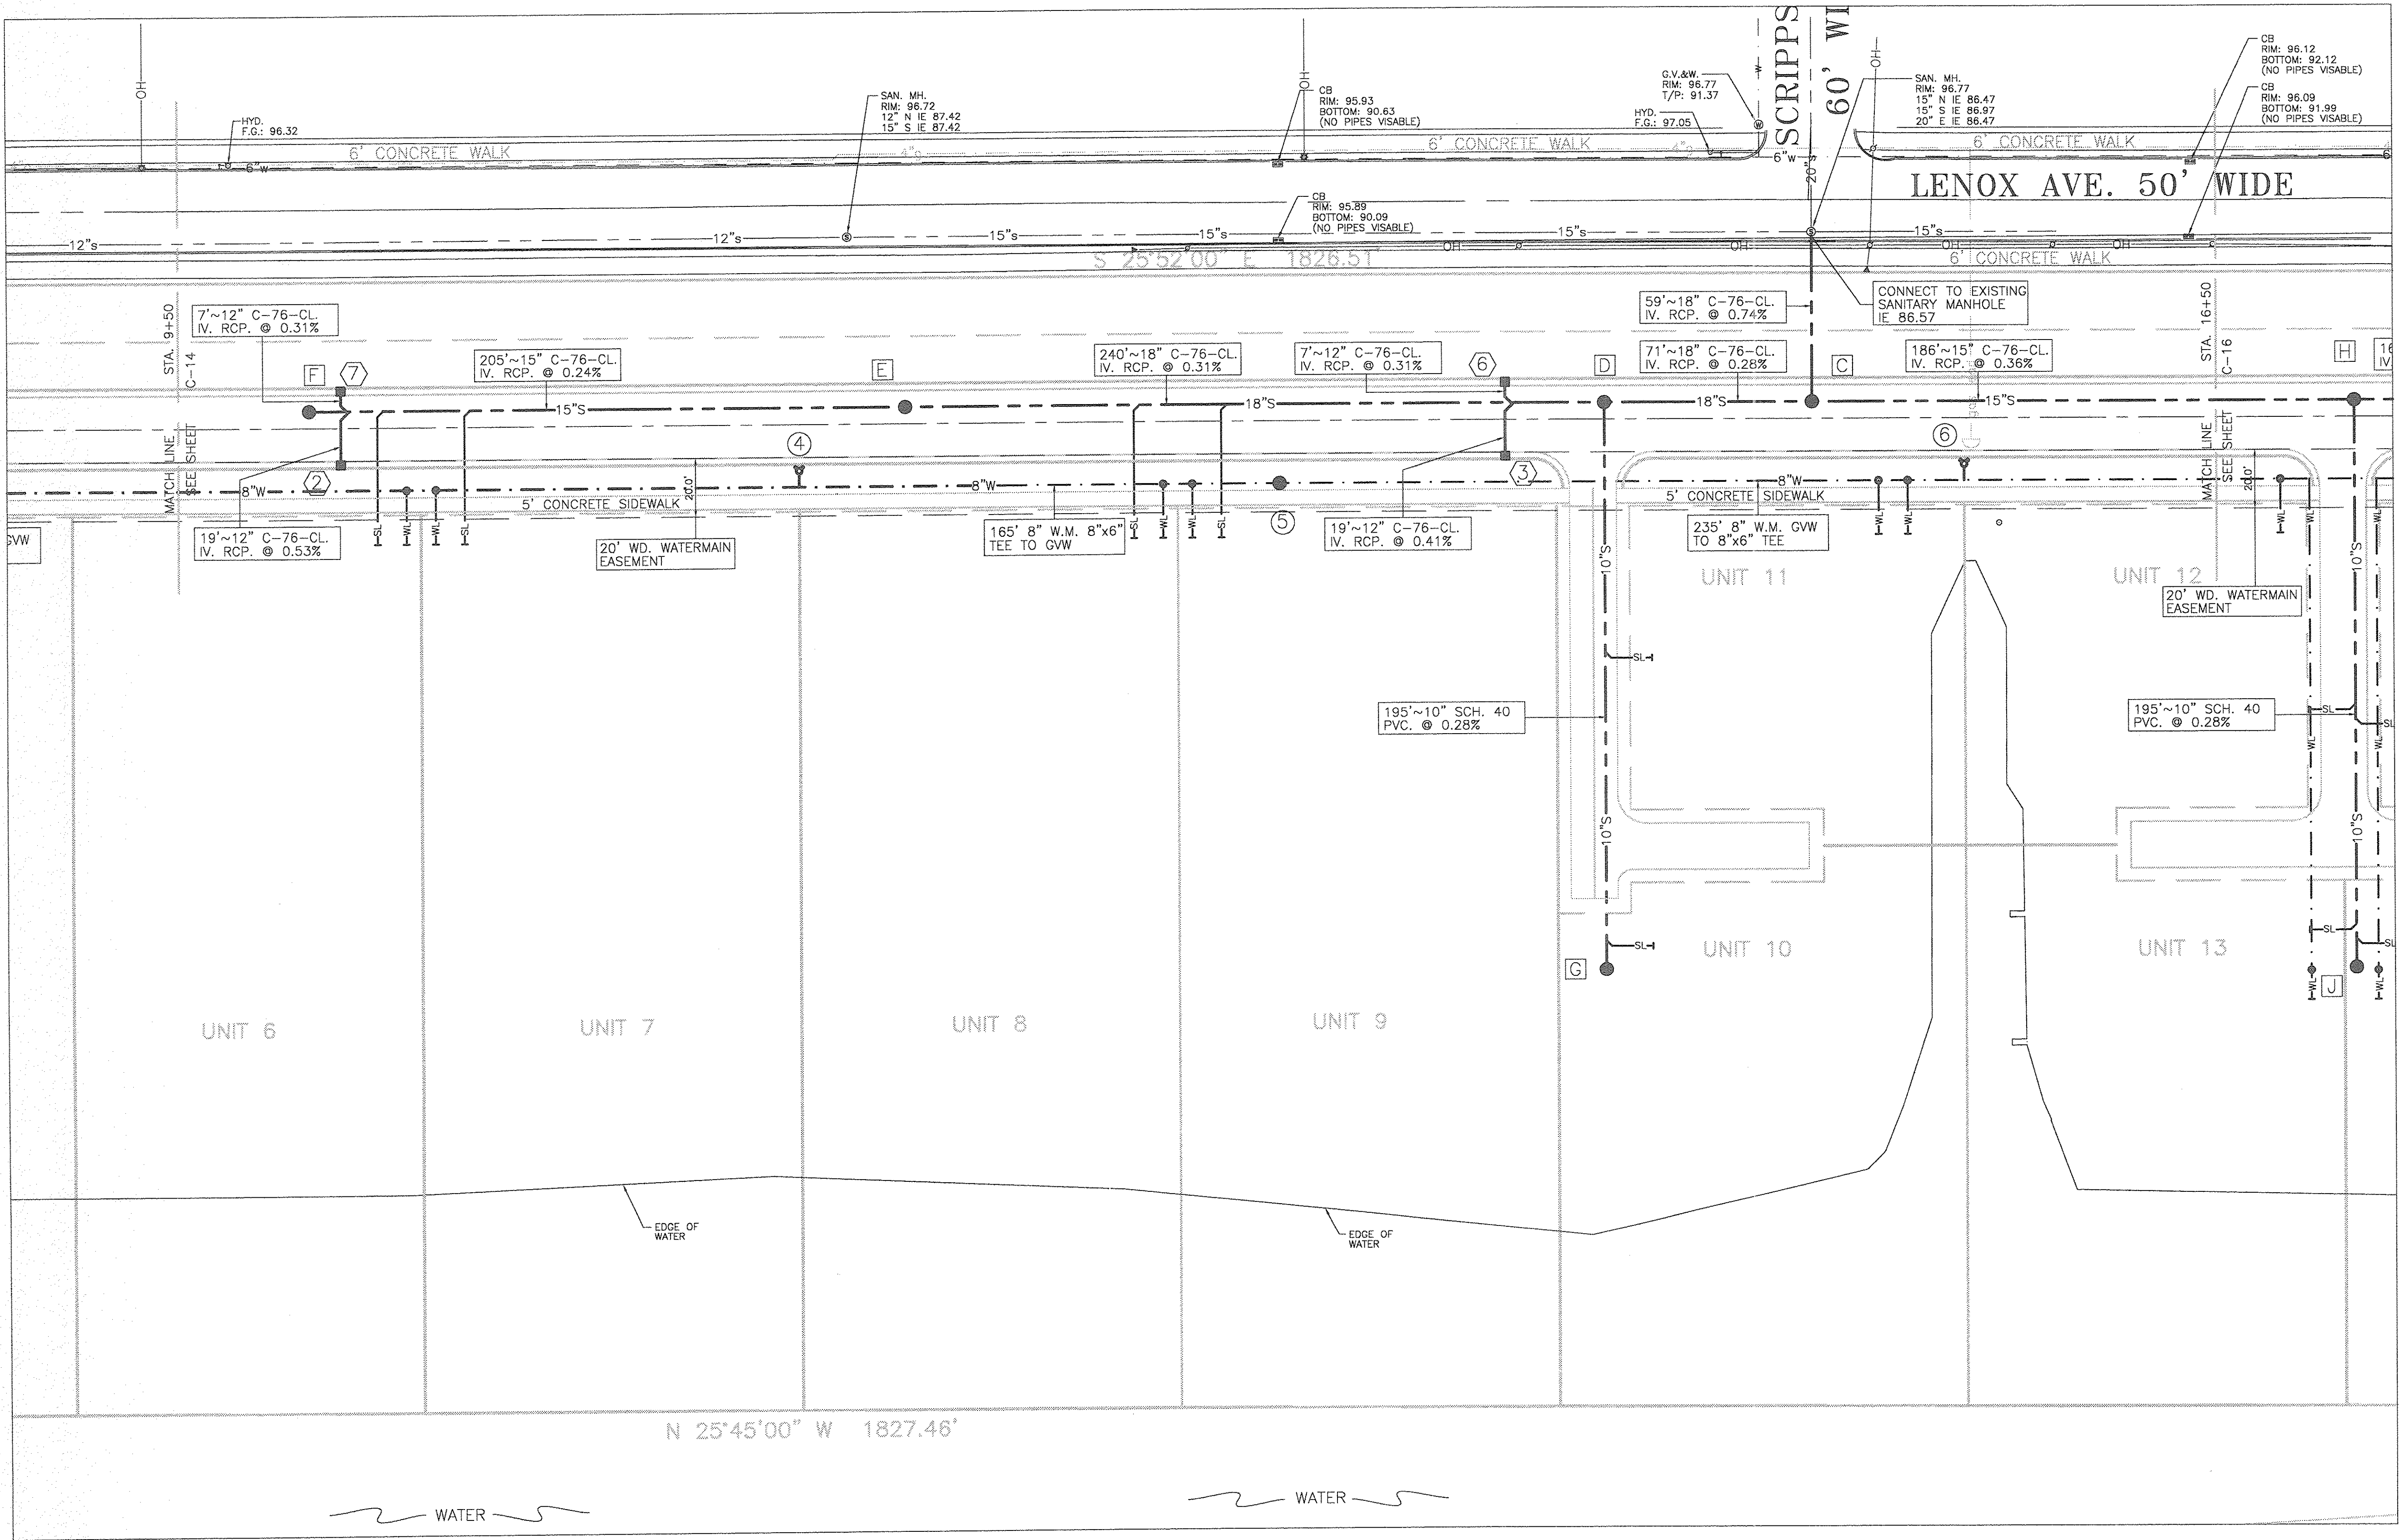

STRUCTURE LEGEND	
☒	SANITARY MANHOLE
☒	CATCH BASIN
☒	WATER STRUCTURE

DWSD SYSTEM ACCEPTANCE	
DESIGNED REVIEWED	DATE
HEAD ENGR-DES.	
CONSTRUCTION INSPECTED	
HEAD ENGR-FLD.	
PERMIT No.	LS#
MDNR	D JOB#
R/W#	DRWG/REF#
	SEWER
	WATER

ISSUED FOR REVIEW ONLY		
FILE NO.: 2791	DWG.: ENG SITE PLAN	SHEET No. C-15
DESIGNED BY: S.A.S.		
DRAWN BY: S.A.S.		
CHECKED BY: L.P.R.		
SCALE: 1" = 30'		

UTILITY COMPANIES

SBC AMERITECH MICHIGAN JEFF COLLARD 100 SOUTH MAIN STREET ROOM 314 MT. CLEMENS, MI 48043-2374 (586) 466-1024	MICHIGAN CONSOLIDATED GAS DRAFTING CLERK MAIN REPLACEMENT TEAM NOBLE SECOND FLOOR 3200 HOBSON DETROIT, MI 48226 (313) 677-7236 (313) 577-7061 FAX	DETROIT WATER & SEWERAGE DEPARTMENT ENGINEERING GROUPS 1420 WASHINGTON BLVD. SUITE 100 DETROIT, MI 48226 (313) 964-9800 (313) 964-9810 FAX
DTE ENERGY SERVICE PLANNING HELEN LEE 2000 SECOND AVE. (518 S.B.) DETROIT, MI 48226 (313) 235-9043 (313) 235-9366 FAX	COMCAST CONSTRUCTION RUSTY KEMPER 12775 LYNDON AVENUE DETROIT, MI 48227-3982 (313) 934-2600 EXT. 440 (313) 934-5782 FAX	

GENERAL NOTES


- IN COMPLIANCE WITH PUBLIC ACT 53 OF THE STATE OF MICHIGAN (EFFECTIVE) AUGUST 1, 1974 THE CONTRACTOR SHALL NOTIFY IN ADVANCE OF CONSTRUCTION (72 HOURS/3 WORKING DAYS) ALL PUBLIC AND PRIVATE UTILITY OWNERS HAVE EXISTING FACILITIES IN OR NEAR THE IMMEDIATE WORKING AREA FOR CONVENIENCE. THE KNOWN UTILITY OWNERS ARE LISTED. THIS LISTING DOES NOT , HOWEVER RELIEVE THE CONTRACTOR OF THE RESPONSIBILITY OF VERIFYING UTILITY LOCATIONS AND NOTIFYING ALL UTILITY OWNERS AND MISS DIG. PHONE: 1-800-482-7171
- ALL WATERMAIN TO BE DUTILE IRON CLASS 56 WITH A POLYETHYLENE WRAP IN ACCORDANCE WITH DWSD STANDARDS.
- ALL WATERMAINS TO BE INSTALLED WITH A MINIMUM OF 5'-0" OF COVER.
- CONCRETE THRUST BLOCKS SHALL BE PLACED ON ALL FITTINGS.
- ALL WATERMAIN WORK IS TO BE DONE IN ACCORDANCE WITH DETROIT WATER AND SEWERAGE DEPARTMENT'S STANDARD AND SPECIFICATIONS, PERMIT AND INSPECTION.
- ROOF DOWNSPOUTS ARE NOT TO BE DIRECTLY CONNECTED TO THE SEWER SYSTEM.

WATER SERVICE NOTE

- A. SINGLE FAMILY DOMESTIC WATER SERVICE LEADS SHALL BE 1" TYPE "K" COPPER.

ISSUE DATE		REVISIONS
9/1/06		
CLIENT:		MORGAN DEVELOPMENT LLC
		36150 DEQUINDRE
		SUITE 600
		STERLING HEIGHTS, MI 48310

9800 ANN ARBOR ROAD, WEST
PLYMOUTH, MI 48170
PHONE: (734) 416-9650
FAX: (734) 416-9657
www.glsurveyor.com


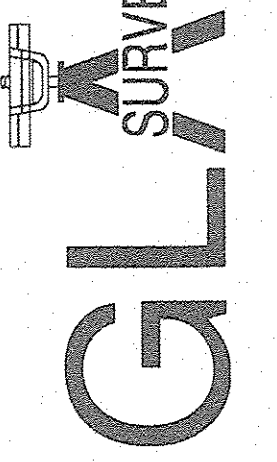
SURVEYORS & ENGINEERS

UTILITY PLAN 2

LENOX WATERFRONT ESTATES


LENOX AVENUE

WAYNE COUNTY, CITY OF DETROIT, MICHIGAN

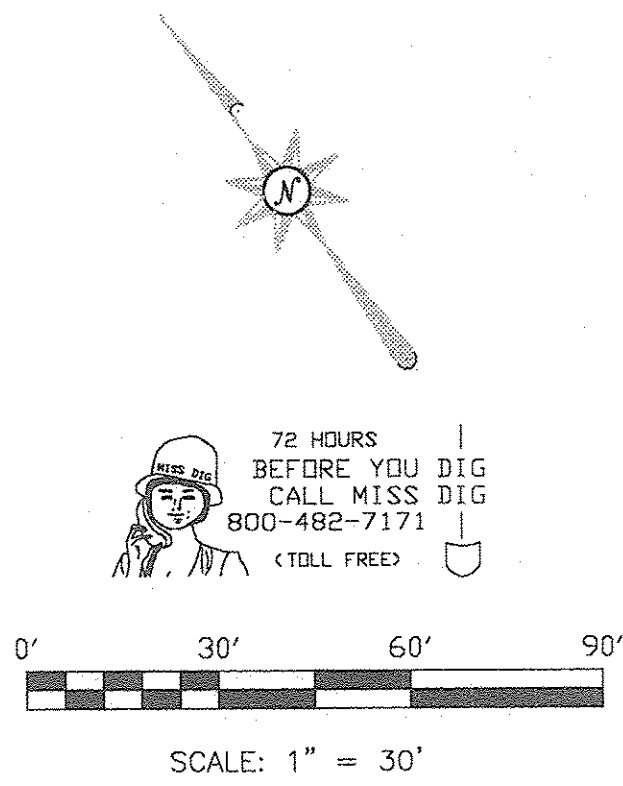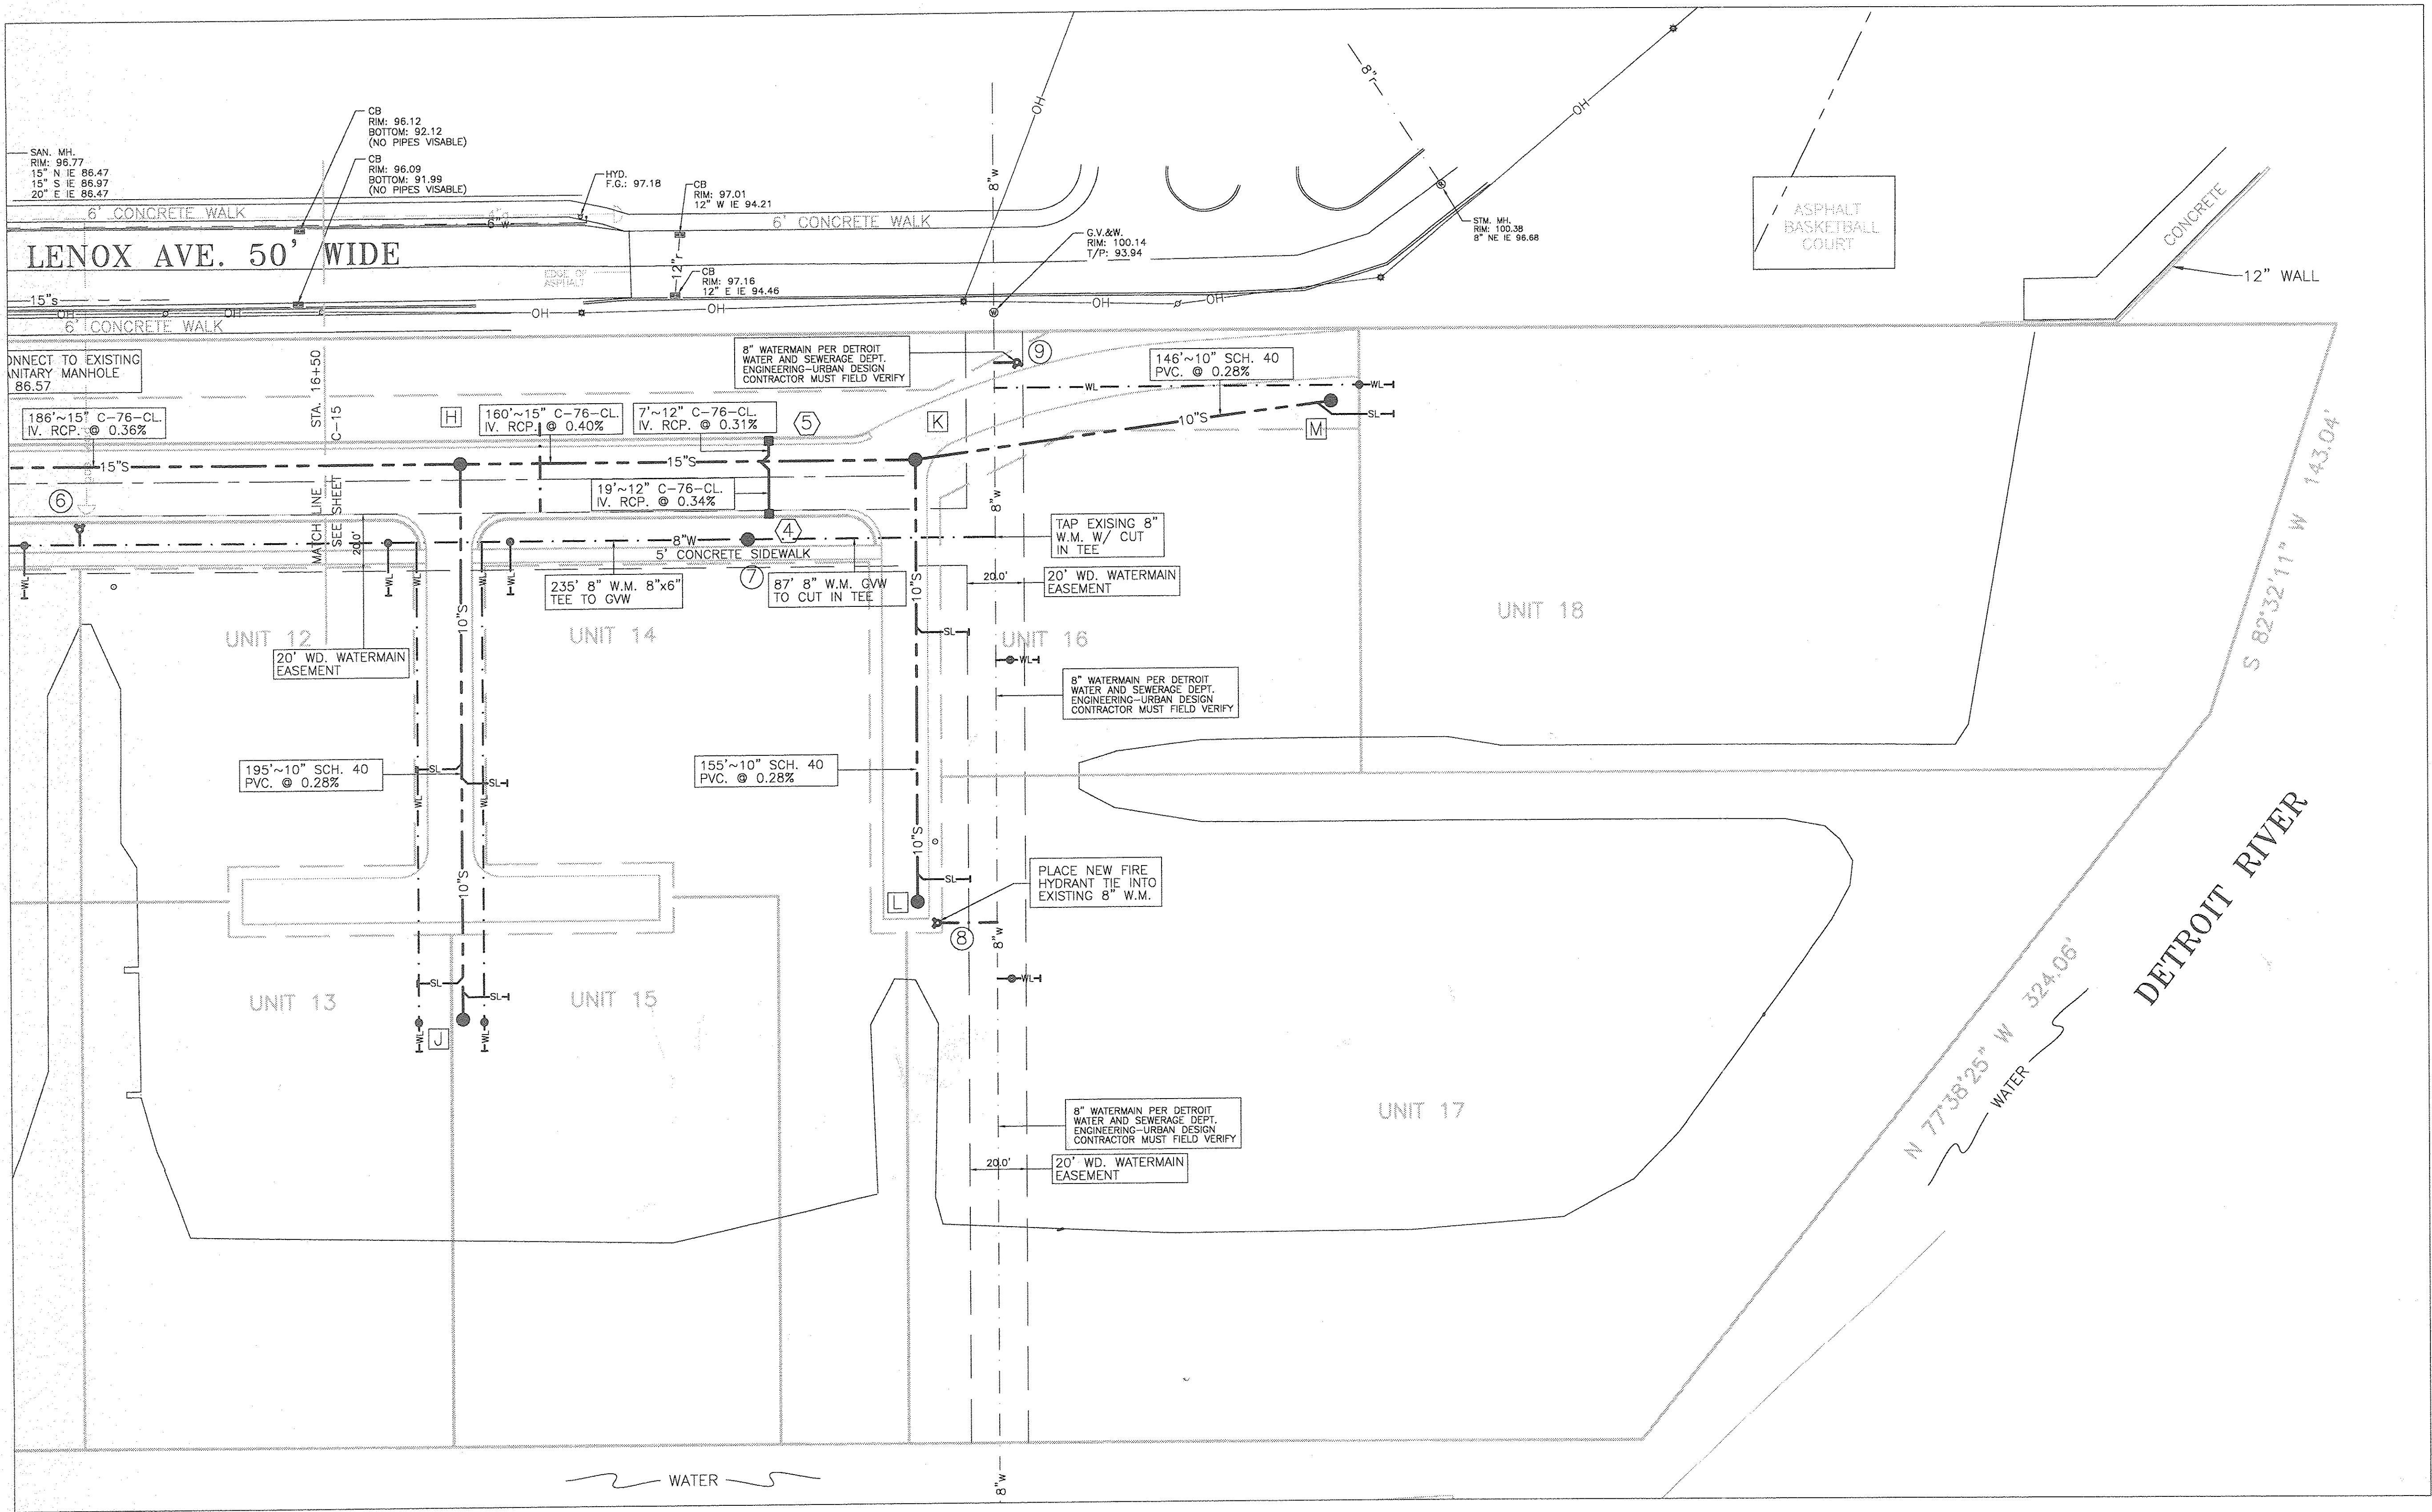

ISSUE DATE	9/1/06
	REVISIONS
CLIENT:	MORGAN DEVELOPMENT LLC
	36150 DEQUINDE
	SUITE 600
	STERLING HEIGHTS, MI 48310

9800 ANN ARBOR ROAD, WEST
PLYMOUTH, MI 48170
PHONE: (734) 416-9650
FAX: (734) 416-9657
www.glasurveyor.com

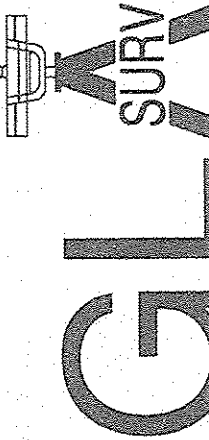GLA
SURVEYORS &
ENGINEERS

STRUCTURE LEGEND	
	SANITARY MANHOLE
	CATCH BASIN
	WATER STRUCTURE

DWSD SYSTEM ACCEPTANCE	
DESIGNED REVIEWED	DATE
HEAD ENGR-DES.	
CONSTRUCTION INSPECTED	
HEAD ENGR-FLD.	
PERMIT No.	LS#
MDNR	D JOB#
MDPH	DRWG/REF#
R/W#	SEWER
	WATER

UTILITY COMPANIES

SBC AMERITECH MICHIGAN JEFF COLLARD 100 SOUTH MAIN STREET ROOM 314 MT. CLEMENS, MI 48043-2374 (586) 466-1024	MICHIGAN CONSOLIDATED GAS ENGINEERING GROUPS MAIN REPLACEMENT TEAM NOBLE SECOND FLOOR 3200 HOBSON DETROIT, MI 45201 (313) 577-7238 (313) 577-7061 FAX	DETROIT WATER & SEWERAGE DEPARTMENT ENGINEERING GROUPS 1420 WASHINGTON BLVD. SUITE 100 DETROIT, MI 48226 (313) 964-9800 (313) 964-9810 FAX
DTE ENERGY SERVICE PLANNING HELEN LEE 2000 SECOND AVE. (518 S.B.) DETROIT, MI 48226 (313) 235-9043 (313) 235-9366 FAX	COMCAST CONSTRUCTION RUSTY KEMPER 12775 LYNDON AVENUE DETROIT, MI 48227-3982 (313) 934-2600 EXT. 440 (313) 934-5782 FAX	

GENERAL NOTES





- IN COMPLIANCE WITH PUBLIC ACT 53 OF THE STATE OF MICHIGAN (EFFECTIVE) AUGUST 1, 1974 THE CONTRACTOR SHALL NOTIFY IN ADVANCE OF CONSTRUCTION (72 HOURS/3 WORKING DAYS) ALL PUBLIC AND PRIVATE UTILITY OWNERS HAVE EXISTING FACILITIES IN OR NEAR THE IMMEDIATE WORKING AREA FOR CONVENIENCE. THE KNOWN UTILITY OWNERS ARE LISTED. THIS LISTING DOES NOT, HOWEVER RELIEVE THE CONTRACTOR OF THE RESPONSIBILITY OF VERIFYING UTILITY LOCATIONS AND NOTIFYING ALL UTILITY OWNERS AND MISS DIG. PHONE: 1-800-482-7171
- ALL WATERMAIN TO BE DUTILE IRON CLASS 56 WITH A POLYETHYLENE WRAP IN ACCORDANCE WITH DWSD STANDARDS.
- ALL WATERMAINS TO BE INSTALLED WITH A MINIMUM OF 5'-0" OF COVER.
- CONCRETE THRUST BLOCKS SHALL BE PLACED ON ALL FITTINGS.
- ALL WATERMAIN WORK IS TO BE DONE IN ACCORDANCE WITH DETROIT WATER AND SEWERAGE DEPARTMENT'S STANDARD AND SPECIFICATIONS, PERMIT AND INSPECTION.
- ROOF DOWNSPOUTS ARE NOT TO BE DIRECTLY CONNECTED TO THE SEWER SYSTEM.

WATER SERVICE NOTE

- A. SINGLE FAMILY DOMESTIC WATER SERVICE LEADS SHALL BE 1" TYPE "K" COPPER.

ISSUED FOR REVIEW ONLY		
FILE NO.: 2791	DWG.: ENG SITE PLAN	
DESIGNED BY: S.A.S.	SHEET No. C-16	
DRAWN BY: S.A.S.		
CHECKED BY: L.P.R.		
SCALE: 1" = 30'		

UTILITY PLAN 3
LENOX WATERFRONT ESTATES
LENOX AVENUE
WAYNE COUNTY, CITY OF DETROIT, MICHIGAN

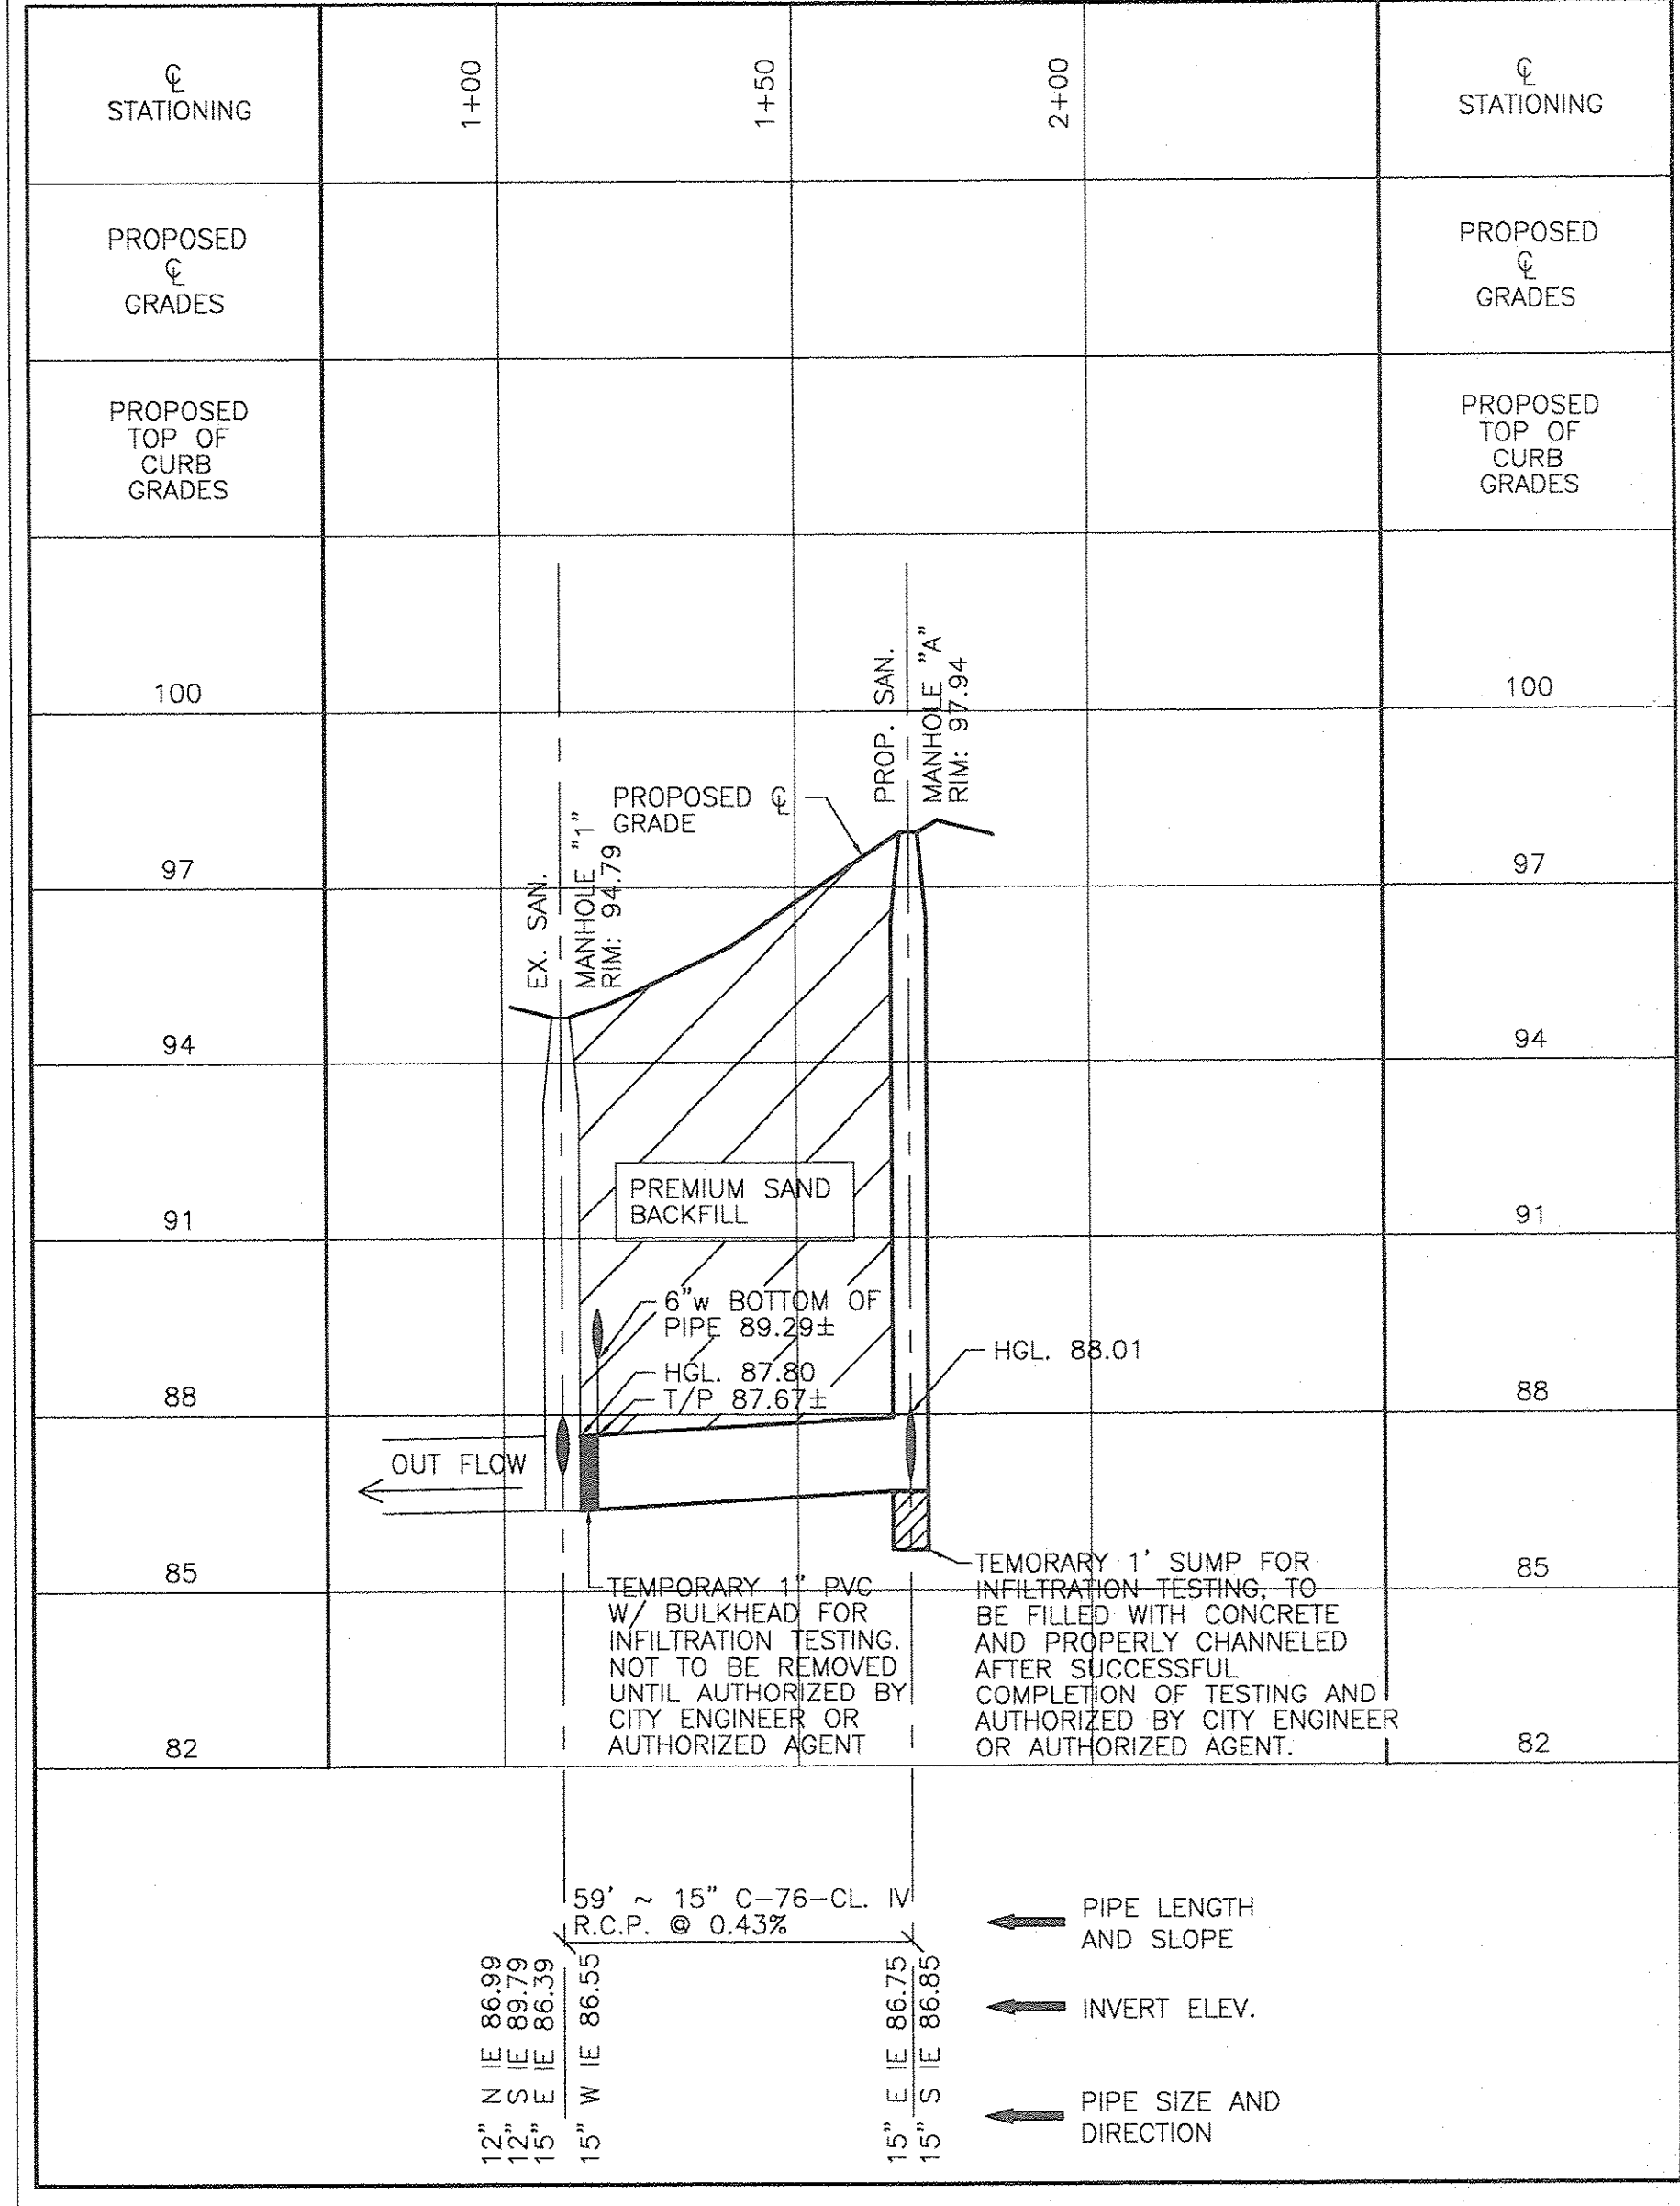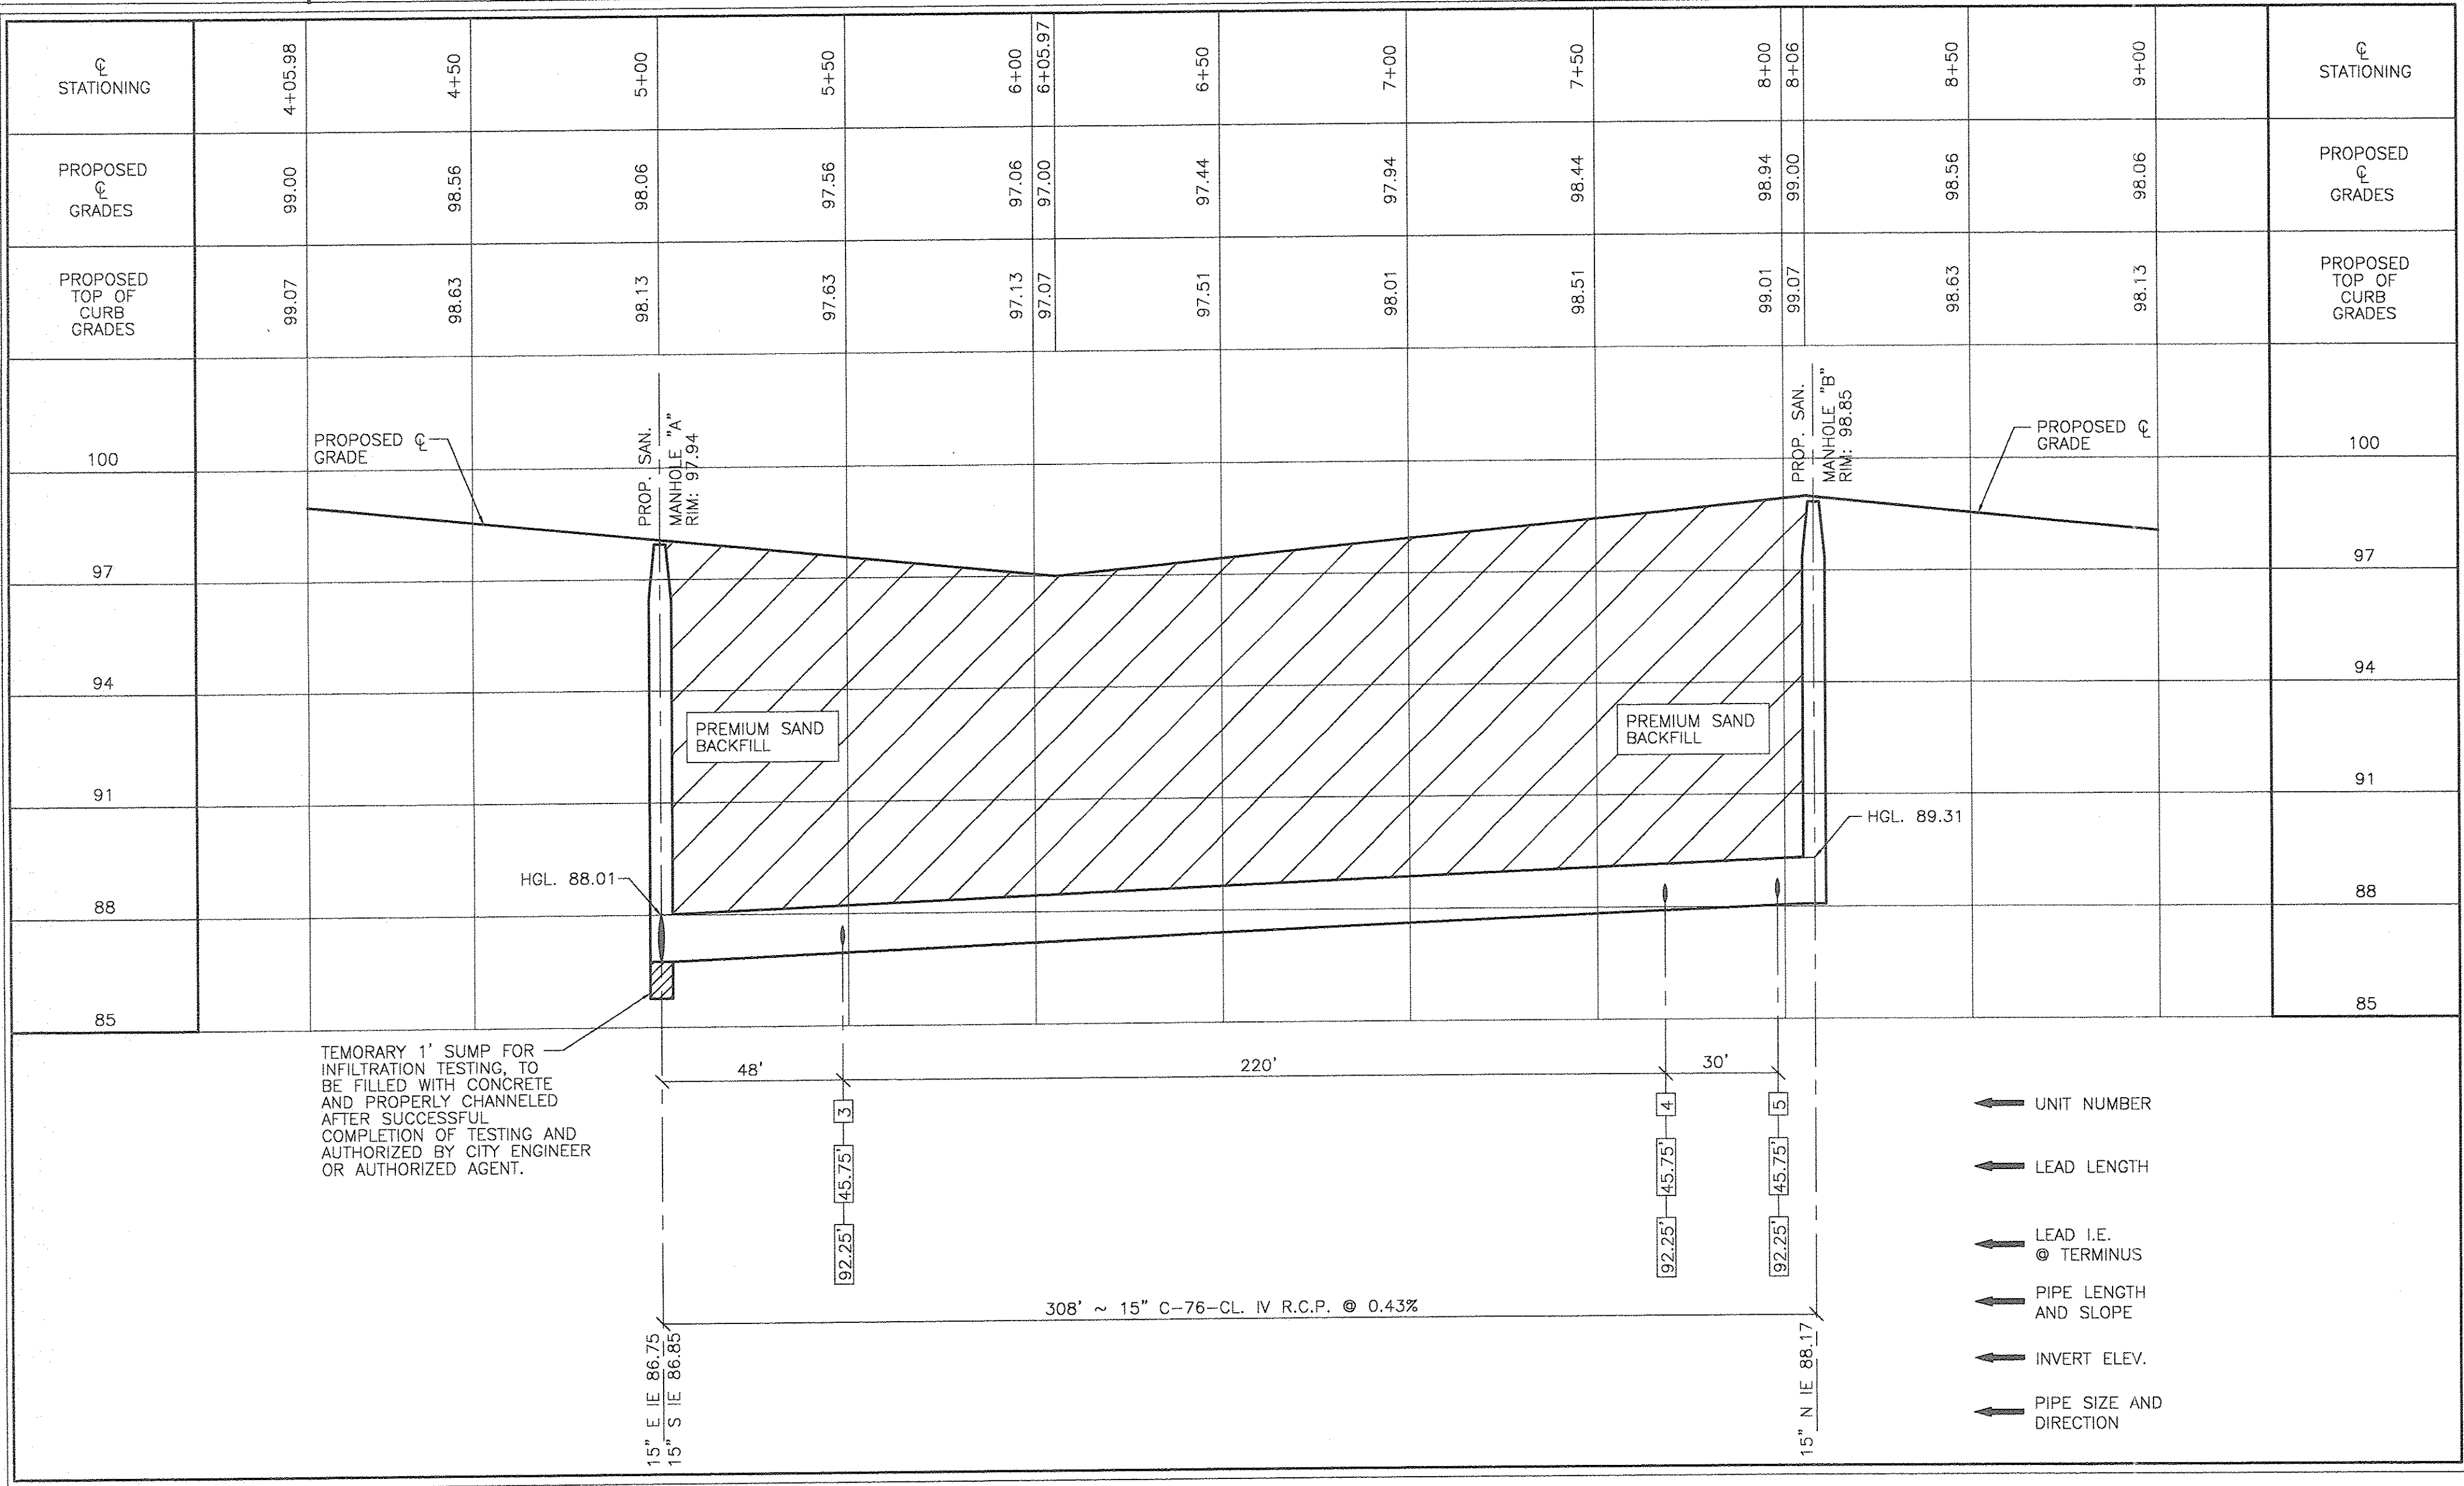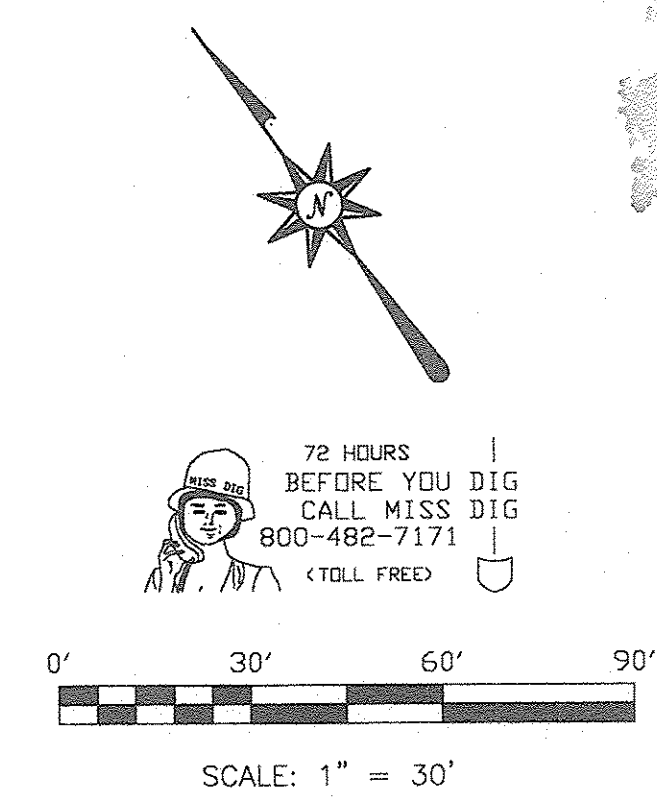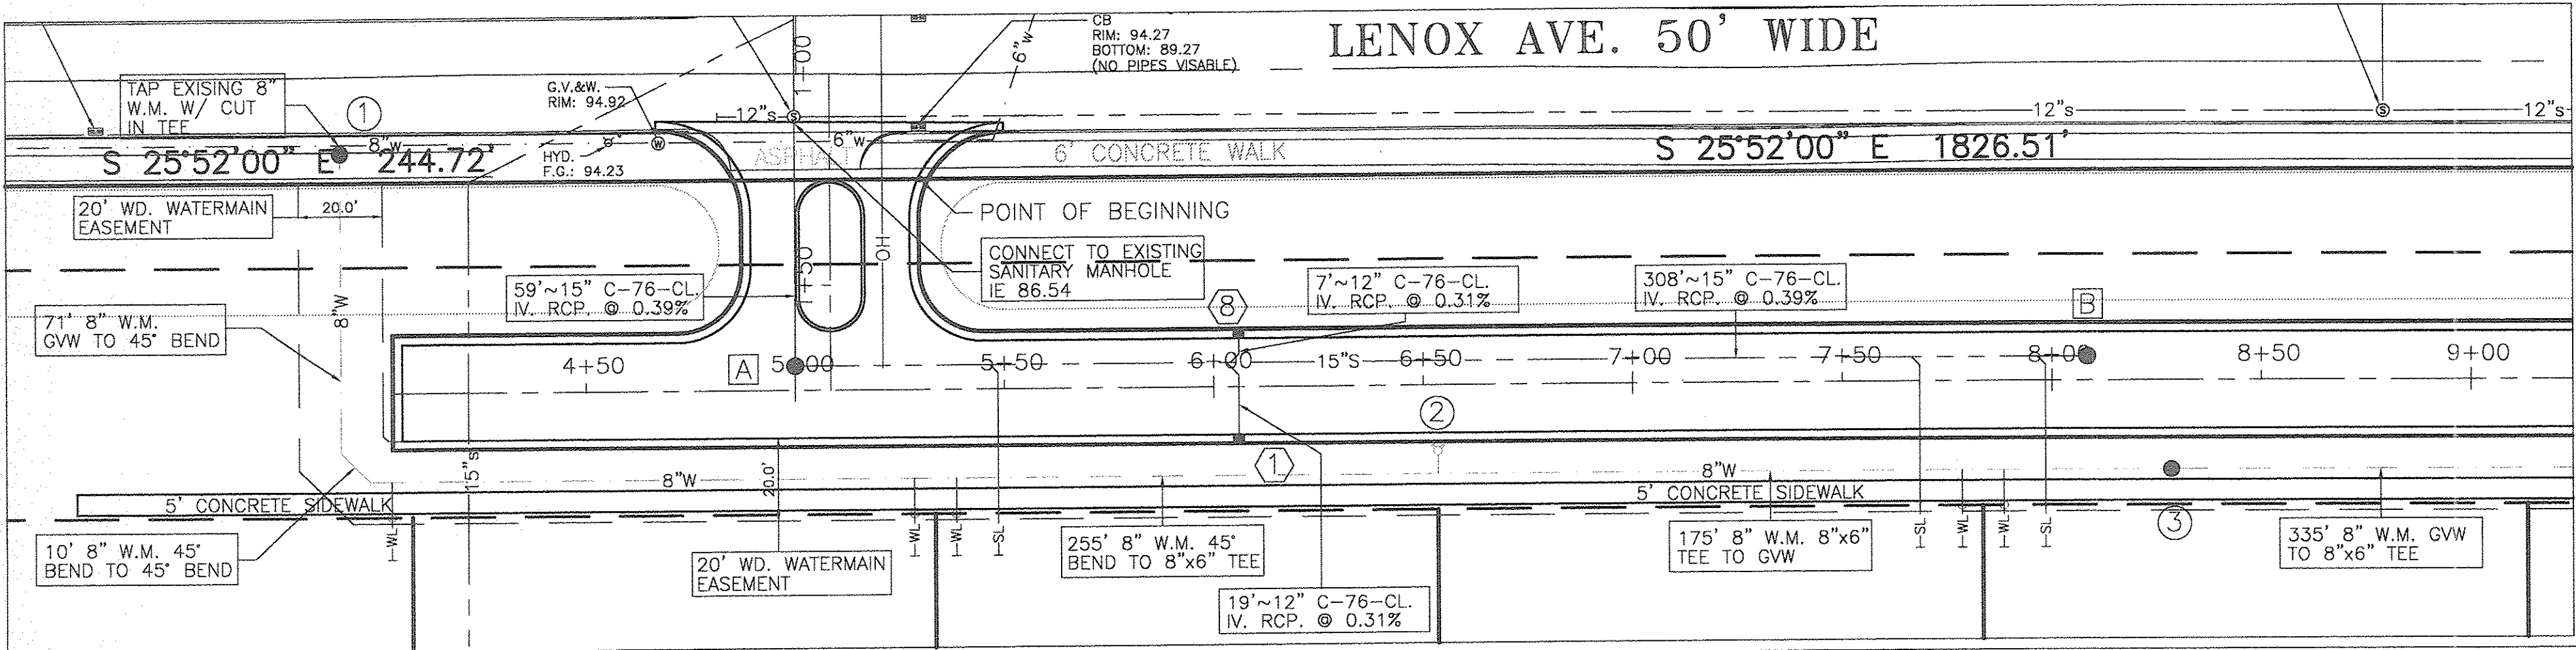

CONTRACTOR'S NOTE

CONTRACTOR MUST COMPLY WITH ALL OF THE CITY OF DETROIT NEW CONSTRUCTION REQUIREMENTS. REQUIREMENTS ARE AS PUBLISHED BY THE CITY OF DETROIT, OR AS DIRECTED BY CITY ENGINEER.

CITY OF DETROIT DEPARTMENT OF PUBLIC WORKS CITY ENGINEERING DIVISION - STANDARD SPECIFICATIONS FOR PAVING AND RELATED CONSTRUCTION. OCTOBER 1999

DETROIT WATER AND SEWERAGE DEPARTMENT - GUIDELINES FOR SEWER SYSTEM CONSTRUCTION IN THE CITY OF DETROIT, NO PUBLISHED DATE.

D.W.S.D. - STANDARD SPECIFICATIONS FOR WATER SERVICE INSTALLATION AND MAINTENANCE, JUNE 1982.

D.W.S.D. - STANDARD SPECIFICATIONS FOR WATER SYSTEM ALTERATIONS, APRIL 1980 REVISED SEPTEMBER 1983.

D.W.S.D. - STANDARD SPECIFICATIONS FOR FIRE HYDRANT ALTERATIONS, APRIL 1980, REVISED SEPTEMBER 1983.

SEWER CONSTRUCTION NOTES

LOWER WATER MAIN AS NECESSARY TO MAINTAIN 18" MINIMUM VERTICAL SEPARATION BETWEEN UTILITIES.

PREMIUM SAND BACKFILL MUST BE M.D.O.T CLASS II MATERIAL COMPACTED TO 95% MAXIMUM UNIT DENSITY.

PROPER JOINTING MATERIAL AND CARE SHALL BE USED TO PRODUCE DURABLE, WATER TIGHT JOINTS. ALL JOINT MATERIALS SHALL BE APPROVED BY CITY ENGINEER BEFORE BEING USED.

ALL GASKETS SHALL BE COMPOSED OF A SYNTHETIC TYPE RUBBER COMPOUND, SUCH AS NEOPRENE OR APPROVED EQUAL, RESISTANT TO ALKALI, ACIDS, OILS, SEWAGE AND WASTE PETROLEUM PRODUCTS. THE GASKETS SHALL COMPLY WITH THE APPLICABLE REQUIREMENTS OF EITHER A.S.T.M. C 443M OR A.S.T.M. C361.

SANITARY SEWER BASIS OF DESIGN

TOTAL # OF UNITS = 18
3.5 PERSONS x UNITS = 3.5 x 18 = 63 PERSONS
AVERAGE FLOW 100 GPD. x 63 = 6300 GPD.
PEAK FLOW $18 + \sqrt{0.063} = 4.81$
 $4 + \sqrt{0.063} = 4.81$
6300 x 4.81 = 30303 GPD.
30303 / 1440 = 21.04 GPM.
= 0.0469 CFS.

STORM SEWER CALCULATIONS

SEE STORM SEWER COMPUTATION DATA FOR COMPLETE HYDROLOGIC DATA.
SHEET C-26

UTILITY NOTE

UNDERGROUND UTILITY LINES AND STRUCTURES SHOWN ARE PER RECORDS MADE AVAILABLE BY UTILITY OR MUNICIPALITY, AND BY FIELD OBSERVATION WHERE POSSIBLE. ALL MUNICIPALITIES AND UTILITY COMPANIES SHOULD BE NOTIFIED BY CONTRACTOR FOR FIELD LOCATION OF ALL UTILITIES PRIOR TO CONSTRUCTION.

PROFILE SCALE

HORIZONTAL: 1" = 30'
VERTICAL: 1" = 3'

ISSUED FOR REVIEW ONLY		
FILE NO.: 2791		DWG.: ENG SITE PLAN
DESIGNED BY: S.A.S.		SHEET No. C-17
DRAWN BY: S.A.S.		
CHECKED BY: L.P.R.		
SCALE: 1" = 30'		

CLIENT:
MORGAN DEVELOPMENT LLC
36150 DEQUINDRE
SUITE 600
STERLING HEIGHTS, MI 48310

9/1/06

ISSUE DATE

REVISIONS




9800 ANN ARBOR ROAD, WEST
PLYMOUTH, MI 48170
GLA SURVEYORS & ENGINEERS
PHONE: (734) 416-9650
FAX: (734) 416-9657
www.glasurveyor.com

PLAN & PROFILE 1

LENOX WATERFRONT ESTATES

LENOX AVENUE

WAYNE COUNTY, CITY OF DETROIT, MICHIGAN

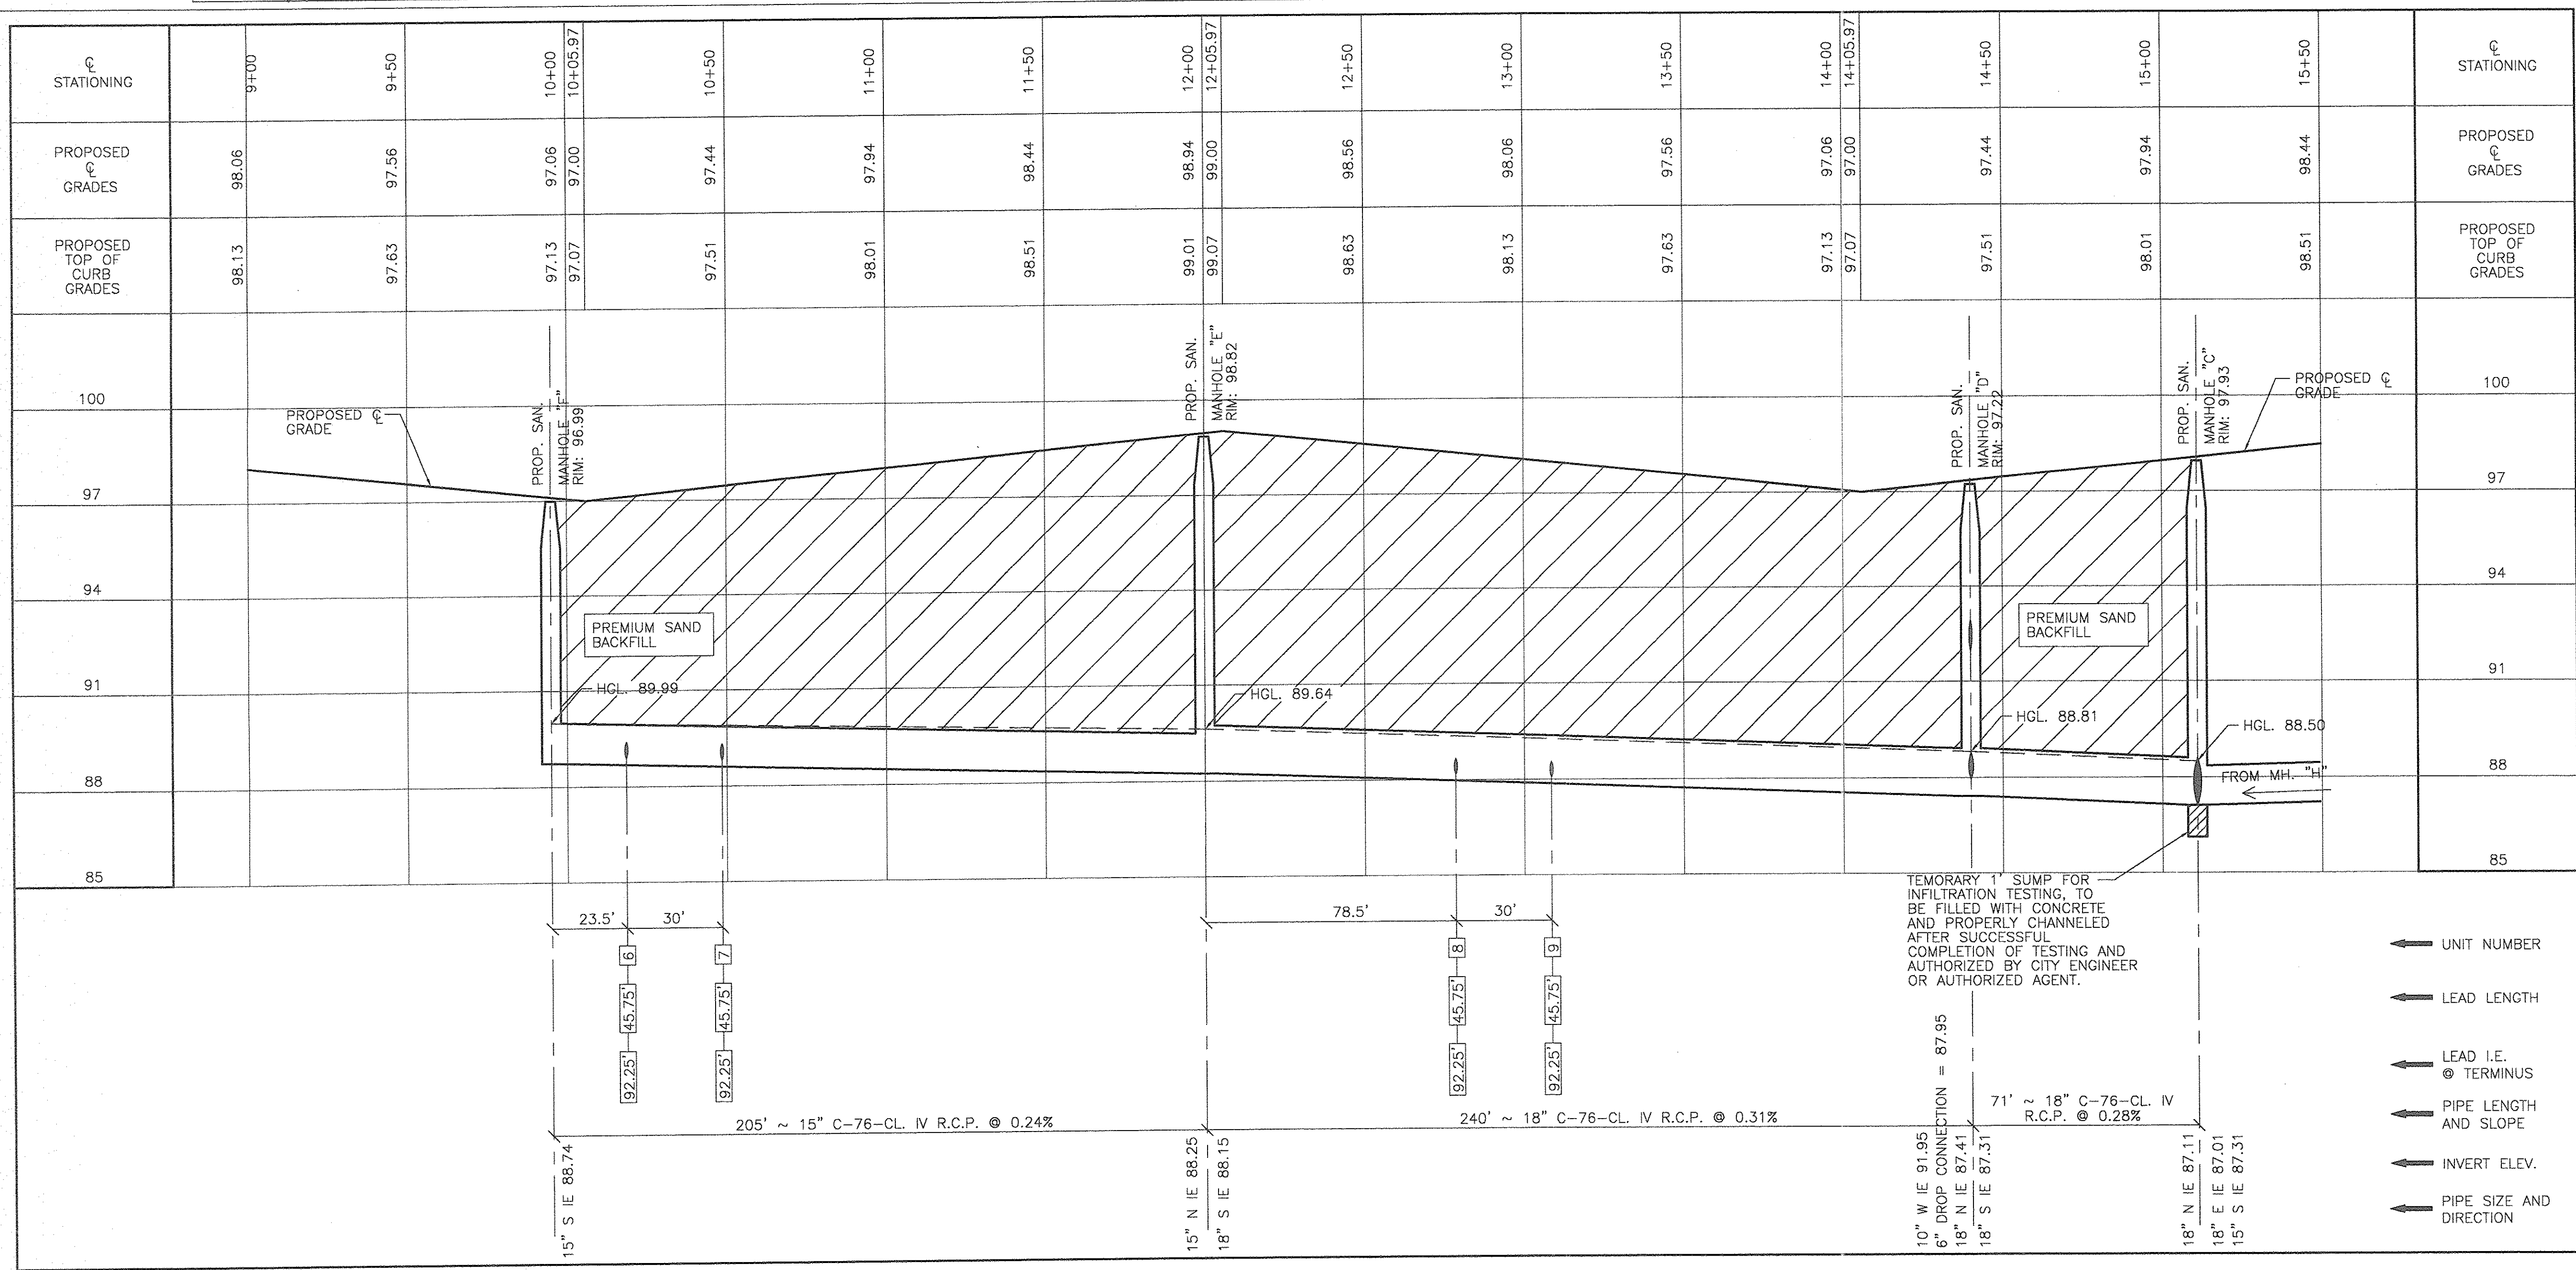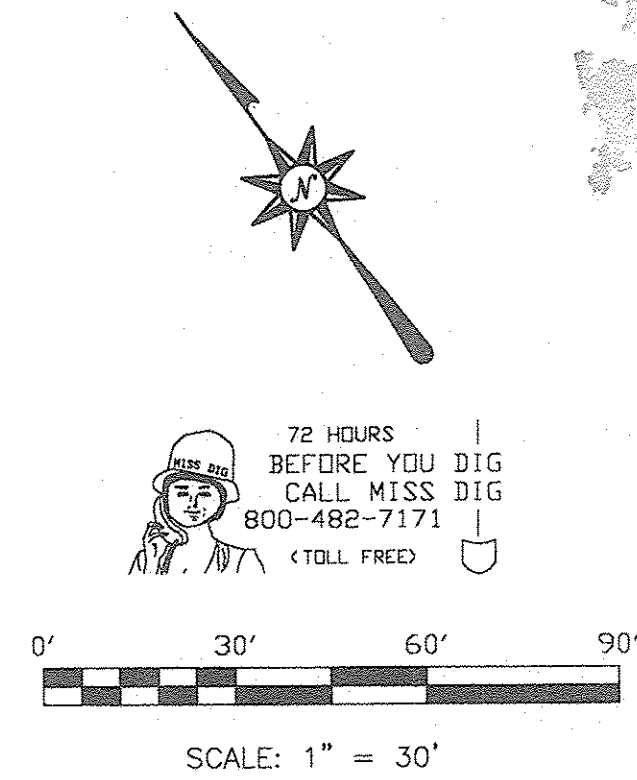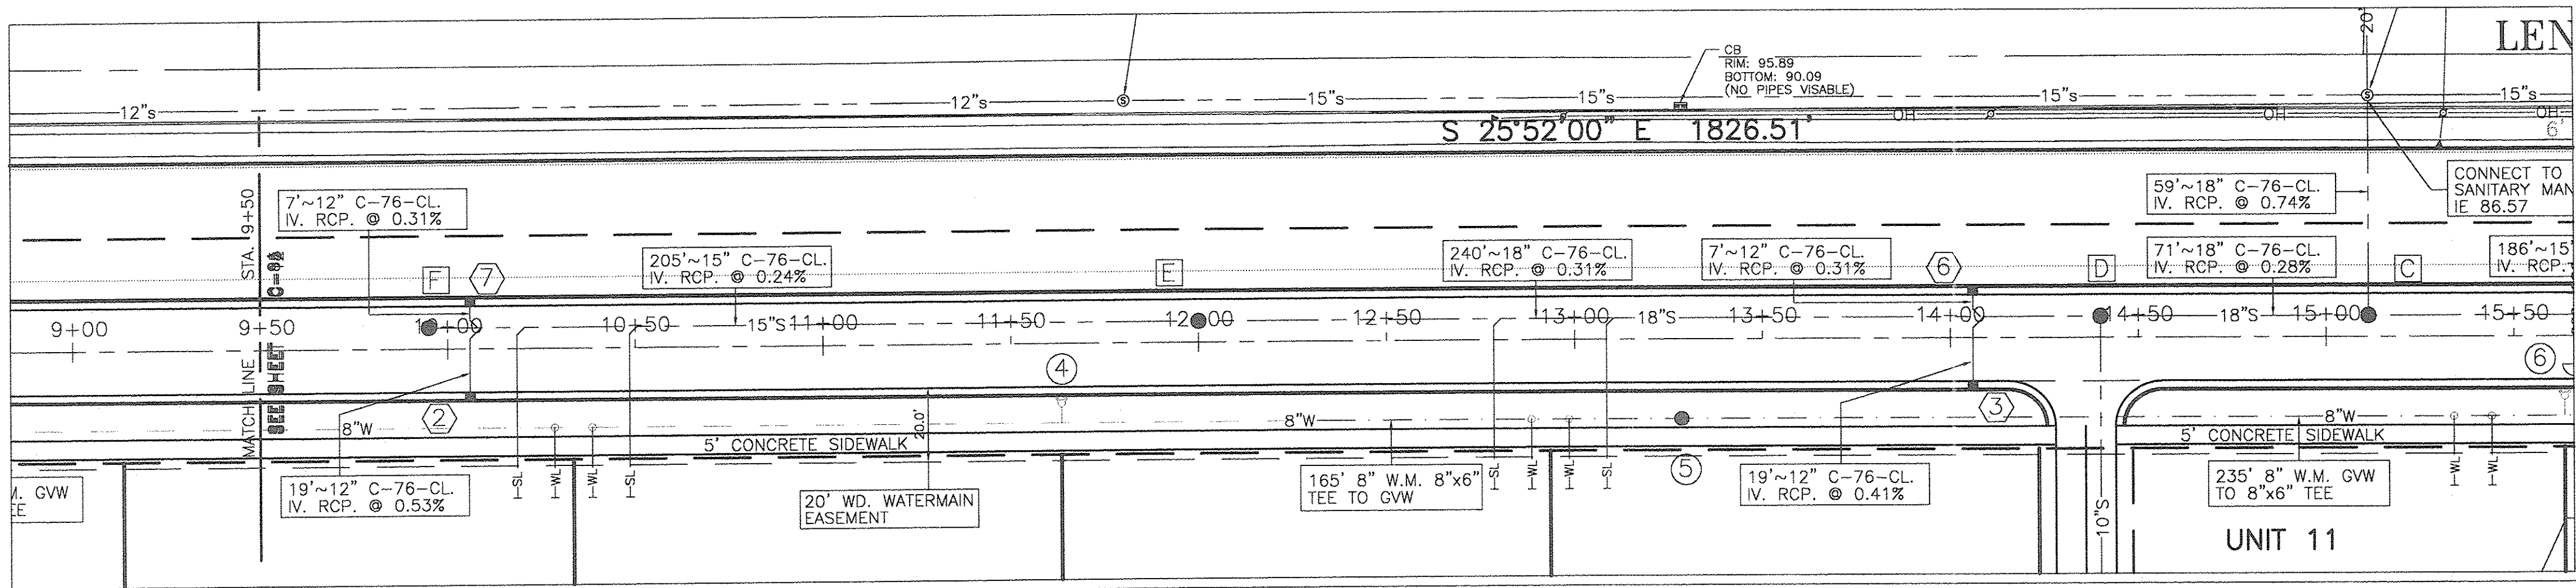

CONTRACTOR'S NOTE

CONTRACTOR MUST COMPLY WITH ALL OF THE CITY OF DETROIT NEW CONSTRUCTION REQUIREMENTS. REQUIREMENTS ARE AS PUBLISHED BY THE CITY OF DETROIT, OR AS DIRECTED BY CITY ENGINEER.

CITY OF DETROIT DEPARTMENT OF PUBLIC WORKS CITY ENGINEERING DIVISION - STANDARD SPECIFICATIONS FOR PAVING AND RELATED CONSTRUCTION. OCTOBER 1999

DETROIT WATER AND SEWERAGE DEPARTMENT - GUIDELINES FOR SEWER SYSTEM CONSTRUCTION IN THE CITY OF DETROIT, NO PUBLISHED DATE.

D.W.S.D. - STANDARD SPECIFICATIONS FOR WATER SERVICE INSTALLATION AND MAINTENANCE, JUNE 1982.

D.W.S.D. - STANDARD SPECIFICATIONS FOR WATER SYSTEM ALTERATIONS, APRIL 1980 REVISED SEPTEMBER 1983.

D.W.S.D. - STANDARD SPECIFICATIONS FOR FIRE HYDRANT ALTERATIONS, APRIL 1980, REVISED SEPTEMBER 1983.

SEWER CONSTRUCTION NOTES

LOWER WATER MAIN AS NECESSARY TO MAINTAIN 18" MINIMUM VERTICAL SEPARATION BETWEEN UTILITIES.

PREMIUM SAND BACKFILL MUST BE M.D.O.T CLASS II MATERIAL COMPACTED TO 95% MAXIMUM UNIT DENSITY.

PROPER JOINTING MATERIAL AND CARE SHALL BE USED TO PRODUCE DURABLE, WATER TIGHT JOINTS. ALL JOINT MATERIALS SHALL BE APPROVED BY CITY ENGINEER BEFORE BEING USED.

ALL GASKETS SHALL BE COMPOSED OF A SYNTHETIC TYPE RUBBER COMPOUND, SUCH AS NEOPRENE OR APPROVED EQUAL, RESISTANT TO ALKALI, ACIDS, OILS, SEWAGE AND WASTE PETROLEUM PRODUCTS. THE GASKETS SHALL COMPLY WITH THE APPLICABLE REQUIREMENTS OF EITHER A.S.T.M. C 443M OR A.S.T.M. C361.

SANITARY SEWER BASIS OF DESIGN

TOTAL # OF UNITS = 18
3.5 PERSONS x UNITS = 3.5 x 18 = 63 PERSONS
AVERAGE FLOW 100 GPD. x 63 = 6300 GPD.
PEAK FLOW $18 + \sqrt{0.063} = 4.81$
 $4 + \sqrt{0.063} = 4.81$

$6300 \times 4.81 = 30303$ GPD.
 $30303 / 1440 = 21.04$ GPM.
 $= 0.0469$ CFS.

STORM SEWER CALCULATIONS

SEE STORM SEWER COMPUTATION DATA FOR COMPLETE HYDROLOGIC DATA.
SHEET C-26

UTILITY NOTE

UNDERGROUND UTILITY LINES AND STRUCTURES SHOWN ARE PER RECORDS MADE AVAILABLE BY UTILITY OR MUNICIPALITY, AND BY FIELD OBSERVATION WHERE POSSIBLE. ALL MUNICIPALITIES AND UTILITY COMPANIES SHOULD BE NOTIFIED BY CONTRACTOR FOR FIELD LOCATION OF ALL UTILITIES PRIOR TO CONSTRUCTION.

PROFILE SCALE

HORIZONTAL: 1" = 30'
VERTICAL: 1" = 3'

PLAN & PROFILE 2 LENOX WATERFRONT ESTATES

LENOX AVENUE

WAYNE COUNTY, CITY OF DETROIT, MICHIGAN


GLA SURVEYORS & ENGINEERS
9800 ANN ARBOR ROAD, WEST
PLYMOUTH, MI 48170
PHONE: (734) 416-9650
FAX: (734) 416-9657
www.glsurveyor.com

CLIENT: MORGAN DEVELOPMENT LLC
36150 DEQUINDRE
SUITE 600
STERLING HEIGHTS, MI 48310

ISSUE DATE: 9/1/06

REVISIONS:

ISSUED FOR REVIEW ONLY		
FILE NO.: 2791	DWG.: ENG SITE PLAN	
DESIGNED BY: S.A.S.	SHEET No. C-18	
DRAWN BY: S.A.S.		
CHECKED BY: L.P.R.		
SCALE: 1" = 30'		

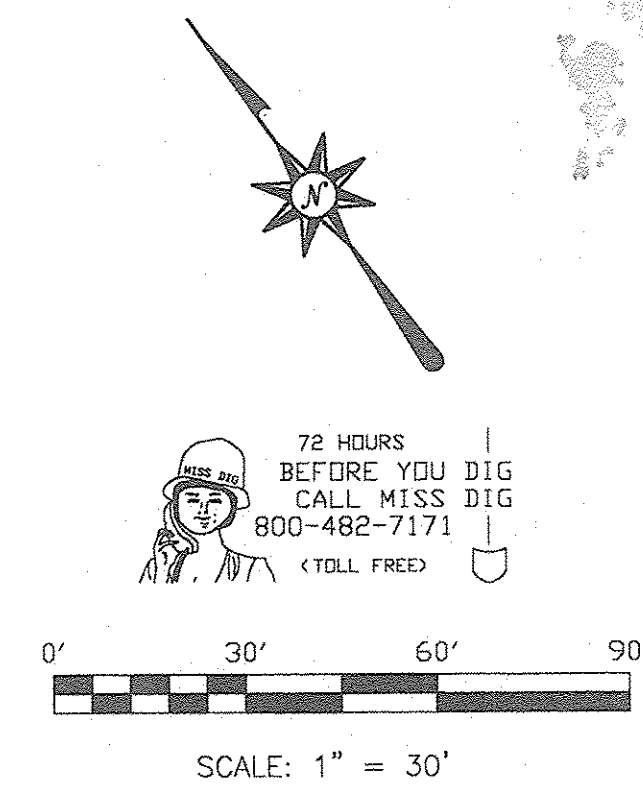

CLIENT:	ISSUE DATE	9/1/06
MORGAN DEVELOPMENT LLC	REVISIONS	
36150 DEQUINDRE		
SUITE 600		
STERLING HEIGHTS, MI 48310		

 **GLA** SURVEYORS & ENGINEERS

9800 ANN ARBOR ROAD, WEST
PLYMOUTH, MI 48170

PHONE: (734) 416-9850
FAX: (734) 416-9657
www.glsurveyor.com

PLAN & PROFILE 3
LENOX WATERFRONT ESTATES
 LENOX AVENUE
 WAYNE COUNTY, CITY OF DETROIT, MICHIGAN

D.W.S.D. - STANDARD SPECIFICATIONS FOR FIRE
HYDRANT ALTERATIONS, APRIL 1980, REVISED SEPTEMBER
1983.




ALL GASKETS SHALL BE COMPOSED OF A SYNTHETIC TYPE RUBBER COMPOUND, SUCH AS NEOPRENE OR APPROVED EQUAL, RESISTANT TO ALKALI, ACIDS, OILS, SEWAGE AND WASTE PETROLEUM PRODUCTS. THE GASKETS SHALL COMPLY WITH THE APPLICABLE REQUIREMENTS OF EITHER A.S.T.M. C 443M OR A.S.T.M. C361.

TOTAL # OF UNITS = 18
3.5 PERSONS x UNITS = 3.5 x 18 = 63 PERSONS
AVERAGE FLOW 100 GPD. x 63 = 6300 GPD.
PEAK FLOW $\frac{18 + \sqrt{0.063}}{4 + \sqrt{0.063}} = 4.81$



SEE STORM SEWER COMPUTATION DATA FOR COMPLETE
HYDROLOGIC DATA.
SHEET C-26

UNDERGROUND UTILITY LINES AND STRUCTURES SHOWN ARE PER RECORDS MADE AVAILABLE BY UTILITY OR MUNICIPALITY, AND BY FIELD OBSERVATION WHERE POSSIBLE. ALL MUNICIPALITIES AND UTILITY COMPANIES SHOULD BE NOTIFIED BY CONTRACTOR FOR FIELD LOCATION OF ALL UTILITIES PRIOR TO CONSTRUCTION.

HORIZONTAL: $1'' = 30'$
VERTICAL: $1'' = 3'$

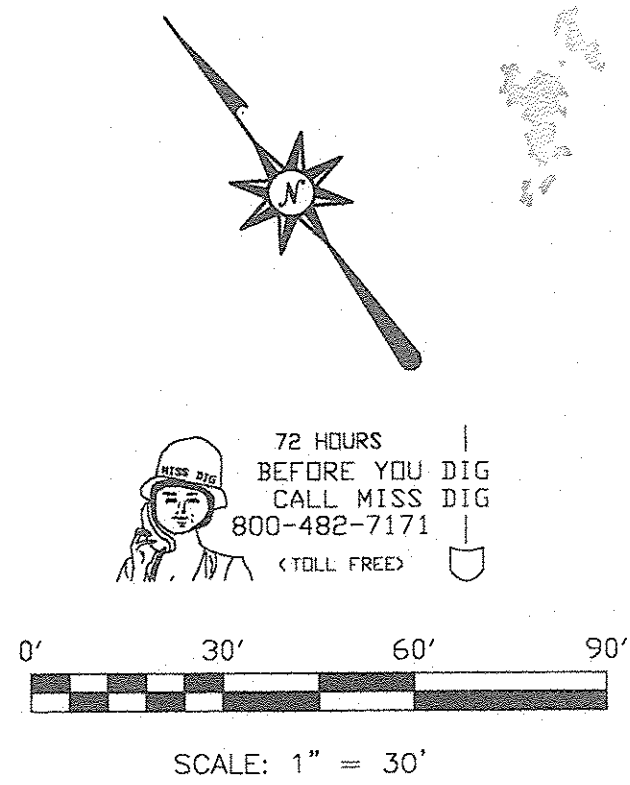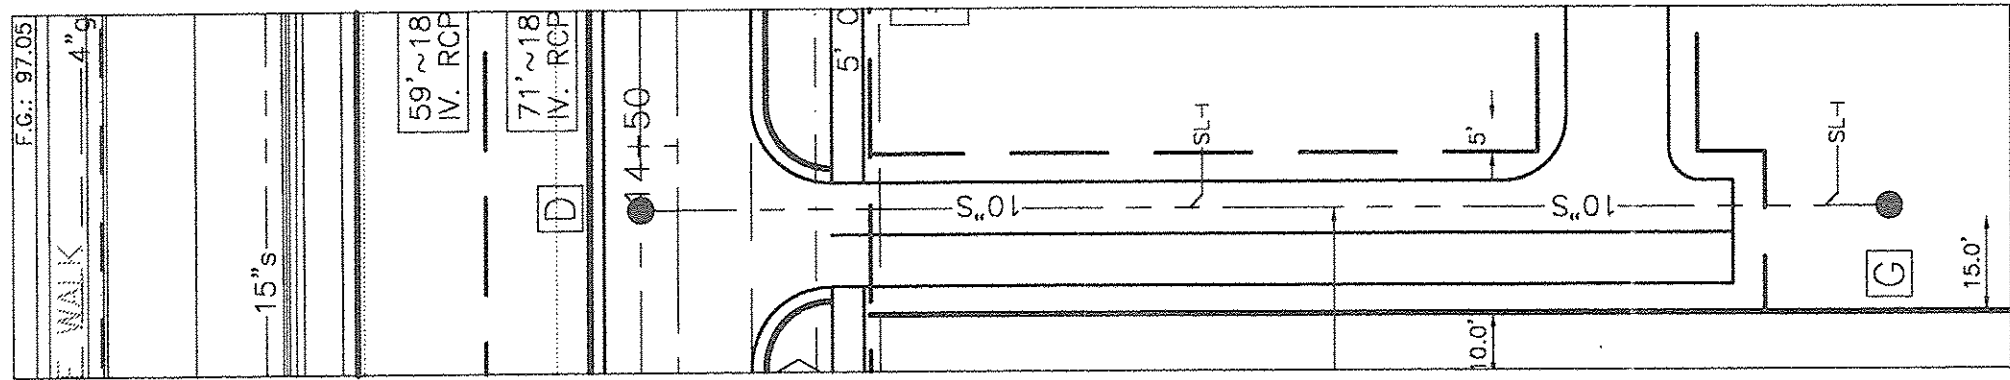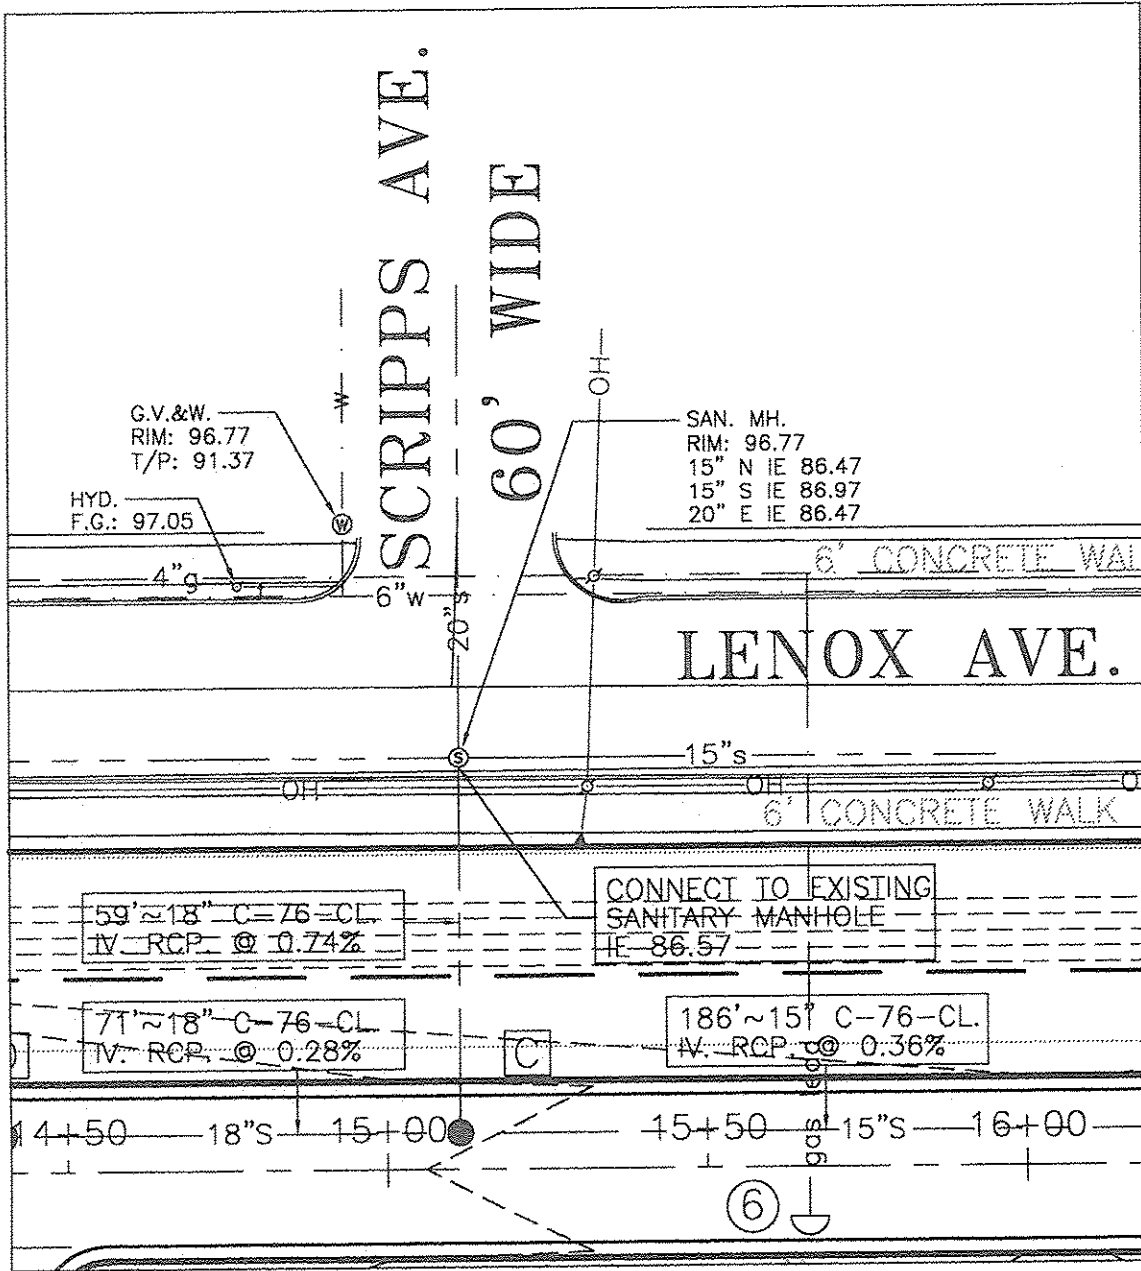

CLIENT:	ISSUE DATE	9/1/06
	REVISIONS	
MORGAN DEVELOPMENT LLC		
36150 DEQUINDRE		
SUITE 600		
STERLING HEIGHTS, MI 48310		

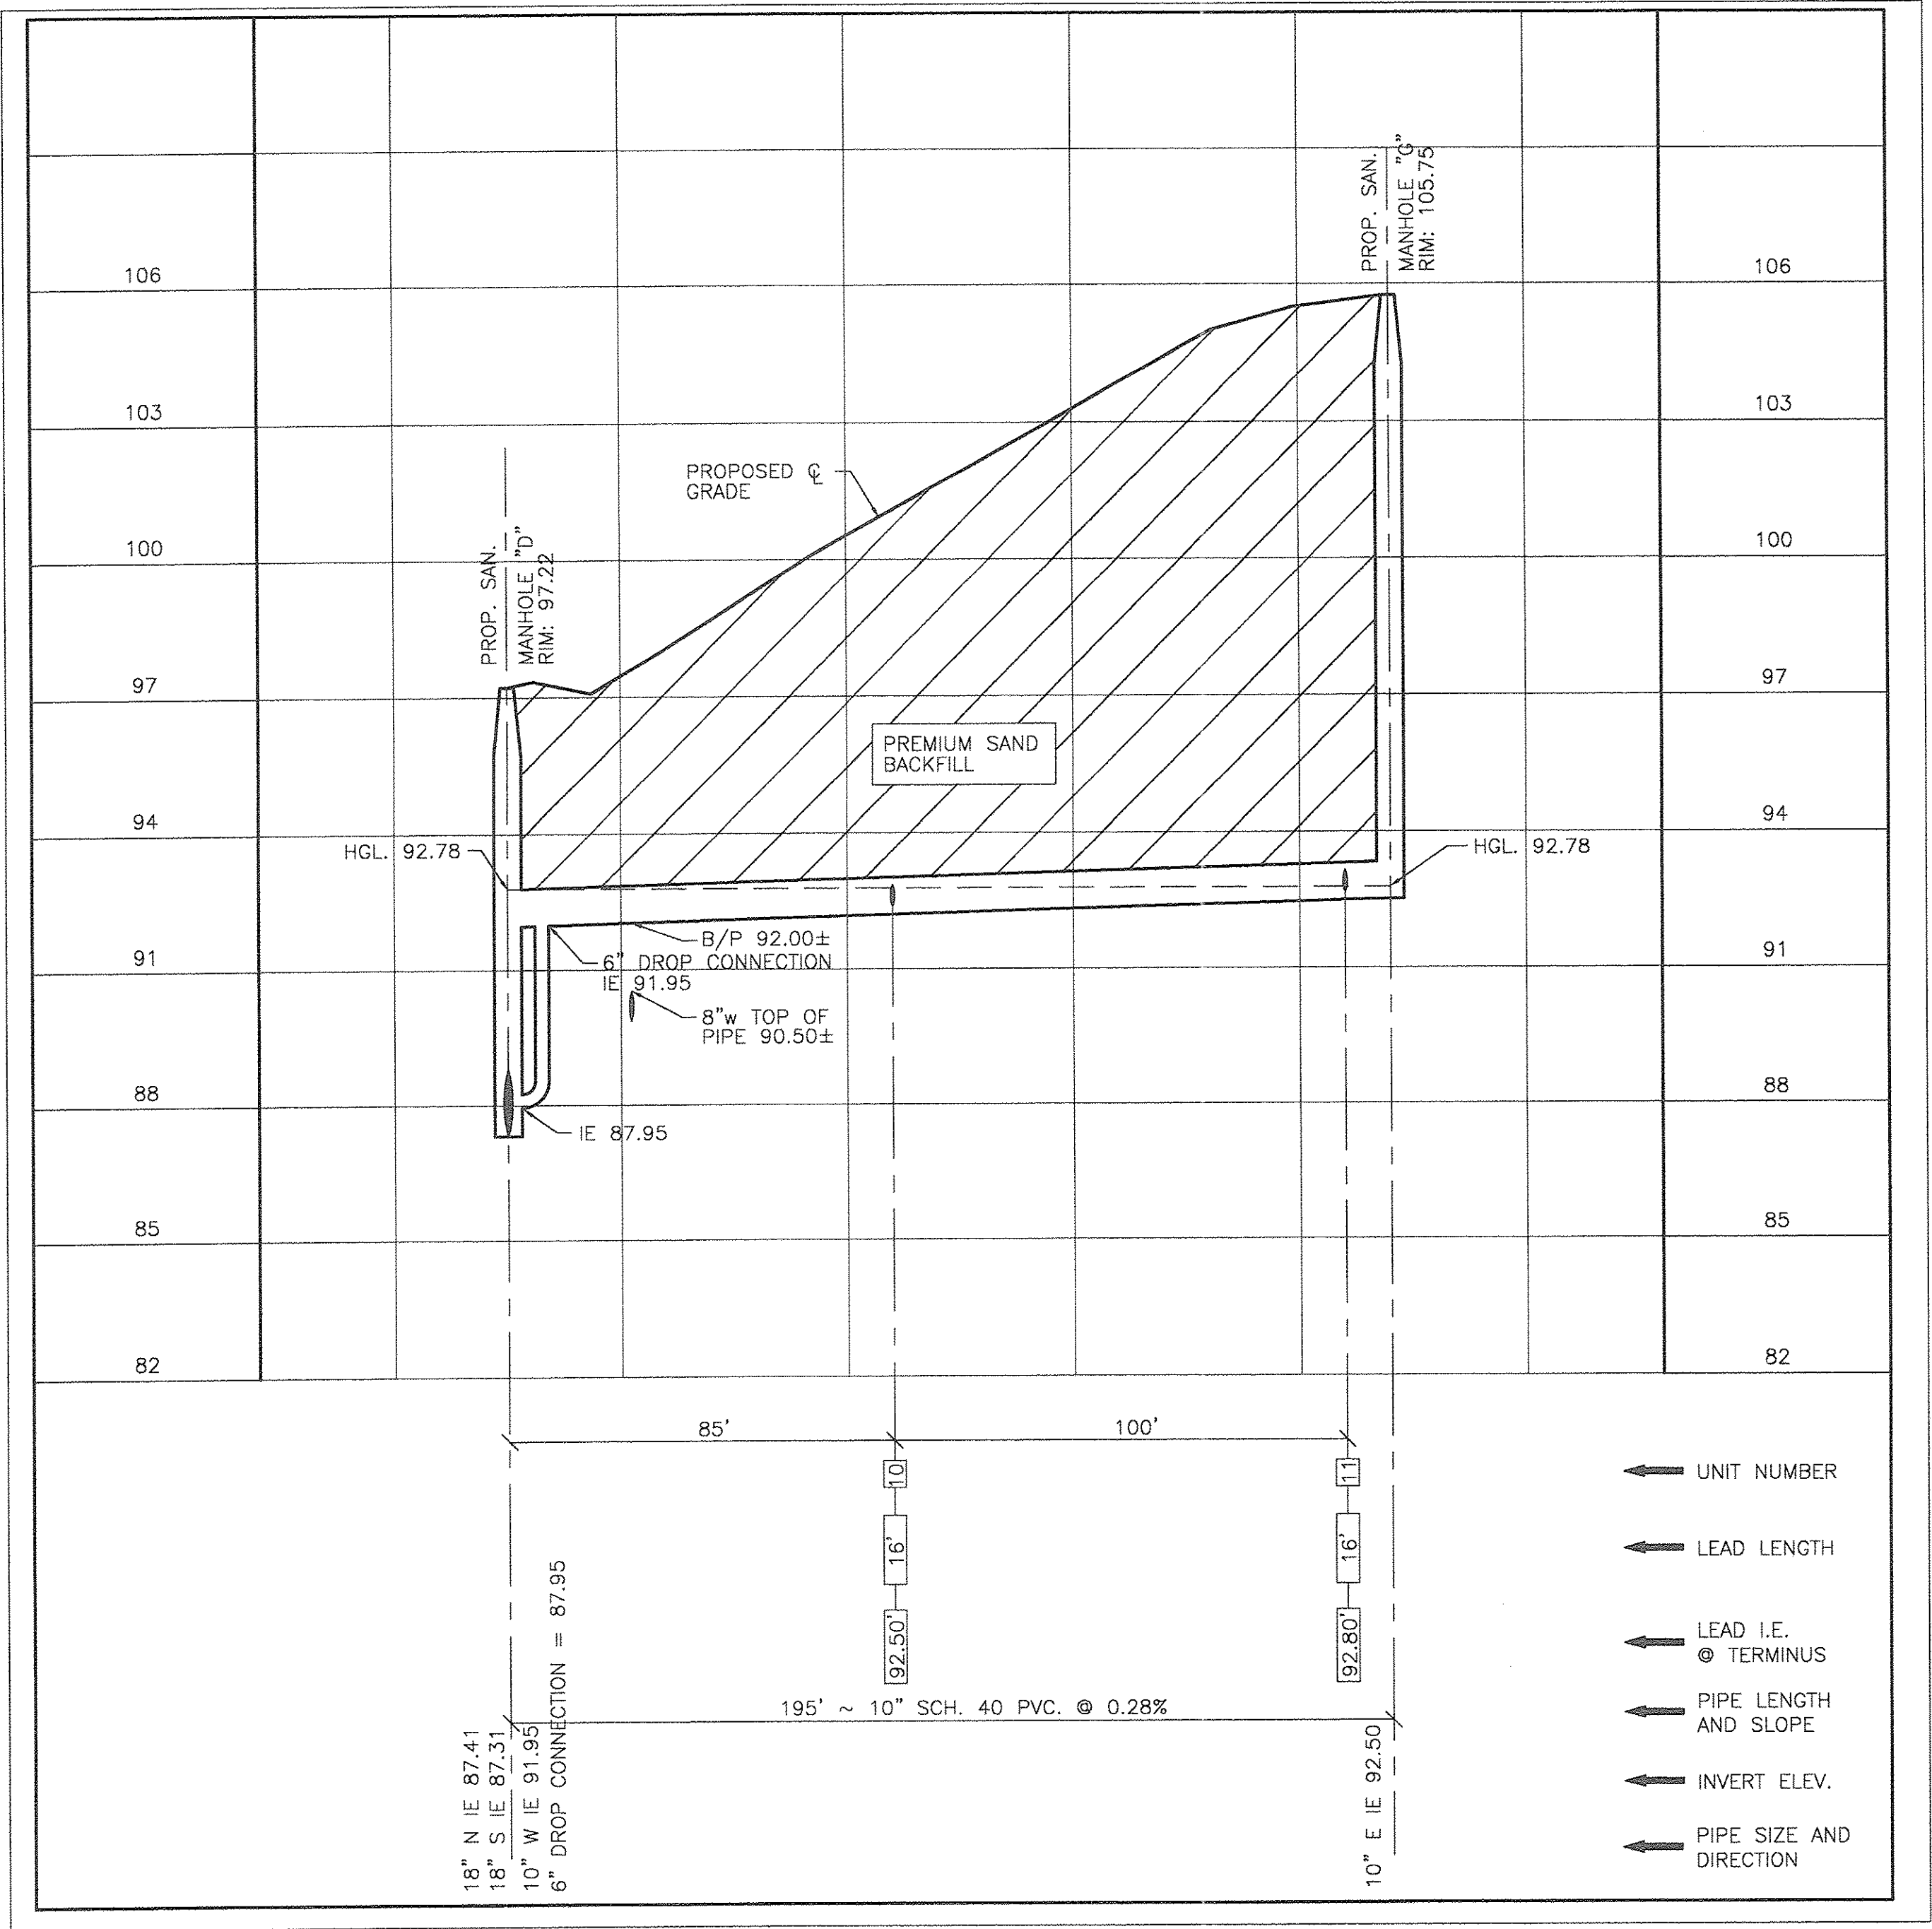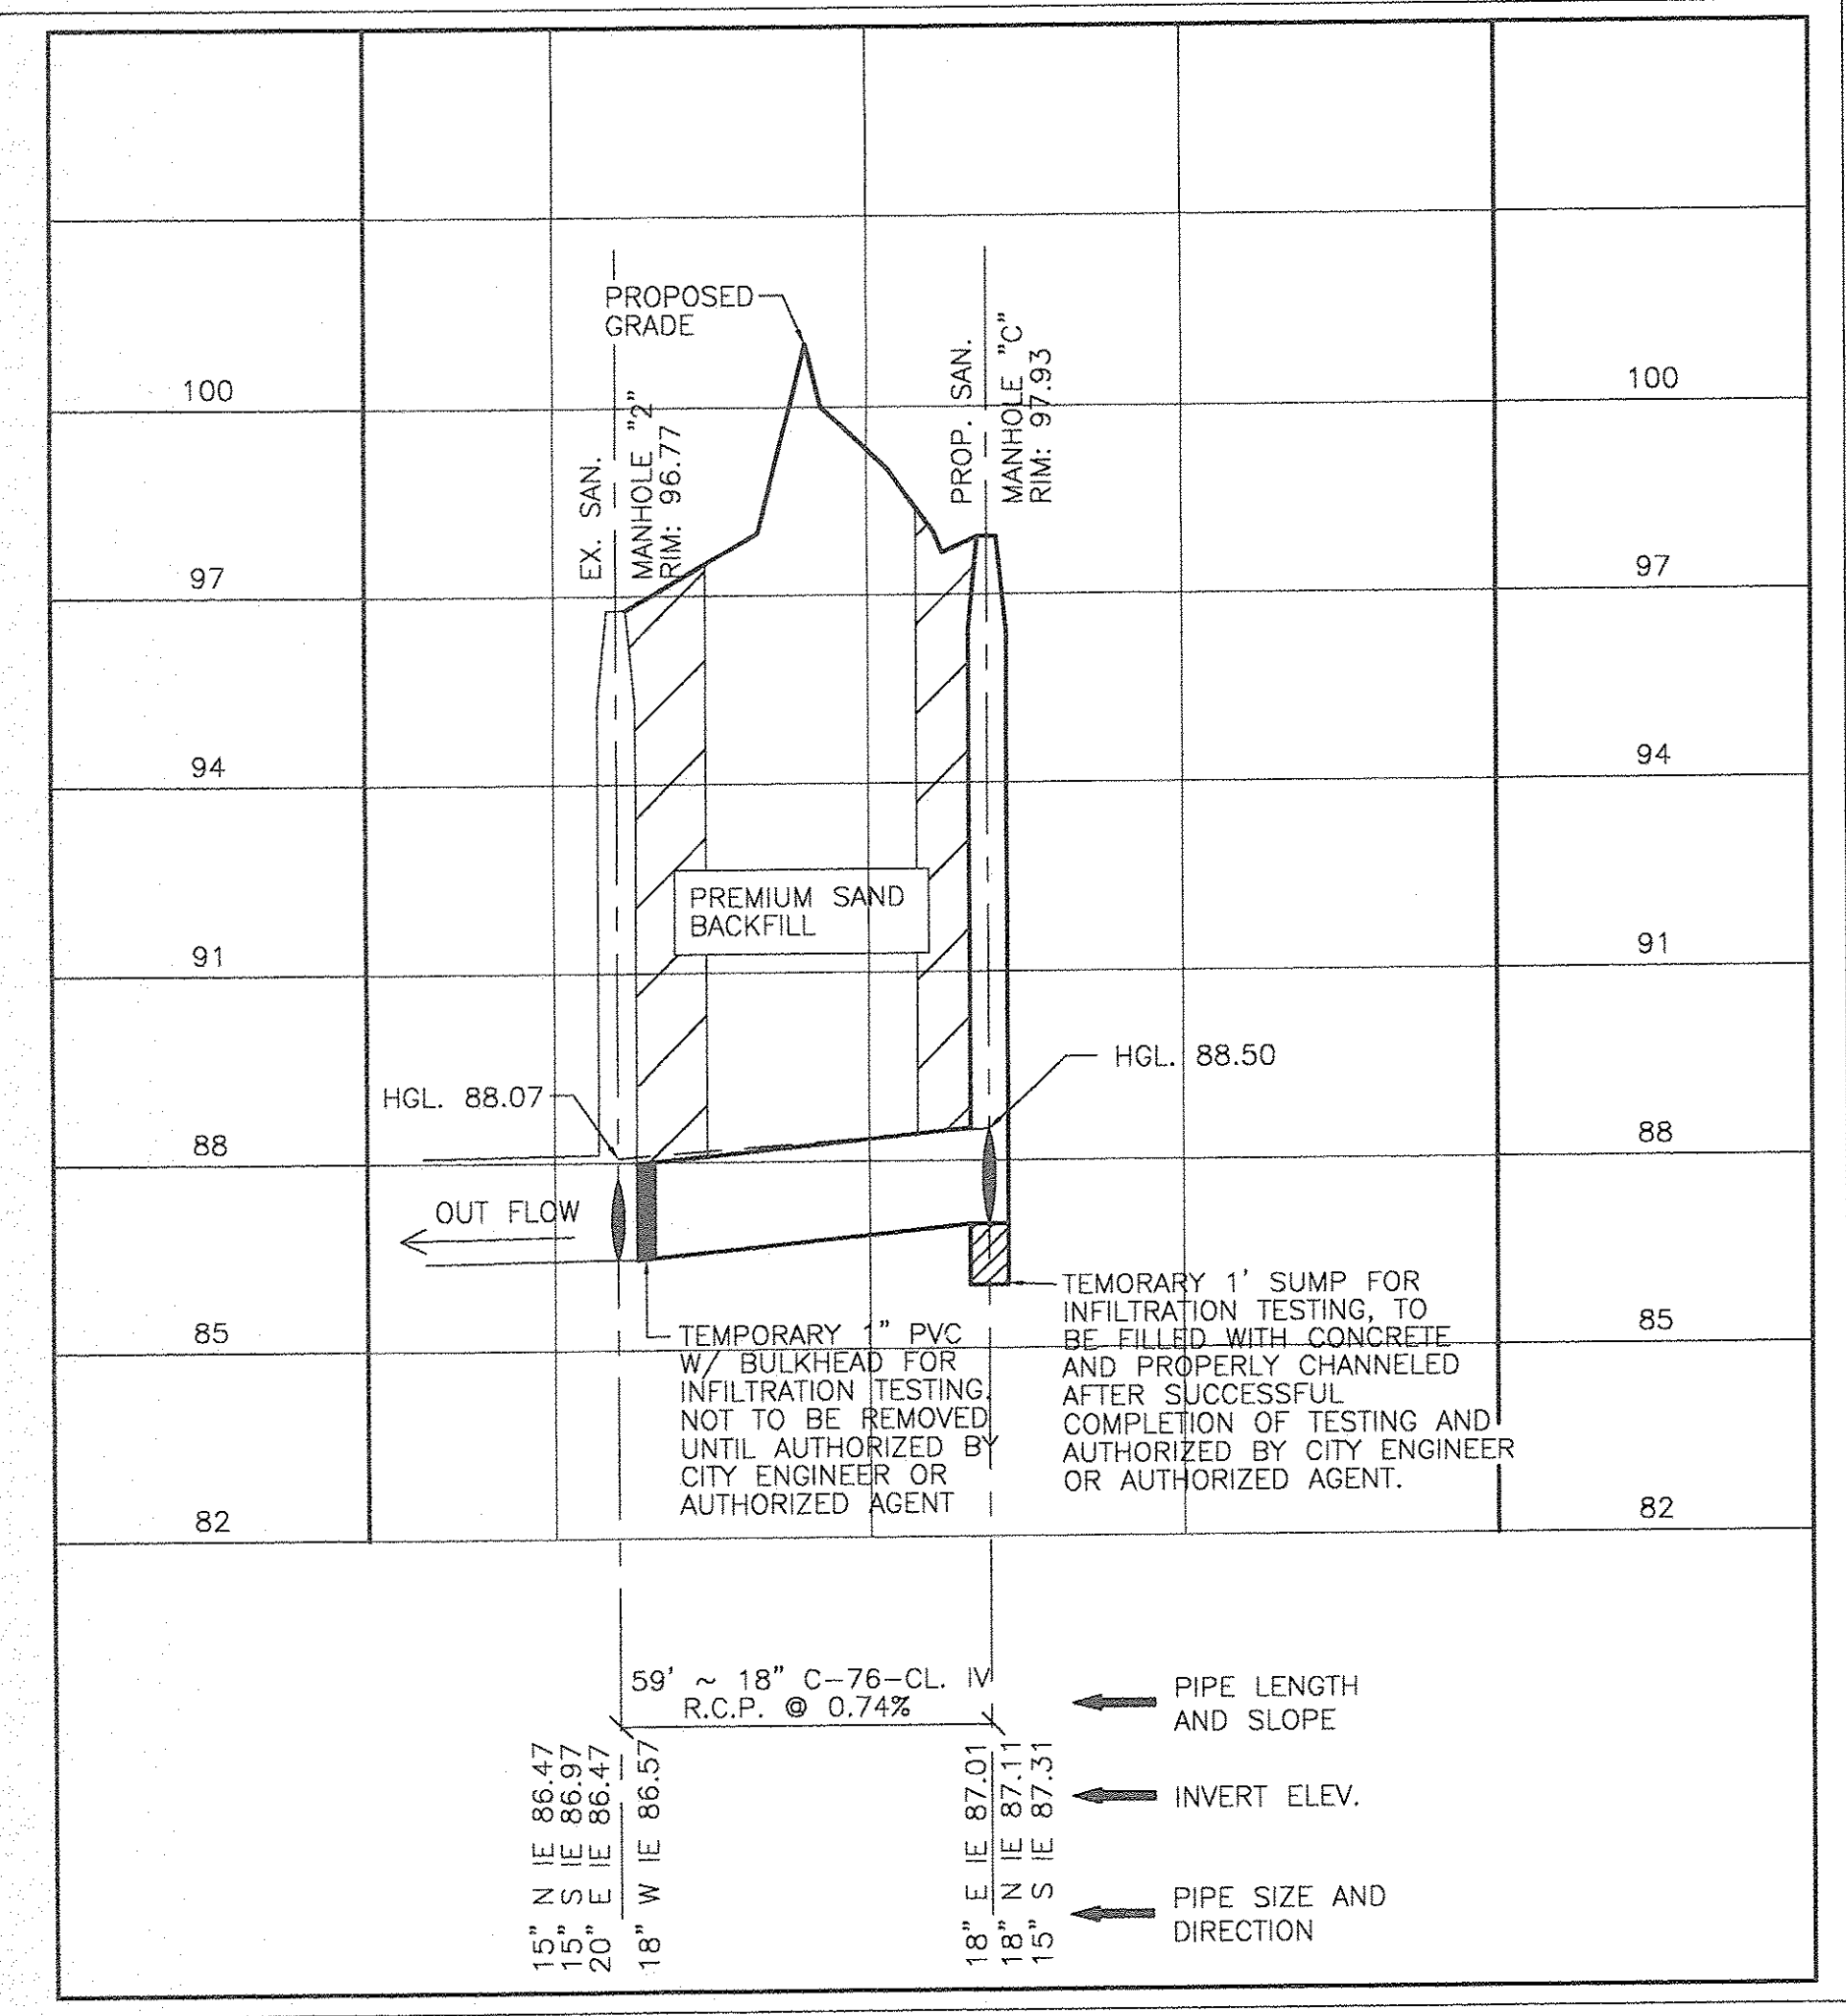

9800 ANN ARBOR ROAD, WEST
PLYMOUTH, MI 48170
PHONE: (734) 416-9650
FAX: (734) 416-9657
www.glsurveyor.com

PLAN & PROFILE 4
LENOX WATERFRONT ESTATES
LENOX AVENUE
WAYNE COUNTY, CITY OF DETROIT, MICHIGAN

CONTRACTOR'S NOTE

CONTRACTOR MUST COMPLY WITH ALL OF THE CITY OF DETROIT NEW CONSTRUCTION REQUIREMENTS. REQUIREMENTS ARE AS PUBLISHED BY THE CITY OF DETROIT, OR AS DIRECTED BY CITY ENGINEER.

CITY OF DETROIT DEPARTMENT OF PUBLIC WORKS CITY ENGINEERING DIVISION - STANDARD SPECIFICATIONS FOR PAVING AND RELATED CONSTRUCTION, OCTOBER 1999

DETROIT WATER AND SEWERAGE DEPARTMENT - GUIDELINES FOR SEWER SYSTEM CONSTRUCTION IN THE CITY OF DETROIT, NO PUBLISHED DATE.

D.W.S.D. - STANDARD SPECIFICATIONS FOR WATER SERVICE INSTALLATION AND MAINTENANCE, JUNE 1982.

D.W.S.D. - STANDARD SPECIFICATIONS FOR WATER SYSTEM ALTERATIONS, APRIL 1980 REVISED SEPTEMBER 1983.

D.W.S.D. - STANDARD SPECIFICATIONS FOR FIRE HYDRANT ALTERATIONS, APRIL 1980, REVISED SEPTEMBER 1983.

SEWER CONSTRUCTION NOTES

LOWER WATER MAIN AS NECESSARY TO MAINTAIN 18" MINIMUM VERTICAL SEPARATION BETWEEN UTILITIES.

PREMIUM SAND BACKFILL MUST BE M.D.O.T CLASS II MATERIAL COMPACTED TO 95% MAXIMUM UNIT DENSITY.

PROPER JOINTING MATERIAL AND CARE SHALL BE USED TO PRODUCE DURABLE, WATER TIGHT JOINTS. ALL JOINT MATERIALS SHALL BE APPROVED BY CITY ENGINEER BEFORE BEING USED.

ALL GASKETS SHALL BE COMPOSED OF A SYNTHETIC TYPE RUBBER COMPOUND, SUCH AS NEOPRENE OR APPROVED EQUAL, RESISTANT TO ALKALI, ACIDS, OILS, SEWAGE AND WASTE PETROLEUM PRODUCTS. THE GASKETS SHALL COMPLY WITH THE APPLICABLE REQUIREMENTS OF EITHER A.S.T.M. C 443M OR A.S.T.M. C361.

SANITARY SEWER BASIS OF DESIGN

TOTAL # OF UNITS = 18
3.5 PERSONS x UNITS = 3.5 x 18 = 63 PERSONS
AVERAGE FLOW 100 GPD. x 63 = 6300 GPD.
PEAK FLOW $18 + \sqrt{0.063} = 4.81$
 $4 + \sqrt{0.063} = 4.81$
6300 x 4.81 = 30303 GPD.
30303 / 1440 = 21.04 GPM.
= 0.0469 CFS.

STORM SEWER CALCULATIONS

SEE STORM SEWER COMPUTATION DATA FOR COMPLETE HYDROLOGIC DATA.
SHEET C-26


UTILITY NOTE

UNDERGROUND UTILITY LINES AND STRUCTURES SHOWN ARE PER RECORDS MADE AVAILABLE BY UTILITY OR MUNICIPALITY, AND BY FIELD OBSERVATION WHERE POSSIBLE. ALL MUNICIPALITIES AND UTILITY COMPANIES SHOULD BE NOTIFIED BY CONTRACTOR FOR FIELD LOCATION OF ALL UTILITIES PRIOR TO CONSTRUCTION.

PROFILE SCALE

HORIZONTAL: 1" = 30'
VERTICAL: 1" = 3'

ISSUED FOR REVIEW ONLY		
FILE NO.: 2791	DWG.: ENG SITE PLAN	
DESIGNED BY: S.A.S.	SHEET No. C-20	
DRAWN BY: S.A.S.		
CHECKED BY: L.P.R.		
SCALE: 1" = 30'		


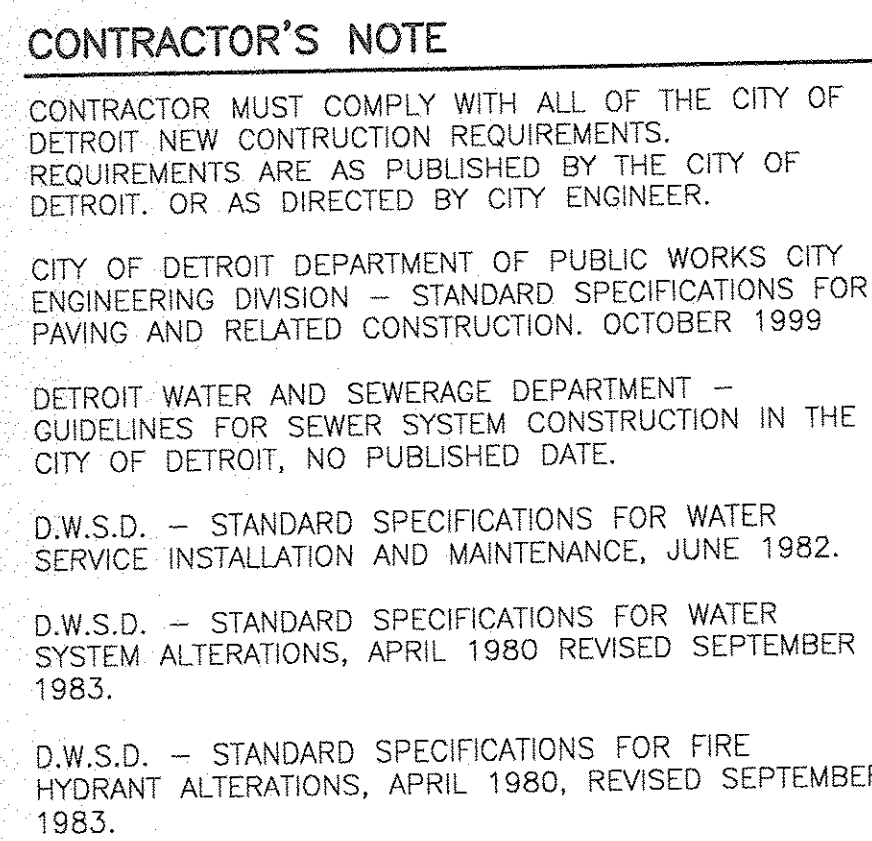


LOWER WATER MAIN AS NECESSARY TO MAINTAIN 18" MINIMUM VERTICAL SEPARATION BETWEEN UTILITIES.

PREMIUM SAND BACKFILL MUST BE M.D.O.T CLASS II MATERIAL COMPACTED TO 95% MAXIMUM UNIT DENSITY.

PROPER JOINTING MATERIAL AND CARE SHALL BE USED TO PROVIDE DURABLE, WATER TIGHT JOINTS. ALL JOINT MATERIALS SHALL BE APPROVED BY CITY ENGINEER BEFORE BEING USED.



ALL GASKETS SHALL BE COMPOSED OF A SYNTHETIC TYPE RUBBER COMPOUND, SUCH AS NEOPRENE OR APPROVED EQUAL, RESISTANT TO ALKALI, ACIDS, OILS, SEWAGE AND WASTE PETROLEUM PRODUCTS. THE GASKETS SHALL COMPLY WITH THE APPLICABLE REQUIREMENTS OF EITHER A.S.T.M. C 443M OR A.S.T.M. C361.

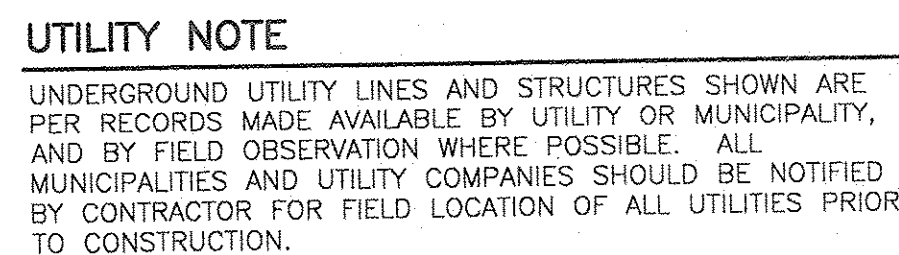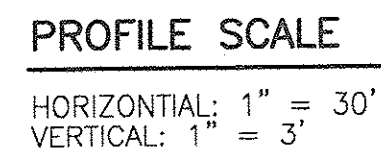

PLAN & PROFILE 5
LENOX WATERFRONT ESTATES
LENOX AVENUE
WAYNE COUNTY, CITY OF DETROIT, MICHIGAN

CLIENT:	ISSUE DATE	9/1/06
MORGAN DEVELOPMENT LLC	REVISIONS	
36150 DEQUINDRE		
SUITE 600		
STERLING HEIGHTS, MI 48310		



ISSUED FOR REVIEW ONLY	
FILE NO.: 2791	DWG.: ENG SITE PLAN
DESIGNED BY: S.A.S.	SHEET No. C-21
DRAWN BY: S.A.S.	
CHECKED BY: L.P.R.	
SCALE: 1" = 30'	

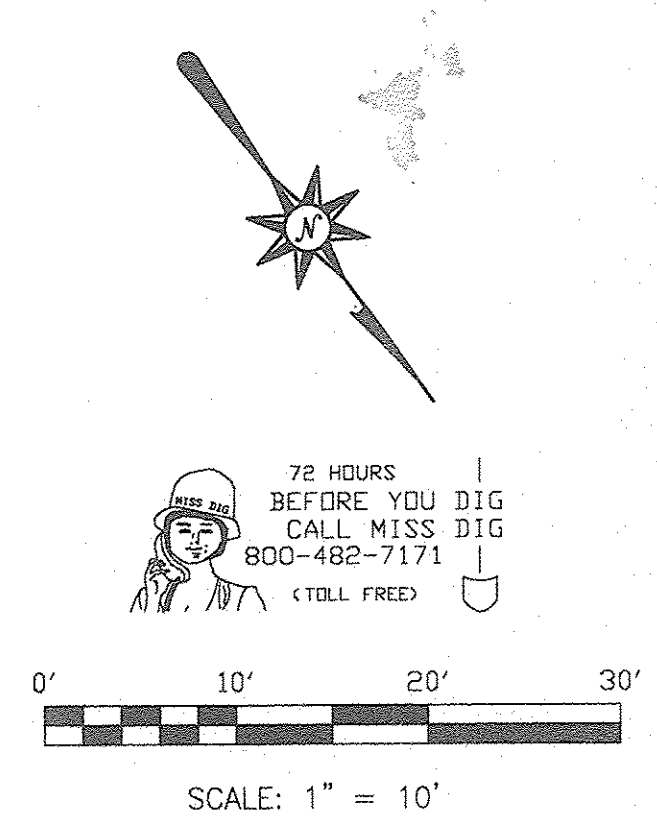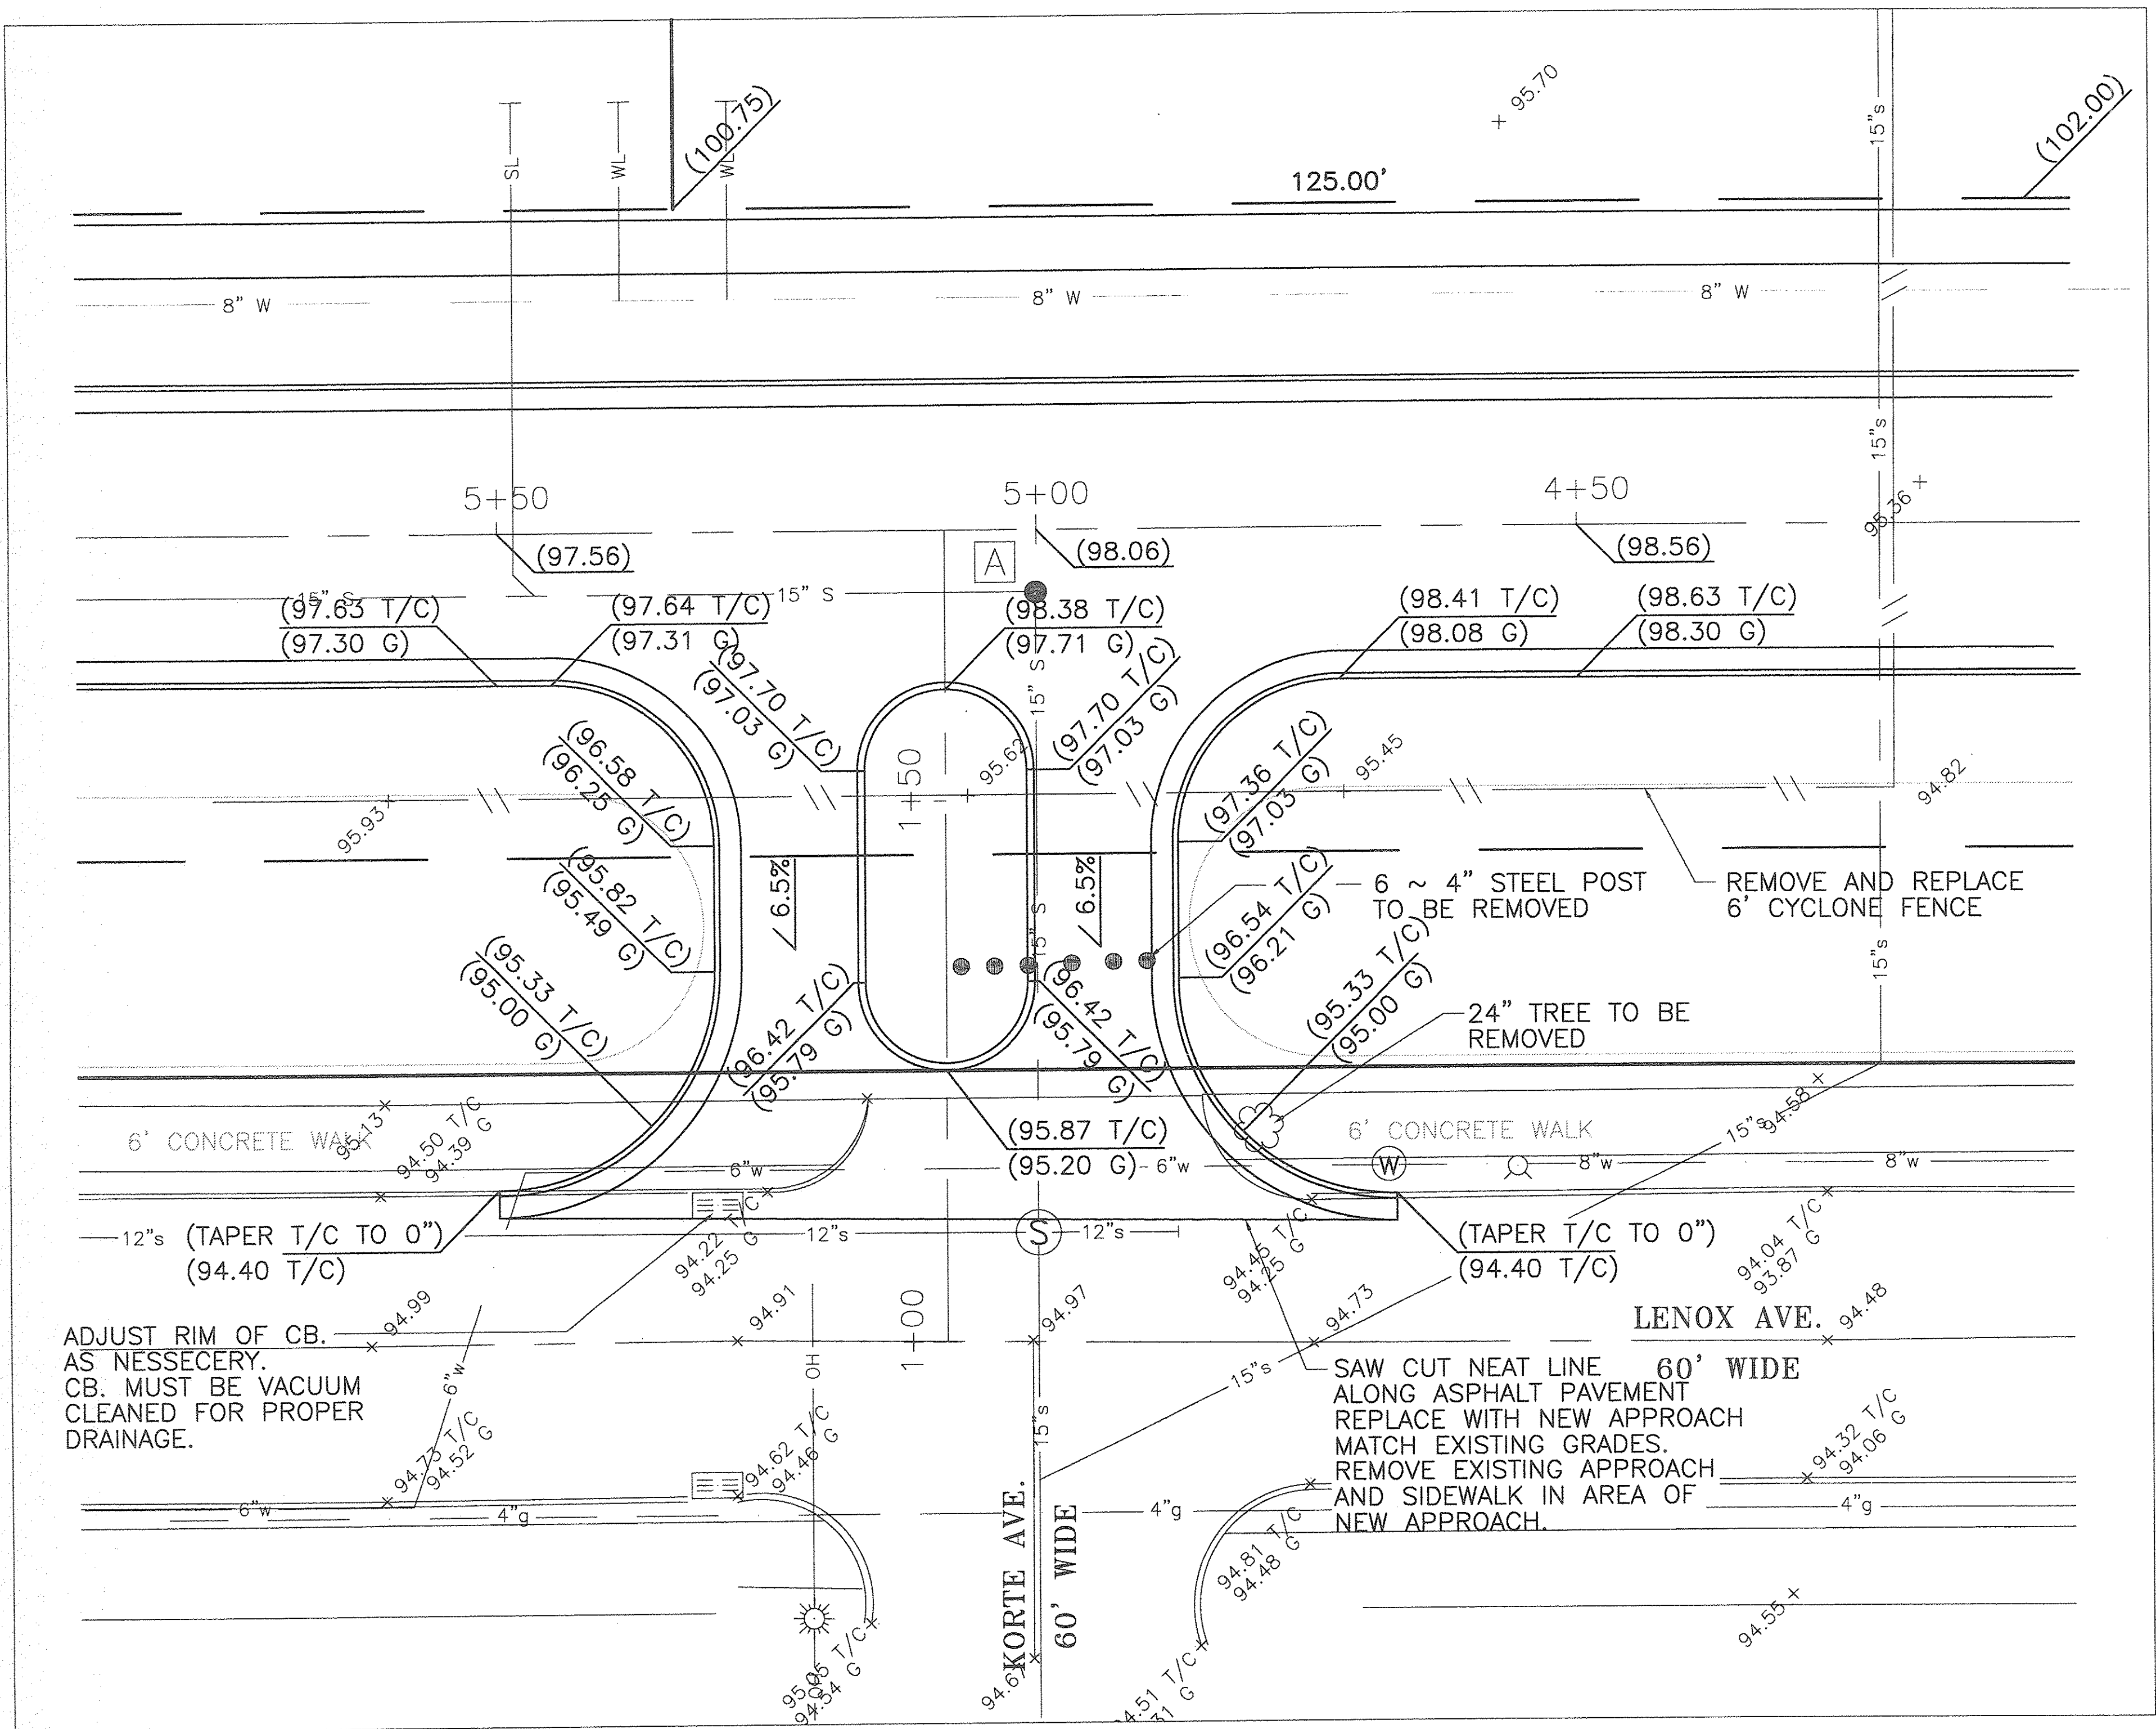

ISSUE DATE	9/1/06
REVISIONS	
CLIENT:	MORGAN DEVELOPMENT LLC
	36150 DEQUINDRE
	SUITE 600
	STERLING HEIGHTS, MI 48310


GLA SURVEYORS & ENGINEERS

9800 ANN ARBOR ROAD, WEST
PLYMOUTH, MI 48170
PHONE: (734) 416-9650
FAX: (734) 416-9657
www.glasurveyor.com

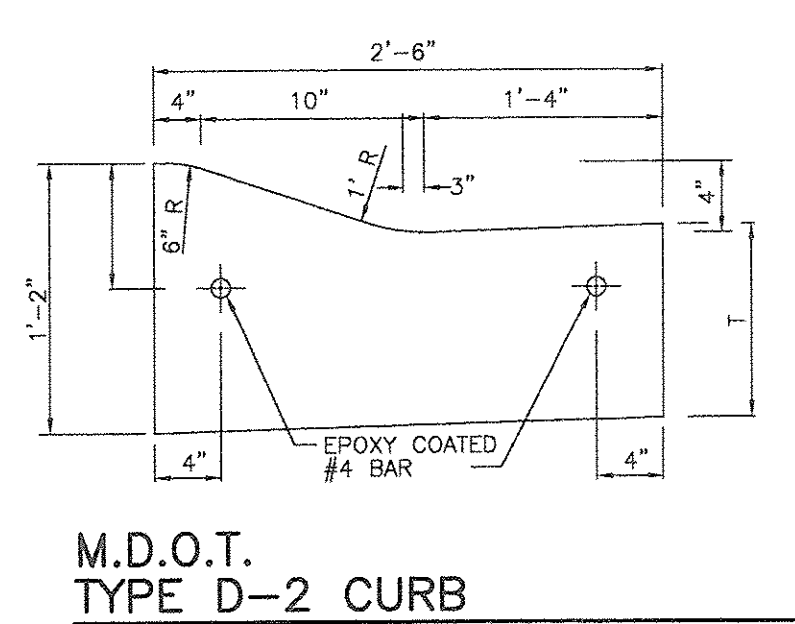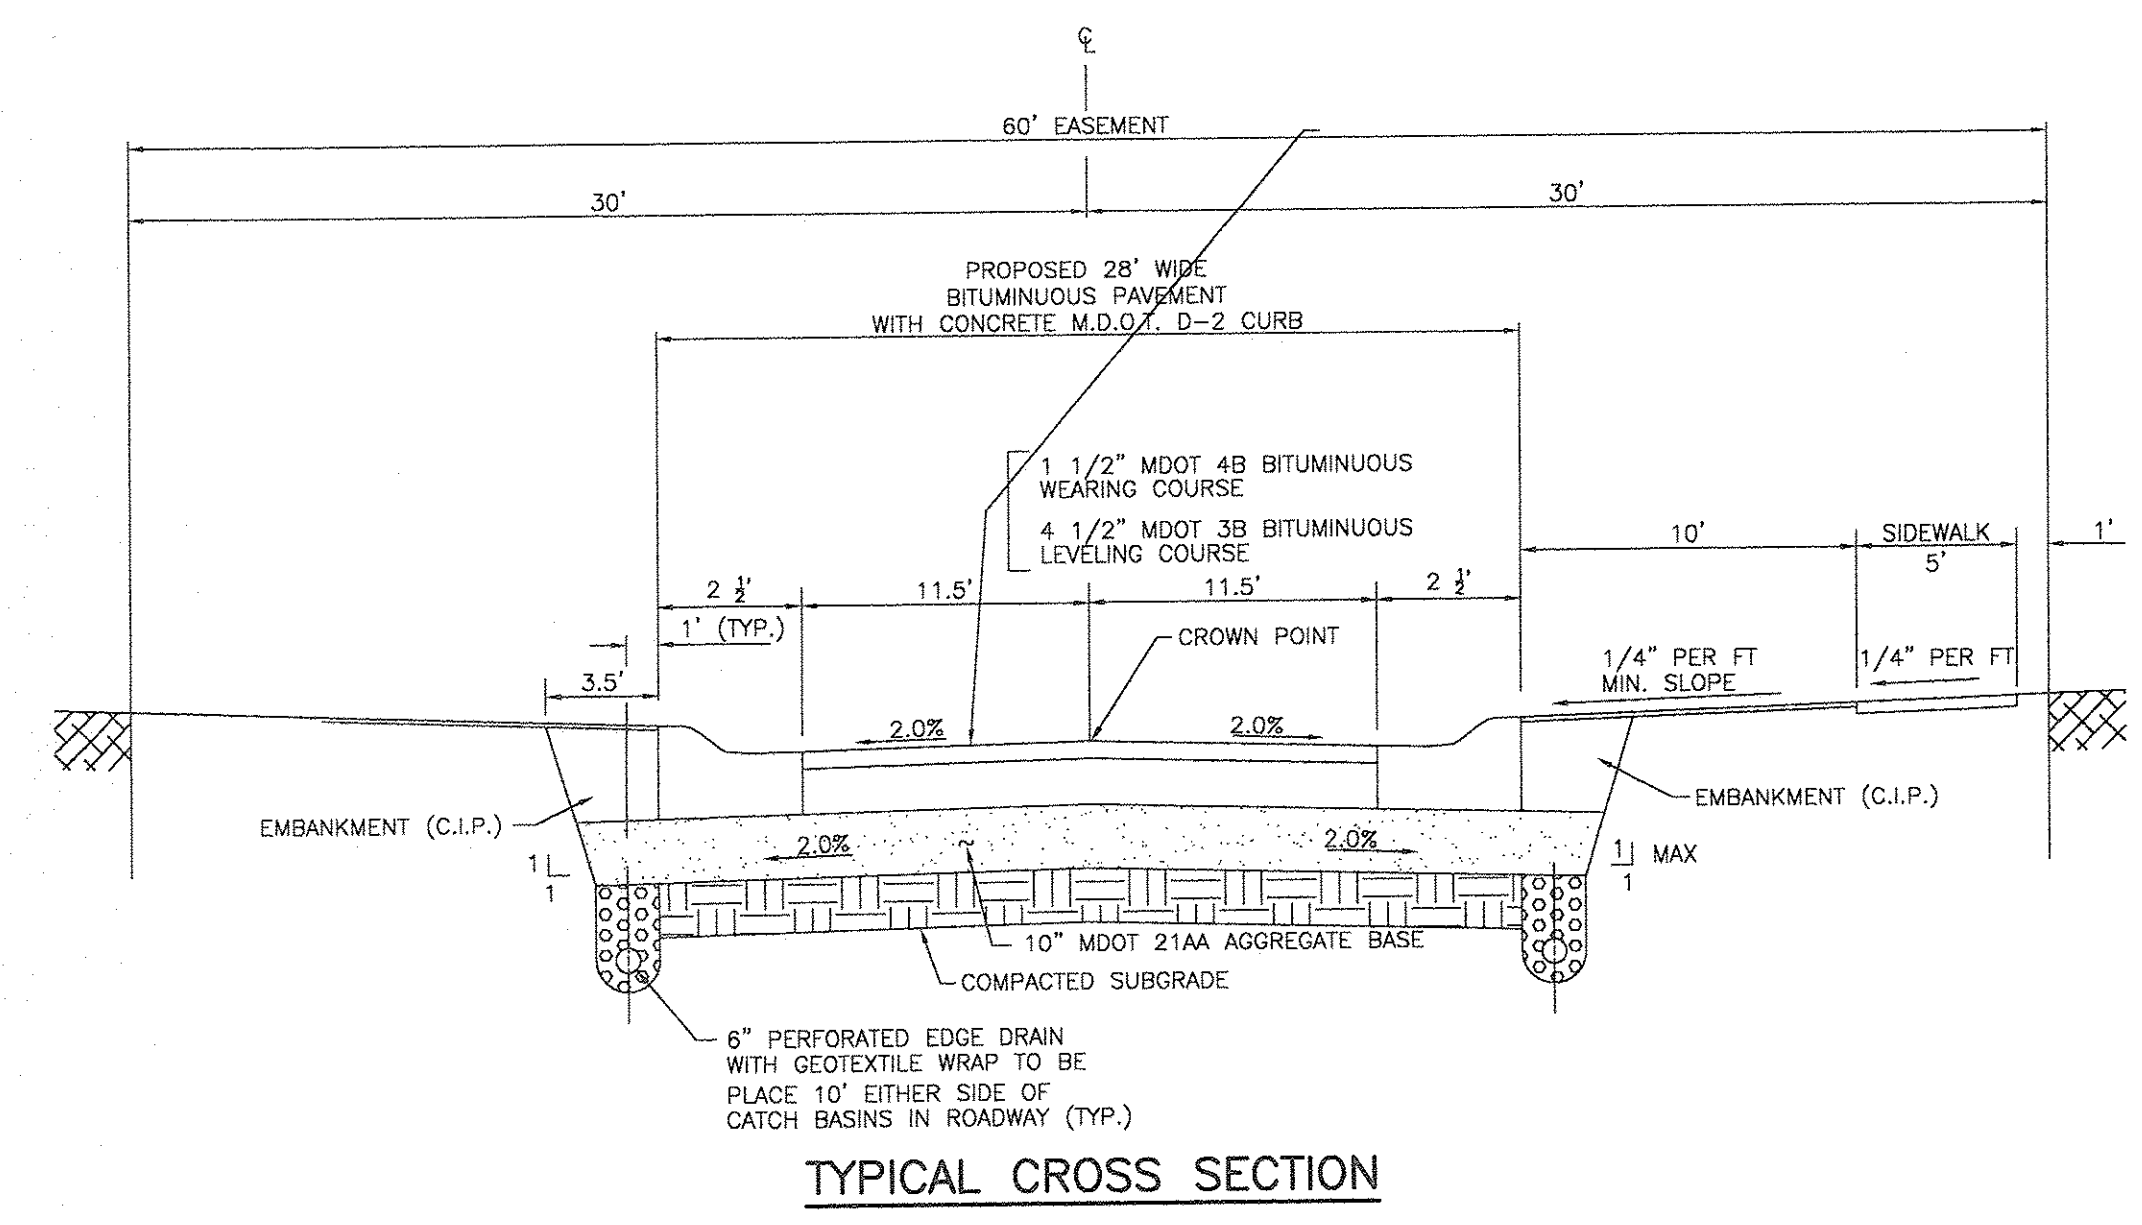

M.D.O.T. "D" CURB TABLE

DETAIL	DIMENSION T	LANE TIES	CONCRETE CYD / LFT
D1	9"	AS SHOWN	0.0788
D2	9"	OMITTED	0.0788
D3	10"	AS SHOWN	0.0826

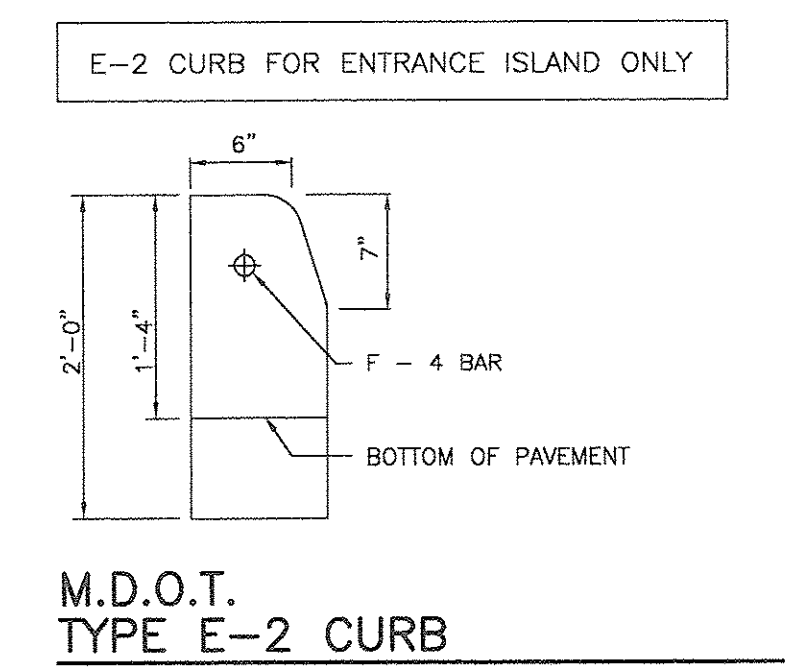

M.D.O.T. "E" CURB TABLE


DETAIL	CURB HEIGHT	LANE TIES	CONCRETE CYD / LFT
E1	1'-4"	AS SHOWN	0.0310
E2	1'-4"	OMITTED	0.0310
E3	2'-0"	AS SHOWN	0.0477

INTERSECTION DETAIL
LENOX WATERFRONT ESTATES
LENOX AVENUE
WAYNE COUNTY, CITY OF DETROIT, MICHIGAN

ISSUED FOR REVIEW ONLY		
FILE NO.: 2791	DWG.: ENG SITE PLAN	
DESIGNED BY: S.A.S.	SHEET No. C-22	
DRAWN BY: S.A.S.		
CHECKED BY: L.P.R.		
SCALE: 1" = 10'		

SEE M.D.O.T. SPECIFICATIONS R-30-D

SEE M.D.O.T. SPECIFICATIONS R-30-D

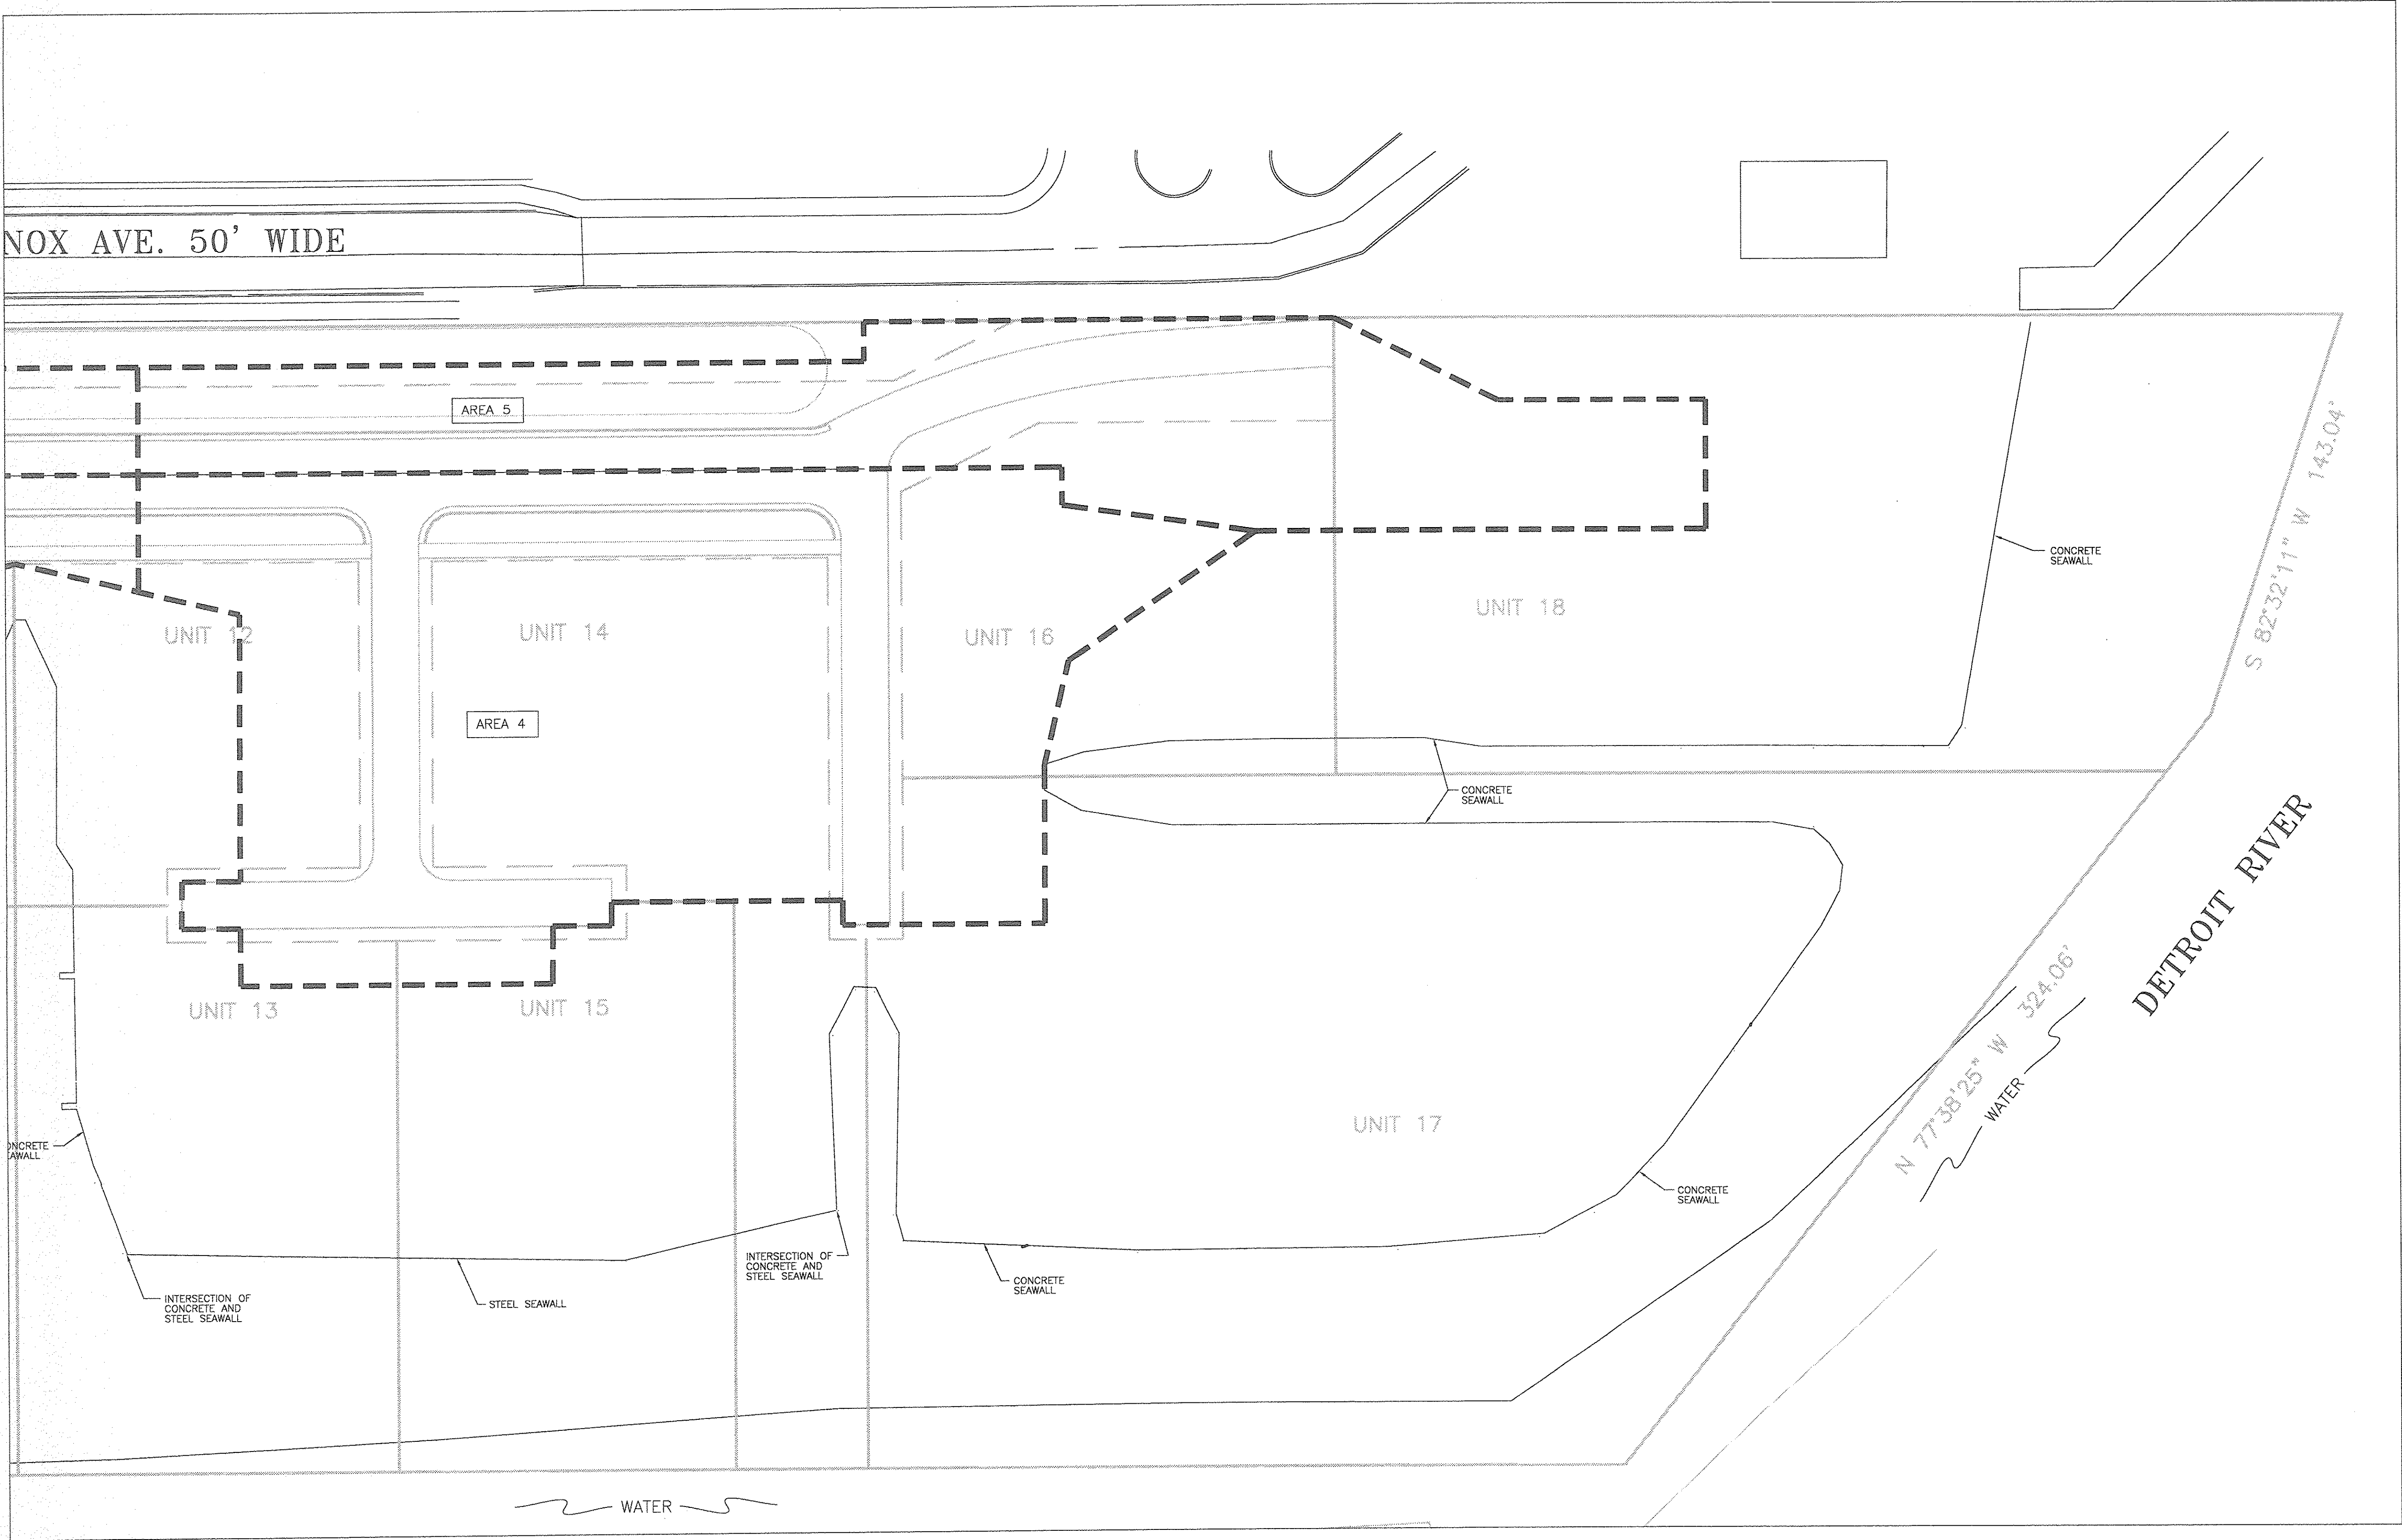



72 HOURS
BEFORE YOU DIG
CALL MISS DIG
800-482-7171
(TOLL FREE)






SCALE: 1" = 30'

ISSUED FOR REVIEW ONLY		
FILE NO.: 2791		DWG.: ENG SITE PLAN
DESIGNED BY: S.A.S.		SHEET No. C-25
DRAWN BY: S.A.S.		
CHECKED BY: L.P.R.		
SCALE: 1" = 30'		

DRAINAGE DISTRICT 3
LENOX WATERFRONT ESTATES
LENOX AVENUE
WAYNE COUNTY, CITY OF DETROIT, MICHIGAN

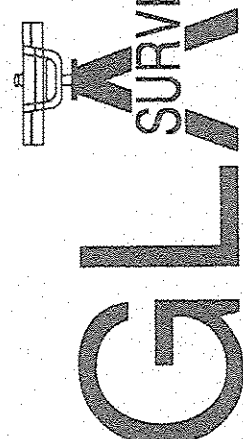

GLA
SURVEYORS &
ENGINEERS

9800 ANN ARBOR ROAD, WEST
PLYMOUTH, MI 48170
PHONE: (734) 416-9650
FAX: (734) 416-9657
www.glasurveyor.com

CLIENT:	ISSUE DATE	9/1/06
	REVISIONS	
MORGAN DEVELOPMENT LLC		
36150 DEQUINDRE		
SUITE 600		
STERLING HEIGHTS, MI 48310		

GLA Surveyors & Engineers							STORM SEWER COMPUTATION SHEET										Manning's 'n' 1 for hydraulic slope: Manning's 'n' 2 for hydraulic slope: Diameter for change in n, if desired min. acceptable cover (ft) Y/CB: Pipe thickness for cover calc. (in):							
							10 YEAR STORM																	
LOCATION: Detroit, MI							JOB NO. 2791																	
Calc'd by: S. Schumacher							Checked by: L. Rausch		Date: August 27, 2006															
PROJECT: Lenox Waterfront Estates							STREET: Lenox St		Rev.:															
Struc. No.	RUN	Area No.	A acre	C	CA	Σ CA	Flow min.	Time min.	I	Q YEAR	Dia in.	L ft.	Pipe S. %	Hyd.S. %	V (full) fps	CAP. cfs	IE upper	IE lower	Hyd. delta	H.G. ft	RIM UP ft			
1	1-B	1	1.73	0.54	0.93	0.93		20.0	3.80	3.55	12	19	0.31	0.99	2.52	1.98	87.44	87.38	0.19	88.57	96.74			
							0.1	20.1												88.38				
8	8-B	8	0.41	0.43	0.18	0.18		20.0	3.80	0.67	12	7	0.31	0.04	2.52	1.98	87.40	87.38	0.00	88.38	96.74			
							0.0	20.0												88.38				
B	B-A	N/A	0.00	0.00	0.00	1.11		20.0	3.80	4.22	15	308	0.43	0.43	3.45	4.23	88.17	86.85	1.32	89.44	98.85			
							1.5	21.5												88.12				
A	A-EXISTING	N/A	0.00	0.00	0.00	1.11		21.6	3.66	4.06	15	59	0.43	0.39	3.45	4.23	86.75	86.50	0.23	88.03	97.94			
							0.3	21.9												87.80				

GLA Surveyors & Engineers						STORM SEWER COMPUTATION SHEET															Manning's 'n'1 for hydraulic slope: Manning's 'n'2 for hydraulic slope: Diameter for change in n, if desired min. acceptable cover (ft) Y/CB: Pipe thickness for cover calc. (in):				
						10 YEAR STORM																			
LOCATION: Detroit, MI						JOB NO. 2791		Checked by: L. Rausch		Date: August 27, 2006															
Calc'd by: S. Schumacher						STREET: Lenox St		Rev.:																	
PROJECT: Lenox Waterfront Estates																									
Struc. No.	RUN	Area No.	A acre	C	CA	Σ CA	Flow min.	Time min.	I 10	Q YEAR	Dia in.	L ft.	Pipe S. %	Hyd. S. %	V (full) fps	CAP. cfs	IE upper	IE lower	Hyd. delta	H.G. ft	RIM UP ft				
2	2-E	2	1.32	0.51	0.68	0.68		20.0	3.80	2.59	12	19	0.53	0.53	3.30	2.59	89.04	88.94	0.10	90.04	96.74				
							0.1	20.1												89.94					
7	7-E	7	0.34	0.45	0.15	0.15		20.0	3.80	0.58	12	7	0.31	0.03	2.52	1.98	88.96	88.94	0.00	89.94	96.74				
							0.0	20.0												89.94					
F	F-E	N/A	0.00	0.00	0.00	0.83		20.1	3.80	3.16	15	205	0.24	0.24	2.58	3.16	88.74	88.25	0.49	89.99	96.99				
							1.3	21.4												89.50					
3	3-D	3	1.10	0.54	0.59	0.59		20.0	3.80	2.26	12	19	0.41	0.40	2.90	2.28	87.80	87.72	0.07	88.79	96.74				
							0.1	20.1												88.72					
6	6-D	6	0.34	0.45	0.15	0.15		20.0	3.80	0.58	12	7	0.31	0.03	2.52	1.98	87.74	87.72	0.00	88.72	96.74				
							0.0	20.0												88.72					
E	E-D	N/A	0.00	0.00	0.00	1.58		21.5	3.67	5.78	18	240	0.31	0.30	3.31	5.85	88.15	87.41	0.73	89.64	98.82				
							1.2	22.7												88.91					
G	G-D	N/A	0.00	0.00	0.00	0.00		20.0	3.80	0.00	10	195	0.28	0.00	2.12	1.16	88.50	87.95	0.00	92.78	105.75				
							1.5	21.5												92.78					
D	D-C	N/A	0.00	0.00	0.00	1.58		23.1	3.53	5.56	18	71	0.28	0.28	3.14	5.56	87.31	87.11	0.20	88.81	97.22				
							0.4	23.5												88.61					
M	M-K	N/A	0.00	0.00	0.00	0.00		20.0	3.80	0.00	10	146	0.28	0.00	2.12	1.16	89.48	89.07	0.00	89.90	101.00				
							1.1	21.1												89.90					
L	L-K	N/A	0.00	0.00	0.00	0.00		20.0	3.80	0.00	10	155	0.28	0.00	2.12	1.16	89.50	89.07	0.00	89.90	99.00				
							1.2	21.2												89.90					
4	4-H	4	1.10	0.51	0.56	0.56		20.0	3.80	2.14	12	19	0.34	0.36	2.64	2.08	88.79	88.73	0.07	89.80	96.74				
							0.1	20.1												89.73					
5	5-H	5	1.68	0.32	0.53	0.53		20.0	3.80	2.03	12	7	0.31	0.33	2.52	1.98	88.75	88.73	0.02	89.75	96.74				
							0.0	20.0												89.73					
K	K-H	N/A	0.00	0.00	0.00	1.10		21.2	3.69	4.05	15	160	0.40	0.39	3.33	4.08	88.73	88.09	0.63	89.97	97.40				
							0.8	22.0												89.34					
J	J-H	N/A	0.00	0.00	0.00	0.00		22.6	3.57	0.00	10	195	0.28	0.00	2.12	1.16	88.98	88.43	0.00	92.78	105.75				
							1.5	24.1												92.78					
H	H-C	N/A	0.00	0.00	0.00	1.10		24.1	3.45	3.78	15	186	0.36	0.34	3.17	3.90	87.99	87.31	0.64	89.20	97.98				
							1.0	25.1												88.56					
C	C-EXISTING	N/A	0.00	0.00	0.00	2.67		25.1	3.37	9.01	18	59	0.74	0.74	5.11	9.03	87.01	86.57	0.43	88.50	97.93				
							0.2	25.3												88.07					

SANITARY SEWER TABLE		
	NORTHING	EASTING
EX #1	SAN. M.H. RIM: 94.79 12" N IE 86.99 12" S IE 88.79 15" E IE 86.39 PROF. 15" W IE 86.55	6644.98 11077.04
EX #2	SAN. M.H. RIM: 96.77 15" N IE 86.47 15" S IE 86.97 20" E IE 86.47 PROF. 18" W IE 86.57	5734.71 11517.48
A	SAN. M.H. RIM: 97.94 15" E IE 86.75 15" S IE 86.85	6619.15 11023.76
B	SAN. M.H. RIM: 98.85 15" N IE 88.17	6341.64 11158.31
C	SAN. M.H. RIM: 97.93 15" S IE 87.31 18" N IE 87.11 18" E IE 87.01	5709.23 11464.93
D	SAN. M.H. RIM: 97.22 10" W IE 91.95 6" DROP IE 87.95 18" N IE 87.41 18" E IE 87.31	5773.41 11433.81
E	SAN. M.H. RIM: 98.82 15" N IE 88.25 18" S IE 88.15	5989.37 11329.11
F	SAN. M.H. RIM: 96.99 15" S IE 88.74	6173.83 11239.67
G	SAN. M.H. RIM: 105.75 10" S IE 92.50	5888.45 11258.58
H	SAN. M.H. RIM: 97.98 10" W IE 91.95 6" DROP IE 88.43 15" N IE 87.99 15" S IE 88.09	5541.71 11546.16
J	SAN. M.H. RIM: 105.75 10" S IE 92.50	5456.74 11370.92
K	SAN. M.H. RIM: 97.40 10" S IE 89.07 10" W IE 89.07 15" N IE 88.73	5397.74 11615.96
L	SAN. M.H. RIM: 99.00 10" W IE 89.50	5330.23 11476.71
M	SAN. M.H. RIM: 101.00 10" N IE 89.48	5274.77 11696.98

STORM SEWER TABLE		
	NORTHING	EASTING
①	4' DIA. C.B. W/ 2' SUMP RIM: 94.40 12" E IE 87.44	6515.78 11053.31
②	4' DIA. C.B. W/ 2' SUMP RIM: 96.74 12" E IE 89.04	6155.86 11227.82
③	4' DIA. C.B. W/ 2' SUMP RIM: 96.74 12" E IE 87.80	5795.93 11402.34
④	4' DIA. C.B. W/ 2' SUMP RIM: 96.74 12" E IE 88.79	5436.01 11576.85
⑤	4' DIA. M.H. W/ 2' SUMP RIM: 96.74 12" W IE 88.75	5447.13 11599.79
⑥	4' DIA. C.B. W/ 2' SUMP RIM: 96.74 12" W IE 87.74	5807.06 11425.28
⑦	4' DIA. C.B. W/ 2' SUMP RIM: 96.74 12" W IE 88.96	6166.98 11250.77
⑧	4' DIA. M.H. W/ 2' SUMP RIM: 96.74 12" W IE 87.40	6526.91 11076.26

WATER STRUCTURE TABLE		
	NORTHING	EASTING
①	5' DIA. G.V. & WELL RIM: 94.40	6739.29 11022.46
②	STD. FIRE HYDRANT F.G.: 97.80	6471.62 11071.11
③	5' DIA. G.V. & WELL RIM: 100.00	6311.76 11142.51
④	STD. FIRE HYDRANT F.G.: 99.00	6012.72 11293.61
⑤	5' DIA. G.V. & WELL RIM: 98.50	5861.85 11360.65
⑥	STD. FIRE HYDRANT F.G.: 99.00	5652.80 11468.12
⑦	5' DIA. G.V. & WELL RIM: 97.75	5438.94 11565.70
⑧	STD. FIRE HYDRANT F.G.: 99.00	5320.62 11472.94
⑨	STD. FIRE HYDRANT F.G.: 99.50	5380.04 11661.81
⑩	5' DIA. G.V. & WELL RIM: 101.65	6111.86 6043.73

MATERIAL LIST

STORM

8 - 4" CATCH BASINS W/ 2' SUMP

104 L.F. 12" R.C.P. C-76-CL. IV

SANITARY

12 - 5" MANHOLE

453 L.F. 6" P.V.C. S.D.R. 23.5, SCH. 40
OR AS APPROVED BY THE CITY OF
DETROIT SANITARY LEAD

918 L.F. 15" C-76-CL. IV R.C.P.

370 L.F. 18" C-76-CL. IV R.C.P.

691 L.F. 10" SCH. 40 PVC.

WATER

2 - 8"x8"x8" CUT IN TEE

4 - 5" GATE, VALVE AND WELL

5 - STD. FIRE HYDRANT AND ASSEMBLY

2 - 8" 45° BENDS

1481 L.F. 8" DUCTILE IRON CL. 56 PIPE
W/ POLY WRAP

680 L.F. 1" TYPE "K" COPPER

ADDITIONAL MATERIAL WILL BE REQUIRED.

THE ABOVE QUANTITIES ONLY REPRESENT THE
CONCEPTUAL DESIGN.