


PLAN VIEW

SCALE: AS NOTED

ISOMETRIC VIEW

NTS

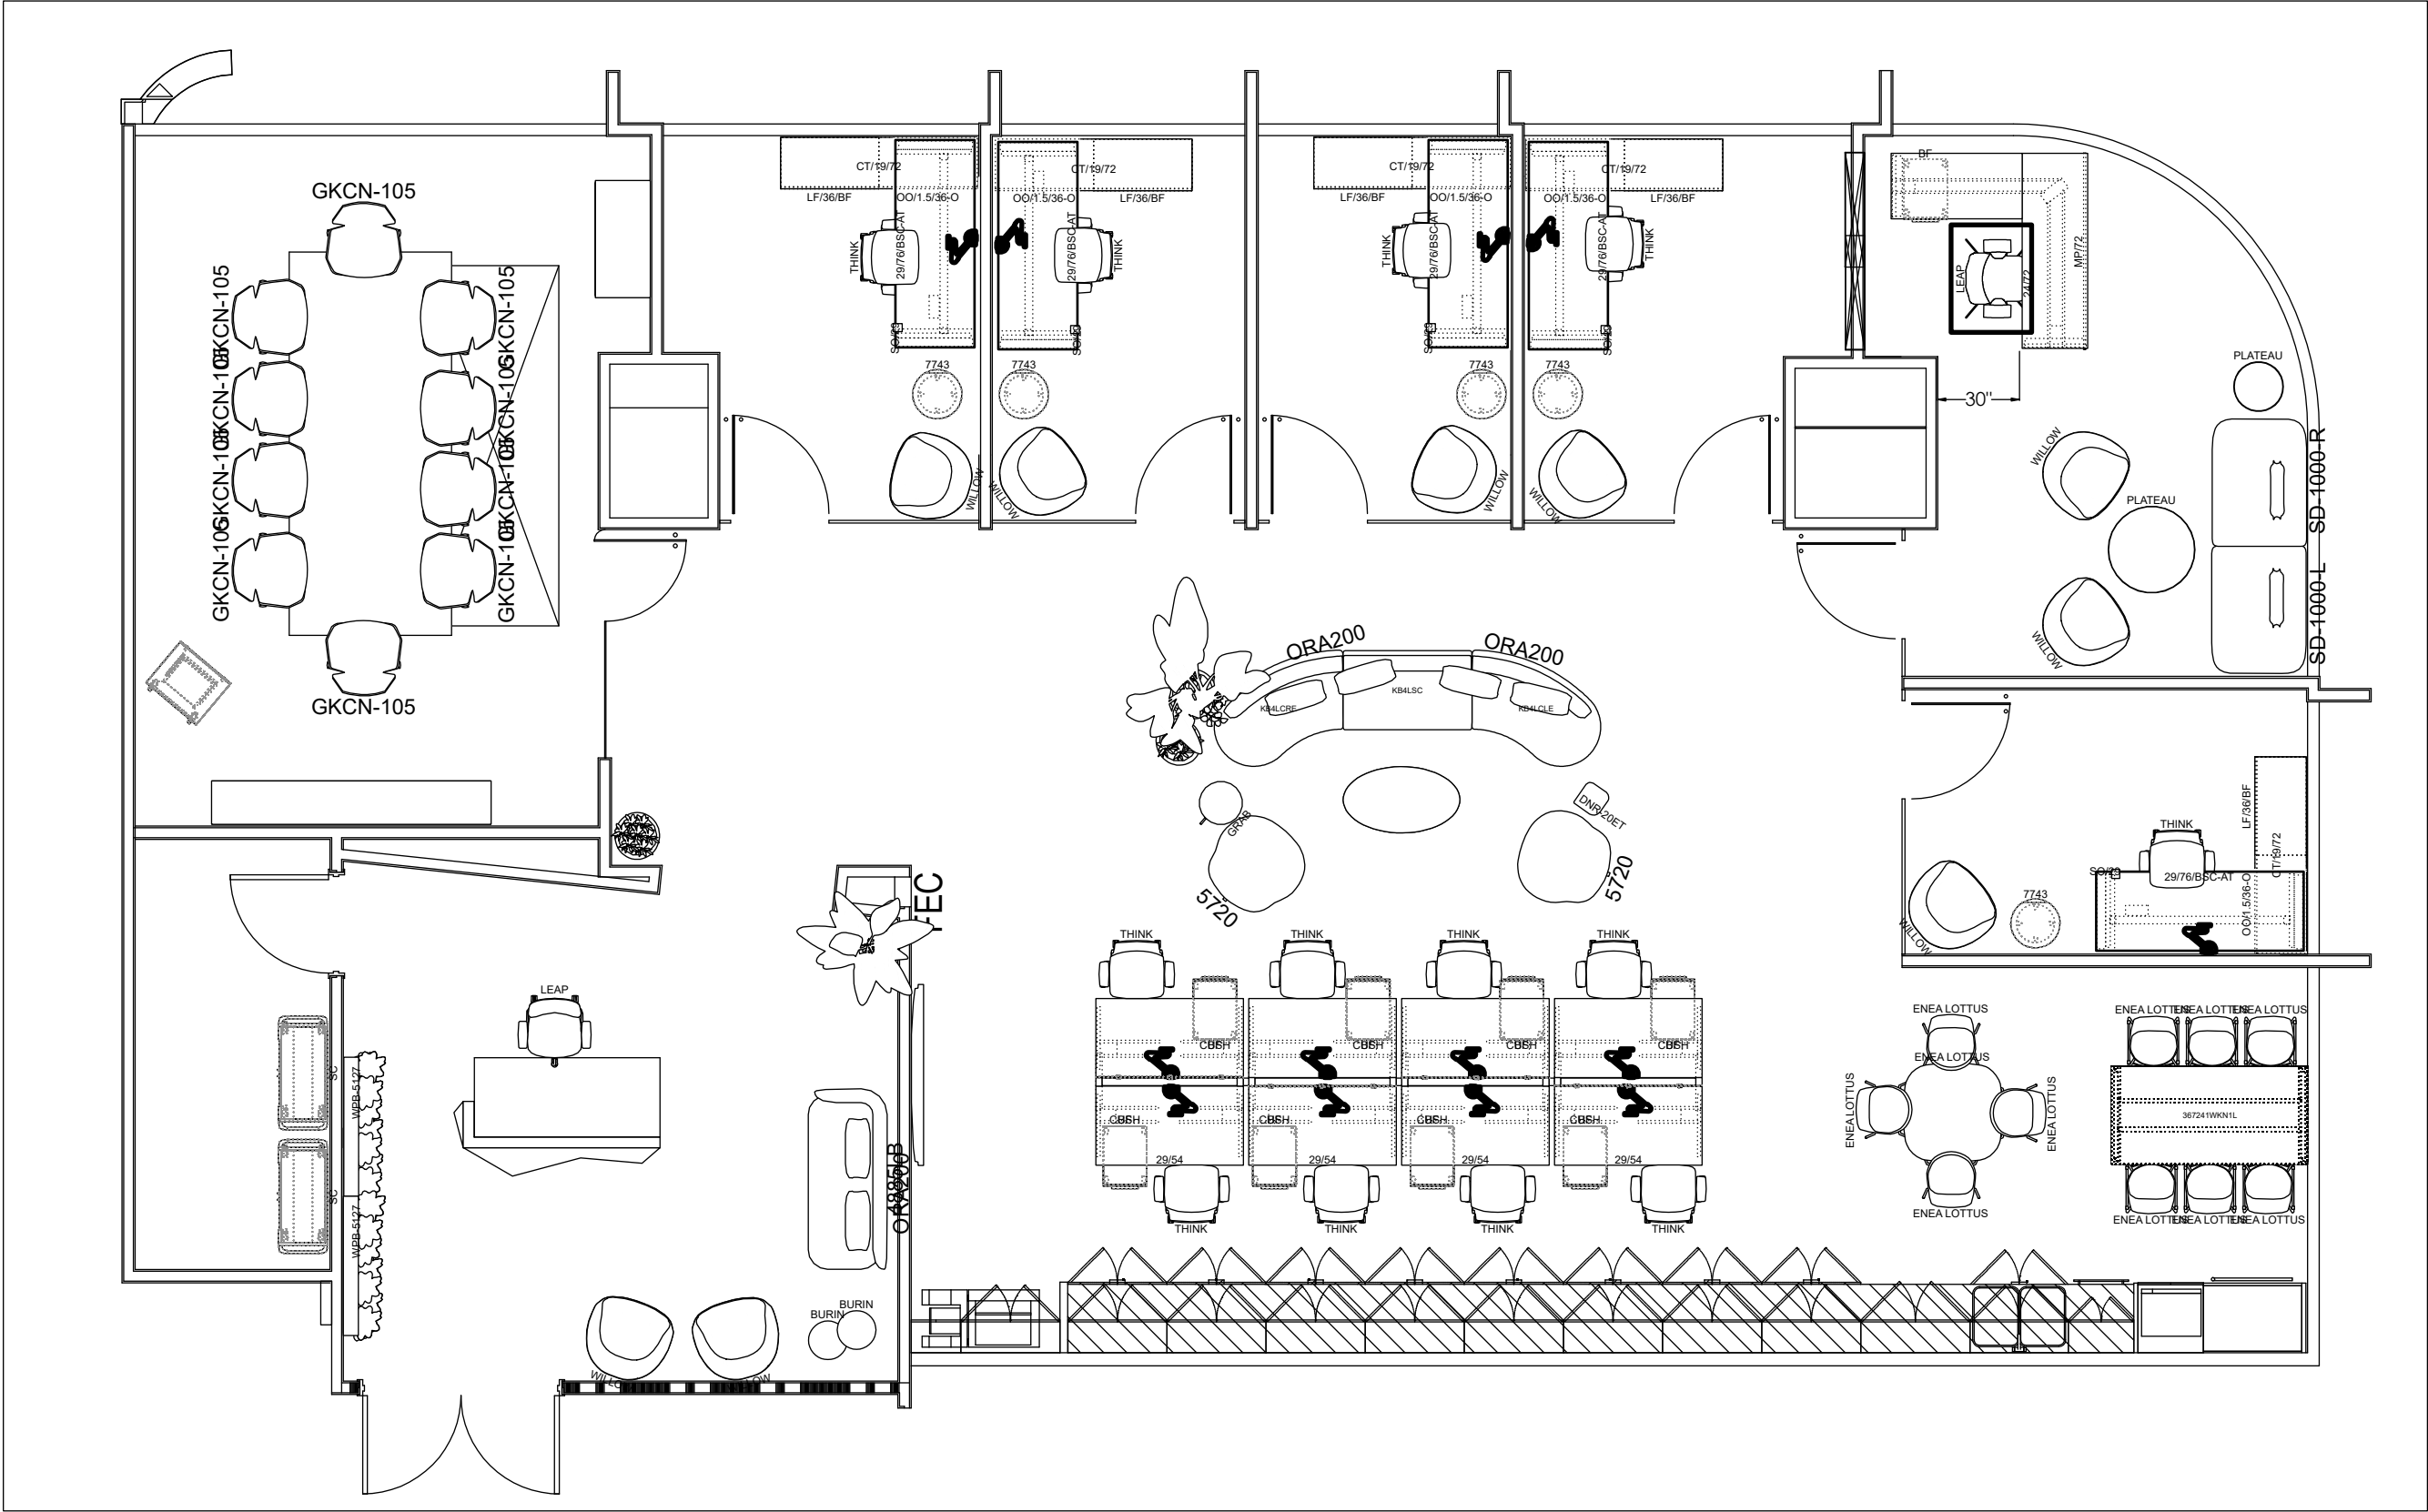

EMPIRE OFFICE SHALL NOT BE HELD LIABLE FOR ANY ERRORS, OMISSIONS OR DISCREPANCIES THAT MAY OCCUR FROM THE USE OF THESE PLANS. FIELD VERIFICATION REQUIRED BY OTHERS FOR ACCURACY. THESE ARE NOT AND SHALL NOT BE USED FOR PERMIT AND/OR CONSTRUCTION PURPOSES. THESE ELECTRICAL PLANS ARE FOR FURNITURE REFERENCE ONLY AND SHALL NOT BE COPIED OR DISTRIBUTED WITHOUT A WRITTEN AUTHORIZATION FROM EMPIRE OFFICE.

ALL ELECTRICAL INFORMATION IS PROVIDED AS A COURTESY AND IT IS THE CLIENTS AND/OR THE CLIENTS REPRESENTATIVES (INCLUDING BUT NOT LIMITED TO GENERAL CONTRACTOR AND/OR ARCHITECT) RESPONSIBILITY TO FIELD VERIFY ALL DIMENSIONS / INFORMATION FOR ACCURACY. EMPIRE OFFICE SHALL BE HELD HARMLESS OF ANY ERRORS, OMISSIONS OR DISCREPANCIES.

(NOT FOR ARCHITECTURAL PURPOSES)

Victory Polymers

Floor Plan

XXX

[Ship to, Address, Line #1]

[Ship to, Address, City]

EMPIRE
OFFICE





NEW YORK - HEADQUARTERS 654 Madison Avenue, FL 14 New York, NY 10065
212.607.5500
HOLLYWOOD 2 Oakwood Blvd, Suite 140 Hollywood, FL 33020 954.707.6200
ORLANDO 110 Hillcrest Street, Orlando, FL 32801 407.626.2400
TAMPA 1000 N Ashley Dr, Suite 130 Tampa, FL 33602 813.543.5050
SECAUCUS 1000 New County Rd, Unit A Secaucus, NJ 07094 212.607.5502
ALPHARETTA 1320 Ridgeland Pkwy Alpharetta, GA 30004 770.360.0200
BIRMINGHAM 112 28th St S Birmingham, AL 35233 205.935.9100
Florida License No: IB26001451
www.empireoffice.com

DWN BY:	JL	REV	DWN	DATE
CHK BY:	JL			
DATE:	04/27/23			
SCALE:	AS NOTED			
PROJECT:	000000			
APPROVED BY:				

SHEET NUMBER:
XF-X.X.X

PLAN VIEW

SCALE: AS NOTED

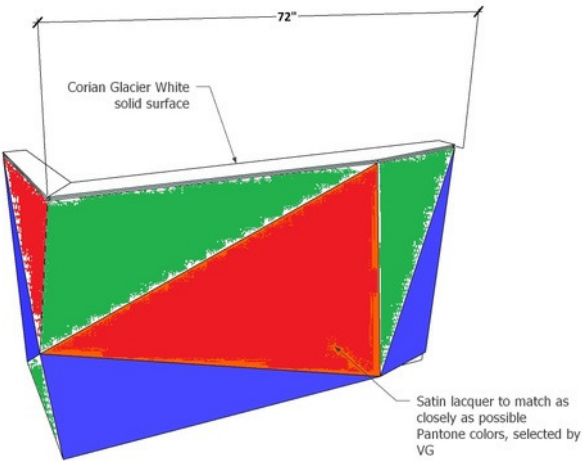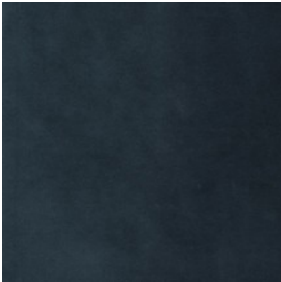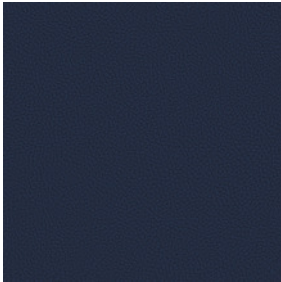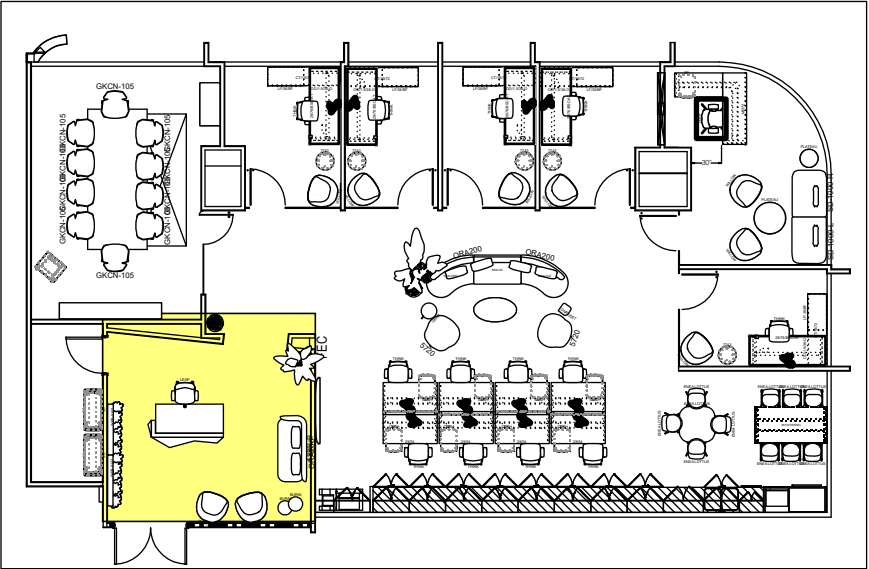

ISOMETRIC VIEW

NTS



EMPIRE OFFICE SHALL NOT BE HELD LIABLE FOR ANY ERRORS, OMISSIONS OR DISCREPANCIES THAT MAY OCCUR FROM THE USE OF THESE PLANS. FIELD VERIFICATION REQUIRED BY OTHERS FOR ACCURACY. THESE ARE NOT AND SHALL NOT BE USED FOR PERMIT AND/OR CONSTRUCTION PURPOSES. THESE ELECTRICAL PLANS ARE FOR FURNITURE REFERENCE ONLY AND SHALL NOT BE COPIED OR DISTRIBUTED WITHOUT A WRITTEN AUTHORIZATION FROM EMPIRE OFFICE.

ALL ELECTRICAL INFORMATION IS PROVIDED AS A COURTESY AND IT IS THE CLIENTS REPRESENTATIVES (INCLUDING BUT NOT LIMITED TO GENERAL CONTRACTOR AND/OR ARCHITECT) RESPONSIBILITY TO FIELD VERIFY ALL DIMENSIONS / INFORMATION FOR ACCURACY. EMPIRE OFFICE SHALL BE HELD HAMRELESS OF ANY ERRORS, OMISSIONS OR DISCREPANCIES.

(NOT FOR ARCHITECTURAL PURPOSES)

Victory Polymers

Reception Area

XXX

[Ship to, Address, Line #1]

[Ship to, Address, City]

NEW YORK - HEADQUARTERS 654 Madison Avenue, FL 14 New York, NY 10065
212.607.5500
HOLLYWOOD 2 Oakwood Blvd, Suite 140 Hollywood, FL 33020 954.707.6200
ORLANDO 110 Hillcrest Street Orlando, FL 32801 407.626.2400
TAMPA 1000 N Ashley Dr, Suite 130 Tampa, FL 33602 813.543.5050
SECAUCUS 1000 New County Rd, Unit A Secaucus, NJ 07094 212.607.5502
ALPHARETTA 1320 Ridgeland Pkwy Alpharetta, GA 30004 770.360.0200
BIRMINGHAM 112 26th St S Birmingham, AL 35233 205.933.9100

EMPIRE
OFFICE

Florida License No: IB26001451

www.empireoffice.com

DWN BY:	JD	REV	DWN	DATE
CHK BY:	JPopoles			
DATE:	04/27/23			
SCALE:	AS NOTED			
PROJECT NO:	000000			
APPROVED BY:				

SHEET NUMBER:
XF-X.X.X

PLAN VIEW

SCALE: AS NOTED


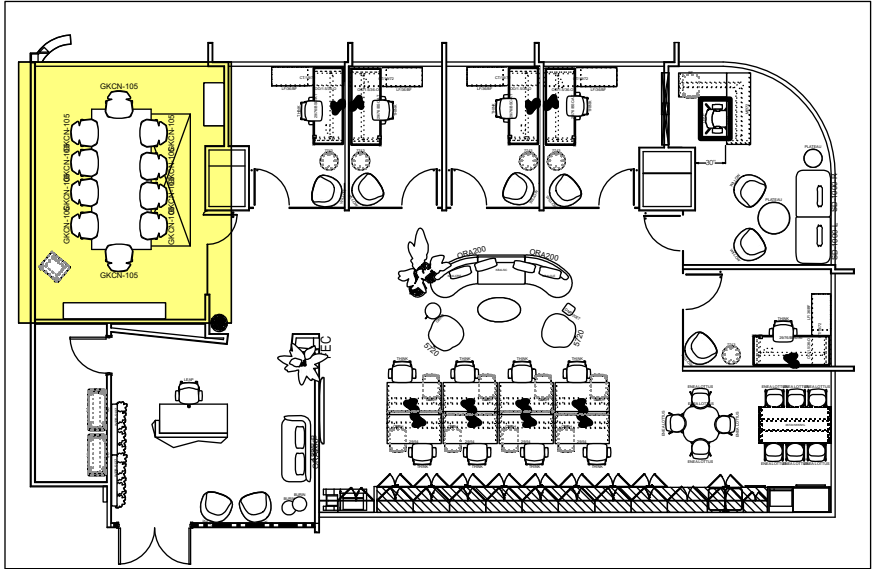


Table top



Chair

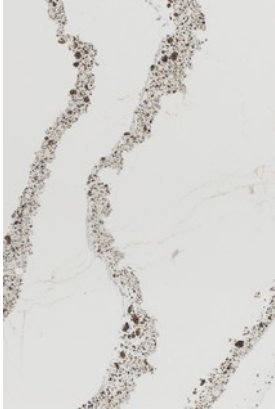

Leather



or




Fabric

Back of chair



ISOMETRIC VIEW

NTS

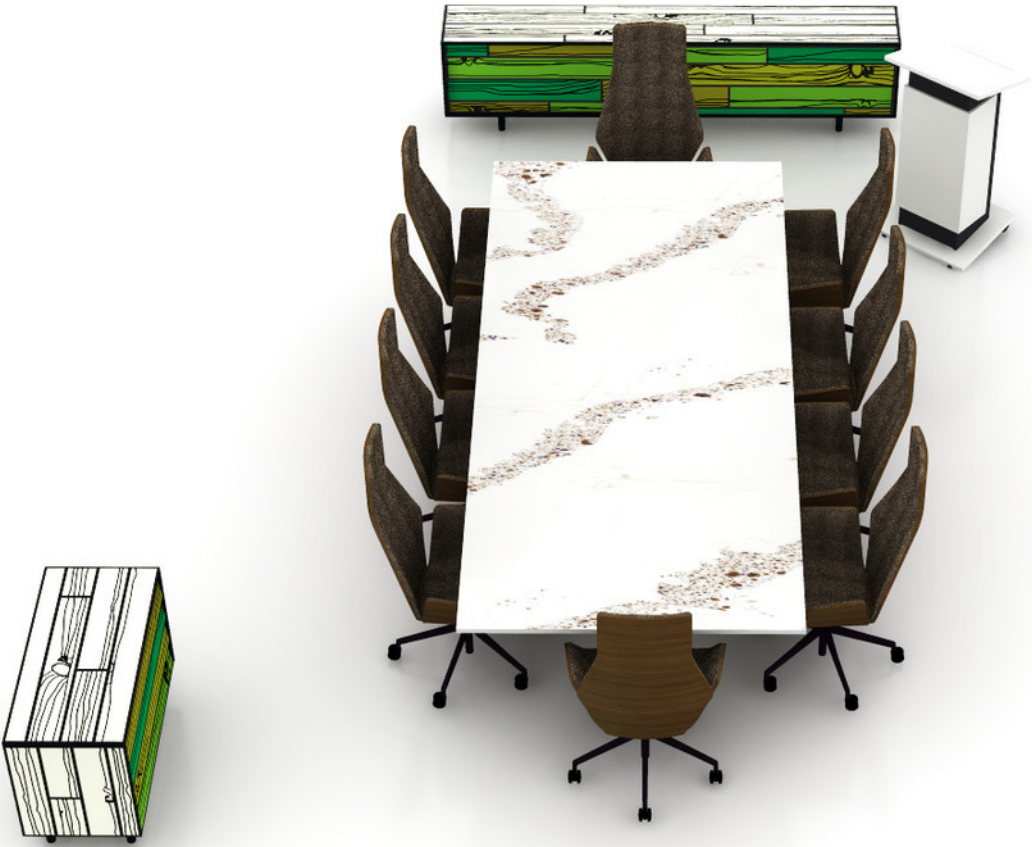

EMPIRE OFFICE SHALL NOT BE HELD LIABLE FOR ANY ERRORS, OMISSIONS OR DISCREPANCIES THAT MAY OCCUR FROM THE USE OF THESE PLANS. FIELD VERIFICATION REQUIRED BY OTHERS FOR ACCURACY. THESE ARE NOT AND SHALL NOT BE USED FOR PERMIT AND/OR CONSTRUCTION PURPOSES. THESE ELECTRICAL PLANS ARE FOR FURNITURE REFERENCE ONLY AND SHALL NOT BE COPIED OR DISTRIBUTED WITHOUT A WRITTEN AUTHORIZATION FROM EMPIRE OFFICE.

ALL ELECTRICAL INFORMATION IS PROVIDED AS A COURTESY AND IT IS THE CLIENTS AND/OR THE CLIENTS REPRESENTATIVES (INCLUDING BUT NOT LIMITED TO GENERAL CONTRACTOR AND/OR ARCHITECT) RESPONSIBILITY TO FIELD VERIFY ALL DIMENSIONS / INFORMATION FOR ACCURACY. EMPIRE OFFICE SHALL BE HELD HARMLESS OF ANY ERRORS, OMISSIONS OR DISCREPANCIES.

(NOT FOR ARCHITECTURAL PURPOSES)

Victory Polymers

Board Room

XXX

[Ship to, Address, Line #1]

[Ship to, Address, City]



DWN BY:	JL	REV	DWN	DATE
CHK BY:	JPopoles			
DATE:	04/27/23			
SCALE:	AS NOTED			
PROJECT NO:	000000			
APPROVED BY:				

EMPIRE OFFICE

NEW YORK - HEADQUARTERS 654 Madison Avenue, FL 14 New York, NY 10065
212.607.5500
HOLLYWOOD 2 Oakwood Blvd, Suite 140 Hollywood, FL 33020 954.707.6200
ORLANDO 110 Hillcrest Street Orlando, FL 32801 407.626.2400
TAMPA 1000 N Ashley Dr, Suite 130 Tampa, FL 33602 813.543.5050
SECAUCUS 1000 New County Rd, Unit A Secaucus, NJ 07094 212.607.5502
ALPHARETTA 1320 Ridgeland Pkwy Alpharetta, GA 30004 770.360.0200
BIRMINGHAM 112 26th St S Birmingham, AL 35233 205.935.9100
Florida License No: IB26001451
www.empireoffice.com

PLAN VIEW

SCALE: AS NOTED

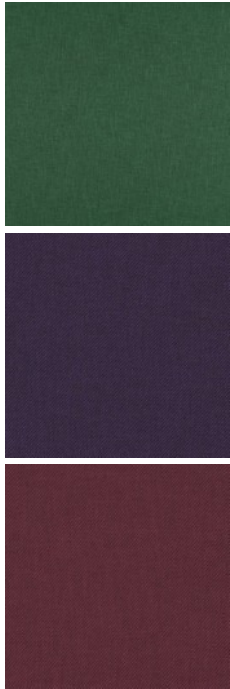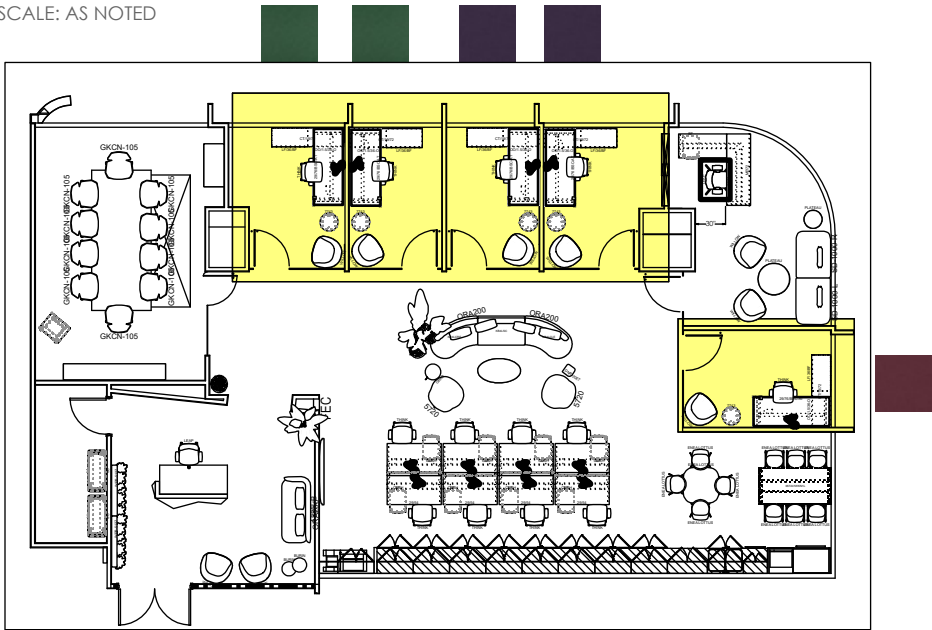

ISOMETRIC VIEW

NTS



EMPIRE OFFICE SHALL NOT BE HELD LIABLE FOR ANY ERRORS, OMISSIONS OR DISCREPANCIES THAT MAY OCCUR FROM THE USE OF THESE PLANS. FIELD VERIFICATION REQUIRED BY OTHERS FOR ACCURACY. THESE ARE NOT AND SHALL NOT BE USED FOR PERMIT AND/OR CONSTRUCTION PURPOSES. THESE ELECTRICAL PLANS ARE FOR FURNITURE REFERENCE ONLY AND SHALL NOT BE COPIED OR DISTRIBUTED WITHOUT A WRITTEN AUTHORIZATION FROM EMPIRE OFFICE.

ALL ELECTRICAL INFORMATION IS PROVIDED AS A COURTESY AND IT IS THE CLIENTS AND/OR THE CLIENTS REPRESENTATIVES (INCLUDING BUT NOT LIMITED TO GENERAL CONTRACTOR AND/OR ARCHITECT) RESPONSIBILITY TO FIELD VERIFY ALL DIMENSIONS / INFORMATION FOR ACCURACY. EMPIRE OFFICE SHALL BE HELD HARMLESS OF ANY ERRORS, OMISSIONS OR DISCREPANCIES.

(NOT FOR ARCHITECTURAL PURPOSES)

NEW YORK - HEADQUARTERS 654 Madison Avenue, FL 14 New York, NY 10065
212.607.5500
HOLLYWOOD 2 Oakwood Blvd, Suite 140 Hollywood, FL 33020 954.707.6200
ORLANDO 110 Hillcrest Street Orlando, FL 32801 407.626.2400
TAMPA 1000 N Ashley Dr, Suite 130 Tampa, FL 33602 813.543.5050
SECAUCUS 1000 New County Rd, Unit A Secaucus, NJ 07094 212.607.5502
ALPHARETTA 1320 Ridgeland Pkwy Alpharetta, GA 30004 770.360.0200
BIRMINGHAM 112 26th St S Birmingham, AL 35233 205.933.9100

EMPIRE
OFFICE

Florida License No: IB26001451
www.empireoffice.com


DWN BY:	JL	REV	DWN	DATE
CHK BY:	JL	PROFILES		
DATE:	04/27/23			
SCALE:	AS NOTED			
PROJECT NO:	000000			
APPROVED BY:				

Victory Polymers
Private Offices
XXX
[Ship to, Address, Line #1]
[Ship to, Address, City]

SHEET NUMBER:
XF-X.X.X

PLAN VIEW

SCALE: AS NOTED

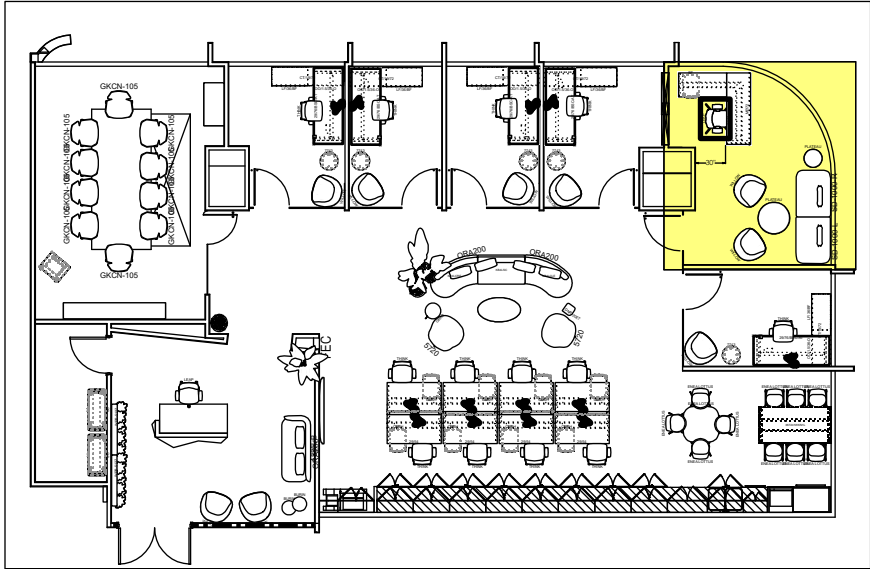

or



or



ISOMETRIC VIEW

NTS



EMPIRE OFFICE

Victory Polymers
Executive Office
XXX

SHEET NUMBER:
XF-X.X.X

[Ship to, Address, Line #1]

[Ship to, Address, City]

DWN BY:	JL
CHK BY:	JL
DATE:	04/27/23
SCALE:	AS NOTED
PROJECT NO:	000000
APPROVED BY:	



EMPIRE OFFICE

NEW YORK - HEADQUARTERS 654 Madison Avenue, FL 14 New York, NY 10065
212.607.5500
HOLLYWOOD 2 Oakwood Blvd, Suite 140 Hollywood, FL 33020 954.707.6200
ORLANDO 110 Hillcrest Street, Orlando, FL 32801 407.626.2400
TAMPA 1000 N Ashley Dr, Suite 130 Tampa, FL 33602 813.543.5050
SECAUCUS 1000 New County Rd, Unit A Secaucus, NJ 07094 212.607.5502
ALPHARETTA 1320 Ridgeland Pkwy Alpharetta, GA 30004 770.360.0200
BIRMINGHAM 112 26th St S Birmingham, AL 35233 205.935.9100
Florida License No: IB26001451
www.empireoffice.com

(NOT FOR ARCHITECTURAL PURPOSES)

PLAN VIEW

SCALE: AS NOTED

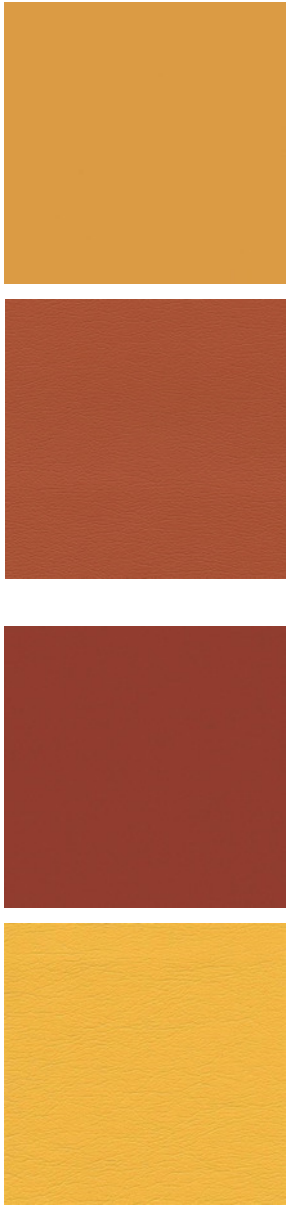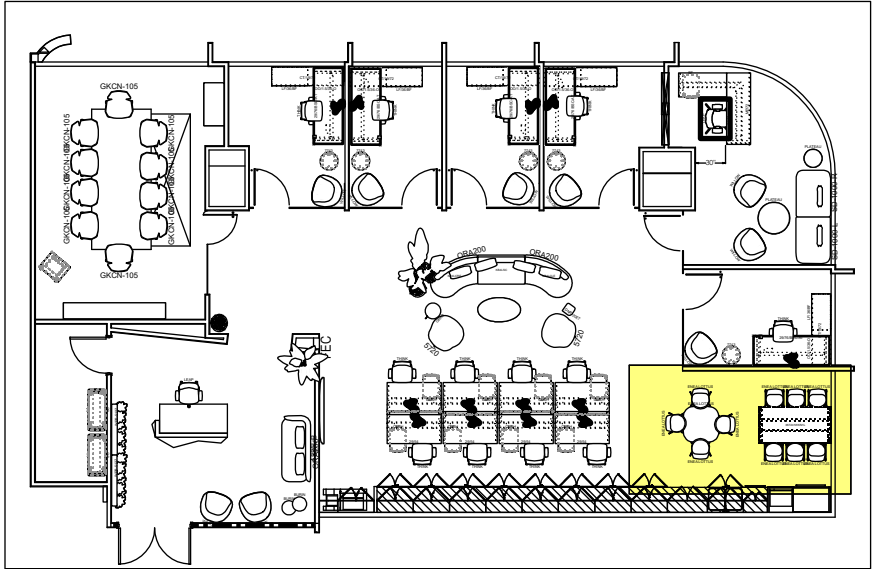

ISOMETRIC VIEW

NTS



EMPIRE OFFICE SHALL NOT BE HELD LIABLE FOR ANY ERRORS, OMISSIONS OR DISCREPANCIES THAT MAY OCCUR FROM THE USE OF THESE PLANS. FIELD VERIFICATION REQUIRED BY OTHERS FOR ACCURACY. THESE ARE NOT AND SHALL NOT BE USED FOR PERMIT AND/OR CONSTRUCTION PURPOSES. THESE ELECTRICAL PLANS ARE FOR FURNITURE REFERENCE ONLY AND SHALL NOT BE COPIED OR DISTRIBUTED WITHOUT A WRITTEN AUTHORIZATION FROM EMPIRE OFFICE.

ALL ELECTRICAL INFORMATION IS PROVIDED AS A COURTESY AND IT IS THE CLIENTS AND/OR THE CLIENTS REPRESENTATIVES (INCLUDING BUT NOT LIMITED TO GENERAL CONTRACTOR AND/OR ARCHITECT) RESPONSIBILITY TO FIELD VERIFY ALL DIMENSIONS / INFORMATION FOR ACCURACY. EMPIRE OFFICE SHALL BE HELD HARMLESS OF ANY ERRORS, OMISSIONS OR DISCREPANCIES.

(NOT FOR ARCHITECTURAL PURPOSES)

NEW YORK - HEADQUARTERS 654 Madison Avenue, FL 14 New York, NY 10065
212.607.5500
HOLLYWOOD 2 Oakwood Blvd, Suite 140 Hollywood, FL 33020 954.707.6200
ORLANDO 110 Hillcrest Street Orlando, FL 32801 407.626.2400
TAMPA 1000 N Ashley Dr, Suite 130 Tampa, FL 33602 813.543.5050
SECAUCUS 1000 New County Rd, Unit A Secaucus, NJ 07094 212.607.5502
ALPHARETTA 1320 Ridgeland Pkwy Alpharetta, GA 30004 770.360.0200
BIRMINGHAM 112 26th St S Birmingham, AL 35233 205.935.9100

EMPIRE
OFFICE

Florida License No: IB26001451
www.empireoffice.com


DWN BY:	JL	REV	DATE
CHK BY:	Propoles		
DATE:	04/27/23		
SCALE:	AS NOTED		
PROJECT NO:	000000		
APPROVED BY:			

Victory Polymers
Breakroom/ Kitchen
XXX
[Ship to, Address, Line #1] [Ship to, Address, City]


SHEET NUMBER:
XF-X.X.X

PLAN VIEW


SCALE: AS NOTED

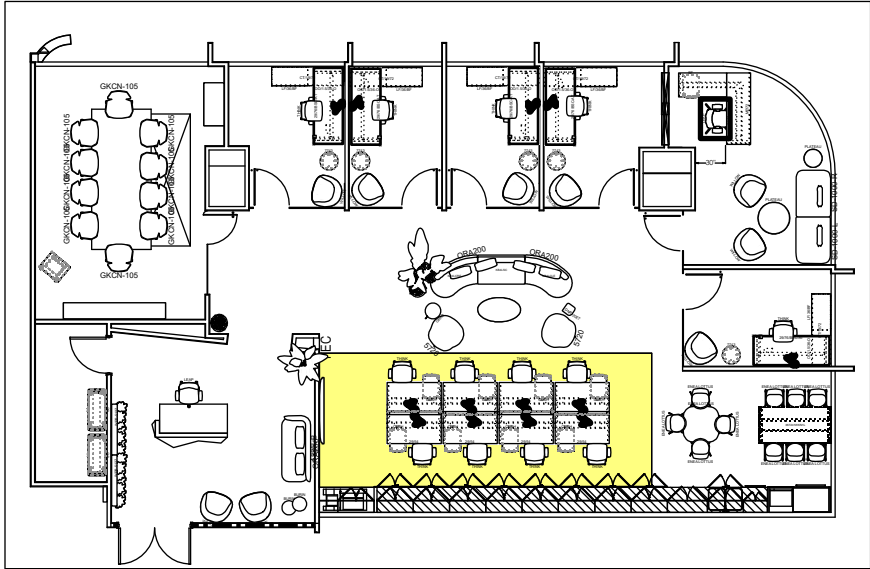

Panel

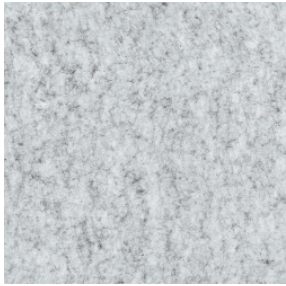

Or

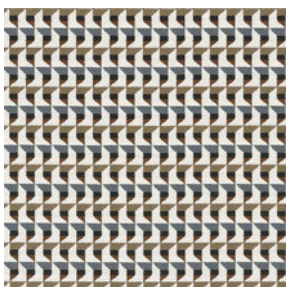

Option 1
Felt Panel: 18" High

ISOMETRIC VIEW

NTS



Option 2
Fabric Panel: 37" High
Mounted on benching system

EMPIRE OFFICE SHALL NOT BE HELD LIABLE FOR ANY ERRORS, OMISSIONS OR DISCREPANCIES THAT MAY OCCUR FROM THE USE OF THESE PLANS. FIELD VERIFICATION REQUIRED BY OTHERS FOR ACCURACY. THESE ARE NOT AND SHALL NOT BE USED FOR PERMIT AND/OR CONSTRUCTION PURPOSES. THESE ELECTRICAL PLANS ARE FOR FURNITURE REFERENCE ONLY AND SHALL NOT BE COPIED OR DISTRIBUTED WITHOUT A WRITTEN AUTHORIZATION FROM EMPIRE OFFICE.

ALL ELECTRICAL INFORMATION IS PROVIDED AS A COURTESY AND IT IS THE CLIENTS AND/OR THE CLIENTS REPRESENTATIVES (INCLUDING BUT NOT LIMITED TO GENERAL CONTRACTOR AND/OR ARCHITECT) RESPONSIBILITY TO FIELD VERIFY ALL DIMENSIONS / INFORMATION FOR ACCURACY. EMPIRE OFFICE SHALL BE HELD HARMLESS OF ANY ERRORS, OMISSIONS OR DISCREPANCIES.

(NOT FOR ARCHITECTURAL PURPOSES)

NEW YORK - HEADQUARTERS 654 Madison Avenue, FL 14 New York, NY 10065
212.607.5500
HOLLYWOOD 2 Oakwood Blvd, Suite 140 Hollywood, FL 33020 954.707.6200
ORLANDO 110 Hillcrest Street, Orlando, FL 32801 407.626.2400
TAMPA 1000 N Ashley Dr, Suite 130 Tampa, FL 33602 813.543.5050
SECAUCUS 1000 New County Rd, Unit A Secaucus, NJ 07094 212.607.5502
ALPHARETTA 1320 Ridgeland Pkwy Alpharetta, GA 30004 770.360.0200
BIRMINGHAM 112 26th St S Birmingham, AL 35233 205.863.9100

EMPIRE
OFFICE

Florida License No: IB26001451
www.empireoffice.com


DWN BY:	JL	REV	DWN	DATE
CHK BY:	JL	PROFILES		
DATE:	04/27/23			
SCALE:	AS NOTED			
PROJECT NO:	000000			
APPROVED BY:				

Victory Polymers
Workstations
XXX
[Ship to, Address, Line #1]
[Ship to, Address, City]

SHEET NUMBER:
XF-X.X.X

PLAN VIEW

SCALE: AS NOTED

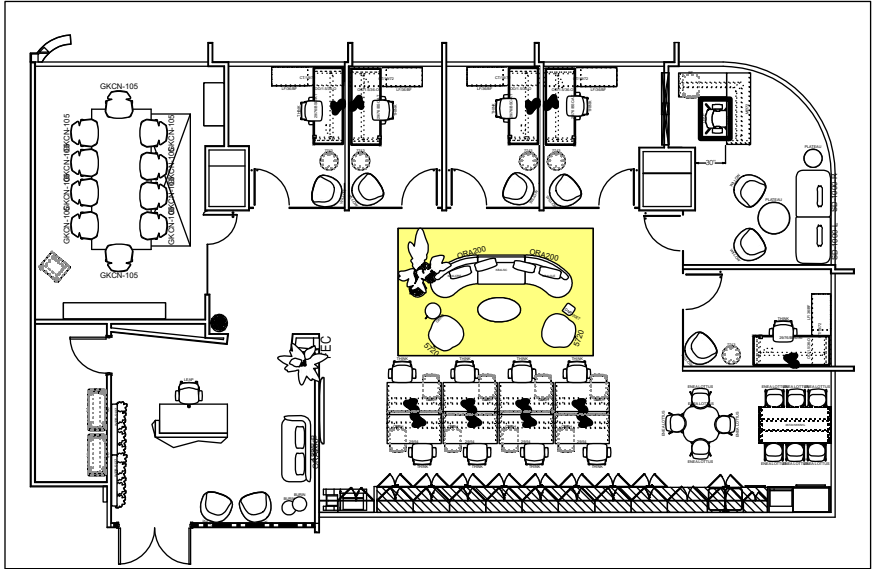

ISOMETRIC VIEW

NTS



Option 1



Option 2

EMPIRE OFFICE SHALL NOT BE HELD LIABLE FOR ANY ERRORS, OMISSIONS OR DISCREPANCIES THAT MAY OCCUR FROM THE USE OF THESE PLANS. FIELD VERIFICATION REQUIRED BY OTHERS FOR ACCURACY. THESE ARE NOT AND SHALL NOT BE USED FOR PERMIT AND/OR CONSTRUCTION PURPOSES. THESE ELECTRICAL PLANS ARE FOR FURNITURE REFERENCE ONLY AND SHALL NOT BE COPIED OR DISTRIBUTED WITHOUT A WRITTEN AUTHORIZATION FROM EMPIRE OFFICE.

ALL ELECTRICAL INFORMATION IS PROVIDED AS A COURTESY AND IT IS THE CLIENTS AND/OR THE CLIENTS REPRESENTATIVES (INCLUDING BUT NOT LIMITED TO GENERAL CONTRACTOR AND/OR ARCHITECT) RESPONSIBILITY TO FIELD VERIFY ALL DIMENSIONS / INFORMATION FOR ACCURACY. EMPIRE OFFICE SHALL BE HELD HAMRLESS OF ANY ERRORS, OMISSIONS OR DISCREPANCIES.

(NOT FOR ARCHITECTURAL PURPOSES)

NEW YORK - HEADQUARTERS 654 Madison Avenue, FL 14 New York, NY 10065
212.607.5500
HOLLYWOOD 2 Oakwood Blvd, Suite 140 Hollywood, FL 33020 954.707.6200
ORLANDO 110 Hillcrest Street Orlando, FL 32801 407.626.2400
TAMPA 1000 N Ashley Dr, Suite 130 Tampa, FL 33602 813.543.5050
SECAUCUS 1000 New County Rd, Unit A Secaucus, NJ 07094 212.607.5502
ALPHARETTA 1320 Ridgeland Pkwy Alpharetta, GA 30004 770.360.0200
BIRMINGHAM 112 26th St S Birmingham, AL 35233 205.863.9100

EMPIRE
OFFICE

Florida License No: IB26001451
www.empireoffice.com

REV	DATE

DWN BY: J2	PROFILES
CHK BY: J2	DATE: 04/27/23
SCALE: AS NOTED	PROJECT NO: 000000
APPROVED BY:	

Victory Polymers
Open Area
XXX
[Ship to, Address, Line #1] [Ship to, Address, City]

SHEET NUMBER:
XF-X.X.X