


BUILDING

SYMBOLS WHERE INDICATED ON THE PLANS

WALL LEGEND

 
- NEW WALL 3/4" STUDS
- PERVIOUS
- EXISTING WALL

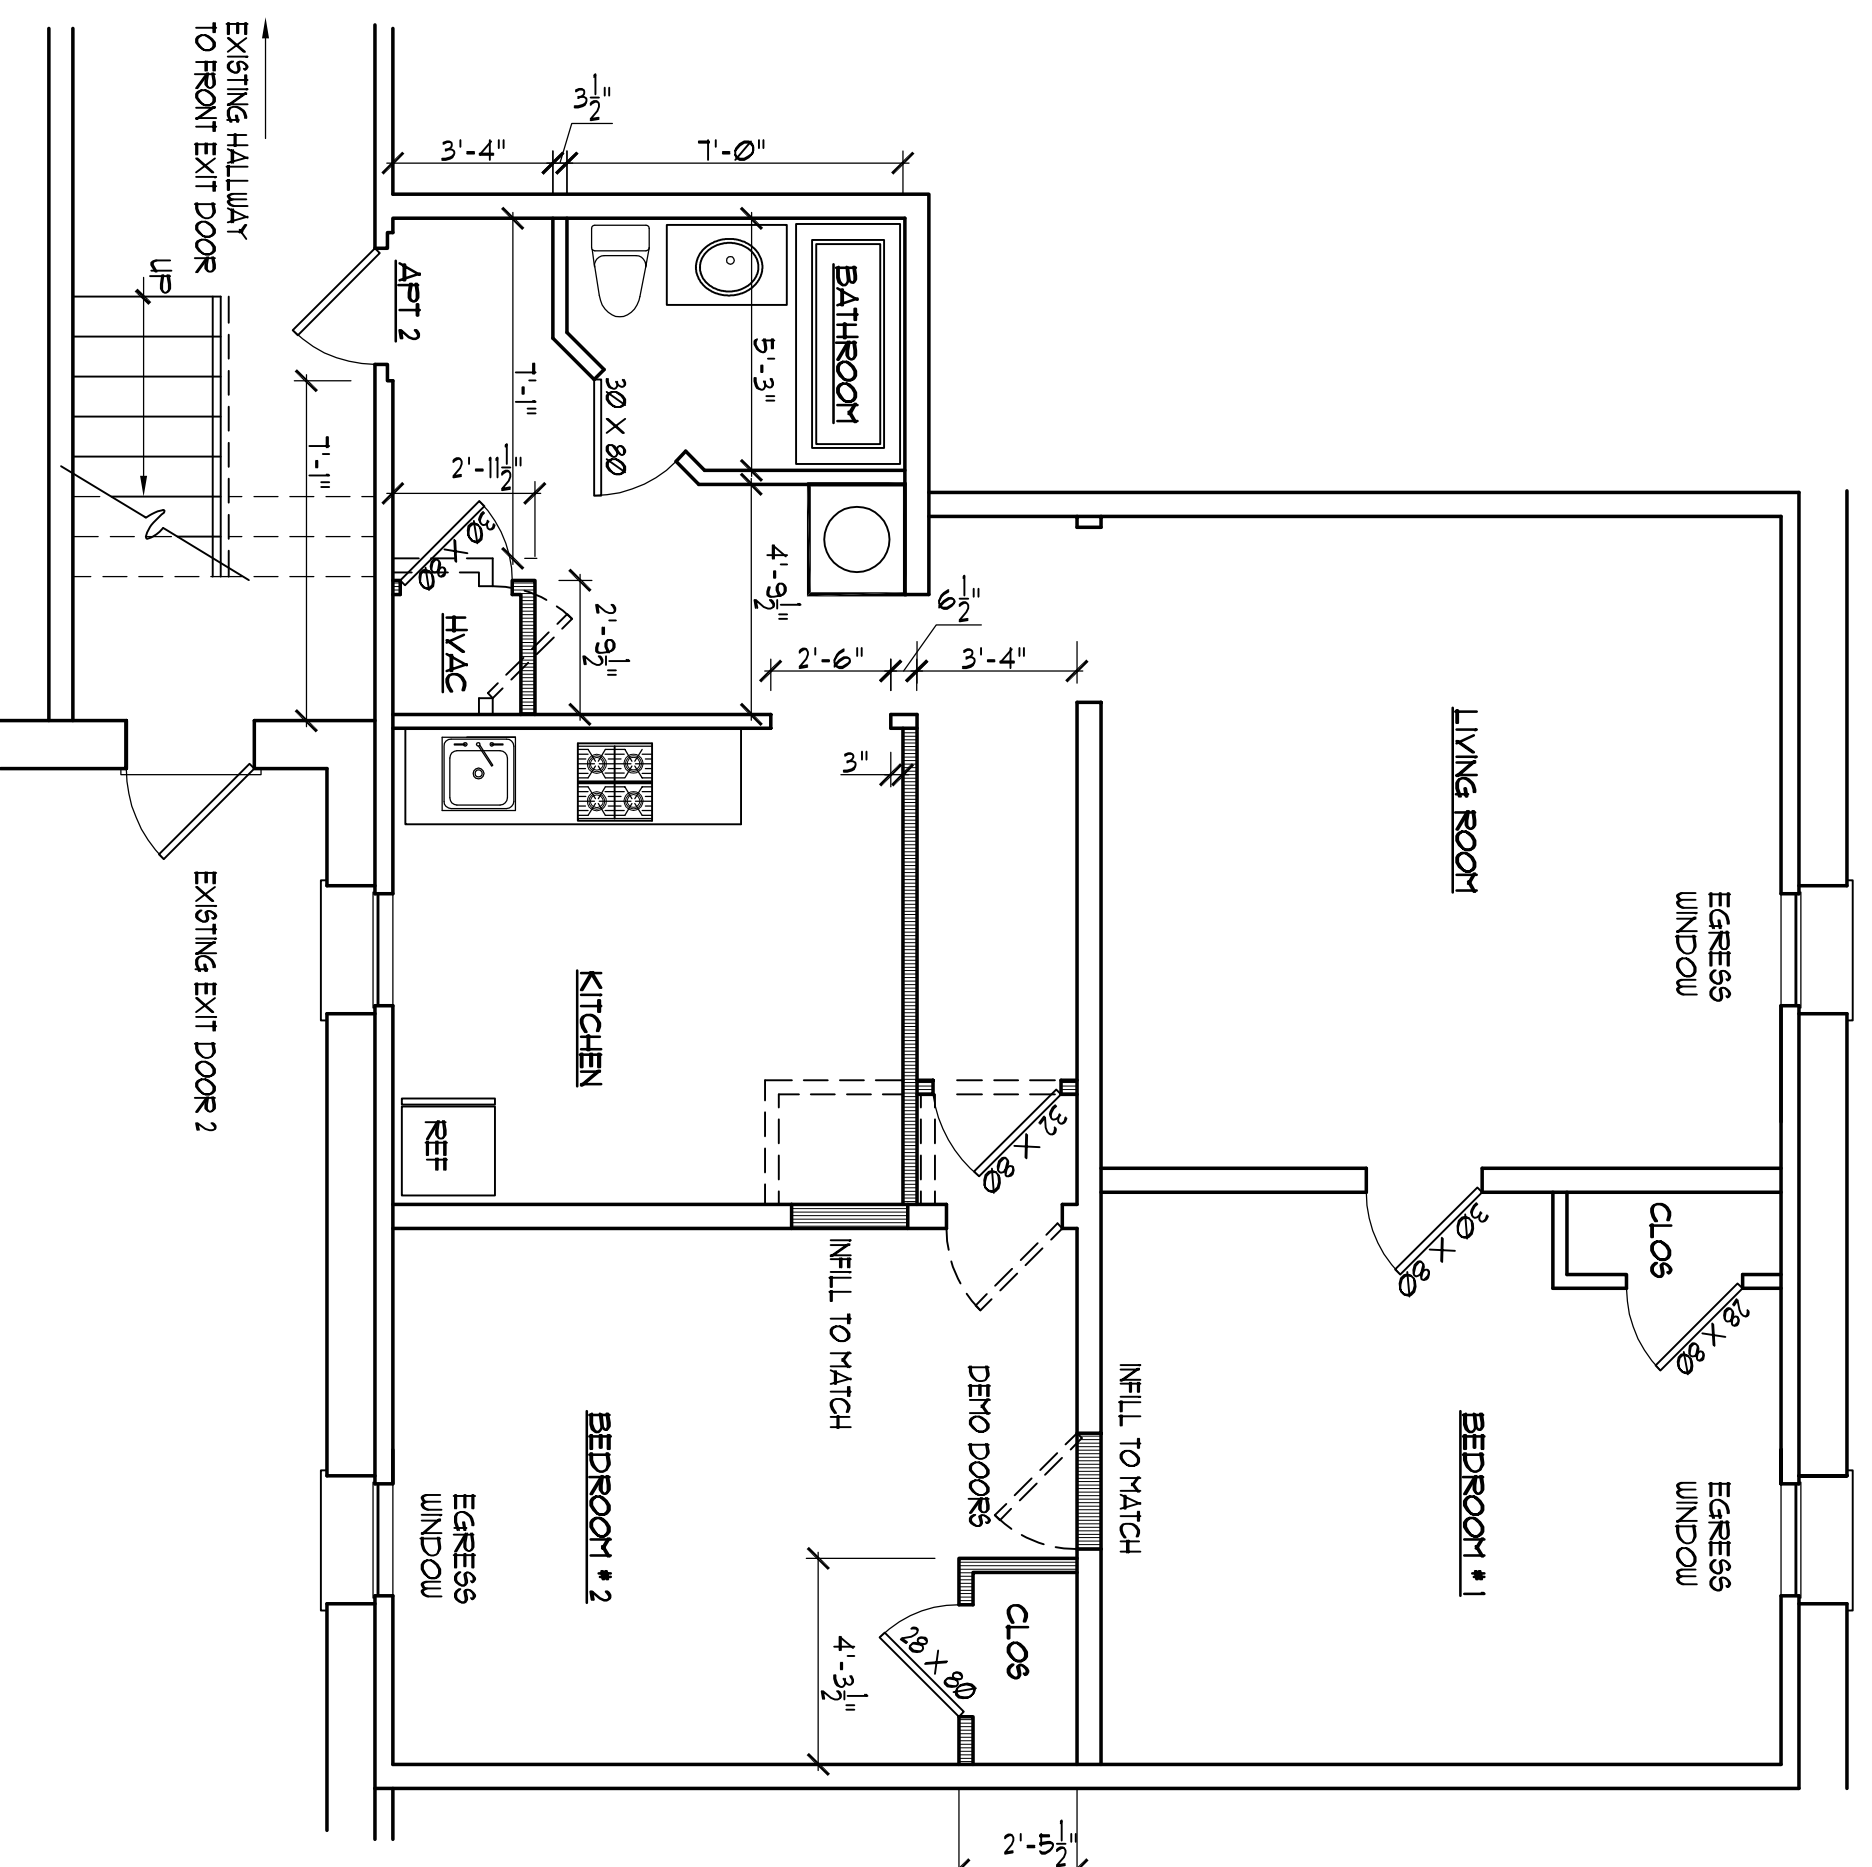

MOST WALLS ARE LOAD BEARING

PROPOSED LAYOUT APARTMENT - 2


SCALE: 1/4" = 1'-0"
Graphic Scale in Feet



ELECTRICAL

SYMBOLS WHERE INDICATED ON THE PLANS


- 1 SINGLE TOGGLE SWITCH
- 2 THREE WAY SWITCH
- 3 DUPE EX OUTLET 15 AMP
- 4 DUPE EX OUTLET 20 AMP
- 5 DUPE EX OUTLET 20 AMP WIRE - 12 AWG
- 6 GROUND FAULT CIRCUIT INTERRUPTER 20 AMP WIRE - 12 AWG
- 7 WATER PROOF CIRCUIT
- 8 EMERGENCY PULL STATION WITH STROBE AND HORN
- 9 EMERGENCY LIGHTING
- 10 ELECTRICAL SUB PANEL
- 11 SMOKE DETECTOR
- 12 SMOKE DETECTOR WITH BATTERY BACKUP
- 13 PHOTOELECTRIC SMOKE DETECTOR
- 14 SMOKE DETECTOR WITH BATTERY BACKUP
- 15 SMOKE DETECTOR WITH BATTERY BACKUP WHEN NOTED
- 16 SMOKE DETECTOR WITH BATTERY BACKUP WHEN NOTED
- 17 SMOKE DETECTOR WITH BATTERY BACKUP WHEN NOTED
- 18 BATHROOM CEILING LIGHT AND RECIRCULATION FAN
- 19 120 CFM
- 20 CEILING MOUNTED 2 BULB FLUORESCENT LIGHTING
- 21 WALL AND CEILING MOUNTED 1 BULB FLUORESCENT LIGHTING
- 22 SMOKE DETECTOR

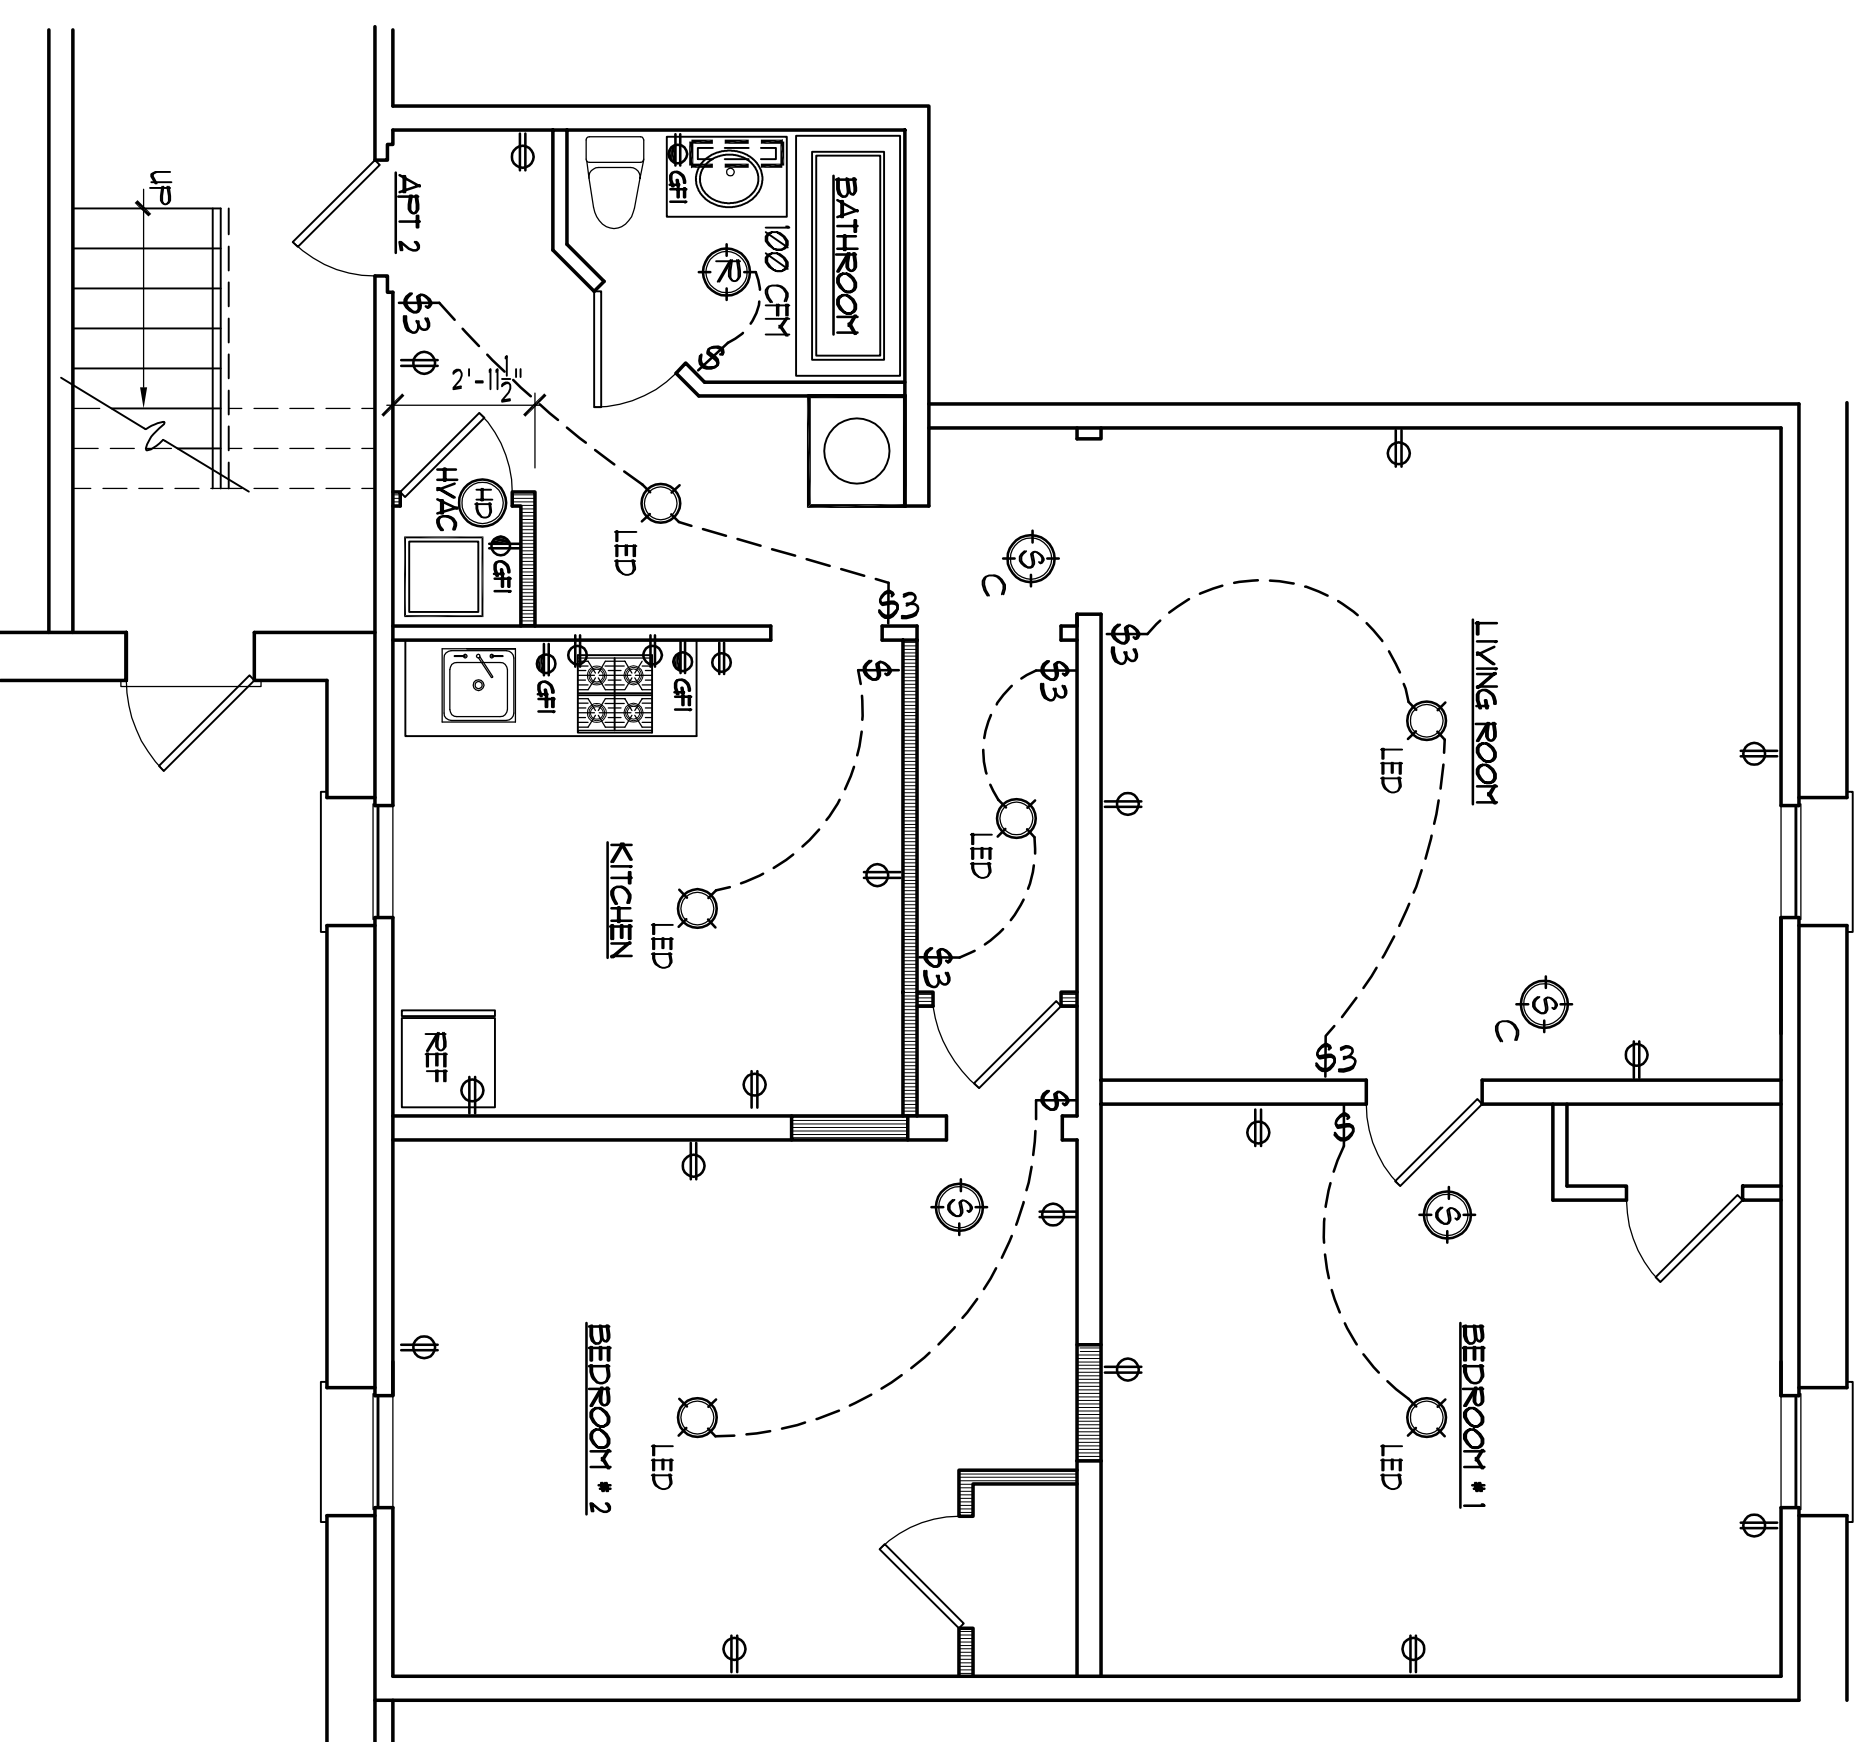

MECHANICAL


SYMBOLS WHERE INDICATED ON THE PLANS

- 1 12" X 12" REGISTER
- 2 6" X 6" SUPPLY REGISTER
- 3 20" X 24" RETURN REGISTER
- 4 2" X 2" REGISTER
- 5 2" X 2" REGISTER
- 6 2" X 2" REGISTER
- 100 2" X 2" REGISTER

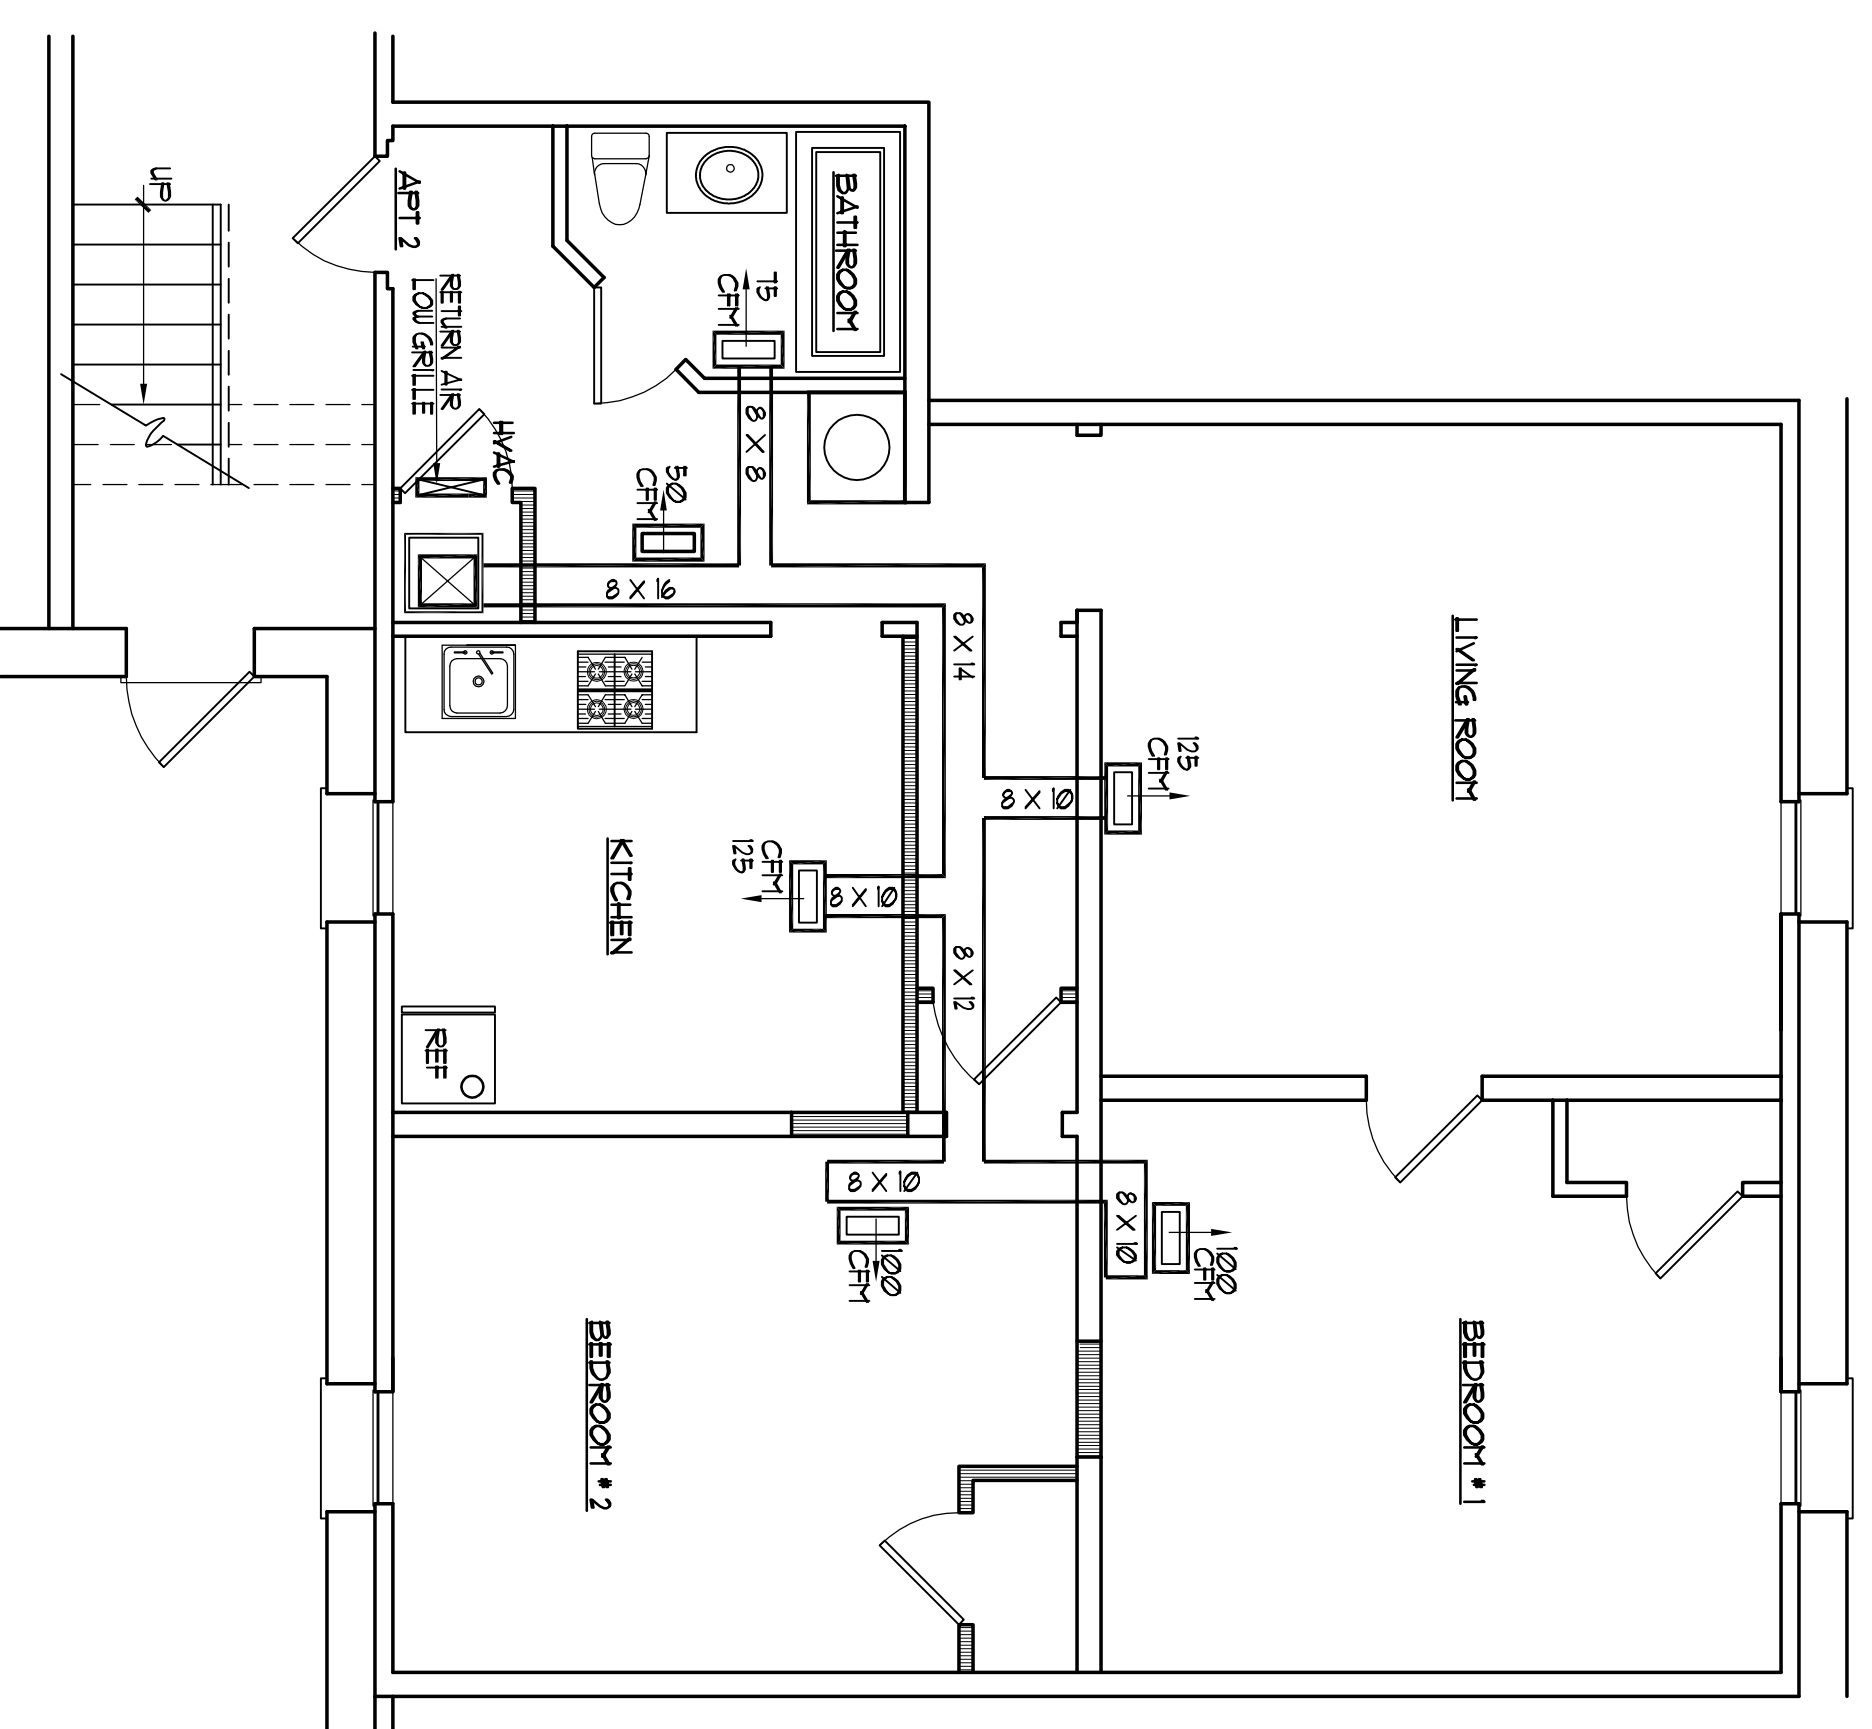

MECHANICAL LAYOUT APARTMENT - 2

 SCALE: 1/4" = 1'-0"
Graphic Scale in Feet



DRAWINGS TITLE
EXISTING AND PROPOSED AND
MECHANICAL FLOOR PLANS
APARTMENT 2

Andre G. Szalay
Architect

THESE DRAWINGS ARE UNLESS OTHERWISE SPECIFIED AND ARE PROTECTED BY COPYRIGHT. THESE DRAWINGS AND DRAWINGS MAY NOT BE REPRODUCED OR TRANSMITTED IN ANY FORM OR BY ANY MEANS WITHOUT PERMISSION FROM THE ARCHITECT.

DESCRIPTION	ISSUED
FIELD MEASURE	3 / 30 / 2024
REVIEW	4 / 1 / 2024
PERMIT	4 / 2 / 2024

CLIENT: 451-51 SPRINGDALE AVE LLC	PROJECT LOCATION: 451-51 SPRINGDALE AVE EAST ORANGE, NEW JERSEY 07101
BLOCK - 563	LOT - 9
ARCHITECTURAL PROJECT NUMBER	027- 024

ARCHITECT STATE & ID NUMBERS
NJ LICENSE # 21A00426200

ANDRE G. SZALAY - RA
CADENCE L. NJ 07071-1884
ANDRE@SZALAYARCHITECT.COM
OFFICE: 908.272.2623
DATE: APR 2, 2024

DRAWING NUMBER
A-1