


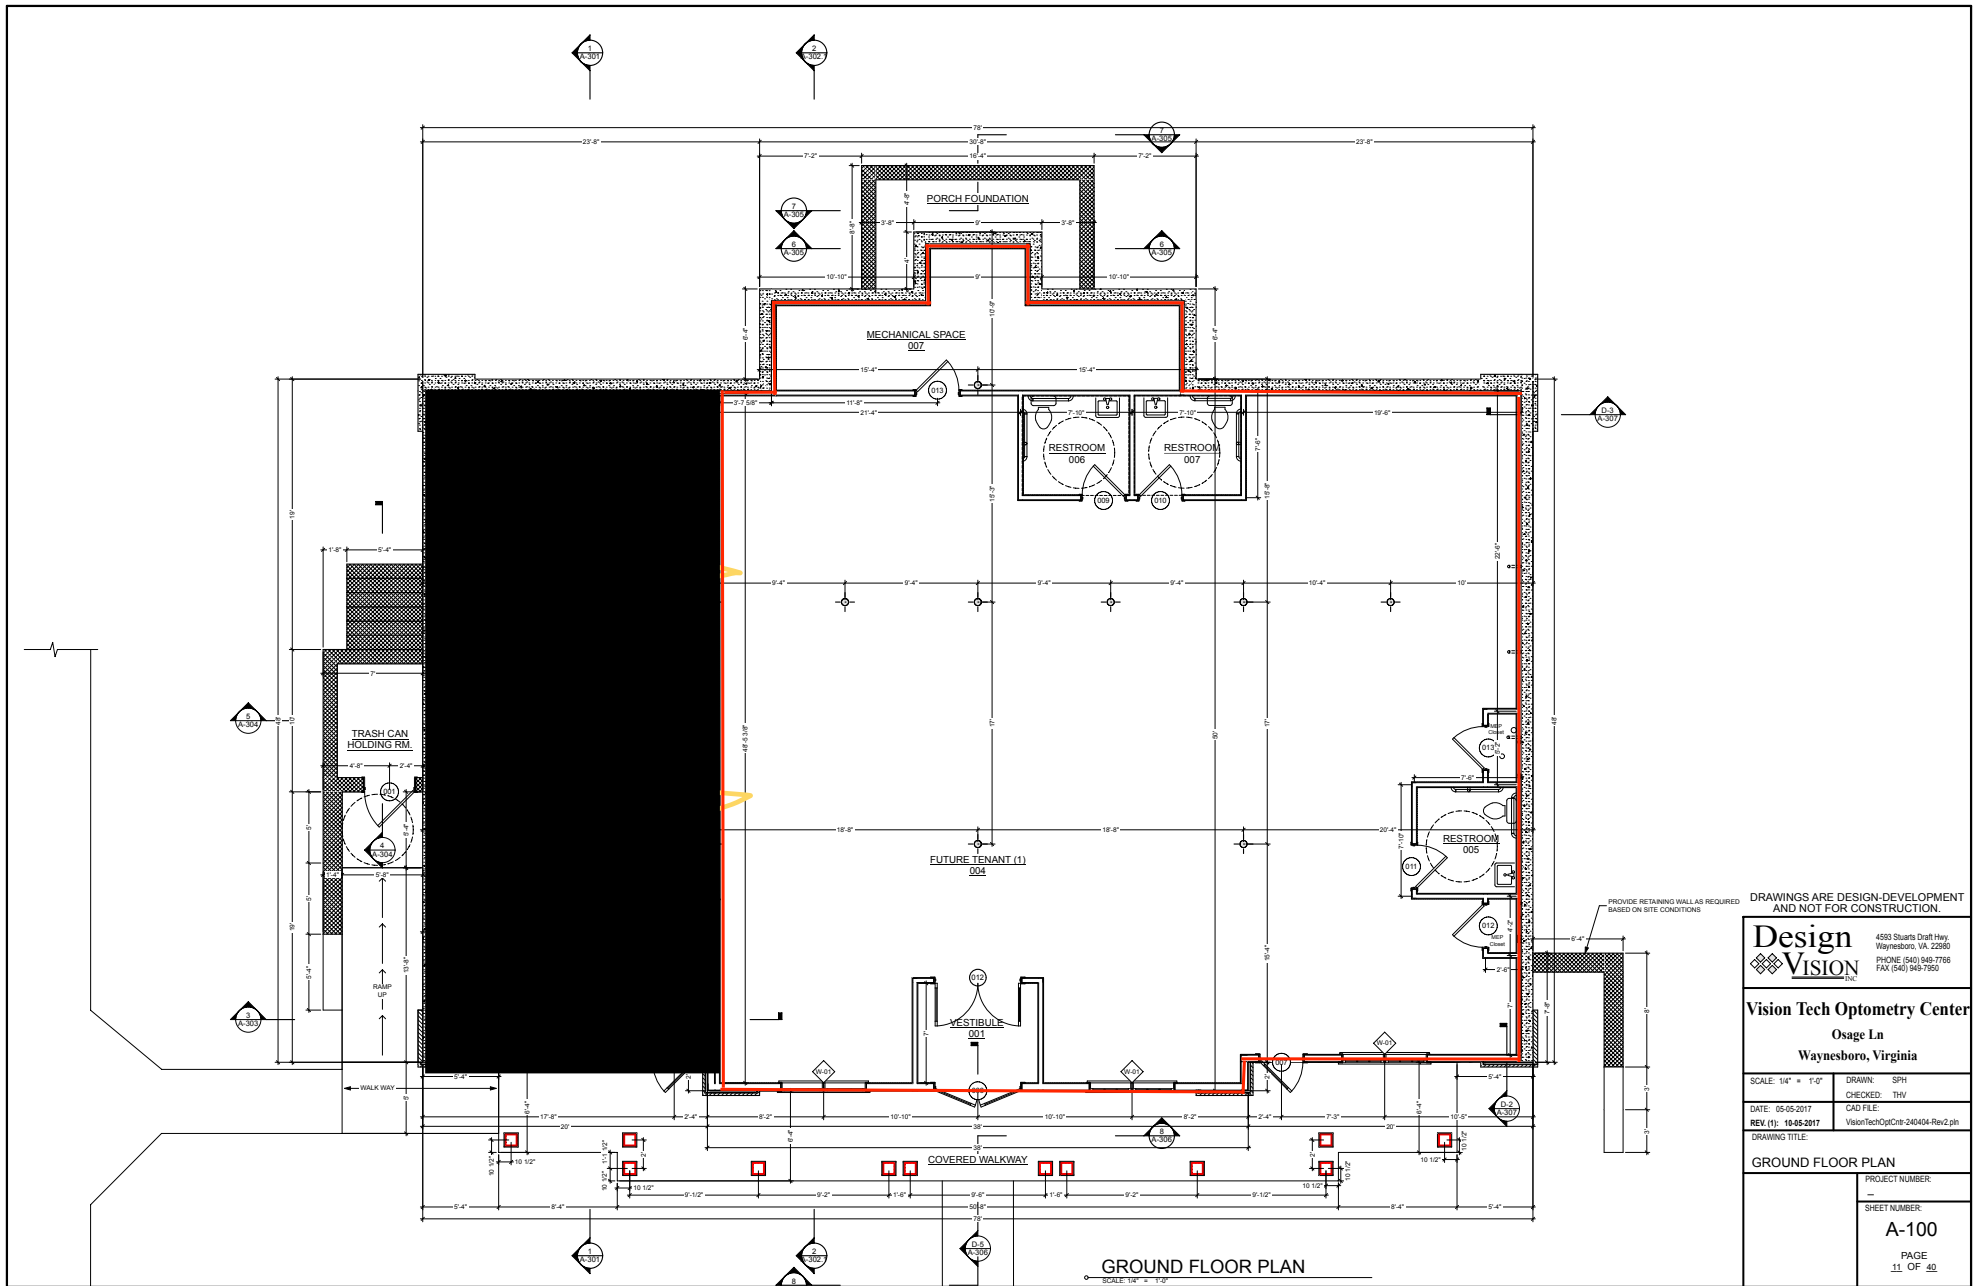

Design VISION 4593 Sharratt Craft Hwy. Waynesboro, VA 22650 PHONE: (540) 949-7766 FAX: (540) 949-7950	
Vision Tech Optometry Center Osage Ln Waynesboro, Virginia	
SCALE: 1/4" = 1'-0" DATE: 05-05-2017 REV (1): 10-05-2017 DRAWING TITLE:	DRAWN: SRH CHECKED: THV CAD FILE: VisionTechOptCntr-240404-Rev2.plt
GROUND FLOOR PLAN	
PROJECT NUMBER: SHEET NUMBER: A-100 PAGE 11 OF 42	