 




FRESH WATER PLUMBING SCHEMATIC  
SCALE: N.T.S.

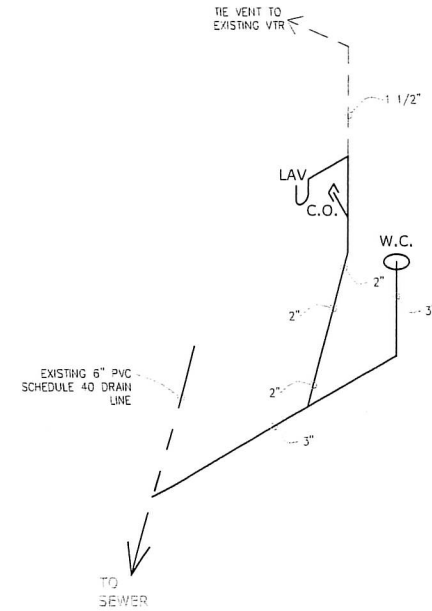


SANITARY DWV PLUMBING SCHEMATIC  
SCALE: N.T.S.

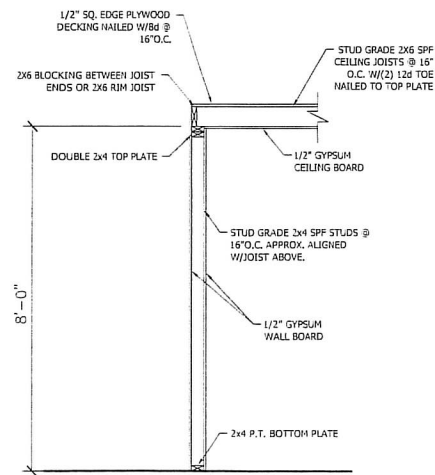

INTERIOR RESTROOM WALL DETAIL  
SCALE: 1/2" = 1'-0"

**SCOPE OF WORK:**  
NEW UNISEX RESTROOM INCLUDING 2X4 FRAMING, 1/2" DRYWALL, ADA FIXTURES/MIRROR/GRAB BARS, SOLID CORE DOOR W/PRIVACY LEVER SET, LED LIGHT FIXTURE, 50 CFM EXHAUST FAN SWITCHED WITH LIGHT, EMERGENCY LIGHT, GFI RECEPT, 2X6 CEILING FRAMING W/DRYWALL FOR CEILING

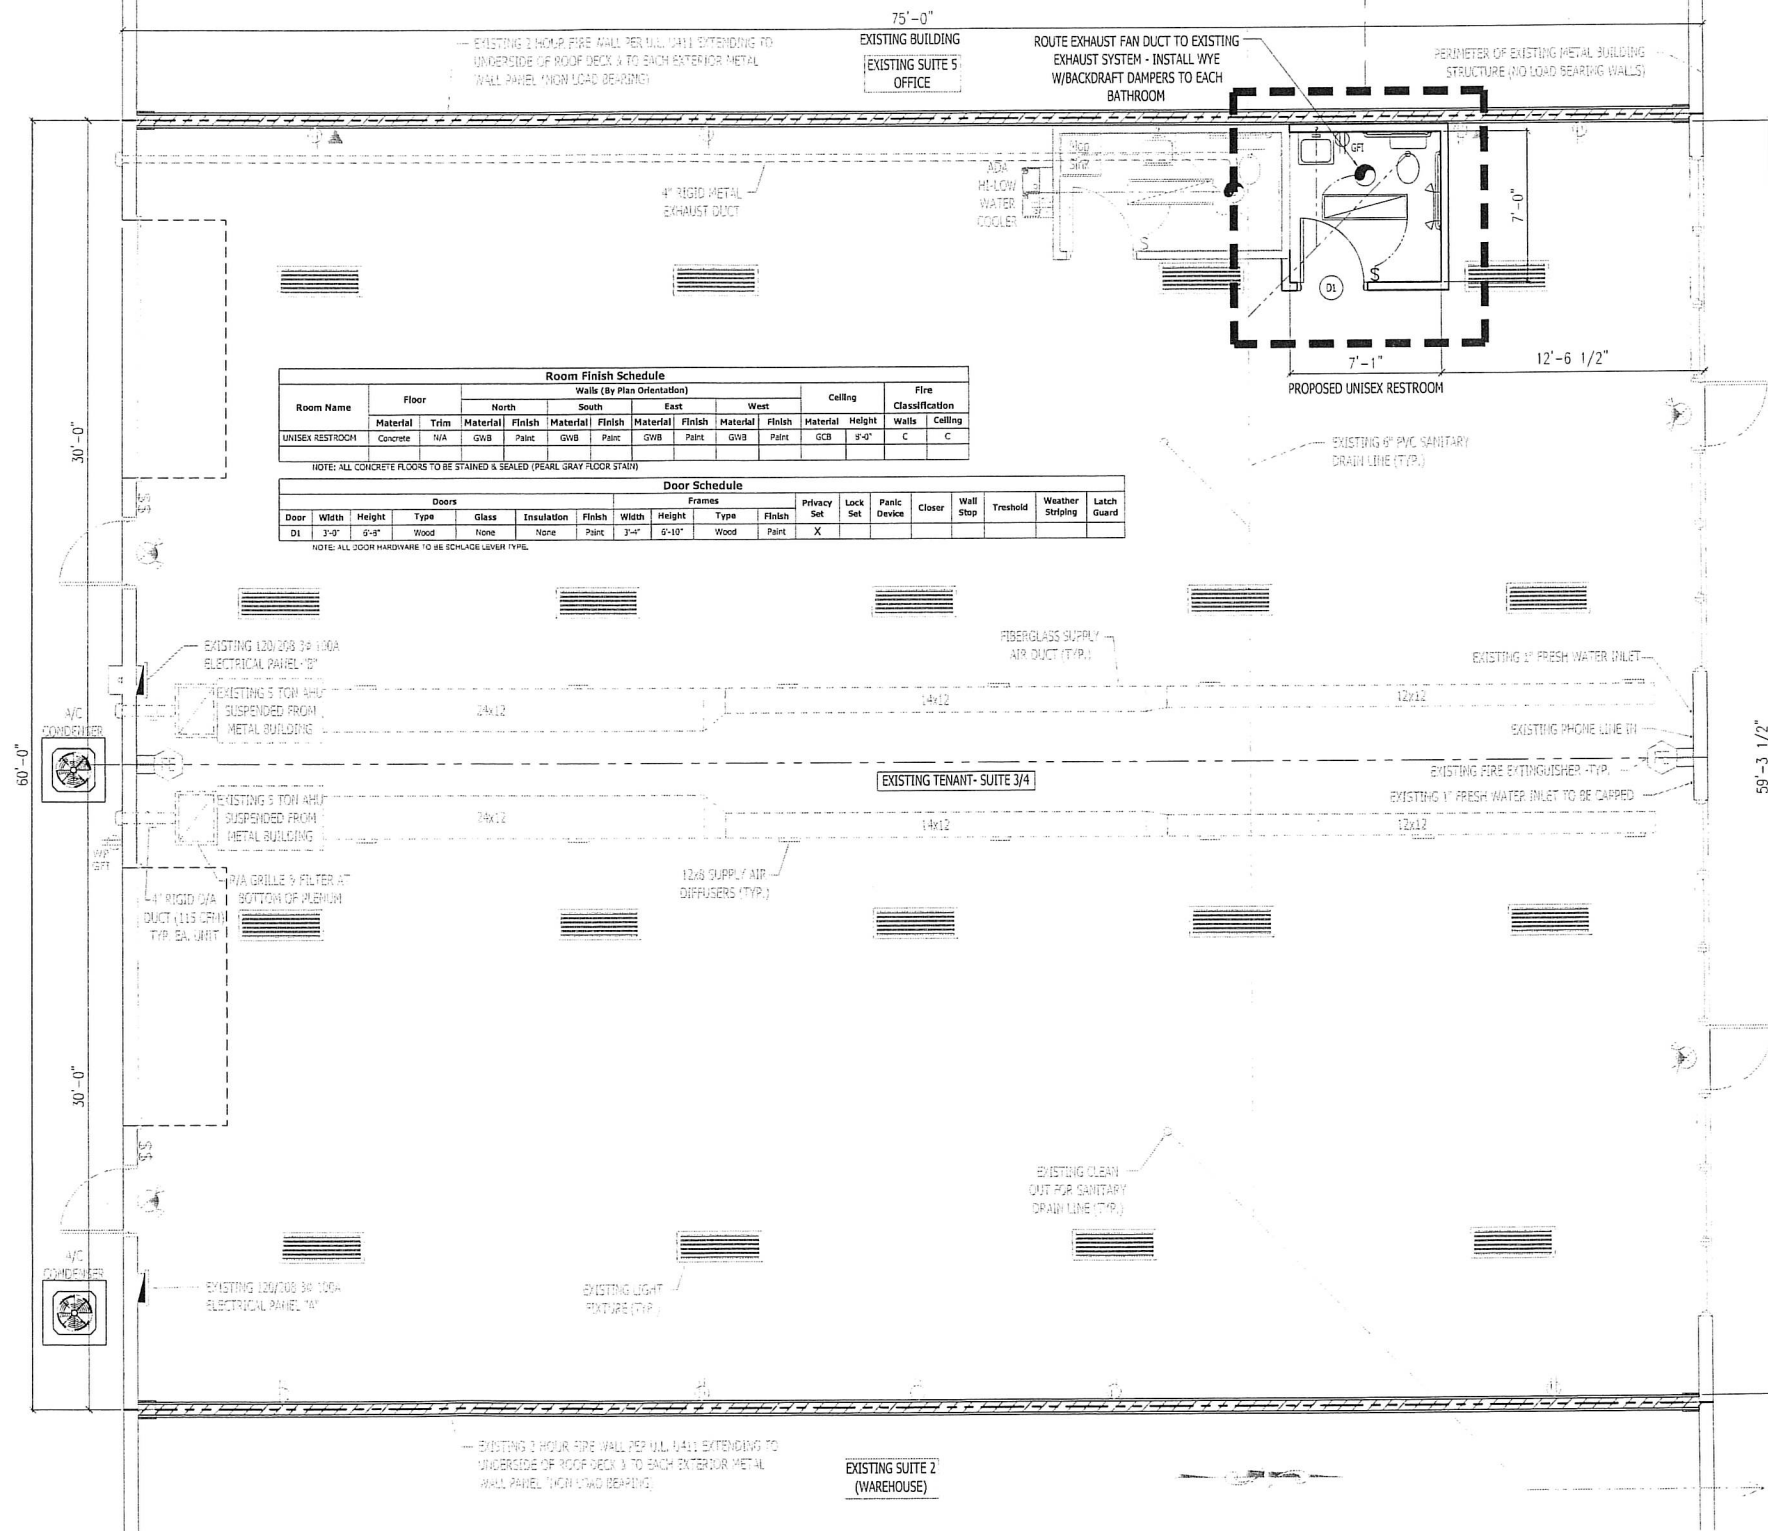

**Room Finish Schedule**

Room Name	Floor	Walls (By Plan Orientation)								Ceiling	Fire Classification			
		North		South		East		West			Walls	Ceiling		
	Material	Trim	Material	Finish	Material	Finish	Material	Finish	Material	Height				
UNISEX RESTROOM	Concrete	N/A	GWB	Paint	GWB	Paint	GWB	Paint	GWB	Paint	GCR	5'-0"	C	C

**Door Schedule**

Door	Doors		Frames								Privacy Set	Lock Set	Panic Device	Closer	Wall Stop	Threshold	Weather Striping	Latch Guard
	Width	Height	Type	Glass	Insulation	Finish	Width	Height	Type	Finish								
DI	3'-0"	6'-8"	Wood	None	None	Paint	3'-4"	6'-10"	Wood	Paint	X							

FLOORPLAN / ELECTRICAL PLAN

Scale: 1/4" = 1'-0"

REVISED: 2021/2  
DATE: 06/08/2021  
BY: RW  
PER PLAN

**MATTHEWS HANNA CONSTRUCTION**  
DESIGN BUILD GENERAL CONTRACTOR  
354 RICHLET ROAD, SUITE 101, LEECSBURG, FL 34748 352.326.0333 vob@mh-c.com 352.326.5178 lds

03 MATTHEWS HANNA CONSTRUCTION, INC. DESIGNER, ENGINEER, ARCHITECT, CONTRACTOR, INSURANCE BROKER, AND OTHER PROFESSIONAL AND TRADE PROGRAMS RIGHTS IN THESE PLANS HAVE BEEN GRANTED AND ARE TO BE REPRODUCED, CHANGED, OR COPIED IN ANY FORM OR MANNER WHATSOEVER WITHOUT FIRST OBTAINING THE EXPRESS WRITTEN PERMISSION OF MATTHEWS HANNA CONSTRUCTION, INC. AND ARE THEY TO BE ASSIGNED TO ANY THIRD PARTY WITHOUT FIRST OBTAINING SAID WRITTEN PERMISSION.

PROPOSED UNISEX RESTROOM FOR:  
BOLIEK ROBERT RICHARD GLENDA C BOLIEK TRUSTEE  
3411 WEST MAIN STREET  
LEECSBURG, FL 34788  
FLOOR/ELECTRICAL/PLUMBING PLAN

A1.0