



DATE: 01/02/23

REVISIONS:

NO.	DESCRIPTION	DATE
1	CITY REV.	02/14/23

REVIEWED BY: Checker

DRAWN BY: Author

DATE: 01/02/23

PROJECT NO. 22-089

SHEET TITLE


LEVEL 1 RCP

SHEET:

A2.6

LIGHTING LEGEND	
DESCRIPTION	
WALL SCANCE A	WALL SCANCE
ACCENT LIGHT O	YARD ACCENT LIGHT
RECESS CAN C	RECESS CAN LIGHT
O	PENDANT LIGHT
2'X4'	FLUORESCENT
EF	EXHAUST FAN
2'X2'	FLUORESCENT
EXIT SIGN	EXIT SIGN
H	EMERGENCY EGRESS
DRYWALL CEILING	DRYWALL CEILING
6'X48" WALL LIGHT	6'X48" WALL LIGHT
K	400 WATT HALIDE LAMP
EM	EMERGENCY LIGHT
E	1'X4' LED SURFACE MOUNTED
VL	VANITY LIGHT
P	PENDANT LIGHT

LIGHTING LEGEND
1/4" = 1'-0"

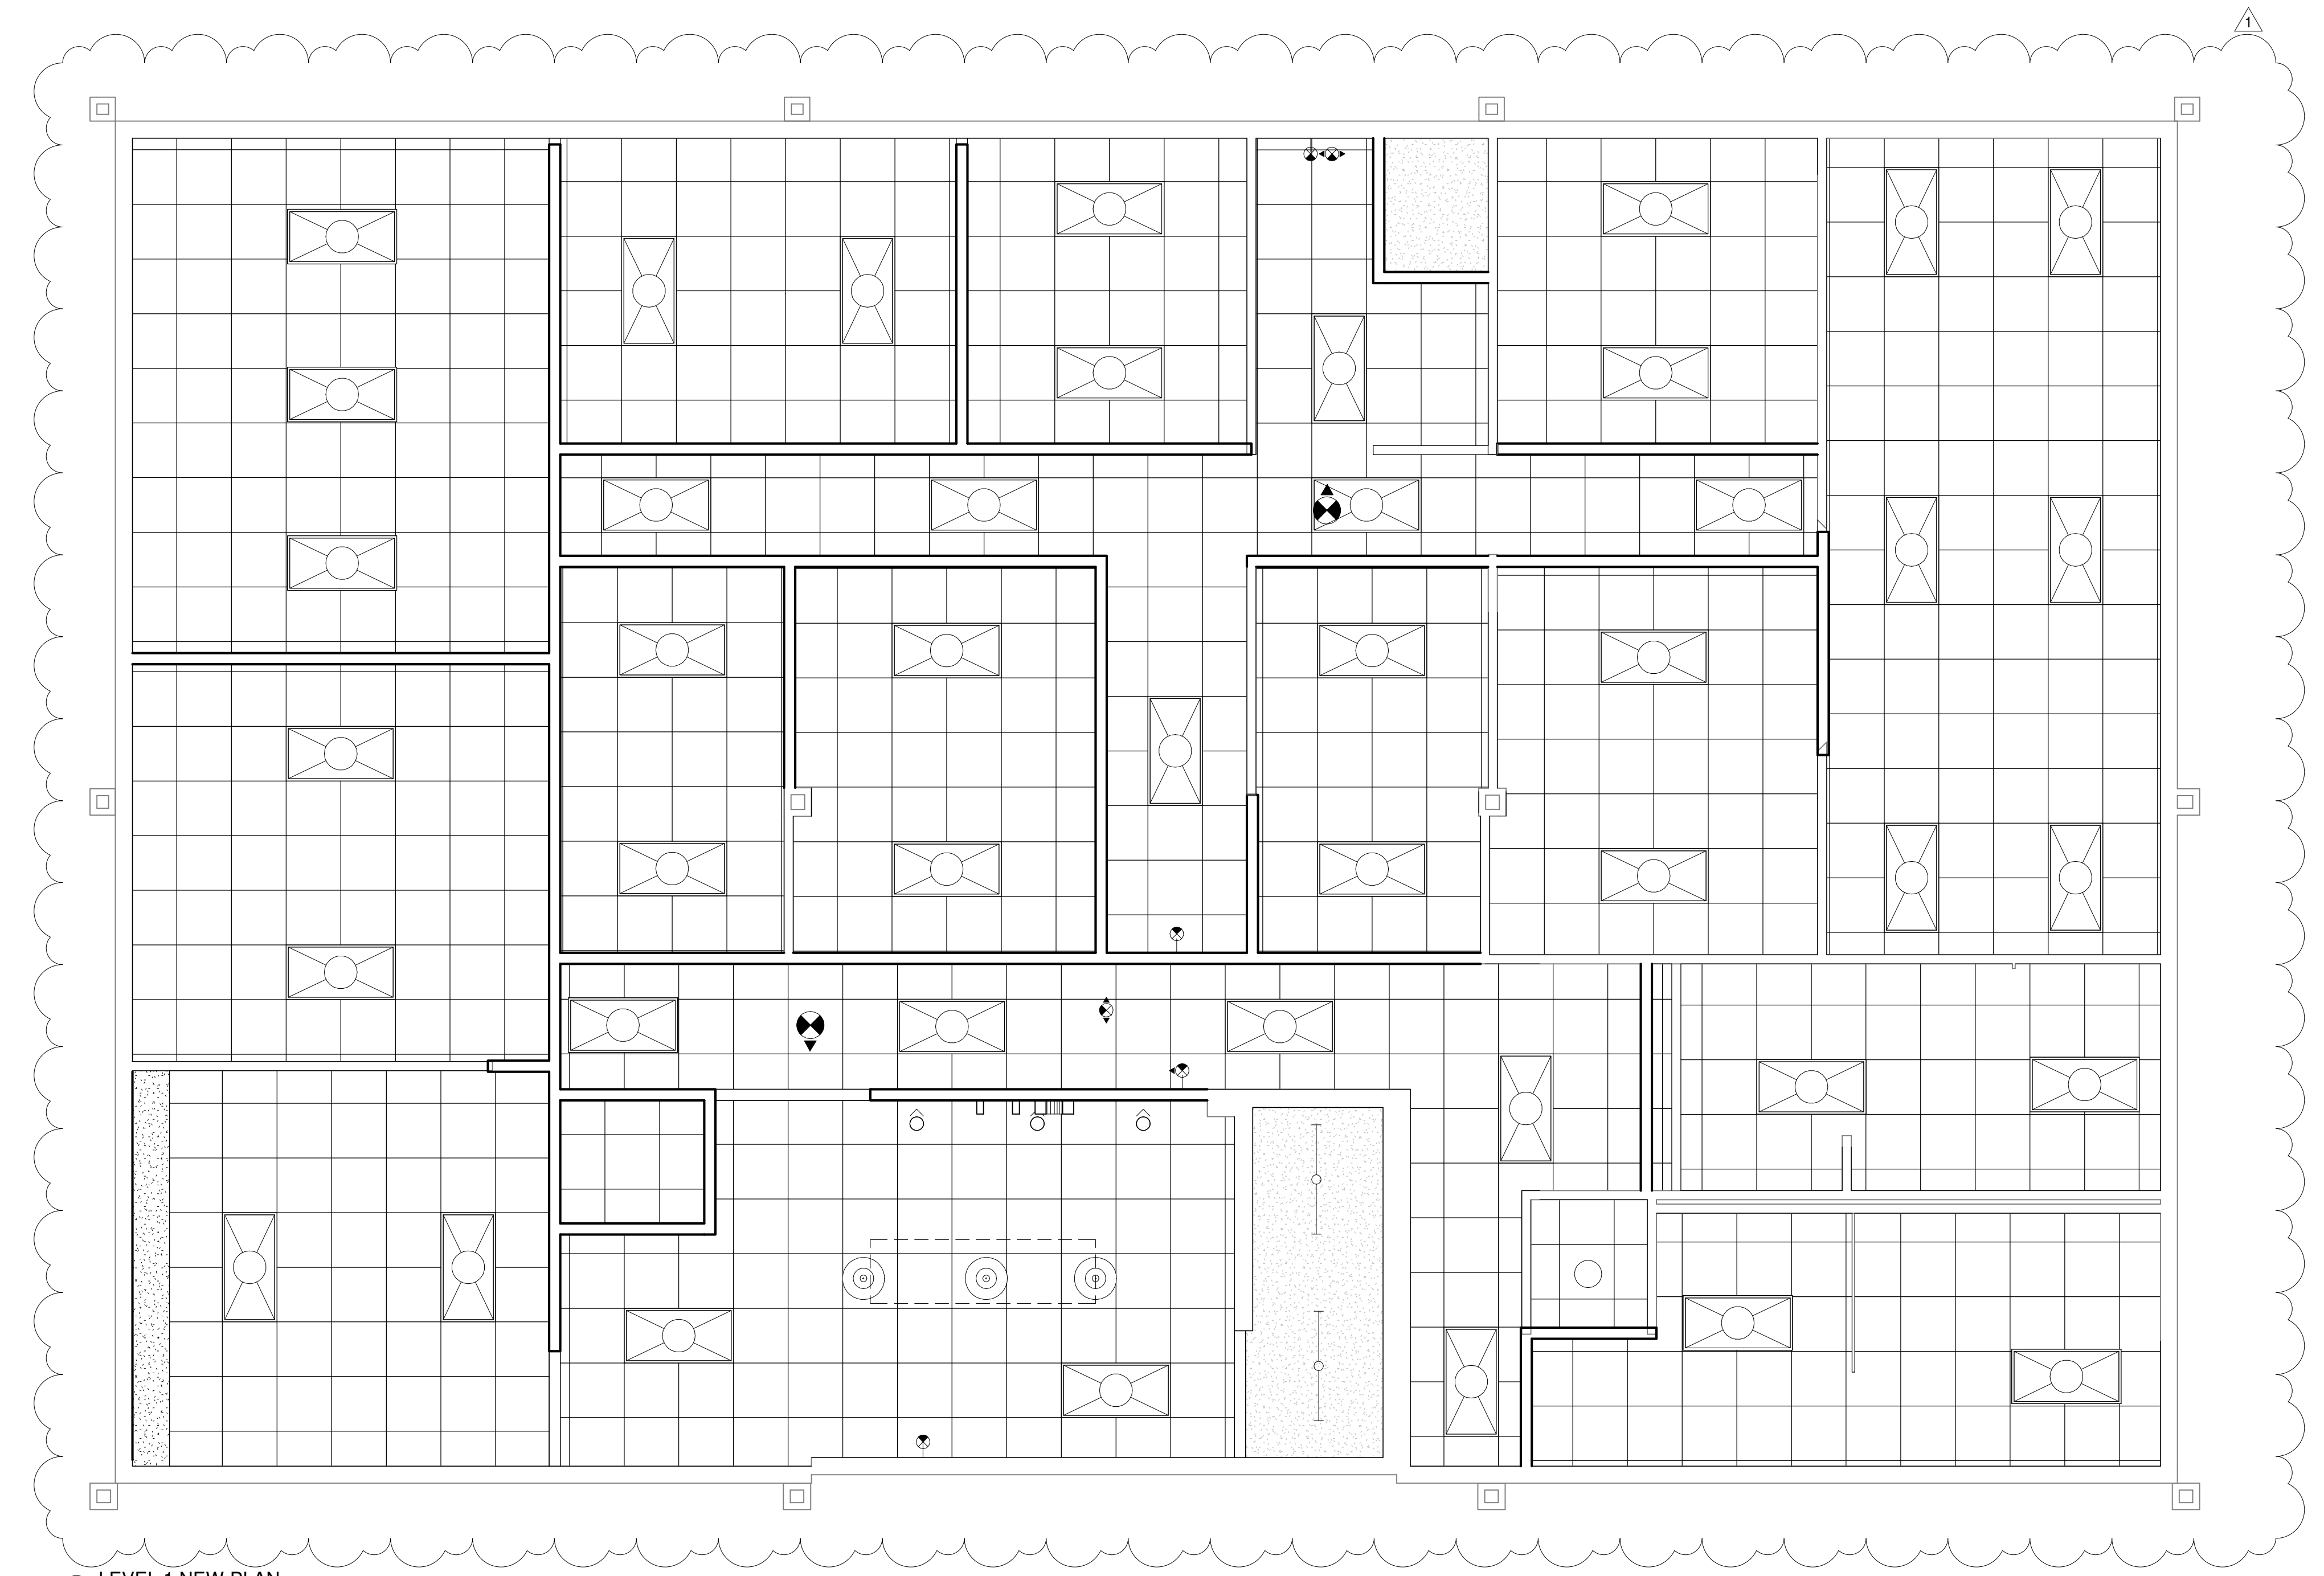

1 LEVEL 1 NEW PLAN
1/4" = 1'-0"

Lighting Fixture Schedule			
Type	Model	Elevation from Level	Count
2'x4'(2 Lamp) - 120V			87
4' 1 Lamp - 120		9' - 0"	2
6" Incandescent - 120V		9' - 0"	3
150W - 277V		9' - 0"	3
LED15FM12-W120			2

Reviewed for Code Compliance
02/17/2023
Hayden Scarnato